


# ALABASTER AMPHITHEATER

ALABASTER, ALABAMA

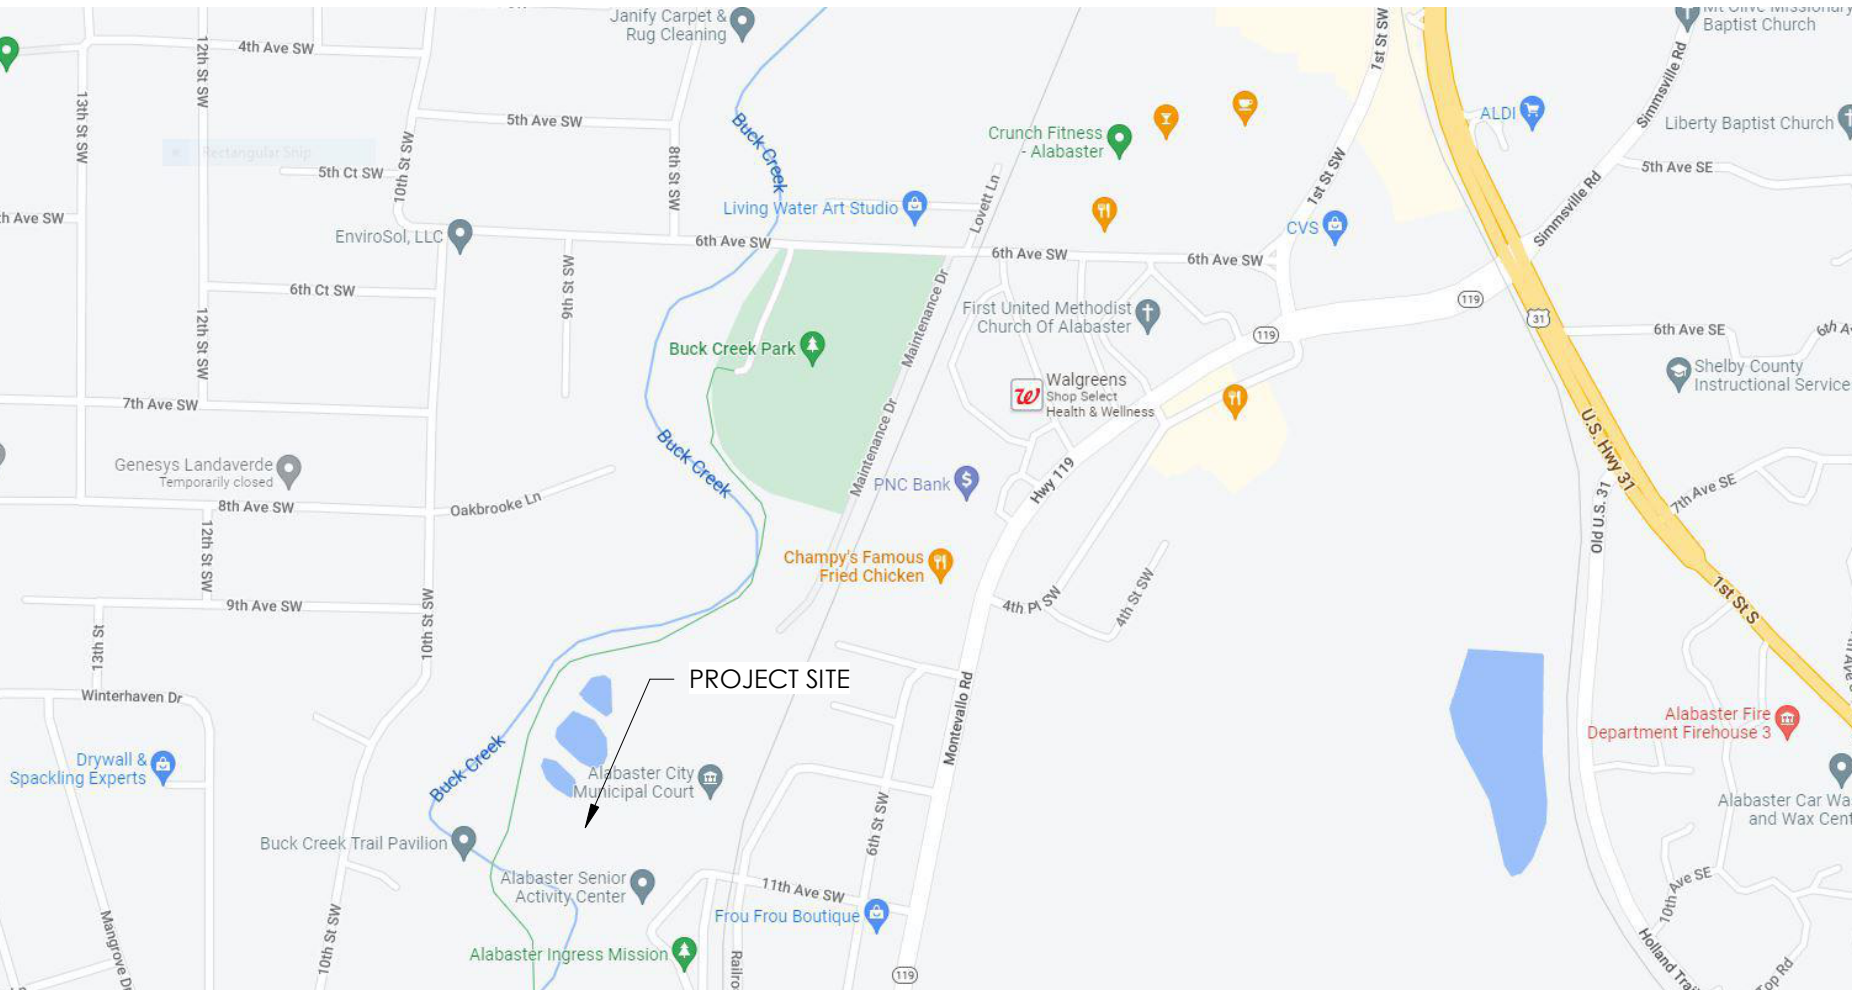

## VICINITY MAP



## PROJECT TEAM

OWNER:	CITY OF ALABASTER 1953 MUNICIPAL WAY ALABASTER, ALABAMA 35007 205.664.6800	STRUCTURAL ENGINEER:	MBA STRUCTURAL ENGINEERS, INC. 300 20TH STREET NORTH SUITE 100 BIRMINGHAM, ALABAMA 35203 205.323.6385 FAX: 205.324.0698
ARCHITECT:	TURNERBATSON 1950 STONEGATE DRIVE, SUITE 200 BIRMINGHAM, ALABAMA 35242 205.403.6201 FAX: 205.403.6206 www.turnerbatson.com	MECHANICAL ENGINEER:	PINNACLE ENGINEERING, INC. 2111 PARKWAY OFFICE CIRCLE, SUITE 125 BIRMINGHAM, ALABAMA 35244 205.733.6912
CIVIL ENGINEER:	ENGINEERING DESIGN GROUP 120 BISHOP CIRCLE, SUITE 300 PELHAM, ALABAMA 35124 205.403.9158	ELECTRICAL ENGINEER:	GUNN & ASSOCIATES 3102 HIGHWAY 14 MILLBROOK, ALABAMA 36054 205.285.1273
LANDSCAPE ARCHITECT:	FORME DESIGN GROUP P.O. BOX 2564 STARKVILLE, MS 39760 662.418.7450		

## INDEX

01 GENERAL	COVER SHEET	06 STRUCTURAL	GENERAL NOTES
G0.00	FIRST FLOOR LIFE SAFETY PLANS	S1.01	GENERAL NOTES
G0.21	ACCESSIBILITY DETAILS	S1.02	TYPICAL DETAILS
G0.30	ACCESSIBILITY DETAILS	S1.03	TYPICAL DETAILS
G0.31	ACCESSIBILITY DETAILS	S1.04	TRUSS ELEVATION
		S1.05	FOUNDATION & FIRST FLOOR PLANS
01 TOPOGRAPHICAL SURVEY		S2.01	ROOF FRAMING PLANS
TS01	BOUNDARY AND TOPOGRAPHICAL SURVEY	S2.02	BUS SHELTER PLANS
TS02	BOUNDARY AND TOPOGRAPHICAL SURVEY	S2.03	SECTIONS
		S3.01	SECTIONS
		S3.02	
02 CIVIL		07 MECHANICAL	
C0.1	GENERAL NOTES	M0.01	MECHANICAL LEGENDS, SCHEDULES, AND DETAILS
C0.2	OVERALL SITE LAYOUT	M2.01	MECHANICAL FLOOR PLANS
C1.0	SOUTH PARKING LOT DEMO PLAN	M2.02	MECHANICAL ROOF PLANS
C1.1	AMPHITHEATER DEMO PLAN	M3.01	MECHANICAL DETAILS
C2.0	SOUTH PARKING LOT SITE PLAN	M3.02	
C2.1	AMPHITHEATER SITE PLAN		
C3.0	SOUTH PARKING LOT GRADING PLAN	08 PLUMBING	
C3.1	AMPHITHEATER GRADING PLAN	P0.01	PLUMBING LEGEND, ABBREV., SCHEDULES, & DETAILS
C4.0	SOUTH PARKING LOT PHASE 1 EROSION CONTROL PLAN	P2.01	PLUMBING GRAVITY PLANS
C4.1	AMPHITHEATER PHASE 1 EROSION CONTROL PLAN	P2.11	PLUMBING PRESSURE PLANS
C4.2	SOUTH PARKING LOT PHASE 2 EROSION CONTROL PLAN	P3.01	PLUMBING DETAILS
C4.3	AMPHITHEATER PHASE 2 EROSION CONTROL PLAN	P3.02	PLUMBING DETAILS
C5.0	SOUTH PARKING LOT UTILITY PLAN		
C5.1	AMPHITHEATER UTILITY PLAN	10 ELECTRICAL	
C6.0	DETAILS	E0.01	ELECTRICAL LEGEND
C6.1	DETAILS	E0.02	ELECTRICAL LEGEND AND NOTES
03 LANDSCAPE		E1.01	SITE PLAN - ELECTRICAL
L1.0	DEMOLITION PLAN	E1.02	SITE PLAN - NEW WORK
L1.1	HARDSCAPE PLAN	E2.01	FLOOR PLAN - PAVILION & SENIOR CENTER LIGHTING
L1.2	LANDSCAPE PLAN	E2.02	FLOOR PLAN - PAVILION & SENIOR CENTER LIGHTING
L1.3	HARDSCAPE PLAN	E3.01	FLOOR PLAN - PAVILION & SENIOR CENTER POWER AND AUXILIARY
L1.4	HARDSCAPE PLAN		
L2.1	HARDSCAPE DETAILS	E3.02	FLOOR PLAN - PAVILION & SENIOR CENTER EQUIPMENT POWER
L2.2	HARDSCAPE DETAILS		
L2.3	HARDSCAPE DETAILS	E3.03	EQUIPMENT SCHEDULE
L3.1	OVERALL IRRIGATION PLAN	E4.01	LUMINAIRE SCHEDULE AND NOTES
L3.2	IRRIGATION PLAN & ALTERNATE #1	E4.02	PANELBOARD SCHEDULE AND NOTES
L3.3	IRRIGATION PLAN ALTERNATE #2	E4.03	PANELBOARD SCHEDULE AND NOTES
L3.4	IRRIGATION NOTES & DETAILS	E5.01	POWER RISER DIAGRAM
L4.1	LANDSCAPE PLAN	E5.02	GROUNDING DETAILS
L4.2	LANDSCAPE PLAN	E6.01	AUXILIARY DETAILS
L4.3	LANDSCAPE PLAN ALTERNATES #1 & #2	E6.02	AUXILIARY DETAILS
L4.4	LANDSCAPE DETAILS & SCHEDULE	E6.03	POWER BOX DETAIL
04 ARCHITECTURAL			
A0.00	ARCHITECTURAL SITE PLAN		
A0.10	BUS SHELTER PLANS, SECTIONS AND DETAILS		
A2.01	FIRST FLOOR PLANS		
A2.02	ROOF PLANS		
A3.00	DOOR AND FRAME SCHEDULE		
A3.10	PARTITION SCHEDULE AND CAST STONE LEGEND		
A4.00	EXTERIOR ELEVATIONS - SENIOR CENTER ADDITION		
A4.01	EXTERIOR ELEVATIONS - PAVILION		
A5.00	BUILDING SECTIONS		
A6.00	WALL SECTIONS - SENIOR CENTER ADDITION		
A6.01	WALL SECTIONS - SENIOR CENTER ADDITION		
A6.02	WALL SECTIONS - PAVILION		
A6.03	WALL SECTIONS - PAVILION		
A6.10	VERTICAL CIRCULATION		
A7.00	PLAN DETAILS		
A7.01	PLAN DETAILS		
A7.10	SECTION DETAILS - ALTERNATE NO. 1		
A7.11	SECTION DETAILS - ALTERNATE NO. 1		
A7.12	SECTION DETAILS - ALTERNATE NO.1		
A7.13	SECTION DETAILS		
A7.14	SECTION DETAILS		
A7.15	SECTION DETAILS		
A7.16	SECTION DETAILS		
A8.00	INTERIOR ELEVATIONS AND ENLARGED PLANS - ALTERNATE NO. 1		
A8.01	INTERIOR ELEVATIONS AND ENLARGED PLANS - ALTERNATE NO. 1		
A8.02	INTERIOR ELEVATIONS AND ENLARGED PLANS		
A9.00	FINISH LISTING		
A9.01	FIRST FLOOR FINISH PLANS		
A9.11	FIRST FLOOR REFLECTED CEILING PLAN		



ALABASTER  
AMPHITHEATER  
ALABASTER, ALABAMA



I.F.C.  
ISSUED FOR  
CONSTRUCTION

REVISIONS:		
No	Date	Description

SHEET TITLE:  
COVER SHEET

PROJECT NUMBER: 2904  
CHECKED BY: BHS  
ISSUE DATE: 4/14/23  
DRAWN BY: HC

G0.00