

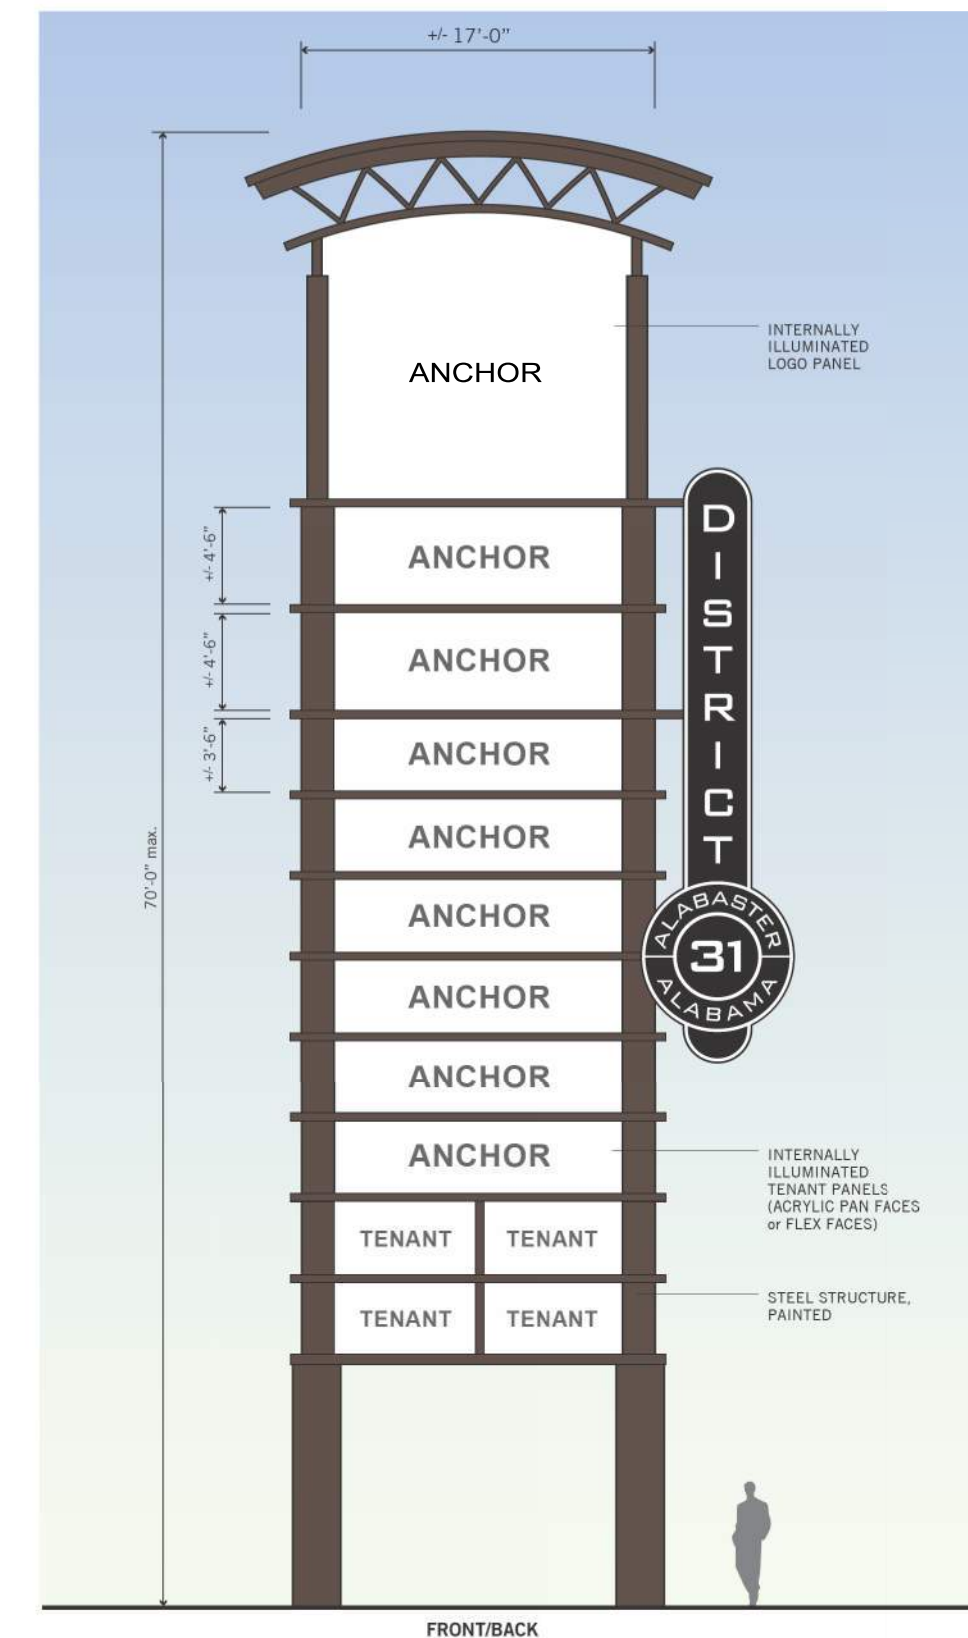


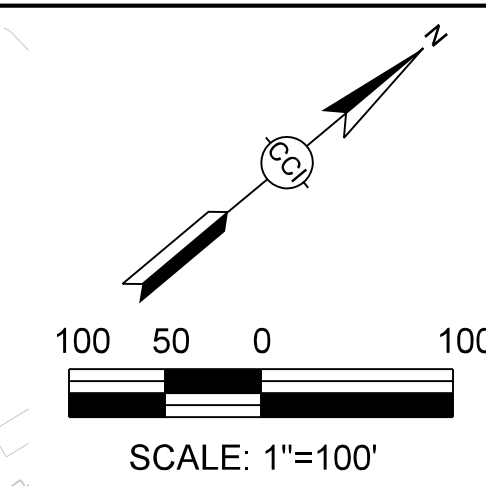

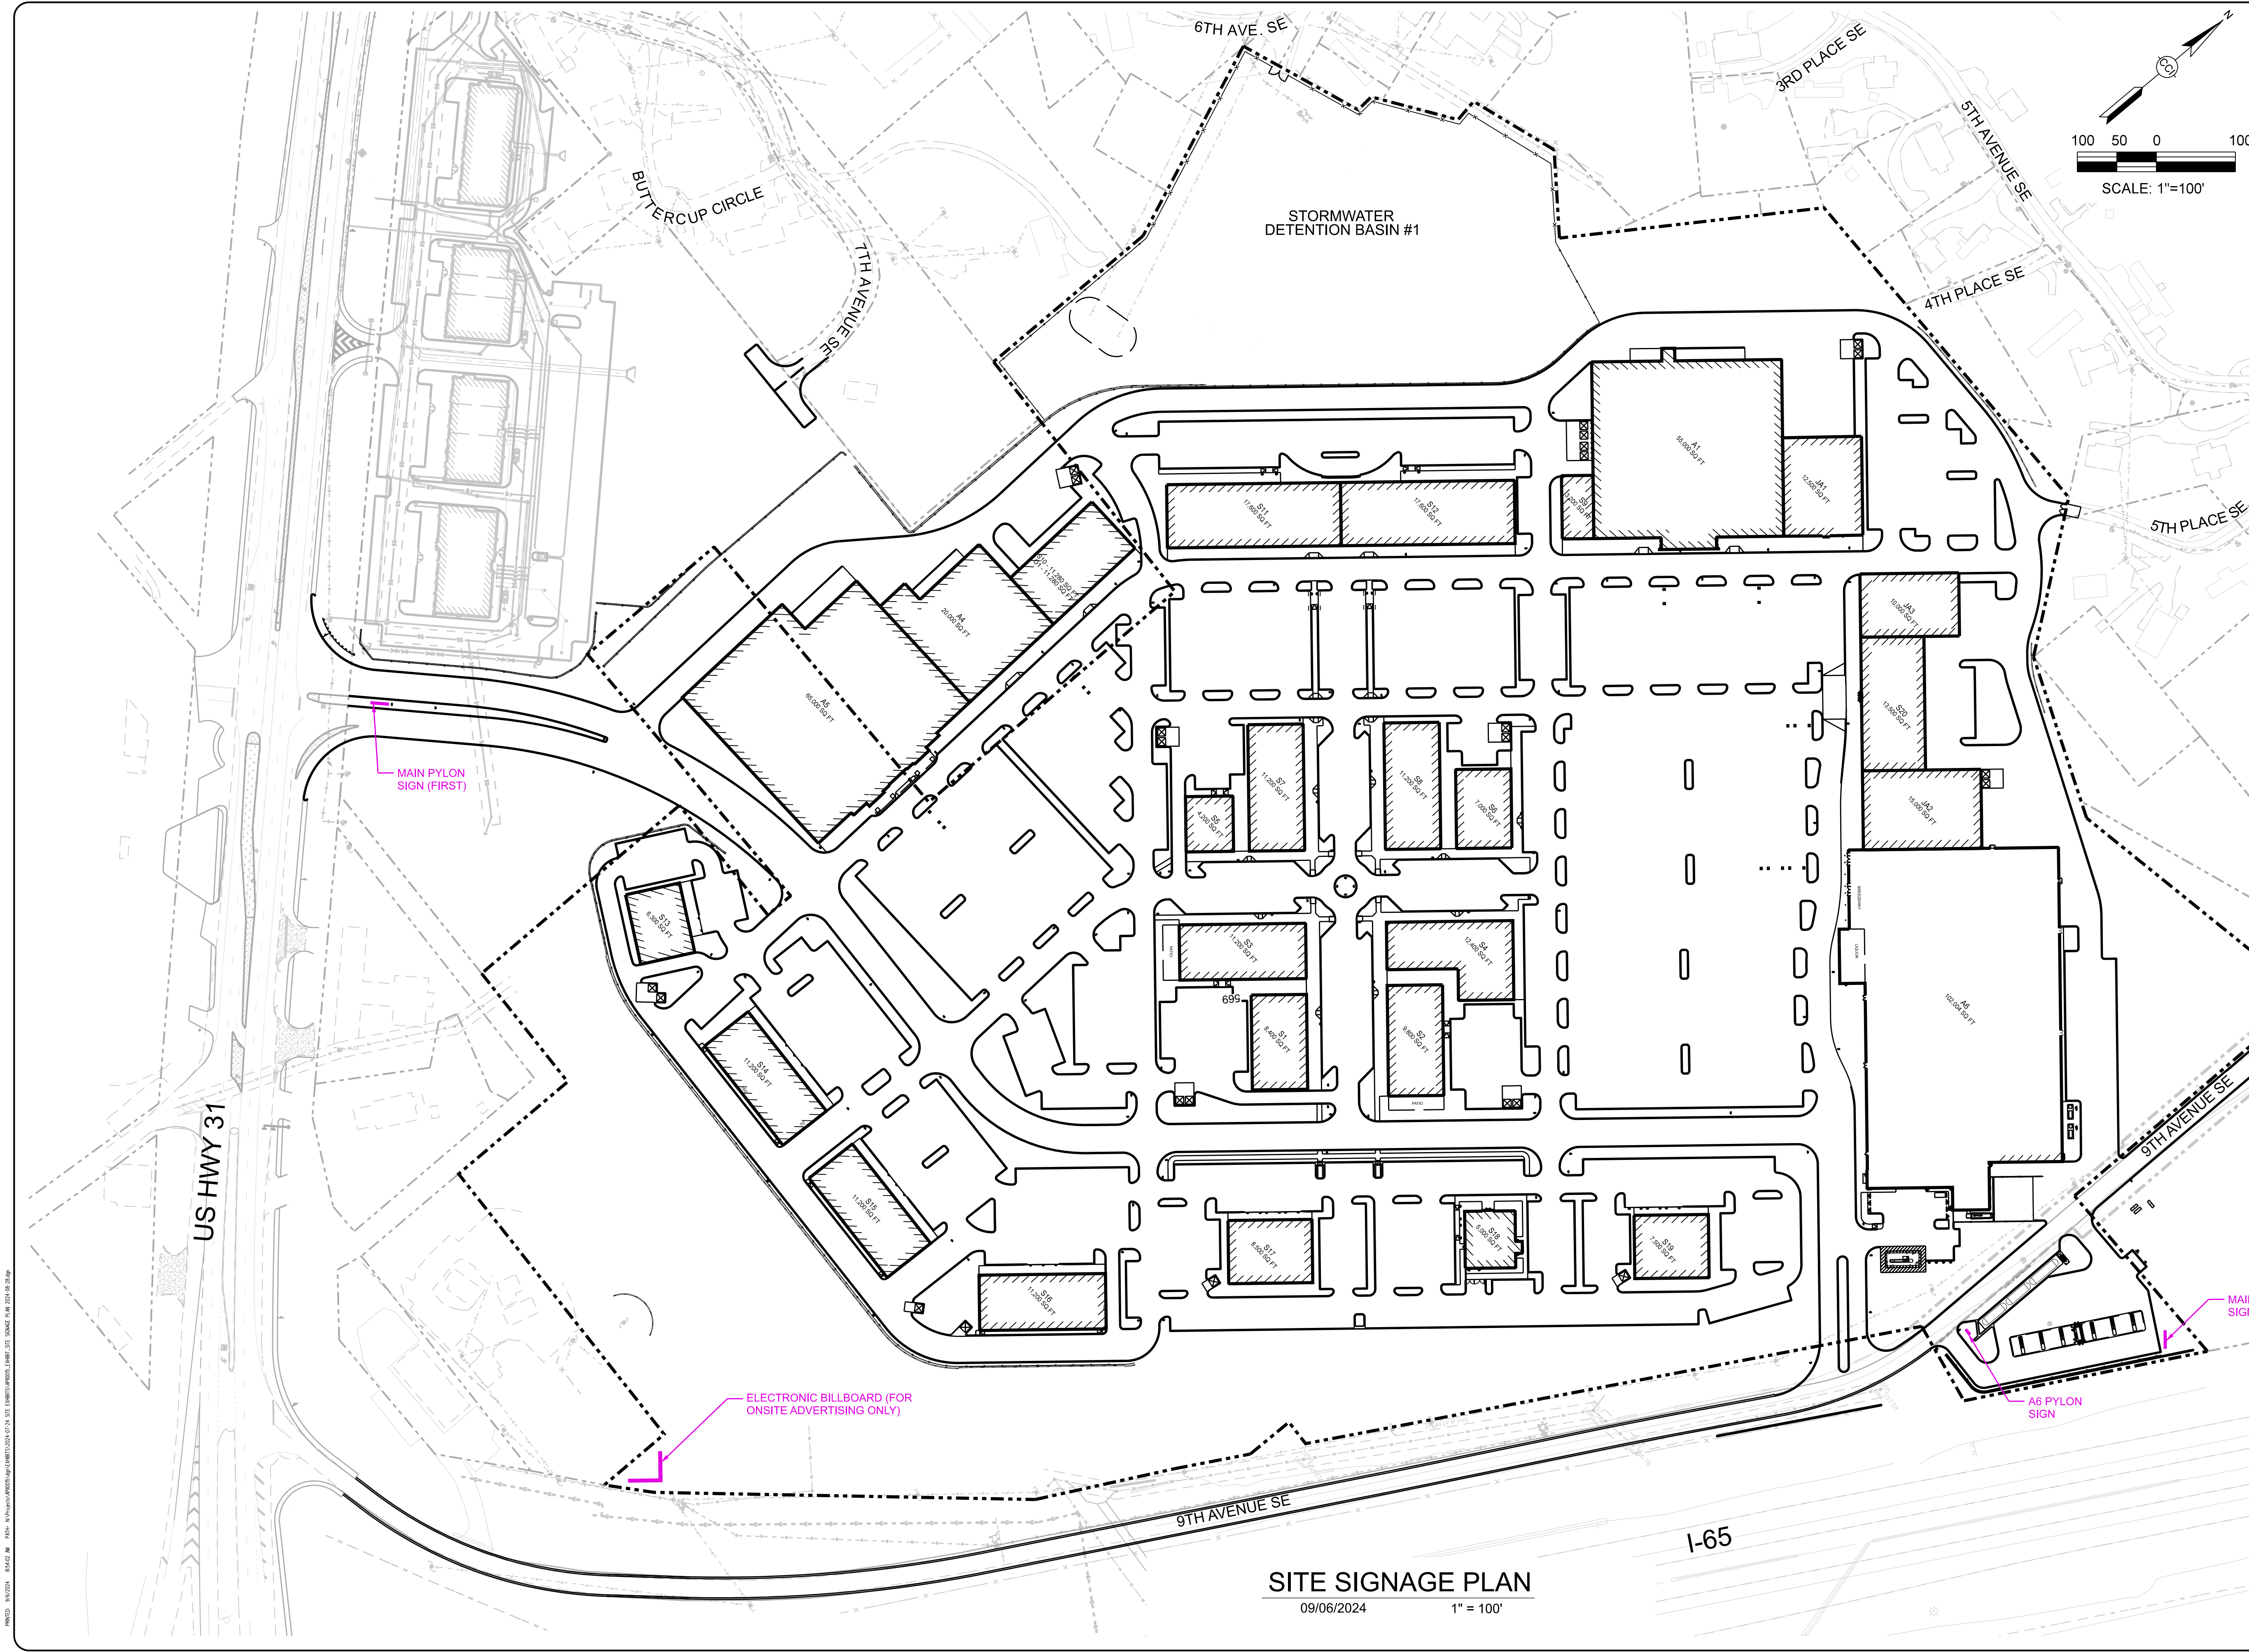

DISTRICT 31 PYLON

12A

57'-4 1/8"

10'-0"

6'-11"

7'-7"

50 SQ. FT.

GENERAL SPECIFICATIONS

Pan formed polycarbonate faces decorated with flat, 1st surface graphics.

Aluminum Cabinet & poles/cladding to match Benjamin Moore Super White (#PM-1 or OC-152)

White LED illumination.

COLOR SPECIFICATIONS

- 3M 3730-53L Red Vinyl / PMS 200
- 3M 3630-22 Black Vinyl
- White
- Benjamin Moore Super White (#PM-1 or OC-152)
- City Scape SW 7067

UNDERGROUND DETAILS TO BE DETERMINED

TENANT A6 PYLON




ALUMNI PROPERTIES

CCI
PLANNING & ENGINEERING

3528 Vann Road
Suite 105
Birmingham, AL 35235
Phone: (205) 655-1991
www.ccipe.com

SITE SIGNAGE PLAN
09/06/2024 1" = 100'

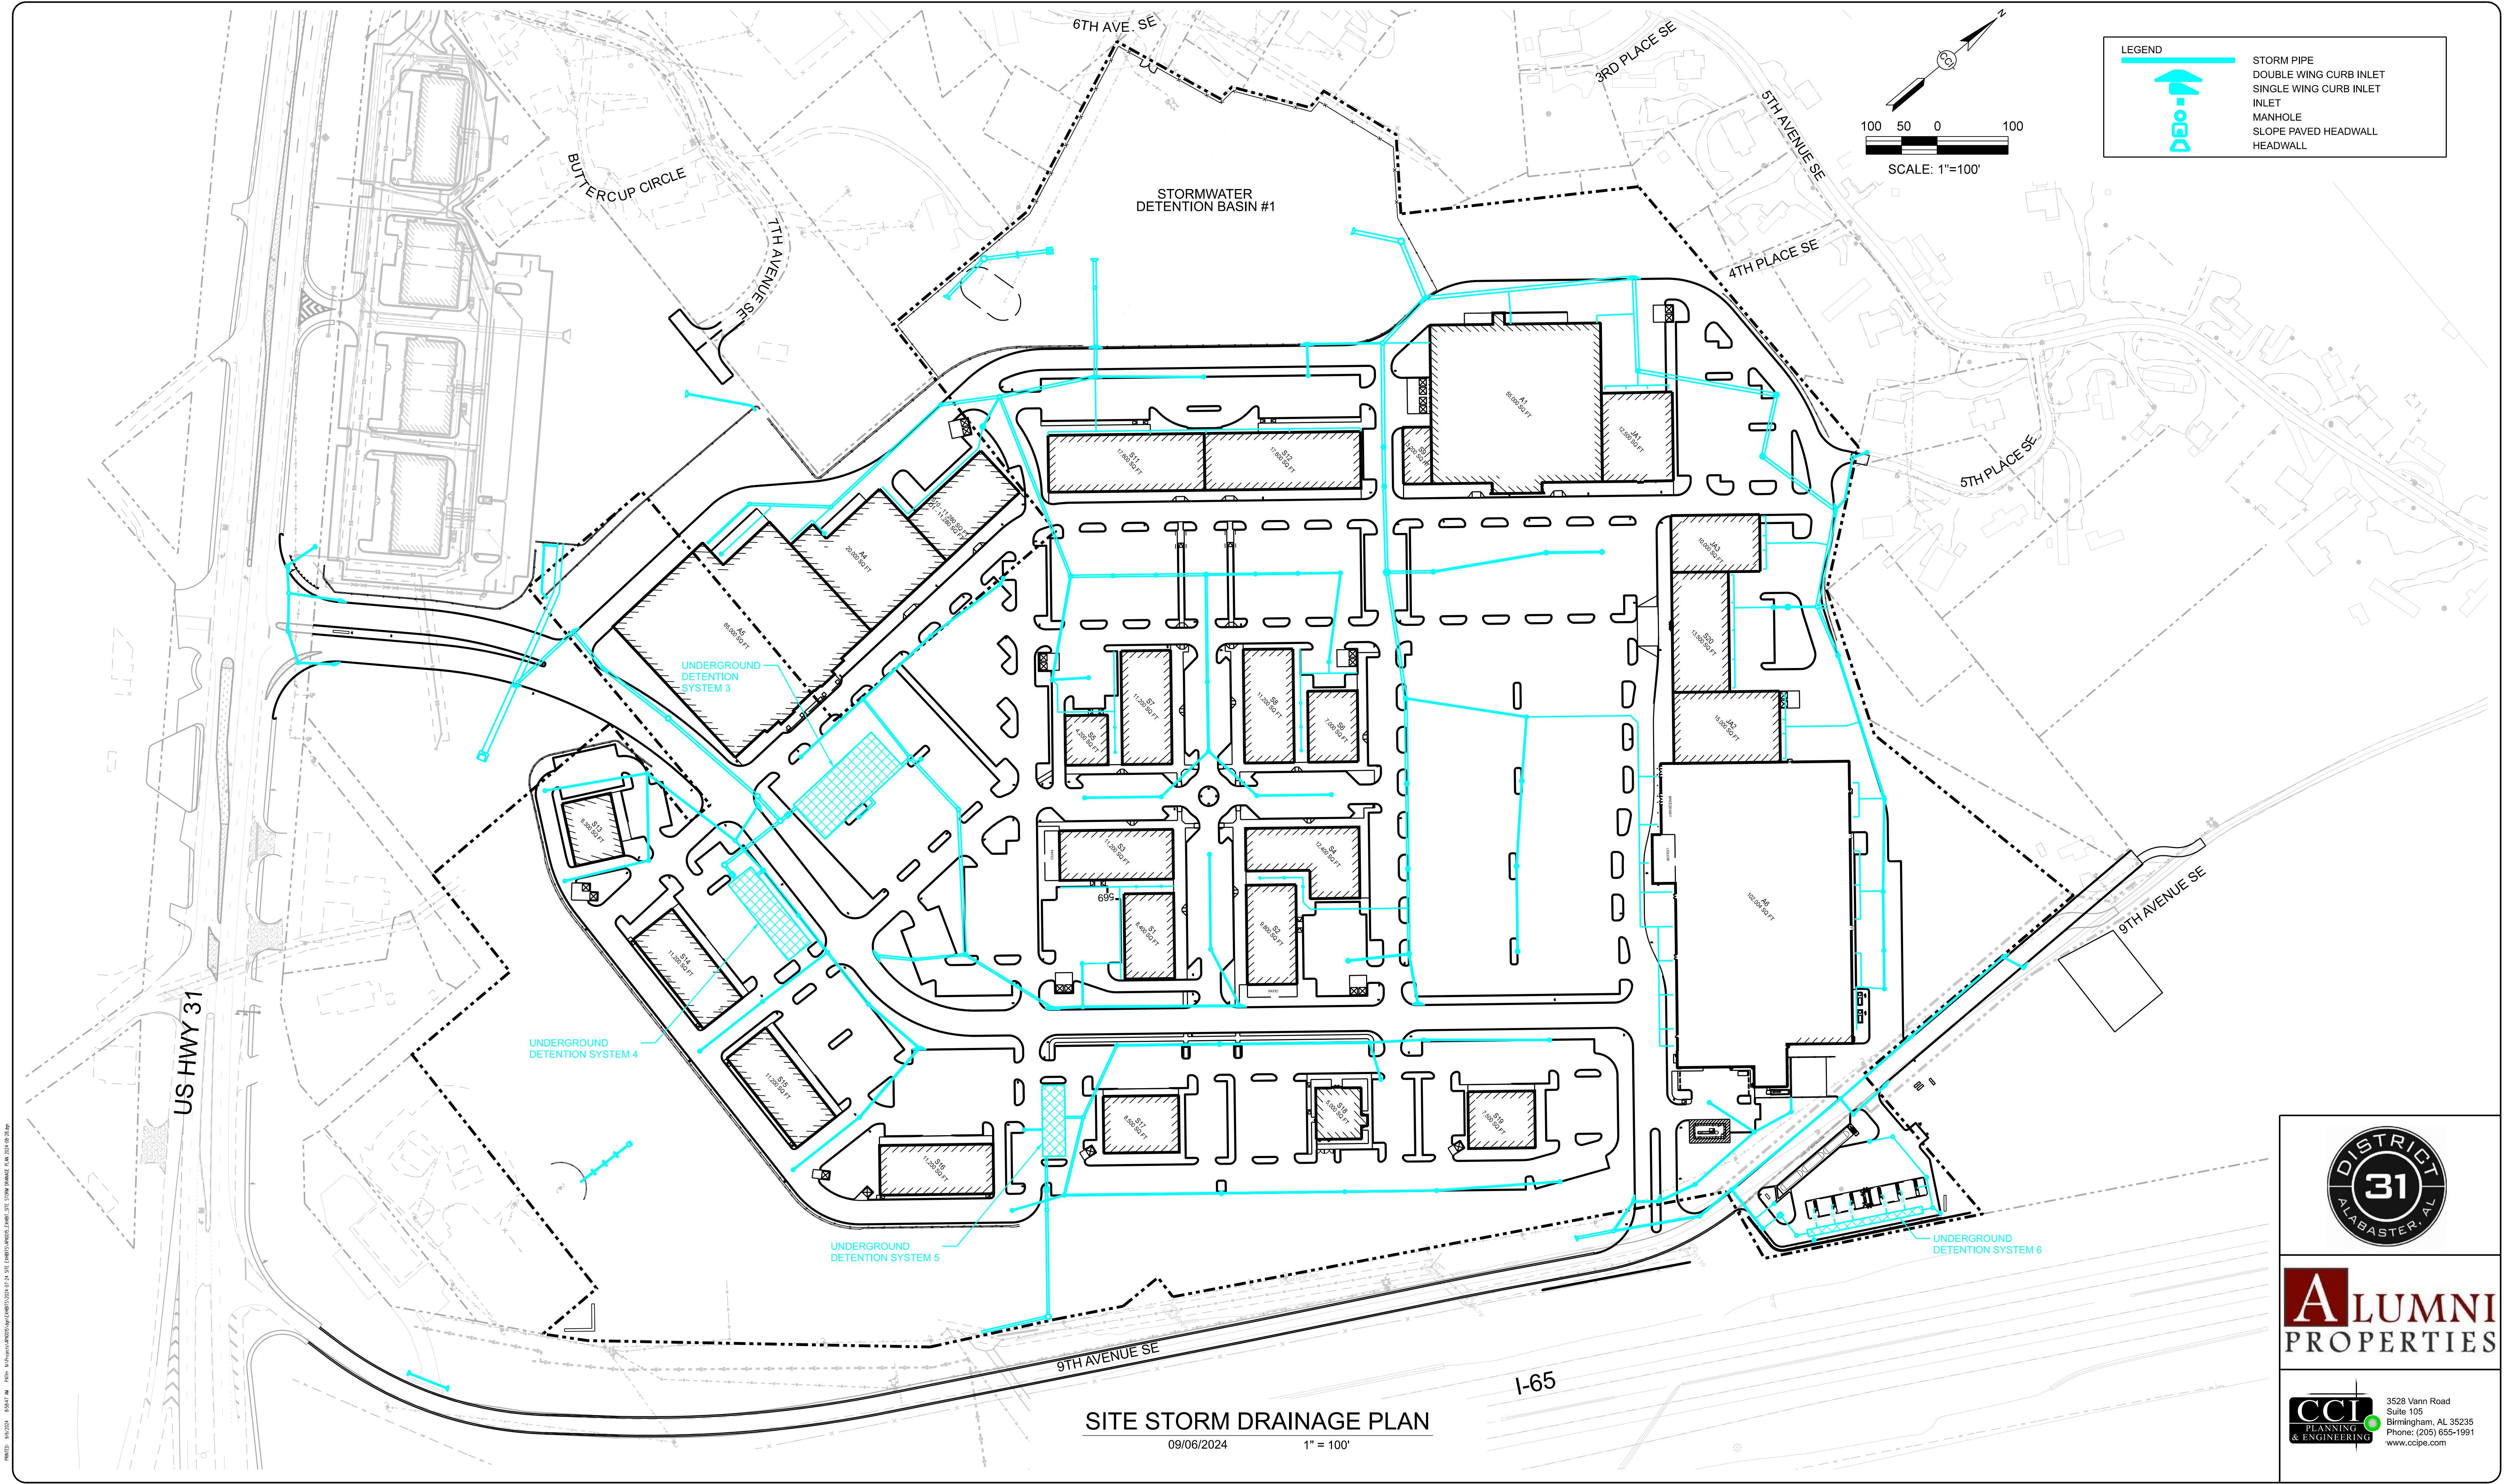

LEGEND

- STORM PIPE
- DOUBLE WING CURB INLET
- SINGLE WING CURB INLET
- INLET
- MANHOLE
- SLOPE PAVED HEADWALL
- HEADWALL

SITE STORM DRAINAGE PLAN

09/06/2024 1" = 100'



DISTRICT
31
ALABASTER, AL






ALUMNI
PROPERTIES




CCI
PLANNING
& ENGINEERING

3528 Vann Road
Suite 105
Birmingham, AL 35235
Phone: (205) 655-1991
www.ccipe.com

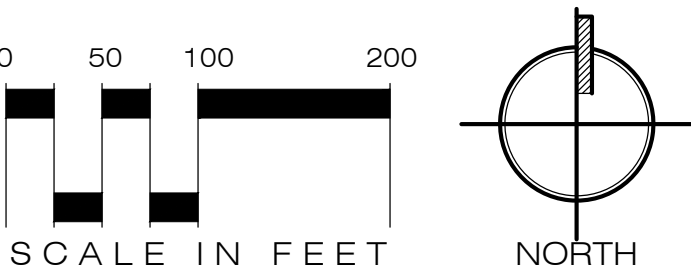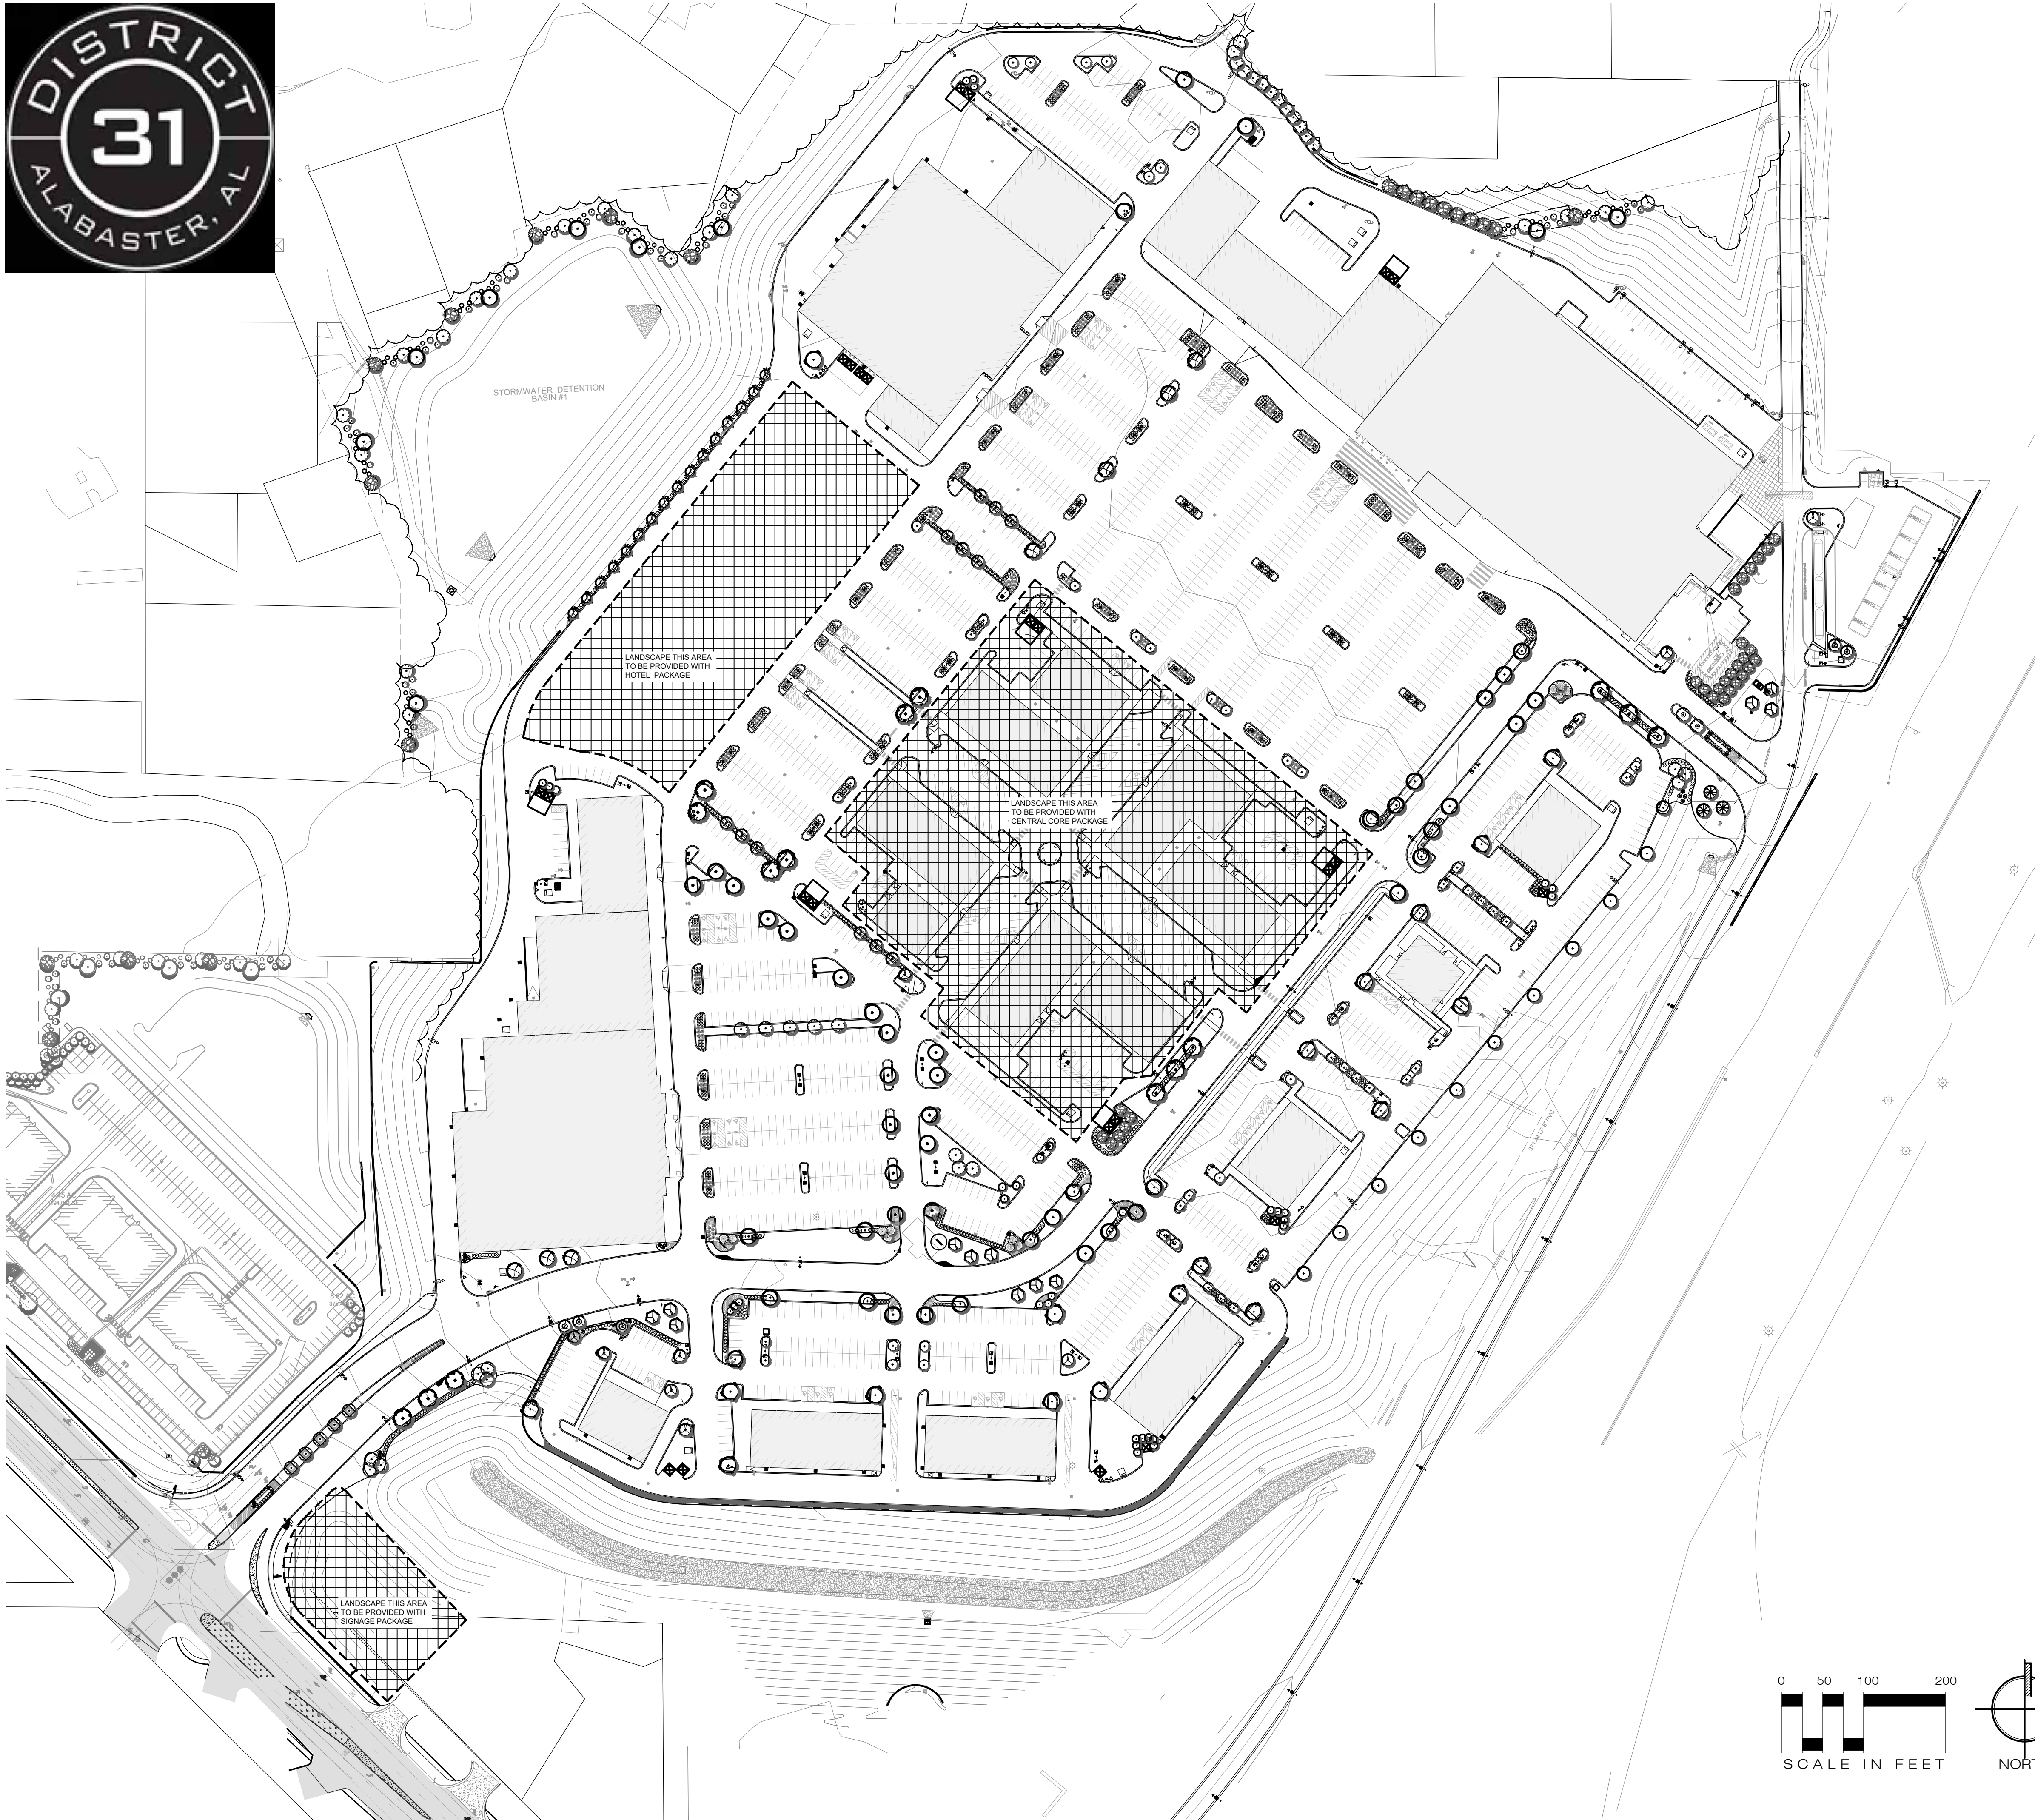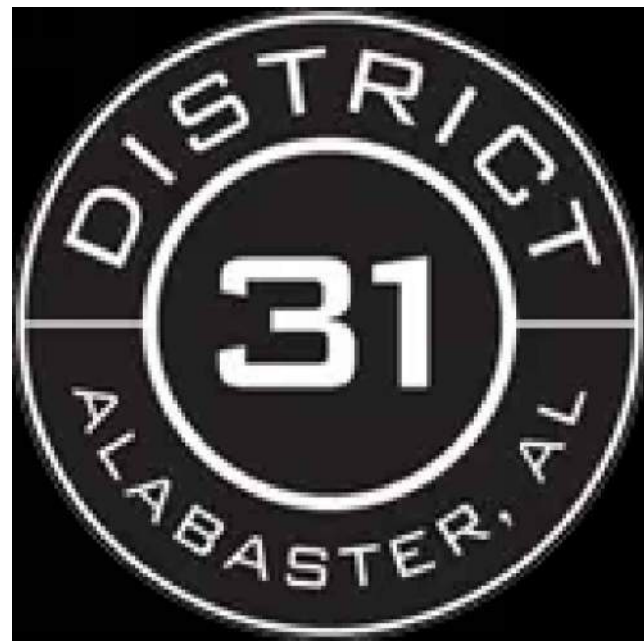

seal

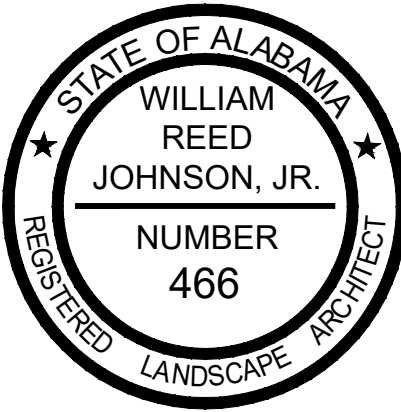

date: 9/6/24

JOHNSON & CO
Land Planners - Landscape Architects

2413 2nd Avenue South, Suite 101
Birmingham, AL 35233
Phone: 205.324.4447
Fax: 205.324.8068
www.johnson-co.net

PROJECT

DISTRICT 31
ALABASTER, ALABAMA
FOR
API ALABASTER, LLC

REVISIONS & ADDENDUMS

No.	Description	Date

Date: SEPTEMBER 6, 2024

Sheet Title:

LANDSCAPE EXHIBIT

Drawn by: JCO Checked by: WRJ

Project No. APII0015

Scale 1" = 100'

Drawing No.

L2.00