

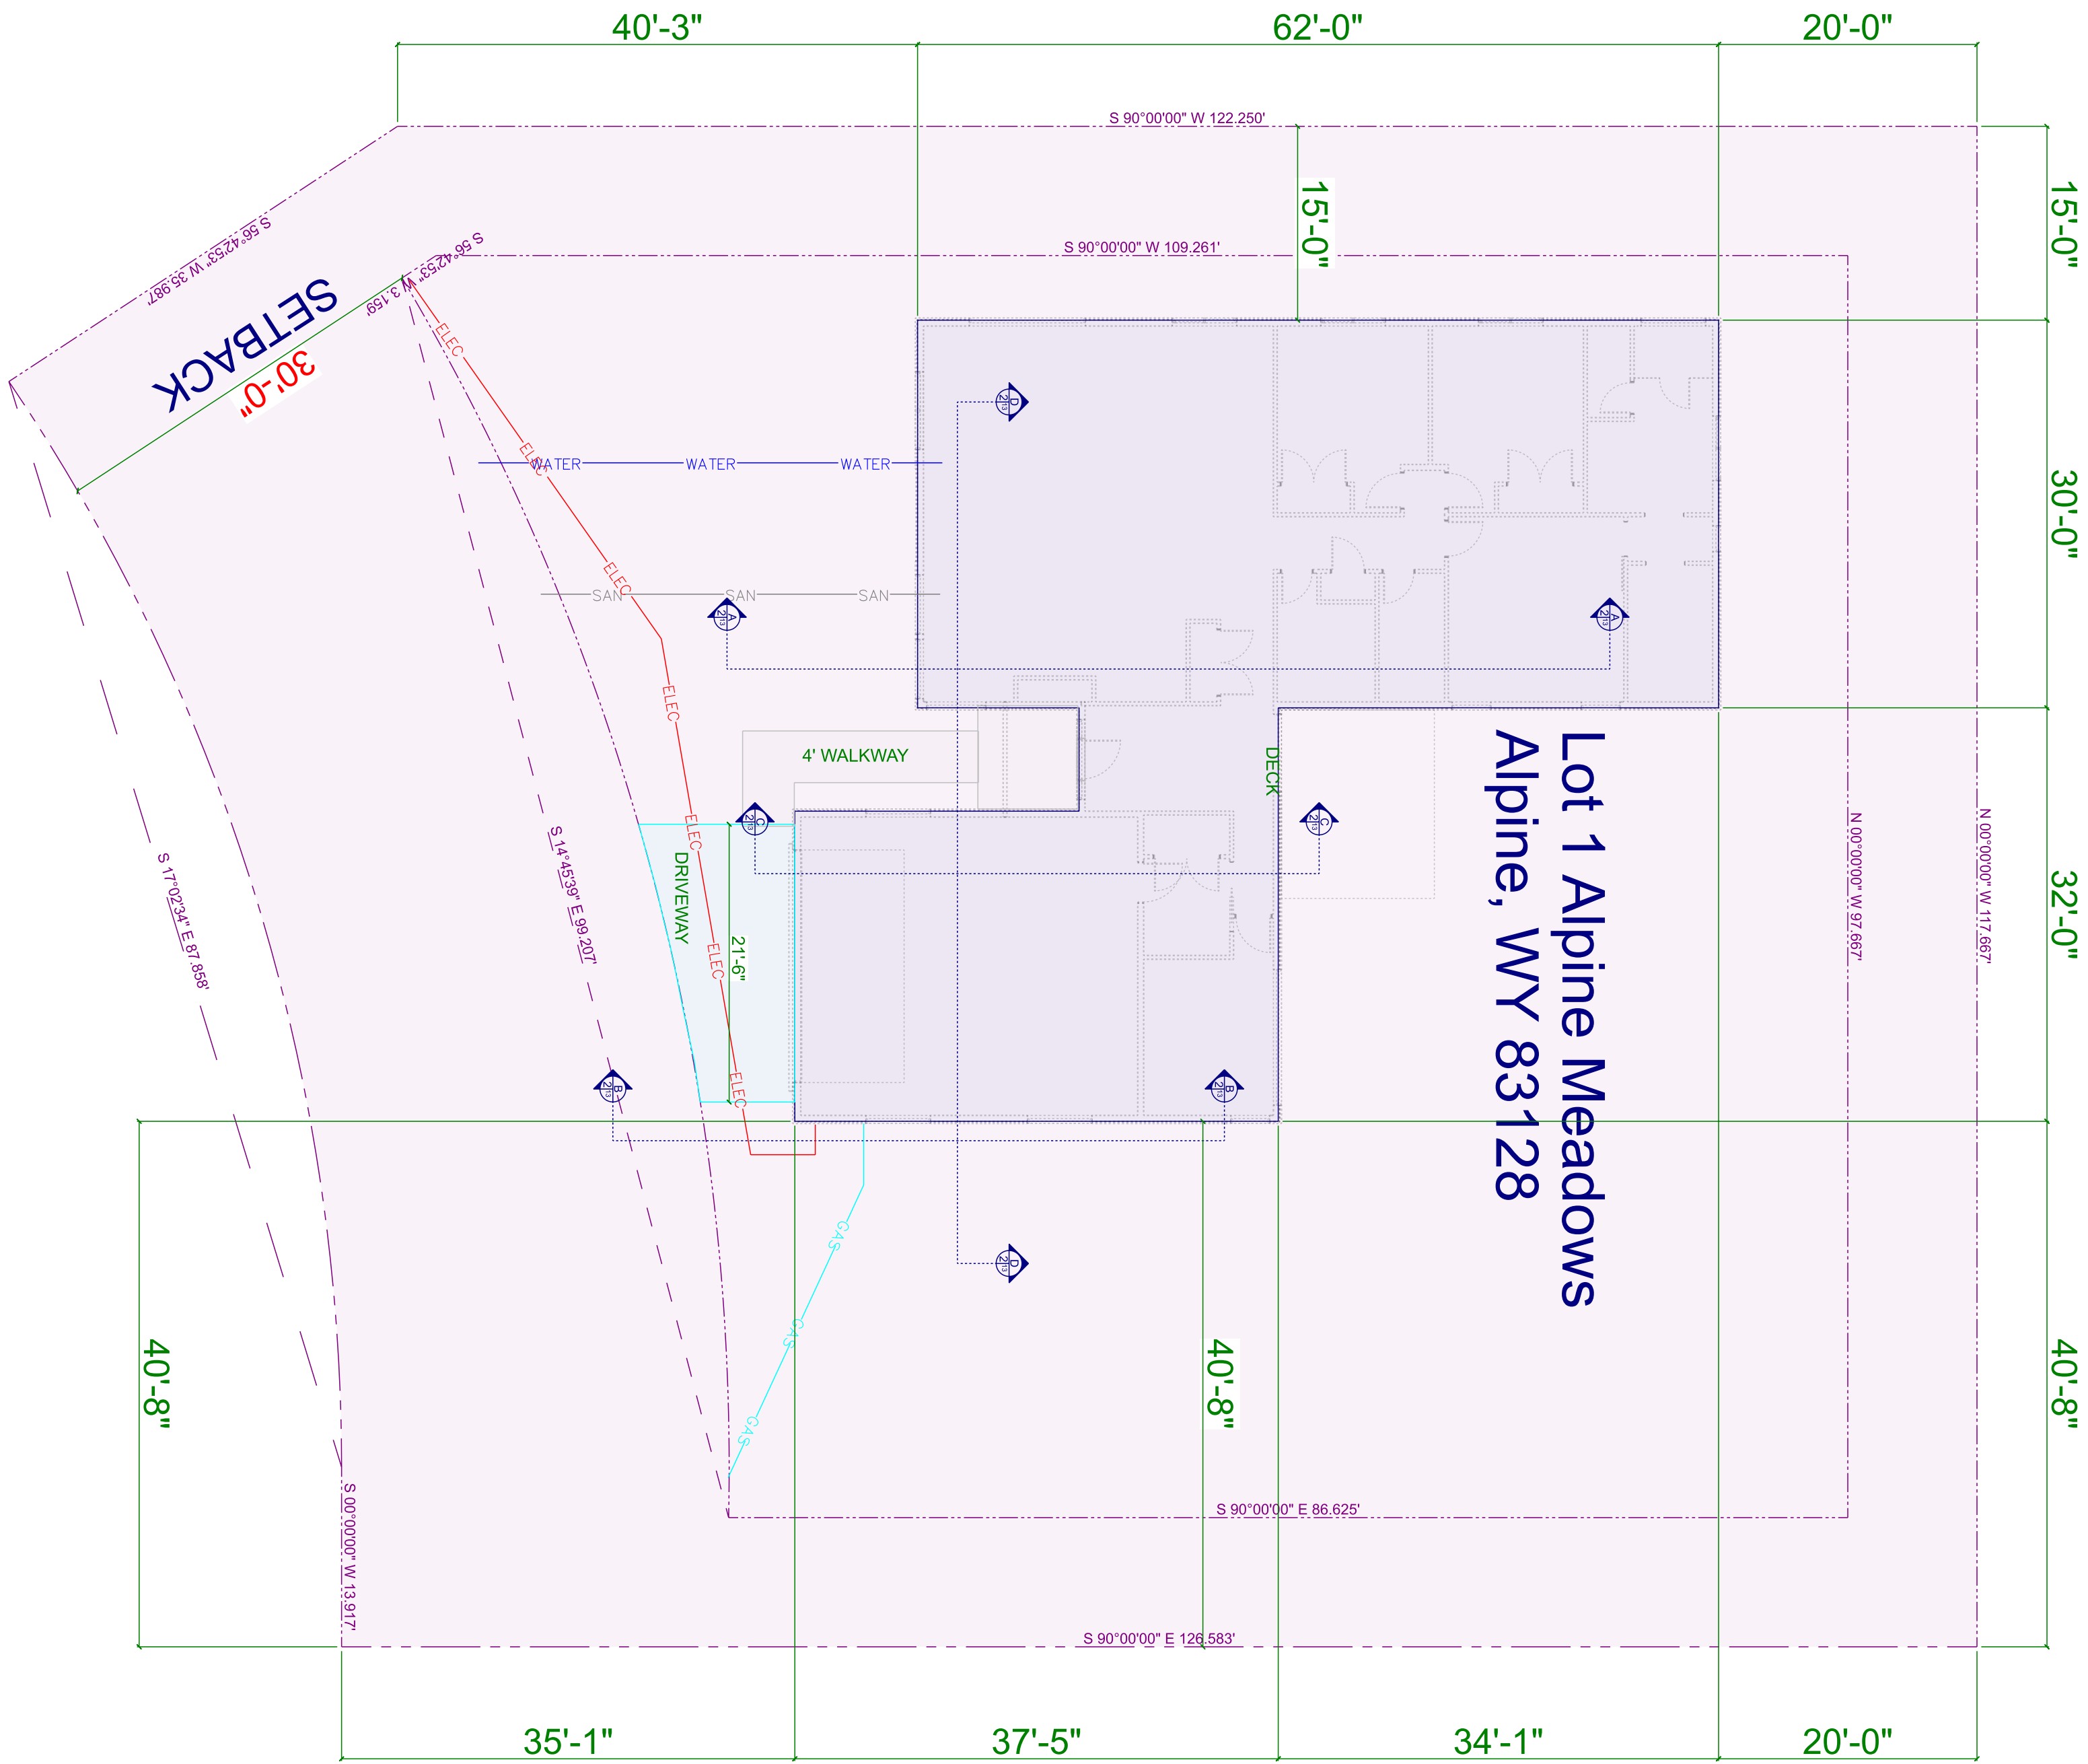
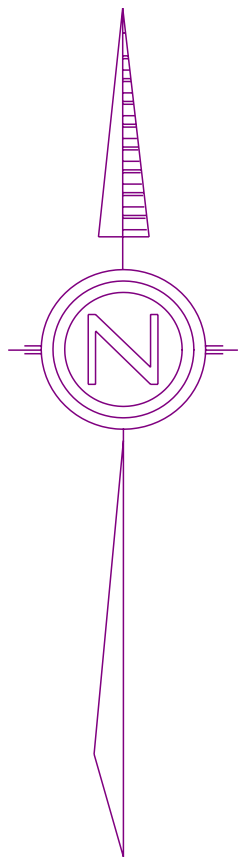



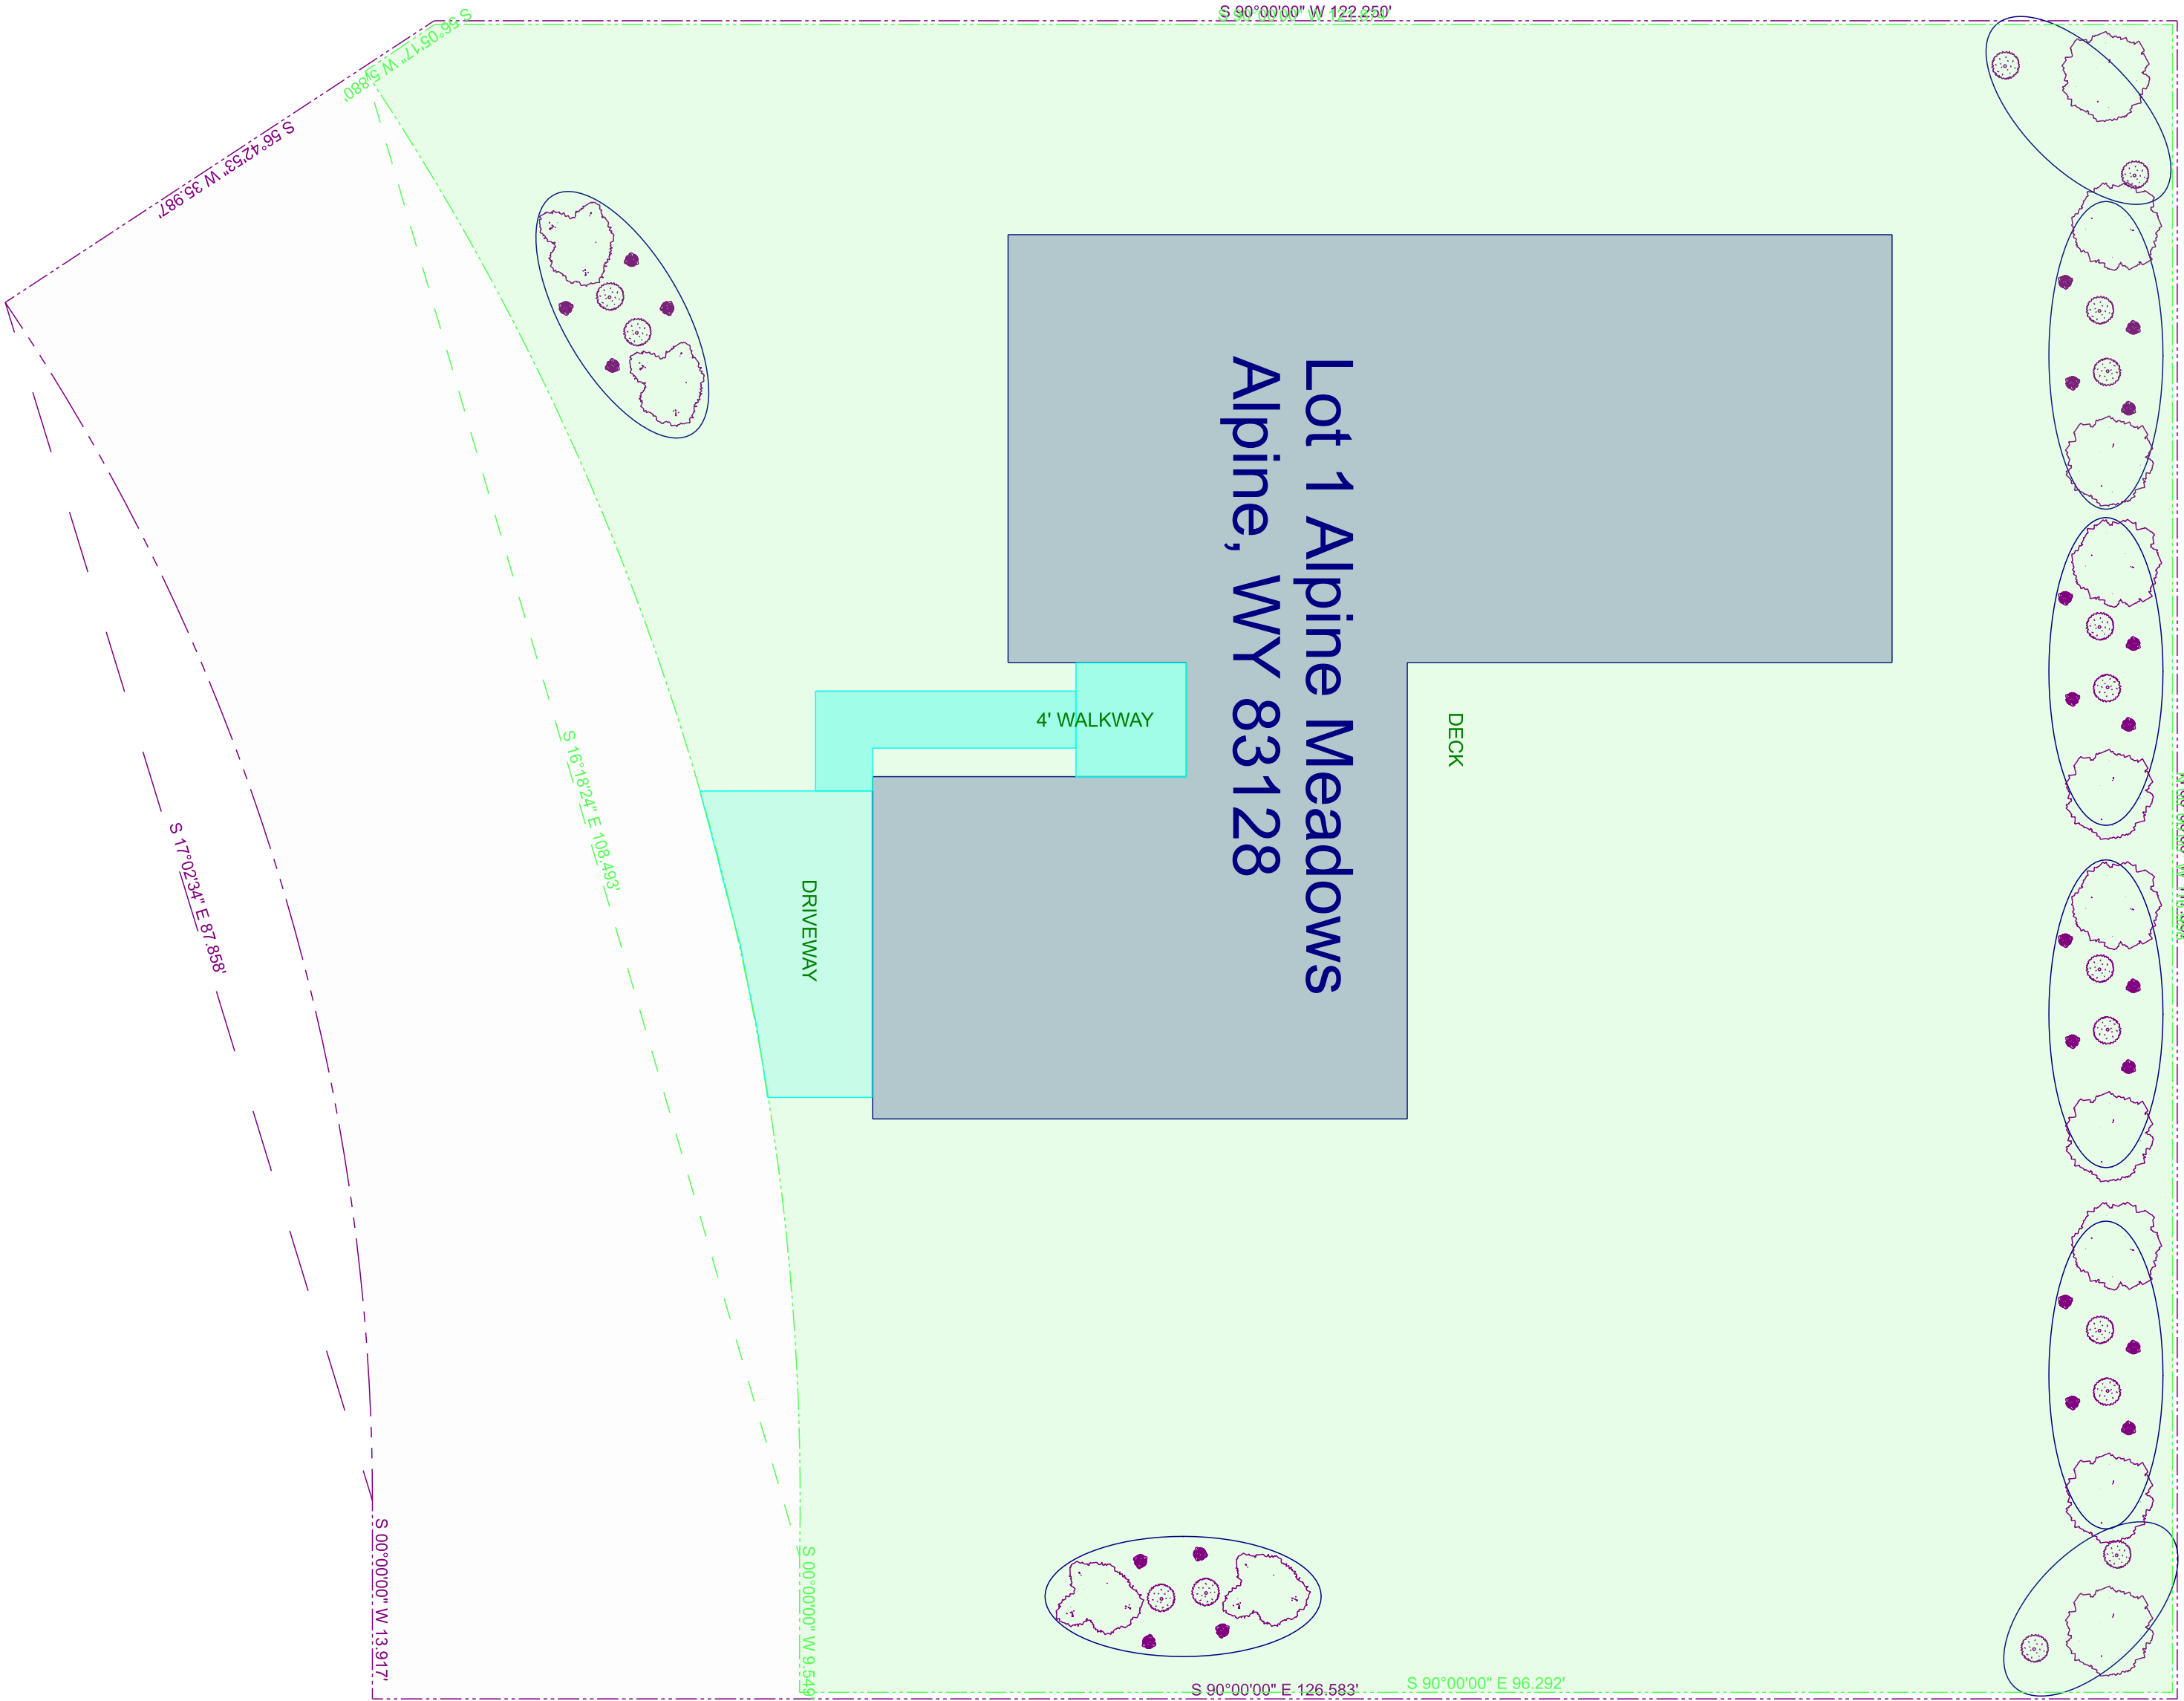


SITE PLAN
SCALE: 1" = 10'-0"

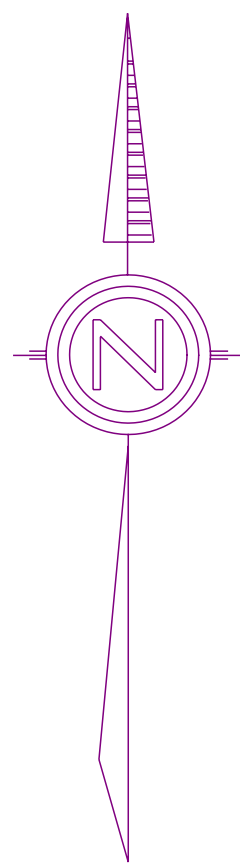


LANDSCAPE
SCALE: 1" = 10'-0"



- LAWN
- PERINNIAL FLOWERS
- ASPEN TREE
- PINE TREE
- SHRUB
- FLOWER BED

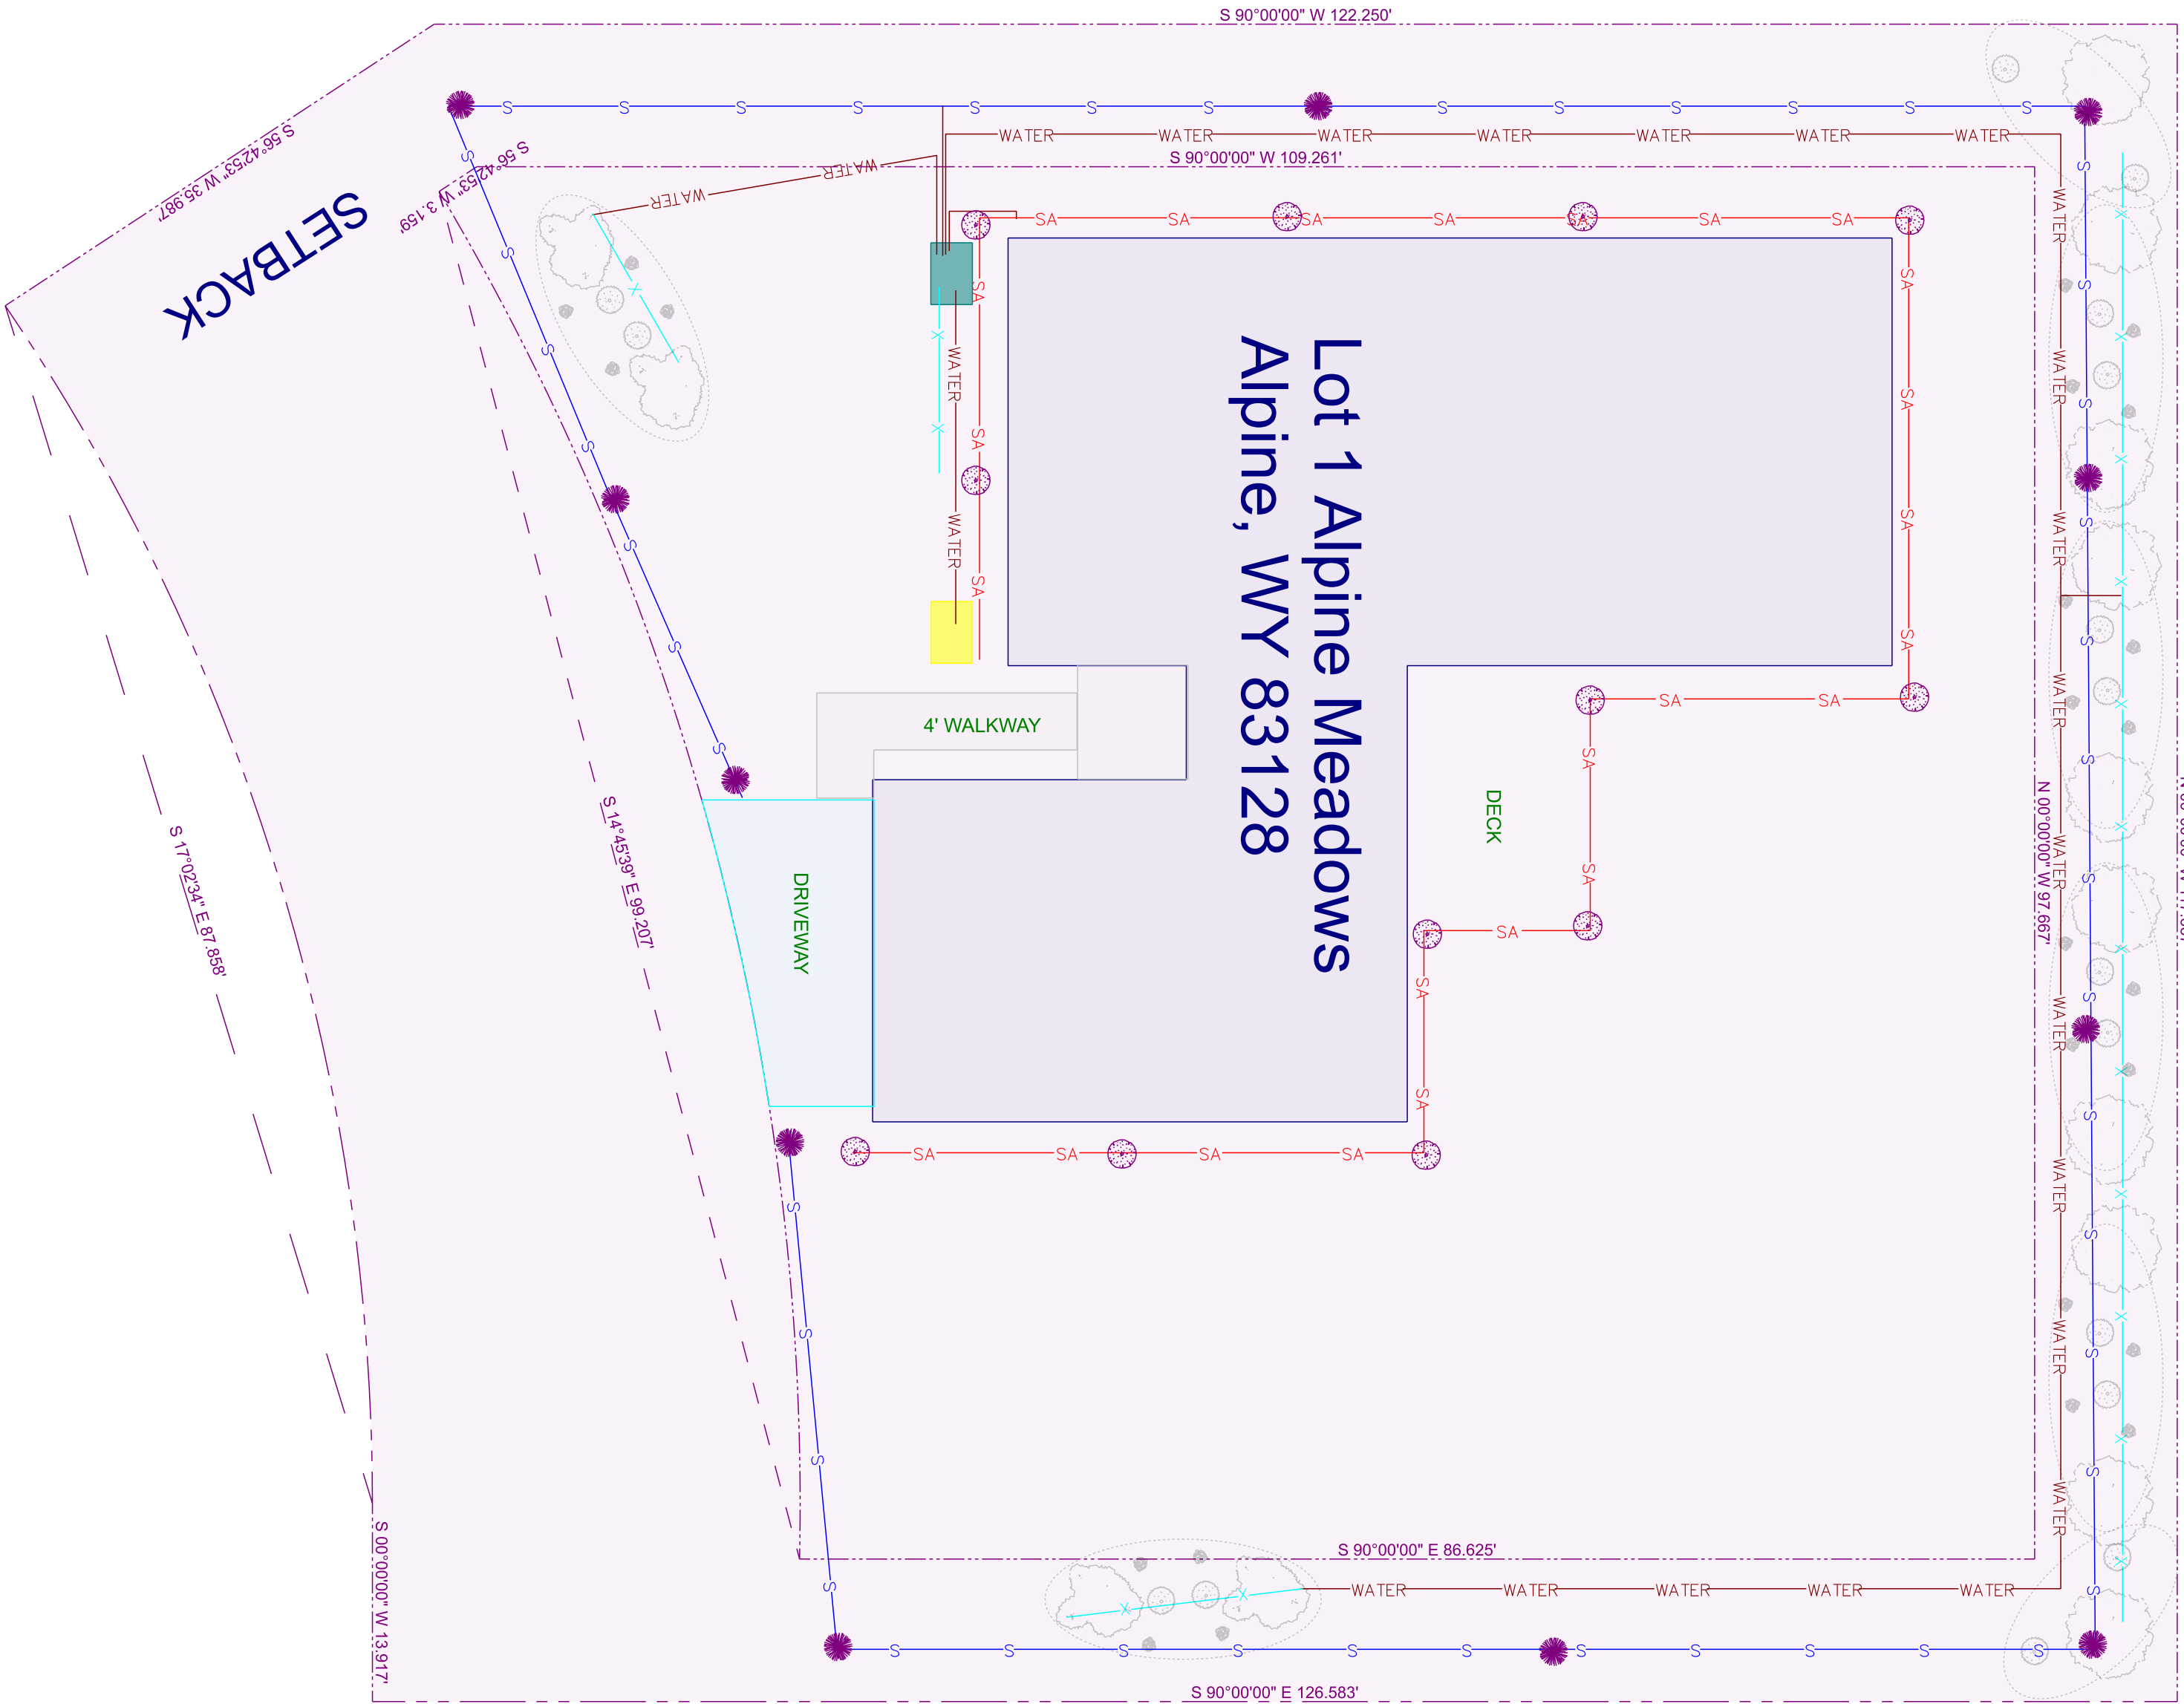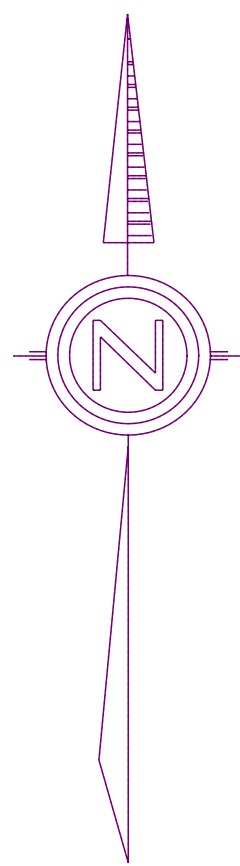

SPRINKLER
SCALE: 1" = 10'-0"

- DRIP LINES
- WATER CONNECTOR
- SPRAYER LINE
- SPRINKLER LINE
- SPRAYHEAD NOZZLE
- ROTARY SPRINKLER
- VALVE BOX
- CONTROL BOX

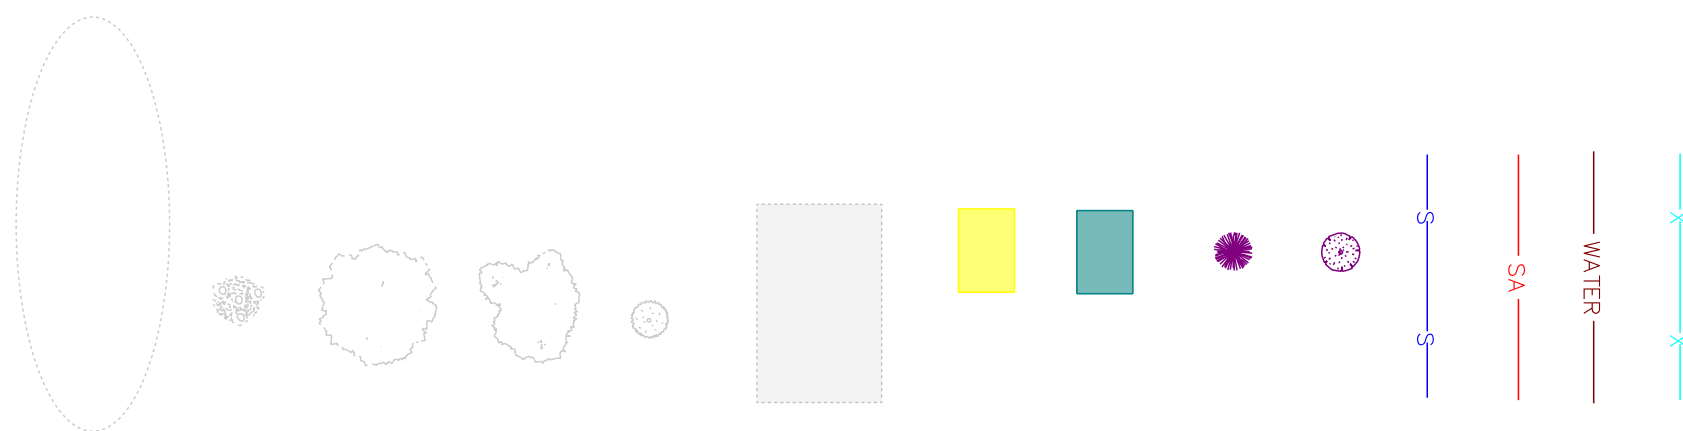

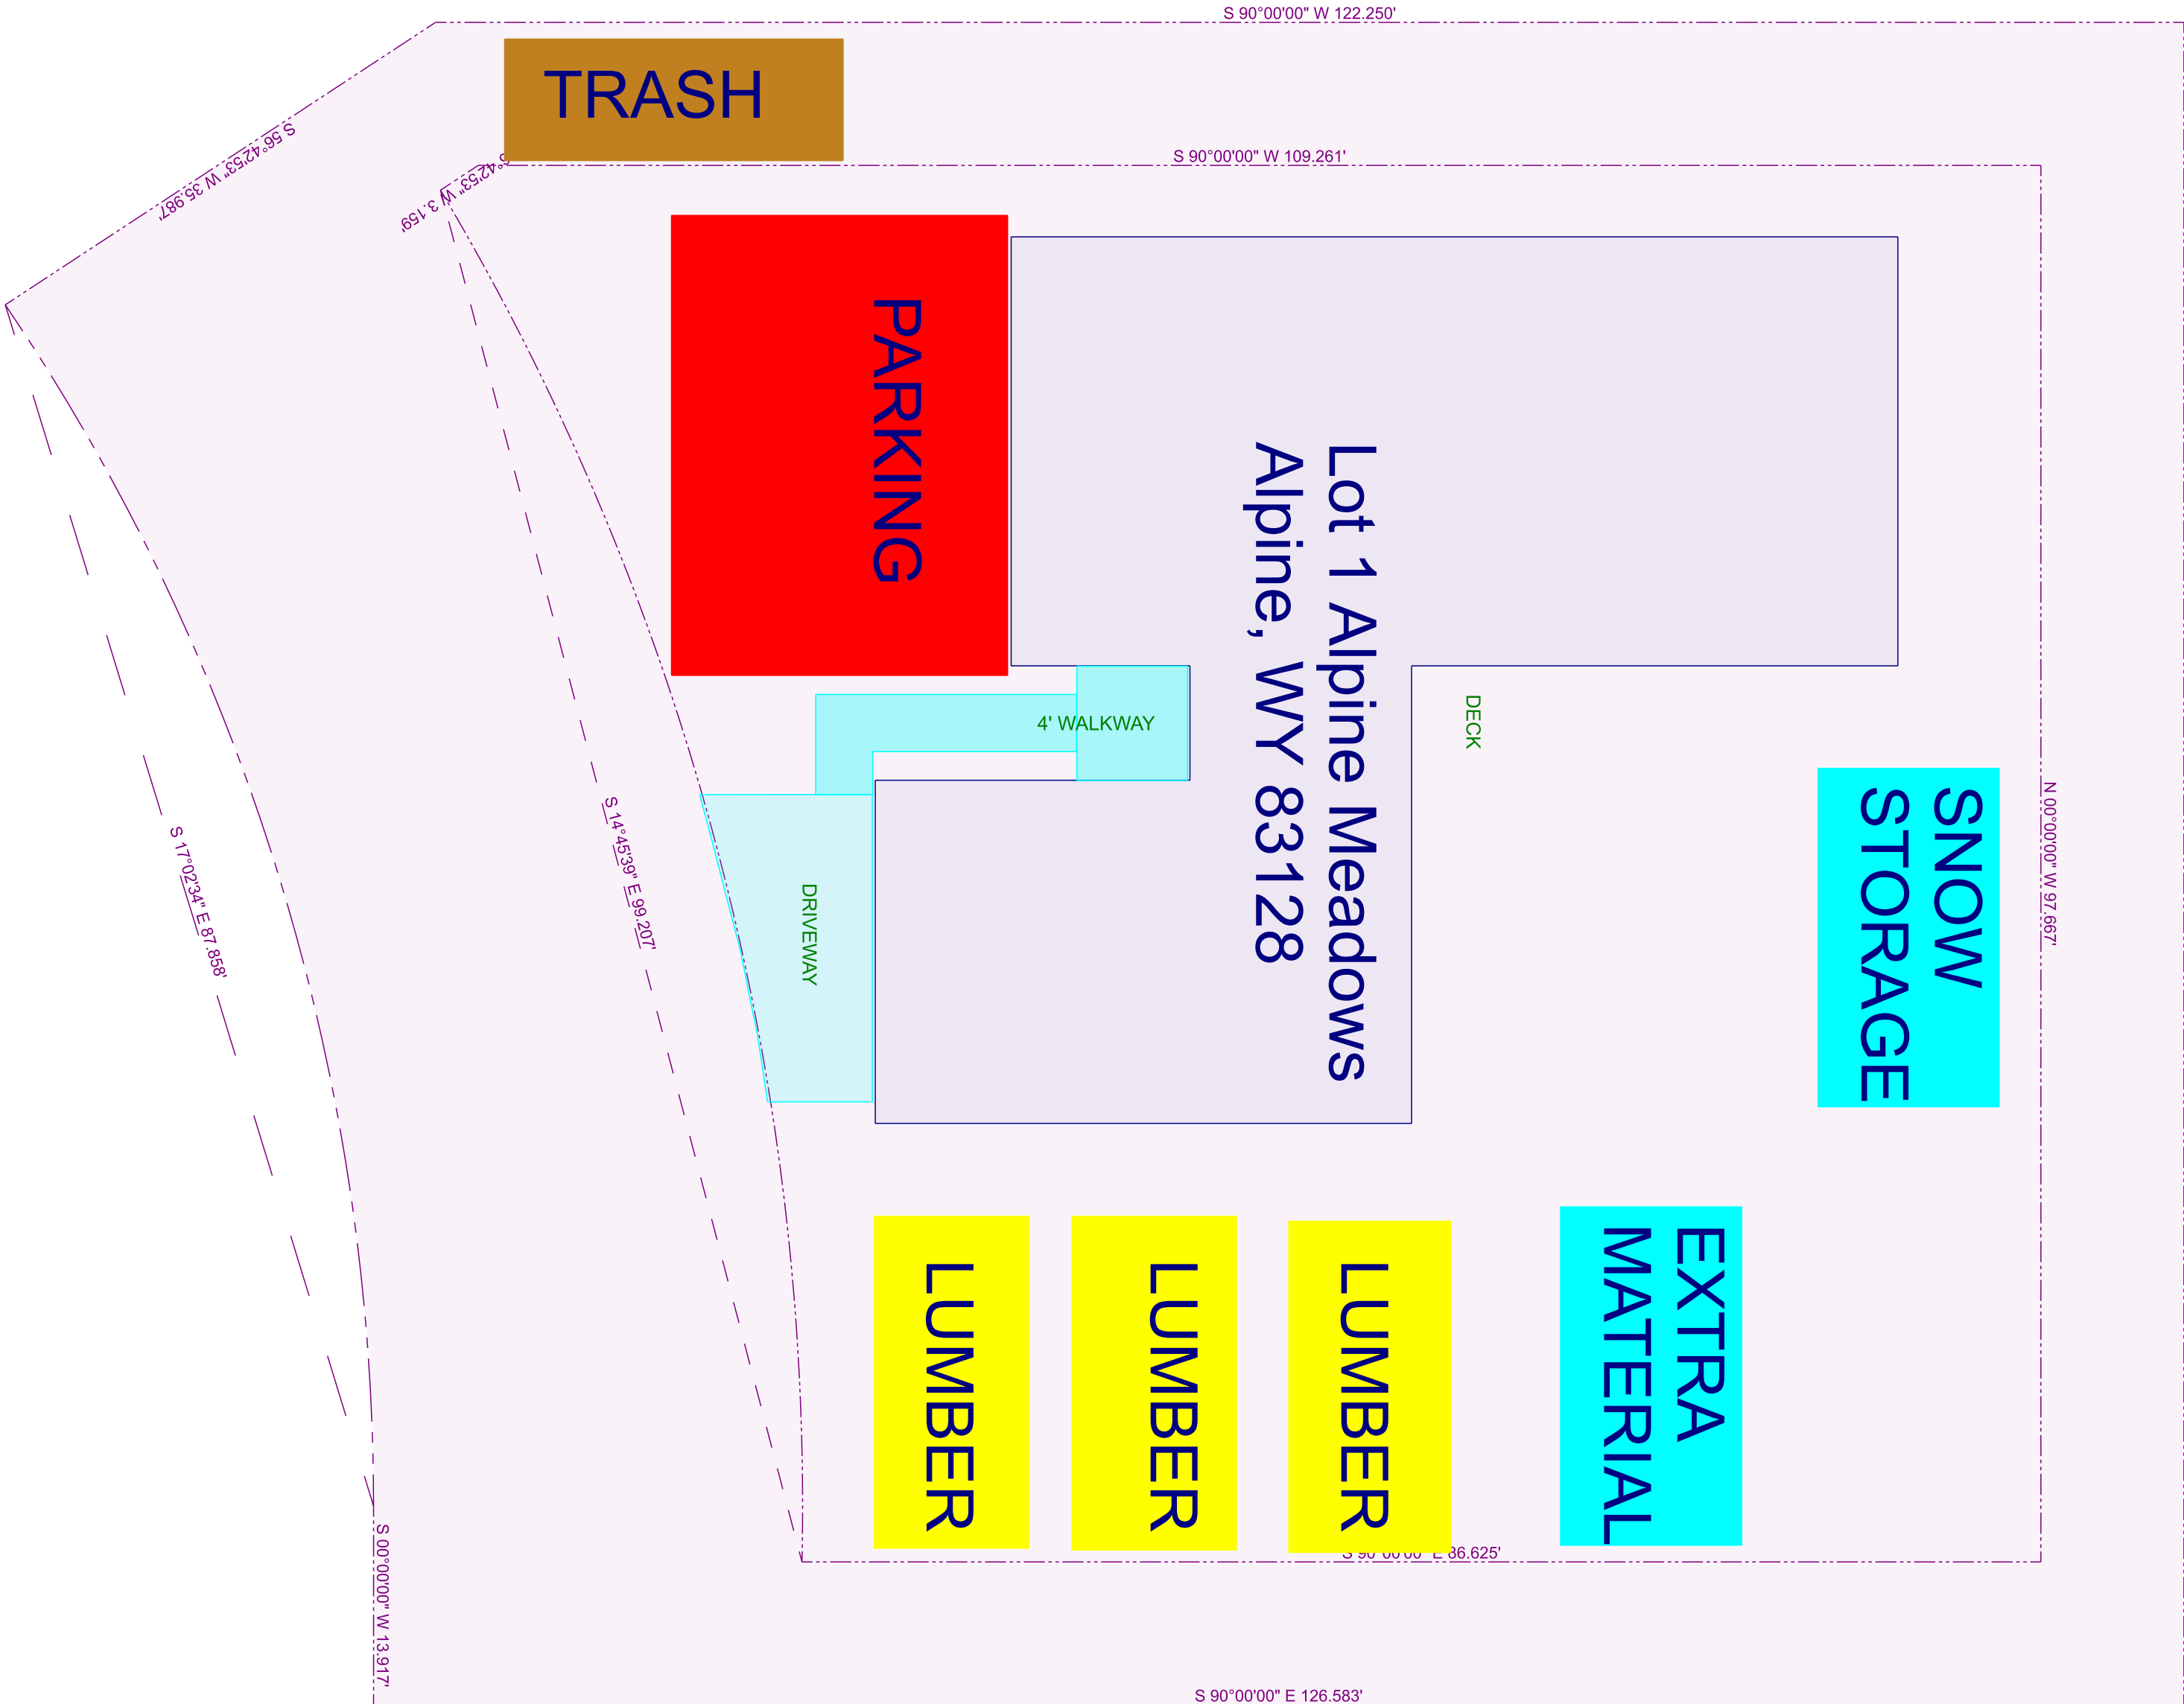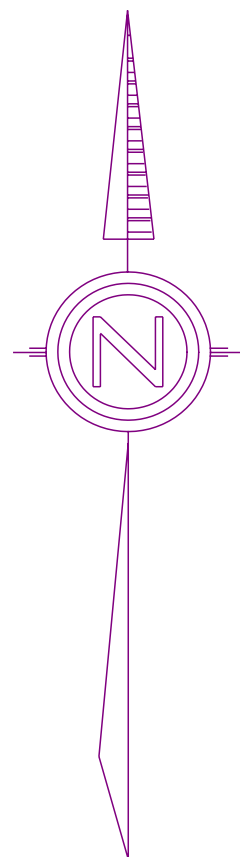

SWPPP
SCALE: 1" = 10'-0"