




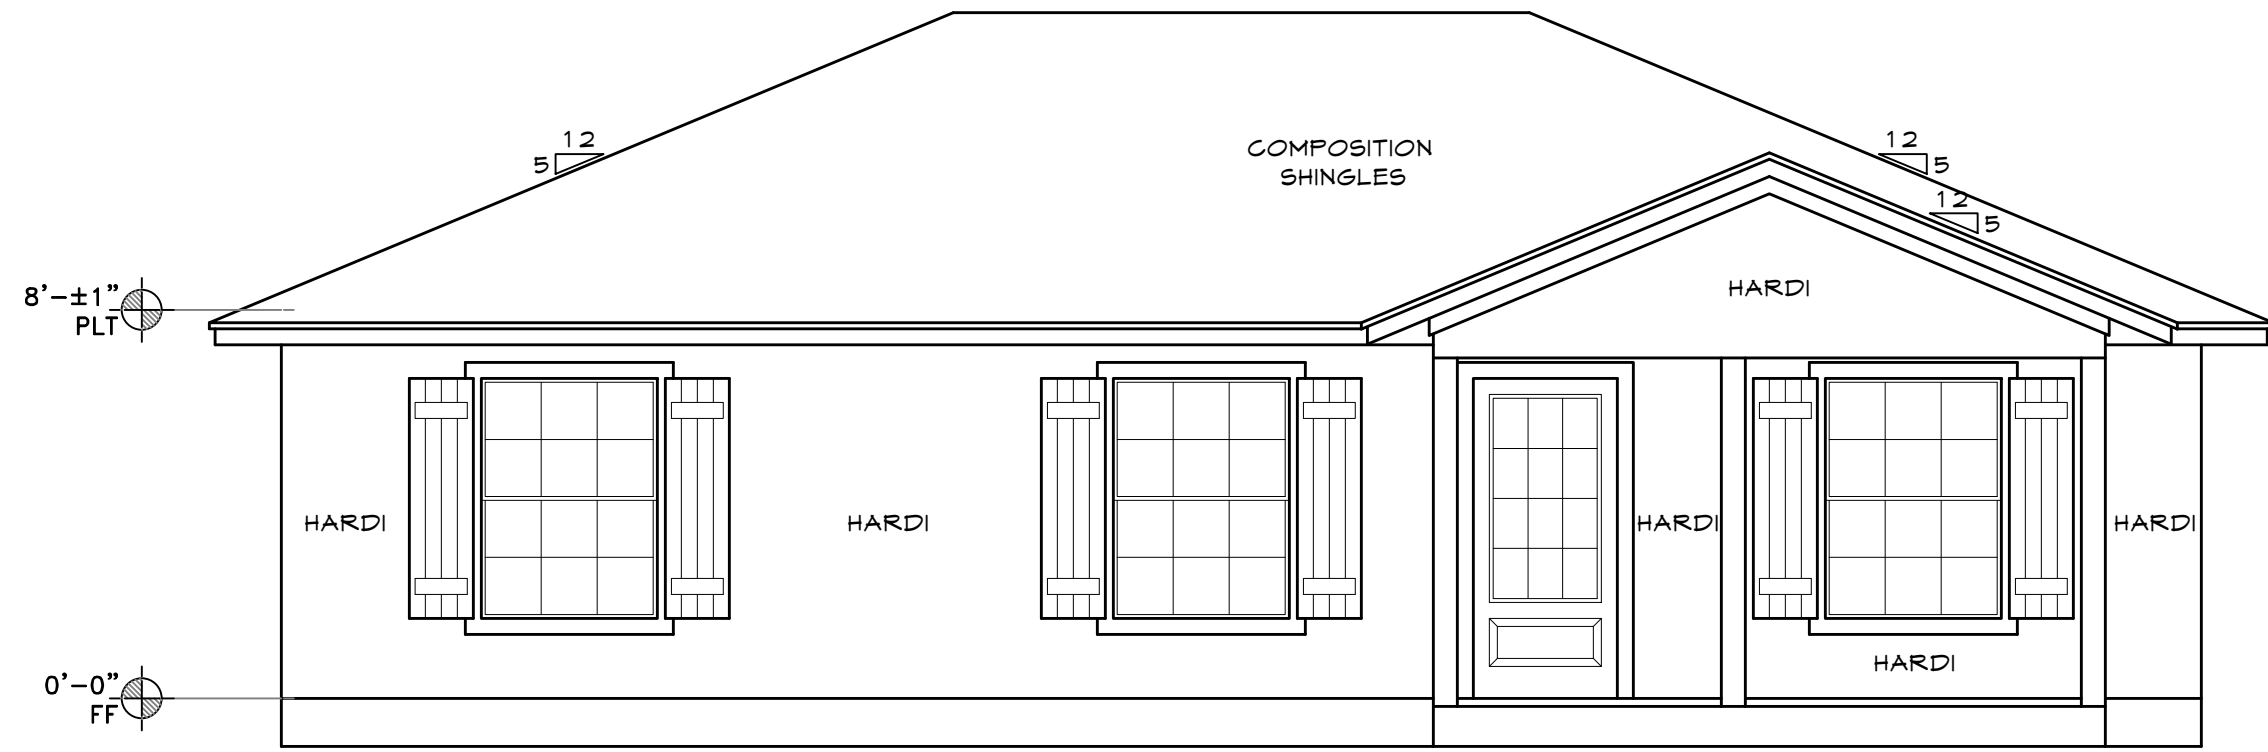


1 FRONT VIEW
A1 SCALE: 1/4" = 1'

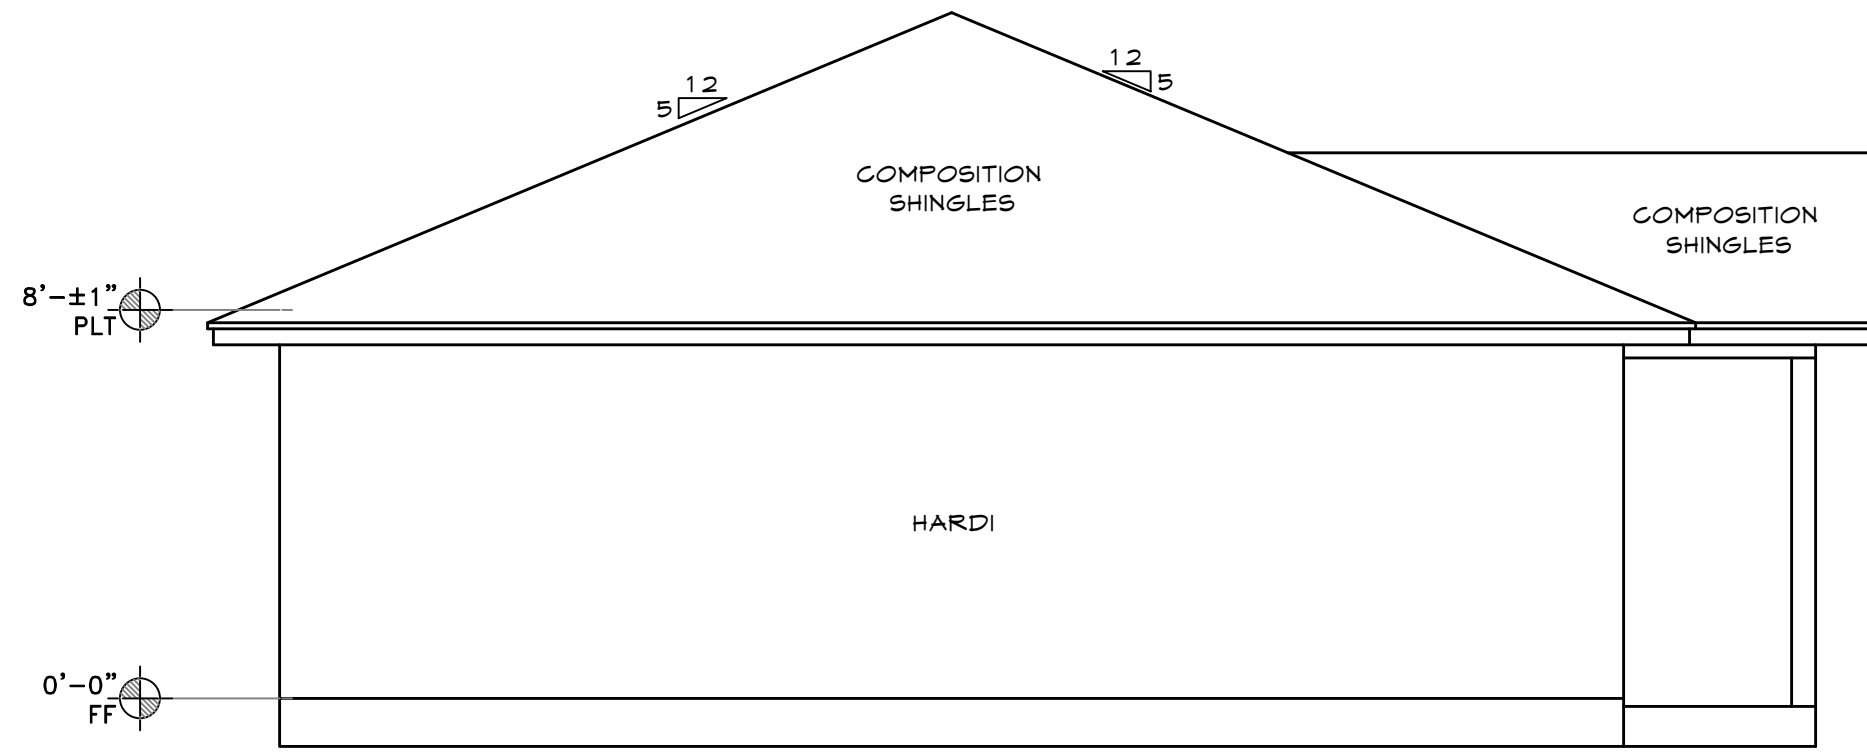



2 LEFT SIDE VIEW
A2 SCALE: 1/4" = 1'

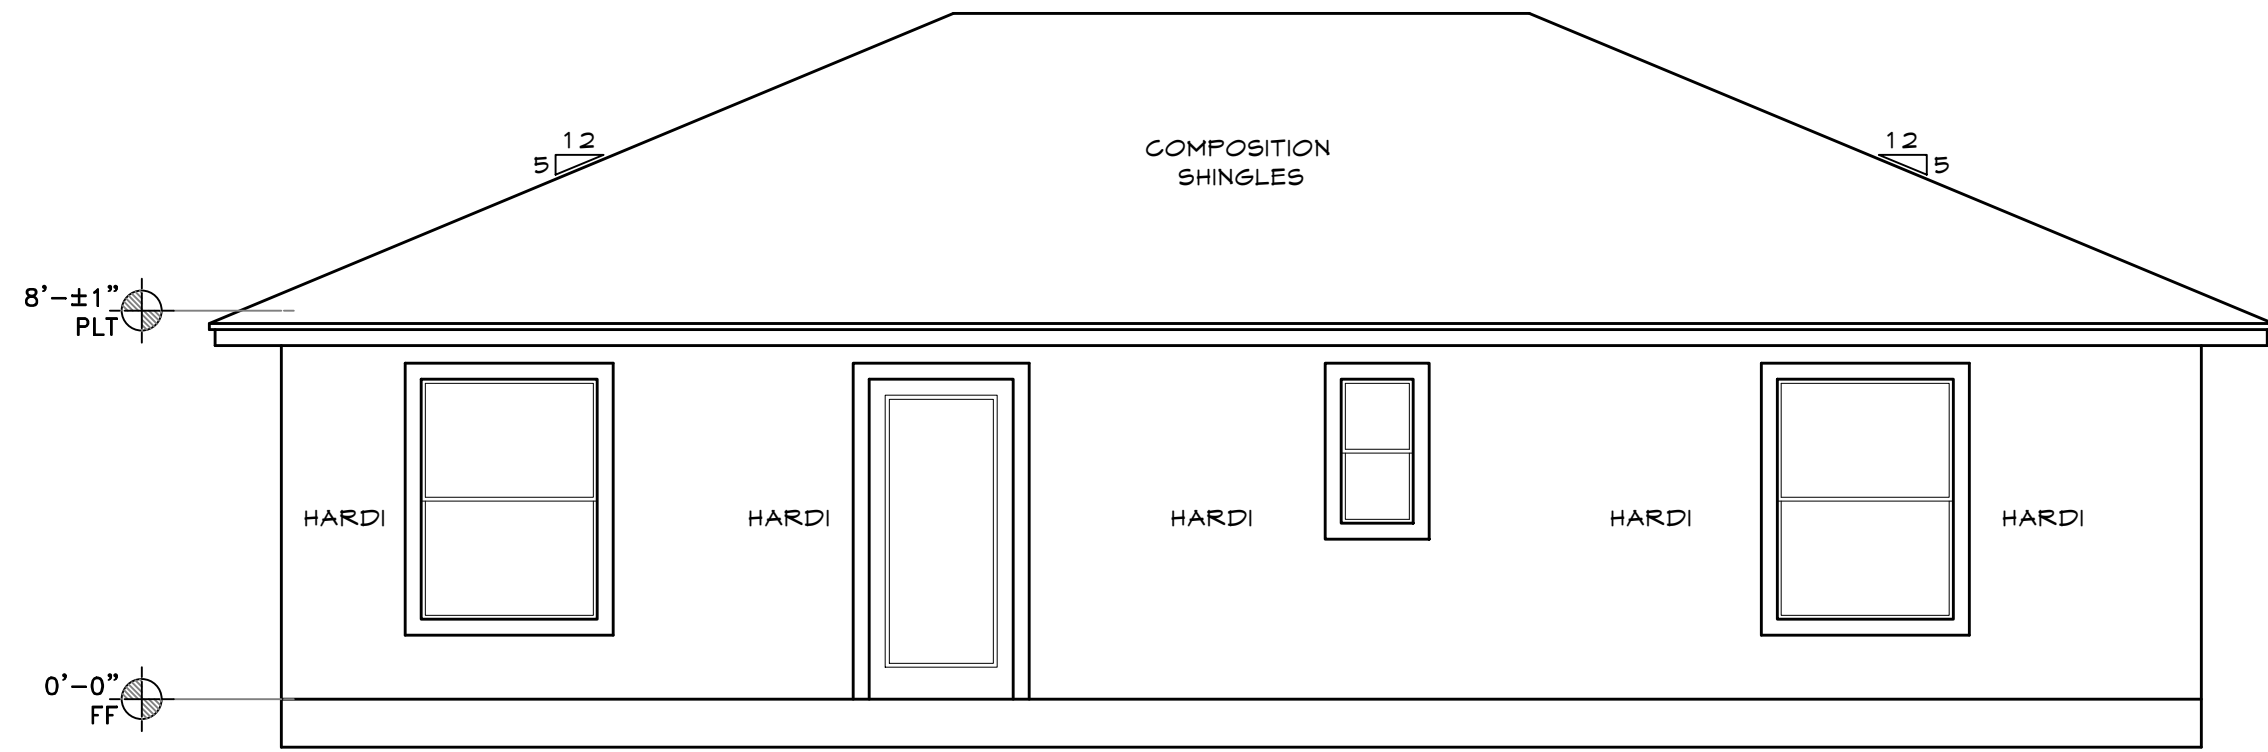

1 REAR VIEW
A2 SCALE: 1/4" = 1'

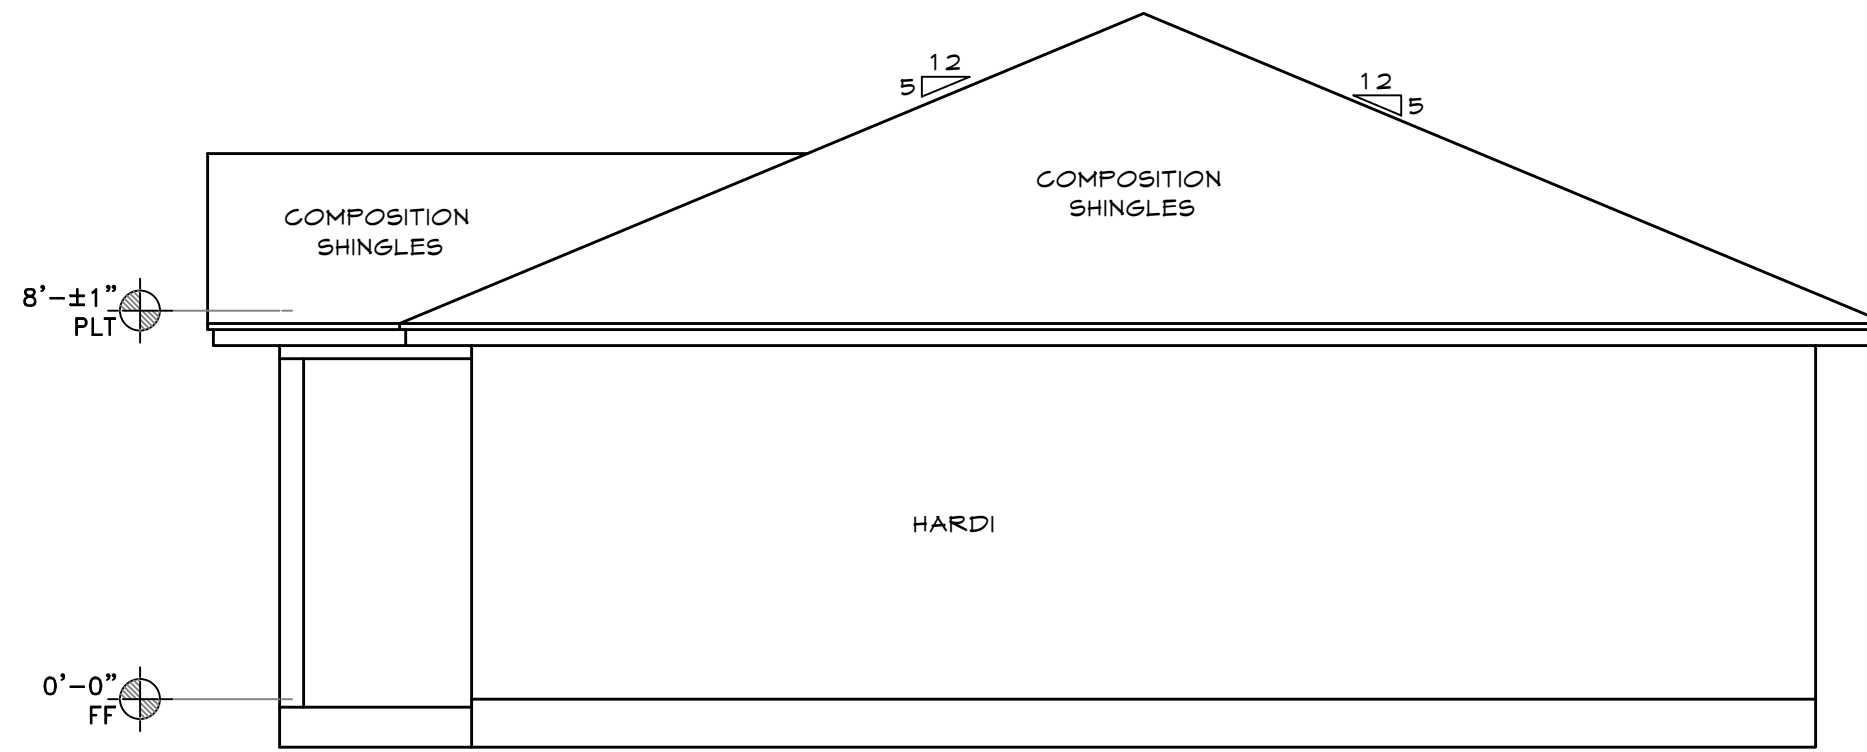

2 RIGHT SIDE VIEW
A1 SCALE: 1/4" = 1'

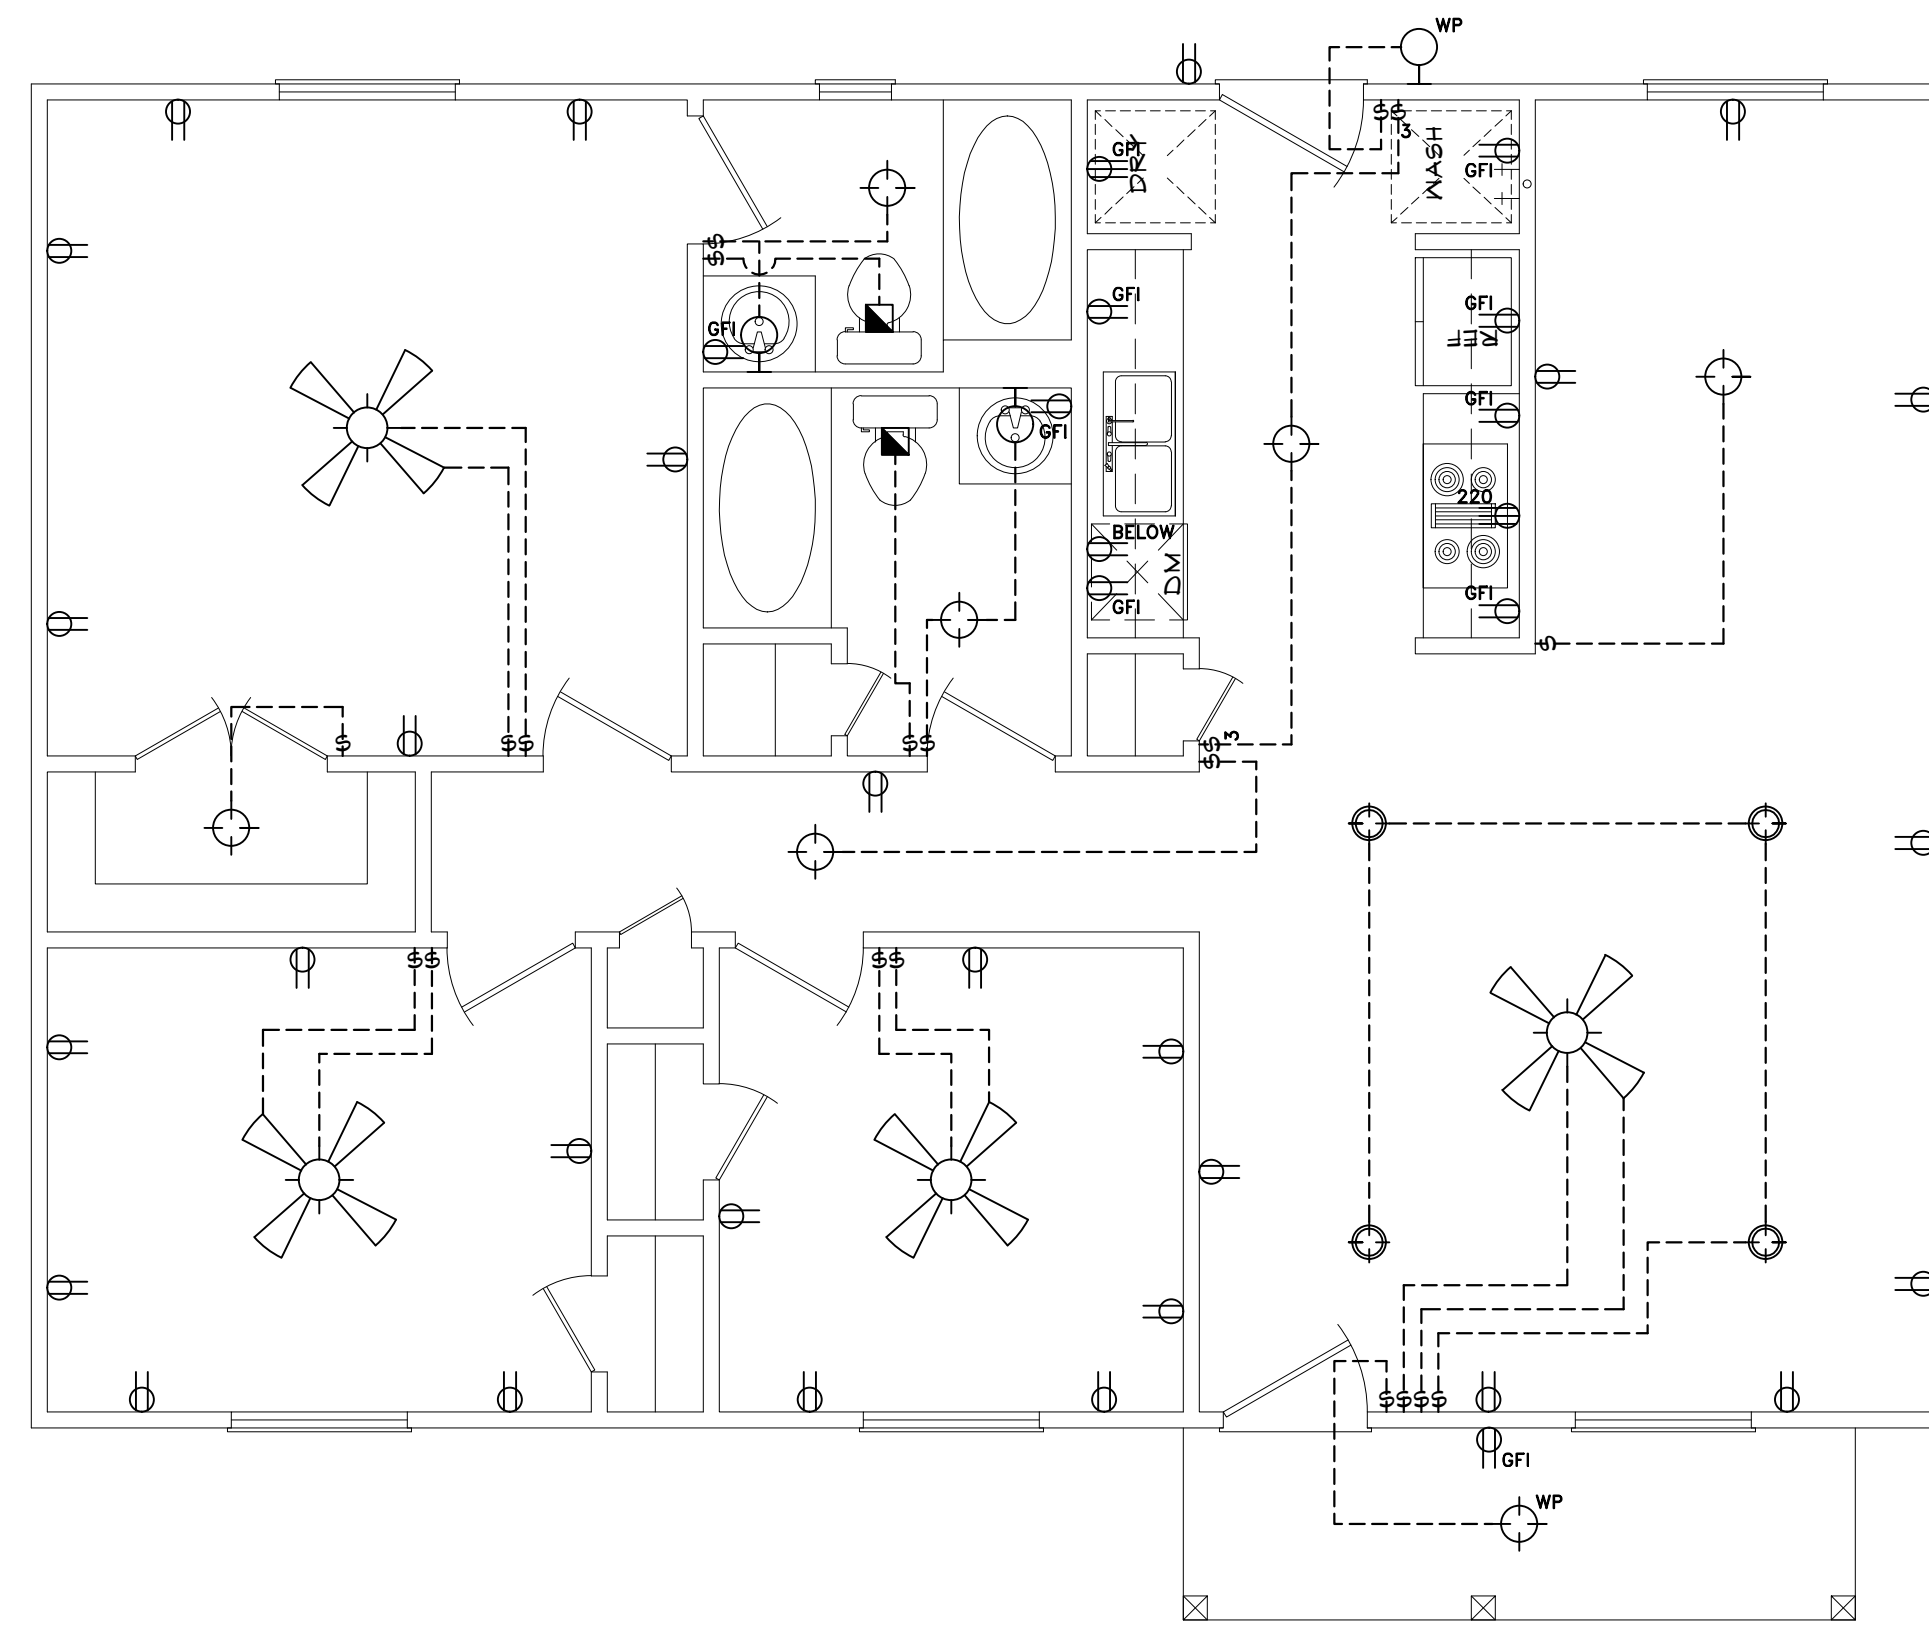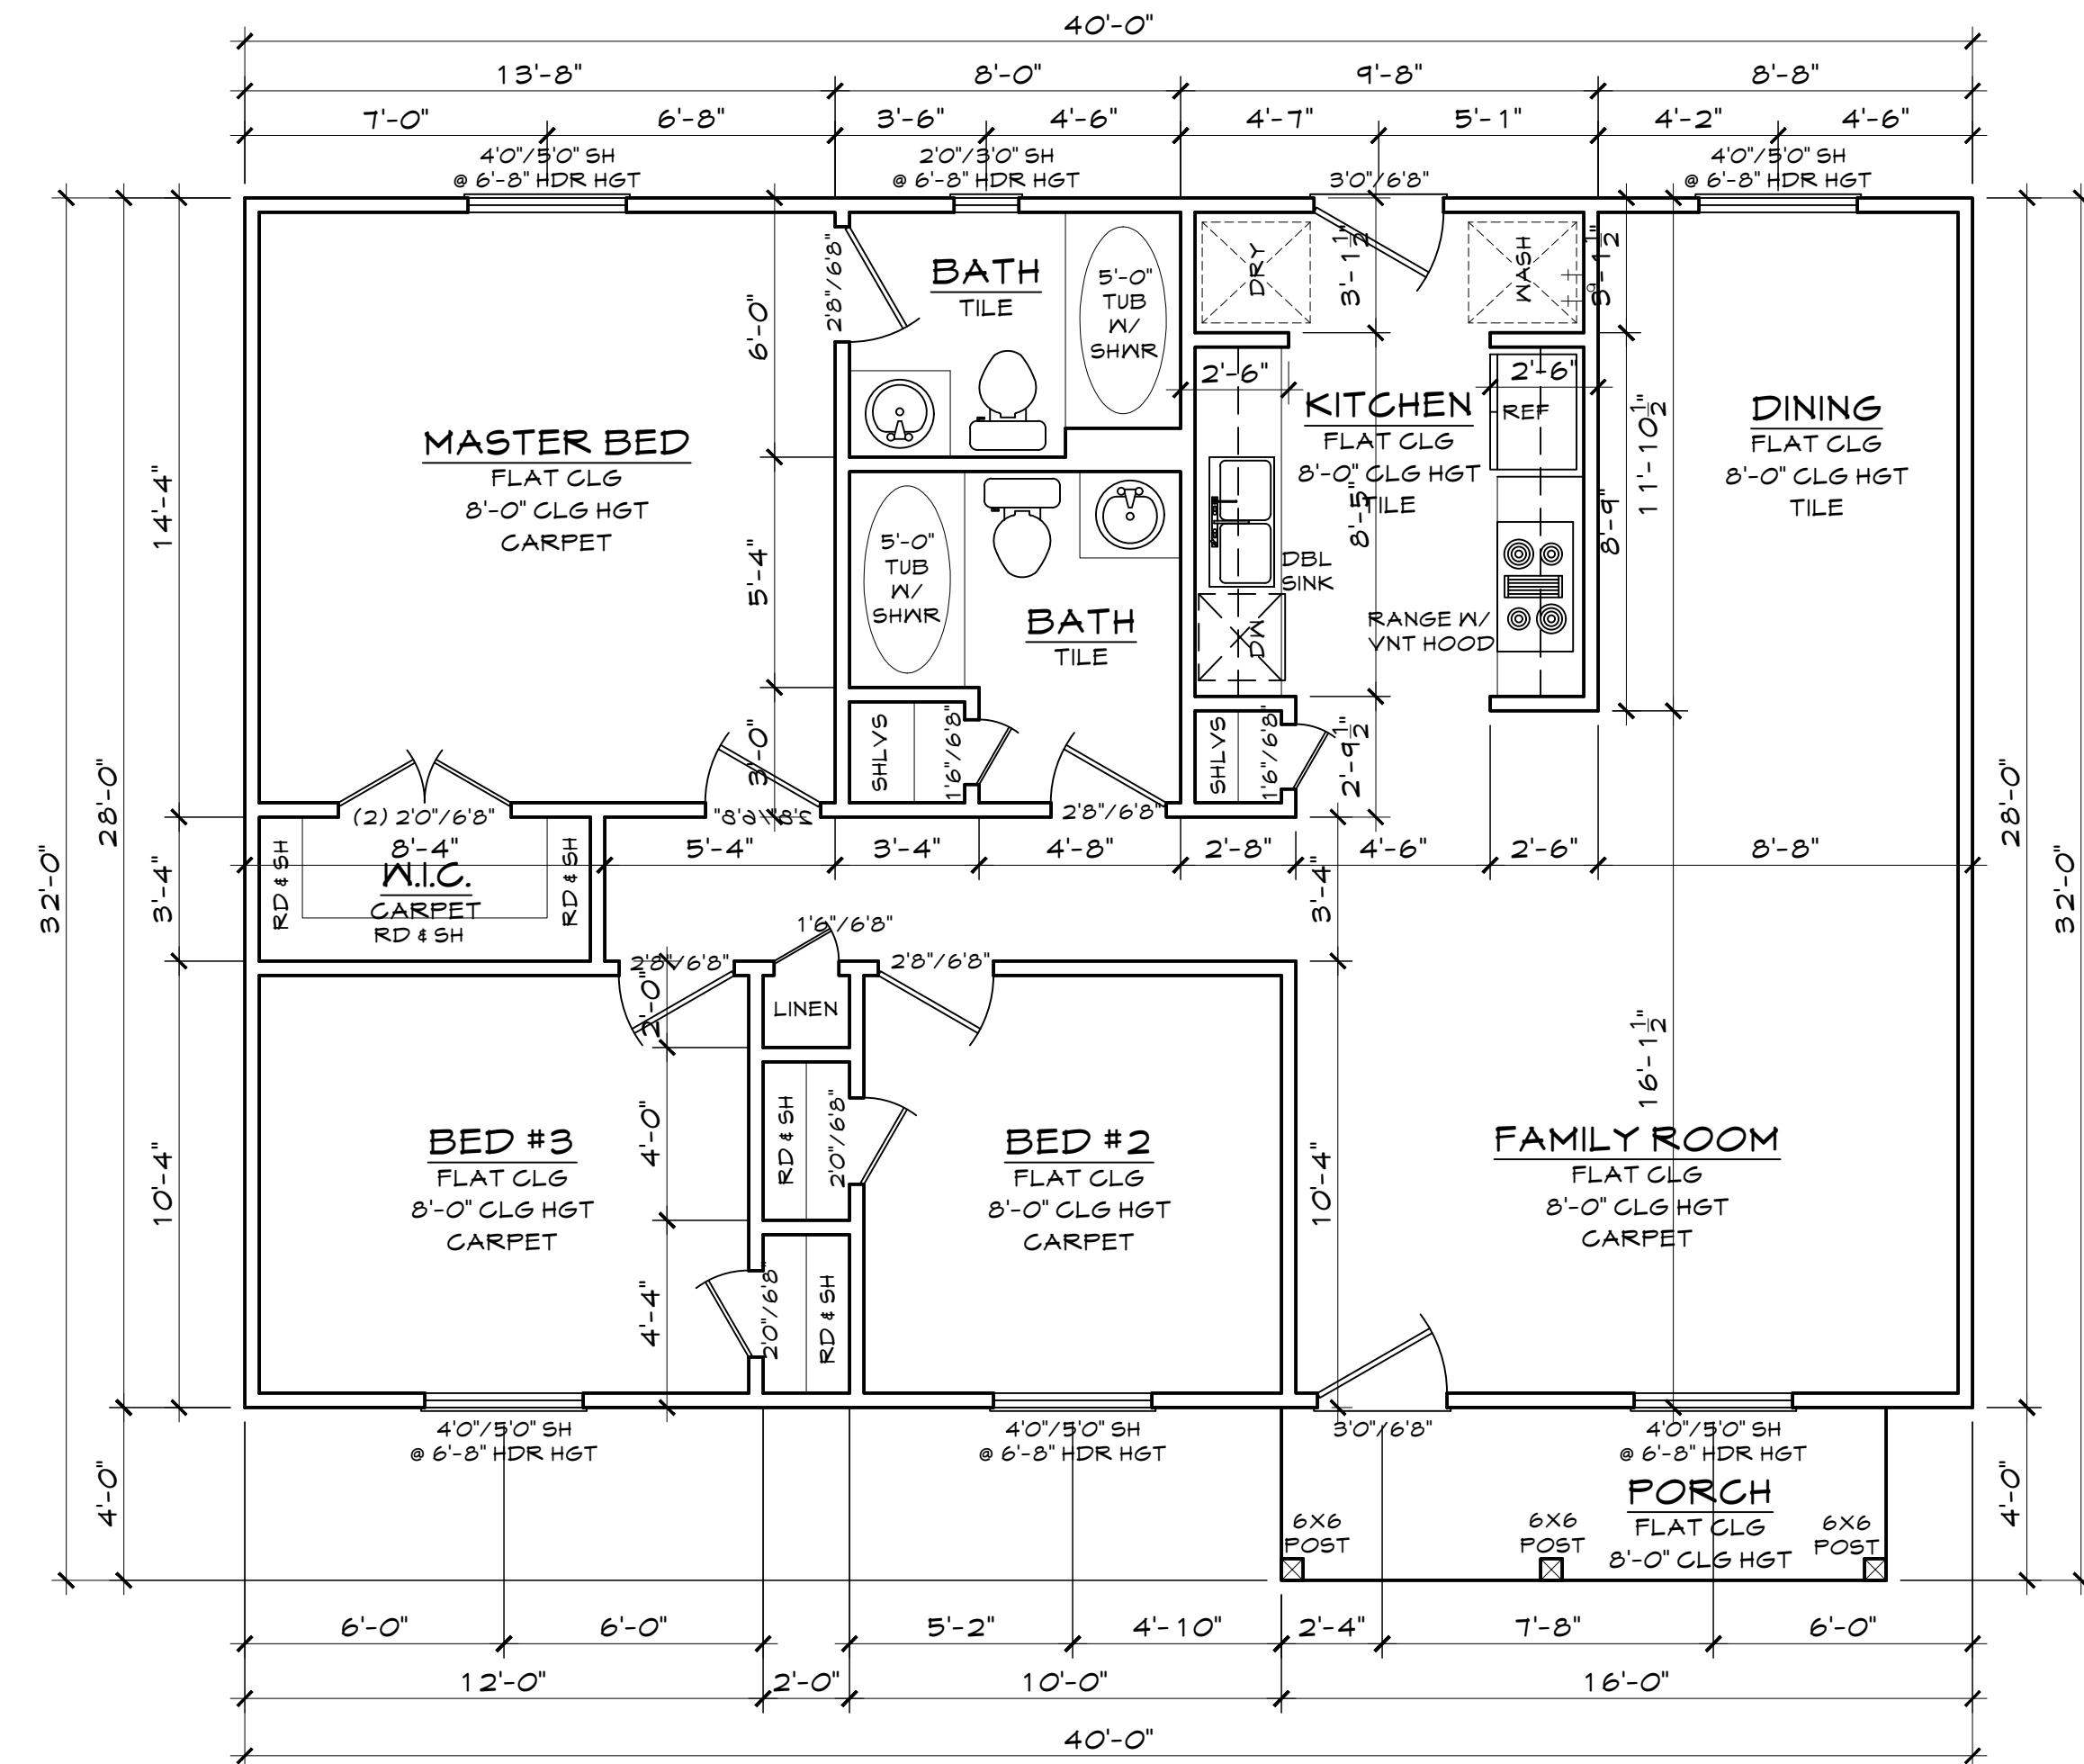

ELECTRICAL LEGEND	
SYMBOL	DESCRIPTION
	RECESSED LIGHT FIXTURE
	CEILING MOUNTED LIGHT FIXTURE
	WALL MOUNT LIGHT FIXTURE
	VENT
	SMOKE DETECTOR
	220 V. DUPLEX RECEPT OUTLET
	110 V. DUPLEX RECEPT OUTLET
	110 V. FLOOR OUTLET
	GROUND FAULT INTERRUPTER DUPLEX RECEPTACLE OUTLET
	WATER PROOF OUTLET
	SINGLE POLE SWITCH
	2 WAY SWITCH
	DIMMER SWITCH
	2 WAY SWITCH WITH DIMMER
	PUSH BUTTON GARAGE DOOR
	DOOR BELL
	CHIME
	TELEVISION JACK
	PHONE JACK
	GAS LINE CONNECTION
	GARAGE DOOR OPENER
	JUNCTION BOX
	FLOOD LIGHTS

ELECTRICAL NOTES:
-SMOKE DETECTORS IN ALL BED ROOMS, REQUIRE 110V TO HOUSE WIRING, BATTERY BACKUP & INTERCONNECT
-VENT ALL EXHAUST FANS TO OUTSIDE
-PROVIDE G.F.I. PROTECTION ON BATH PLUGS
-PROVIDE LIGHT FIXTURE & SMOKE DETECTORS AT WATER HEATER & A/C UNIT
-PROVIDE ELECTRIC DISCONNECT AT A/C UNIT

ABBREVIATIONS							
SH	SINGLE HUNG	EB	EYE BROW	PAN	PANTRY	W.I.C.	WALK-IN CLOSET
DL	DIVIDED LIGHTS	PKT	POCKET	RM	ROOM	DBL	DOUBLE
HD	HEADER	DR	DOOR	CLST	CLOSET	SNK	SINK
HT	HEIGHT	FG	FIXED GLASS	SHLVS	SHELVES	DW	DISH WASHER
OH	OVERHEAD	OBSSG	OBSCURED GLASS	CW	COLD WATER TAP	MSTR	MASTER
SECT	SECTIONAL	/BTH	HALF BATH	CLG	CEILING		

MOONLIGHT HOUSE PLANS IS A DRAFTING FIRM, NOT AN ENGINEERING OR ARCHITECTURAL FIRM. THESE PRINTS ARE FOR INFORMATIONAL PURPOSES ONLY. MOONLIGHT HOUSE PLANS IS NOT RESPONSIBLE FOR ANY STRUCTURAL OR DESIGN MISTAKES. DIMENSIONS, DETAILS & SPECIFICATIONS. DESIGNER WILL NOT BE LIABLE FOR HUMAN ERROR AFTER CONSTRUCTION IS STARTED. THESE DRAWINGS, SPECIFICATIONS AND DEAS ARE THE PROPERTY OF MOONLIGHT HOUSE PLANS, AND SHALL NOT BE REUSED, REPRODUCED, OR ALTERED IN ANY WAY.

Moonlight House Plans
979-482-1967

REVISION HISTORY	DATE
	NUMBER

DWG. SCALE:
1/4" = 1'-0"

FLOOR PLAN
BRAZORIA COUNTY
PLAN 1120

JOB #: 20152968

12-07-15

A1