



CITY ENGINEER APPROVAL	CONSULTANT PROJECT MANAGER D. RICHARD	REGISTRATION No.	LICENSE Exp DATE	DATE SIGNED	APPROVED AS TO IMPACT ON CITY FACILITIES AND CONFORMANCE WITH APPLICABLE CITY STANDARDS AND PRACTICES AND THAT TECHNICAL OVERSIGHT WAS PERFORMED.

CITY OF ANGELS
CALAVERAS COUNTY, CALIFORNIA
WATER METER REPLACEMENT PROJECT
PHASE 1 AND PHASE 2

TO BE SUPPLEMENTED BY THE CITY OF ANGELS 2010 IMPROVEMENT STANDARDS

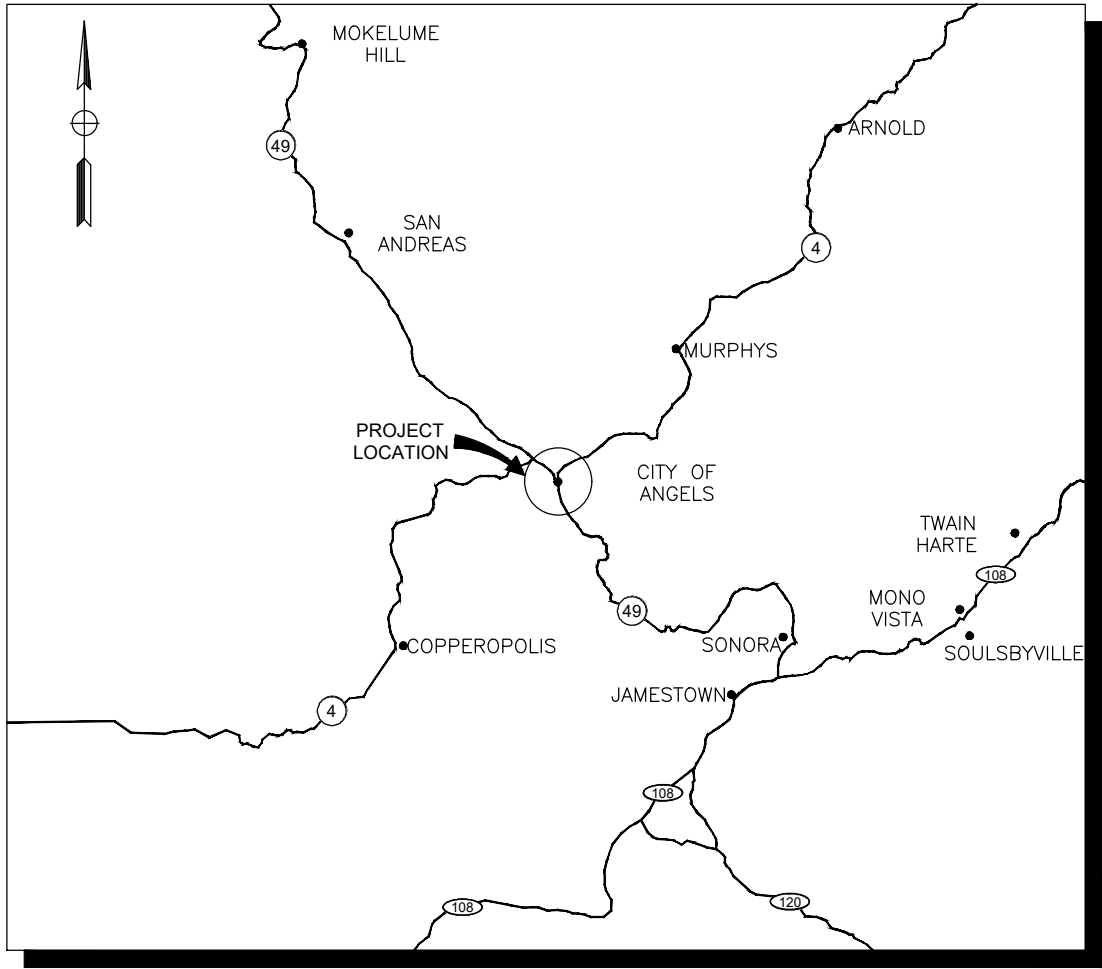



VICINITY MAP
NO SCALE

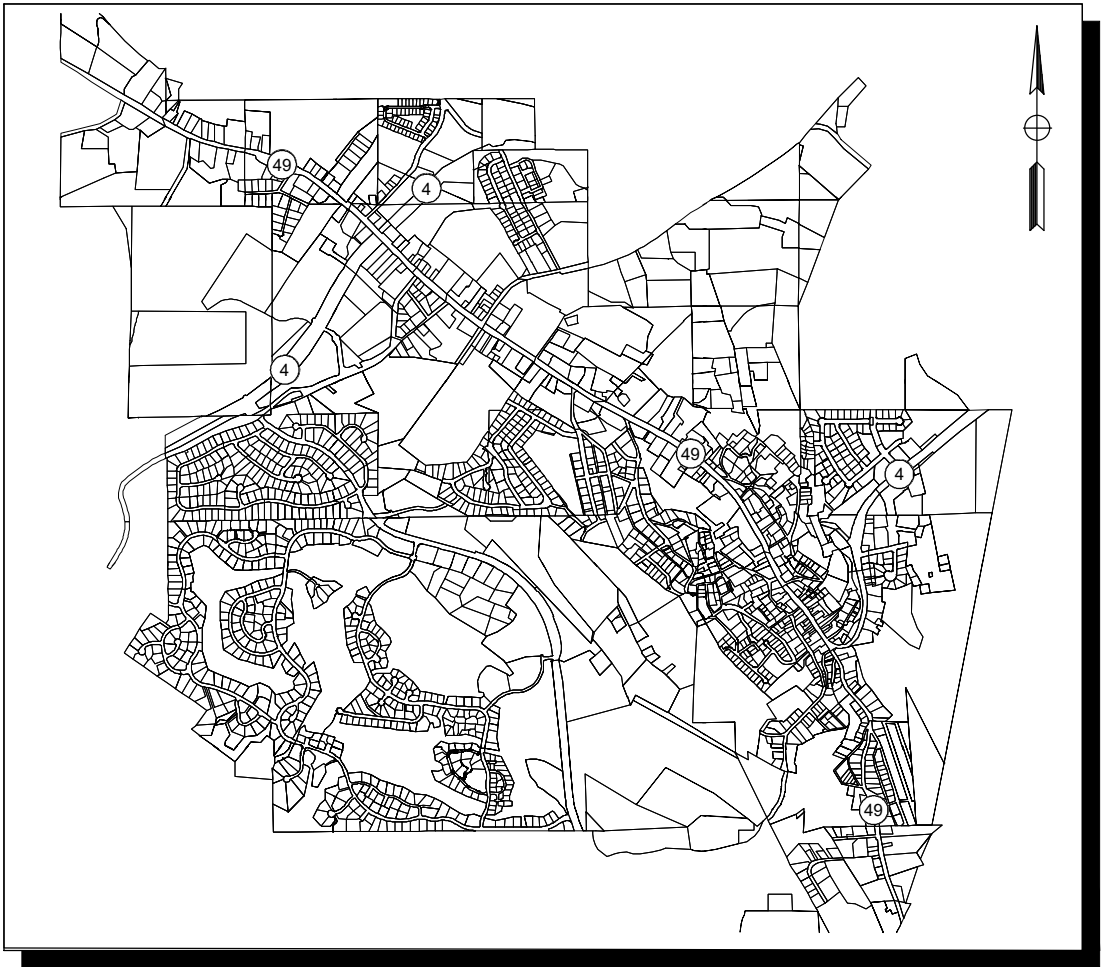

LOCATION MAP
NO SCALE



SHEET No.	TOTAL SHEETS
1	21

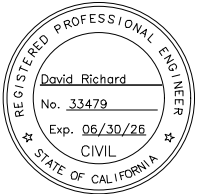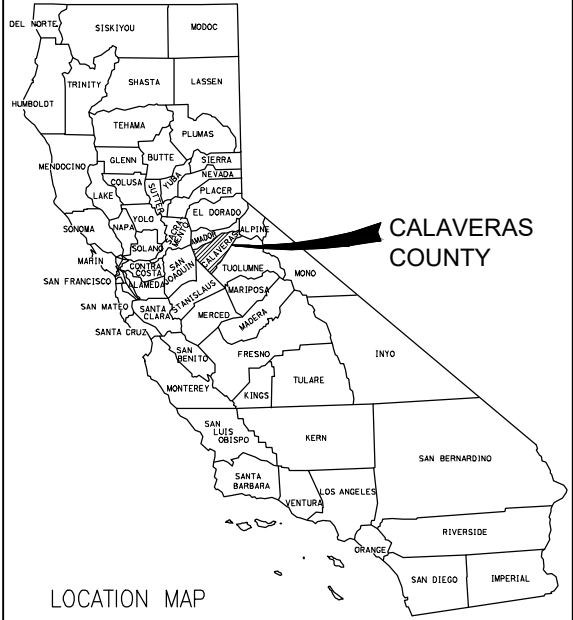

G0.10

TITLE SHEET

DEWBERRY
903 W CENTER STREET
MANTECA, CA 95337
CITY OF ANGELS
DEPARTMENT OF PUBLIC WORKS
2990 CENTENNIAL ROAD
ANGELS CAMP, CA 95222

BID SET

USERNAME = cogular
DGN FILE = COA-WMRP-G0.10.dwg


UNIT 0000 PROJECT NUMBER & PHASE 00000000001

THE CONTRACTOR SHALL POSSESS THE CLASS (OR CLASSES)
OF LICENSE AS SPECIFIED IN THE "NOTICE TO CONTRACTORS"



LAST REVISION DATE PLOTTED = Nov 17, 2025
11-17-25 TIME PLOTTED = 12:57 pm

CITY OF ANGELS - DEPARTMENT OF PUBLIC WORKS	CONSULTANT PROJECT MANAGER	CALCULATED-DESIGNED BY	C. AGUIAR	REVISED BY	C. AGUIAR	
WATER METER REPLACEMENT PROJECT	D. RICHARD	CHECKED BY	D. RICHARD	DATE REVISED	11/17/25	

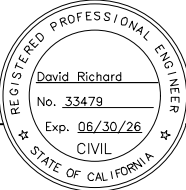 Dewberry®	<table><tr><th>SHEET No.</th><th>TOTAL SHEETS</th></tr><tr><td>2</td><td>21</td></tr></table>	SHEET No.	TOTAL SHEETS	2	21
	SHEET No.	TOTAL SHEETS			
2	21				
					
CITY OF ANGELS DEPARTMENT OF PUBLIC WORKS 2990 CENTENNIAL ROAD ANGELS CAMP, CA 95222	DEWBERRY 903 W CENTER STREET MANTECA, CA 95337				

		GO. 20
LIST OF DRAWINGS, SYMBOLS AND ABBREVIATIONS		

<u>INDEX OF PLANS</u>		
<u>SHEET NO.</u>	<u>DRAWING</u>	<u>DESCRIPTION</u>
<u>GENERAL</u>		
1	G0.10	TITLE SHEET
2	G0.20	LIST OF DRAWINGS, SYMBOLS AND ABBREVIATIONS
3	G0.30	GENERAL CONSTRUCTION NOTES
4	G0.40	GENERAL SYMBOLS, VALVE SYMBOLS AND UTILITY CONTACTS
<u>CIVIL</u>		
5	C0.01	OVERVIEW OF WATER METER READING ROUTES AND INVENTORY
6	C0.02	METER REPLACEMENT DETAILS
7	C1.00	WATER METER REPLACEMENT SCHEDULE ROUTE 1-1
8	C1.01	WATER METER REPLACEMENT SCHEDULE ROUTE 1-2
9	C1.02	WATER METER REPLACEMENT SCHEDULE ROUTE 2
10	C1.03	WATER METER REPLACEMENT SCHEDULE ROUTE 3
11	C1.04	WATER METER REPLACEMENT SCHEDULE ROUTE 4-1
12	C1.05	WATER METER REPLACEMENT SCHEDULE ROUTE 4-2
13	C1.06	WATER METER REPLACEMENT SCHEDULE ROUTE 5
14	C1.07	WATER METER REPLACEMENT SCHEDULE ROUTE 7
15	C1.08	WATER METER REPLACEMENT SCHEDULE ROUTE 8-1
16	C1.09	WATER METER REPLACEMENT SCHEDULE ROUTE 8-2
17	C1.10	WATER METER REPLACEMENT SCHEDULE ROUTE 10
18	C1.11	WATER METER REPLACEMENT SCHEDULE ROUTE 11
19	C1.12	WATER METER REPLACEMENT SCHEDULE ROUTE 12
20	C1.13	WATER METER REPLACEMENT SCHEDULE ROUTE 13
21	C1.14	WATER METER REPLACEMENT SCHEDULE ROUTE 99

<u>GENERAL ABBREVIATIONS</u>			
AB	AGGREGATE BASE	GSM	GALVANIZED SHEET METAL
AGG	AGGREGATE	GPS	GLOBAL POSITIONING SYSTEM
CIPP	CURED IN PLACE PIPE	GSP	GALVANIZED STEEL PIPE
¢	CENTERLINE	GV	GATE VALVE
CONC	CONCRETE	HGT	HEIGHT
COORD	COORDINATE	HORIZ	HORIZONTAL
CU FT	CUBIC FEET	HR	HOSE RACK
CU IN	CUBIC INCH	ID	INSIDE DIAMETER
CY	CUBIC YARD	IN	INCH
C—C	CENTER TO CENTER	INV, I.E.	INVERT ELEVATION
DET	DETAIL	LB/CU FT	POUNDS PER CUBIC FOOT
DIA, Ø	DIAMETER	LF	LINEAR FEET
DIP	DUCTILE IRON PIPE	MAX	MAXIMUM
DRWG	DRAWING	MECH	MECHANICAL
EA	EACH	MFR	MANUFACTURER
EL, ELEV	ELEVATION	MH	MANHOLE
ELL	ELBOW	MIN	MINIMUM
ELEC	ELECTRIC	MISC	MISCELLANEOUS
ENGR	ENGINEER	MJ	MECHANICAL JOINT
EX	EXISTING	NO.	NUMBER
FDC	FIRE DEPARTMENT CONNECTION	NTS	NOT TO SCALE
FG	FINISHED GRADE	NIC	NOT IN CONTRACT
FIG	FIGURE	OC	ON CENTER
FL	FLANGED	OD	OUTSIDE DIAMETER
FLR	FLOOR	OG	ORIGINAL GRADE
FT	FOOT		

OHE	OVERHEAD ELECTRICAL
P	PROPOSED
PC	POINT OF CURVATURE
PE	PLAIN END
PI	POINT OF INTERSECTION
P/L	PROPERTY LINE
PP	POWER POLE
PT	POINT OF TANGENCY
PVC	POLYVINYL CHLORIDE
RCP	REINFORCED CONCRETE PIPE
REF	REFER OR REFERENCE
REINF	REINFORCE(D)
RMJ	RESTRAINED MECHANICAL JOINT
R.O.W.	RIGHT-OF-WAY
SCHED	SCHEDULE
SHT	SHEET
SLP	SLOPE
SQ	SQUARE
SQ FT	SQUARE FOOT
SQ IN	SQUARE INCH
SST	STAINLESS STEEL
STL	STEEL
TBM	TEMPORARY BENCH MARK
TYP	TYPICAL
UE	UNDERGROUND ELECTRIC
UON	UNLESS OTHERWISE NOTED

PIPING SYSTEM DESIGNATIONS

BP	BYPASS
DR	DRAIN
ELEC, E	ELECTRICAL
SD	STORM DRAIN
SS	SANITARY SEWER
WTR, W	POTABLE WATER

DRAWING LEGEND

G	GENERAL
C	CIVIL

SECTION/DETAIL SYMBOLS

SECTION SCALE: 1/2"=1'-0"		SECTION LETTER SHEET WHERE SECTION IS REFERENCED
DETAIL SCALE: 1/2"=1'-0"		DETAIL NUMBER SHEET WHERE DETAIL IS REFERENCED
		SECTION LETTER SHEET WHERE SECTION IS DRAWN

PIPING DESIGNATIONS

The diagram illustrates piping designations. It shows two rows of pipe symbols: 'PROPOSED PIPE' and 'EXISTING PIPE'. For 'PROPOSED PIPE', the symbols are '10" W' (with 'NOMINAL DIAMETER' pointing to '10"' and 'SERVICE' pointing to 'W') and '10" SS' (with 'NOMINAL DIAMETER' pointing to '10"' and 'SERVICE' pointing to 'SS'). For 'EXISTING PIPE', the symbols are '36" W' and '36" SS'. Below these, a detailed example shows a horizontal pipe with a vertical branch labeled '12" BD'. The main pipe is labeled '12"'. The branch is labeled '12" BD'. The flow stream identification legend is '(D)'. The additional description is 'ADDITIONAL DESCRIPTION (IF REQUIRED)'.

PROPOSED PIPE

EXISTING PIPE

NOMINAL DIAMETER

SERVICE

10" W

10" SS

36" W

36" SS

12" BD

12"

BD

(D)

ADDITIONAL DESCRIPTION (IF REQUIRED)

FLOW STREAM IDENTIFICATION LEGEND

NOMINAL PIPE SIZE


<u>MATERIAL DESIGNATIONS</u>	
	AGGREGATE BASE (A.B.)
	AGGREGATE BASE WALK
	ASPHALTIC CONCRETE (A.C.)
	CHECKERED PLATE
	CONCRETE
	CONCRETE MASONRY WALL
	EARTH
	EARTHWORK/GRADING
	NATIVE ROCK
	GRATING
	PLASTIC, RUBBER OR NEOPRENE
	SAND
	STUCCO

```

USERNAME =>caguair
DWG FILE => COA-WMRP-G0.20.dwg

```

 
RELATIVE BORDER SCALE
IS IN INCHES



BID SET		LIST OF DRAWINGS, SYMBOLS AND ABBREVIATIONS	
UNIT 0000	PROJECT NUMBER & PHASE		00000000001


[illegible]

CITY OF ANGELS – DEPARTMENT OF PUBLIC WORKS	CONSULTANT PROJECT MANAGER	CALCULATED – DESIGNED BY	C. AGUIAR	REVISED BY	C. AGUIAR	
WATER METER REPLACEMENT PROJECT	D. RICHARD	CHECKED BY	D. RICHARD	DATE REVISED	11/17/25	

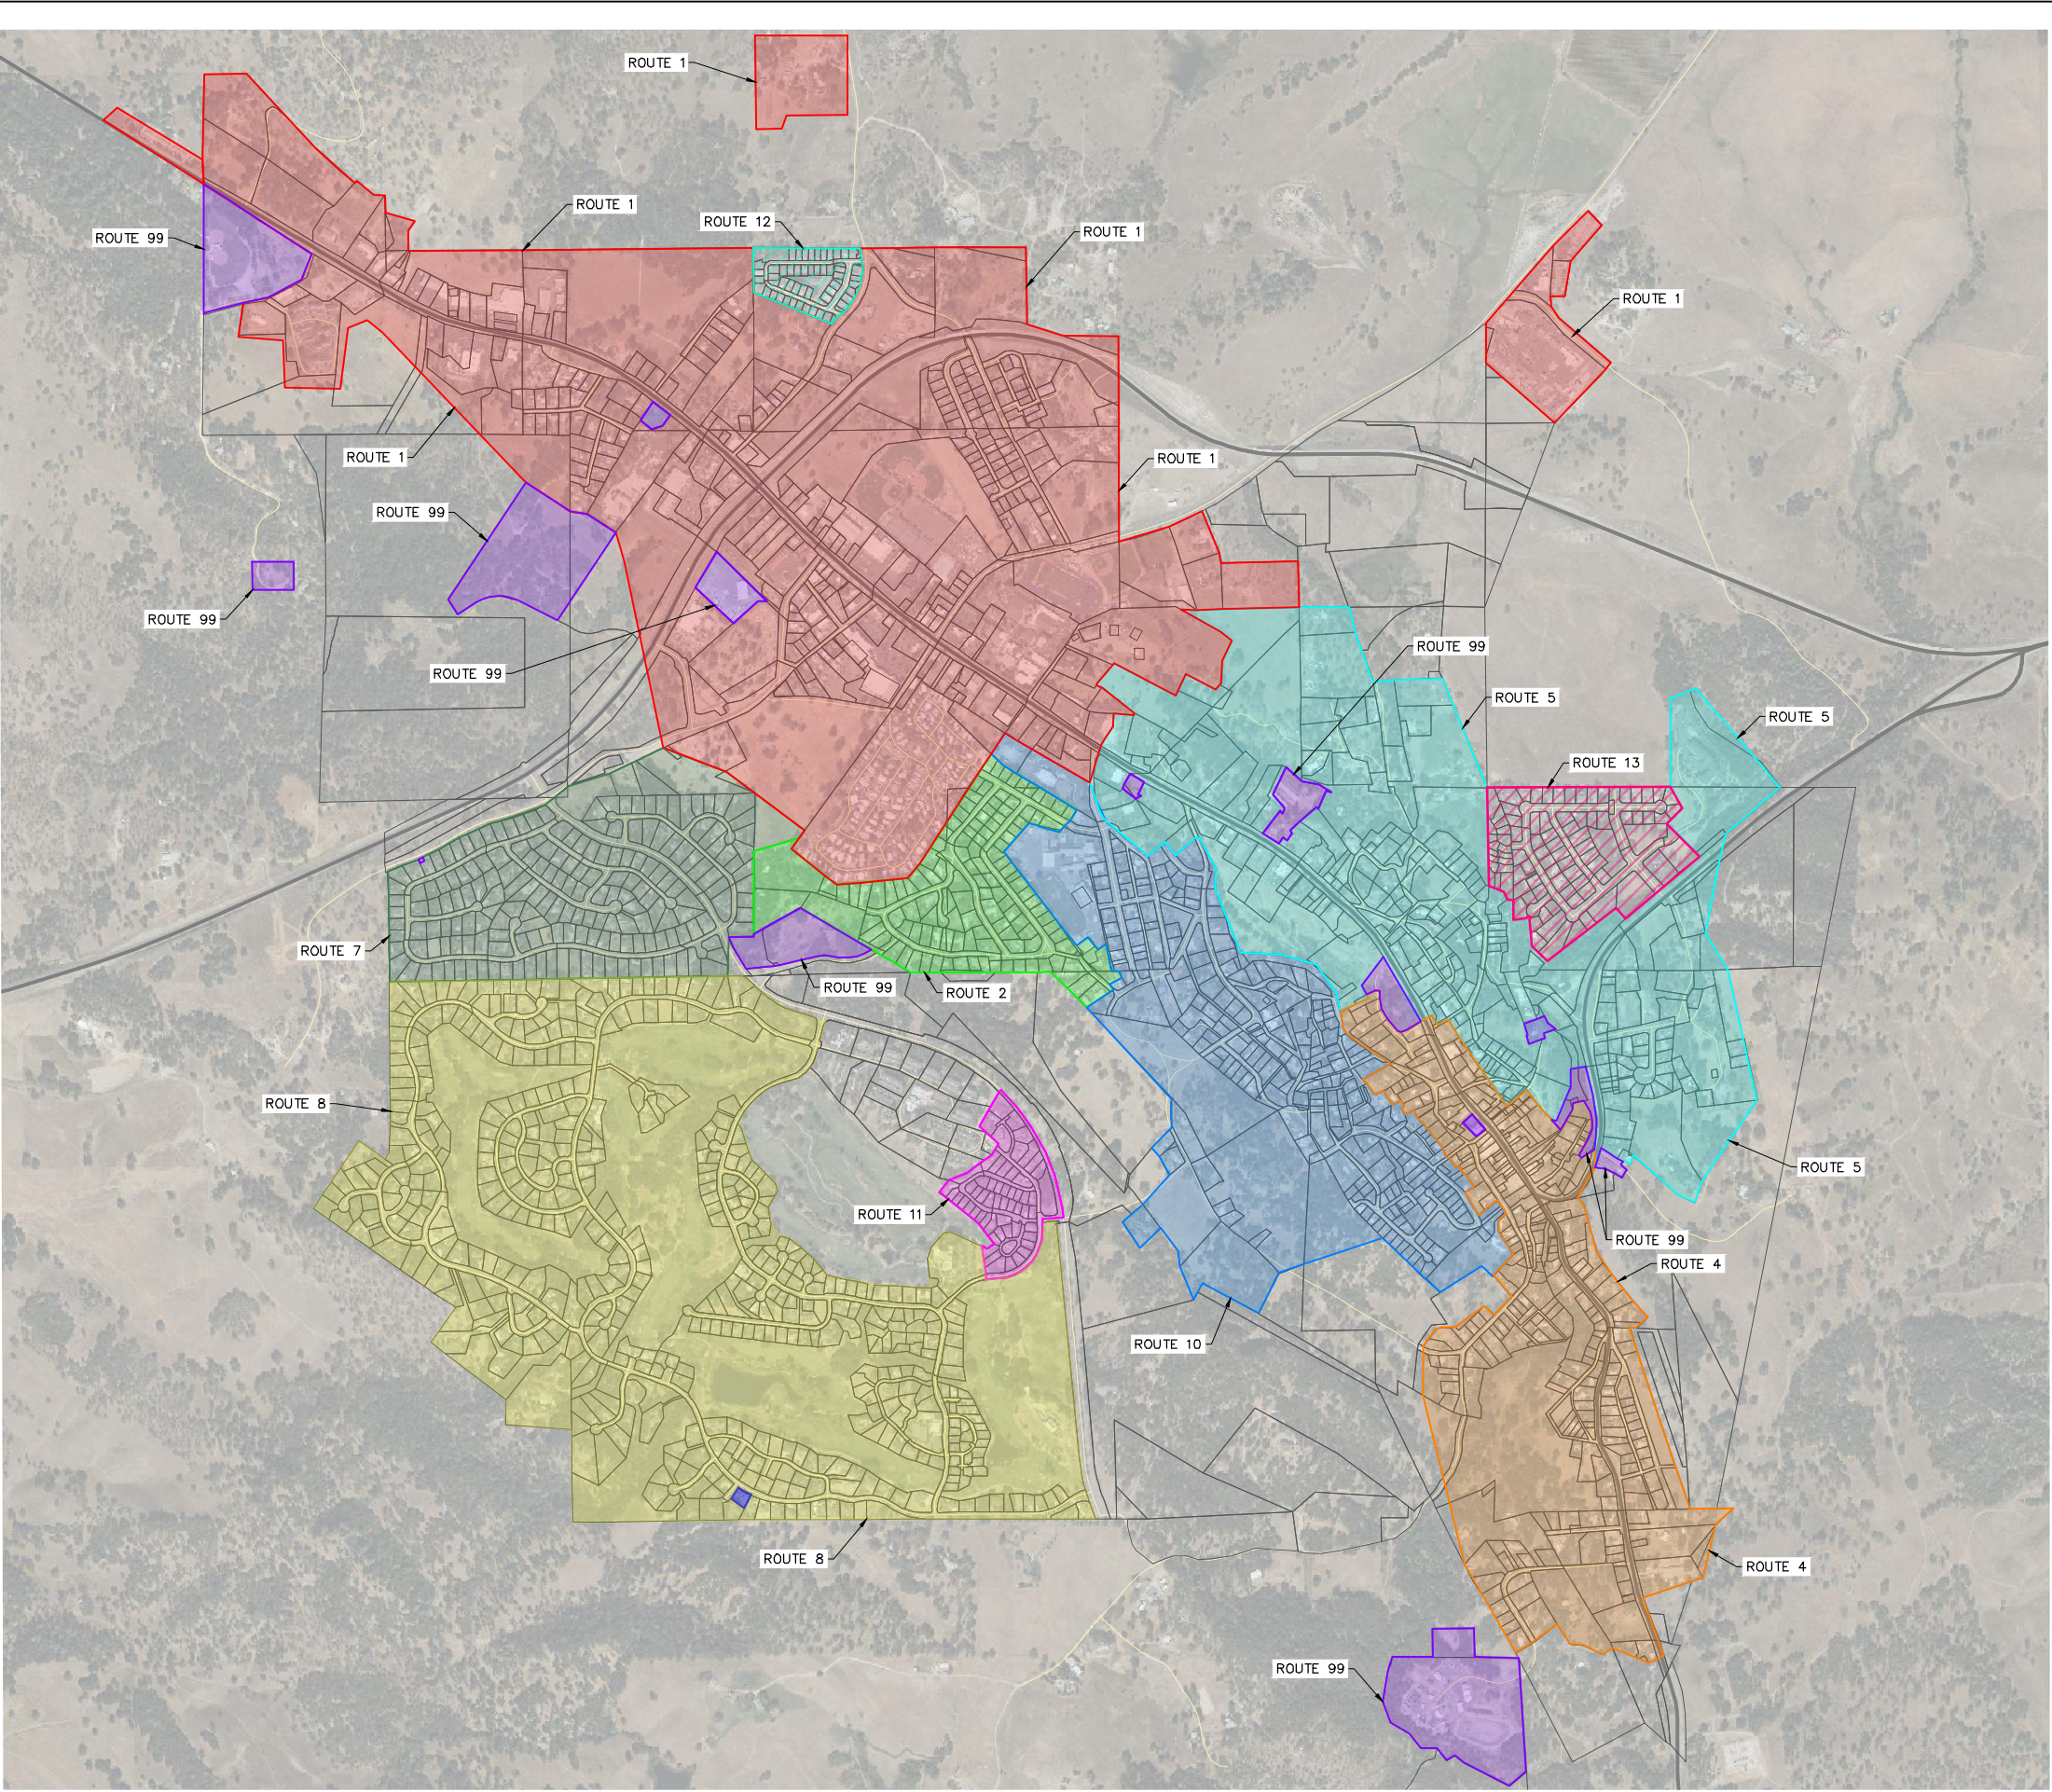



SHEET No.	TOTAL SHEETS
5	21

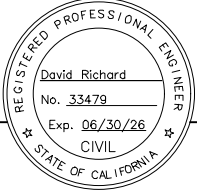


CITY OF ANGELS
DEPARTMENT OF PUBLIC WORKS
2990 CENTENNIAL ROAD
ANGELS CAMP, CA 95222

DEWBERRY
903 W CENTER STREET
MANTECA, CA 95337

- LEGEND**
- ROUTE 1 – 304 METERS
 - ROUTE 2 – 141 METERS
 - ROUTE 3 – 189 METERS
 - ROUTE 4 – 231 METERS
 - ROUTE 5 – 176 METERS
 - ROUTE 7 – 166 METERS
 - ROUTE 8 – 400 METERS
 - ROUTE 9 – CONSTRUCTION METERS ONLY (NO METER REPLACEMENT)
 - ROUTE 10 – 1 METER
 - ROUTE 11 – 55 METERS
 - ROUTE 12 – 54 METERS
 - ROUTE 13 – 78 METERS
 - ROUTE 99 – 23 METERS
 - TOTAL – 1,822 METERS
- CONSTRUCTION SEQUENCING / METER REPLACEMENT**
- PHASE 1: ROUTES 1, 7, 8, 9, 10, 11, 12, 13, AND 99
- STAGE 1: ROUTES 7 AND 8
- STAGE 2: ROUTES 1, 9, 10, 11, 12, 13, AND 99
- PHASE 2: ROUTES 1, 2, 3, 4, AND 5
- STAGE 1: ROUTES 1, 2, AND 3
- STAGE 2: ROUTES 4 AND 5
- NOTES:**
- SEQUENCE OF METER REPLACEMENT WITHIN EACH STAGE IS DETAILED ON SHEET C1.00 – C1.14

CITY OF ANGELS - DEPARTMENT OF PUBLIC WORKS	CONSULTANT PROJECT MANAGER	C. AGUIAR	REVISD BY	C. AGUIAR	
WATER METER REPLACEMENT PROJECT	D. RICHARD	D. RICHARD	DATE REVISED	11/17/25	

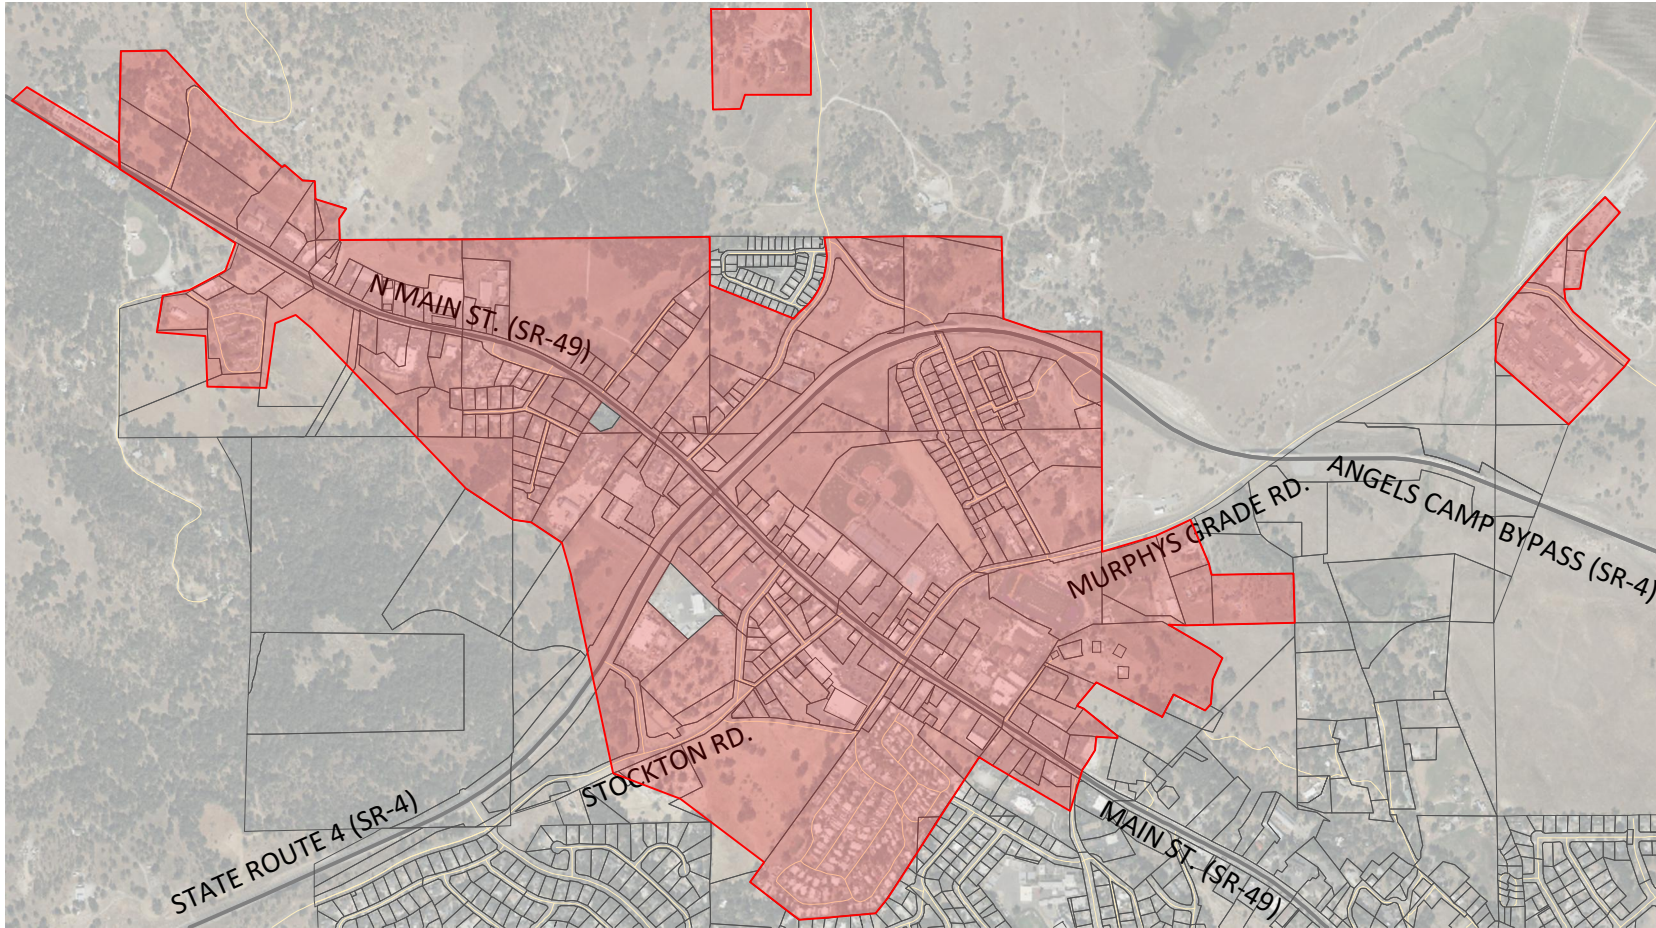

LEGEND

 ROUTE 1 – 304 METERS


LEVEL 1 REPLACEMENT – 212


LEVEL 2 REPLACEMENT – 45

LEVEL 3 REPLACEMENT – 47

STREET ADDRESS	LEVEL	PHASE	STAGE
9 AVERY RIDGE TRL	1	P-1	S-2
13 AVERY RIDGE TRL	1	P-1	S-2
23 N MAIN ST - downstairs	1	P-1	S-2
23 N MAIN ST - Landscape	1	P-1	S-2
23 N MAIN ST - upstairs	1	P-1	S-2
27 N MAIN ST - Round Table	1	P-1	S-2
27 N MAIN ST - Starbucks	1	P-1	S-2
33 N MAIN ST	1	P-1	S-2
33 N MAIN ST-Intlg/landscape	1	P-1	S-2
38 S MAIN ST	1	P-1	S-2
36 N MAIN ST	1	P-1	S-2
41 N MAIN ST	1	P-1	S-2
45 S MAIN ST	1	P-2	S-1
51 N MAIN ST-landscape	1	P-1	S-2
51 N MAIN ST-water 6 shops	1	P-1	S-2
52 S MAIN ST	1	P-1	S-2
60 N MAIN ST	3	P-1	S-2
65 S MAIN ST - Store	1	P-2	S-1
68 N MAIN ST	3	P-1	S-2
73 DOGTOWN RD	3	P-1	S-2
79 S MAIN ST	1	P-2	S-1
80 S MAIN ST	1	P-1	S-2
82 N MAIN ST	3	P-1	S-2
85 DOGTOWN RD	3	P-1	S-2
87 S MAIN ST	1	P-2	S-1
96 N MAIN ST	3	P-1	S-2
98 N MAIN ST	3	P-1	S-2
98 S MAIN ST	1	P-1	S-2
99 DOGTOWN RD	3	P-1	S-2
99 N MAIN ST - water/sewer	3	P-1	S-2
100 S FOUNDRY LANE	1	P-1	S-2
103 S MAIN ST - 1 wtr 1 sewer	1	P-2	S-1
115 S MAIN ST - storage yard/bldg	1	P-2	S-1
116 N MAIN ST	2	P-1	S-2
117 A DOGTOWN RD - DOROTHY CASHERO	3	P-1	S-2
117 B DOGTOWN RD - DOROTHY/DOTTIE CASHERO	3	P-1	S-2
117 B DOGTOWN RD	3	P-1	S-2
222 S MAIN ST - LAUREN HOBSTETTER	1	P-1	S-2
122 S MAIN ST	1	P-1	S-2
125 N MAIN ST	1	P-1	S-2
129 DOGTOWN RD	2	P-1	S-2
130 S MAIN ST	1	P-1	S-2
139 DOGTOWN RD - CARRISSA GOMEZ	3	P-1	S-2
140 N MAIN ST	2	P-1	S-2
143 MONTE VERDA ST	1	P-1	S-2
151 DOGTOWN RD - ISMAEL MEDRANO	3	P-1	S-2
148 S MAIN ST	1	P-1	S-2
155 S MAIN ST - 1 wtr 1 swrs	1	P-2	S-1
158 N MAIN ST	3	P-1	S-2
163 MONTE VERDA ST	1	P-1	S-2
167 DOGTOWN RD #2 - SANDRA HORAT	2	P-1	S-2
167 DOGTOWN RD #1 - SANDRA HORAT	3	P-1	S-2
169 N MAIN ST	2	P-1	S-2
172 S MAIN ST- Main House	1	P-1	S-2
173 PERI ST	1	P-1	S-2
177 MONTE VERDA ST	1	P-1	S-2
178 N MAIN ST	3	P-1	S-2
183 N MAIN ST	2	P-1	S-2
183 PERI ST	1	P-1	S-2
185 S MAIN ST	1	P-2	S-1
190 DOGTOWN RD - GRACE ESTATES	3	P-1	S-2
192 MONTE VERDA ST	1	P-1	S-2
194 N MAIN ST	3	P-1	S-2
195 CLIFTON LN	3	P-1	S-2
196 N MAIN ST	3	P-1	S-2
197 MONTE VERDA ST	1	P-1	S-2
200 DOGTOWN RD	3	P-1	S-2
200 DOGTOWN RD - big house	3	P-1	S-2
200 S MAIN ST	1	P-1	S-2
206 N MAIN ST # C	1	P-1	S-2
206 N MAIN ST # A	1	P-1	S-2
206 N MAIN ST # B	1	P-1	S-2
207 DOGTOWN RD	2	P-1	S-2
209 DOGTOWN RD	2	P-1	S-2
210 S MAIN ST	1	P-1	S-2
214 S MAIN ST	1	P-1	S-2
215 MONTE VERDA ST- #2 water	1	P-1	S-2
215 MONTE VERDA ST- #3 water	1	P-1	S-2
215 MONTE VERDA ST- #4 water	1	P-1	S-2
217 N MAIN ST	1	P-1	S-2
218 PERI ST	1	P-1	S-2
218 S MAIN ST	1	P-1	S-2
220 DOGTOWN RD	3	P-1	S-2
220 S MAIN ST	1	P-1	S-2
221 MONTE VERDA ST	1	P-1	S-2
229 S MAIN ST	1	P-2	S-1

STREET ADDRESS	LEVEL	PHASE	STAGE
230 S MAIN ST	1	P-2	S-1
231 MONTE VERDA ST	1	P-1	S-2
232 CLIFTON LN	3	P-1	S-2
240 S MAIN ST	1	P-2	S-1
241 MONTE VERDA ST	1	P-1	S-2
244 S MAIN ST	1	P-2	S-1
246 S MAIN ST	1	P-2	S-1
250 CLIFTON LN	2	P-1	S-2
250 STOCKTON RD-water/sewer 182 A & B also	1	P-1	S-2
252 N MAIN ST	1	P-1	S-2
253 N BAKER ST - 2 waters	2	P-1	S-2
253 S MAIN ST	1	P-2	S-1
260 S MAIN ST	1	P-2	S-1
260 STOCKTON RD - Protestant	1	P-1	S-2
262 CLIFTON LN	2	P-1	S-2
262 DOGTOWN RD - water only *	1	P-1	S-2
263 S MAIN ST	1	P-2	S-1
265 BENNETT ST	2	P-1	S-2
268 FRANCIS ST	2	P-1	S-2
273 N BAKER ST	2	P-1	S-2
273 S MAIN ST	1	P-2	S-1
273 WILSON ST	2	P-1	S-2
280 CLIFTON LN	3	P-1	S-2
281 STOCKTON RD	1	P-1	S-2
284 FRANCIS ST	2	P-1	S-2
289 STOCKTON RD	1	P-1	S-2
290 S MAIN ST	1	P-2	S-1
292 CLIFTON LN	2	P-1	S-2
293 BENNETT ST	2	P-1	S-2
294 S MAIN ST	1	P-2	S-1
295 WILSON ST	2	P-1	S-2
297 STOCKTON RD	1	P-1	S-2
299 STOCKTON RD	1	P-1	S-2
300 N MAIN ST - front building	3	P-1	S-2
300 S MAIN ST - downstairs	1	P-2	S-1
300 S MAIN ST - upstairs	1	P-2	S-1
301 DEMAREST ST	1	P-2	S-1
301 S MAIN ST	3	P-2	S-1
302 WILSON ST	3	P-1	S-2
303 N BAKER ST #1	2	P-1	S-2
303 N BAKER ST #2	2	P-1	S-2
304 CLIFTON LN	3	P-1	S-2
308 STOCKTON RD	1	P-1	S-2
311 BENNETT ST	2	P-1	S-2
311 MURPHYS GRD RD	1	P-2	S-1
312 BENNETT ST	2	P-1	S-2
313 WILSON ST	2	P-1	S-2
314 S MAIN ST	1	P-2	S-1
314 S MAIN ST - wtr meter	1	P-2	S-1
316 WILSON ST	3	P-1	S-2
320 N MAIN ST - 320 & 300 back	3	P-1	S-2
321 STOCKTON RD	1	P-1	S-2
323 MURPHYS GRD RD	1	P-2	S-1
323 S MAIN ST	3	P-2	S-1
324 S MAIN ST	1	P-2	S-1
326 S MAIN ST	1	P-2	S-1
327 BENNETT ST	1	P-1	S-2
328 BENNETT ST	2	P-1	S-2
329 N MAIN ST	3	P-1	S-2
329 STOCKTON RD	1	P-1	S-2
330 MURPHYS GRD RD	1	P-2	S-1
332 WILSON ST	1	P-1	S-2
333 MURPHYS GRD RD	1	P-2	S-1
333 STOCKTON RD	1	P-1	S-2
335 WILSON ST	2	P-1	S-2
340 BENNETT ST	3	P-1	S-2
343 BENNETT ST	2	P-1	S-2
343 MURPHYS GRD RD	1	P-2	S-1
343 WILSON ST	2	P-1	S-2

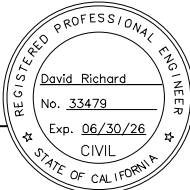 Dewberry®	SHEET No. 7	TOTAL SHEETS 21
		
CITY OF ANGELS DEPARTMENT OF PUBLIC WORKS 2990 CENTENNIAL ROAD ANGELS CAMP, CA 95222	DEWBERRY 903 W CENTER STREET MANTECA, CA 95337	

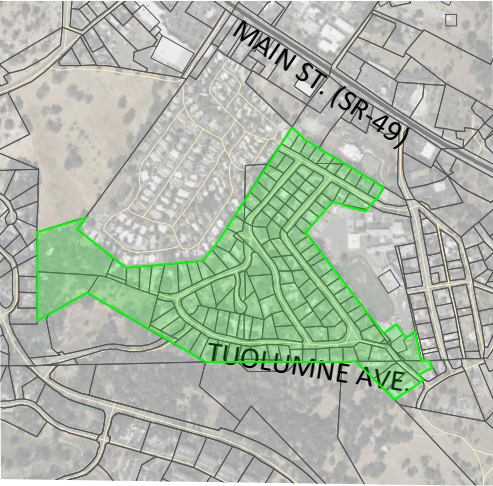

LEGEND

ROUTE 2 – 141 METERS

LEVEL 1 REPLACEMENT – 5
LEVEL 2 REPLACEMENT – 10
LEVEL 3 REPLACEMENT – 126

STREET ADDRESS	LEVEL	PHASE	STAGE
463 SAN JOAQUIN	3	P-2	S-1
464 SAN JOAQUIN	3	P-2	S-1
473 SAN JOAQUIN	3	P-2	S-1
489 SAN JOAQUIN	2	P-2	S-1
497 SAN JOAQUIN	3	P-2	S-1
498 SAN JOAQUIN	3	P-2	S-1
502 AMADOR AVE	3	P-2	S-1
503 AMADOR AVE	3	P-2	S-1
513 SAN JOAQUIN	3	P-2	S-1
516 AMADOR AVE	3	P-2	S-1
517 AMADOR AVE	3	P-2	S-1
521 SAN JOAQUIN	3	P-2	S-1
529 AMADOR AVE	3	P-2	S-1
530 AMADOR AVE	3	P-2	S-1
531 SAN JOAQUIN	3	P-2	S-1
537 ALPINE AVE	3	P-2	S-1
538 ALPINE AVE	3	P-2	S-1
539 AMADOR AVE	3	P-2	S-1
540 AMADOR AVE	3	P-2	S-1
547 SAN JOAQUIN AVE	3	P-2	S-1
548 SAN JOAQUIN	3	P-2	S-1
549 AMADOR AVE	3	P-2	S-1
551 ALPINE AVE	3	P-2	S-1
552 ALPINE AVE	3	P-2	S-1
558 AMADOR AVE	3	P-2	S-1
559 ALPINE AVE	3	P-2	S-1
560 ALPINE AVE	3	P-2	S-1
563 SAN JOAQUIN	3	P-2	S-1
564 SAN JOAQUIN	1	P-2	S-1
569 AMADOR AVE	3	P-2	S-1
570 AMADOR AVE	3	P-2	S-1
571 STANISLAUS AVE - 8 water/sewer	3	P-2	S-1
572 ALPINE AVE	3	P-2	S-1
573 ALPINE AVE	3	P-2	S-1
577 SAN JOAQUIN	3	P-2	S-1
580 AVEY PL	3	P-2	S-1
582 AVEY PL	3	P-2	S-1
583 ALPINE AVE	3	P-2	S-1
584 ALPINE AVE	3	P-2	S-1
584 AVEY PL	3	P-2	S-1
597 AMADOR AVE	1	P-2	S-1
600 ALPINE AVE	3	P-2	S-1
608 TUOLUMNE AVE	3	P-2	S-1
612 STANISLAUS AVE #1	3	P-2	S-1
612 STANISLAUS AVE #2	3	P-2	S-1
612 STANISLAUS AVE #3	3	P-2	S-1
612 STANISLAUS AVE #4	3	P-2	S-1
612 STANISLAUS AVE #5	3	P-2	S-1
612 STANISLAUS AVE #6	3	P-2	S-1
613 ALPINE AVE	3	P-2	S-1
615A TUOLUMNE AVE	3	P-2	S-1
615B TUOLUMNE AVE	3	P-2	S-1
624 ALPINE AVE	3	P-2	S-1
631 ALPINE AVE	3	P-2	S-1

STREET ADDRESS	LEVEL	PHASE	STAGE
637 AMADOR AVE	3	P-2	S-1
639 PLACER ST	3	P-2	S-1
640 A PLACER ST	1	P-2	S-1
640 ALPINE AVE	3	P-2	S-1
640 B PLACER ST	1	P-2	S-1
640 TUOLUMNE AVE	3	P-2	S-1
641 ALPINE AVE	1	P-2	S-1
641 PLACER ST	3	P-2	S-1
643 PLACER ST	3	P-2	S-1
644 PLACER ST	3	P-2	S-1
645 PLACER ST	3	P-2	S-1
646 PLACER ST	3	P-2	S-1
647 AMADOR AVE	3	P-2	S-1
649 PLACER ST	3	P-2	S-1
652 AMADOR AVE	3	P-2	S-1
654 ALPINE AVE	3	P-2	S-1
655 HILLSIDE CT	2	P-2	S-1
655 TUOLUMNE AVE	3	P-2	S-1
656 TUOLUMNE AVE	3	P-2	S-1
657 HILLSIDE CT	2	P-2	S-1
657 TUOLUMNE AVE	3	P-2	S-1
660 AMADOR AVE	3	P-2	S-1
664 TUOLUMNE AVE	3	P-2	S-1
665 ALPINE AVE	3	P-2	S-1
670 ALPINE AVE	3	P-2	S-1
675 ALPINE AVE	3	P-2	S-1
675 HILLSIDE CT	2	P-2	S-1
676 AMADOR AVE - 1 sewer 2 waters	3	P-2	S-1
676 HILLSIDE CT	2	P-2	S-1
677 AMADOR AVE	3	P-2	S-1
679 HILLSIDE CT	2	P-2	S-1
680 TUOLUMNE AVE	3	P-2	S-1
684 ALPINE AVE	3	P-2	S-1
685 TUOLUMNE AVE	3	P-2	S-1
690 AMADOR AVE	3	P-2	S-1
692 TUOLUMNE AVE	3	P-2	S-1
693 ALPINE AVE	3	P-2	S-1
700 PLACER ST	3	P-2	S-1
702 ALPINE AVE	3	P-2	S-1
705 ALPINE AVE	3	P-2	S-1
715 ALPINE AVE	3	P-2	S-1
716 ALPINE AVE	3	P-2	S-1
725 AMADOR AVE	3	P-2	S-1
729 ALPINE AVE	3	P-2	S-1
734 TUOLUMNE AVE	3	P-2	S-1
736 TUOLUMNE AVE	3	P-2	S-1
737 TUOLUMNE AVE	2	P-2	S-1
738 TUOLUMNE AVE - Water Service	3	P-2	S-1
740 TUOLUMNE AVE - Water Service	3	P-2	S-1
741 ALPINE AVE	3	P-2	S-1
753 TUOLUMNE AVE	3	P-2	S-1
759 PLACER ST	3	P-2	S-1
760 TUOLUMNE AVE	3	P-2	S-1
770 TUOLUMNE AVE	3	P-2	S-1

STREET ADDRESS	LEVEL	PHASE	STAGE
771 TUOLUMNE AVE	3	P-2	S-1
785 TUOLUMNE AVE	3	P-2	S-1
788 TUOLUMNE AVE	3	P-2	S-1
794 TUOLUMNE AVE	3	P-2	S-1
803 TUOLUMNE AVE	3	P-2	S-1
806 TUOLUMNE AVE	3	P-2	S-1
813 TUOLUMNE AVE	3	P-2	S-1
816 TUOLUMNE AVE	3	P-2	S-1
831 TUOLUMNE AVE	3	P-2	S-1
832 TUOLUMNE AVE	3	P-2	S-1
856 TUOLUMNE AVE	3	P-2	S-1
862 TUOLUMNE AVE	3	P-2	S-1
863 TUOLUMNE AVE	3	P-2	S-1
871 TUOLUMNE AVE	3	P-2	S-1
873 TUOLUMNE AVE	3	P-2	S-1
876 TUOLUMNE AVE	3	P-2	S-1
892 TUOLUMNE AVE	3	P-2	S-1
906 TUOLUMNE AVE	3	P-2	S-1
918 TUOLUMNE AVE	3	P-2	S-1
925 TUOLUMNE AVE	3	P-2	S-1
936 TUOLUMNE AVE	3	P-2	S-1
954 TUOLUMNE AVE	3	P-2	S-1
961 TUOLUMNE AVE	2	P-2	S-1
968 TUOLUMNE AVE	3	P-2	S-1
971 TUOLUMNE AVE	2	P-2	S-1
978 TUOLUMNE AVE	3	P-2	S-1
1006 TUOLUMNE AVE	3	P-2	S-1
1015 TUOLUMNE AVE	3	P-2	S-1
1026 TUOLUMNE AVE	2	P-2	S-1
1026 TUOLUMNE AVE - 1 meter	3	P-2	S-1
LOW END TR PK - wtr meter	3	P-2	S-1
W/END SAN JOAQUIN - wtr mtr #1	3	P-2	S-1
W/END SAN JOAQUIN - wtr mtr #2	3	P-2	S-1



SHEET No.

9

TOTAL SHEETS

21

REGISTERED PROFESSIONAL ENGINEER

David Richard

No. 33479

Exp. 06/30/26


CIVIL

STATE OF CALIFORNIA

CITY OF ANGELS
DEPARTMENT OF PUBLIC WORKS
2990 CENTENNIAL ROAD
ANGELS CAMP, CA 95222

DEWBERRY
903 W CENTER STREET
MANTECA, CA 95337

CITY OF ANGELS – DEPARTMENT OF PUBLIC WORKS	CONSULTANT PROJECT MANAGER	CALCULATED – DESIGNED BY	C. AGUIAR	REVISED BY	C. AGUIAR	DATE	11/17/25
WATER METER REPLACEMENT PROJECT	D. RICHARD	CHECKED BY	D. RICHARD	DATE REVISED			

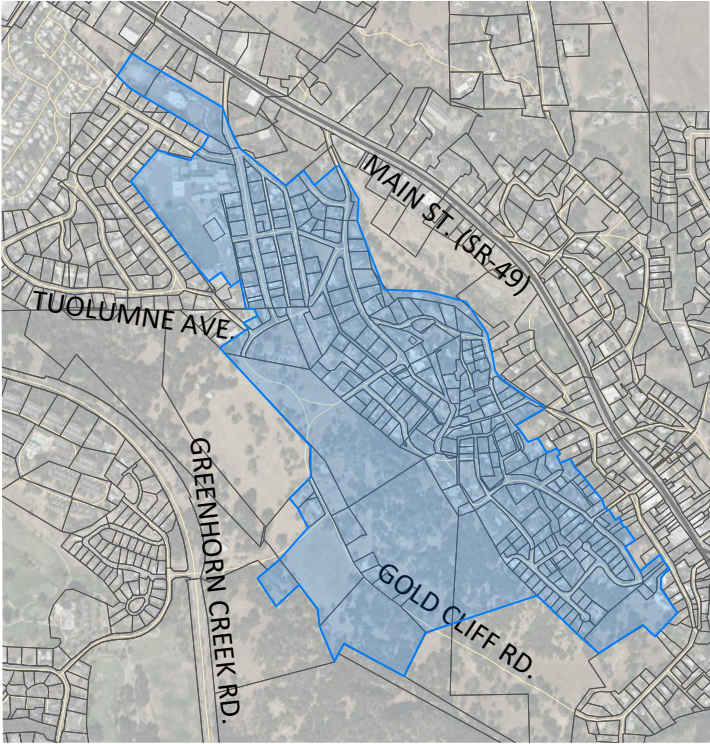

LEGEND

ROUTE 3 – 189 METERS

LEVEL 1 REPLACEMENT – 79

LEVEL 2 REPLACEMENT – 33

LEVEL 3 REPLACEMENT – 77

STREET ADDRESS	LEVEL	PHASE	STAGE
1000 GOLD CLIFF RD	3	P-2	S-1
1001 HIGHLAND ALLEY	1	P-2	S-1
1001 HILLCREST ST	3	P-2	S-1
1002 HILLCREST ST	3	P-2	S-1
1002 MARK TWAIN RD	3	P-2	S-1
1002 WEST ST	2	P-2	S-1
1013 CRYSTAL ST	3	P-2	S-1
1013 MARK TWAIN RD	1	P-2	S-1
1014 BUSH ST	1	P-2	S-1
1015 WEST ST	1	P-2	S-1
1016 MARK TWAIN RD	1	P-2	S-1
1022 BUSH ST	1	P-2	S-1
1025 MARK TWAIN RD	1	P-2	S-1
1026 MARK TWAIN RD	2	P-2	S-1
1032 BUSH ST	1	P-2	S-1
1033 WEST ST	1	P-2	S-1
1034 MARK TWAIN RD	1	P-2	S-1
1037 MARK TWAIN RD	1	P-2	S-1
1038 BUSH ST	1	P-2	S-1
1040 HIGHLAND ALLEY	3	P-2	S-1
1041 MARK TWAIN RD	3	P-2	S-1
1050 ECHO ST	1	P-2	S-1
1053 MARK TWAIN RD	1	P-2	S-1
1054 MARK TWAIN RD	1	P-2	S-1
1070 ECHO ST	3	P-2	S-1
1071 MARK TWAIN RD - 3	1	P-2	S-1
1075 MARK TWAIN RD	1	P-2	S-1
1080 ECHO ST	2	P-2	S-1
1085 BUSH ST	1	P-2	S-1
1088 BUSH ST	2	P-2	S-1
1088 ECHO ST	1	P-2	S-1
1090 BUSH ST	1	P-2	S-1
1090 UTICA LN	3	P-2	S-1
1094 BUSH ST	3	P-2	S-1
1100 ECHO ST	3	P-2	S-1
1101 ECHO ST	3	P-2	S-1
1116 MARK TWAIN RD	1	P-2	S-1
1118 ECHO ST	2	P-2	S-1
1123 MARK TWAIN RD	1	P-2	S-1
1131 GOLD CLIFF RD	3	P-2	S-1
1143 ECHO ST	3	P-2	S-1
1143 MARK TWAIN RD	3	P-2	S-1
1151 MARK TWAIN RD	3	P-2	S-1
1156 ECHO ST	1	P-2	S-1
1157 MINNA ST	2	P-2	S-1
1159 MARK TWAIN RD	2	P-2	S-1
1161 ECHO ST	3	P-2	S-1
1166 GOLD CLIFF RD	3	P-2	S-1
1170 ECHO ST	1	P-2	S-1
1171 MINNA ST	2	P-2	S-1
1180 GOLD CLIFF RD	3	P-2	S-1
1182 MARK TWAIN RD-water/sewer	1	P-2	S-1
1185 MINNA ST	2	P-2	S-1
1191 MARK TWAIN RD	3	P-2	S-1
1209 MARK TWAIN RD	3	P-2	S-1
1212 MARK TWAIN RD	1	P-2	S-1
1212 MINNA ST	2	P-2	S-1
1215 GOLD CLIFF RD	3	P-2	S-1
1215 MARK TWAIN RD	1	P-2	S-1
1220 FAIRVIEW DR - Apts.	3	P-2	S-1
1221 FAIRVIEW DR	3	P-2	S-1
1233 LOVE ST	3	P-2	S-1
1243 OAK CT	2	P-2	S-1
1244 FAIRVIEW DR	1	P-2	S-1
1245 LOVE ST	3	P-2	S-1
1251 GOLD CLIFF RD	2	P-2	S-1
1253 FAIRVIEW DR	1	P-2	S-1
1253 OAK CT	3	P-2	S-1
1254 FAIRVIEW DR	1	P-2	S-1
1257 HARDSCRABBLE	1	P-2	S-1
1260 GOLD CLIFF RD	2	P-2	S-1
1264 FAIRVIEW DR	3	P-2	S-1
1267 HARDSCRABBLE	1	P-2	S-1
1269 GOLD CLIFF RD	1	P-2	S-1
1270 OAK CT	1	P-2	S-1
1273 MARK TWAIN RD	3	P-2	S-1
1274 MARK TWAIN RD	2	P-2	S-1
1275 GOLD CLIFF RD	2	P-2	S-1
1275 MARK TWAIN RD	3	P-2	S-1
1280 FAIRVIEW DR	2	P-2	S-1
1281 LOVE ST	3	P-2	S-1

STREET ADDRESS	LEVEL	PHASE	STAGE
1282 MINNA ST	2	P-2	S-1
1290 FAIRVIEW DR	1	P-2	S-1
1296 OAK PL - water/sewer	3	P-2	S-1
1300 FAIRVIEW DR	3	P-2	S-1
1303 OAK PL	3	P-2	S-1
1304 OAK PL	1	P-2	S-1
1305 MARK TWAIN RD	3	P-2	S-1
1308 MARK TWAIN RD	3	P-2	S-1
1310 FAIRVIEW DR	1	P-2	S-1
1315 FAIRVIEW DR	1	P-2	S-1
1315 LOVE ST-DUPLEX	3	P-2	S-1
1315 OAK PL	3	P-2	S-1
1318 MARK TWAIN RD	3	P-2	S-1
1320 FAIRVIEW DR	1	P-2	S-1
1320 FAIRVIEW DR - Horse trough	1	P-2	S-1
1321 OAK PL	1	P-2	S-1
1325 FAIRVIEW DR	1	P-2	S-1
1325 LOVE ST	1	P-2	S-1
1328 MARK TWAIN RD	3	P-2	S-1
1330 FAIRVIEW DR	3	P-2	S-1
1330 OAK PL	3	P-2	S-1
1335 LOVE ST	1	P-2	S-1
1336 FAIRVIEW DR	3	P-2	S-1
1340 MARK TWAIN RD	1	P-2	S-1
1342 OAK PL	1	P-2	S-1
1348 MARK TWAIN RD	3	P-2	S-1
1350 FAIRVIEW PL	1	P-2	S-1
1355 MARK TWAIN RD	3	P-2	S-1
1356 MARK TWAIN RD	3	P-2	S-1
1360 FAIRVIEW PL	1	P-2	S-1
1362 BUSH ST	3	P-2	S-1
1362 MARK TWAIN RD	3	P-2	S-1
1369 MARK TWAIN RD	3	P-2	S-1
1370 FAIRVIEW DR	1	P-2	S-1
1370 FAIRVIEW PL	2	P-2	S-1
1375 FAIRVIEW PL	3	P-2	S-1
1380 FAIRVIEW PL	1	P-2	S-1
1394 FAIRVIEW DR	3	P-2	S-1
1401 FAIRVIEW DR	3	P-2	S-1
1409 FAIRVIEW DR	3	P-2	S-1
1417 FAIRVIEW DR	3	P-2	S-1
1420 MARK TWAIN RD	3	P-2	S-1
575 STANISLAUS AVE - 3 water/sewer	1	P-2	S-1
575 STANISLAUS AVE - landscape meter	1	P-2	S-1
590 STANISLAUS AVE	1	P-2	S-1
590 STANISLAUS AVE - Irrigation	3	P-2	S-1
595 STANISLAUS AVE LOT A #1 - 3 water/sewer	1	P-2	S-1
637 STANISLAUS AVE	3	P-2	S-1
663 STANISLAUS AVE	3	P-2	S-1
668 STANISLAUS AVE - house torn down	3	P-2	S-1
682 ONEIDA ST	1	P-2	S-1
682 STANISLAUS AVE	2	P-2	S-1
685 STANISLAUS AVE	2	P-2	S-1
687 ONEIDA ST	1	P-2	S-1
695 STANISLAUS AVE	1	P-2	S-1
700 MARK TWAIN RD - apartments	3	P-2	S-1
701 ONEIDA ST	3	P-2	S-1
701 STANISLAUS AVE	2	P-2	S-1
706 MARK TWAIN RD	3	P-2	S-1
708 ONEIDA ST	2	P-2	S-1

SHEET No.10TOTAL SHEETS21

REGISTERED PROFESSIONAL ENGINEER

David Richard

No. 33479

Exp. 06/30/26

CIVIL

STATE OF CALIFORNIA

CITY OF ANGELS
DEPARTMENT OF PUBLIC WORKS
2990 CENTENNIAL ROAD
ANGELS CAMP, CA 95222


DEWBERRY
903 W CENTER STREET
MANTECA, CA 95337

BID SET		WATER METER REPLACEMENT SCHEDULE ROUTE 3	
UNIT 0000	PROJECT NUMBER & PHASE	00000000001	

USERNAME ==>caguiar
DWG FILE ==> COA-WMRP-C1.03-R3.dwg



CITY OF ANGELS – DEPARTMENT OF PUBLIC WORKS	CONSULTANT PROJECT MANAGER		C. AGUIAR	REVISD BY	C. AGUIAR	
	D. RICHARD					
WATER METER REPLACEMENT PROJECT	D. RICHARD		C. AGUIAR	DATE REVISED	11/17/25	

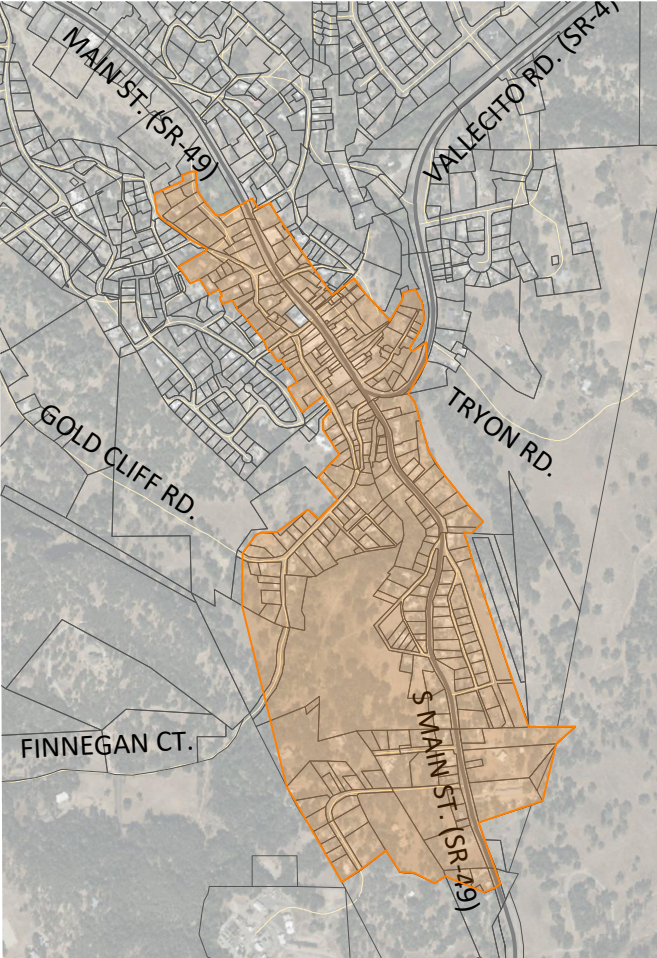

LEGEND

ROUTE 4 – 231 METERS

LEVEL 1 REPLACEMENT – 67
LEVEL 2 REPLACEMENT – 48
LEVEL 3 REPLACEMENT – 116

STREET ADDRESS	LEVEL	PHASE	STAGE
1049 S MAIN ST	2	P-2	S-2
1050 UTICA LN	2	P-2	S-2
1056 UTICA LN	2	P-2	S-2
1071 S MAIN ST	2	P-2	S-2
1082 S MAIN ST	3	P-2	S-2
1082 UTICA LN	2	P-2	S-2
1092 S MAIN ST	3	P-2	S-2
1115 S MAIN ST	1	P-2	S-2
1128 #1 BUSH ST	1	P-2	S-2
1128 #2 BUSH ST	1	P-2	S-2
1128 #3 BUSH ST	1	P-2	S-2
1128 #4 BUSH ST	1	P-2	S-2
1138 S MAIN ST	2	P-2	S-2
1141 S MAIN ST	1	P-2	S-2
1142 S MAIN ST	3	P-2	S-2
1152 S MAIN ST	3	P-2	S-2
1153 MINARD ST	1	P-2	S-2
1159 MINARD ST	3	P-2	S-2
1161 S MAIN ST	1	P-2	S-2
1162 S MAIN ST	2	P-2	S-2
1168 BUSH ST	3	P-2	S-2
1173 MINARD ST	3	P-2	S-2
1177 S MAIN ST & 1183	3	P-2	S-2
1179 MINARD ST	3	P-2	S-2
1180 BUSH ST	2	P-2	S-2
1186 BUSH ST	3	P-2	S-2
1194 BUSH ST	3	P-2	S-2
1195 S MAIN ST	1	P-2	S-2
1197 S MAIN ST - Apartment complex	1	P-2	S-2
1202 BRET HARTE RD	2	P-2	S-2
1208 S MAIN ST	3	P-2	S-2
1211 S MAIN ST	2	P-2	S-2
1216 BUSH ST	3	P-2	S-2
1216 S MAIN ST	1	P-2	S-2
1219 S MAIN ST	2	P-2	S-2
1221 S MAIN ST	3	P-2	S-2
1225 S MAIN ST	3	P-2	S-2
1227 S MAIN ST- Gold Rush Originals	3	P-2	S-2
1228 S MAIN ST	1	P-2	S-2
1234 S MAIN ST	1	P-2	S-2
1235 S MAIN ST	3	P-2	S-2
1239 S MAIN ST	3	P-2	S-2
1240 S MAIN ST	3	P-2	S-2
1241 BUSH ST	2	P-2	S-2
1243 S MAIN ST	1	P-2	S-2
1244 RASBERRY LN	1	P-2	S-2
1246 S MAIN ST - cafe	3	P-2	S-2
1249 S MAIN ST	1	P-2	S-2
1251 BUSH ST	2	P-2	S-2
1251 S MAIN ST- 3 APTS.	1	P-2	S-2
1252 S MAIN ST - Cascabel	1	P-2	S-2
1254 S MAIN ST	1	P-2	S-2
1259 S MAIN ST	1	P-2	S-2
1260 S MAIN ST	3	P-2	S-2
1262 S MAIN ST	1	P-2	S-2
1263/1265 S MAIN ST-	1	P-2	S-2
1264 BUSH ST	3	P-2	S-2
1267 S MAIN ST	3	P-2	S-2
1275 S MAIN ST - 1273 & 1275	3	P-2	S-2
1277 S MAIN ST	3	P-2	S-2
1279 S MAIN ST #2	3	P-2	S-2
1279 S MAIN ST #1	3	P-2	S-2
1279 S MAIN ST #3	3	P-2	S-2
1279 S MAIN ST- YARD FAUCET	3	P-2	S-2
1280 BUSH ST	3	P-2	S-2
1284 BUSH ST	3	P-2	S-2
1287 S MAIN ST	3	P-2	S-2
1290 BUSH ST	3	P-2	S-2
1298 BUSH ST	2	P-2	S-2

STREET ADDRESS	LEVEL	PHASE	STAGE
1301 S MAIN ST	3	P-2	S-2
1303 BUSH ST	3	P-2	S-2
1311 S MAIN ST	1	P-2	S-2
1312 BUSH ST	1	P-2	S-2
1316 BIRDS WY - water/sewer	1	P-2	S-2
1320 S MAIN ST	3	P-2	S-2
1322 FINNEGAN LN	3	P-2	S-2
1329 S MAIN ST	1	P-2	S-2
1332 BUSH ST	2	P-2	S-2
1335 S MAIN ST	1	P-2	S-2
1339 BIRDS WY - water/sewer	3	P-2	S-2
1339 BUSH ST - water for Hotel	3	P-2	S-2
1340 BIRDS WY - water/sewer	3	P-2	S-2
1340 BUSH ST- downstairs	1	P-2	S-2
1343 BIRDS WY - water/sewer	1	P-2	S-2
1345 FINNEGAN LN	1	P-2	S-2
1346 FINNEGAN LN	3	P-2	S-2
1347 BIRDS WY #2 - water service	1	P-2	S-2
1347 BIRDS WY #1 - water service	1	P-2	S-2
1347 BIRDS WY #3 - water service	2	P-2	S-2
1348 S MAIN ST	2	P-2	S-2
1349 S MAIN ST - side porch door unit #3	3	P-2	S-2
1352 FINNEGAN LN	3	P-2	S-2
1355 FINNEGAN LN	1	P-2	S-2
1361 BIRDS WY - water service	3	P-2	S-2
1361 S MAIN ST	3	P-2	S-2
1366 FINNEGAN LN	2	P-2	S-2
1367 BIRDS WY - water service	3	P-2	S-2
1371 BUSH ST	3	P-2	S-2
1372 BUSH ST	3	P-2	S-2
1375 BIRDS WY - water service	1	P-2	S-2
1375 FINNEGAN LN	3	P-2	S-2
1376 BIRDS WY - water/sewer	1	P-2	S-2
1377 BIRDS WY- water service	1	P-2	S-2
1377 S MAIN ST	2	P-2	S-2
1380 FINNEGAN LN	3	P-2	S-2
1384 S MAIN ST	3	P-2	S-2
1385 BIRDS WY- water service	2	P-2	S-2
1386 BIRDS WY - water/sewer	3	P-2	S-2
1387 BIRDS WY- water service	3	P-2	S-2
1388 BIRDS WY - water/sewer	3	P-2	S-2
1389 S MAIN ST	3	P-2	S-2
1392 BUSH ST	1	P-2	S-2
1393 BIRDS WY- 2 waters 1393 & 1395	3	P-2	S-2
1400 BUSH ST	2	P-2	S-2
1403 FINNEGAN LN	3	P-2	S-2
1403 S MAIN ST	2	P-2	S-2
1404 FINNEGAN LN	2	P-2	S-2
1408 S MAIN ST	1	P-2	S-2
1411 S MAIN ST	2	P-2	S-2
1413 FINNEGAN LN	1	P-2	S-2
1418 BUSH ST	3	P-2	S-2
1425 S MAIN ST	2	P-2	S-2
1429 FINNEGAN LN	3	P-2	S-2
1434 FINNEGAN LN	3	P-2	S-2
1439 FINNEGAN LN	2	P-2	S-2
1445 S MAIN ST	1	P-2	S-2
1447 FINNEGAN LN	3	P-2	S-2
1454 S MAIN ST	3	P-2	S-2
1463 MYRTLE ST	3	P-2	S-2
1463 S MAIN ST	2	P-2	S-2
1464 S MAIN ST-Downstairs	3	P-2	S-2
1468 S MAIN ST duplex (upstairs)	3	P-2	S-2
1470 HARRIS ST	1	P-2	S-2
1470 SYCAMORE ST	1	P-2	S-2
1471 FINNEGAN LN	3	P-2	S-2
1473 MYRTLE ST	2	P-2	S-2
1475 FINNEGAN LN	3	P-2	S-2

STREET ADDRESS	LEVEL	PHASE	STAGE
1476 FINNEGAN LN	3	P-2	S-2
1477 SYCAMORE ST.	2	P-2	S-2
1478 MYRTLE ST	2	P-2	S-2
1479 S MAIN ST	2	P-2	S-2
1486 SYCAMORE ST	3	P-2	S-2
1487 S MAIN ST	3	P-2	S-2
1488 FINNEGAN LN	3	P-2	S-2
1488 S MAIN ST #1	1	P-2	S-2
1488 S MAIN ST #2	3	P-2	S-2
1491 S MAIN ST	2	P-2	S-2
1496 PARK AVE	2	P-2	S-2
1497 FINNEGAN LN	1	P-2	S-2
1498 FINNEGAN LN	1	P-2	S-2
1500 PARK AVE	3	P-2	S-2
1507 FINNEGAN LN	1	P-2	S-2
1512 FINNEGAN LN	1	P-2	S-2
1519 SONORA ST	3	P-2	S-2
1526 FINNEGAN LN	2	P-2	S-2
1531 FINNEGAN LN	3	P-2	S-2
1540 FINNEGAN LN	3	P-2	S-2
1541 S MAIN ST	1	P-2	S-2
1544 S MAIN ST	1	P-2	S-2
1548 PARK AVE	3	P-2	S-2
1552 FINNEGAN LN	1	P-2	S-2
1553 S MAIN ST	2	P-2	S-2
1555 MTN VIEW	3	P-2	S-2
1556 S MAIN ST	3	P-2	S-2
1560 FINNEGAN LN	3	P-2	S-2
1563 FINNEGAN LN	1	P-2	S-2
1563 S MAIN ST	1	P-2	S-2
1566 PARK AVE	2	P-2	S-2
1570 FINNEGAN LN	1	P-2	S-2
1572 S MAIN ST	1	P-2	S-2
1575 S MAIN ST	1	P-2	S-2
1580 GOLD CLIFF RD	3	P-2	S-2
1581 PARK AVE	2	P-2	S-2
1583 PARK AVE	3	P-2	S-2
1583 S MAIN ST	1	P-2	S-2
1584 SONORA ST	3	P-2	S-2
1596 SONORA ST	1	P-2	S-2
1598 SONORA ST	3	P-2	S-2
1605 S MAIN ST	3	P-2	S-2
1614 PARK AVE	1	P-2	S-2
1625 S MAIN ST	3	P-2	S-2
1629 MTN VIEW	3	P-2	S-2
1631 MOUNTAIN VIEW RD	3	P-2	S-2
1634 S MAIN ST	3	P-2	S-2
1647 MAYO RD	1	P-2	S-2
1649 S MAIN ST	2	P-2	S-2
1650 S MAIN ST	3	P-2	S-2
1665 SONORA ST	3	P-2	S-2
1669 S MAIN ST	3	P-2	S-2
1680 S MAIN ST	3	P-2	S-2

BID SET

WATER METER REPLACEMENT
SCHEDULE ROUTE 4–1

UNIT 0000

PROJECT NUMBER & PHASE

00000000001



SHEET No.11TOTAL SHEETS21

REGISTERED PROFESSIONAL ENGINEER

David Richard

No. 33479

Exp. 06/30/26

 
CIVIL

STATE OF CALIFORNIA

CITY OF ANGELS
DEPARTMENT OF PUBLIC WORKS
2990 CENTENNIAL ROAD
ANGELS CAMP, CA 95222

DEWBERRY
903 W CENTER STREET
MANTECA, CA 95337

C1.04



x

x

x

x

x

CITY OF ANGELS – DEPARTMENT OF PUBLIC WORKS	CONSULTANT PROJECT MANAGER	CALCULATED – DESIGNED BY	REVISD BY	C. AGUIAR	
WATER METER REPLACEMENT PROJECT	D. RICHARD	CHECKED BY	DATE REVISED	11/17/25	

STREET ADDRESS	LEVEL	PHASE	STAGE
1690 MARTINA ST	1	P-2	S-2
1699 S MAIN ST	3	P-2	S-2
1705 MARTINA ST	3	P-2	S-2
1708 S MAIN ST	2	P-2	S-2
1720 S MAIN ST	2	P-2	S-2
1721 S MAIN ST	3	P-2	S-2
1729 MARTINA ST	3	P-2	S-2
1731 S MAIN ST	2	P-2	S-2
1750 S MAIN ST	3	P-2	S-2
1755 S MAIN ST	3	P-2	S-2
1758 RAMORINI LN	3	P-2	S-2
1760 S MAIN ST	3	P-2	S-2
1770 S MAIN ST	1	P-2	S-2
1792 RAMORINI LN	1	P-2	S-2
1799 S MAIN ST - 1 comm 4 res	3	P-2	S-2
1810 S MAIN ST	3	P-2	S-2
1820 S MAIN ST	3	P-2	S-2
1826 RAMORINI LN	1	P-2	S-2
1834 S MAIN ST	3	P-2	S-2
1872 CENTENNIAL RD	3	P-2	S-2
1882 CENTENNIAL RD	3	P-2	S-2
1884 S MAIN ST - water only	3	P-2	S-2
1892 CENTENNIAL RD	3	P-2	S-2
1895 CENTENNIAL RD	2	P-2	S-2
1896 S MAIN ST	3	P-2	S-2
1902 CENTENNIAL RD	2	P-2	S-2
1906 CENTENNIAL RD	3	P-2	S-2
1917 CENTENNIAL RD	2	P-2	S-2
1919 CENTENNIAL RD	2	P-2	S-2
1922 CENTENNIAL RD	1	P-2	S-2
1925 CENTENNIAL RD	2	P-2	S-2
1951 RAMORINI LN	3	P-2	S-2
1959 CENTENNIAL RD	2	P-2	S-2
1960 CENTENNIAL RD	3	P-2	S-2
1972 CENTENNIAL RD	1	P-2	S-2
1979 RAMORINI LN	3	P-2	S-2
1984 CENTENNIAL RD	3	P-2	S-2
2002 CENTENNIAL RD	1	P-2	S-2
2017 CENTENNIAL RD	3	P-2	S-2
2122 S HWY 49 - outside city limits	2	P-2	S-2



SHEET No.12TOTAL SHEETS21

REGISTERED PROFESSIONAL ENGINEER

David Richard

No. 33479

Exp. 06/30/26

CIVIL

STATE OF CALIFORNIA


CITY OF ANGELS
DEPARTMENT OF PUBLIC WORKS
2990 CENTENNIAL ROAD
ANGELS CAMP, CA 95222

DEWBERRY
903 W CENTER STREET
MANTECA, CA 95337

LAST REVISION

C1.05

CITY OF ANGELS – DEPARTMENT OF PUBLIC WORKS	CONSULTANT PROJECT MANAGER	CALCULATED – DESIGNED BY	C. AGUIAR	REVISED BY	C. AGUIAR	x
WATER METER REPLACEMENT PROJECT	D. RICHARD	CHECKED BY	D. RICHARD	DATE REVISED	11/17/25	x

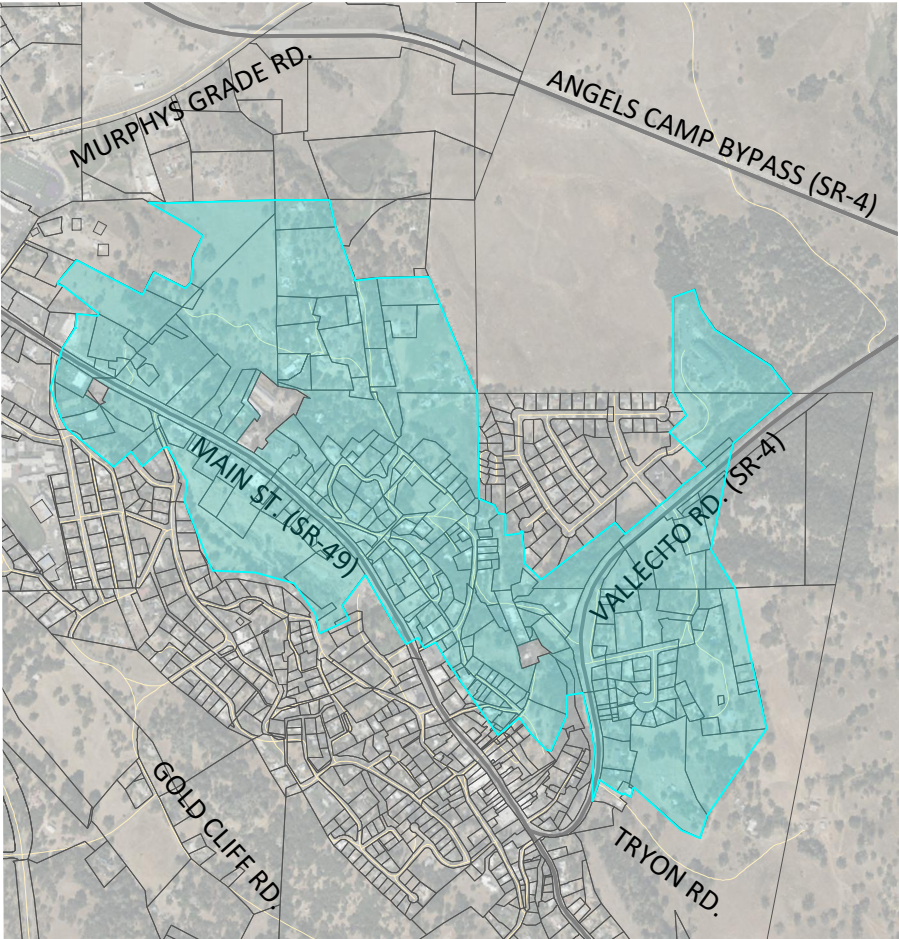

LEGEND

ROUTE 5 – 176 METERS

LEVEL 1 REPLACEMENT – 3
LEVEL 2 REPLACEMENT – 10
LEVEL 3 REPLACEMENT – 163

STREET ADDRESS	LEVEL	PHASE	STAGE
1000 BRAGG ST	3	P-2	S-2
1004 BRET HARTE RD - water/sewer	3	P-2	S-2
1017 - 1/2 PURDY RD - 1 Duplex	3	P-2	S-2
1017 PURDY RD - 1 Duplex	3	P-2	S-2
1017 STORK RD	3	P-2	S-2
1024 BRAGG ST	3	P-2	S-2
1030 BRAGG ST	3	P-2	S-2
1030 STORK RD	3	P-2	S-2
1034 BRAGG ST	3	P-2	S-2
1035 BRET HARTE RD -	3	P-2	S-2
1038 BRAGG ST	3	P-2	S-2
1040 BRAGG ST	3	P-2	S-2
1042 BRET HARTE RD - water/sewer	3	P-2	S-2
1045 HENRY PL	3	P-2	S-2
1050 BRET HARTE RD	3	P-2	S-2
1051 BRET HARTE RD	3	P-2	S-2
1054 BRAGG ST	3	P-2	S-2
1055 BRAGG ST	3	P-2	S-2
1059 BRET HARTE RD	3	P-2	S-2
1060 HENRY PL	3	P-2	S-2
1062 BRET HARTE RD	3	P-2	S-2
1069 BRET HARTE RD	3	P-2	S-2
1079 BRET HARTE RD	3	P-2	S-2
1084 BRET HARTE RD	3	P-2	S-2
1087 BRET HARTE RD	3	P-2	S-2
1095 BRET HARTE RD	3	P-2	S-2
1104 BRAGG ST	3	P-2	S-2
1105/1107 BRET HARTE RD	3	P-2	S-2
1148 BOOSTER WY	3	P-2	S-2
1168 BOOSTER WY - Hydro service center	3	P-2	S-2
1168 BOOSTER WY - Power plant shop	2	P-2	S-2
1184 CHURCH ST	3	P-2	S-2
1185 BRET HARTE RD	3	P-2	S-2
1185 S SUMMIT RD	2	P-2	S-2
1190 BRET HARTE RD	3	P-2	S-2
1191 BOOSTER WY	3	P-2	S-2
1194 BRET HARTE RD #1	3	P-2	S-2
1194 BRET HARTE RD #2	3	P-2	S-2
1194 BRET HARTE RD #3	3	P-2	S-2
1194 BRET HARTE RD #4	3	P-2	S-2
1194 BRET HARTE RD #5	3	P-2	S-2
1194 BRET HARTE RD #6/laundry	3	P-2	S-2
1197 BRET HARTE RD - duplex	3	P-2	S-2
1204 S SUMMIT RD	3	P-2	S-2
1222 S SUMMIT RD	3	P-2	S-2
1234 S SUMMIT RD	3	P-2	S-2
1241 RASBERRY LN	3	P-2	S-2
1241 S SUMMIT RD	3	P-2	S-2
1242 S SUMMIT RD	3	P-2	S-2
1245 S SUMMIT RD	3	P-2	S-2
1246 S SUMMIT RD	3	P-2	S-2
1253 S SUMMIT RD	3	P-2	S-2
1256 S SUMMIT RD	3	P-2	S-2
1259 S SUMMIT RD	3	P-2	S-2
1265 S SUMMIT RD	2	P-2	S-2
1291 RASBERRY LN	2	P-2	S-2
1394 VALLECITO RD	3	P-2	S-2
1400 FOOTHILL VIL	3	P-2	S-2
1424 VALLECITO RD	3	P-2	S-2
1443 TRYON RD	3	P-2	S-2
1448 VALLECITO RD	3	P-2	S-2
1472 VALLECITO RD	3	P-2	S-2
1492 VALLECITO RD	3	P-2	S-2
1512 VALLECITO RD	3	P-2	S-2
1522 VALLECITO RD	3	P-2	S-2
1538 VALLECITO RD	3	P-2	S-2
1545 TRYON RD	3	P-2	S-2
1555 DEPOT RD	3	P-2	S-2
1568 OLD VALLECITO	3	P-2	S-2
1580 OLD VALLECITO	3	P-2	S-2

STREET ADDRESS	LEVEL	PHASE	STAGE
1586 DEPOT RD	3	P-2	S-2
1600 DEPOT RD	3	P-2	S-2
1600 OLD VALLECITO	3	P-2	S-2
1614 DEPOT RD	3	P-2	S-2
1614 OLD VALLECITO	3	P-2	S-2
1620 OLD VALLECITO	3	P-2	S-2
1630 OLD VALLECITO	3	P-2	S-2
1638 MOOSE TRAIL	3	P-2	S-2
1639 DEPOT RD	3	P-2	S-2
1640 OLD VALLECITO	3	P-2	S-2
1652 TRYON CT	3	P-2	S-2
1653 TRYON CT	3	P-2	S-2
1655 TRYON RD #1	3	P-2	S-2
1655 TRYON RD #2	3	P-2	S-2
1663 TRYON CT	3	P-2	S-2
1664 DEPOT RD	3	P-2	S-2
1666 TRYON CT	3	P-2	S-2
1669 DEPOT RD	3	P-2	S-2
1673 TRYON CT	3	P-2	S-2
1674 DEPOT RD	3	P-2	S-2
1683 TRYON CT	3	P-2	S-2
1689 TRYON CT	3	P-2	S-2
1690 TRYON CT	3	P-2	S-2
1694 TRYON CT	3	P-2	S-2
1695 TRYON CT	3	P-2	S-2
1700 DEPOT RD	3	P-2	S-2
1702 TRYON CT	3	P-2	S-2
1703 TRYON CT	3	P-2	S-2
1719 MOOSE TRAIL	3	P-2	S-2
1731 MOOSE TRAIL	3	P-2	S-2
1745 DEPOT RD	3	P-2	S-2
1755 MOOSE TRAIL	3	P-2	S-2
1779 MOOSE TRAIL	3	P-2	S-2
1786 DEPOT RD	3	P-2	S-2
1789 MOOSE TRAIL	3	P-2	S-2
554 SULTANA LN - water only	3	P-2	S-2
580 S MAIN ST	3	P-2	S-2
594 PURDY RD	3	P-2	S-2
598 SULTANA LN	3	P-2	S-2
667 S MAIN ST	3	P-2	S-2
667 S MAIN ST - Landscape	3	P-2	S-2
668 MARK TWAIN RD	3	P-2	S-2
686 S MAIN ST	3	P-2	S-2
691 PURDY RD	3	P-2	S-2
709 S MAIN ST	2	P-2	S-2
714 PURDY RD	3	P-2	S-2
714 S MAIN ST	3	P-2	S-2
715 PURDY RD	3	P-2	S-2
720 S MAIN ST	3	P-2	S-2
730 S MAIN ST	3	P-2	S-2
735 S MAIN ST	2	P-2	S-2
740 S MAIN ST	3	P-2	S-2
744 PURDY RD	3	P-2	S-2
747 KIDS CT	3	P-2	S-2
750 KIDS CT	3	P-2	S-2
761 DADS RD	3	P-2	S-2
770 KIDS CT	3	P-2	S-2
784 DADS RD	3	P-2	S-2
800 DADS RD	3	P-2	S-2
808 S MAIN ST	3	P-2	S-2
809 S MAIN ST	3	P-2	S-2
815 DADS RD - 2 buildings	1	P-2	S-2
815 PURDY RD	3	P-2	S-2
820 S MAIN ST	3	P-2	S-2
825 PURDY RD	3	P-2	S-2
827 PURDY RD	3	P-2	S-2
834 S MAIN ST	3	P-2	S-2
835 PURDY RD	3	P-2	S-2

STREET ADDRESS	LEVEL	PHASE	STAGE
842 S MAIN ST - senior services bldg	3	P-2	S-2
845 S MAIN ST	3	P-2	S-2
848 S MAIN ST	3	P-2	S-2
850 PURDY RD	3	P-2	S-2
859 S MAIN ST	3	P-2	S-2
866 S MAIN ST	3	P-2	S-2
876 S MAIN ST- LOWER UNIT	3	P-2	S-2
876 S MAIN ST- UPPER UNIT	3	P-2	S-2
901 S MAIN ST	3	P-2	S-2
907 BRAGG ST	3	P-2	S-2
908 STORK RD	3	P-2	S-2
910 PURDY RD	2	P-2	S-2
913 BRAGG ST	3	P-2	S-2
920 PURDY RD	3	P-2	S-2
921 PURDY RD	1	P-2	S-2
938 S BAKER ST	3	P-2	S-2
941 BRET HARTE RD	3	P-2	S-2
941 PURDY RD	3	P-2	S-2
947 S BAKER ST	3	P-2	S-2
948 PURDY RD	3	P-2	S-2
950 S BAKER ST	3	P-2	S-2
951 S MAIN ST	3	P-2	S-2
954 BRET HARTE RD	3	P-2	S-2
966 BRAGG ST	3	P-2	S-2
967 BRAGG ST	3	P-2	S-2
967 PURDY RD	3	P-2	S-2
969 BRAGG ST	2	P-2	S-2
970 BRET HARTE RD	2	P-2	S-2
971 STORK RD	3	P-2	S-2
973 PURDY RD	3	P-2	S-2
973 STORK RD	3	P-2	S-2
974 S BAKER ST	3	P-2	S-2
977 STORK RD	3	P-2	S-2
984 S BAKER ST	1	P-2	S-2
987 PURDY RD	3	P-2	S-2
996 STORK RD	3	P-2	S-2
999 BRAGG ST	2	P-2	S-2
LANDSCAPE	3	P-2	S-2



SHEET No.13TOTAL SHEETS21

REGISTERED PROFESSIONAL ENGINEER

David Richard

No. 33479

Exp. 06/30/26

CIVIL

STATE OF CALIFORNIA


CITY OF ANGELS
DEPARTMENT OF PUBLIC WORKS
2990 CENTENNIAL ROAD
ANGELS CAMP, CA 95222

DEWBERRY
903 W CENTER STREET
MANTECA, CA 95337

C1.06

DATE PLOTTED => Nov 17, 2025
TIME PLOTTED => 1:02 pm

CITY OF ANGELS – DEPARTMENT OF PUBLIC WORKS		CONSULTANT PROJECT MANAGER	C. AGUIAR	REVISD BY	C. AGUIAR	11/17/25
WATER METER REPLACEMENT PROJECT		D. RICHARD	C. AGUIAR	DATE REVISED	D. RICHARD	

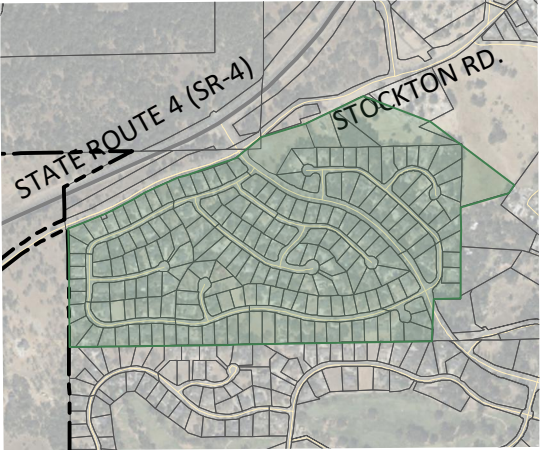

LEGEND

ROUTE 7 – 166 METERS

LEVEL 1 REPLACEMENT – 101
LEVEL 2 REPLACEMENT – 55
LEVEL 3 REPLACEMENT – 10

STREET ADDRESS	LEVEL	PHASE	STAGE
102 MISTLETOE LN	1	P-1	S-1
102 ROCKY RIDGE LN	1	P-1	S-1
103 ACORN DR	1	P-1	S-1
105 MISTLETOE LN	2	P-1	S-1
105 ROCKY RIDGE LN	1	P-1	S-1
114 ROCKY RIDGE LN	1	P-1	S-1
115 ACORN DR	1	P-1	S-1
116 MISTLETOE LN	2	P-1	S-1
119 ROCKY RIDGE LN	1	P-1	S-1
121 MISTLETOE LN	3	P-1	S-1
126 ROCKY RIDGE LN	1	P-1	S-1
127 ACORN DR	1	P-1	S-1
130 MISTLETOE LN	2	P-1	S-1
133 ROCKY RIDGE LN	1	P-1	S-1
137 MISTLETOE LN	3	P-1	S-1
138 ROCKY RIDGE LN	1	P-1	S-1
139 ACORN DR	1	P-1	S-1
147 ROCKY RIDGE LN	1	P-1	S-1
150 ROCKY RIDGE LN	1	P-1	S-1
151 ACORN DR	1	P-1	S-1
153 MISTLETOE CT	3	P-1	S-1
160 ACORN DR	1	P-1	S-1
161 ROCKY RIDGE LN	1	P-1	S-1
162 ROCKY RIDGE LN	2	P-1	S-1
163 ACORN DR	1	P-1	S-1
169 MISTLETOE CT	1	P-1	S-1
170 MISTLETOE CT	1	P-1	S-1
173 ROCKY RIDGE LN	2	P-1	S-1
174 ROCKY RIDGE LN	1	P-1	S-1
175 ACORN DR	1	P-1	S-1
180 ACORN DR	2	P-1	S-1
185 MISTLETOE CT	1	P-1	S-1
186 ROCKY RIDGE LN	2	P-1	S-1
187 ACORN DR	1	P-1	S-1
190 MISTLETOE CT	1	P-1	S-1
195 ROCKY RIDGE CT	1	P-1	S-1
198 ROCKY RIDGE CT	2	P-1	S-1
199 ACORN DR	1	P-1	S-1
200 ACORN DR	1	P-1	S-1
201 MISTLETOE CT	1	P-1	S-1
211 LEAF CT	1	P-1	S-1
217 MISTLETOE CT	1	P-1	S-1
219 ROCKY RIDGE CT	1	P-1	S-1
220 MISTLETOE CT	1	P-1	S-1
223 LEAF CT	3	P-1	S-1
224 ACORN DR	1	P-1	S-1
224 ROCKY RIDGE CT	1	P-1	S-1
231 ROCKY RIDGE CT	1	P-1	S-1
233 MISTLETOE CT	1	P-1	S-1
234 MISTLETOE CT	1	P-1	S-1
235 LEAF CT	3	P-1	S-1
235 ROCKY RIDGE CT	1	P-1	S-1
236 ROCKY RIDGE CT	1	P-1	S-1
240 ROCKY RIDGE CT	1	P-1	S-1
247 LEAF CT	1	P-1	S-1

STREET ADDRESS	LEVEL	PHASE	STAGE
248 ACORN DR	1	P-1	S-1
248 LEAF CT	3	P-1	S-1
249 MISTLETOE CT	1	P-1	S-1
250 MISTLETOE CT	2	P-1	S-1
259 LEAF CT	1	P-1	S-1
259 MISTLETOE CT	2	P-1	S-1
260 ACORN DR	1	P-1	S-1
260 LEAF CT	1	P-1	S-1
260 MISTLETOE CT	1	P-1	S-1
270 MISTLETOE CT	2	P-1	S-1
271 LEAF CT	1	P-1	S-1
272 ACORN DR	1	P-1	S-1
272 LEAF CT	1	P-1	S-1
280 LIVE OAK DR	1	P-1	S-1
283 LEAF CT	1	P-1	S-1
284 LEAF CT	3	P-1	S-1
292 LIVE OAK DR	1	P-1	S-1
295 LEAF CT	1	P-1	S-1
301 ACORN DR	1	P-1	S-1
302 ACORN DR	1	P-1	S-1
304 LIVE OAK DR	1	P-1	S-1
305 LIVE OAK DR	1	P-1	S-1
311 LIVE OAK DR	1	P-1	S-1
313 ACORN DR	1	P-1	S-1
314 ACORN DR	1	P-1	S-1
316 LIVE OAK DR	1	P-1	S-1
325 ACORN DR	1	P-1	S-1
328 LIVE OAK DR	1	P-1	S-1
337 ACORN DR	1	P-1	S-1
338 ACORN DR	1	P-1	S-1
340 LIVE OAK DR	1	P-1	S-1
345 LIVE OAK DR	1	P-1	S-1
349 ACORN DR	1	P-1	S-1
361 ACORN DR	1	P-1	S-1
364 LIVE OAK DR	1	P-1	S-1
376 LIVE OAK DR	1	P-1	S-1
388 LIVE OAK DR	1	P-1	S-1
400 LIVE OAK DR	2	P-1	S-1
412 LIVE OAK DR	2	P-1	S-1
424 LIVE OAK DR	2	P-1	S-1
431 LIVE OAK DR	1	P-1	S-1
436 LIVE OAK DR	2	P-1	S-1
443 LIVE OAK DR	1	P-1	S-1
448 LIVE OAK DR	1	P-1	S-1
455 LIVE OAK DR	1	P-1	S-1
460 LIVE OAK DR	1	P-1	S-1
467 LIVE OAK DR	2	P-1	S-1
472 LIVE OAK DR	2	P-1	S-1
479 LIVE OAK DR	2	P-1	S-1
484 LIVE OAK DR	2	P-1	S-1
491 LIVE OAK DR	3	P-1	S-1
496 LIVE OAK DR	2	P-1	S-1
503 LIVE OAK DR	3	P-1	S-1
507 LIVE OAK CT	2	P-1	S-1
508 LIVE OAK DR	2	P-1	S-1

STREET ADDRESS	LEVEL	PHASE	STAGE
511 LIVE OAK CT	2	P-1	S-1
515 LIVE OAK CT	2	P-1	S-1
519 LIVE OAK CT	2	P-1	S-1
520 LIVE OAK DR	2	P-1	S-1
523 LIVE OAK CT	2	P-1	S-1
527 LIVE OAK CT	2	P-1	S-1
531 LIVE OAK CT	2	P-1	S-1
532 LIVE OAK DR	2	P-1	S-1
535 LIVE OAK CT	2	P-1	S-1
537 LIVE OAK CT	2	P-1	S-1
539 LIVE OAK CT	2	P-1	S-1
541 LIVE OAK CT	2	P-1	S-1
544 LIVE OAK DR	2	P-1	S-1
545 LIVE OAK CT	2	P-1	S-1
549 LIVE OAK CT	2	P-1	S-1
553 LIVE OAK CT	1	P-1	S-1
556 LIVE OAK DR	2	P-1	S-1
557 LIVE OAK DR	2	P-1	S-1
568 LIVE OAK DR	2	P-1	S-1
580 LIVE OAK DR	2	P-1	S-1
589 LIVE OAK DR	2	P-1	S-1
592 LIVE OAK DR	2	P-1	S-1
604 LIVE OAK DR	2	P-1	S-1
607 LIVE OAK DR	1	P-1	S-1
616 LIVE OAK DR	2	P-1	S-1
617 LIVE OAK DR	2	P-1	S-1
627 LIVE OAK DR	2	P-1	S-1
630 LIVE OAK DR	2	P-1	S-1
631 LAKEVIEW CT	2	P-1	S-1
644 LIVE OAK DR	2	P-1	S-1
649 LAKEVIEW CT	2	P-1	S-1
658 LIVE OAK DR	2	P-1	S-1
661 LIVE OAK DR	2	P-1	S-1
711 LIVE OAK DR	2	P-1	S-1
723 LIVE OAK DR	1	P-1	S-1
724 LIVE OAK DR	1	P-1	S-1
73 MISTLETOE LN	1	P-1	S-1
735 LIVE OAK DR	2	P-1	S-1
74 MISTLETOE LN	1	P-1	S-1
747 LIVE OAK DR	1	P-1	S-1
748 LIVE OAK DR	1	P-1	S-1
771 LIVE OAK DR	1	P-1	S-1
772 LIVE OAK DR	1	P-1	S-1
796 LIVE OAK DR	1	P-1	S-1
808 LIVE OAK DR	1	P-1	S-1
820 LIVE OAK DR	1	P-1	S-1
831 LIVE OAK DR	1	P-1	S-1
832 LIVE OAK DR	3	P-1	S-1
843 LIVE OAK DR	1	P-1	S-1
844 LIVE OAK DR	1	P-1	S-1
855 LIVE OAK DR	1	P-1	S-1
856 LIVE OAK DR	1	P-1	S-1
868 LIVE OAK DR	1	P-1	S-1



SHEET No.14TOTAL SHEETS21

REGISTERED PROFESSIONAL ENGINEER

David Richard

No. 33479

Exp. 06/30/26

CIVIL


STATE OF CALIFORNIA

CITY OF ANGELS
DEPARTMENT OF PUBLIC WORKS
2990 CENTENNIAL ROAD
ANGELS CAMP, CA 95222

DEWBERRY
903 W CENTER STREET
MANTECA, CA 95337

STREET ADDRESS	LEVEL	PHASE	STAGE
88 MISTLETOE LN	1	P-1	S-1
89 MISTLETOE LN	1	P-1	S-1
807 LIVE OAK DR	1	P-1	S-1

CITY OF ANGELS – DEPARTMENT OF PUBLIC WORKS	CONSULTANT PROJECT MANAGER		CALCULATED– DESIGNED BY	C. AGUIAR	REVISED BY	C. AGUIAR	
WATER METER REPLACEMENT PROJECT	D. RICHARD		CHECKED BY	D. RICHARD	DATE	REVISED	11/17/25

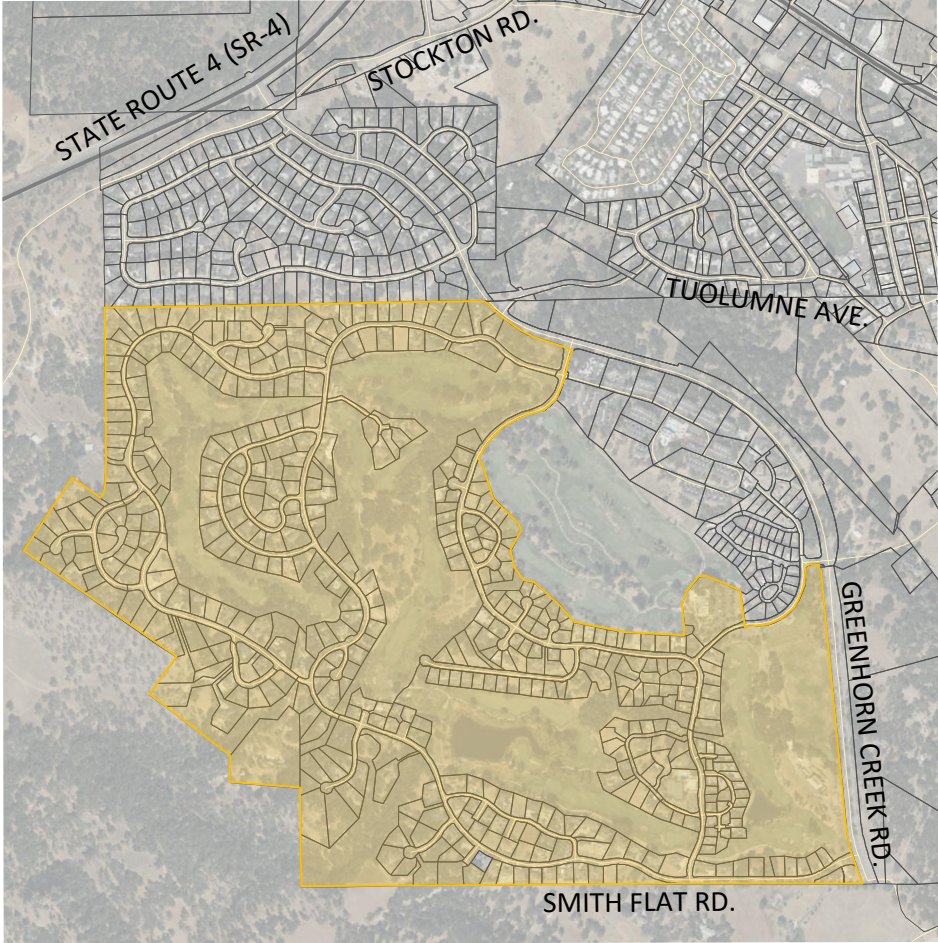

LEGEND

ROUTE 8 – 400 METERS

LEVEL 1 REPLACEMENT – 181

LEVEL 2 REPLACEMENT – 200

LEVEL 3 REPLACEMENT – 19

STREET ADDRESS	LEVEL	PHASE	STAGE
1170 GOLD CLIFF RD	2	P-1	S-1
138 SMITH FLAT RD	2	P-1	S-1
139 SMITH FLAT RD	2	P-1	S-1
142 SMITH FLAT RD	2	P-1	S-1
146 SMITH FLAT RD	2	P-1	S-1
154 SMITH FLAT RD	2	P-1	S-1
157 SMITH FLAT RD	2	P-1	S-1
162 SMITH FLAT RD	1	P-1	S-1
170 SMITH FLAT RD	1	P-1	S-1
173 SMITH FLAT RD	1	P-1	S-1
186 SMITH FLAT RD	1	P-1	S-1
193 SMITH FLAT RD	1	P-1	S-1
194 SMITH FLAT RD	1	P-1	S-1
202 SMITH FLAT RD	1	P-1	S-1
210 SMITH FLAT RD	1	P-1	S-1
218 SMITH FLAT RD	1	P-1	S-1
221 SMITH FLAT RD	1	P-1	S-1
222 SMITH FLAT RD	1	P-1	S-1
226 SMITH FLAT RD	1	P-1	S-1
230 SMITH FLAT RD	1	P-1	S-1
231 SMITH FLAT RD	2	P-1	S-1
234 SMITH FLAT RD	1	P-1	S-1
244 BLAIR MINE RD	1	P-1	S-1
244 EL DORADO CT	1	P-1	S-1
245 BLAIR MINE RD	1	P-1	S-1
245 EL DORADO CT	1	P-1	S-1
246 BLAIR MINE RD	1	P-1	S-1
247 BLAIR MINE RD	1	P-1	S-1
248 BLAIR MINE RD	1	P-1	S-1
248 EL DORADO CT	1	P-1	S-1
249 BLAIR MINE RD	1	P-1	S-1
249 EL DORADO CT	1	P-1	S-1
250 BLAIR MINE RD	1	P-1	S-1
251 BLAIR MINE RD	1	P-1	S-1
251 EL DORADO CT	1	P-1	S-1
252 EL DORADO CT	1	P-1	S-1
253 EL DORADO CT	1	P-1	S-1
253 POINTE DR	2	P-1	S-1
254 EL DORADO CT	1	P-1	S-1
255 EL DORADO CT	1	P-1	S-1
255 POINTE DR	2	P-1	S-1
257 BLAIR MINE RD	1	P-1	S-1
257 POINTE DR	2	P-1	S-1
259 BLAIR MINE RD	1	P-1	S-1
259 POINTE DR	2	P-1	S-1
260 BLAIR MINE RD	1	P-1	S-1
261 BLAIR MINE RD	1	P-1	S-1
263 BLAIR MINE RD	1	P-1	S-1
263 CATALPA LN	2	P-1	S-1
264 CATALPA LN	2	P-1	S-1
265 BLAIR MINE RD	1	P-1	S-1
268 CATALPA LN	2	P-1	S-1
270 BLAIR MINE RD	1	P-1	S-1
271 CATALPA LN	2	P-1	S-1
272 BLAIR MINE RD	1	P-1	S-1
273 SMITH FLAT RD	2	P-1	S-1
274 BLAIR MINE RD	1	P-1	S-1
276 CATALPA LN	2	P-1	S-1
278 BLAIR MINE RD	1	P-1	S-1
279 BLAIR MINE RD	1	P-1	S-1
280 CATALPA LN	2	P-1	S-1
280 SMITH FLAT RD	2	P-1	S-1
282 BLAIR MINE RD	1	P-1	S-1
283 BLAIR MINE RD	1	P-1	S-1
283 MARY BELLE WY	1	P-1	S-1
284 CATALPA LN	2	P-1	S-1
285 BLAIR MINE RD	1	P-1	S-1
286 BLAIR MINE RD	1	P-1	S-1

STREET ADDRESS	LEVEL	PHASE	STAGE
286 MARY BELLE WY	2	P-1	S-1
287 MARY BELLE WY	3	P-1	S-1
288 BLAIR MINE RD	1	P-1	S-1
288 CATALPA LN	2	P-1	S-1
288 MARY BELLE WY	1	P-1	S-1
290 BLAIR MINE RD	1	P-1	S-1
290 MARY BELLE WY	1	P-1	S-1
292 BLAIR MINE RD	1	P-1	S-1
292 CATALPA LN	2	P-1	S-1
292 MARY BELLE WY	1	P-1	S-1
293 BLAIR MINE RD	1	P-1	S-1
293 MARY BELLE WAY	1	P-1	S-1
293 SMITH FLAT RD	2	P-1	S-1
296 BLAIR MINE RD	1	P-1	S-1
296 CATALPA LN	2	P-1	S-1
296 MARY BELLE WY	1	P-1	S-1
297 MARY BELLE WAY	1	P-1	S-1
298 MARY BELLE WY	1	P-1	S-1
300 BLAIR MINE RD	2	P-1	S-1
301 BLAIR MINE RD	2	P-1	S-1
301 MARY BELLE WY	1	P-1	S-1
301 MILL RD	2	P-1	S-1
302 MARY BELLE WY	1	P-1	S-1
304 CATALPA LN	2	P-1	S-1
304 MARY BELLE WY	1	P-1	S-1
306 MARY BELLE WY	1	P-1	S-1
306 MILL RD	2	P-1	S-1
307 SMITH FLAT RD	2	P-1	S-1
308 CATALPA LN	2	P-1	S-1
311 PROSPECT CT	2	P-1	S-1
312 CATALPA LN	2	P-1	S-1
313 MARY BELLE WY	1	P-1	S-1
313 SMITH FLAT RD	2	P-1	S-1
316 CATALPA LN	2	P-1	S-1
319 PROSPECT CT	2	P-1	S-1
320 BLAIR MINE RD	2	P-1	S-1
320 CATALPA LN	2	P-1	S-1
320 MILL CT	2	P-1	S-1
323 PROSPECT CT	2	P-1	S-1
324 CATALPA LN	2	P-1	S-1
325 SMITH FLAT RD	2	P-1	S-1
328 BLAIR MINE RD	2	P-1	S-1
328 CATALPA LN	2	P-1	S-1
329 PROSPECT CT	2	P-1	S-1
332 CATALPA LN	2	P-1	S-1
335 PROSPECT CT	2	P-1	S-1
338 MILL RD	2	P-1	S-1
341 BLAIR MINE RD	2	P-1	S-1
344 SMITH FLAT RD	2	P-1	S-1
349 BLAIR MINE RD	1	P-1	S-1
349 SMITH FLAT RD	2	P-1	S-1
350 MILL RD	1	P-1	S-1
352 SMITH FLAT RD	2	P-1	S-1
353 SMITH FLAT RD	2	P-1	S-1
355 BLAIR MINE RD	1	P-1	S-1
360 SMITH FLAT RD	3	P-1	S-1
365 BLAIR MINE RD	1	P-1	S-1
366 BLAIR MINE RD	1	P-1	S-1
370 SMITH FLAT RD	2	P-1	S-1
371 SMITH FLAT RD	2	P-1	S-1
375 BLAIR MINE RD	1	P-1	S-1
379 BLAIR MINE RD	1	P-1	S-1
379 PERLINA TERR	2	P-1	S-1
380 SMITH FLAT RD	2	P-1	S-1
387 PERLINA TERR	2	P-1	S-1
388 BLAIR MINE RD	1	P-1	S-1
388 SMITH FLAT RD	2	P-1	S-1
389 BLAIR MINE RD	1	P-1	S-1

STREET ADDRESS	LEVEL	PHASE	STAGE
391 PERLINA TERR	3	P-1	S-1
394 BLAIR MINE RD	1	P-1	S-1
396 SMITH FLAT RD	2	P-1	S-1
397 BLAIR MINE RD	1	P-1	S-1
399 PERLINA TERR	3	P-1	S-1
400 ALBASIO CT	1	P-1	S-1
400 CORRAL LOOP	1	P-1	S-1
401 ALBASIO CT	1	P-1	S-1
401 BLAIR MINE RD	2	P-1	S-1
402 BLAIR MINE RD	2	P-1	S-1
406 CORRAL LOOP	1	P-1	S-1
408 ALBASIO CT	1	P-1	S-1
408 CORRAL LOOP	2	P-1	S-1
409 ALBASIO CT	1	P-1	S-1
410 CORRAL LOOP	2	P-1	S-1
411 PERLINA TERR	2	P-1	S-1
412 ALBASIO CT	2	P-1	S-1
412 CORRAL LOOP	3	P-1	S-1
416 CORRAL LOOP	2	P-1	S-1
418 CORRAL LOOP	2	P-1	S-1
419 ALBASIO CT	2	P-1	S-1
420 SMITH FLAT RD	2	P-1	S-1
425 PERLINA TERR	2	P-1	S-1
428 SMITH FLAT RD	2	P-1	S-1
441 OLIVIA PL	1	P-1	S-1
449 OLIVIA PL	1	P-1	S-1
450 SELKIRK RANCH	1	P-1	S-1
453 OLIVIA PL	1	P-1	S-1
457 SELKIRK RANCH	1	P-1	S-1
457 SMITH FLAT RD	1	P-1	S-1
458 SELKIRK RANCH	1	P-1	S-1
463 SMITH FLAT RD	1	P-1	S-1
465 SELKIRK RANCH	1	P-1	S-1
466 FIDDLERS CT	1	P-1	S-1
468 FIDDLERS CT	1	P-1	S-1
473 CORNELIA PL	3	P-1	S-1
474 FIDDLERS CT	2	P-1	S-1
476 FIDDLERS CT	2	P-1	S-1
476 SMITH FLAT RD	1	P-1	S-1
477 CORNELIA PL	2	P-1	S-1
481 CORNELIA PL	2	P-1	S-1
481 ROCK FORGE LP	2	P-1	S-1
482 SELKIRK RANCH	1	P-1	S-1
483 CORNELIA PLACE	2	P-1	S-1
489 ROCK FORGE LP	2	P-1	S-1
490 SELKIRK RANCH	1	P-1	S-1
490 SMITH FLAT RD	2	P-1	S-1
497 ROCK FORGE LP	2	P-1	S-1
498 SELKIRK RANCH	1	P-1	S-1
500 ROCK FORGE LP	2	P-1	S-1
501 ROSEBUSH CT	2	P-1	S-1
505 ROCK FORGE LP	1	P-1	S-1
506 SELKIRK RANCH	1	P-1	S-1

BID SET

WATER METER REPLACEMENT SCHEDULE ROUTE 8–1

UNIT 0000

PROJECT NUMBER & PHASE

00000000001

USERNAME ==>caguiar
DWG FILE ==> COA–WMRP–C1.08–1.09–R8.dwg

RELATIVE BORDER SCALE IS IN INCHES

0

1

2

3

C1.08

DATE PLOTTED ==> Nov 17, 2025
TIME PLOTTED ==> 1:03 pm

REGISTERED PROFESSIONAL ENGINEER
David Richard
No. 33479
Exp. 06/30/26
CIVIL
STATE OF CALIFORNIA

CITY OF ANGELS
DEPARTMENT OF PUBLIC WORKS
2990 CENTENNIAL ROAD
ANGELS CAMP, CA 95222

DEWBERRY
903 W CENTER STREET
MANTECA, CA 95337


CITY OF ANGELS – DEPARTMENT OF PUBLIC WORKS	CONSULTANT PROJECT MANAGER	C. AGUIAR	REVISÉ BY	C. AGUIAR	
WATER METER REPLACEMENT PROJECT	D. RICHARD	D. RICHARD	DATE REVISED	11/17/25	

STREET ADDRESS	LEVEL	PHASE	STAGE
508 ROCK FORGE LP	2	P-1	S-1
509 SELKIRK RANCH	1	P-1	S-1
515 ROSEBUSH CT	1	P-1	S-1
516 ROCK FORGE LP	1	P-1	S-1
517 SELKIRK RANCH	1	P-1	S-1
520 SMITH FLAT RD	2	P-1	S-1
521 ROCK FORGE LP	1	P-1	S-1
522 SELKIRK RANCH	2	P-1	S-1
524 ROCK FORGE LP	1	P-1	S-1
525 ROCK FORGE LP	1	P-1	S-1
528 SPRINGHOUSE RD	1	P-1	S-1
529 ROCK FORGE LP	1	P-1	S-1
533 SPRINGHOUSE RD	1	P-1	S-1
534 SMITH FLAT RD	2	P-1	S-1
536 SPRINGHOUSE RD	1	P-1	S-1
537 ROCK FORGE LP	2	P-1	S-1
540 RAGGIO CT	2	P-1	S-1
541 ROCK FORGE LP	2	P-1	S-1
542 RAGGIO CT	2	P-1	S-1
544 RAGGIO CT	2	P-1	S-1
544 SPRINGHOUSE RD	1	P-1	S-1
546 RAGGIO CT	2	P-1	S-1
548 RAGGIO CT	2	P-1	S-1
552 SPRINGHOUSE RD	1	P-1	S-1
555 MIWUK WY	2	P-1	S-1
556 SELKIRK RANCH	2	P-1	S-1
556 SMITH FLAT RD	2	P-1	S-1
560 MIWUK WAY	2	P-1	S-1
560 SELKIRK RANCH	2	P-1	S-1
560 SPRINGHOUSE RD	1	P-1	S-1
561 SELKIRK RANCH	2	P-1	S-1
562 LIGHTNER PL	2	P-1	S-1
566 LIGHTNER PL	2	P-1	S-1
568 LIGHTNER PL	2	P-1	S-1
568 MIWUK WY	1	P-1	S-1
568 SPRINGHOUSE RD	1	P-1	S-1
569 MIWUK WY	1	P-1	S-1
570 LIGHTNER PL	2	P-1	S-1
574 SMITH FLAT RD	2	P-1	S-1
576 CHIMNEY HILL	2	P-1	S-1
576 SASA PL	2	P-1	S-1
576 SPRINGHOUSE RD	1	P-1	S-1
577 SELKIRK RANCH	2	P-1	S-1
578 SASA PL	2	P-1	S-1
579 STONE CORRAL	2	P-1	S-1
580 CHIMNEY HILL	1	P-1	S-1
581 STONE CORRAL	2	P-1	S-1
582 CHIMNEY HILL	1	P-1	S-1
583 STONE CORRAL	2	P-1	S-1
584 CHIMNEY HILL	3	P-1	S-1
584 SMITH FLAT RD	2	P-1	S-1
585 STONE CORRAL	2	P-1	S-1
586 CHIMNEY HILL CT	3	P-1	S-1
586 MIWUK WY	1	P-1	S-1
587 STONE CORRAL	2	P-1	S-1
591 MIWUK WY	1	P-1	S-1
591 STONE CORRAL	2	P-1	S-1
592 SELKIRK RANCH	2	P-1	S-1
592 SPRINGHOUSE RD	1	P-1	S-1
594 SMITH FLAT RD	2	P-1	S-1
598 ALAWA PL	1	P-1	S-1
600 SELKIRK RANCH	2	P-1	S-1
600 SMITH FLAT RD	2	P-1	S-1
600 SPRINGHOUSE RD	1	P-1	S-1
602 ALAWA PL	2	P-1	S-1
608 SPRINGHOUSE RD	1	P-1	S-1
609 LINDSAY CT	2	P-1	S-1
610 SMITH FLAT RD	2	P-1	S-1
611 LINDSAY CT	2	P-1	S-1

STREET ADDRESS	LEVEL	PHASE	STAGE
611 SMITH FLAT RD	2	P-1	S-1
612 SELKIRK RANCH	2	P-1	S-1
613 LINDSAY CT	2	P-1	S-1
613 MIWUK WY	1	P-1	S-1
615 LINDSAY CT	2	P-1	S-1
616 SELKIRK RANCH	2	P-1	S-1
617 SMOKEHOUSE CT	2	P-1	S-1
619 LINDSAY CT	2	P-1	S-1
619 MIWUK WY	2	P-1	S-1
620 SMITH FLAT RD	2	P-1	S-1
622 MIWUK WY	2	P-1	S-1
624 SELKIRK RANCH	2	P-1	S-1
624 SPRINGHOUSE RD	1	P-1	S-1
625 MIWUK WY	2	P-1	S-1
625 SMITH FLAT RD	2	P-1	S-1
630 SMITH FLAT RD	2	P-1	S-1
631 MIWUK WY	2	P-1	S-1
637 SELKIRK RANCH	2	P-1	S-1
639 MIWUK WY	2	P-1	S-1
640 SMITH FLAT RD	3	P-1	S-1
640 SPRINGHOUSE RD	2	P-1	S-1
643 MIWUK WY	2	P-1	S-1
647 SELKIRK RANCH	2	P-1	S-1
648 SELKIRK RANCH	2	P-1	S-1
650 SMITH FLAT RD	3	P-1	S-1
653 MIWUK WAY	2	P-1	S-1
655 SELKIRK RANCH	2	P-1	S-1
656 SELKIRK RANCH	2	P-1	S-1
661 SELKIRK RANCH	2	P-1	S-1
663 SMITH FLAT RD	2	P-1	S-1
670 GREENSTONE WY	1	P-1	S-1
671 GREENSTONE WY	2	P-1	S-1
671 SELKIRK RANCH RD	2	P-1	S-1
674 GREENSTONE WY	1	P-1	S-1
675 MC CAULEY RNCH - Maintenance Barn	3	P-1	S-1
676 MC CAULEY RNCH - ClubhouseCamps	3	P-1	S-1
677 SMITH FLAT RD	2	P-1	S-1
678 GREENSTONE WY	1	P-1	S-1
679 N STAR LOOP	2	P-1	S-1
681 SELKIRK RANCH	2	P-1	S-1
687 NORTH STAR LP	2	P-1	S-1
689 SMITH FLAT RD	2	P-1	S-1
690 EMPIRE CT	1	P-1	S-1
691 GREENSTONE WY	1	P-1	S-1
691 SELKIRK RANCH RD	3	P-1	S-1
694 GREENSTONE WY	1	P-1	S-1
695 NORTH STAR LP	2	P-1	S-1
698 MADISON CT	1	P-1	S-1
701 SELKIRK RANCH	2	P-1	S-1
706 PILOT KNOB	2	P-1	S-1
707 MC CAULEY RNCH	3	P-1	S-1
710 PILOT KNOB	3	P-1	S-1
711 MC CAULEY RNCH - spa & locker	2	P-1	S-1
711 NORTH STAR LP	2	P-1	S-1
714 PILOT KNOB	3	P-1	S-1
718 GREENSTONE WY	2	P-1	S-1
727 GRINDING ROCK	1	P-1	S-1
729 SMITH FLAT RD	2	P-1	S-1
733 SELKIRK RANCH	2	P-1	S-1
739 GRINDING ROCK	1	P-1	S-1
741 SMITH FLAT RD	2	P-1	S-1
749 SELKIRK RANCH	2	P-1	S-1
757 SELKIRK RANCH	2	P-1	S-1
761 SMITH FLAT RD	2	P-1	S-1
767 QUARTZ MINE	2	P-1	S-1
769 QUARTZ MINE	2	P-1	S-1
775 GRINDING ROCK	1	P-1	S-1
775 QUARTZ MINE	3	P-1	S-1

STREET ADDRESS	LEVEL	PHASE	STAGE
777 GRINDING ROCK	1	P-1	S-1
777 TRIPLE LODGE DR	1	P-1	S-1
780 TRIPLE LODGE DR	1	P-1	S-1
781 QUARTZ MINE	3	P-1	S-1
783 TRIPLE LODGE DR	1	P-1	S-1
786 TRIPLE LODGE DR	1	P-1	S-1
787 SMITH FLAT RD	2	P-1	S-1
789 TRIPLE LODGE DR	1	P-1	S-1
792 TRIPLE LODGE DR	1	P-1	S-1
793 GRINDING ROCK	2	P-1	S-1
795 TRIPLE LODGE DR	1	P-1	S-1
797 SELKIRK RANCH	1	P-1	S-1
797 SMITH FLAT RD	2	P-1	S-1
798 TRIPLE LODGE DR	1	P-1	S-1
799 GRINDING ROCK - new const.	2	P-1	S-1
800 SELKIRK RANCH - Poolhouse	2	P-1	S-1
800 SMITH FLAT RD	2	P-1	S-1
800-1 SELKIRK RANCH - landscape meter by pool	2	P-1	S-1
800C SELKIRK RANCH - 2nd pool	2	P-1	S-1
801 TRIPLE LODGE DR	1	P-1	S-1
805 GRINDING ROCK	2	P-1	S-1
807 SELKIRK RANCH	2	P-1	S-1
807 SMITH FLAT RD	2	P-1	S-1
807 TRIPLE LODGE DR	1	P-1	S-1
811 GRINDING ROCK	2	P-1	S-1
813 TRIPLE LODGE DR	1	P-1	S-1
817 GRINDING ROCK	2	P-1	S-1
817 SELKIRK RANCH	2	P-1	S-1
817 SMITH FLAT RD	3	P-1	S-1
819 TRIPLE LODGE DR	1	P-1	S-1
825 TRIPLE LODGE DR	1	P-1	S-1
827 SELKIRK RANCH	2	P-1	S-1
829 PIONEER MINE	2	P-1	S-1
831 PIONEER MINE	2	P-1	S-1
833 PIONEER MINE	2	P-1	S-1
835 PIONEER MINE	2	P-1	S-1
837 SELKIRK RANCH	2	P-1	S-1
847 SELKIRK RANCH	2	P-1	S-1
857 SELKIRK RANCH	2	P-1	S-1
900 SELKIRK RANCH RD	2	P-1	S-1
JUMPING FROG - laundryoffice + 32 Units	1	P-1	S-1
JUMPING FROG - pool bldgs 34567	1	P-1	S-1
LANDSCAPE MTR	2	P-1	S-1
LOT122 GREENSTONE WY- Ph 1 irrigation	2	P-1	S-1
MINERS CIRCLE - 28 Units	1	P-1	S-1
MINERS CIRCLE - GarRestroom44 Units	1	P-1	S-1
MINERS CIRCLE - rec center + 32 units	1	P-1	S-1
SMITH FLAT RD- restrooms 17th tee	2	P-1	S-1
SPRINGHOUSE RD - Restroom & Irrigation	1	P-1	S-1
300 CATALPA LN	2	P-1	S-1
LIGHTING LANDSCAPE DIST	1	P-1	S-1
MAIN ENT @POND - LIGHTING LANDSCAPE DIST	1	P-1	S-1
FIDDLERS CT - LIGHTING LANDSCAPE DIST	1	P-1	S-1
LOT 9 SELKIRK RANCH - LIGHTING LANDSCAPE DIST	1	P-1	S-1
LOT 80 SELKIRK RANCH - LIGHTING LANDSCAPE DIST	1	P-1	S-1
LOT 67 SELKIRK RANCH - LIGHTING LANDSCAPE DIST	1	P-1	S-1
LOT 71 SELKIRK RANCH - LIGHTING LANDSCAPE DIST	1	P-1	S-1
DRIVING RANGE - LIGHTING LANDSCAPE DIST	1	P-1	S-1
MC CAULEY RNCH - LIGHTING LANDSCAPE DIST	1	P-1	S-1
MEDIAN GREENHORN CRK DRIVE - LIGHTING LANDSCAPE DIST	1	P-1	S-1
SMITH FL & SELKIRK - LIGHTING LANDSCAPE DIST	1	P-1	S-1
LOT167 SMITH FLAT RD - LIGHTING LANDSCAPE DIST	1	P-1	S-1


STREET ADDRESS	LEVEL	PHASE	STAGE
LOT167 SMITH FLAT RD - LIGHTING LANDSCAPE DIST	1	P-1	S-1
LOT169 SMITH FLAT RD - LIGHTING LANDSCAPE DIST	1	P-1	S-1
LOT172 SMITH FLAT RD - LIGHTING LANDSCAPE DIST	1	P-1	S-1
LOT179 SMITH FLAT RD - LIGHTING LANDSCAPE DIST	1	P-1	S-1
LOT189 SMITH FLAT RD - LIGHTING LANDSCAPE DIST	1	P-1	S-1
LOT192 SMITH FLAT RD - LIGHTING LANDSCAPE DIST	1	P-1	S-1
LOT209 SMITH FLAT RD - LIGHTING LANDSCAPE DIST	1	P-1	S-1
LOT207 OLIVIA PL - LLD LANDSCAPIN - LIGHTING LANDSCAPE DIST	1	P-1	S-1
DRIVING RANGE & LANDSCAPING - GREENHORN CREEK GOLF RESORT	1	P-1	S-1
LOT164 SMITH FLAT RD - LIGHTING LANDSCAPE DIST #1	1	P-1	S-1
LOT164 SMITH FLAT RD - LIGHTING LANDSCAPE DIST #2	1	P-1	S-1
LOT153 MIWUK WY - LIGHTING LANDSCAPE DIST #1	1	P-1	S-1
LOT153 MIWUK WY - LIGHTING LANDSCAPE DIST #2	1	P-1	S-1

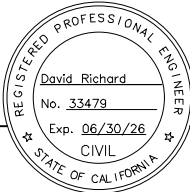 Dewberry®	SHEET No. 16	TOTAL SHEETS 21
		
CITY OF ANGELS DEPARTMENT OF PUBLIC WORKS 2990 CENTENNIAL ROAD ANGELS CAMP, CA 95222	DEWBERRY 903 W CENTER STREET MANTECA, CA 95337	

BID SET		WATER METER REPLACEMENT SCHEDULE ROUTE 8-2	
UNIT 0000	PROJECT NUMBER & PHASE		00000000001



CITY OF ANGELS – DEPARTMENT OF PUBLIC WORKS	CONSULTANT PROJECT MANAGER	CALCULATED – DESIGNED BY	C. AGUIAR	REVISED BY	C. AGUIAR	x
WATER METER REPLACEMENT PROJECT	D. RICHARD	CHECKED BY	D. RICHARD	DATE REVISED	11/17/25	x

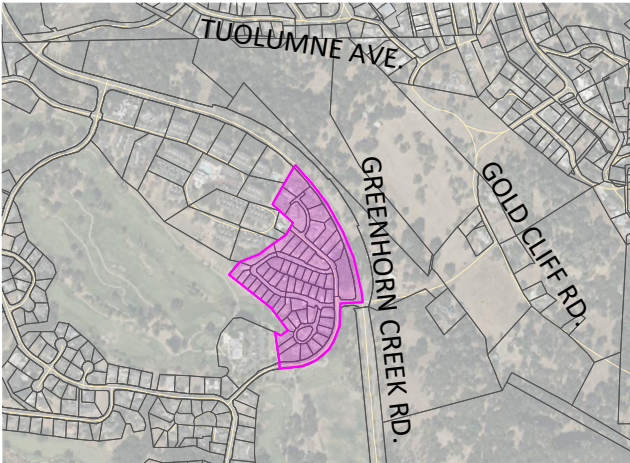

LEGEND

- ROUTE 11 – 55 METERS
- LEVEL 1 REPLACEMENT – 55

STREET ADDRESS	LEVEL	PHASE	STAGE
306 IRONWOOD CT	1	P-1	S-2
309 IRONWOOD CT - Lot 55	1	P-1	S-2
310 IRONWOOD CT	1	P-1	S-2
313 IRONWOOD CT	1	P-1	S-2
314 IRONWOOD CT	1	P-1	S-2
401 MC CAULEY RNCH - Lot 1	1	P-1	S-2
405 MC CAULEY RNCH - Lot 2	1	P-1	S-2
408 MC CAULEY RNCH	1	P-1	S-2
409 MC CAULEY RNCH - Lot 3	1	P-1	S-2
412 MC CAULEY RNCH	1	P-1	S-2
413 MC CAULEY RANCH	1	P-1	S-2
416 MC CAULEY RNCH	1	P-1	S-2
417 MC CAULEY RNCH - Lot 5	1	P-1	S-2
420 MC CAULEY RNCH	1	P-1	S-2
501 SPYGLASS CIRCLE	1	P-1	S-2
505 SPYGLASS CIRCLE	1	P-1	S-2
509 SPYGLASS CIRCLE	1	P-1	S-2
513 SPYGLASS CIRCLE	1	P-1	S-2
517 SPYGLASS CIRCLE	1	P-1	S-2
520 SPYGLASS CIRCLE	1	P-1	S-2
521 SPYGLASS CIRCLE	1	P-1	S-2
524 SPYGLASS CIRCLE - Lot 15	1	P-1	S-2
525 SPYGLASS CIRCLE	1	P-1	S-2
527 SPYGLASS CIRCLE	1	P-1	S-2
528 SPYGLASS CIRCLE	1	P-1	S-2
532 SPYGLASS CIRCLE	1	P-1	S-2
533 SPYGLASS CIRCLE - Lot 33	1	P-1	S-2
536 SPYGLASS CIRCLE	1	P-1	S-2
537 SPYGLASS CIRCLE	1	P-1	S-2
540 SPYGLASS CIRCLE	1	P-1	S-2
541 SPYGLASS CIRCLE	1	P-1	S-2
544 SPYGLASS CIRCLE - Lot 20	1	P-1	S-2
545 SPYGLASS CIRCLE	1	P-1	S-2
548 SPYGLASS CIRCLE	1	P-1	S-2
549 SPYGLASS CIRCLE - Lot 29	1	P-1	S-2
552 SPYGLASS CIRCLE - Lot 22	1	P-1	S-2
553 SPYGLASS CIRCLE - Lot 28	1	P-1	S-2
556 SPYGLASS CIRCLE	1	P-1	S-2
557 SPYGLASS CIRCLE - Lot 27	1	P-1	S-2
561 SPYGLASS CIRCLE - Lot 26	1	P-1	S-2
565 SPYGLASS CIRCLE - Lot 25	1	P-1	S-2
569 SPYGLASS CIRCLE - Lot 24	1	P-1	S-2
600 EDGEWOOD LOOP	1	P-1	S-2
604 EDGEWOOD LP - Lot 35	1	P-1	S-2
608 EDGEWOOD LP - Lot 36	1	P-1	S-2
612 EDGEWOOD LOOP	1	P-1	S-2
616 EDGEWOOD LOOP	1	P-1	S-2
620 EDGEWOOD LOOP	1	P-1	S-2
624 EDGEWOOD LOOP	1	P-1	S-2
628 EDGEWOOD LOOP	1	P-1	S-2
632 EDGEWOOD LOOP	1	P-1	S-2
636 EDGEWOOD LOOP	1	P-1	S-2
640 EDGEWOOD LOOP	1	P-1	S-2
644 EDGEWOOD LOOP	1	P-1	S-2
648 EDGEWOOD LOOP	1	P-1	S-2



SHEET No.18TOTAL SHEETS21

REGISTERED PROFESSIONAL ENGINEER

David Richard

No. 33479

Exp. 06/30/26

CIVIL

STATE OF CALIFORNIA

CITY OF ANGELS
DEPARTMENT OF PUBLIC WORKS
2990 CENTENNIAL ROAD
ANGELS CAMP, CA 95222

DEWBERRY
903 W CENTER STREET
MANTECA, CA 95337

BID SET

WATER METER REPLACEMENT
SCHEDULE ROUTE 11

UNIT 0000

PROJECT NUMBER & PHASE

00000000001

USERNAME ==>caguiar

DWG FILE ==> COA–WMRP–C1.11–R11.dwg

RELATIVE BORDER SCALE
IS IN INCHES

0

1

2

3

C1.11

DATE PLOTTED ==> Nov 17, 2025

TIME PLOTTED ==> 1:04 pm

CITY OF ANGELS – DEPARTMENT OF PUBLIC WORKS	CONSULTANT PROJECT MANAGER		CALCULATED– DESIGNED BY	C. AGUIAR	REVISED BY	C. AGUIAR	
	D. RICHARD						
WATER METER REPLACEMENT PROJECT			CHECKED BY	D. RICHARD	DATE REVISED	11/17/25	



- LEGEND**
-  ROUTE 12 – 54 METERS
 - LEVEL 1 REPLACEMENT – 47
 - LEVEL 2 REPLACEMENT – 5
 - LEVEL 3 REPLACEMENT – 2

STREET ADDRESS	LEVEL	PHASE	STAGE
990 COUNTRY LN	2	P-1	S-2
988 COUNTRY LN	1	P-1	S-2
986 COUNTRY LN	1	P-1	S-2
985 COUNTRY LN - Community Building	1	P-1	S-2
984 COUNTRY LN	1	P-1	S-2
983 COUNTRY LN	1	P-1	S-2
982 COUNTRY LN	1	P-1	S-2
981 COUNTRY LN	1	P-1	S-2
980 COUNTRY LN	2	P-1	S-2
979 COUNTRY LN	1	P-1	S-2
978 COUNTRY LN	2	P-1	S-2
977 COUNTRY LN	3	P-1	S-2
976 COUNTRY LN	1	P-1	S-2
975 COUNTRY LN	1	P-1	S-2
974 COUNTRY LN	1	P-1	S-2
972 COUNTRY LN	1	P-1	S-2
970 COUNTRY LN	1	P-1	S-2
968 COUNTRY LN	1	P-1	S-2
967 COUNTRY LN	1	P-1	S-2
966 COUNTRY LN	2	P-1	S-2
965 COUNTRY LN	1	P-1	S-2
964 COUNTRY LN	3	P-1	S-2
955 COUNTRY LN	1	P-1	S-2
954 COUNTRY LN - Landscape Meter	2	P-1	S-2
954 COUNTRY LN	1	P-1	S-2
953 COUNTRY LN	1	P-1	S-2
952 COUNTRY LN	1	P-1	S-2
951 COUNTRY LN	1	P-1	S-2
950 COUNTRY LN	1	P-1	S-2
949 COUNTRY LN	1	P-1	S-2
948 COUNTRY LN	1	P-1	S-2
947 COUNTRY LN	1	P-1	S-2
946 COUNTRY LN	1	P-1	S-2
945 COUNTRY LN	1	P-1	S-2
944 COUNTRY LN	1	P-1	S-2
943 COUNTRY LN	1	P-1	S-2
942 COUNTRY LN	1	P-1	S-2
941 COUNTRY LN	1	P-1	S-2
938 COUNTRY LN	1	P-1	S-2
936 COUNTRY LN	1	P-1	S-2
934 COUNTRY LN- Landscape meter	1	P-1	S-2
934 COUNTRY LN	1	P-1	S-2
320 ELDERBERRY LN - Landscape meter	1	P-1	S-2
320 ELDERBERRY LN	1	P-1	S-2
317 ELDERBERRY LN	1	P-1	S-2
314 ELDERBERRY LN	1	P-1	S-2
308 ELDERBERRY LN	1	P-1	S-2
307 ELDERBERRY LN	1	P-1	S-2
302 ELDERBERRY LN	1	P-1	S-2
297 ELDERBERRY LN	1	P-1	S-2
292 ELDERBERRY LN	1	P-1	S-2
287 ELDERBERRY LN	1	P-1	S-2
282 ELDERBERRY LN	1	P-1	S-2
277 ELDERBERRY LN	1	P-1	S-2



SHEET No.19TOTAL SHEETS21

REGISTERED PROFESSIONAL ENGINEER

David Richard

No. 33479

Exp. 06/30/26

CIVIL


STATE OF CALIFORNIA

CITY OF ANGELS
DEPARTMENT OF PUBLIC WORKS
2990 CENTENNIAL ROAD
ANGELS CAMP, CA 95222

DEWBERRY
903 W CENTER STREET
MANTECA, CA 95337

C1.12

DATE PLOTTED => Nov 17, 2025
TIME PLOTTED => 1:05 pm

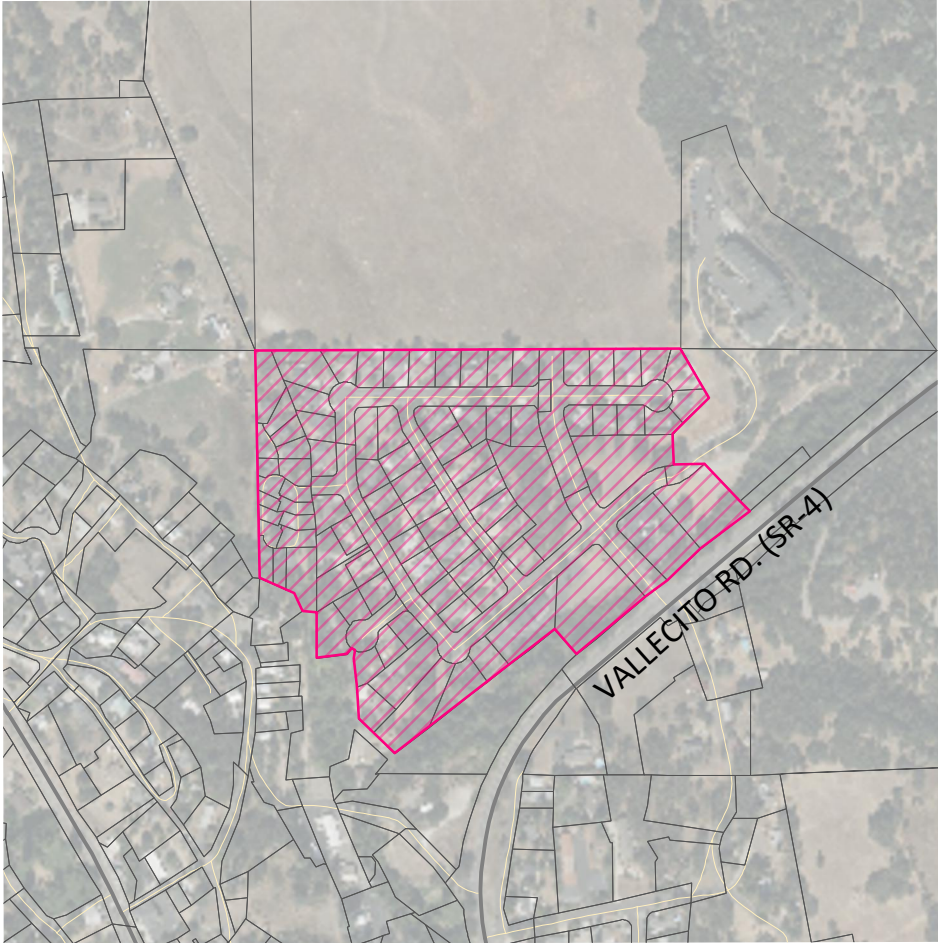

LEGEND

 ROUTE 13 – 78 METERS

LEVEL 2 REPLACEMENT – 77

LEVEL 3 REPLACEMENT – 1

STREET ADDRESS	LEVEL	PHASE	STAGE
1000 STELTE CT	2	P-1	S-2
1002 STELTE CT	2	P-1	S-2
1003 STELTE CT	2	P-1	S-2
1005 STELTE CT	2	P-1	S-2
1010 DE VEGGIO LN	2	P-1	S-2
1010 STELTE CT	2	P-1	S-2
1015 STELTE CT	2	P-1	S-2
1020 DE VEGGIO LN	2	P-1	S-2
1020 STELTE CT	2	P-1	S-2
1025 DE VEGGIO LN	2	P-1	S-2
1025 STELTE CT	2	P-1	S-2
1030 DE VEGGIO LN	2	P-1	S-2
1030 STELTE CT	2	P-1	S-2
1035 DE VEGGIO LN	2	P-1	S-2
1035 STELTE CT	2	P-1	S-2
1040 DE VEGGIO LN	2	P-1	S-2
1040 SUZANNE DR	2	P-1	S-2
1045 DE VEGGIO LN	2	P-1	S-2
1045 SUZANNE DR	2	P-1	S-2
1050 DE VEGGIO LN	2	P-1	S-2
1050 SUZANNE DR	2	P-1	S-2
1055 DE VEGGIO LN	2	P-1	S-2
1055 SUZANNE DR	2	P-1	S-2
1060 DE VEGGIO LN	2	P-1	S-2
1060 SUZANNE DR	2	P-1	S-2
1065 DE VEGGIO LN	2	P-1	S-2
1065 SUZANNE DR	2	P-1	S-2
1070 SUZANNE DR	2	P-1	S-2
1073 SUZANNE DR	2	P-1	S-2
1075 DE VEGGIO LN	2	P-1	S-2
1080 SUZANNE DR	2	P-1	S-2
1090 SUZANNE DR	2	P-1	S-2
1100 SUZANNE DR	2	P-1	S-2
1110 SUZANNE DR	2	P-1	S-2
1115 ANNALEE CT	2	P-1	S-2
1120 SUZANNE DR	2	P-1	S-2
1125 ANNALEE CT	2	P-1	S-2
1130 SUZANNE DR	2	P-1	S-2
1135 ANNALEE CT	2	P-1	S-2
1140 ANNALEE CT	2	P-1	S-2
1140 SUZANNE DR	2	P-1	S-2
1145 ANNALEE CT	2	P-1	S-2
1150 ANNALEE CT	2	P-1	S-2
1150 SUZANNE DR	2	P-1	S-2
1155 ANNALEE CT	2	P-1	S-2
1165 SUZANNE DR	2	P-1	S-2
1170 SUZANNE DR	2	P-1	S-2
1175 SUZANNE DR	2	P-1	S-2
1180 SUZANNE DR	2	P-1	S-2
1182 SUZANNE DR	2	P-1	S-2
1186 SUZANNE DR	2	P-1	S-2
1190 SUZANNE DR	2	P-1	S-2
1195 SUZANNE DR	2	P-1	S-2
1200 SUZANNE DR	2	P-1	S-2
1205 ANNALEE DR	2	P-1	S-2
1205 SUZANNE DR	2	P-1	S-2
1215 ANNALEE DR	2	P-1	S-2
1225 ANNALEE DR	2	P-1	S-2
1225 SUZANNE CT	2	P-1	S-2
1230 SUZANNE CT	2	P-1	S-2
1232 SUZANNE CT	2	P-1	S-2
1235 ANNALEE DR	2	P-1	S-2
1235 SUZANNE DR	2	P-1	S-2
1236 ANNALEE DR	2	P-1	S-2
1236 SUZANNE DR	2	P-1	S-2
1240 ANNALEE DR	2	P-1	S-2
1240 SUZANNE DR	2	P-1	S-2
1244 ANNALEE DR	2	P-1	S-2
1245 ANNALEE DR	2	P-1	S-2

STREET ADDRESS	LEVEL	PHASE	STAGE
1245 SUZANNE DR	2	P-1	S-2
1246 SUZANNE DR	2	P-1	S-2
1250 SUZANNE DR	2	P-1	S-2
1255 ANNALEE DR	2	P-1	S-2
1265 ANNALEE DR	2	P-1	S-2
1265 SUZANNE DR	2	P-1	S-2
1270 SUZANNE DR	2	P-1	S-2
1275 ANNALEE DR	2	P-1	S-2
1300 KURT DR	3	P-1	S-2



SHEET No.20TOTAL SHEETS21

REGISTERED PROFESSIONAL ENGINEER

David Richard

No. 33479


Exp. 06/30/26

CIVIL

STATE OF CALIFORNIA

CITY OF ANGELS
DEPARTMENT OF PUBLIC WORKS
2990 CENTENNIAL ROAD
ANGELS CAMP, CA 95222

DEWBERRY
903 W CENTER STREET
MANTECA, CA 95337

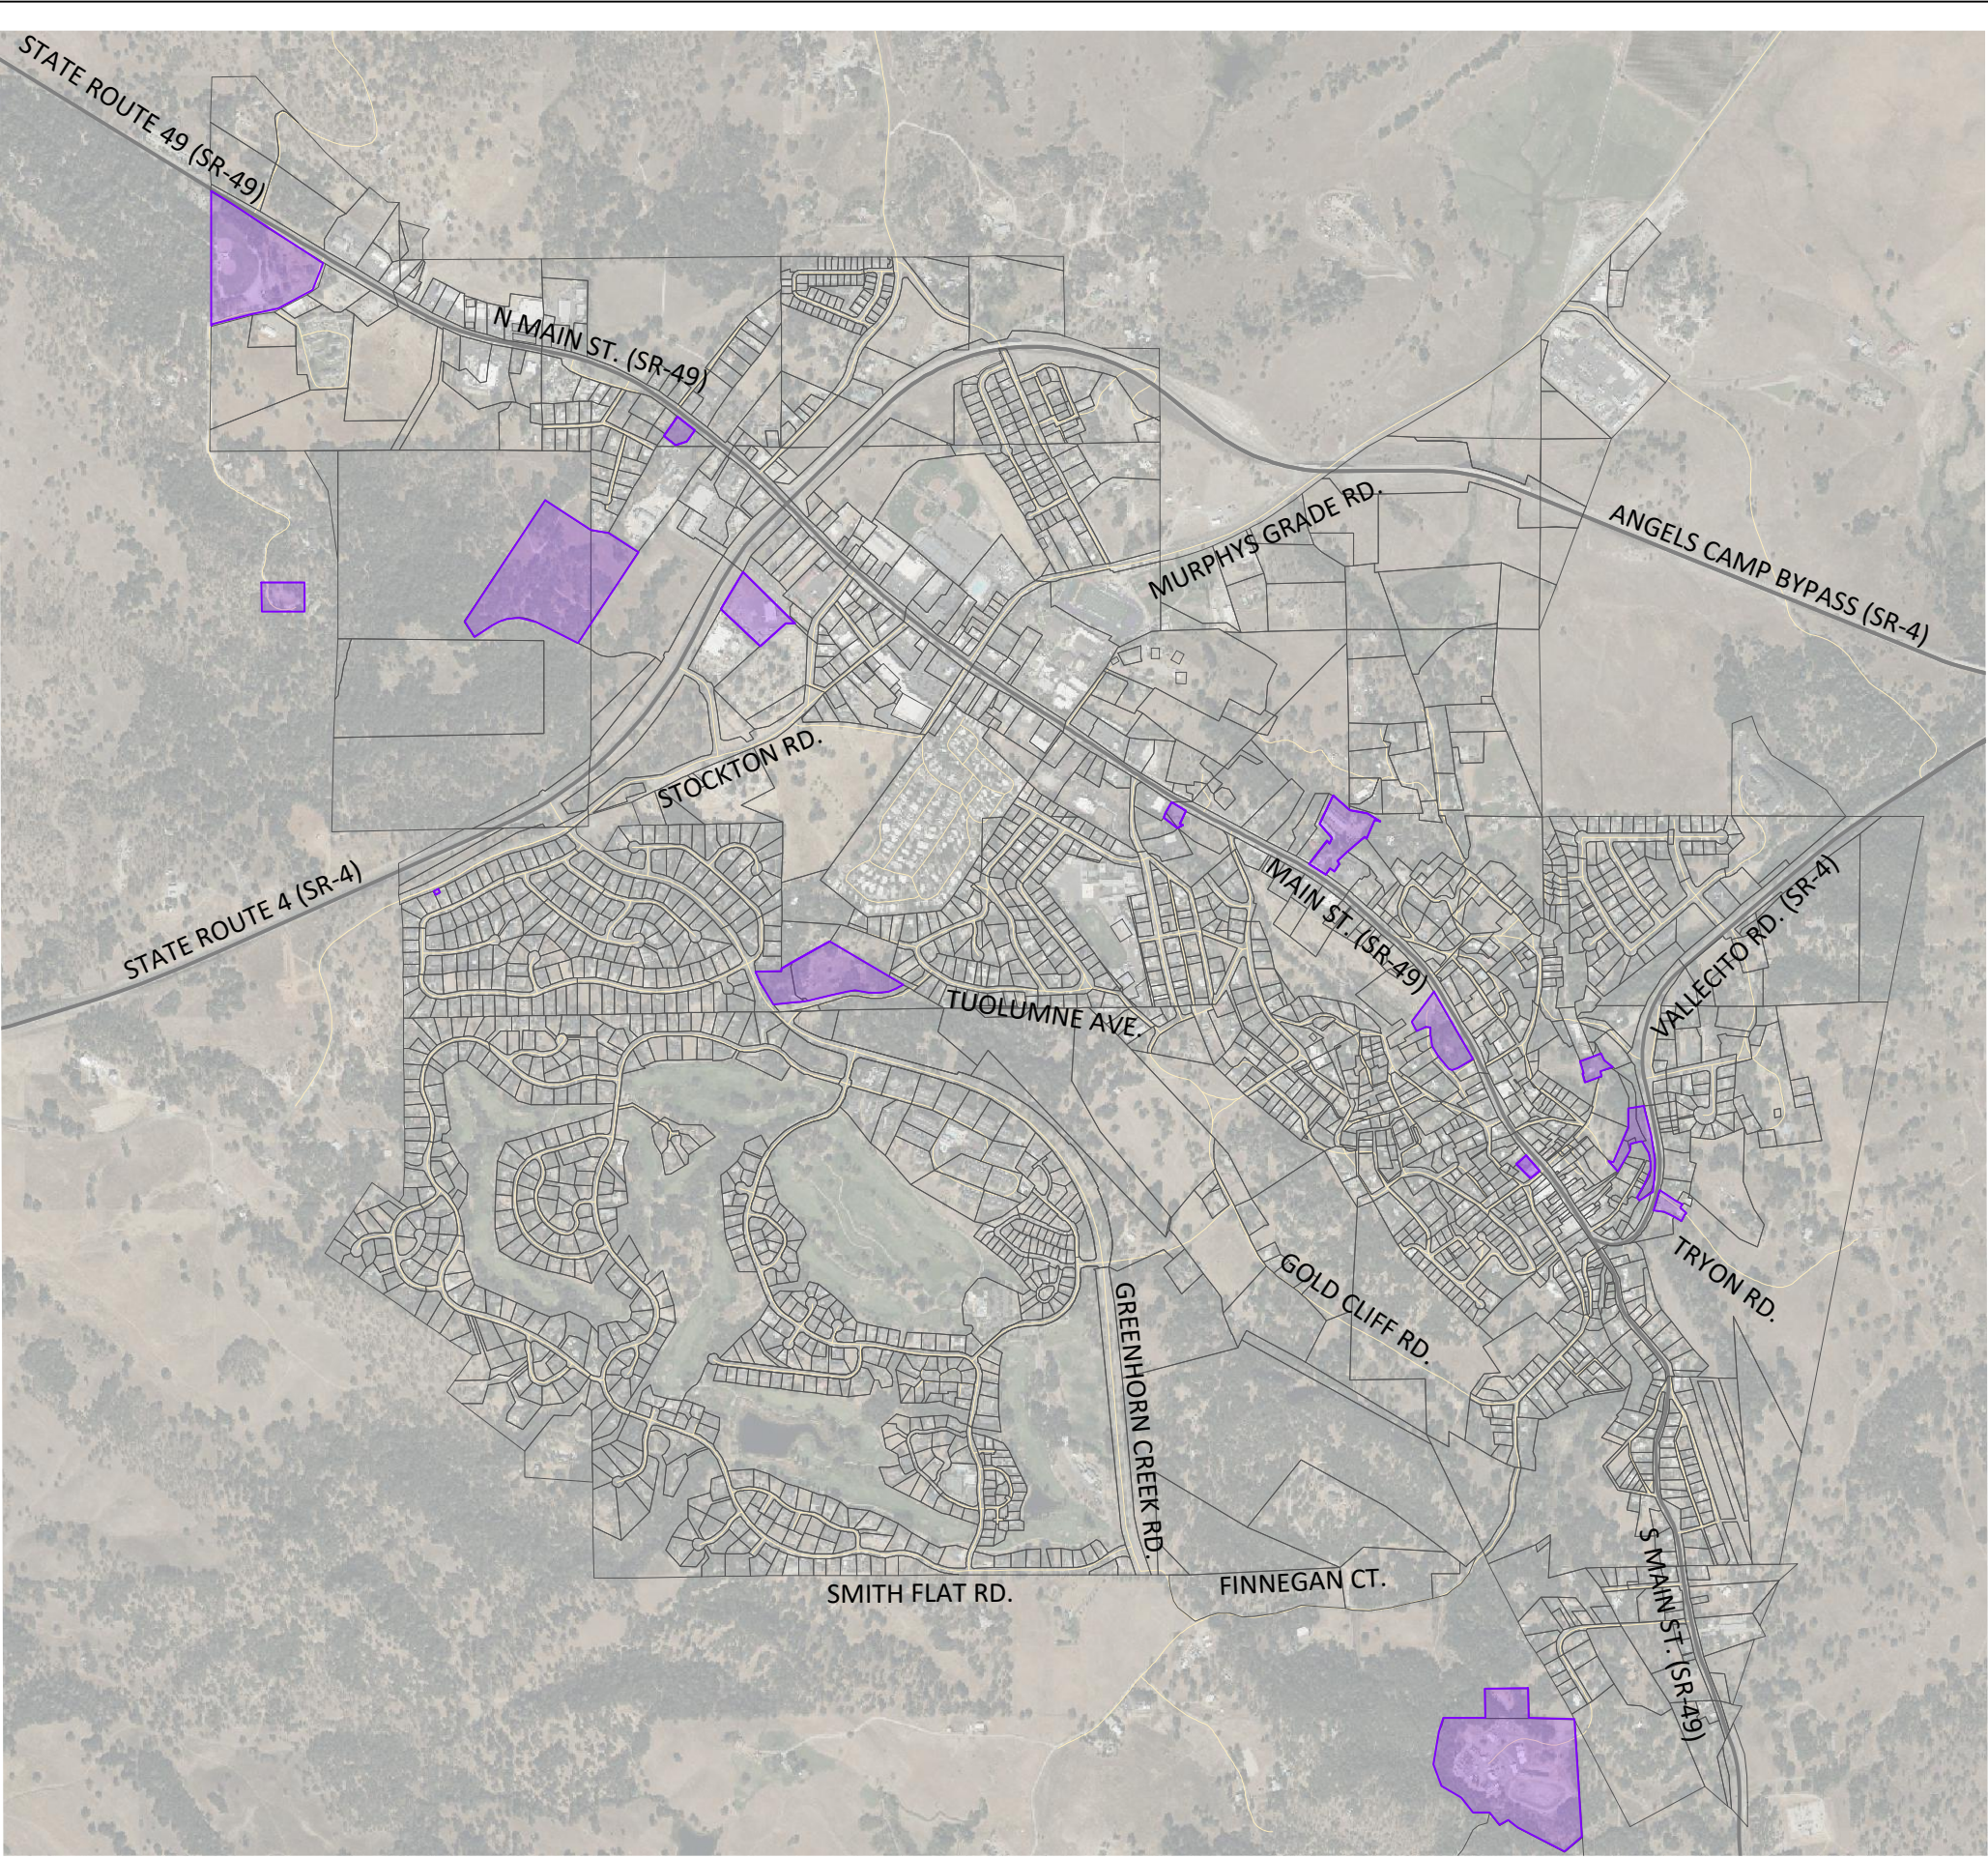

SHEET No.21

TOTAL SHEETS21

REGISTERED PROFESSIONAL ENGINEER

David Richard

No. 33479

Exp. 06/30/26

CIVIL

STATE OF CALIFORNIA

CITY OF ANGELS
DEPARTMENT OF PUBLIC WORKS
2990 CENTENNIAL ROAD
ANGELS CAMP, CA 95222

DEWBERRY
903 W CENTER STREET
MANTECA, CA 95337

- LEGEND
- ROUTE 99 – 23 METERS
- LEVEL 1 REPLACEMENT – 21
- LEVEL 2 REPLACEMENT – 1
- LEVEL 3 REPLACEMENT – 1

STREET ADDRESS	LEVEL	PHASE	STAGE
1075 UTICA LN - Irrigation	1	P-1	S-2
1075 UTICA LN - Restrooms	1	P-1	S-2
1192 S MAIN ST	1	P-1	S-2
1219 RASPBERRY LN - Vets Hall	2	P-1	S-2
1300 BOOSTER WAY - Tryon Park	3	P-1	S-2
135 N MAIN ST - Altaville School	1	P-1	S-2
1358 COPELLO DR- Pump Station	1	P-1	S-2
1404 VALLECITO RD - Firehouse	1	P-1	S-2
200 MONTE VERDA ST - Community Dev.	1	P-1	S-2
200 MONTE VERDA ST - Police Dept.	1	P-1	S-2
2990 CENTENNIAL RD - Corp yard	1	P-1	S-2
3000 CENTENNIAL RD - WW plant	1	P-1	S-2
584 S MAIN ST - City Hall	1	P-1	S-2
700 COPELLO DR - PARK WATER	1	P-1	S-2
753 S MAIN ST - Museum #1	1	P-1	S-2
753 S MAIN ST - Museum #2	1	P-1	S-2
ALTAVILLE LIFT	1	P-1	S-2
GATEWAY PARK - Sierra Ave	1	P-1	S-2
LOT 1 LIVE OAK DR - Lift Station	1	P-1	S-2
PW HYDRANT FLUSHING METER - 2	1	P-1	S-2
PW HYDRANT FLUSHING METER -1	1	P-1	S-2
RAGGIO CT - Lift Station	1	P-1	S-2
RIGHT OF PARK - Gateway Park	1	P-1	S-2