

C:\Beacon\DWG\REF\GIS Base Cash.dwg Layout11 Sep 08, 2020 - 3:30:20pm jmlt@ac



SITE AREA: 29.2 AC.
 NEW R/W: 1.2 AC.
 NET AREA: 28.0 AC.
 RCA REQ. 5.6 AC.

BURMA DRIVE

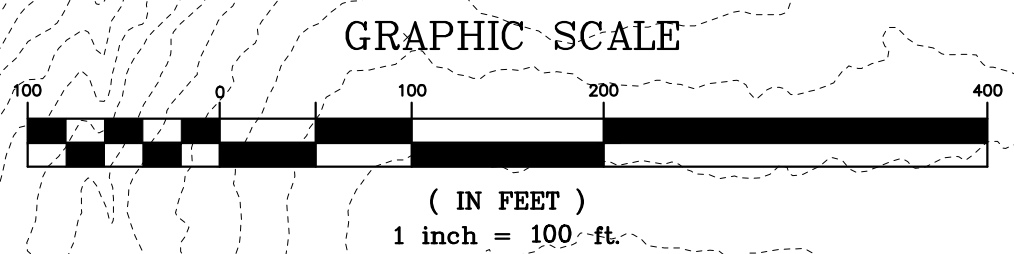
0.3 Acres RCA

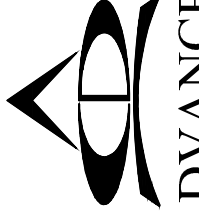

5.3 Acres RCA

STORMWATER BMP

PRISTINE WATER DR.

PRISTINE WATER DR.



PLAN PREPARED BY:  ADVANCED CIVIL DESIGN ENGINEERS SURVEYORS 422 Beecher Road Gahanna, Ohio 43230 ph 614.428.7750 fax 614.428.7755	PLAN PREPARED FOR:  BEACON PARTNERS 500 East Morehead St. Suite 200 Charlotte, North Carolina 28269 tel. 704.592.7727 fax 704.598.6335
	TOWN OF APEX, WAKE COUNTY, NORTH CAROLINA CASH CORPORATE CENTER FOR SITE PLAN FOR BEACON PARTNERS CONCEPT PLAN
Issue Dates:	Date: 09/08/2020 Scale: 1" = 100'
Drawn By: JLB	Checked By: JDW
Project Number: 20-0000-00	Drawing Number: 1 / 1