


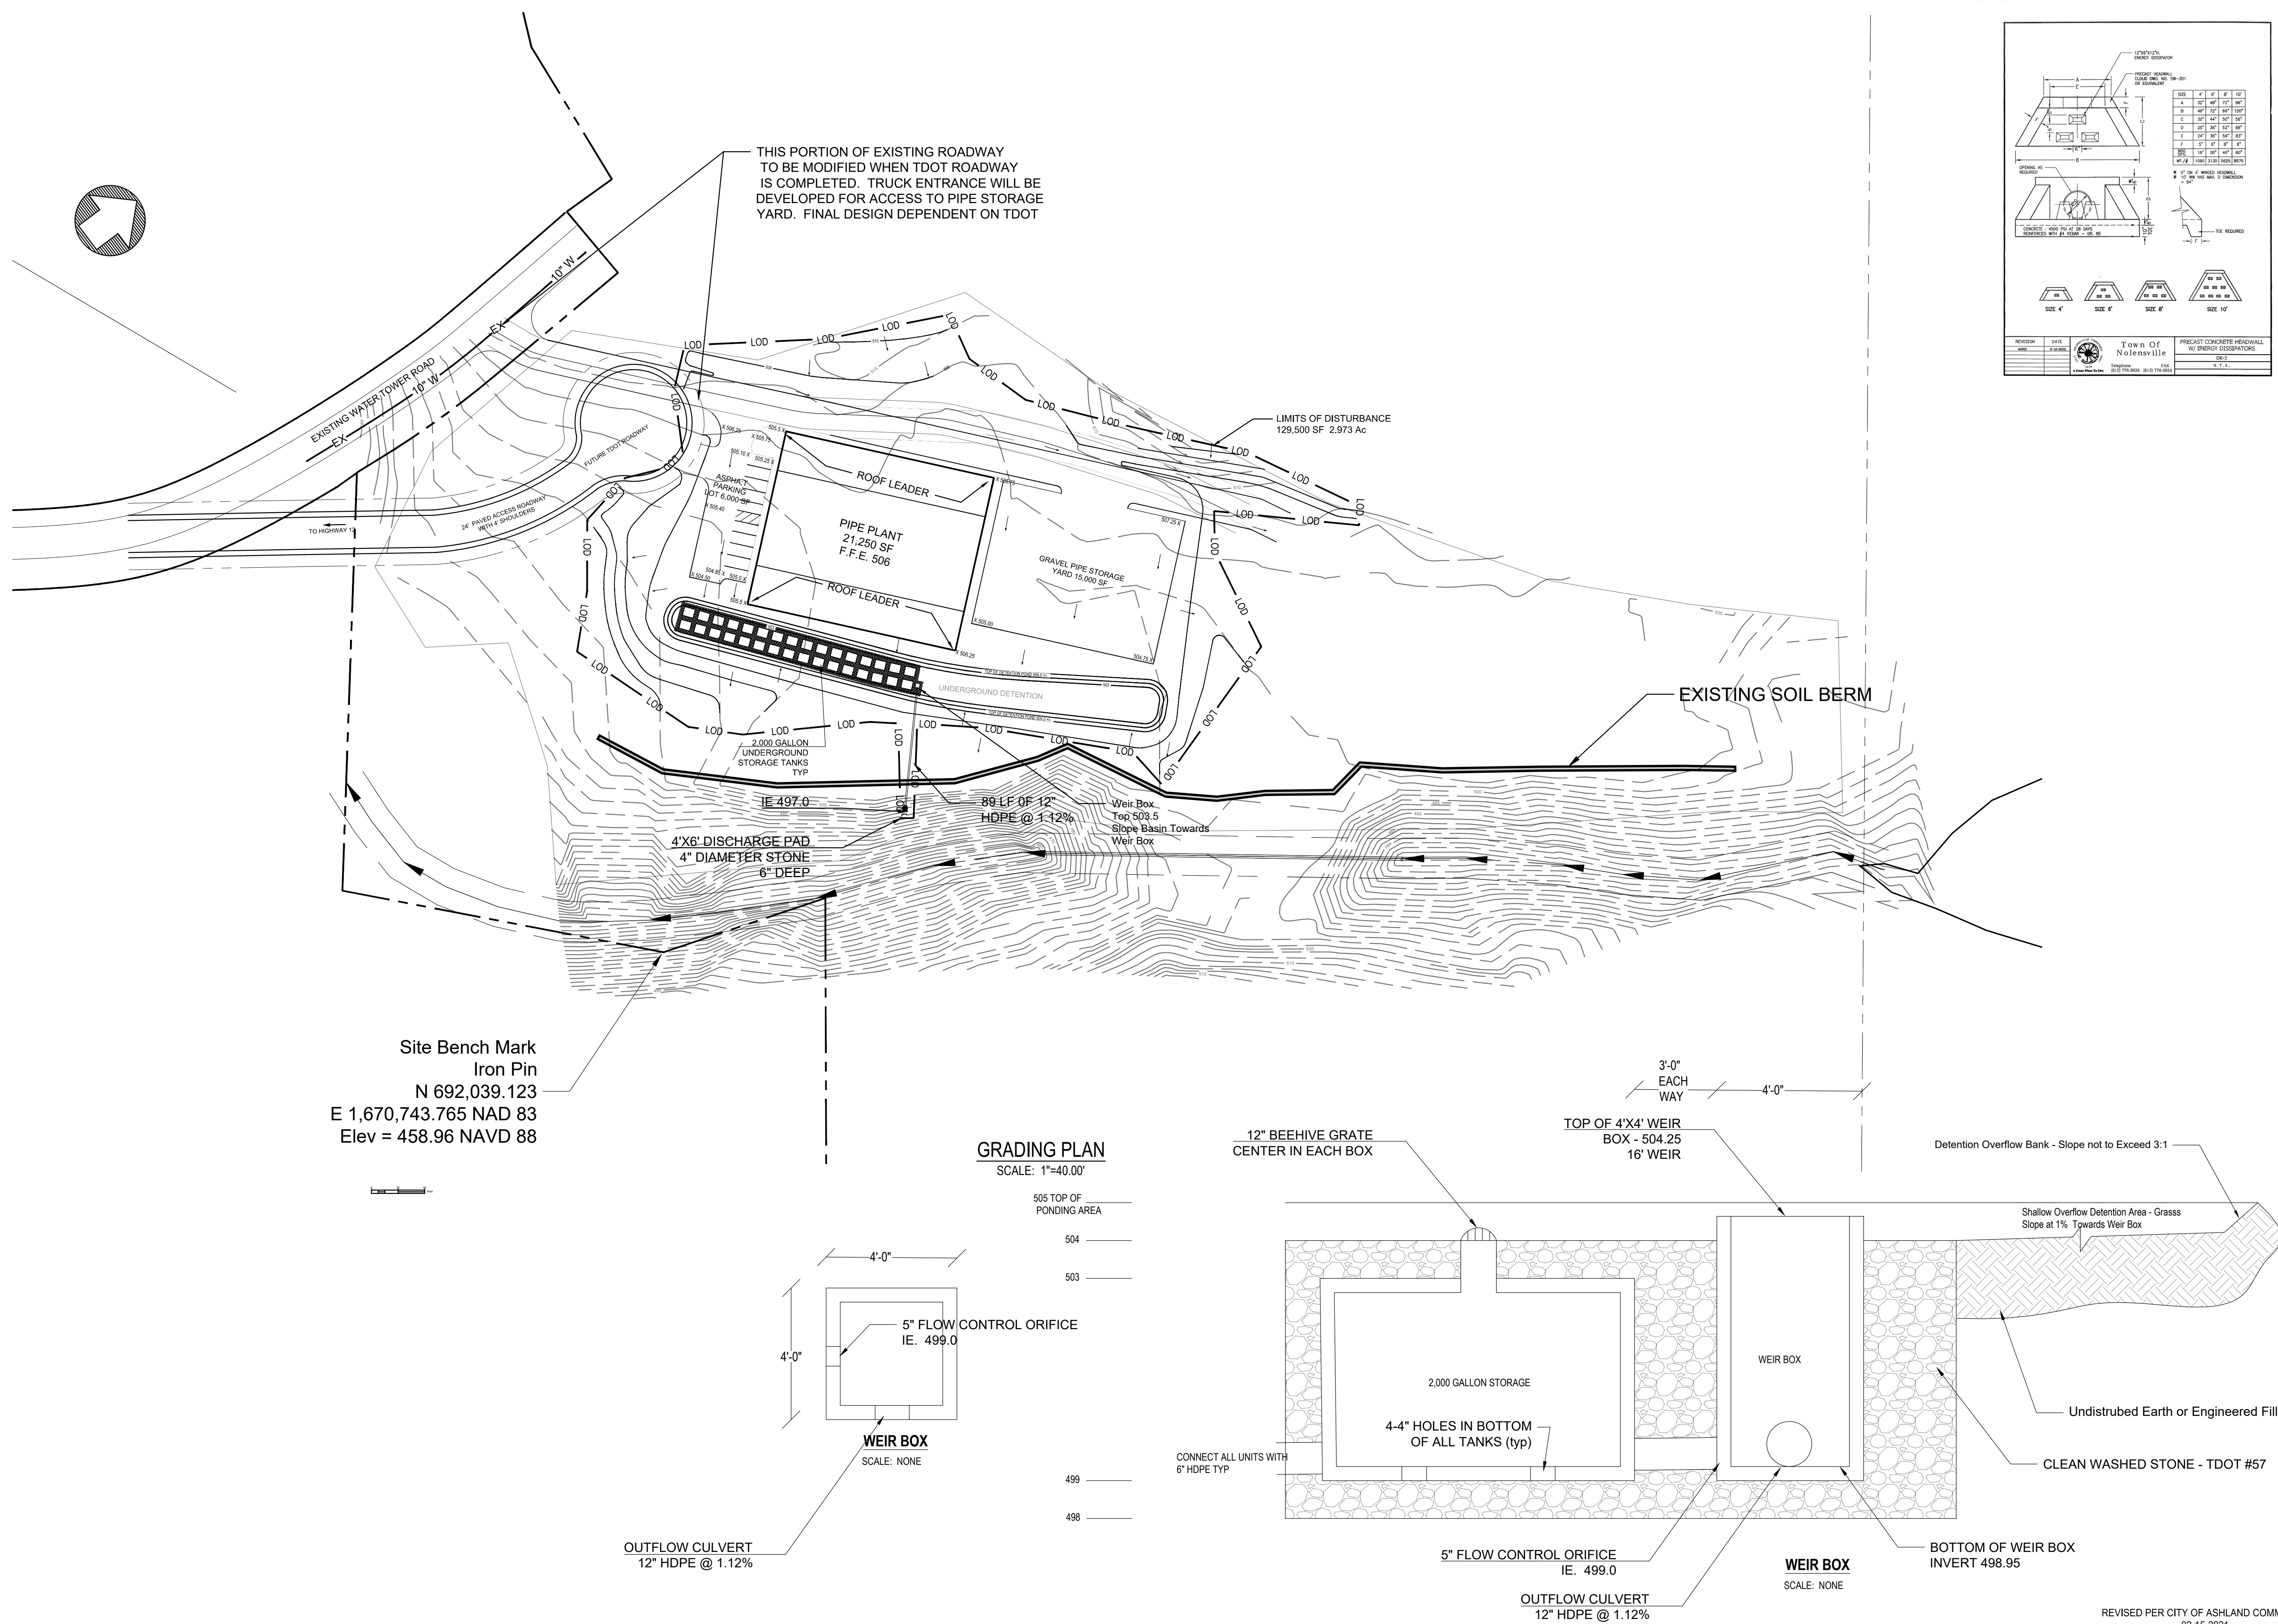

SANDHU CONSULTANTS INTERNATIONAL ENGINEERING AND SCIENCE 1709 ASHWOOD AVENUE, NASHVILLE, TN 37212 TEL. 615-292-0759 FAX 615-292-2973			
GRADING PLAN		JOB NUMBER SCL 20201212	
JARRETT CONCRETE PRODUCTS CONCRETE PIPE PLANT HIGHWAY 12, ASHLAND CITY, TN		SHEET NUMBER C2.2	
DATE:	NO.	DATE	PERIODIC
12-15-2020		12-15-2020	
ISSUE	AS SHOWN	04-15-2021	PERIODIC SUBMITTAL TO ASHLAND CITY
DESIGNED BY	DRAWN BY		REVISED PER CITY OF ASHLAND CITY COMMENTS
DRS			