
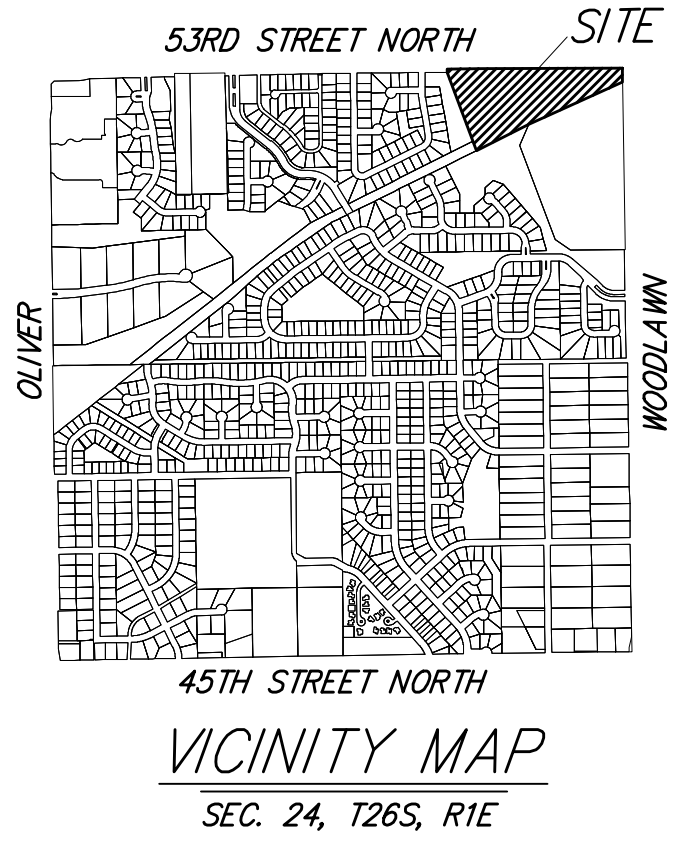
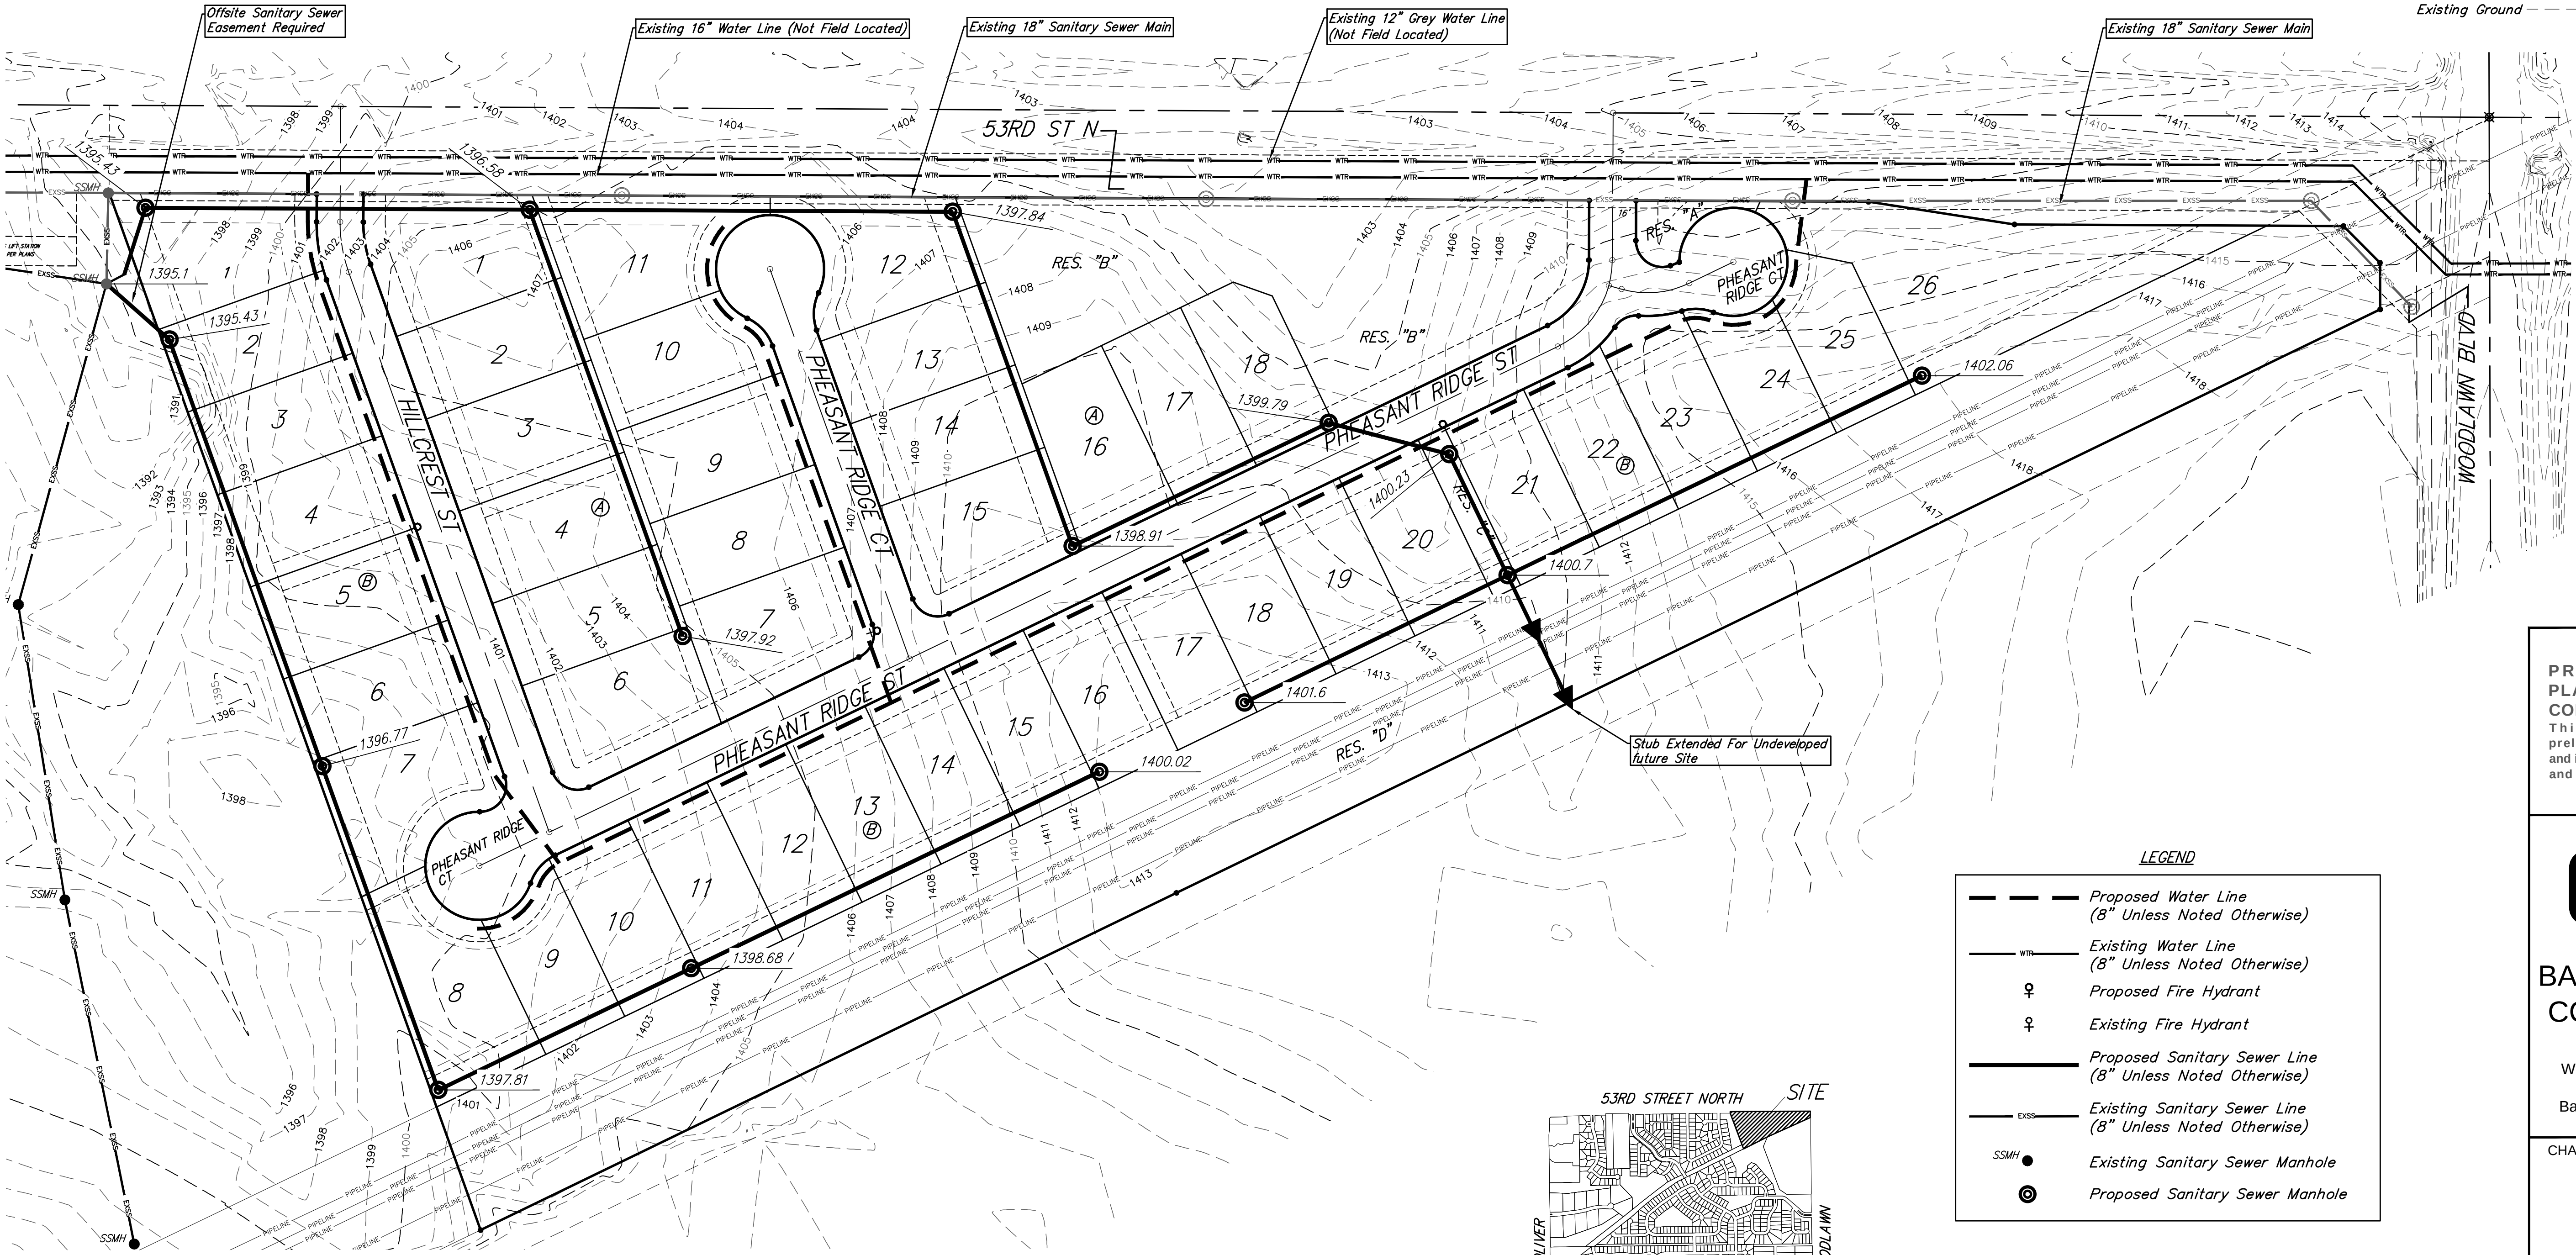


CHAPEL LANDING 7TH ADDITION
BEL AIRE, SEDGWICK COUNTY, KANSAS

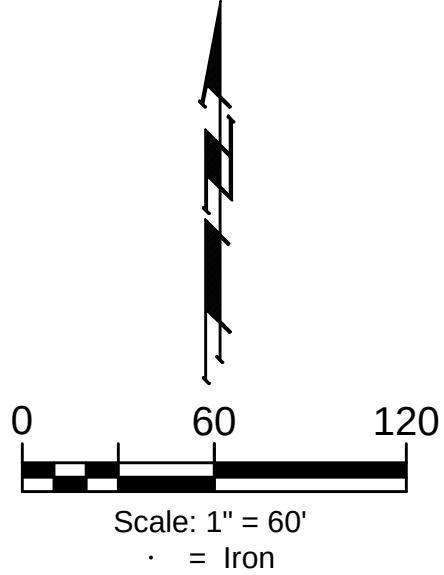

LEGEND

	Proposed Water Line (8" Unless Noted Otherwise)
	Existing Water Line (8" Unless Noted Otherwise)
	Proposed Fire Hydrant
	Existing Fire Hydrant
	Proposed Sanitary Sewer Line (8" Unless Noted Otherwise)
	Existing Sanitary Sewer Line (8" Unless Noted Otherwise)
	Existing Sanitary Sewer Manhole
	Proposed Sanitary Sewer Manhole

**PRELIMINARY
PLAN. NOT FOR
CONSTRUCTION.**
This document is
preliminary in nature
and is not a final, signed
and sealed document.

**BAUGHMAN
COMPANY**

315 Ellis St.
Wichita, KS 67211
316-262-7271
BaughmanCo.com

CHAPEL LANDING 7TH
ADDITION

**UTILITY
PLAN**

PROJECT NUMBER:

DESIGN: AEG DRAWN: LEN
DATE: October 12, 2023

SHEET 01 OF 01

File: E:\Projects\Chapel Landing 7th Addition (20-12-P610)\Engineering\Utility Plan\Chapel Landing 7th F_U_P-Revise.dwg