


CIVIL SITE GENERAL NOTES

1. DOWNSPOUTS FOR DRAINING THE NEW ROOF ADDITION ARE SHOWN. THE DOWNSPOUTS WILL DRAIN USING SPLASH BLOCKS AND ARE TO BE INSTALLED IN ACCORDANCE WITH THE ARCHITECT'S SPECIFICATIONS. SEE THE ARCHITECT PLANS FOR MORE DETAIL ON THE GUTTER SYSTEM.
2. GRADE THE GROUND OUTSIDE THE NEW ADDITION TO FOLLOW THE EXISTING GRADES AWAY FROM THE FOUNDATION.
3. SEE THE ARCHITECT PLANS FOR CONSTRUCTION DETAILS OF STEPS, HANDRAIL, USED ON THE STEPS AND RAMP.
4. SEE THE ARCHITECT PLANS FOR CONSTRUCTION DETAILS ON HANDRAIL USED ON THE STEPS AND RAMP.
5. LANDSCAPE PER ARCHITECT AND OWNER.

SYMBOL LEGEND

⊕	POWER POLE W/ U/G CONNECTION
⊕	POWER/TELECOM POLE
⊕	ANCHOR POLE
⊕	ELECTRIC TRANSFORMER
⊕	ELECTRIC METER
⊕	FLAG POLE
⊕	GAS METER
▶	GAS LINE MARKER
▲	FLOOD LAMP
☆	LIGHT POLE
☐	MAIL BOX
☐	AIR COND UNIT
☐	SANITARY MANHOLE
☐	CATCH BASIN
☐	STORM MANHOLE
☐	CURB INLET
☐	TELECOM SPLICE BOX
☐	FIRE HYDRANT
☐	WATER METER
☐	1/2" IRON PIPE FOUND
☐	5/8" IRON PIN FOUND
○ DS	DOWNSPOUT
—	POLE ANCHOR CABLE
—	U/G ELECTRIC LINE
—	GAS LINE
—	SANITARY SEWER LINE
—	TELECOM LINE
—	WATER LINE

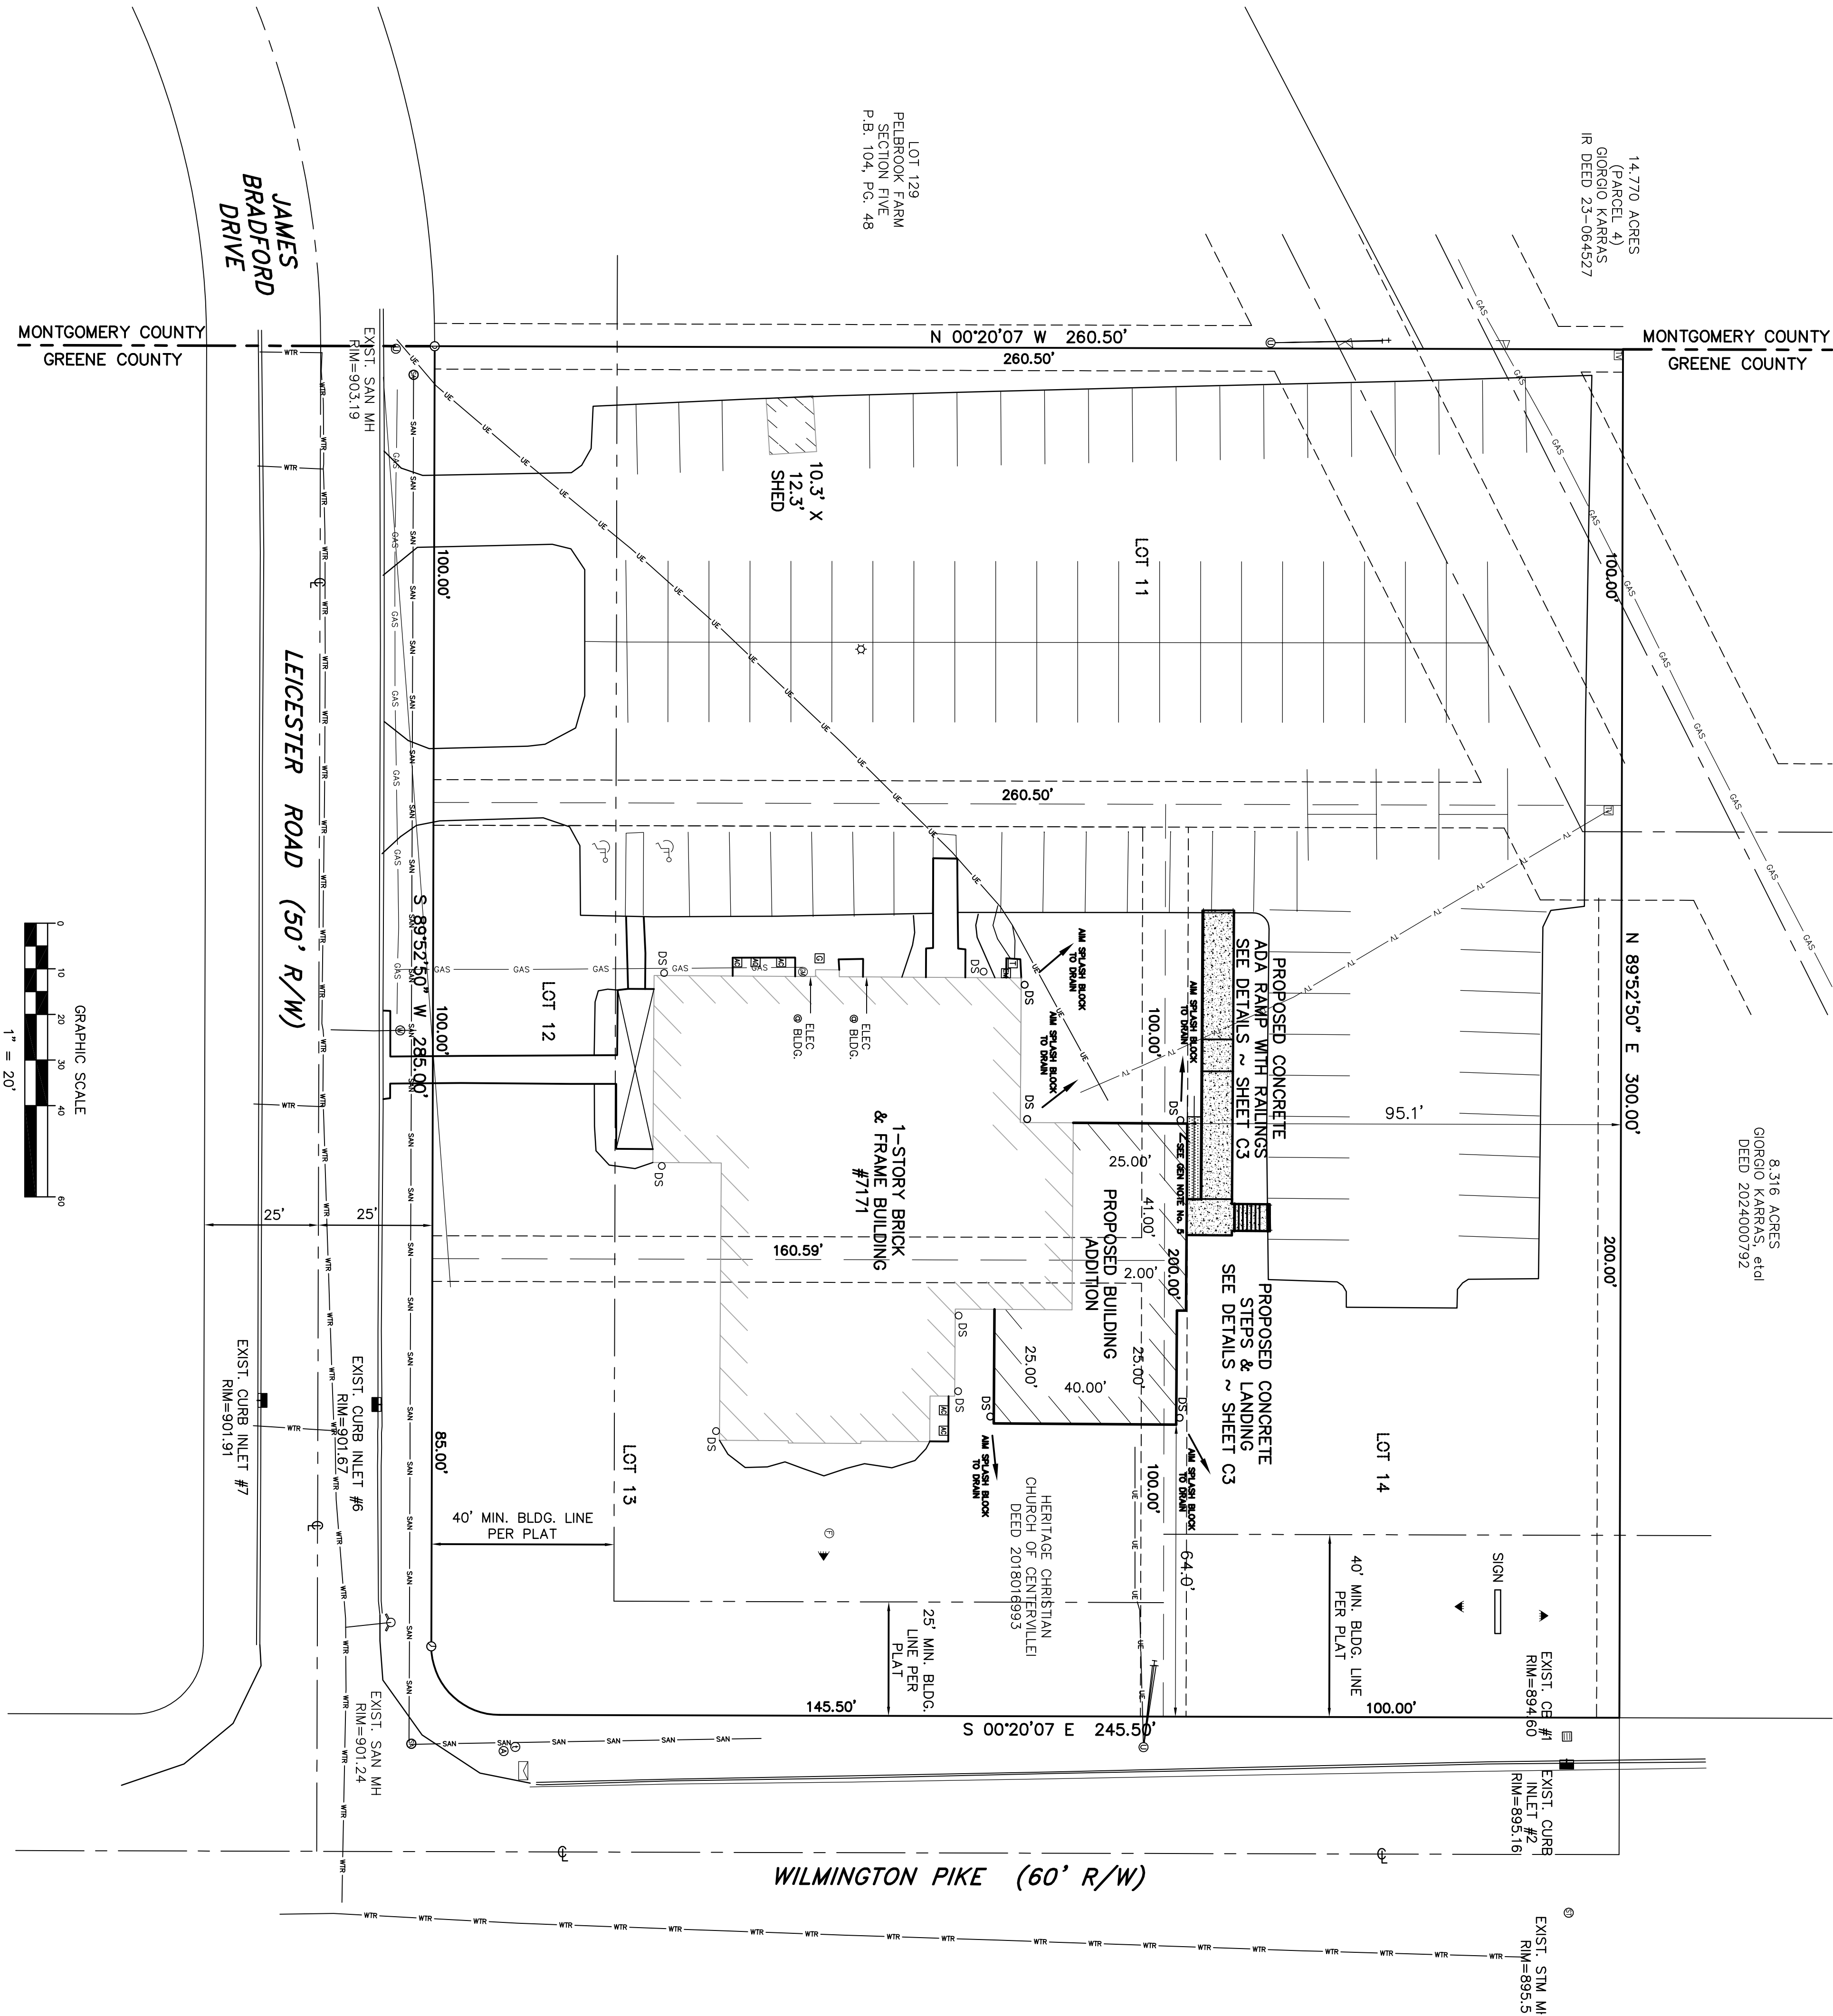

By: *Thomas E. Dusa* Reg. Engineer E-49719


No.	DATE	REVISION

PROJECT No:	E3447
DATE	02-11-25
SCALE	1" = 20'
DES.	TED
DR.	JRC
CKD.	TED

Haley-Dusa
Engineering & Surveying Group, LLC
270 Regency Ridge Drive, Suite 203
Dayton, OH 45424
Phone: (937) 439-4300 Fax: (937) 439-2005

HERITAGE CHRISTIAN CHURCH
BUILDING ADDITION
7171 WILMINGTON PIKE
CITY OF BELLBROOK
GREENE COUNTY, OHIO

CIVIL SITE PLAN

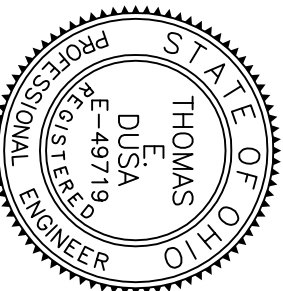

SHEET NO.

C2