











 

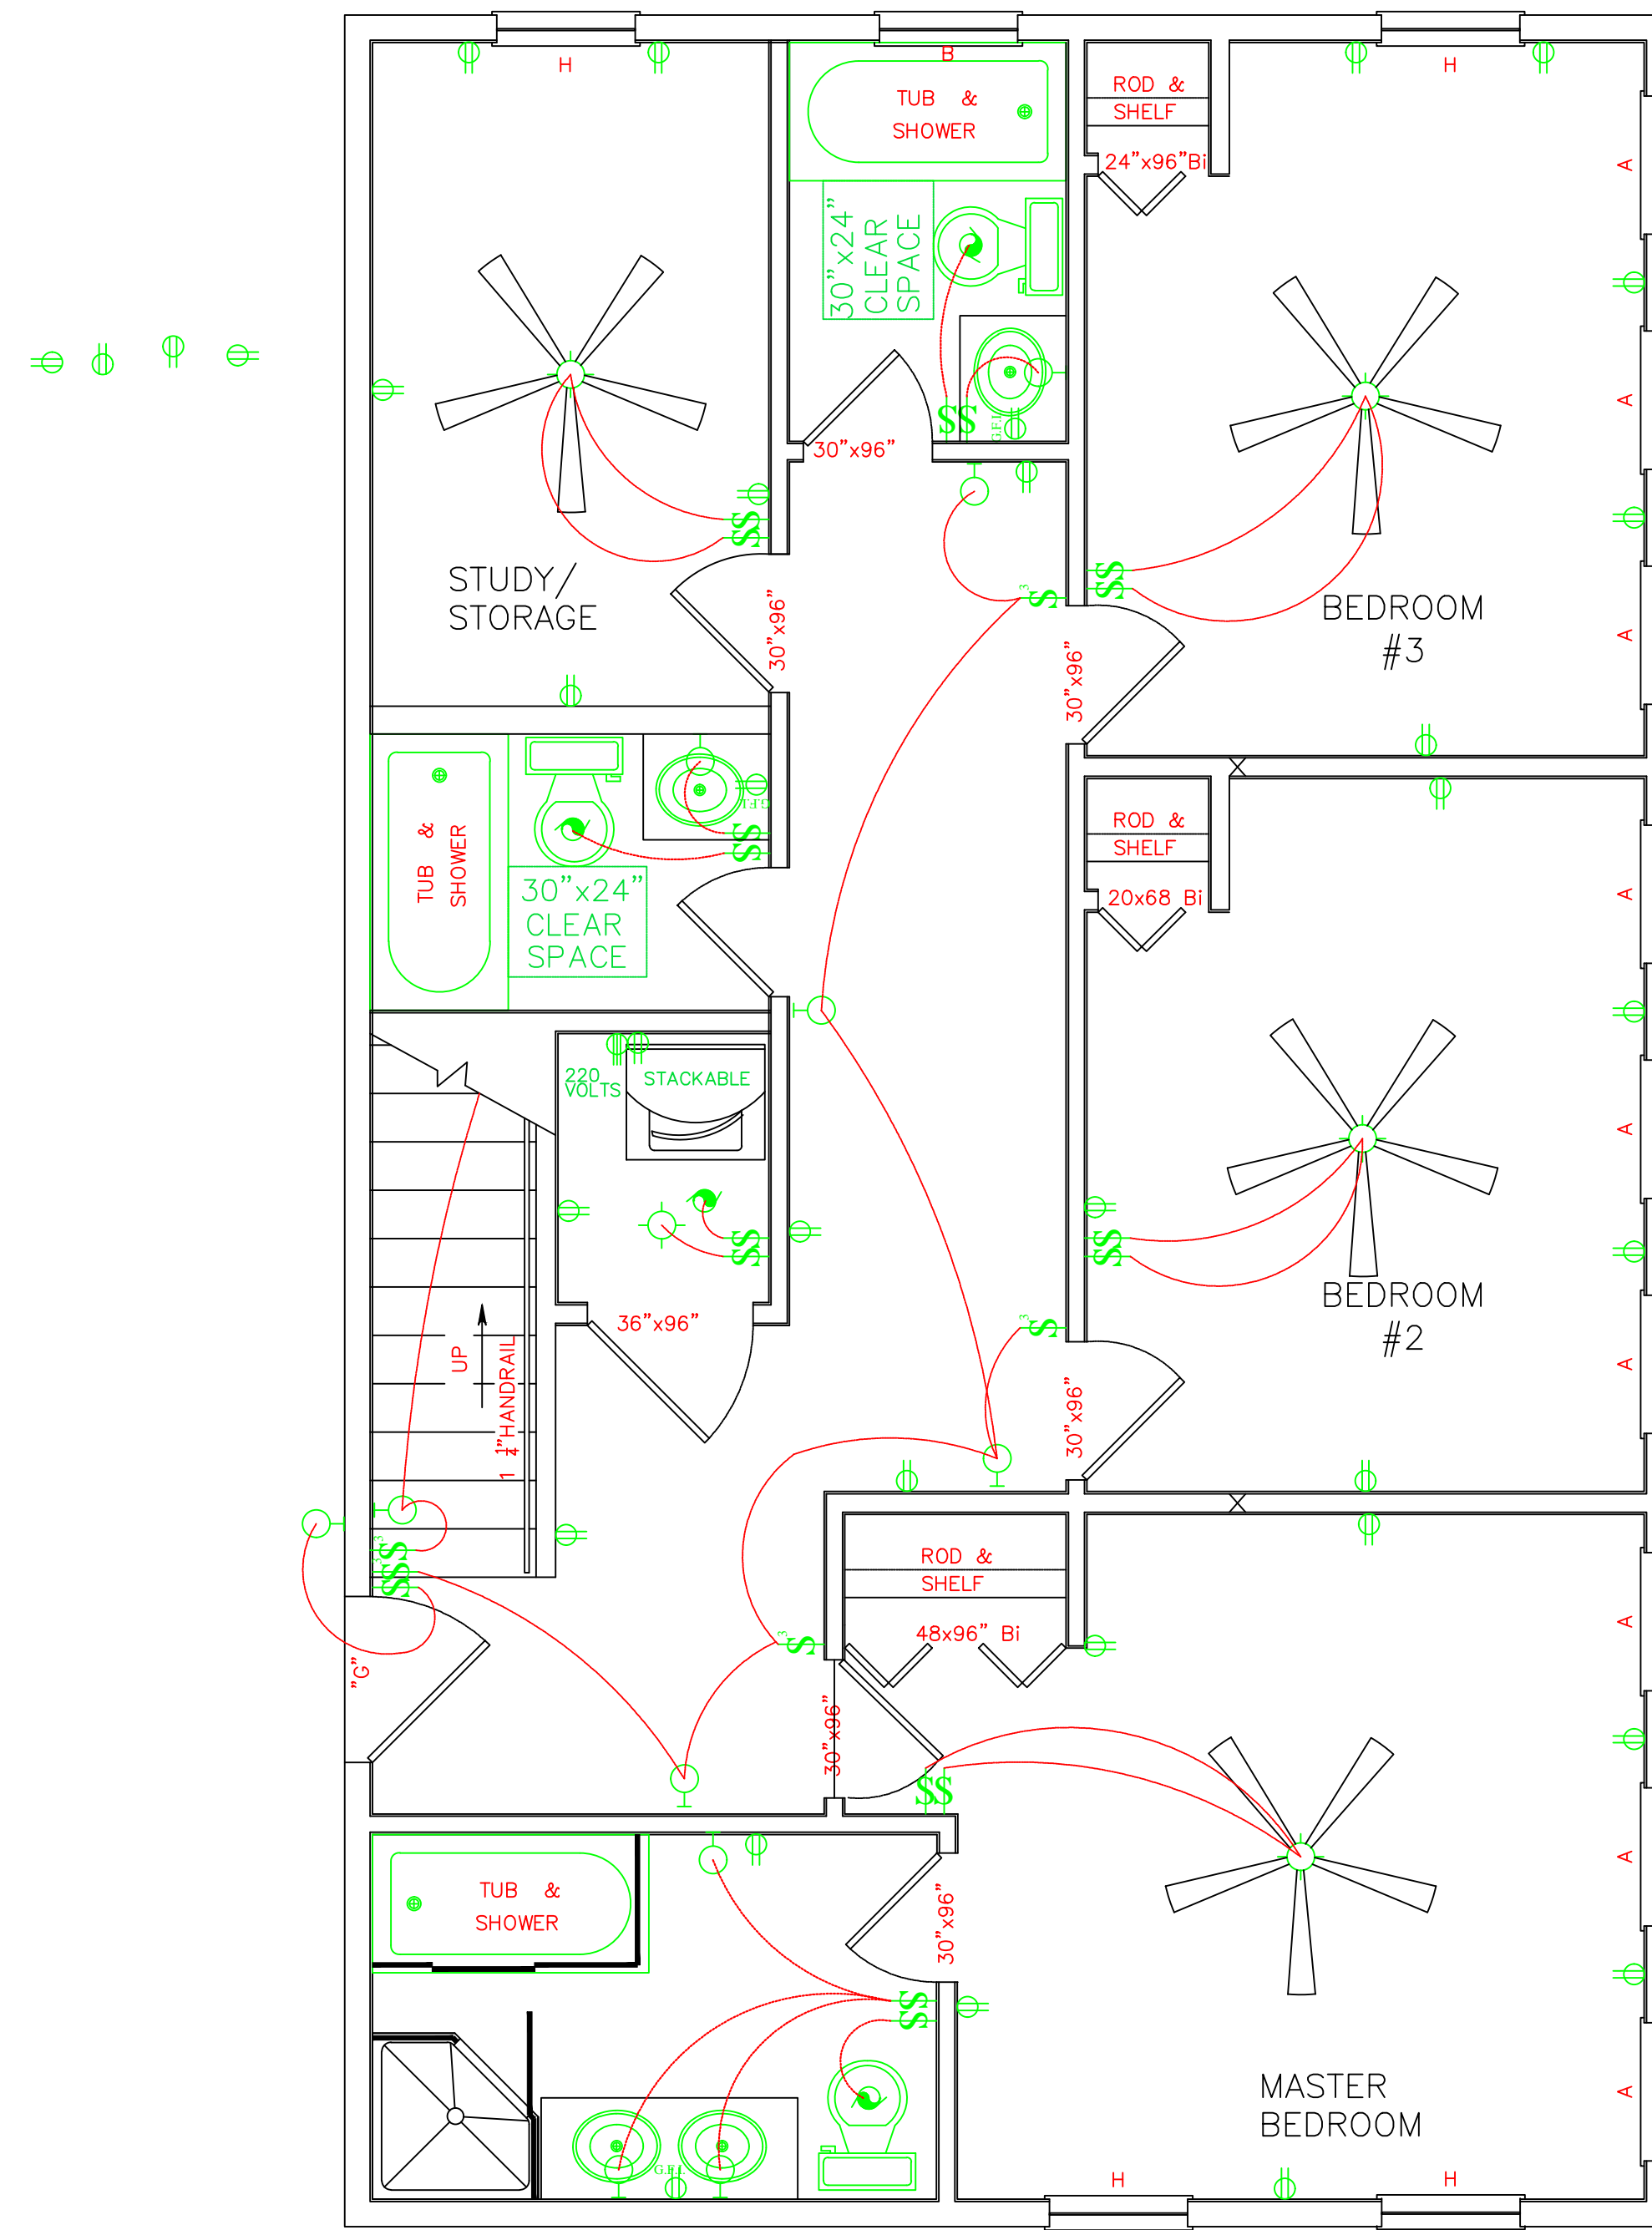


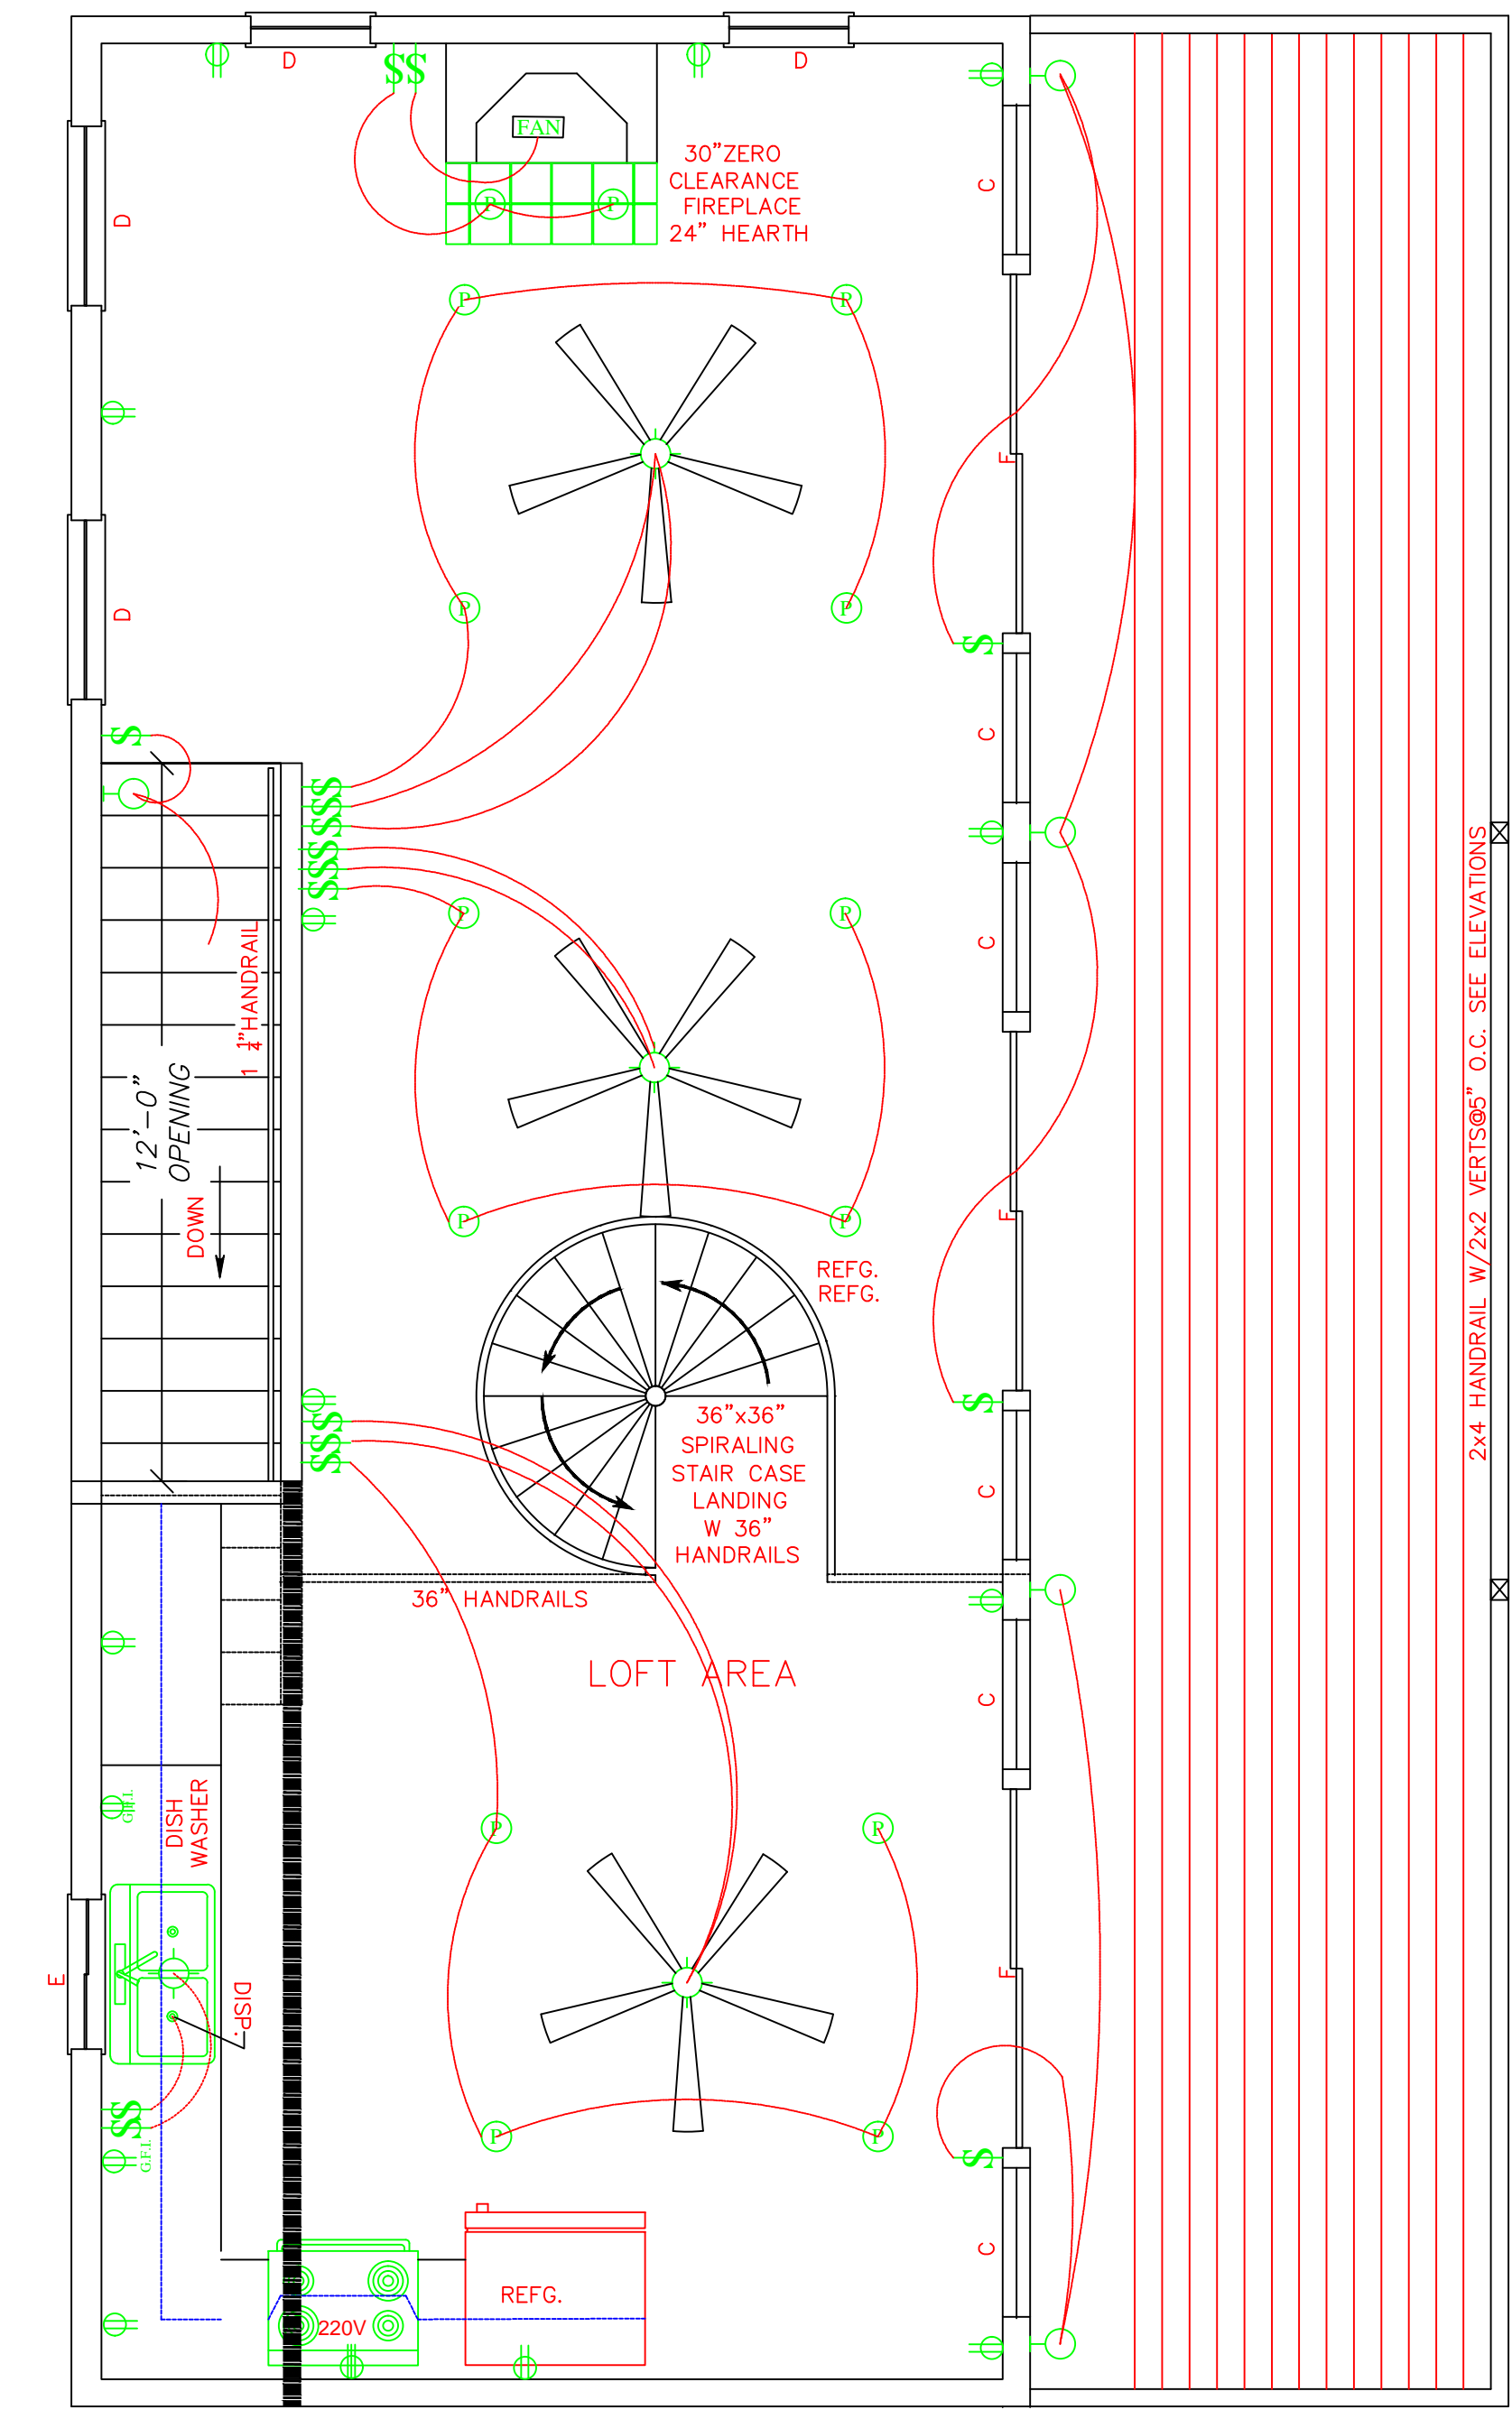
ELECTRICAL SYMBOL LEGEND

-  SMOKE DETECTOR
ALL INTER-CONNECTED WITH BASEMENT
INCLUDING BATTERY BACK-UP
-  DUPLEX OUTLET
-  DUPLEX OUTLET, HALF SWITCHED
-  DUPLEX OUTLET, GROUND FAULT INTERRUPT
-  DUPLEX OUTLET, WEATHER PROOF
-  THREE SPEED FAN SWITCH
-  SINGLE POLE SWITCH
-  THREE WAY POLE SWITCH
-  FOUR WAY POLE SWITCH
-  SURFACE MOUNTED LIGHT
-  PENDANT LIGHT
-  RECESSED LIGHT
-  WALL MOUNTED LIGHT
-  EXHAUST FAN



LOWER LEVEL
FLOOR PLAN
SCALE - 1/4"=1'-0"

THIS DRAWING IS NOT FOR CONSTRUCTION
FOR APPROVAL PURPOSES ONLY



UPPER LEVEL
FLOOR PLAN
SCALE - 1/4"=1'-0"
WITH SPIRAL STAIRCASE
& LOFT LOCATION
SEE SHEET A-5

THIS DRAWING IS NOT FOR CONSTRUCTION
FOR APPROVAL PURPOSES ONLY