


FOUNDATION PLAN SCALE OF 1/4" = 1'-0"

THE KELLY RESIDENCE
11 BRIDGE STREET
BLUFFTON, SOUTH CAROLINA

MANUEL STUDIO, LLC
ANSLEY HESTER MANUEL, ARCHITECT
843.338.8932

28 SEPT 2023
PRICING SET
8 NOVEMBER 2023
FINAL PLANNING

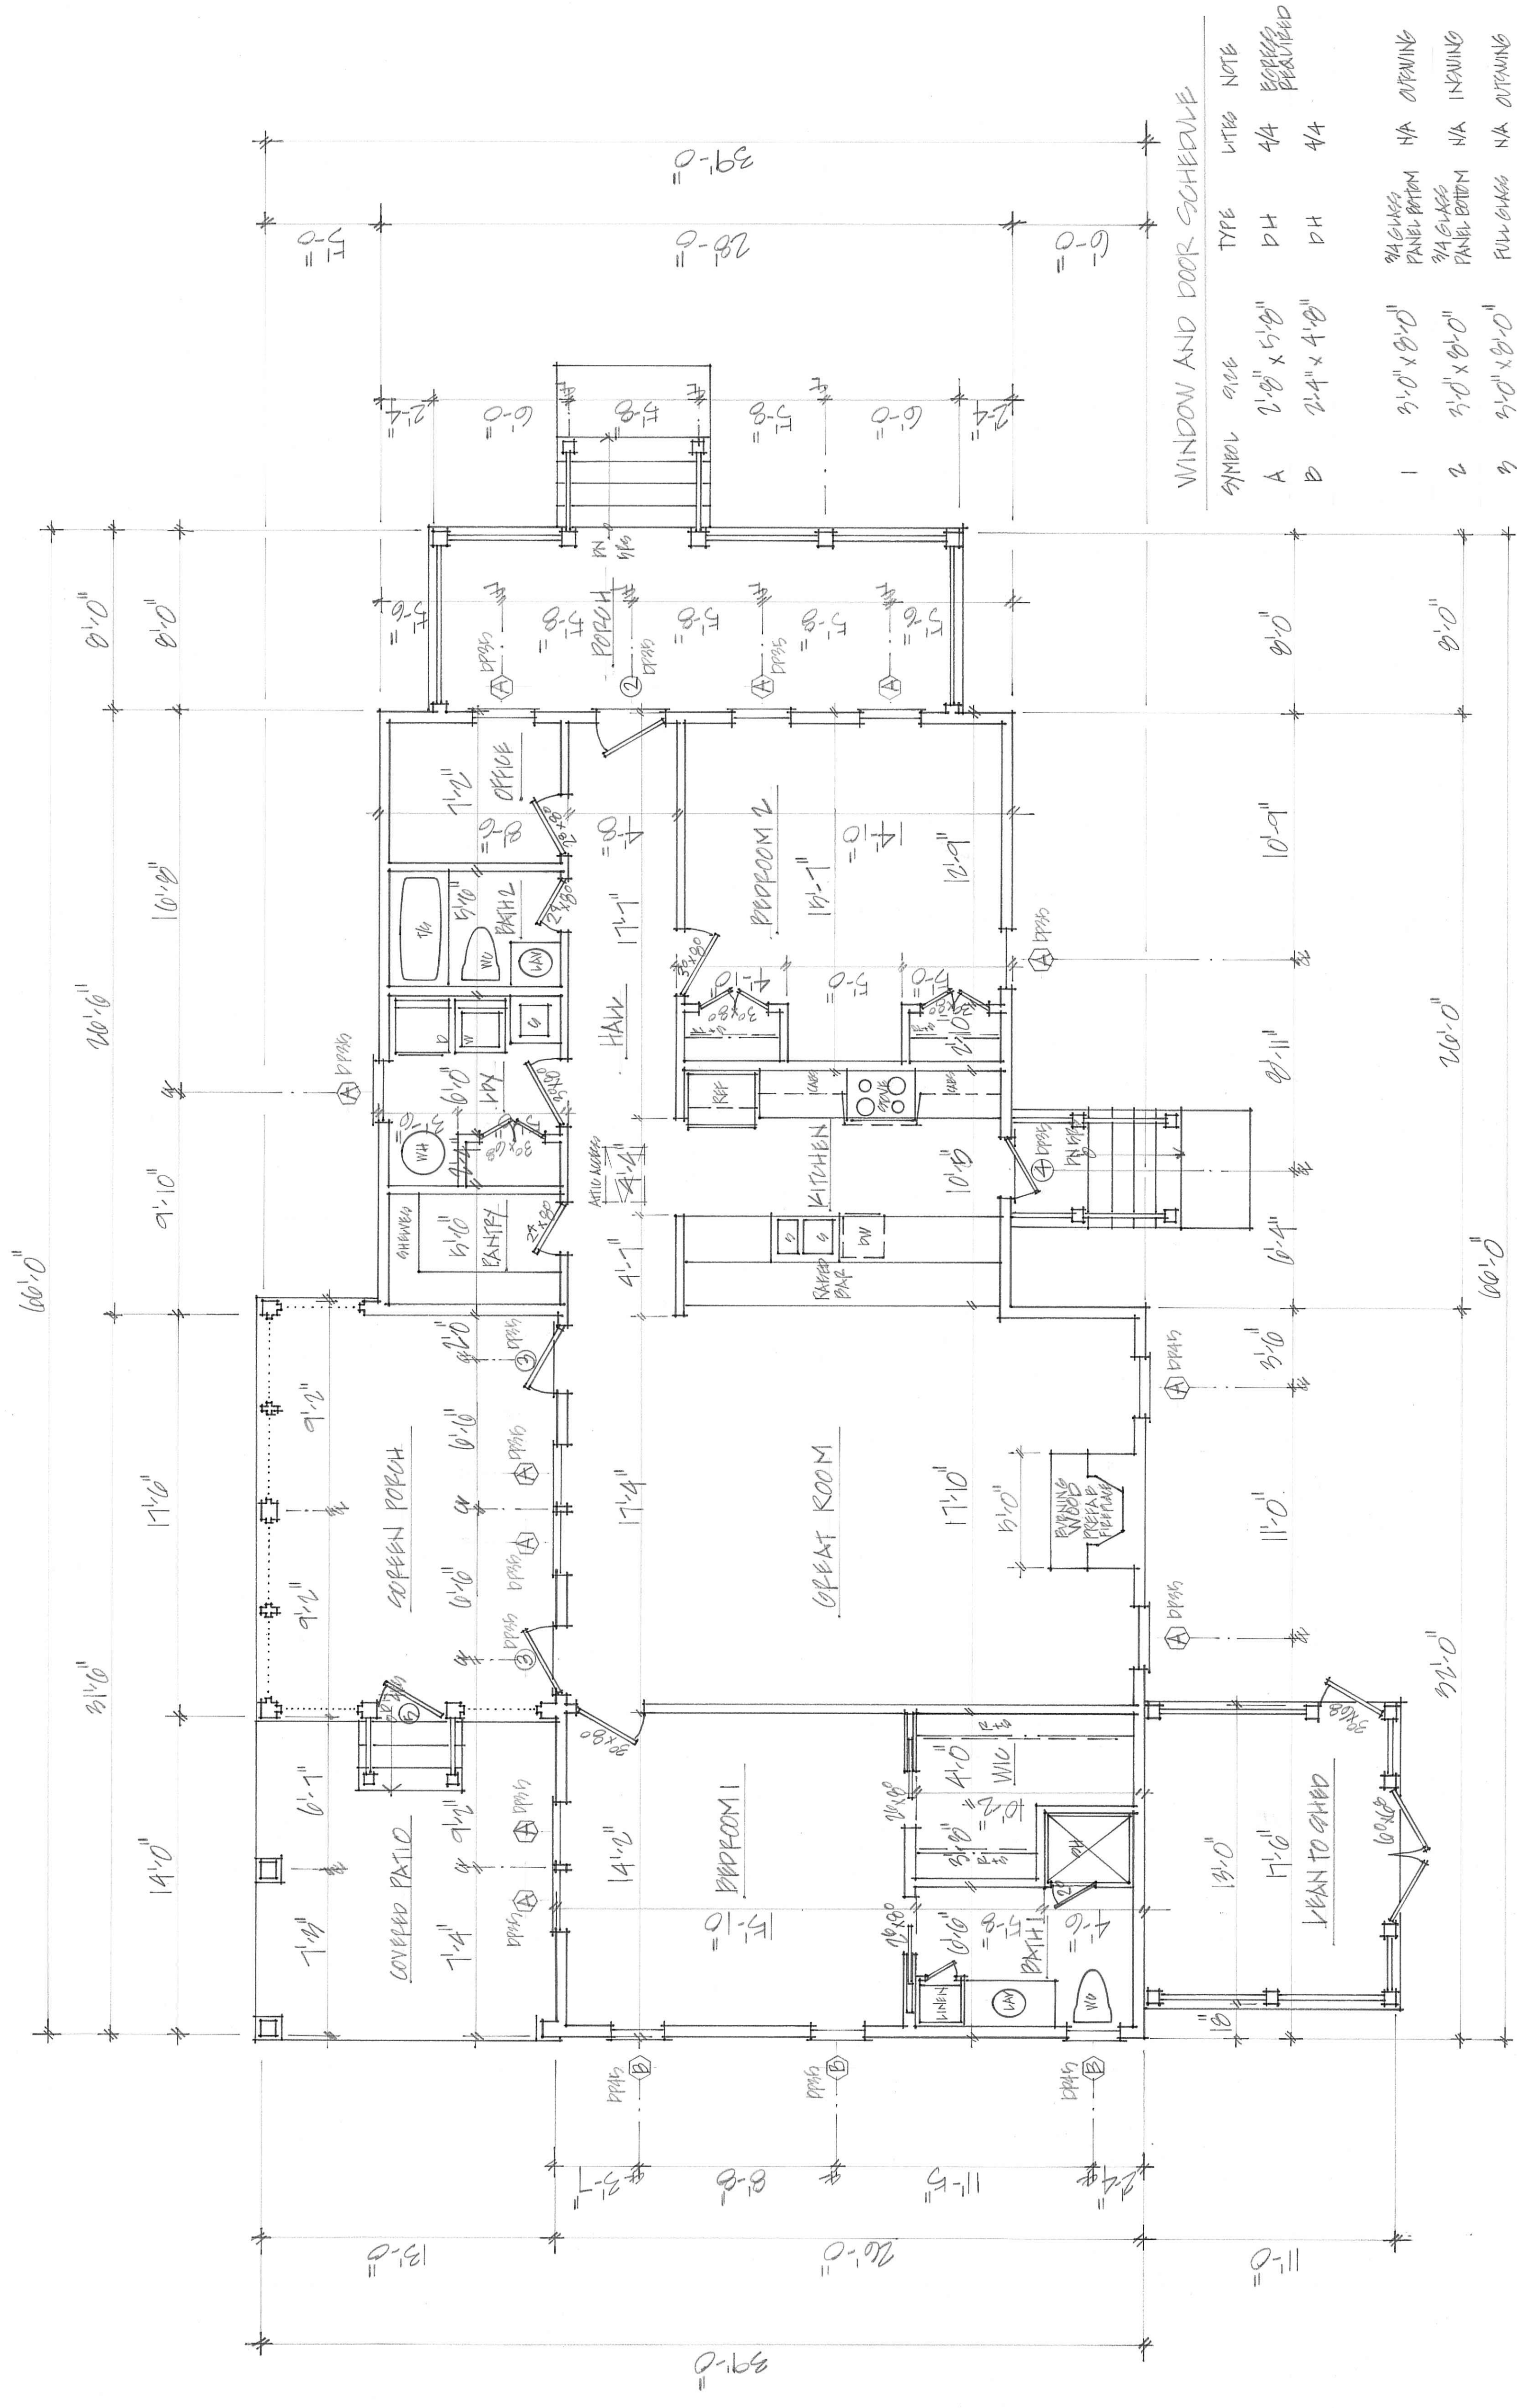


FLOOR PLAN SCALE OF 1/4" = 1'-0"

		28 SEPT 2023 PRICING SET 8 NOVEMBER 2023 FINAL PLANNING	MANUEL STUDIO, LLC ANOLEY HEISTER MANUEL, ARCHITECT 843. 338. 8932	THE KELLY RESIDENCE 11 BRIDGE STREET BLUFFTON, SOUTH CAROLINA	
--	--	--	--	---	--



LEFT ELEVATION SCALE OF 1/4" = 1'-0"

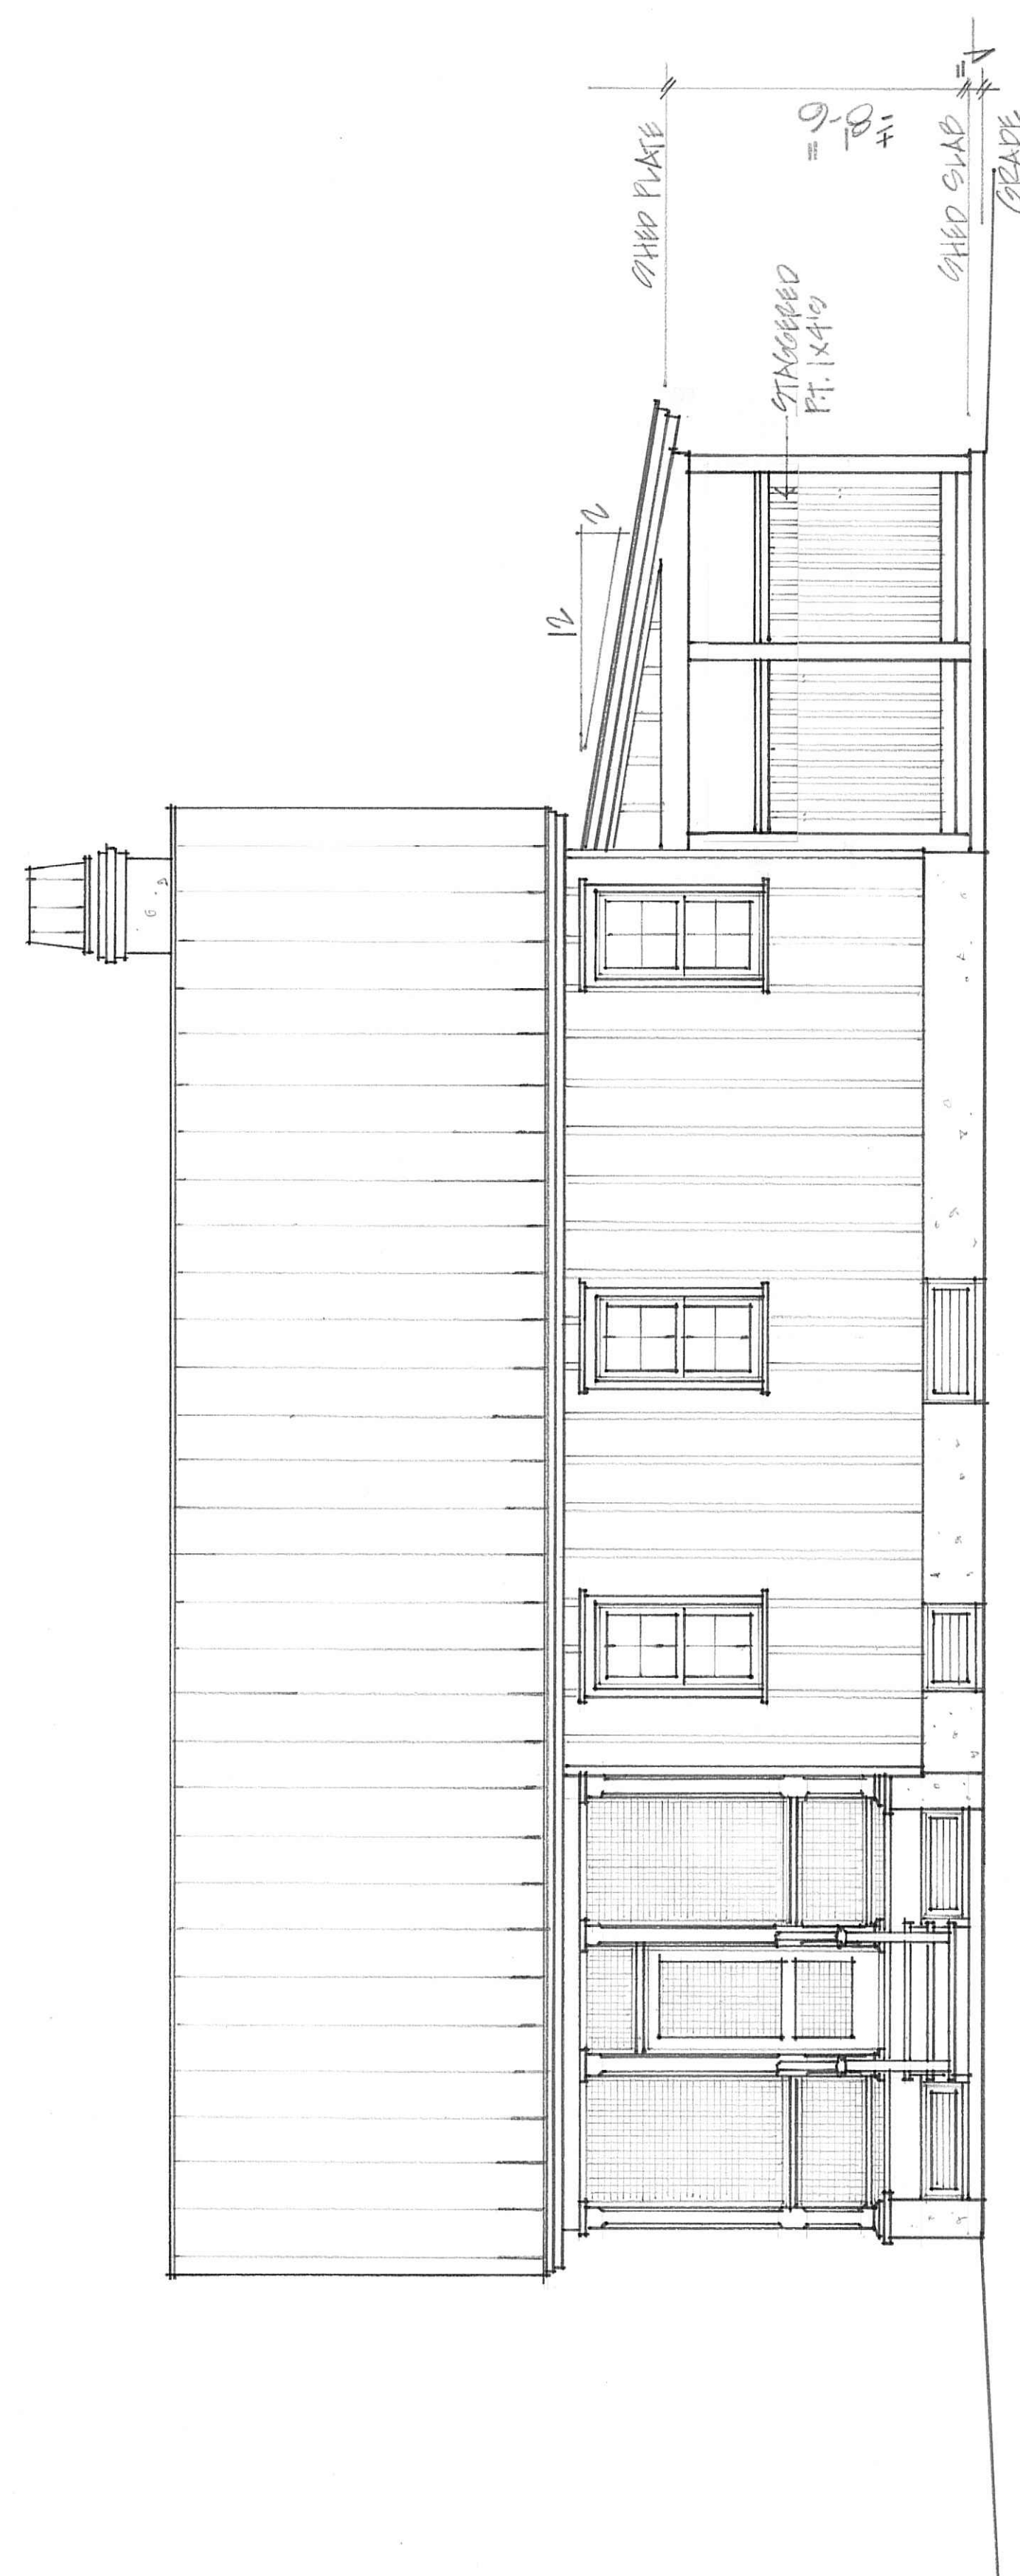


REAR ELEVATION SCALE OF 1/4" = 1'-0"

3

THE KELLY RESIDENCE
17 BRIDGE STREET
BLUFFTON, SOUTH CAROLINA

MANVEL STUDIO, LLC
ANGLEY HESTER MANVEL, ARCHITECT
843.338.8932

18 SEPT 2023
PRINTING SET
5 NOVEMBER 2023
FINAL PLANNING

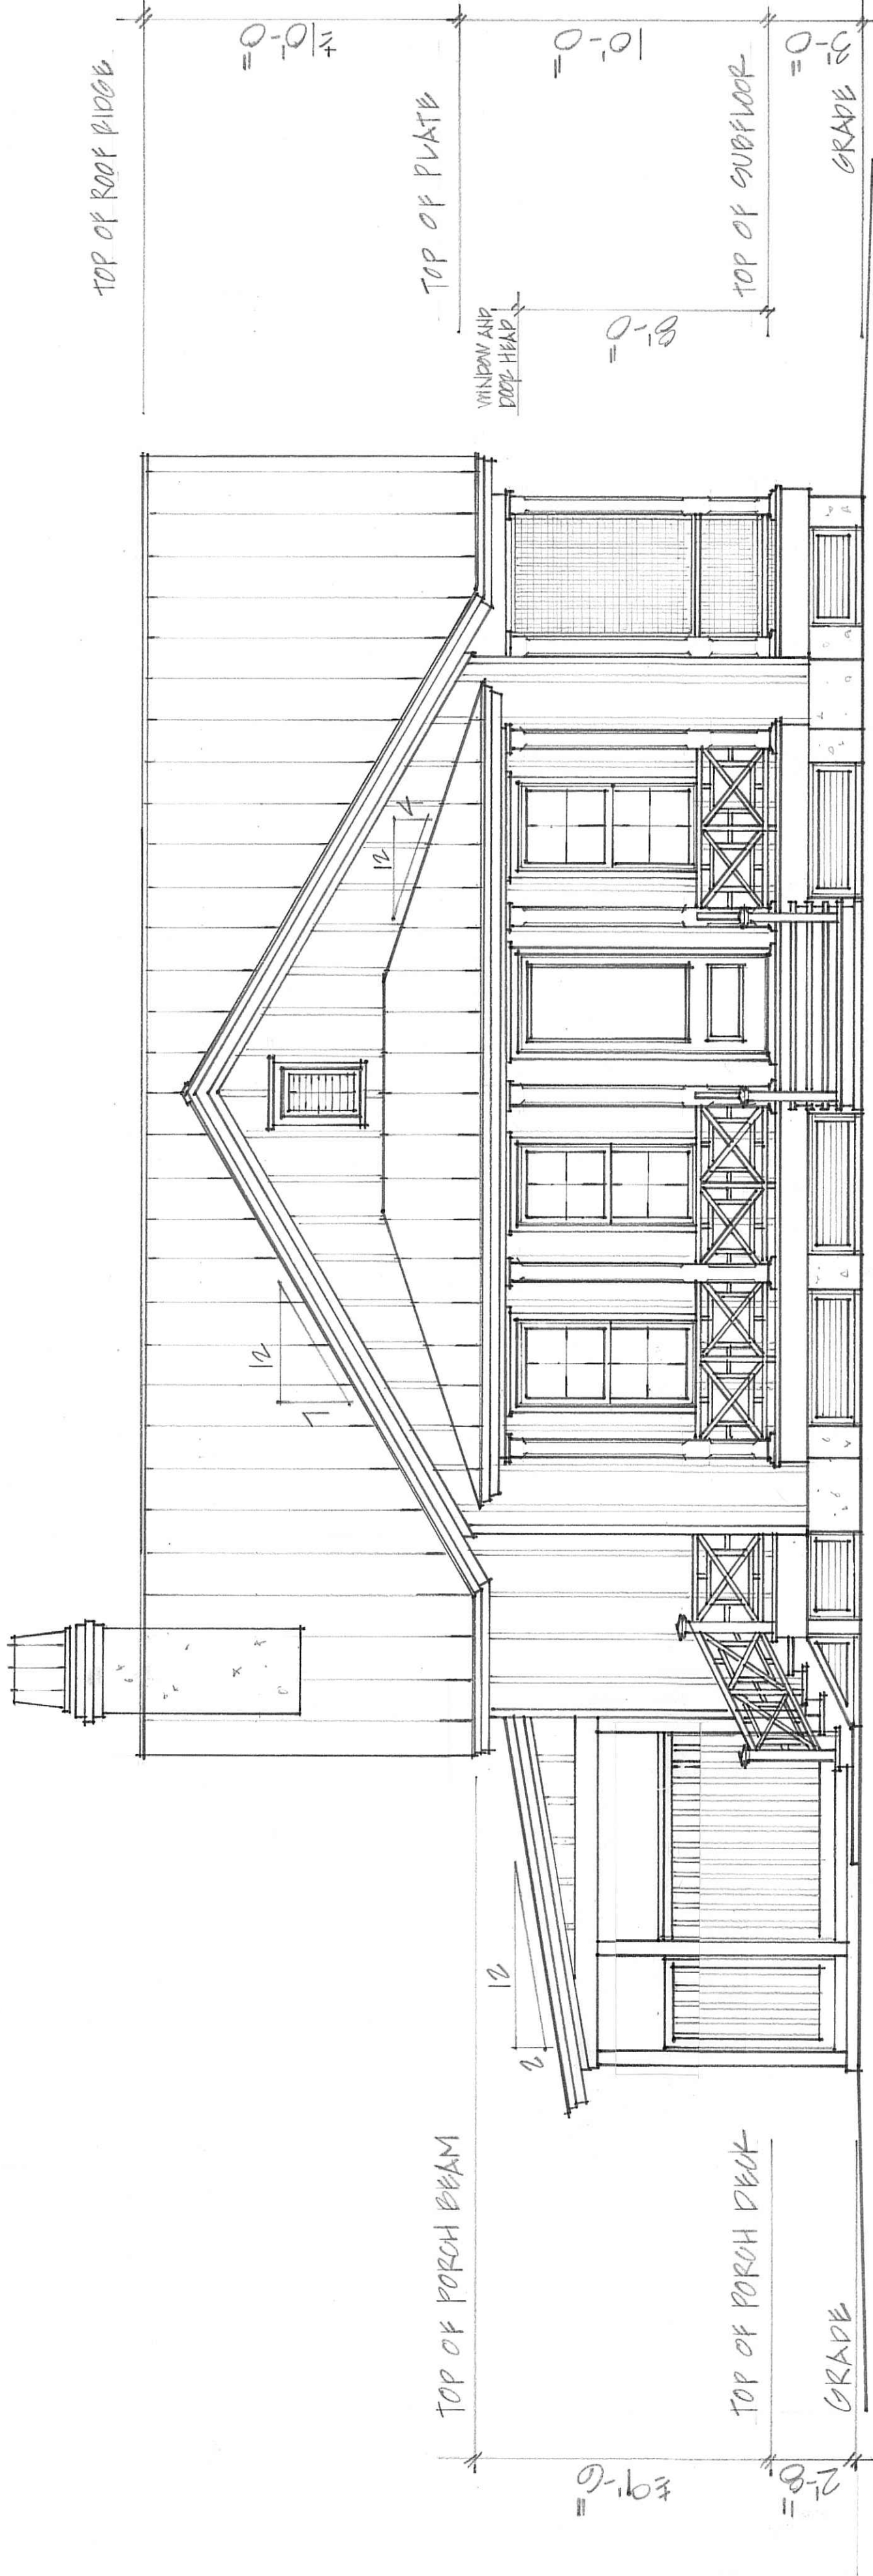



18 SEP 2023
PRELIMINARY
8 NOVEMBER 2023
FINAL PLANNING

MANUEL STUDIO, LLC
ANGLEY HEATER MANUEL, ARCHITECT
843.338.8932


THE KELLY RESIDENCE
11 BRIDGE STREET
BLUFFTON, SOUTH CAROLINA

5

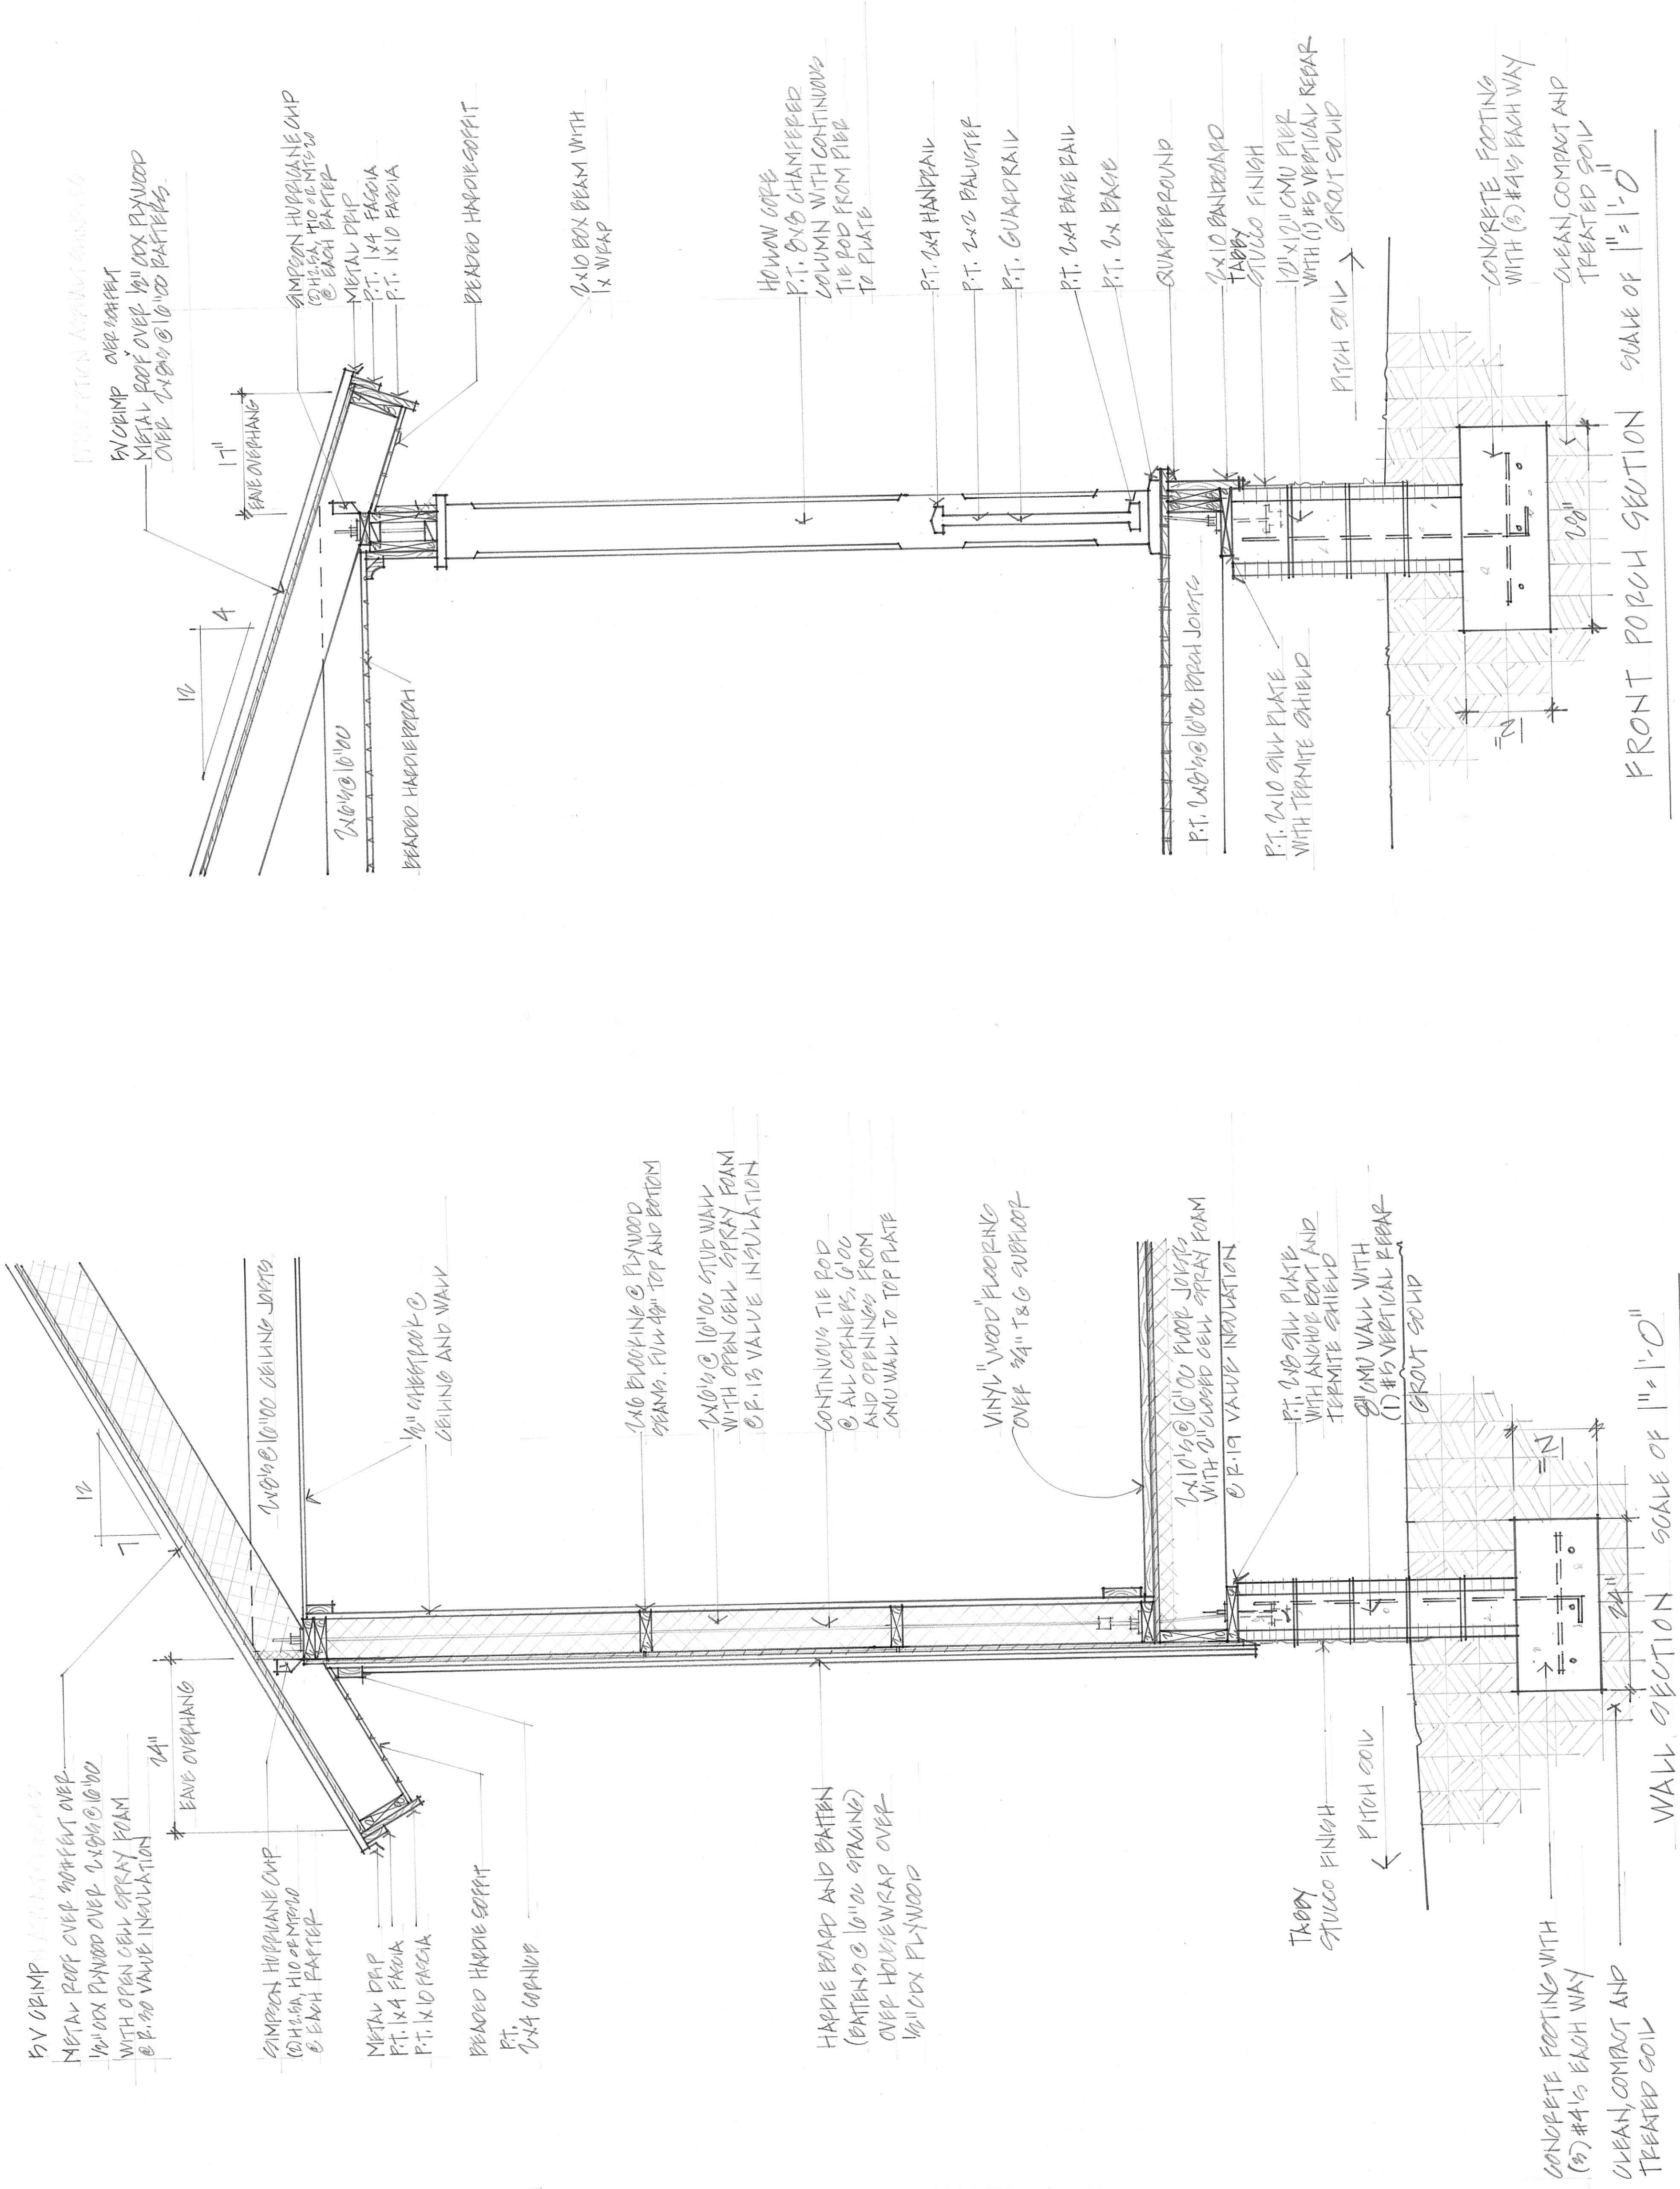


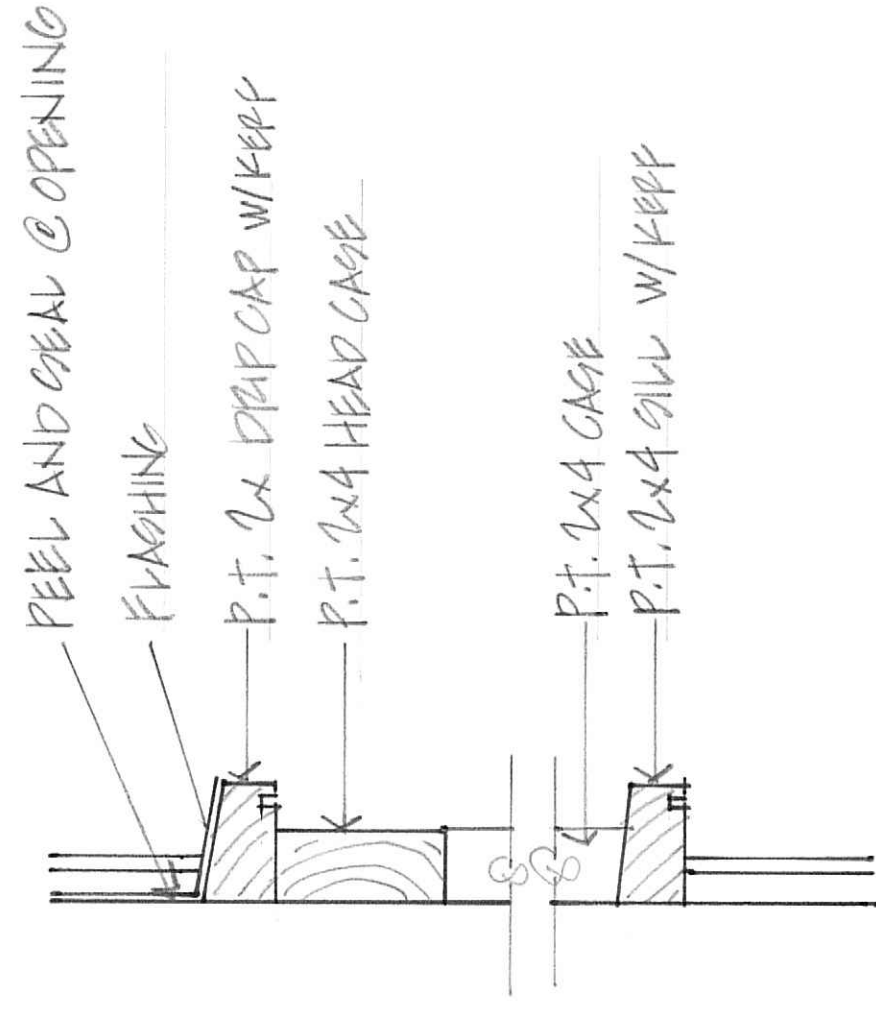


WINDOW TRIM DETAIL SCALE OF 3" = 1'-0"

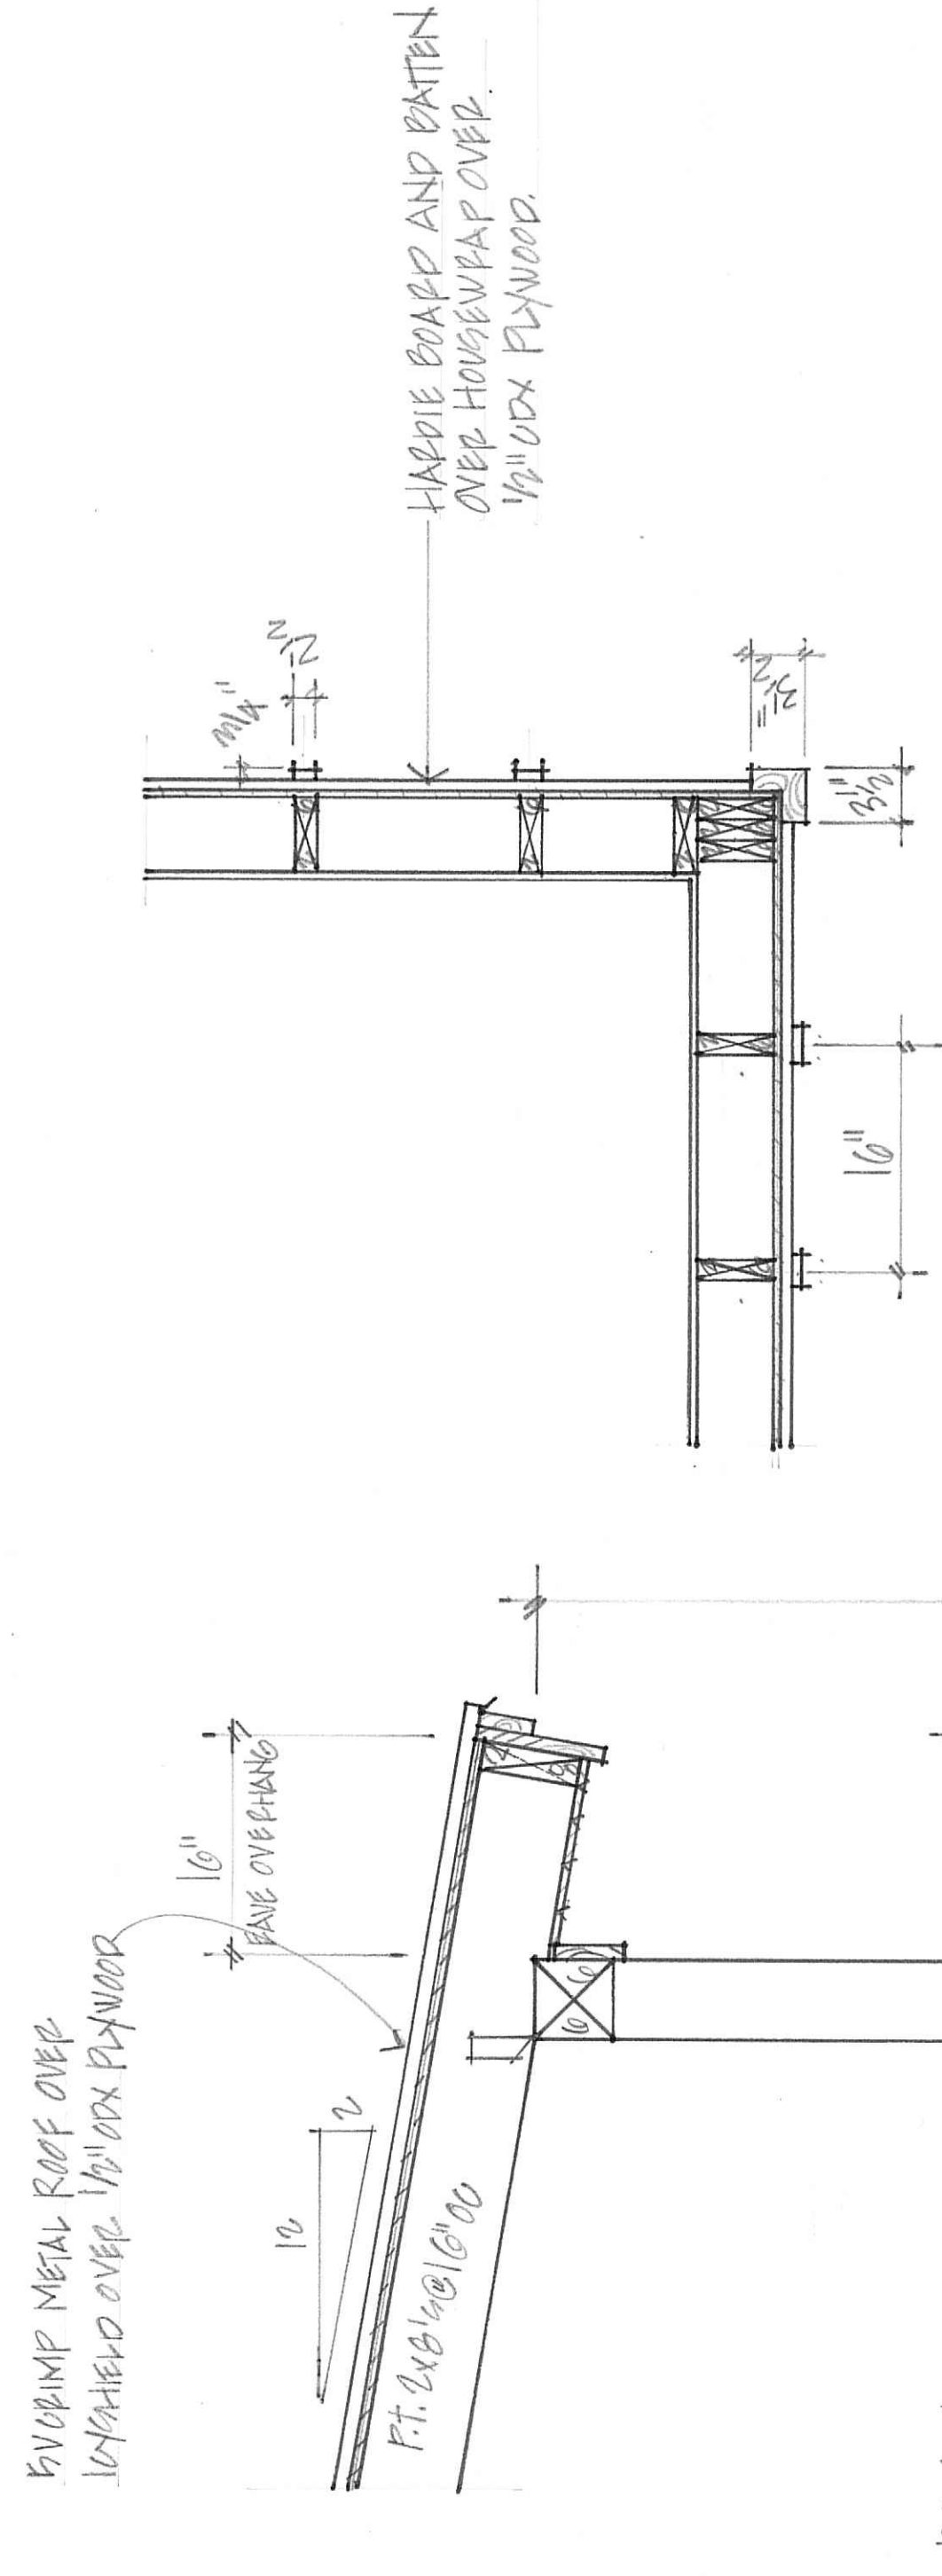



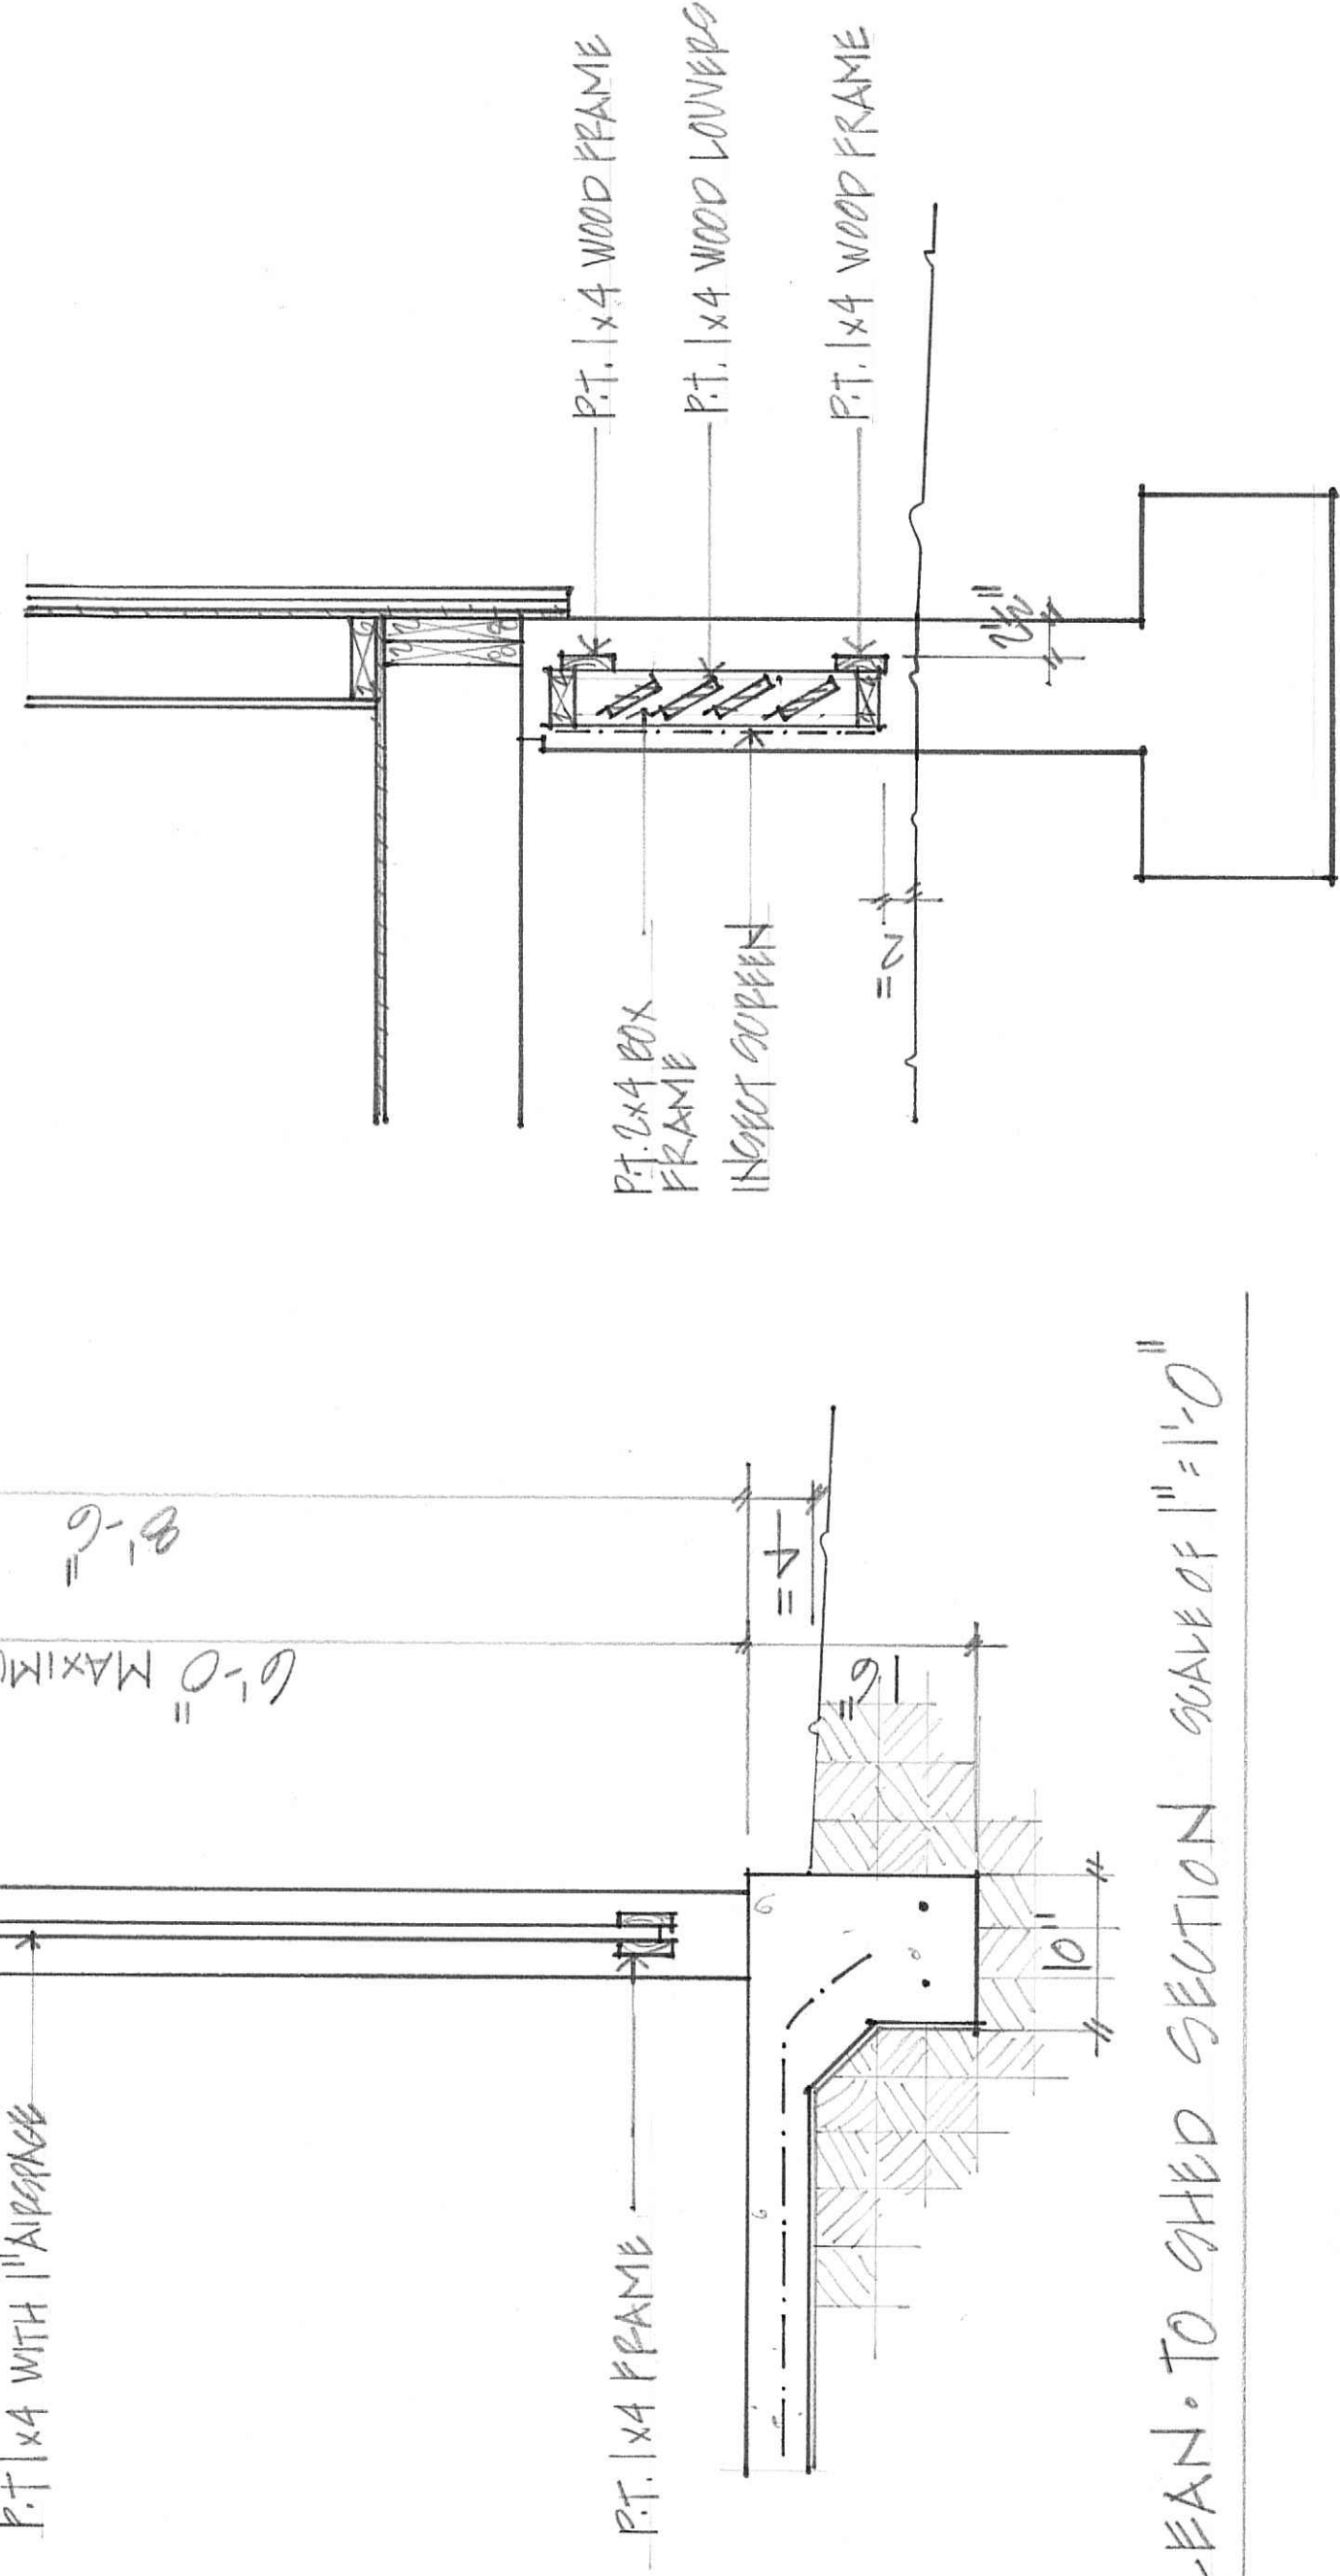



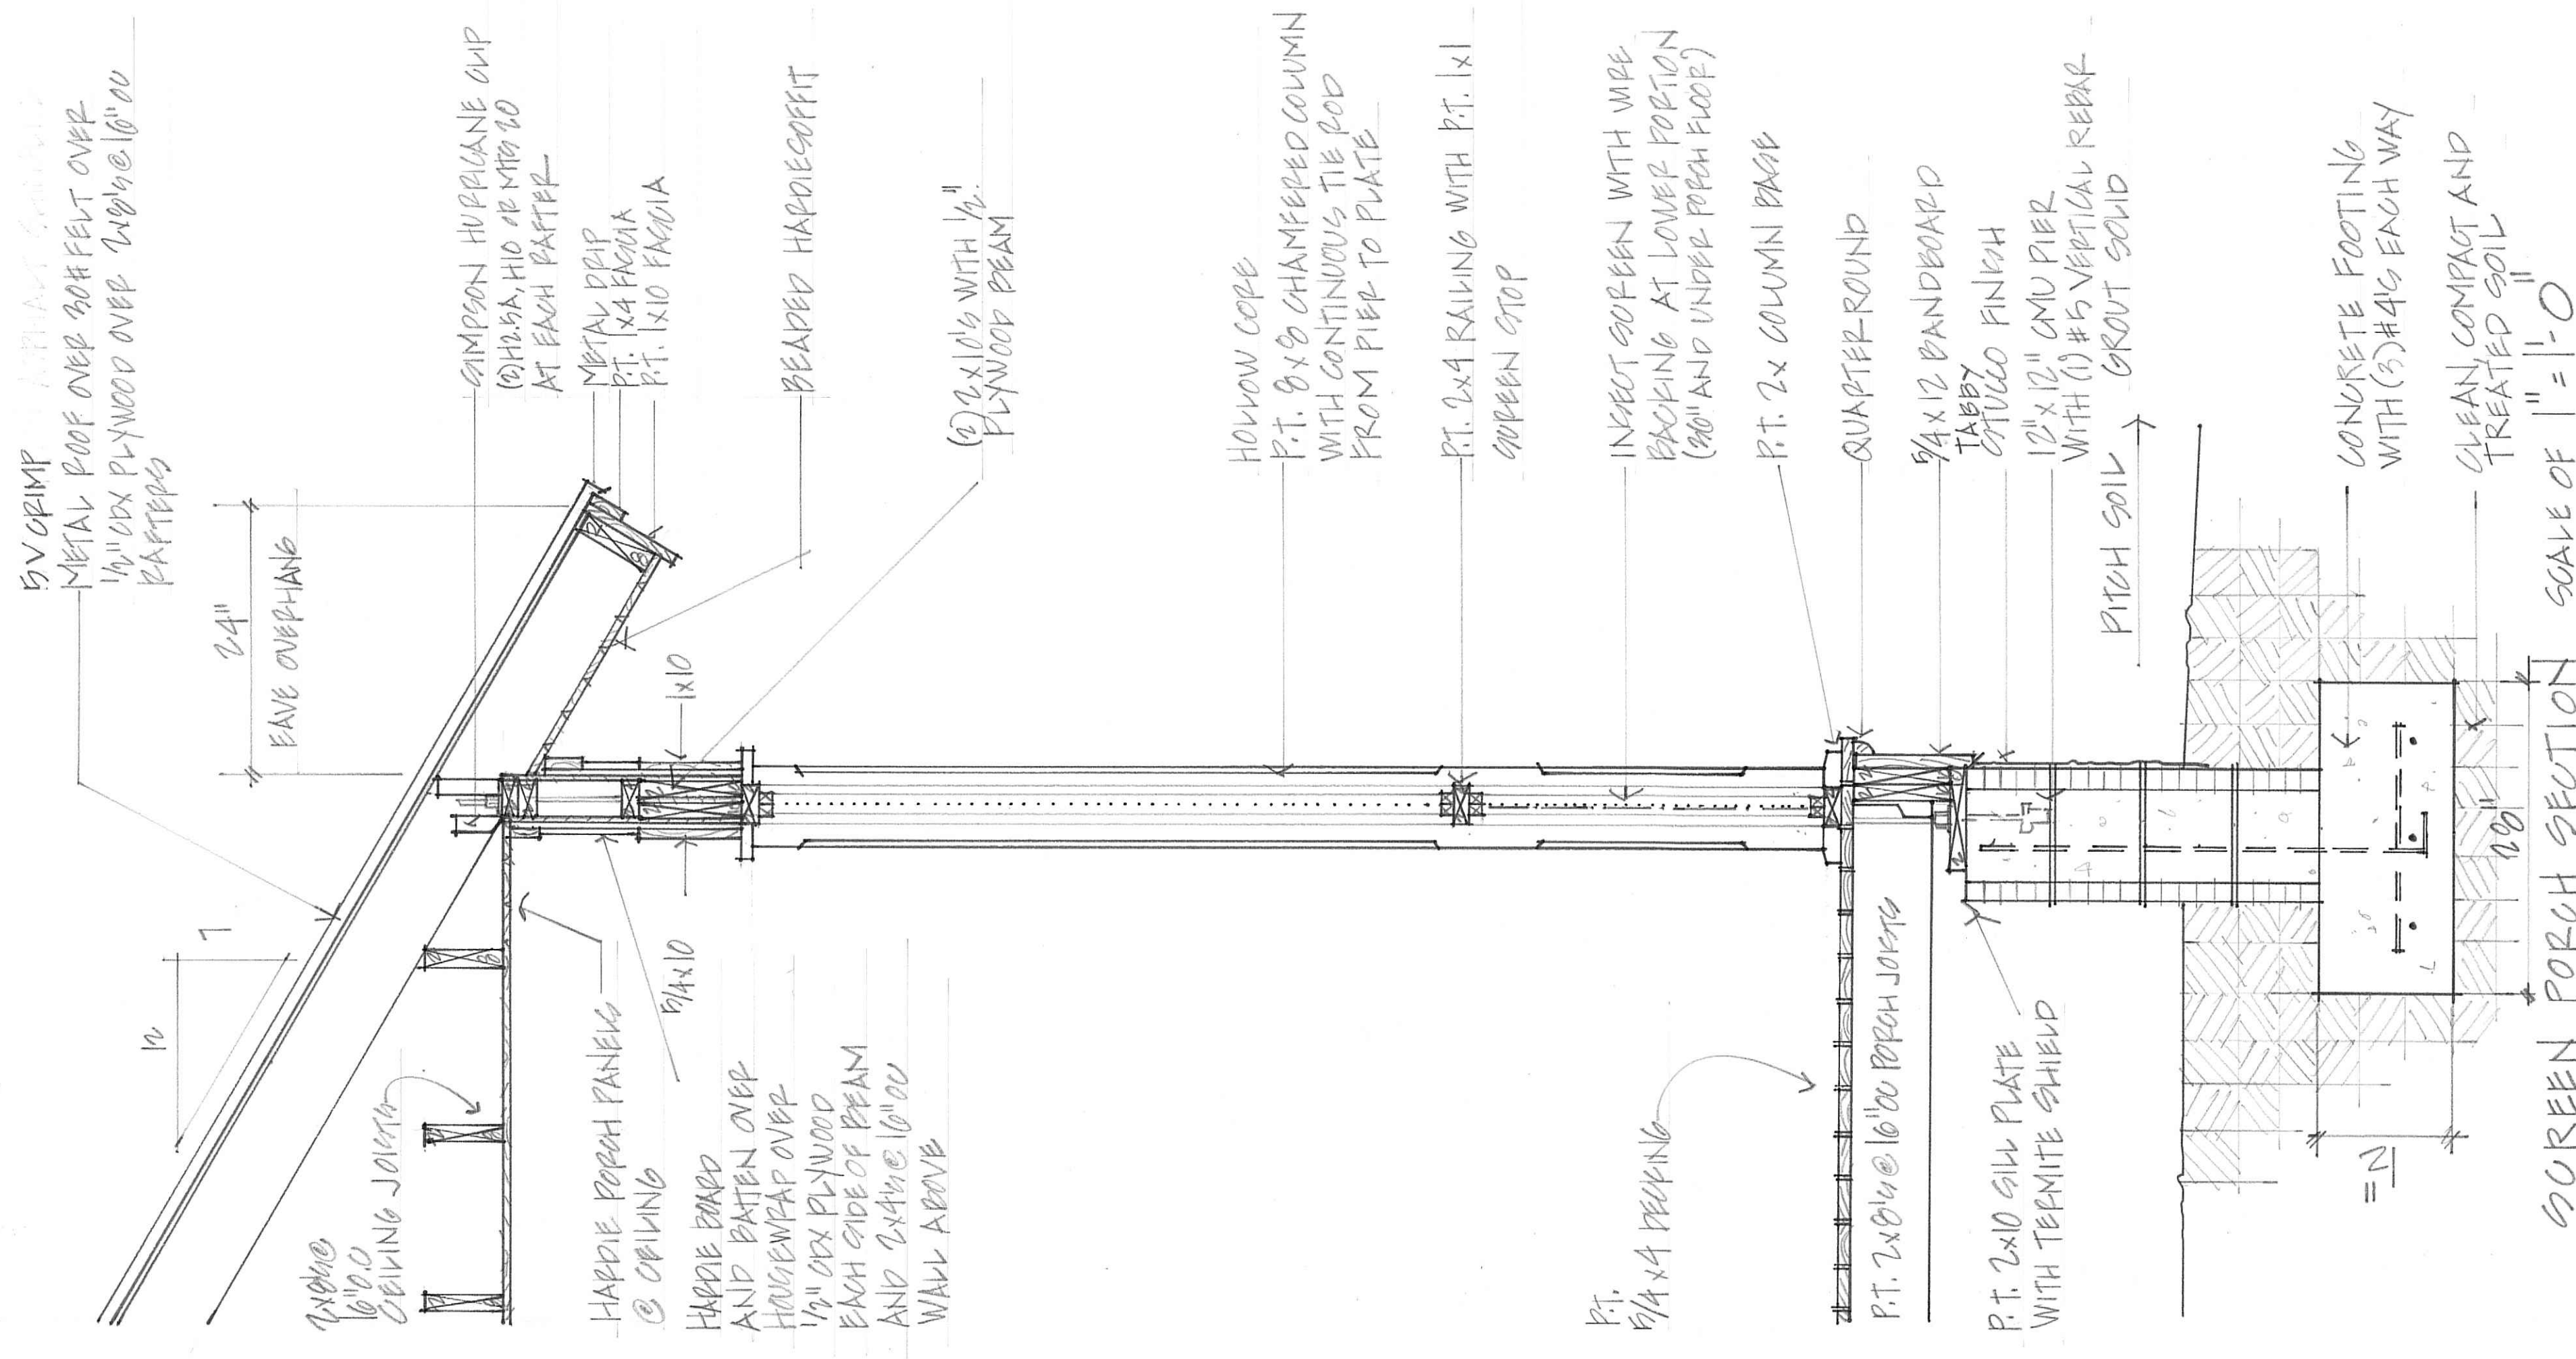 




 

 



 

 




CORNER DETAIL




FOUNDATION LOWERED VENT DETAIL



SURFEN PORCH SECTION SCALE OF 1" = 10'

	INSTANT SWITCH
	3 WAY SWITCH
	ELECTRICAL OUTLET
	220 VOLT
	1/2" SWITCH
	4" HEIGHT GROUND FAULT INTERRUPT
	FLOOR OUTLET
	OUTDOOR SCONCE
	INDOOR SCONCE
	SURFACE MOUNT LIGHT
	VAPOR SEAL CAN LIGHT
	RECESSED CAN LIGHT
	TELEVISION CABLE
	TELEPHONE JACK
	EXHAUST FAN
	CEILING FAN
	CEILING FAN WITH LIGHT
	SMOKE DETECTOR
	DOORBELL CHIME
	SECURITY
	THERMOSTAT
	PANEL
	METER
	DISCONNECT

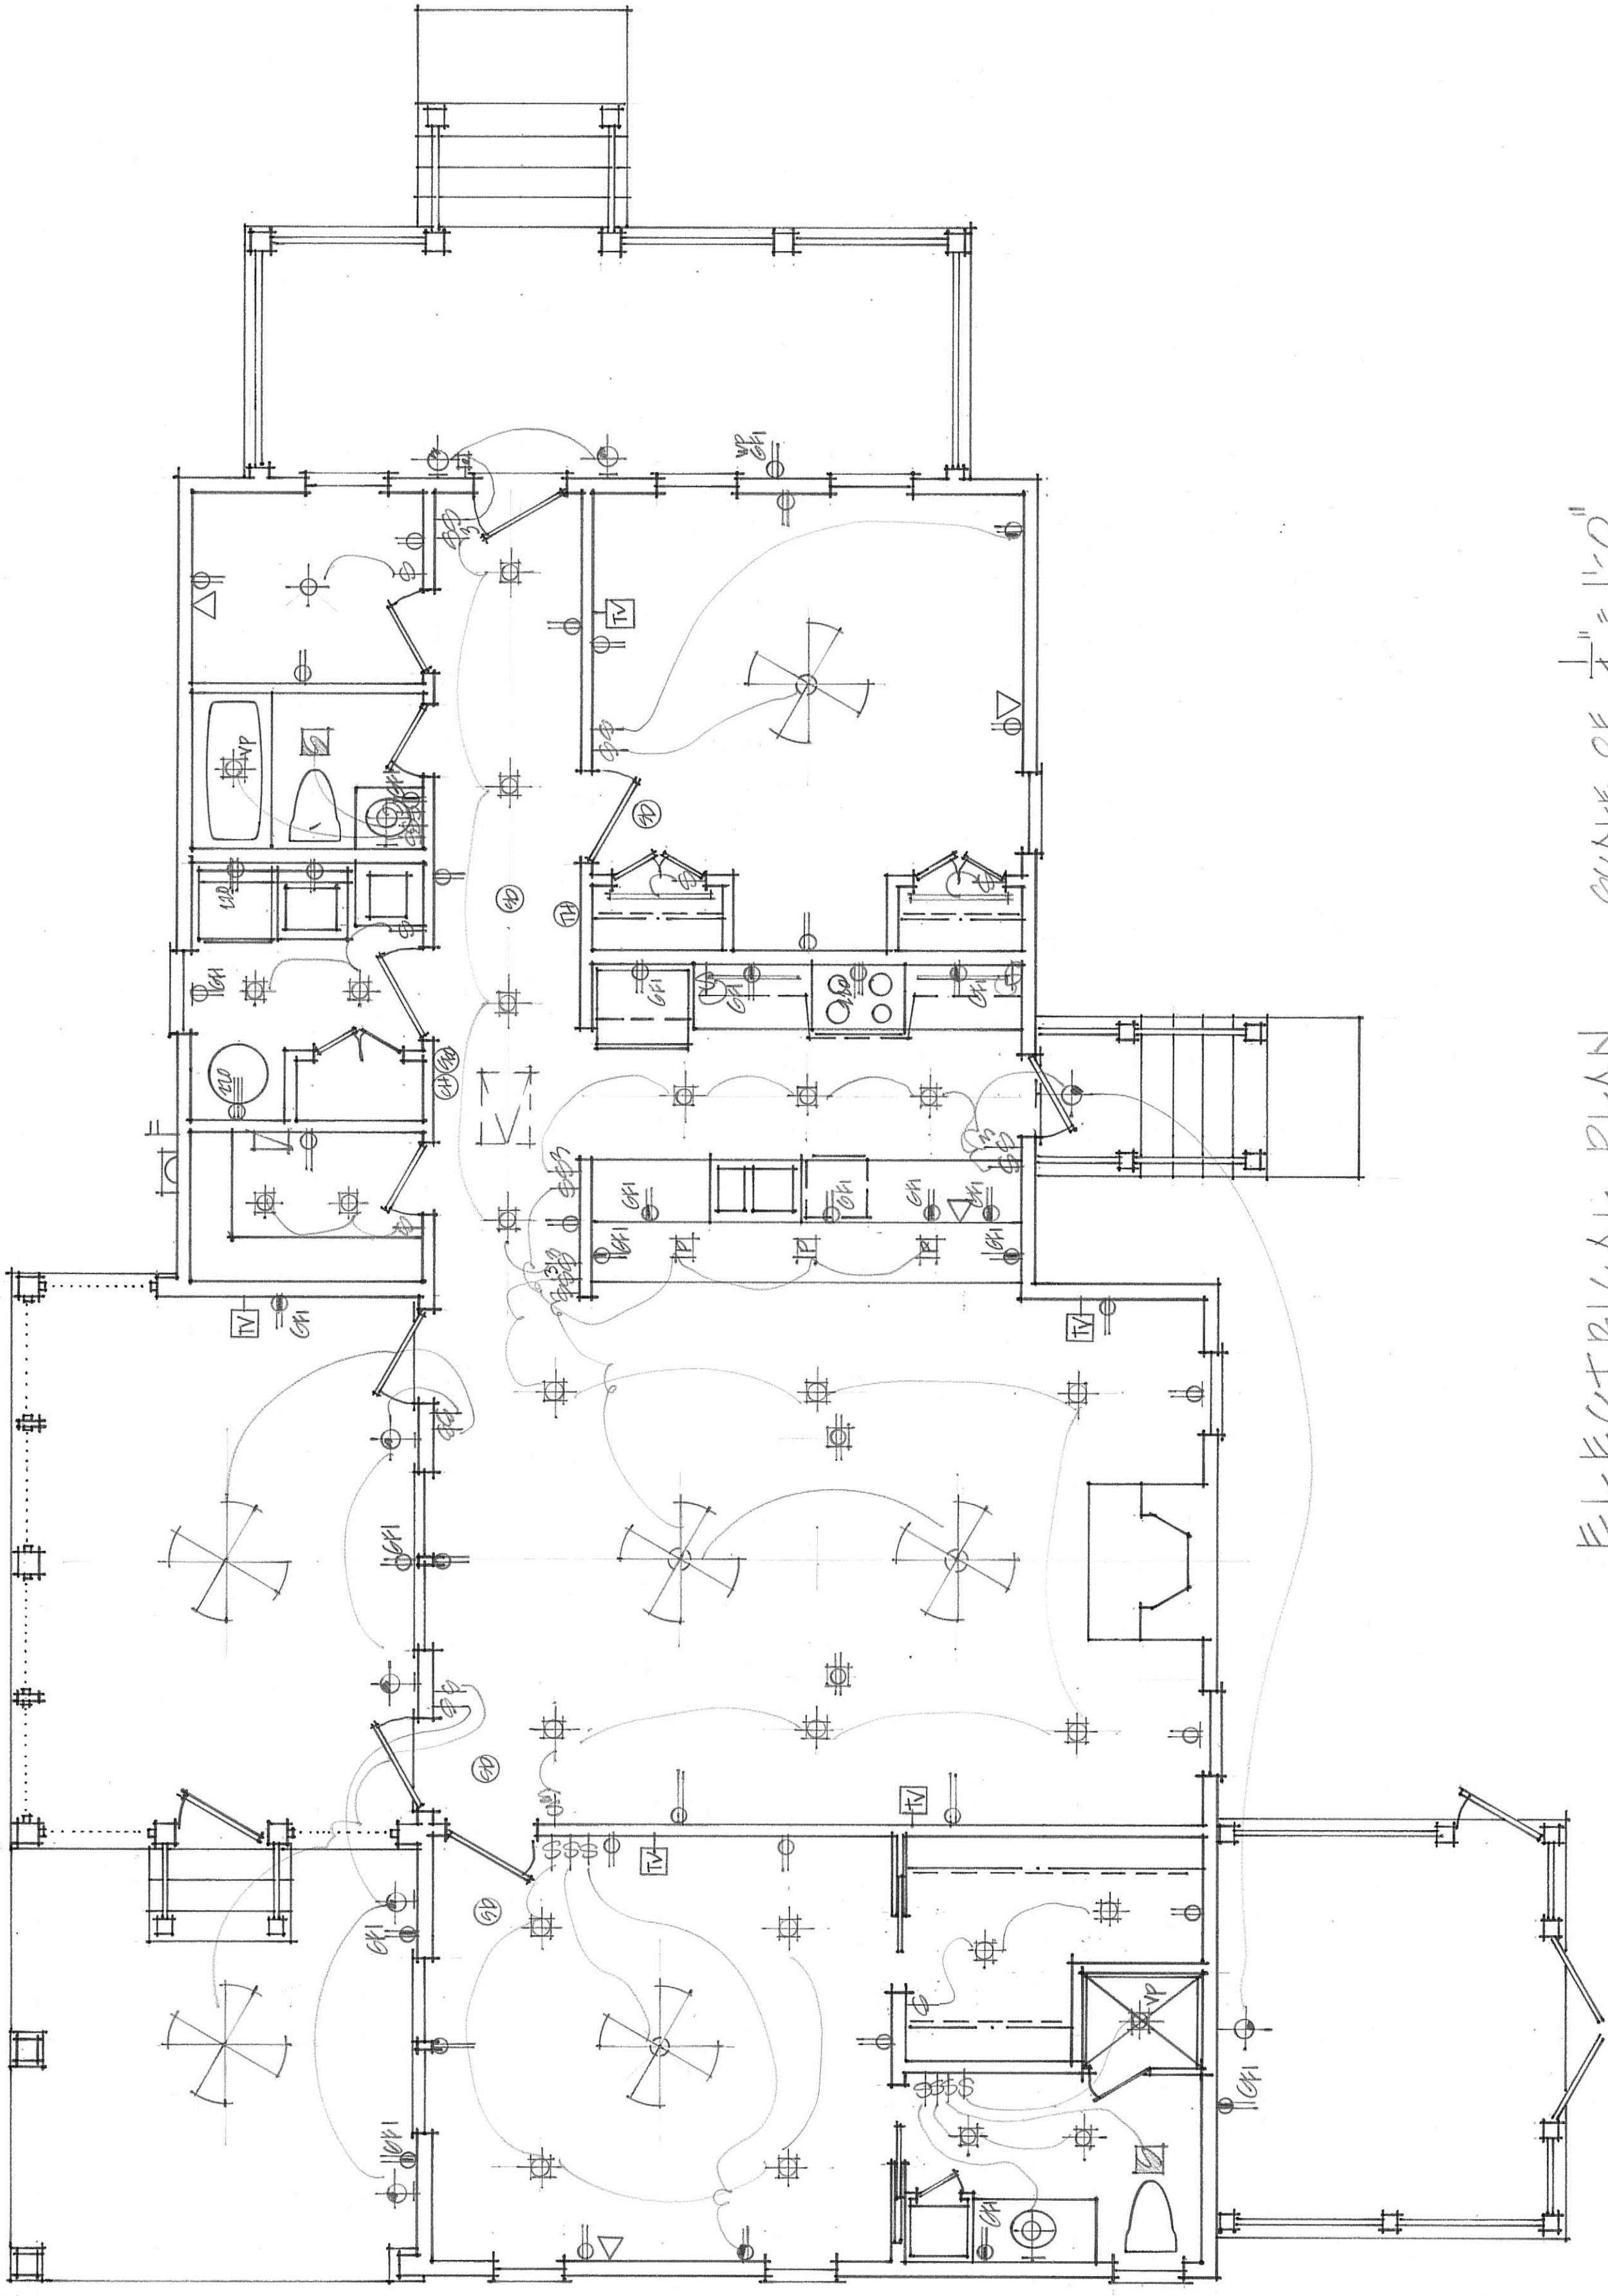

ELECTRICAL PLAN SCALE OF $\frac{1}{4}" = 1'-0"$

THE KELLY RESIDENCE
77 BRIDGE STREET
BLUFFTON, SOUTH CAROLINA

MANUEL STUDIO, LLC
ANSLEY HESTER MANUEL, ARCHITECT
843.338.8932


28 SEP 2023
PRICING SET
8 NOVEMBER 2023
FINAL PLANNING

THE KELLY RESIDENCE
11 BRIDGE STREET
BLUFFTON, SOUTH CAROLINA


MANUEL STUDIO, LLC
ANGIE HESTER MANUEL, ARCHITECT
843.338.8932

28 SEP 2023
PRICING SET
8 NOVEMBER 2023
FINAL PLANNING

FOUNDATION PLAN SCALE OF 1/4" = 1'-0"

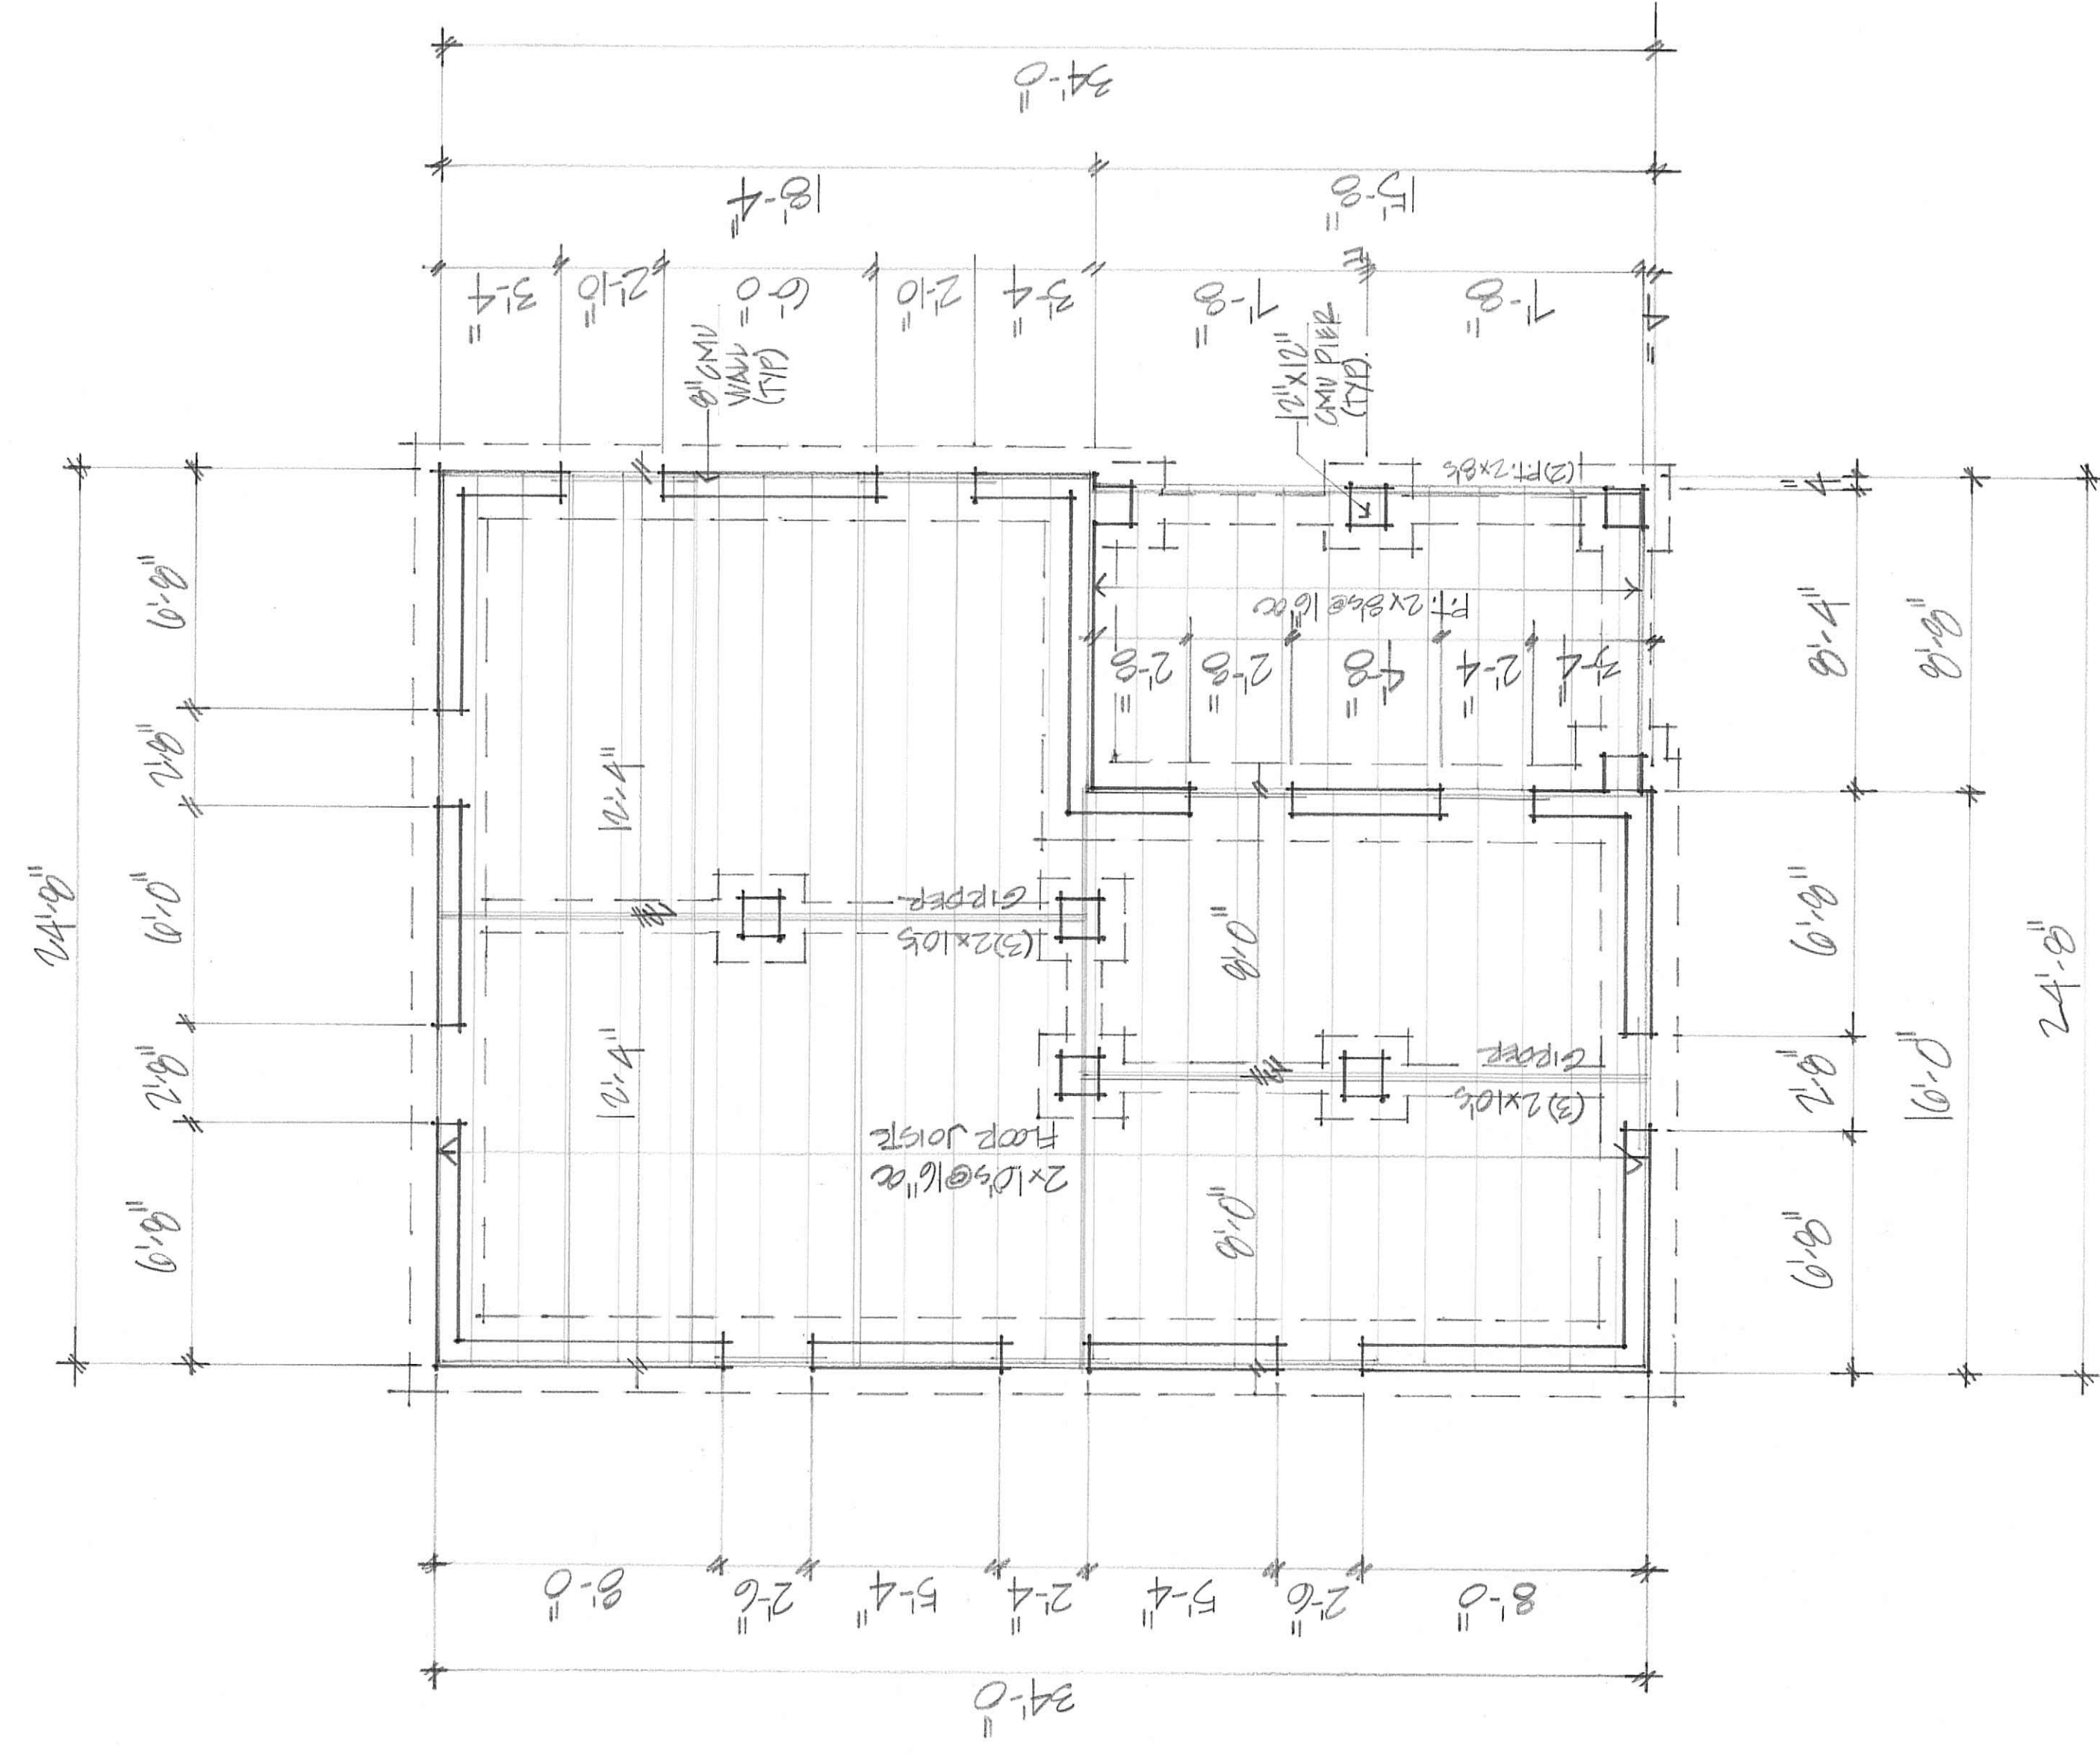

FLOOR PLAN SCALE OF 1/4" = 1'-0"

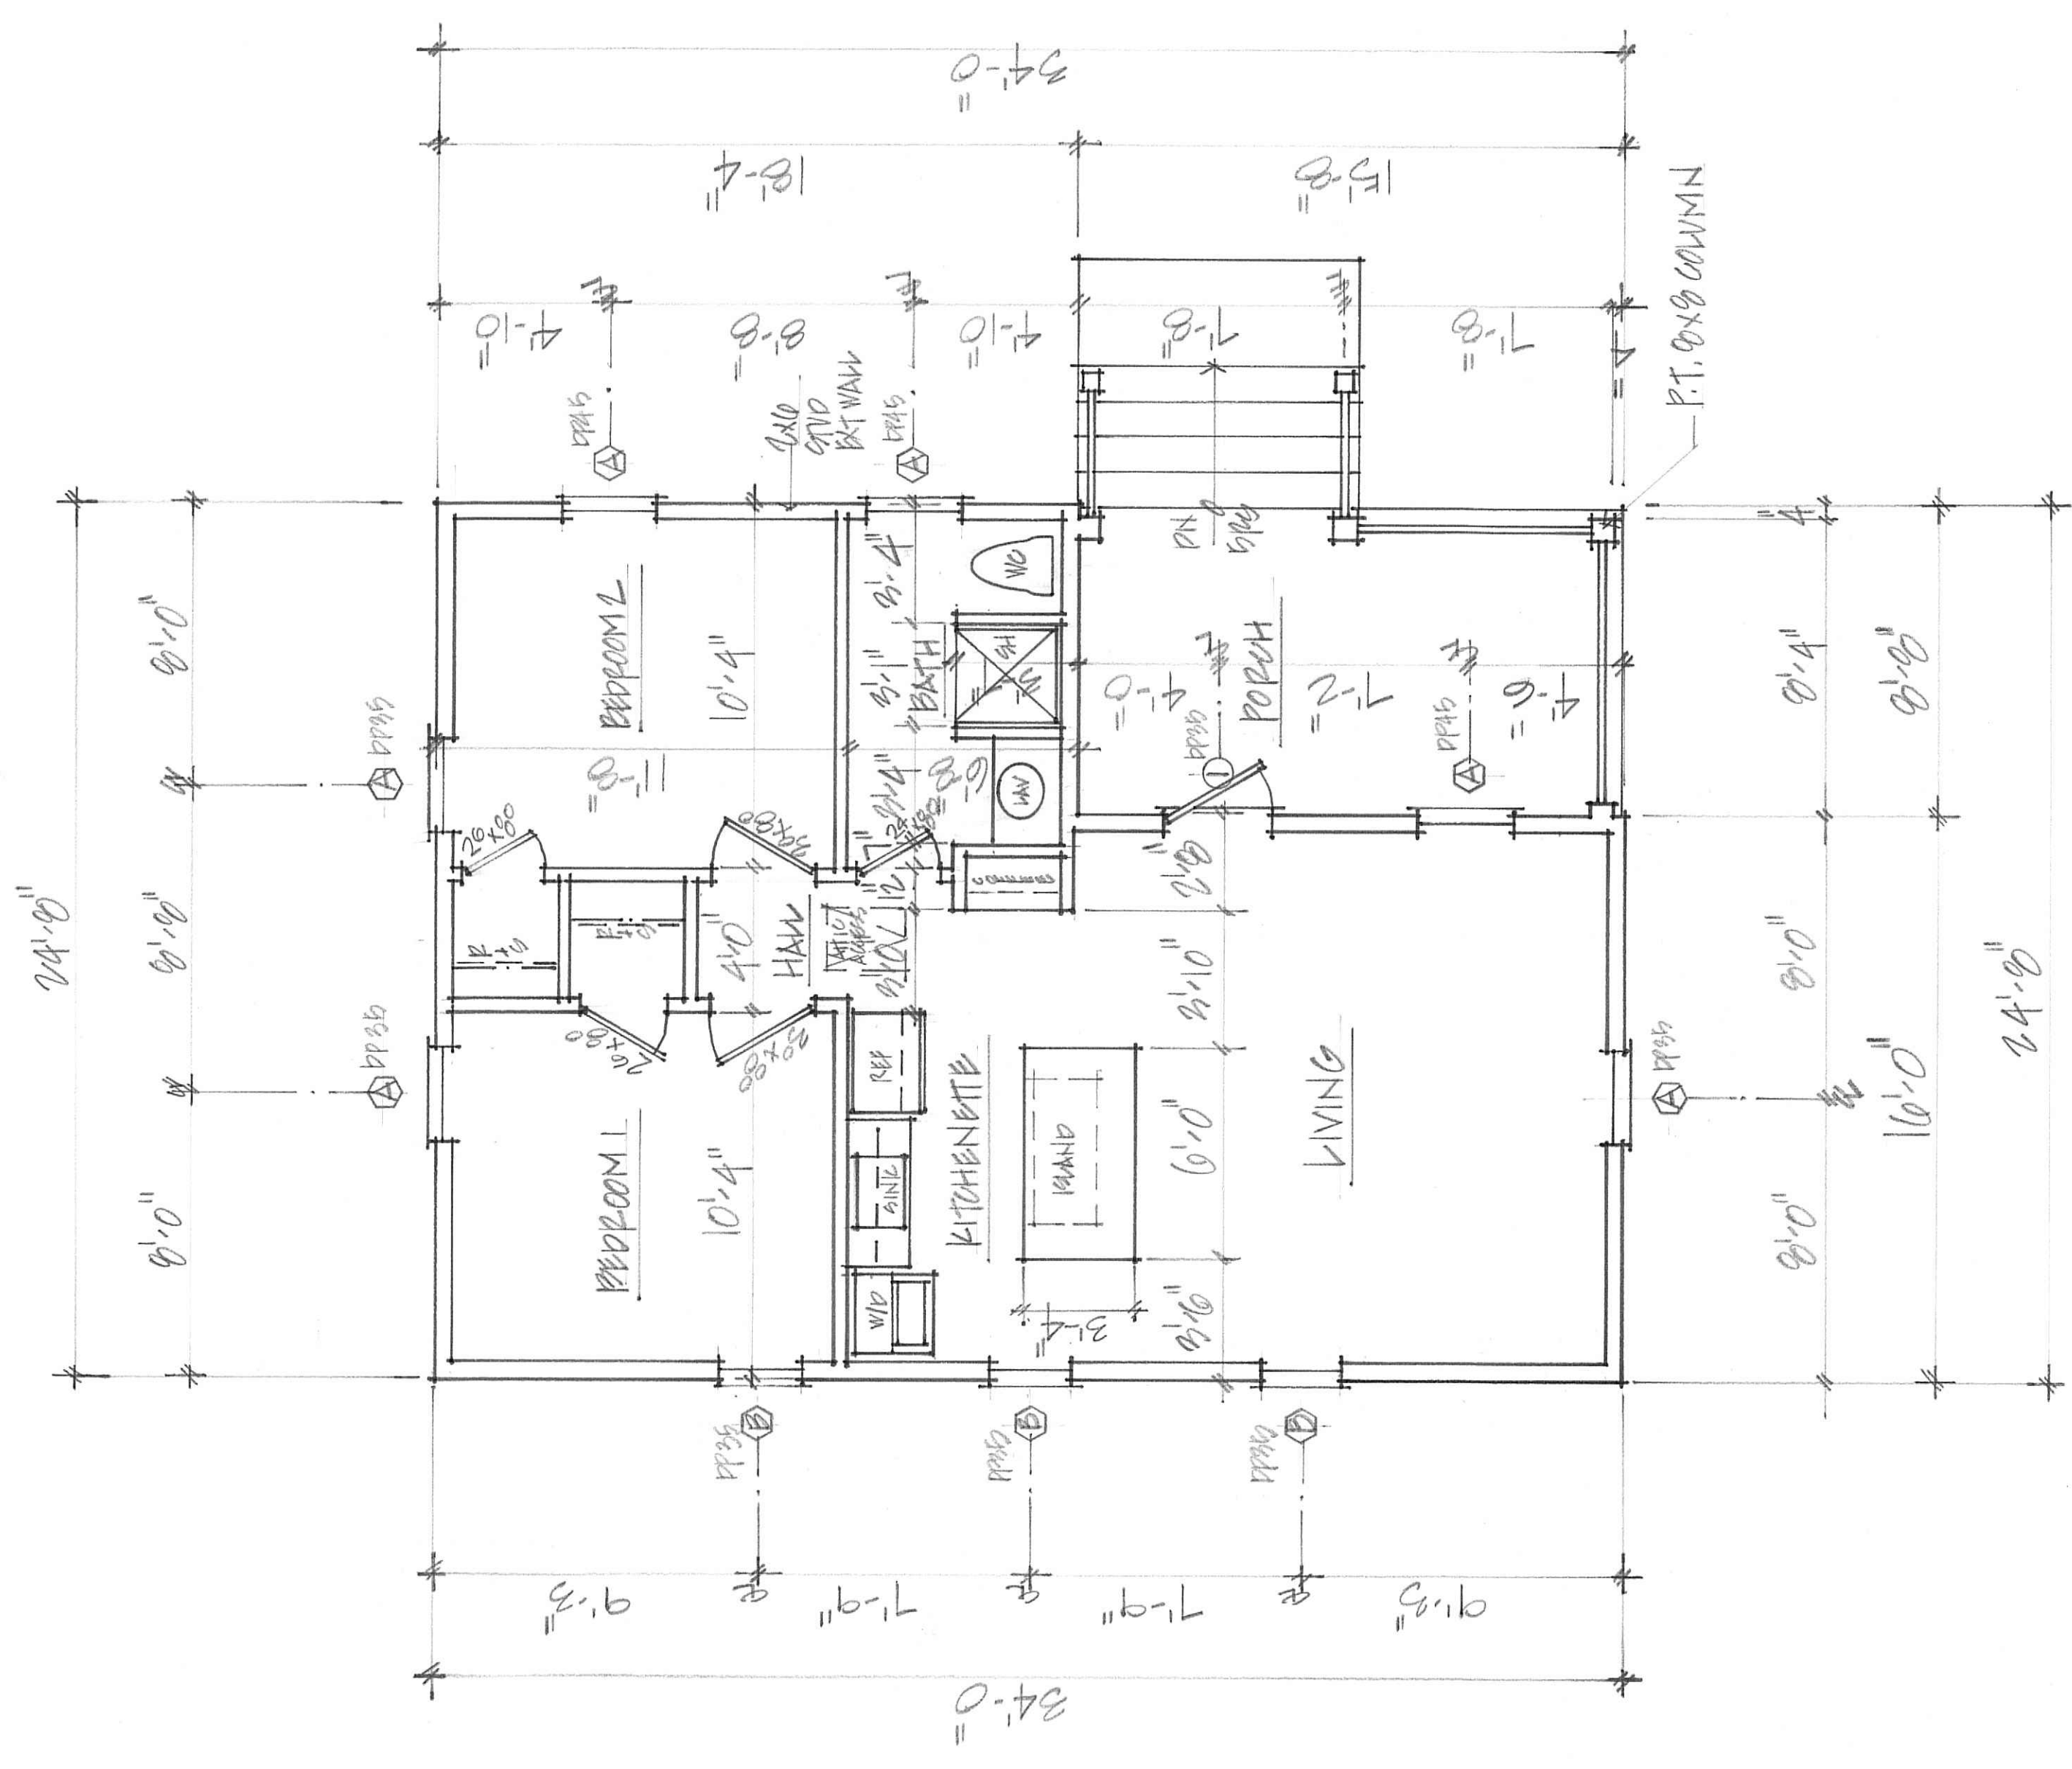


THE KELLY RESIDENCE
71 BRIDGE STREET
BLUFFTON, SOUTH CAROLINA


MANUEL STUDIO, LLC
ANGLEY HEETER MANUEL, ARCHITECT
843.338.8932

28 SEPT 2023
PRICING SET
FINAL PLANNING


FRONT ELEVATION SCALE OF $\frac{1}{4}'' = 1'-0''$

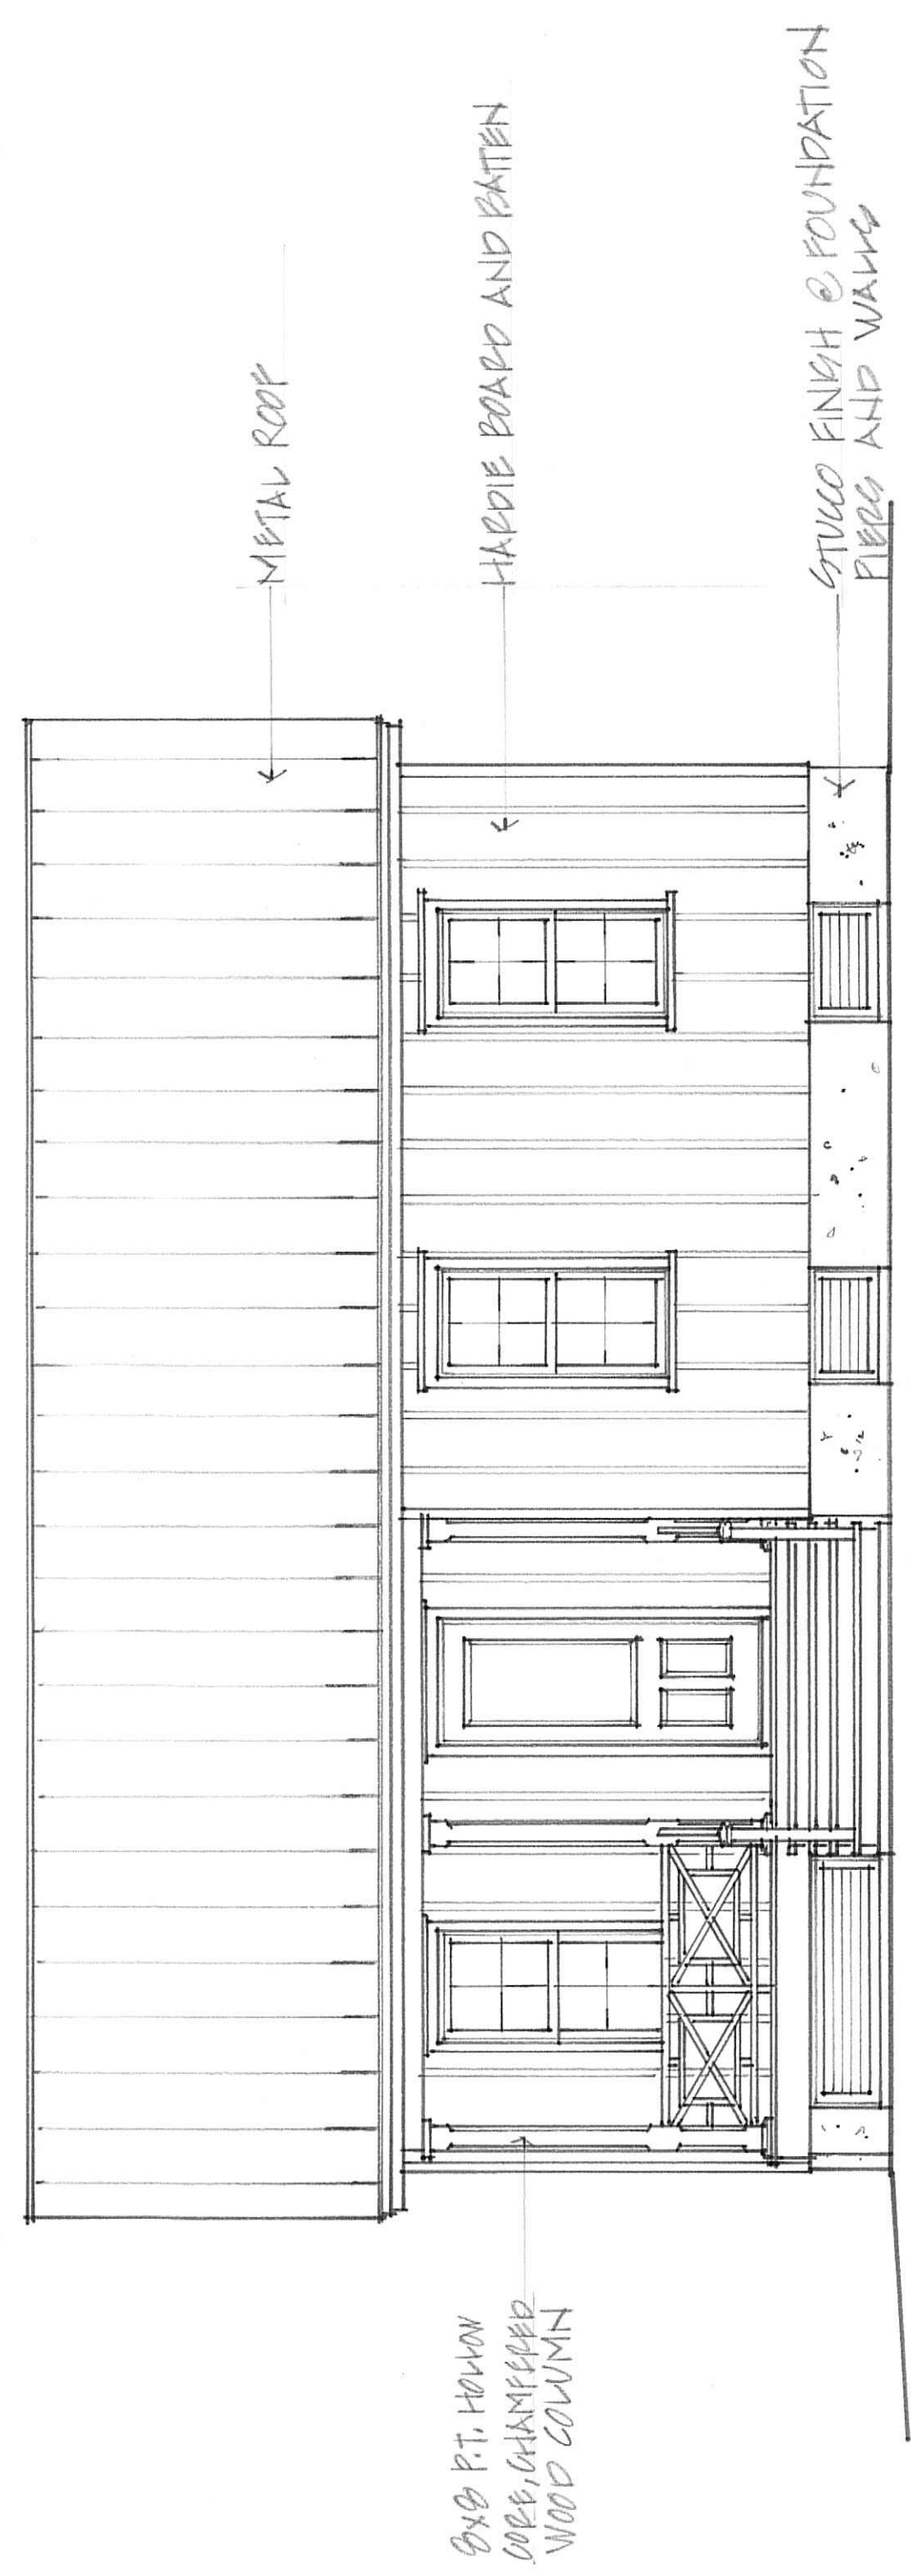


LEFT ELEVATION SCALE OF $\frac{1}{4}'' = 1'-0''$

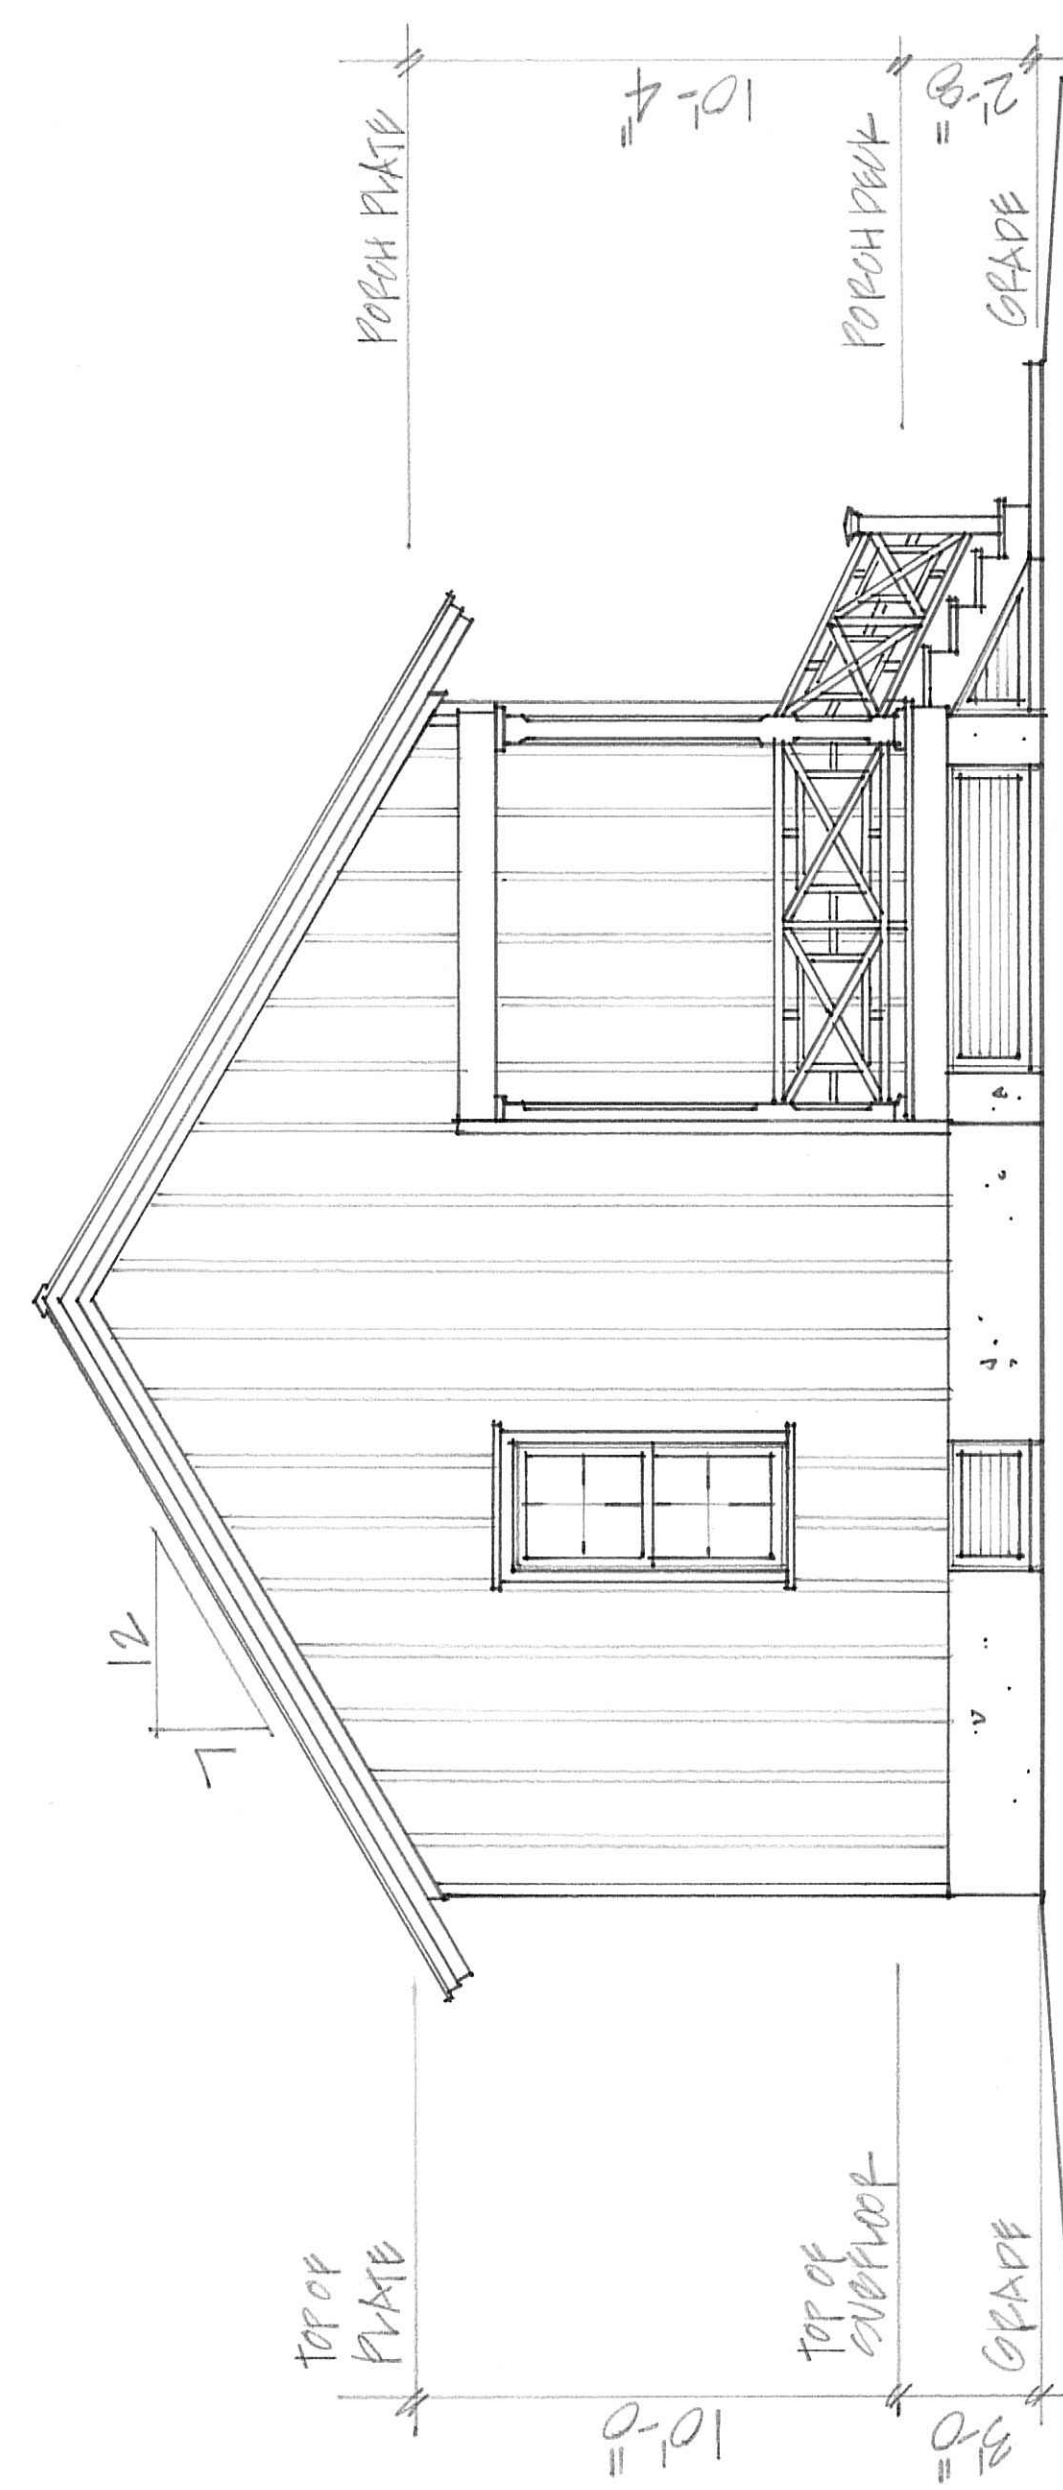


REAR ELEVATION SCALE OF $\frac{1}{4}'' = 1'-0''$

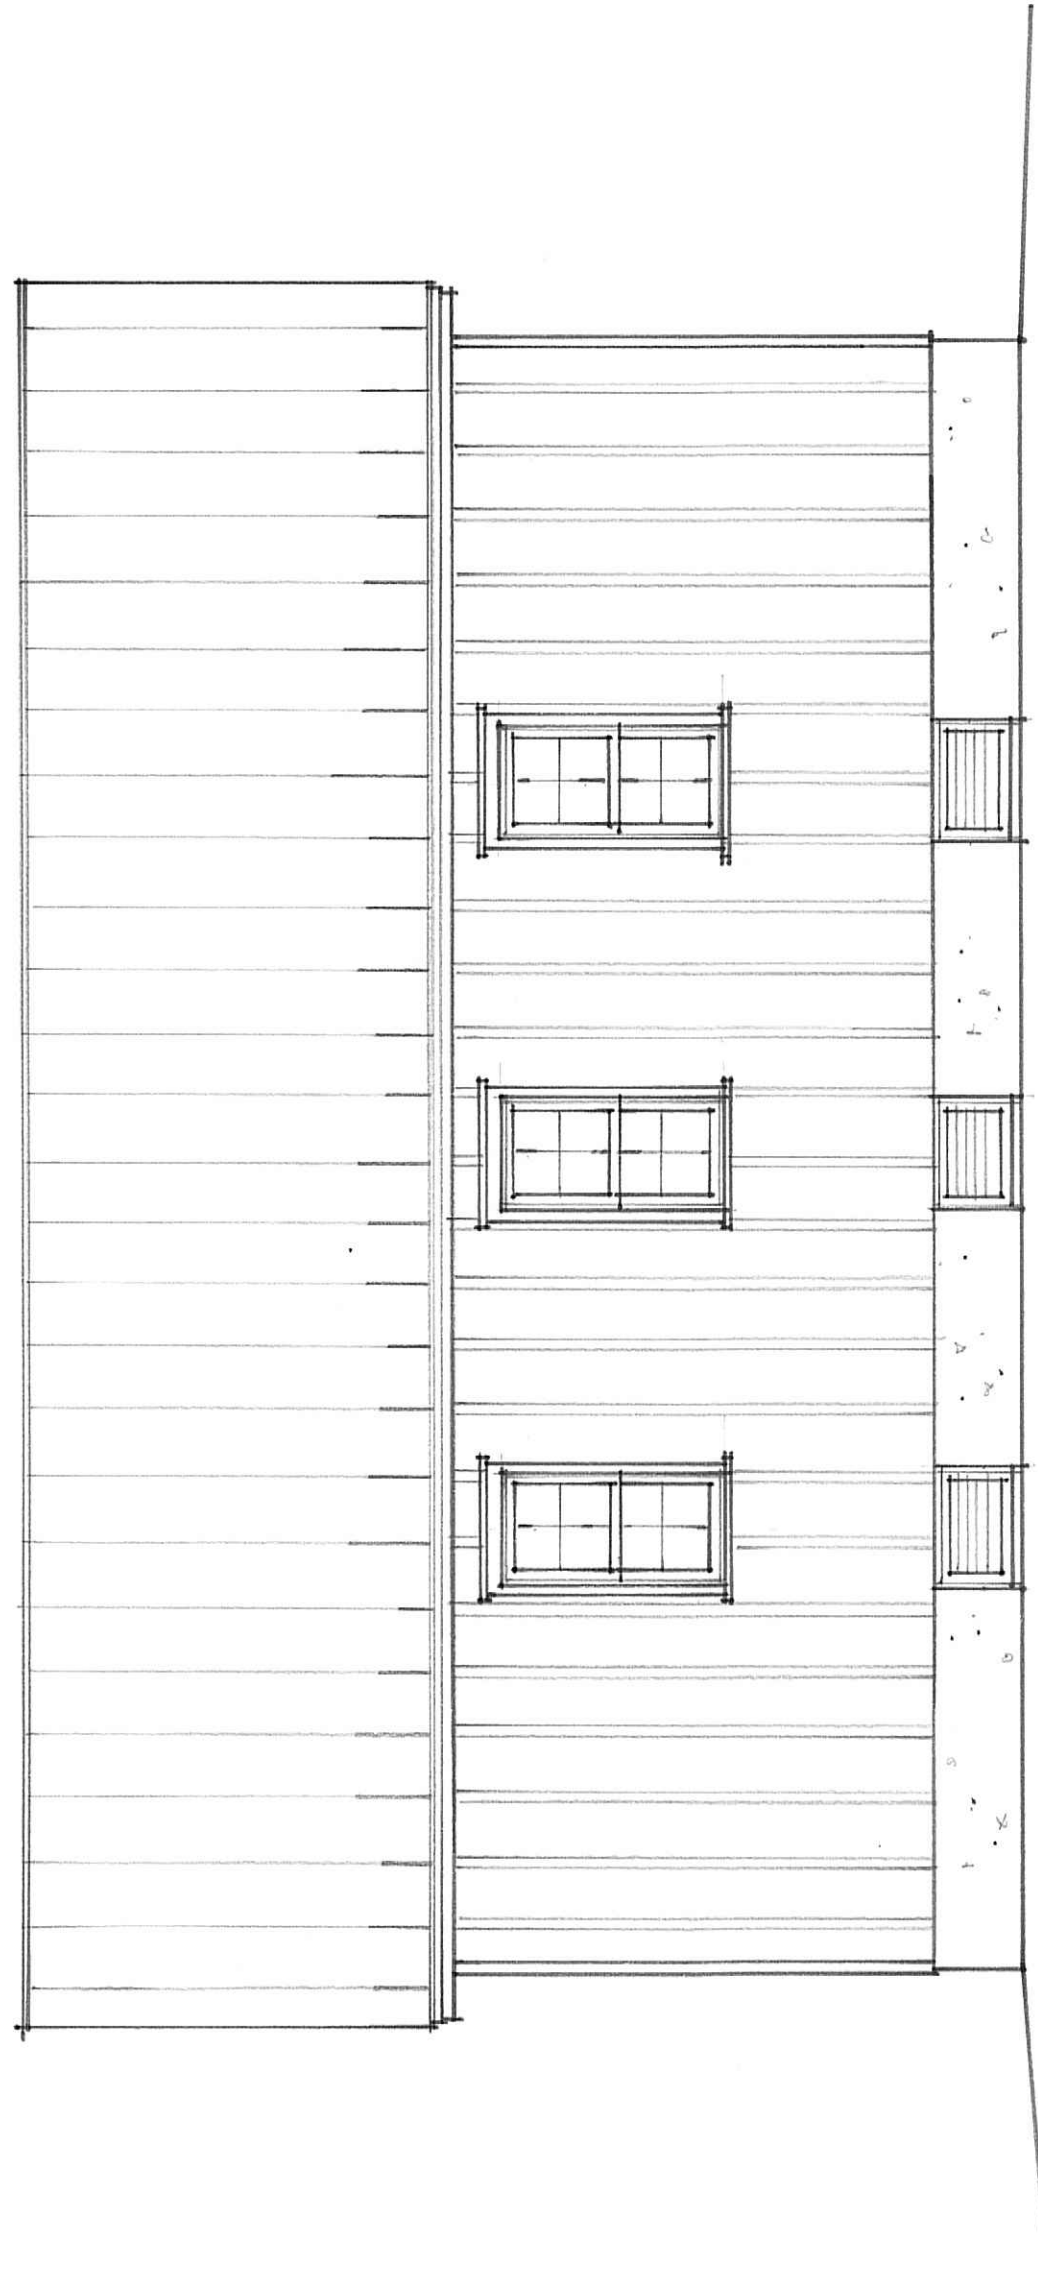

RIGHT ELEVATION SCALE OF $\frac{1}{4}'' = 1'-0''$

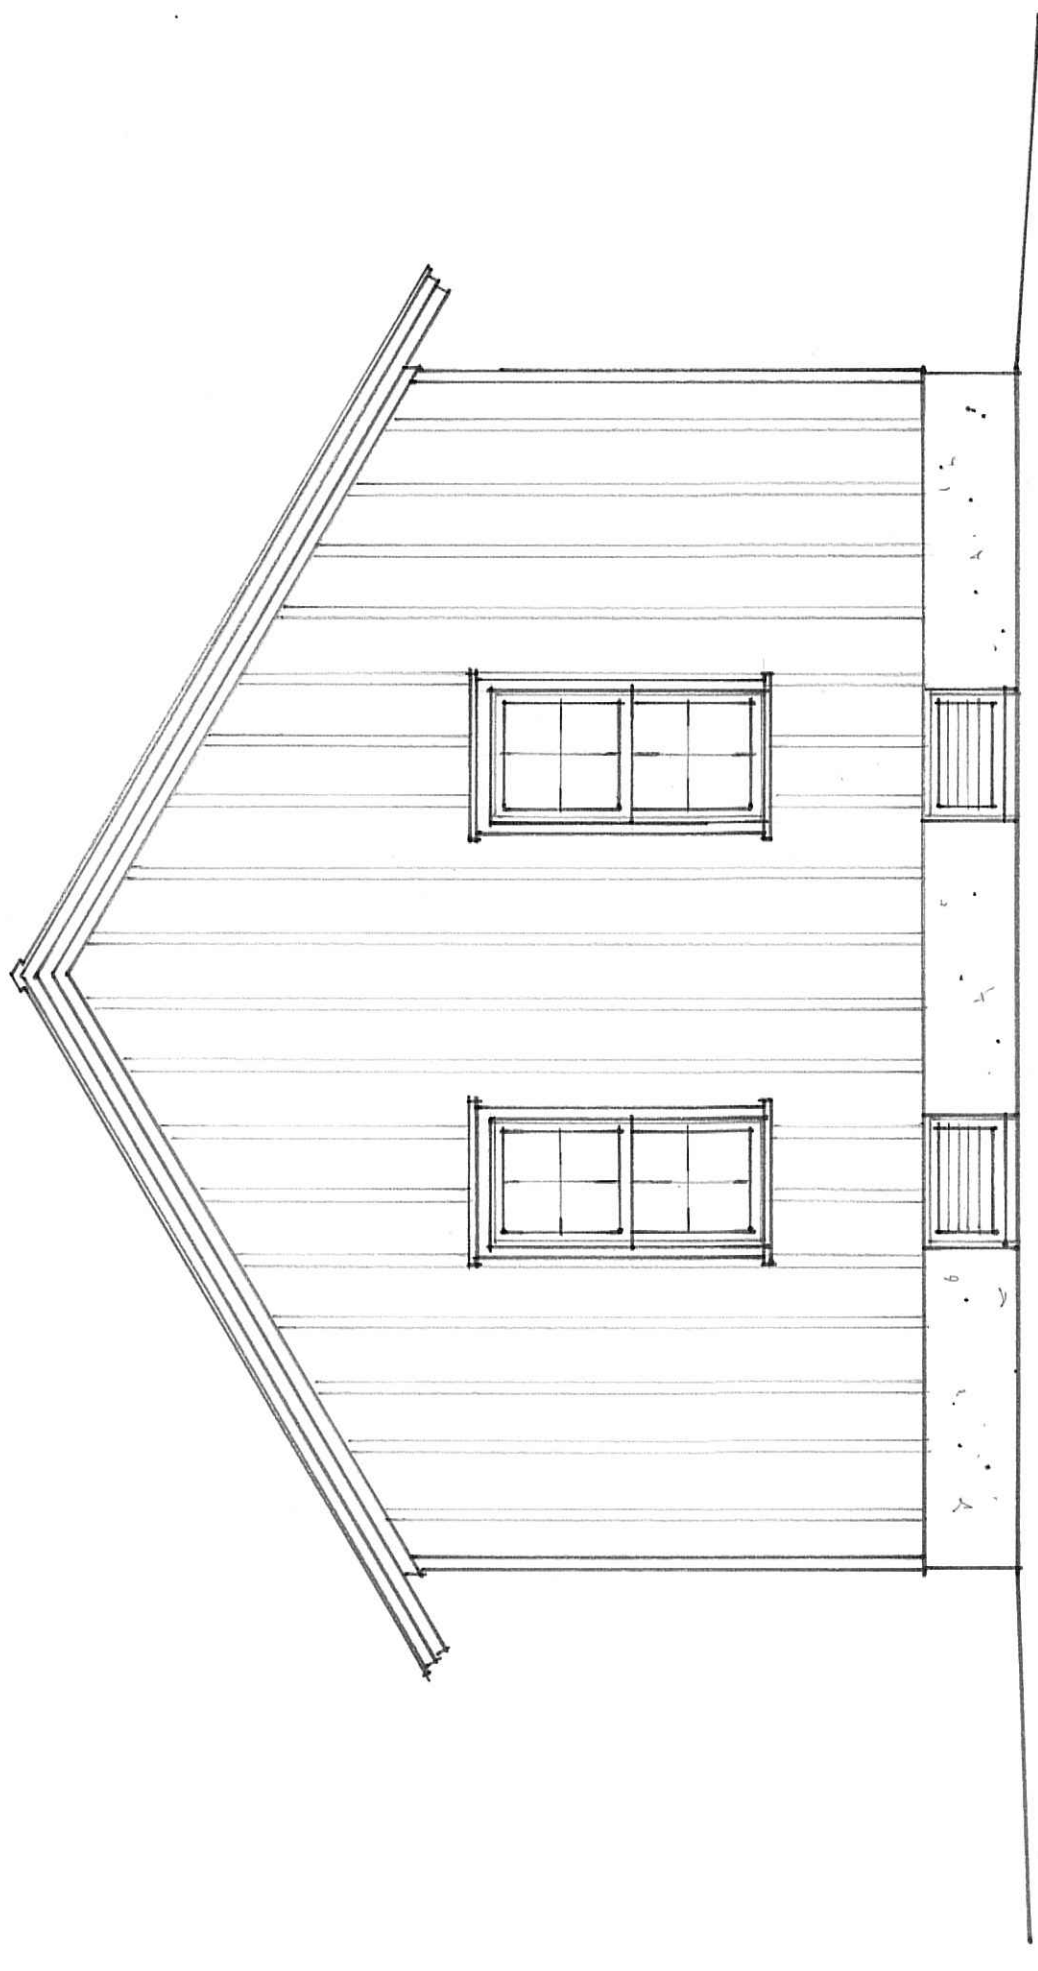

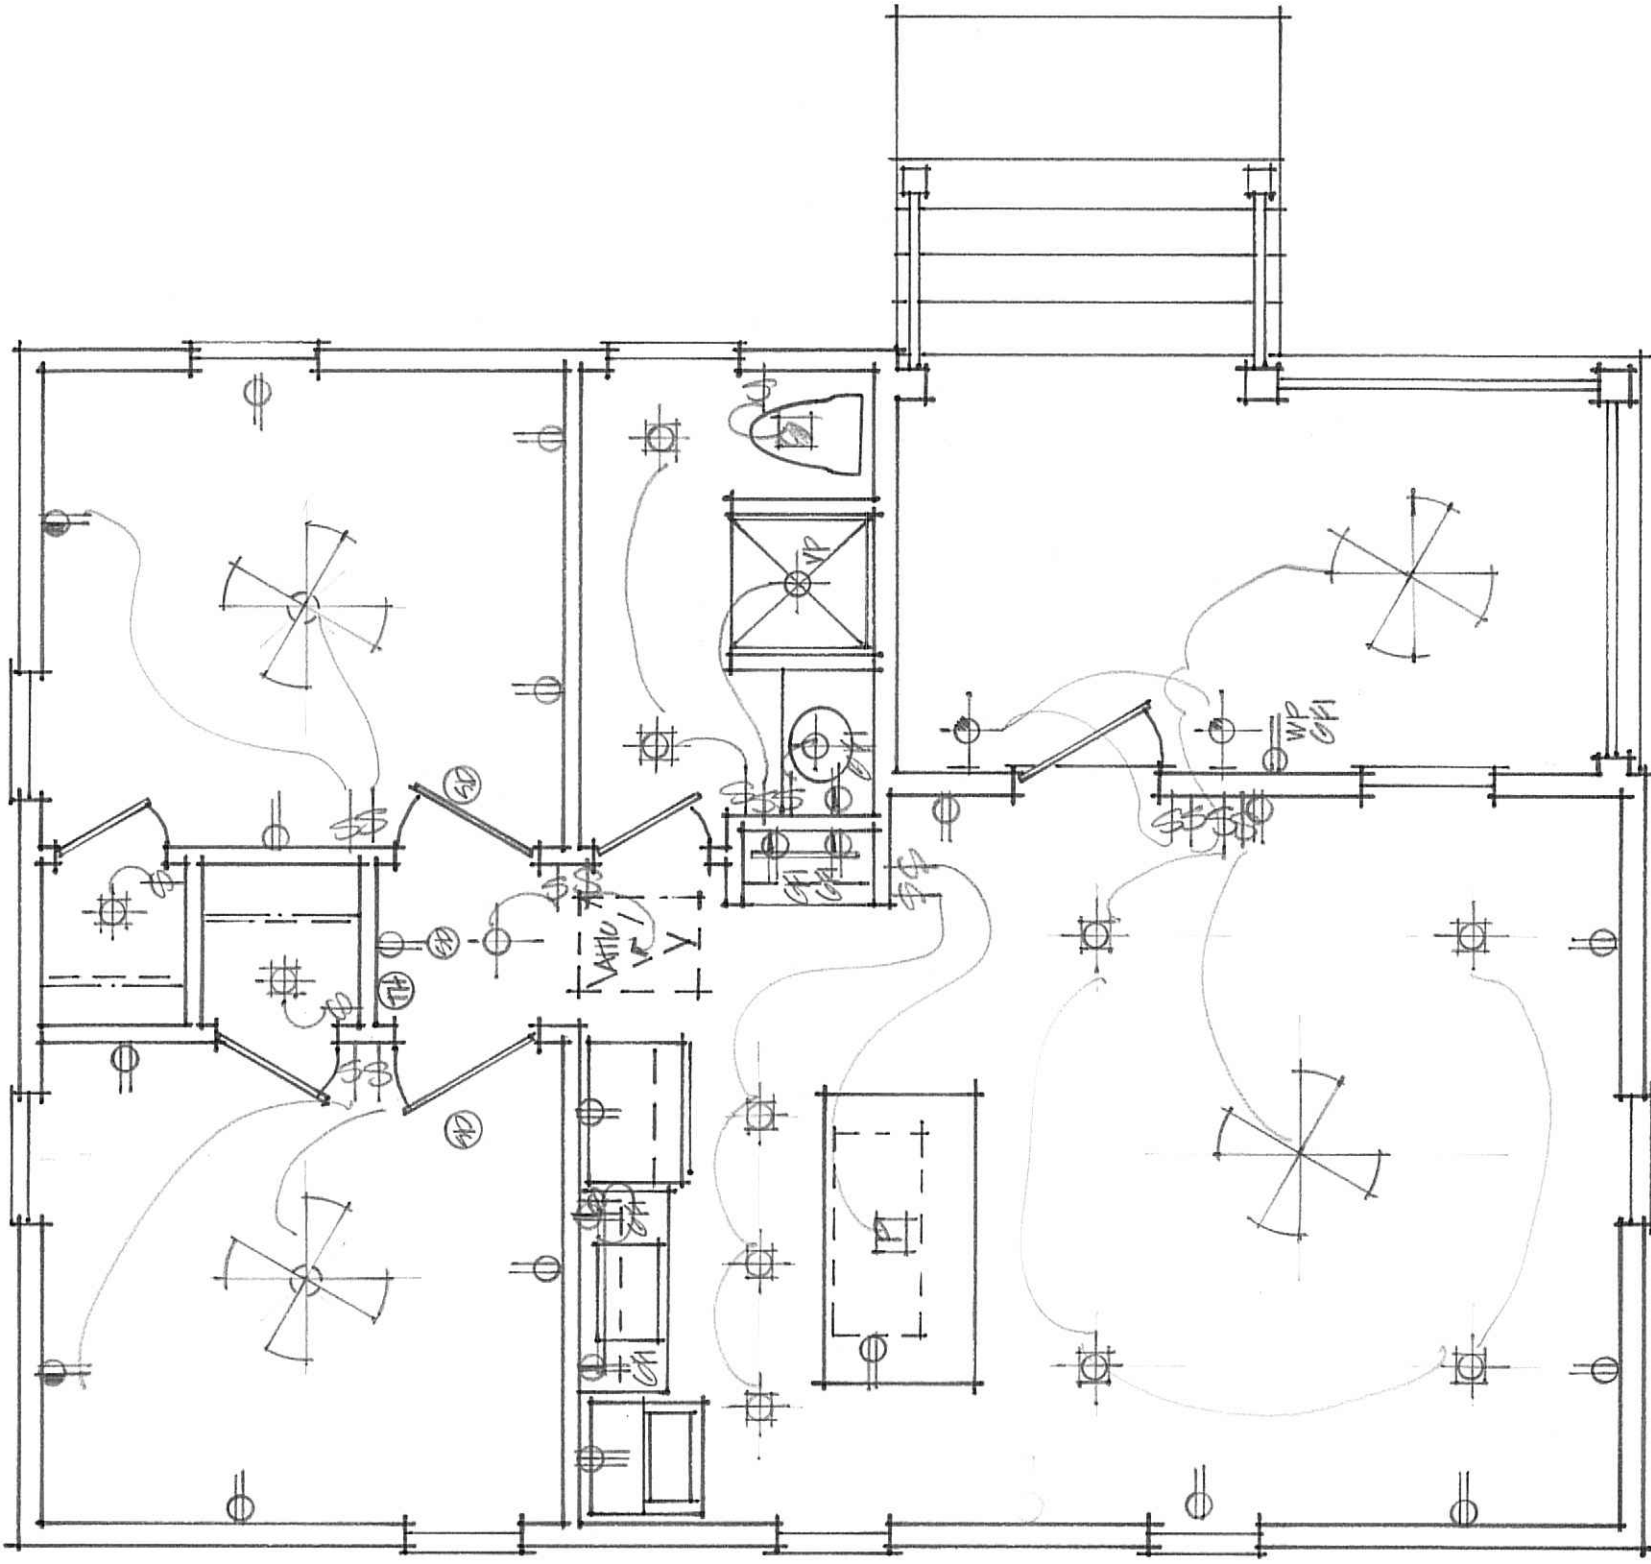

ELECTRICAL PLAN SCALE OF 1/4" = 1'-0"