



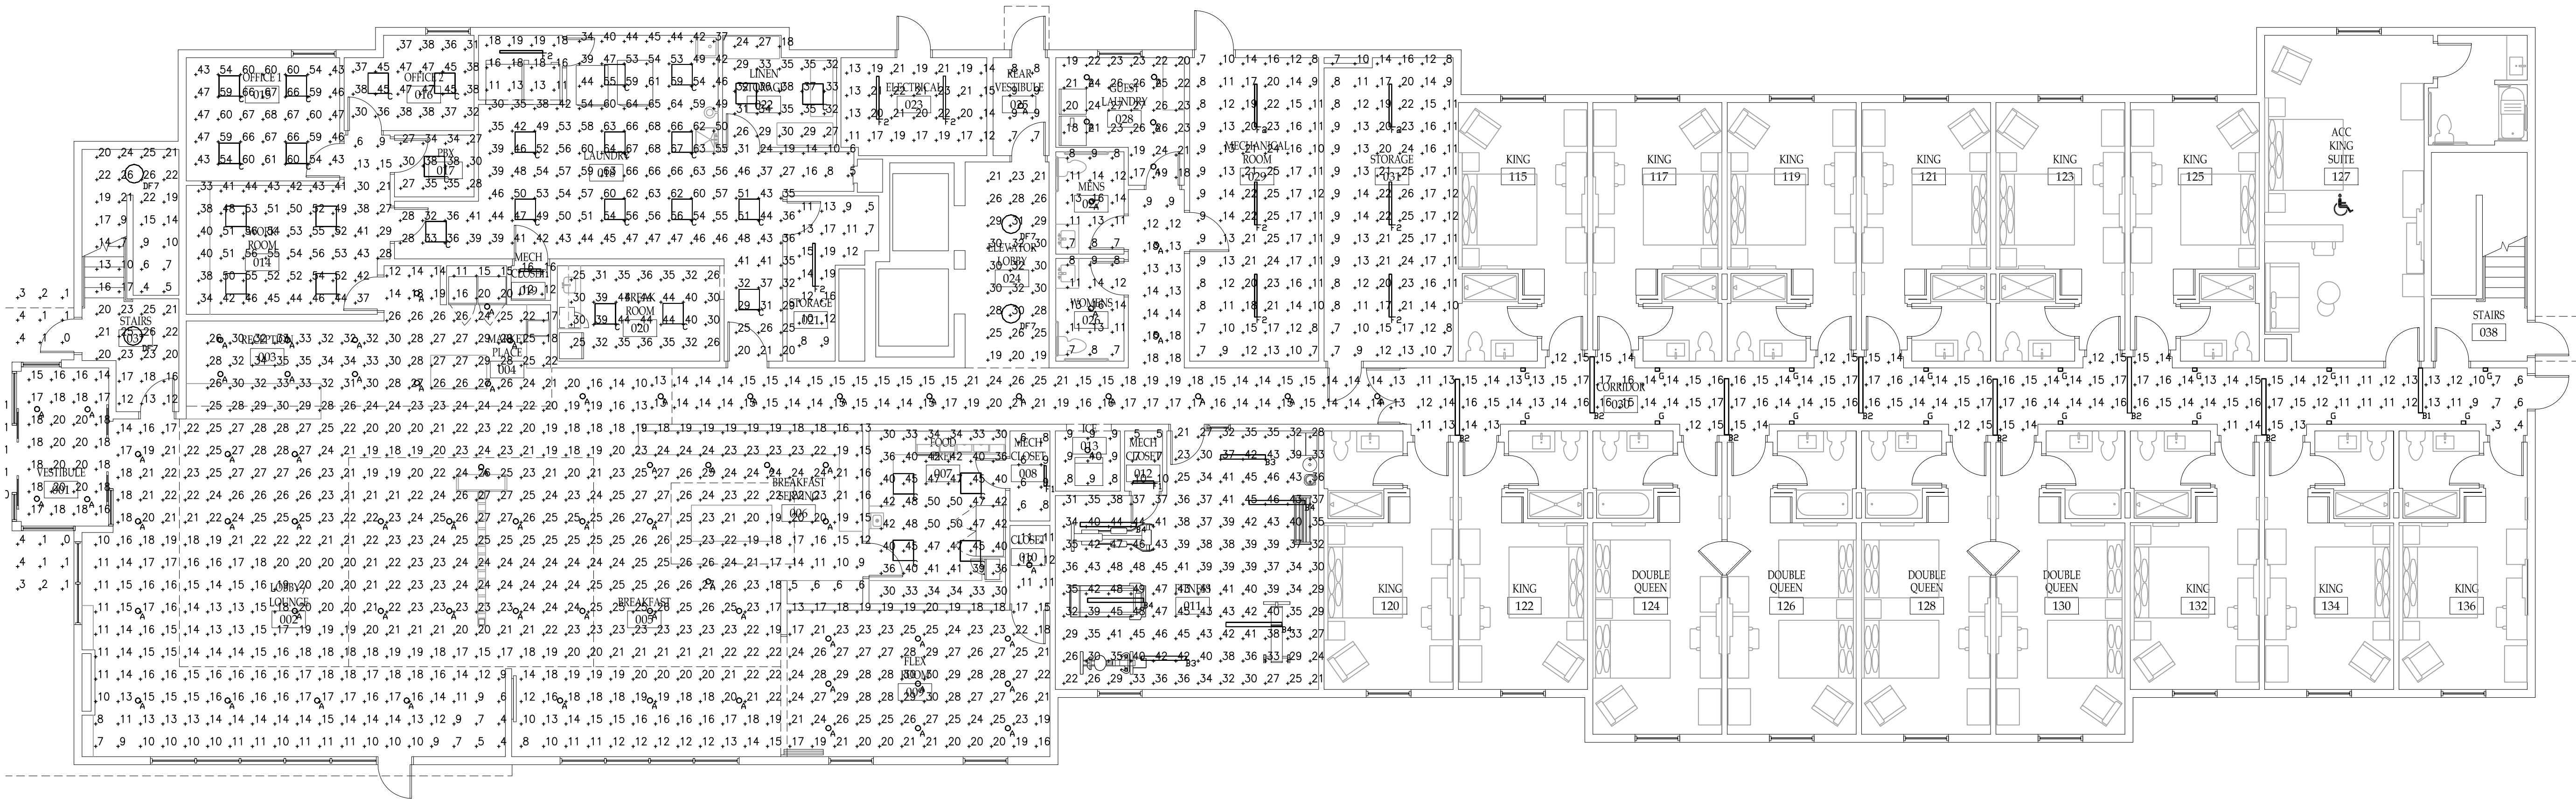

PARTIAL FIRST FLOOR
LIGHTING PHOTOMETRIC PLAN

1
LP-1

SCALE: 1/8" = 1'-0"

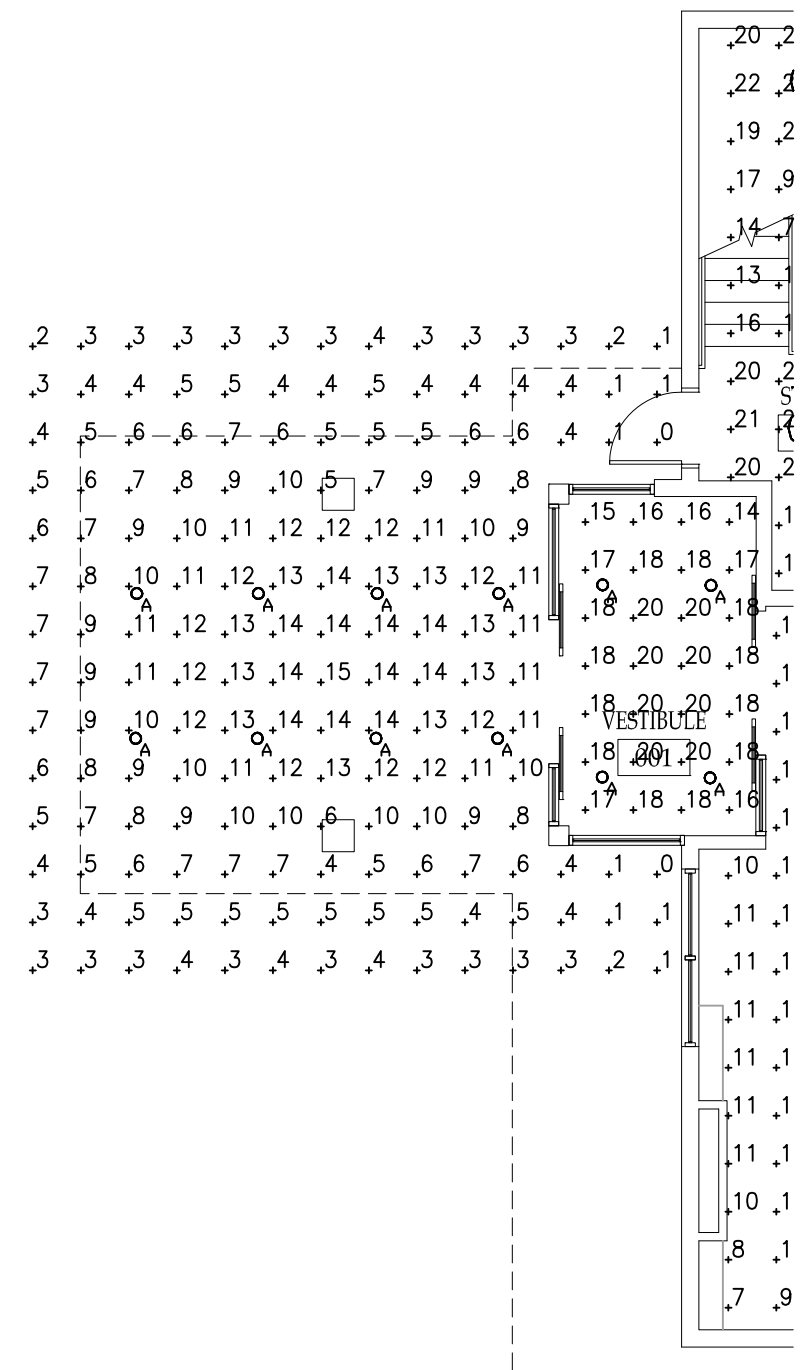

PARTIAL FIRST FLOOR
LIGHTING PHOTOMETRIC PLAN

2
LP-2

SCALE: 1/8" = 1'-0"

Luminaire Schedule					
Symbol	Label	Manufacturer	Catalog	Lamp Output	Input Power
○	A	Juno Lighting	6RLD G4 10LM 30K 90CRI 120 FRPC WWH MG	1081	12
	B1	LumenWerx	VASPD-HLO-FH-SW-80-350-30-4FT - GRID CEILING	1400	11
	B2	LumenWerx	VASPD-HLO-FH-SW-80-350-30-5FT - GRID CEILING	1400	14
	B3	LumenWerx	VASPD-HLO-FH-SW-80-1000-30-4FT - GYP CEILING	4000	34
	B4	LumenWerx	VASPD-HLO-FH-SW-80-1000-30-5FT - GYP CEILING	4000	42
□	C	Lithonia Lighting	CPX 2X2 3200LM 80 35K SWL MVOLT	3668	30
○	DF7	Brownlee Lighting Inc	2080-20-R49-35K	3797	45
	F1	Lithonia Lighting	CSS L24 2000LM MVOLT 40K 80CRI	2151	15
	F2	Lithonia Lighting	CSS L48 4000LM UVOLT 40K 80 CRI	4819	38
□	G	Brownlee Lighting Inc	1345-B12-35K	1161	3

Statistics						
Description	Symbol	Avg	Max	Min	Max/Min	Avg/Min
Claset 010	+	11 fc	12 fc	11 fc	1.1:1	1.0:1
Corridor 030 (1st Fl.)	+	14 fc	17 fc	3 fc	5.7:1	4.7:1
Corridor 239 (2nd & 3rd Fl.)	+	14 fc	18 fc	4 fc	4.5:1	3.5:1
Corridor (1st Fl.)	+	16 fc	26 fc	9 fc	2.9:1	1.8:1
Elec. 242 (2nd & 3rd Fl.)	+	14 fc	17 fc	10 fc	1.7:1	1.4:1
Electrical 023	+	18 fc	23 fc	11 fc	2.1:1	1.6:1
Elevator Lobby 024	+	27 fc	32 fc	19 fc	1.7:1	1.4:1
Elevator Lobby 243 (2nd & 3rd Fl.)	+	26 fc	32 fc	19 fc	1.7:1	1.4:1
Fitness 011	+	37 fc	49 fc	21 fc	2.3:1	1.8:1
Food Prep 007	+	40 fc	50 fc	30 fc	1.7:1	1.3:1
Guest Laundry 026	+	23 fc	27 fc	17 fc	1.6:1	1.4:1
Housekeeping 240 (2nd & 3rd Fl.)	+	17 fc	25 fc	8 fc	3.1:1	2.1:1
Ice 013 (1st Fl.)	+	9 fc	10 fc	8 fc	1.3:1	1.1:1
Ice 244 (2nd & 3rd Fl.)	+	10 fc	11 fc	7 fc	1.6:1	1.4:1
Laundry 018	+	46 fc	68 fc	5 fc	13.6:1	9.2:1
Laundry Dryer Room	+	16 fc	19 fc	11 fc	1.7:1	1.5:1
Mech. 241 (2nd & 3rd Fl.)	+	9 fc	10 fc	8 fc	1.3:1	1.1:1
Mech. Closet 008	+	7 fc	9 fc	6 fc	1.5:1	1.2:1
Mech. Closet 012	+	7 fc	10 fc	5 fc	2.0:1	1.4:1
Mech. Closet 019	+	14 fc	16 fc	12 fc	1.3:1	1.2:1
Mech. Rm. 029	+	14 fc	25 fc	7 fc	3.6:1	2.0:1
Mens 027	+	11 fc	16 fc	7 fc	2.3:1	1.6:1
Office 015	+	57 fc	68 fc	43 fc	1.6:1	1.3:1
Office 016	+	40 fc	47 fc	30 fc	1.6:1	1.3:1
PBX 017	+	32 fc	38 fc	27 fc	1.4:1	1.2:1
Porte Cochere	+	7 fc	15 fc	0 fc	N/A	N/A
Reception, Lounge, Market Place, Breakfast, Flex Rm.	+	21 fc	35 fc	4 fc	8.8:1	5.3:1
Stair 037 (1st Fl.)	+	17 fc	26 fc	4 fc	6.5:1	4.3:1
Stair 237 (2nd & 3rd Fl.)	+	22 fc	27 fc	12 fc	2.3:1	1.8:1
Stair 238 (2nd & 3rd Fl.)	+	22 fc	27 fc	14 fc	1.9:1	1.6:1
Storage 021	+	12 fc	19 fc	5 fc	3.8:1	2.4:1
Storage 031	+	14 fc	26 fc	7 fc	3.7:1	2.0:1
Storage 032	+	31 fc	38 fc	18 fc	2.1:1	1.7:1
Vestibule 001	+	18 fc	20 fc	14 fc	1.4:1	1.3:1
Vestibule 025	+	8 fc	9 fc	7 fc	1.3:1	1.1:1
Womens 026	+	11 fc	16 fc	7 fc	2.3:1	1.6:1
Work Room 014	+	43 fc	56 fc	6 fc	9.3:1	7.2:1
Break Rm. 020	+	35 fc	44 fc	25 fc	1.8:1	1.4:1

NOTICE

This document, the property of, prepared and issued by the architect, is submitted for the specific project namely _____ and the recipient by accepting this document assumes custody and agrees that this document will not be copied or reproduced in part or in whole, and any special features peculiar to this design shall not be incorporated in any other project, unless prior agreement has been obtained in writing. These documents will be returned immediately upon completion of the project or upon the request of the architect.

This document is the exclusive property of the architect, no rights to ownership are transferable, or shall be lost by the filing of this document with any and all public authorities for the purpose of compliance with Codes and or Ordinances, i.e. Building Permit, etc.

Comfort Inn
& Suites
PROPERTY ID: RI043
Gooding Avenue
Bristol, RI 02809

ISSUE:

SA PROJECT TEAM: PRINCIPAL P.Silvestri
PROJ. ARCH. _____ DRAFTER _____
JOB CAPT. _____ INTERIORS _____

SEAL:

TITLE:
FIRST FLOOR
LIGHTING
PHOTOMETRIC
PLAN



SILVESTRI
ARCHITECTS • PC

1321 MILLERSPORT HWY PH. 716.691.0900
AMHERST, NY 14221 FAX 716.691.4773

SA JOB #:
20038.01

DATE:

DRAWING #:
LP-1