

ENGINEERING & DESIGN
 CIVIL ENGINEERING ~ LAND PLANNING
 DEVELOPMENT SERVICES
 LANDSCAPE ARCHITECTURE


2005 BROADWAY
 VANCOUVER, WA 98663
 PHONE (360)993-0911
 FAX (360)993-0912



PRELIMINARY STREET, STORMWATER AND UTILITY PLAN
LACAMAS COUNSELING CENTER
 WASHINGTON
 CITY OF CAMAS

DESIGNED BY:	SAT, SEM
DRAWN BY:	SAT, SEM
CHECKED BY:	KRS
SCALE:	1" = 10'

JOB NUMBER 5023 SHEET PRE4.0

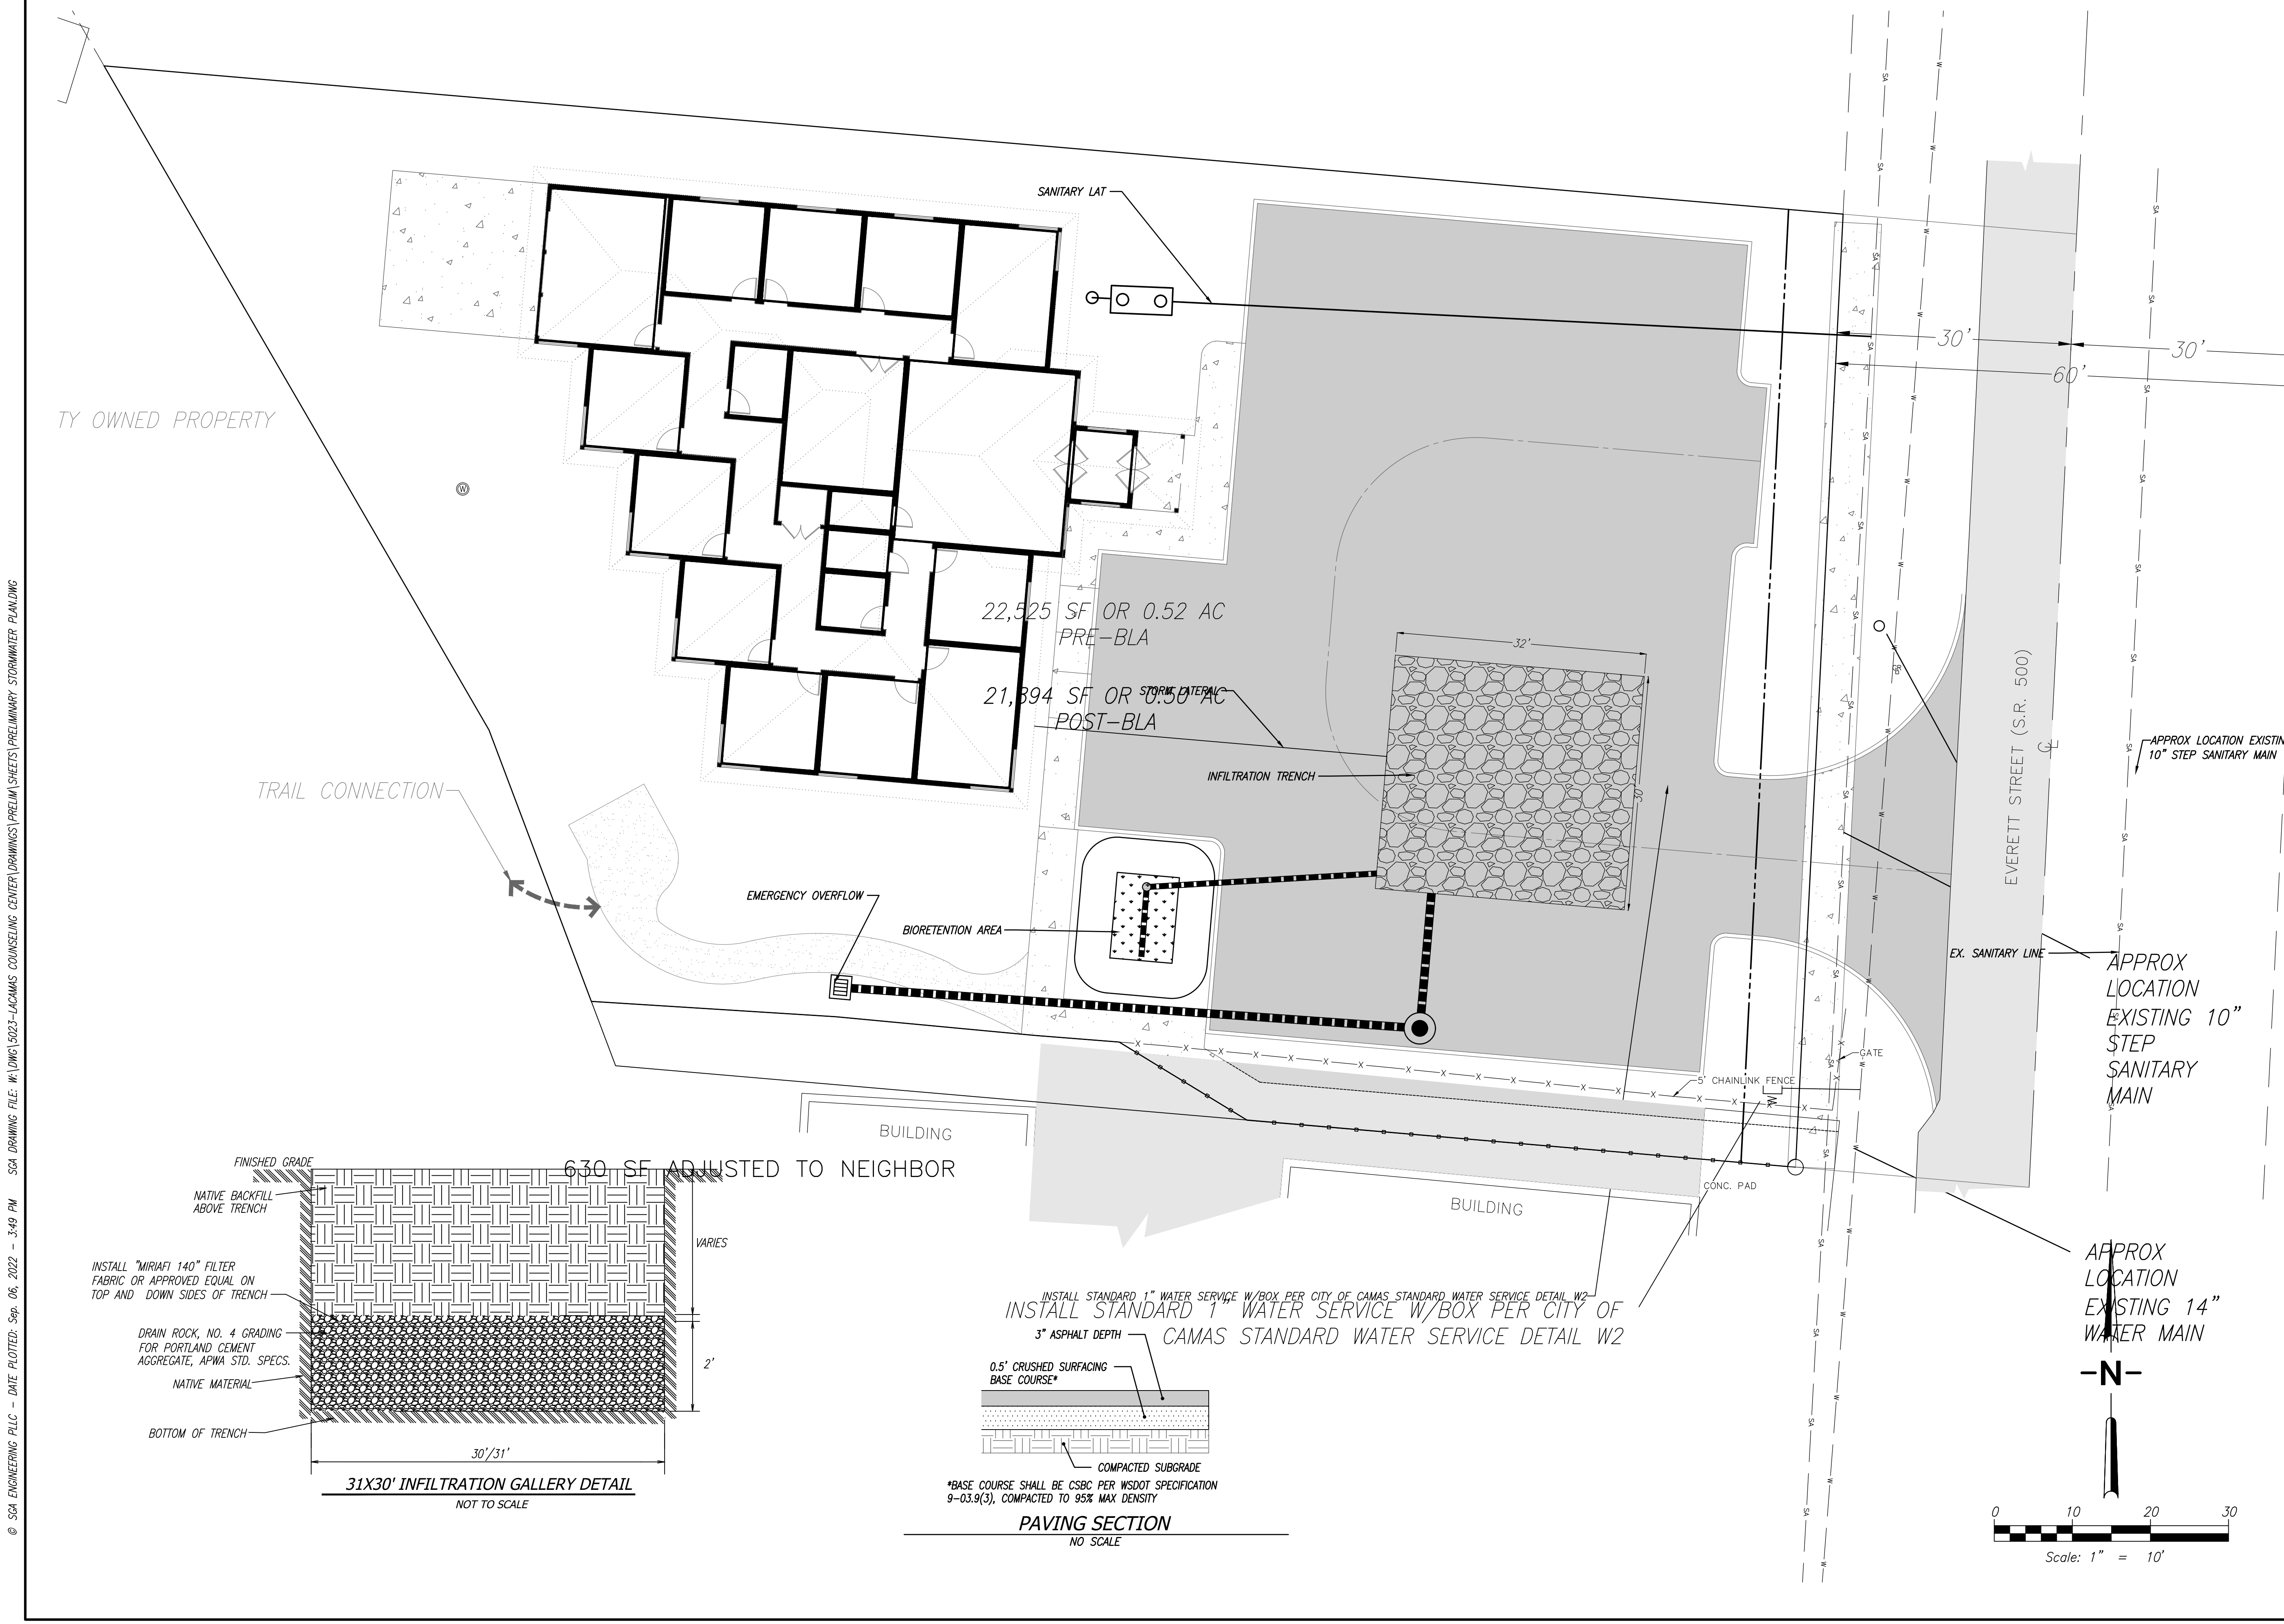

© SCA ENGINEERING PLLC - DATE PLOTTED: Sep. 06, 2022 - 3:49 PM SCA DRAWING FILE: W:\DWG\5023-LACAMAS COUNSELING CENTER\DRAWINGS\PRELIM\SHEETS\PRELIMINARY STORMWATER PLAN.DWG