


**WILSON**  
ARCHITECTS, PLLC  
404 E 15TH ST. #7  
VANCOUVER, WA.  
98663  
(360) 696-4722

11895 REGISTERED ARCHITECT  
RYAN C WILSON  
STATE OF WASHINGTON

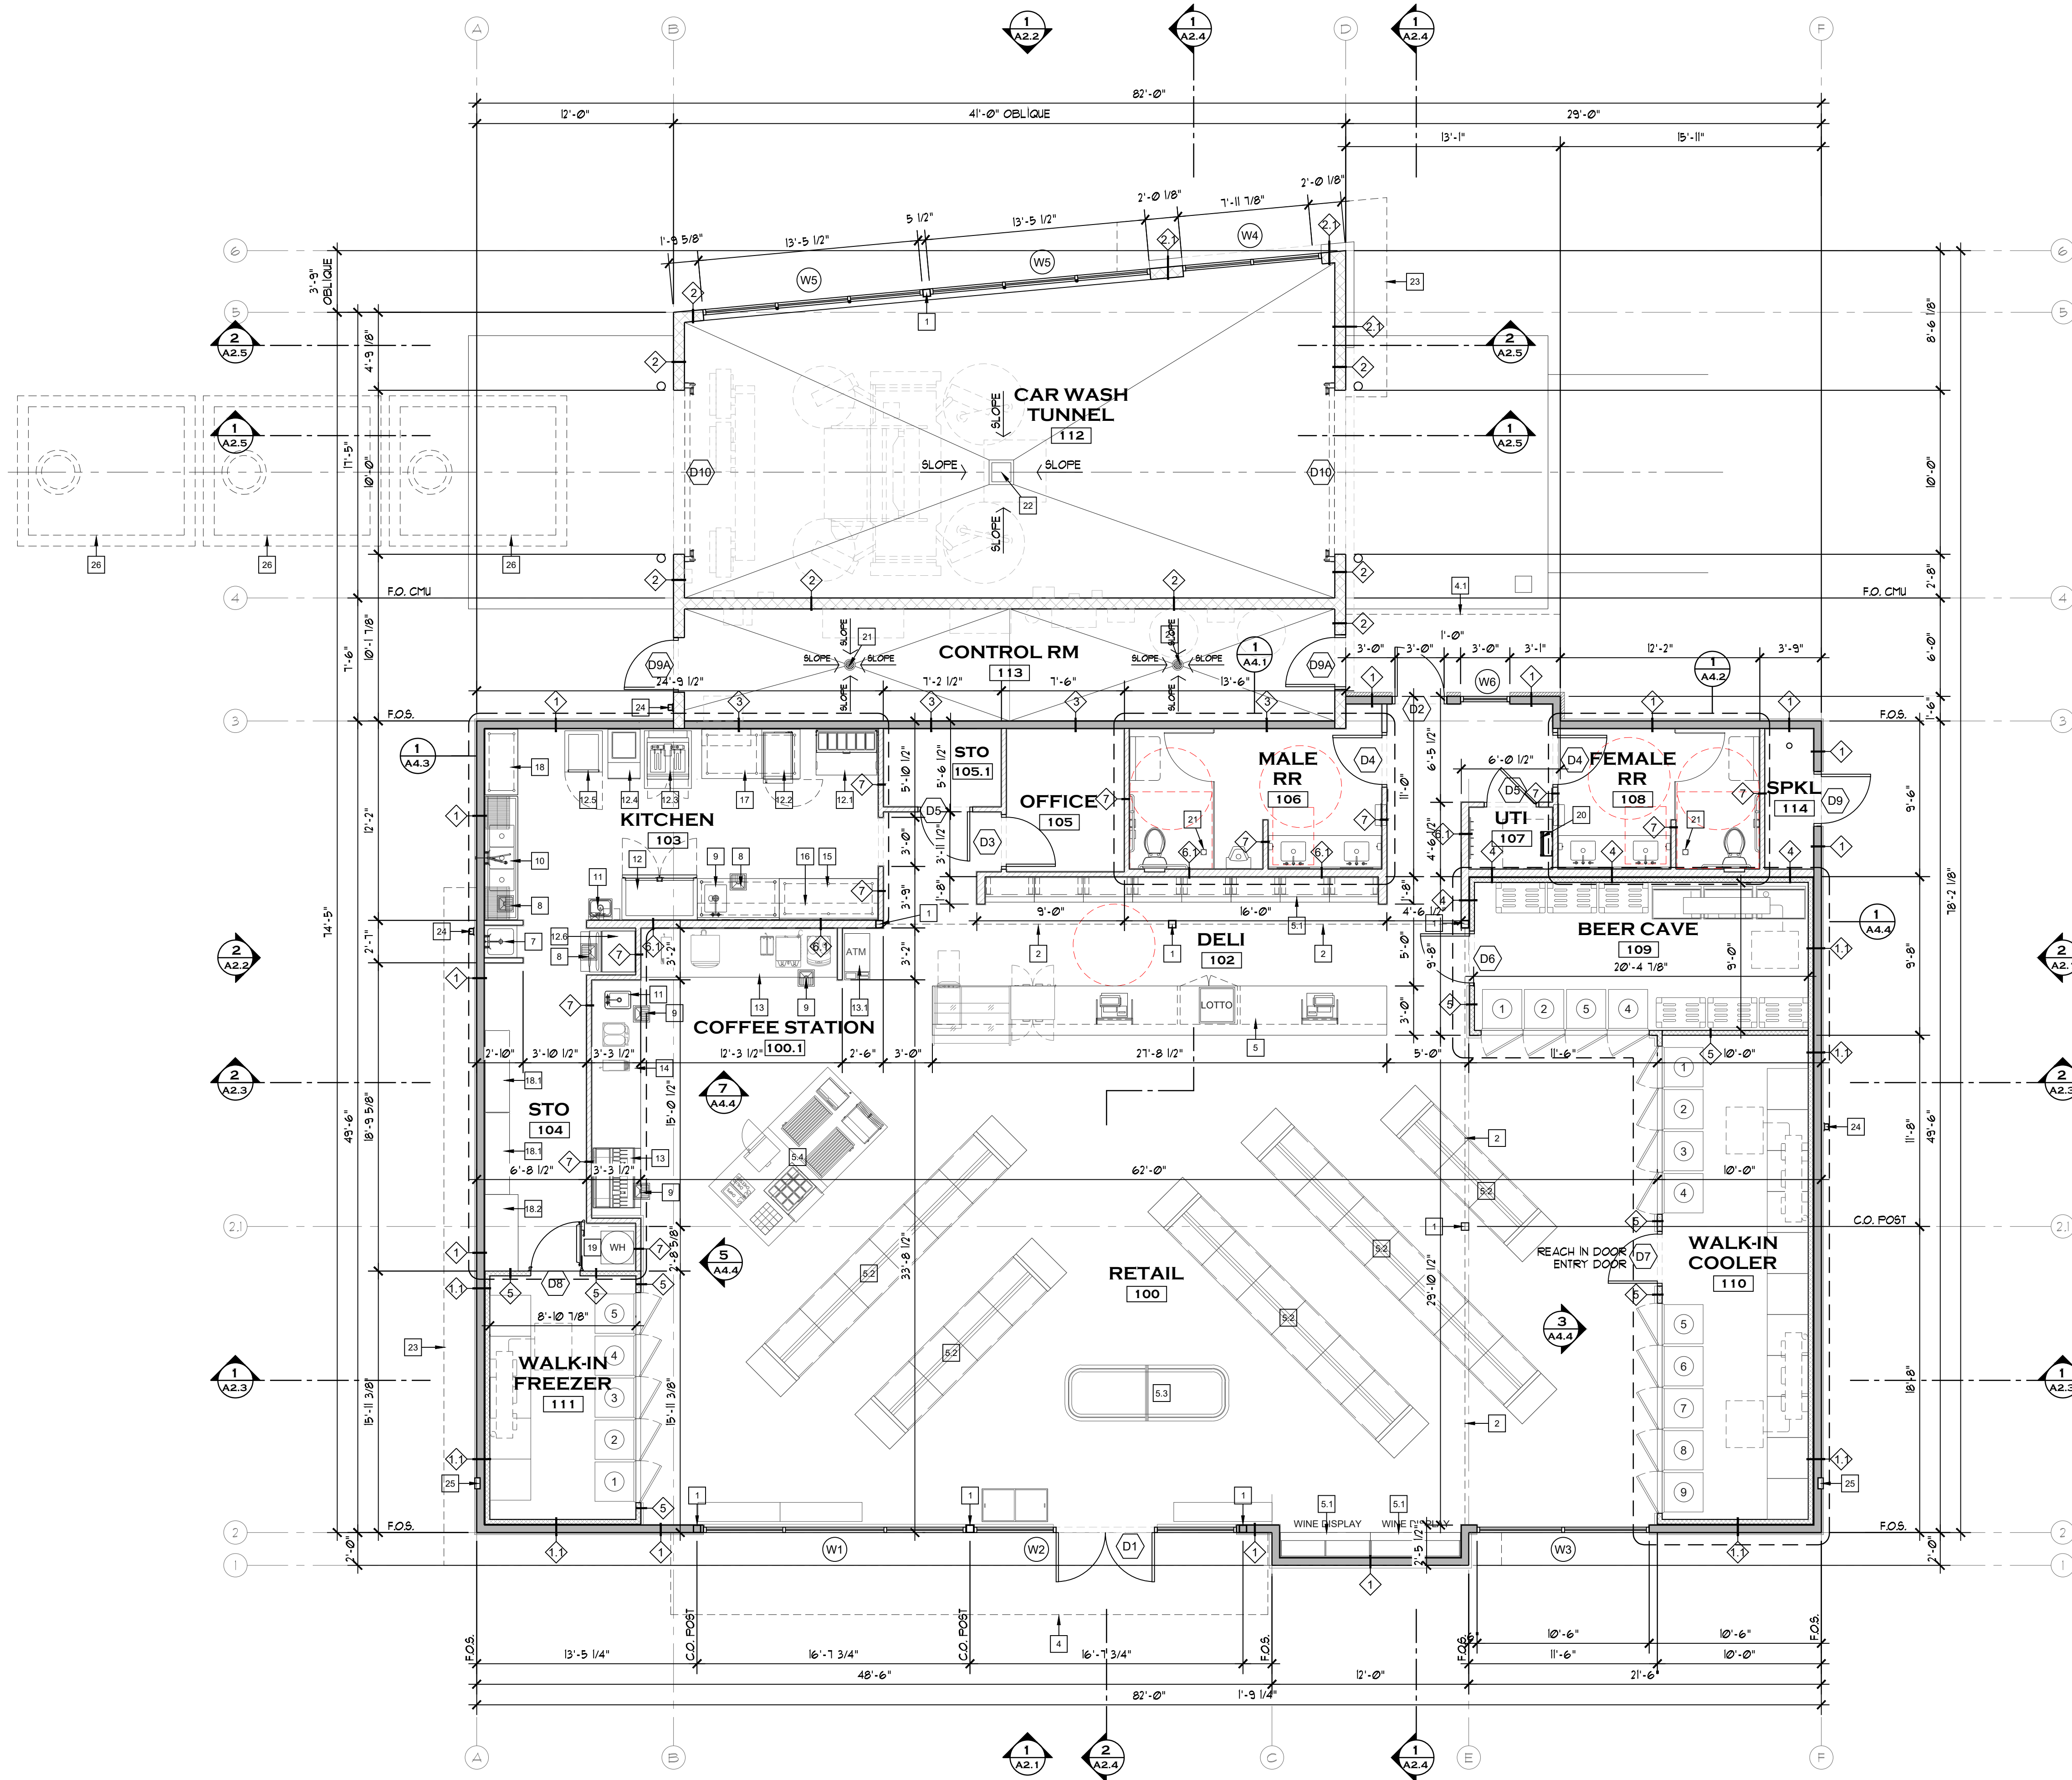

**FLOOR PLAN**  
SCALE: 3/16" = 1'-0"

- KEY NOTES**
- 1 STEEL POST PER STRUCT'L
  - 2 BEAM PER STRUCT'L
  - 3 ELECTRIC PANEL SEE ELECT'L DRAWING
  - 4 CANOPY TYPE 1
  - 4.1 CANOPY TYPE 2
  - 5 CABINET COUNTER WITH POS, LOTTO AND DISPLAY DELI
  - 5.1 DISPLAY CABINET
  - 5.2 GONDOLA
  - 5.3 GRAB AND GO
  - 5.4 HOT CASE FOOD STATION
  - 6 NOT USED
  - 7 MOP SINK
  - 8 FLOOR SINK
  - 9 PREP SINK
  - 10 3 COMPARTMENT SINK
  - 11 HANDWASH SINK
  - 11.1 DROP-IN SINK
  - 12 56" FREEZER
  - 12.1 PIZZA PREPARATION REFRIGERATOR
  - 12.2 MULTI-COOK OVEN
  - 12.3 VENTLESS FRYER
  - 12.4 BREAD AND BATTER STATION
  - 12.5 REACH-IN REFRIGERATOR
  - 12.6 ICE MAKER CUBE-STYLE
  - 13 SODA ICE & BEVERAGE DISPENSER
  - 13.1 ATM MACHINE
  - 14 DRINKING FOUNTAIN BAR STATION
  - 15 30"x60" WORKING TABLE
  - 16 SHELVING WALL MOUNTED
  - 17 36"x44" WORKING TABLE
  - 18 24"x60" WORKING TABLE
  - 18.1 WIRE SHELVING
  - 18.2 BAG IN BOX STYRUP TANK RACK
  - 19 WATER HEATER
  - 20 ROOF HATCH WITH FIXED LADDER
  - 21 FLOOR DRAIN
  - 22 FLOOR DRAIN (CARWASH TUNNEL)
  - 23 ROOF LINE
  - 24 DOWNSPOUT
  - 25 8 1/2"x8 1/4" STAINLESS STEEL HOSE BIBB SEE DETAIL 3/A14
  - 26 UNDERGROUND TANK

- GENERAL NOTES**
1. ALL INTERIOR DIMENSIONS ARE TO FACE OF STUD UNLESS NOTED OTHERWISE.
  2. ALL DENOTED DIMENSIONS ARE TO BE USED. PLANS SHALL NOT BE SCALED.
  3. EXTERIOR WALLS ARE 2"x6" STUD, INT SHEAR WALLS ARE 2"x6" #10" O.C. UNLESS NOTED OTHERWISE, SEE STRUCTURAL.
  4. SEE PLUMBING DRAWINGS FOR DIMENSIONS TO PLUMBING FIXTURES.
  5. LOCATION OF (N) KNOX BOX, VERIFY EXACT LOCATION WITH FIRE MARSHALL PRIOR TO INSTALLING.
  6. ELECTRICAL PLAN SEE ELECTRICAL DUG'S.
  7. MECHANICAL PLAN SEE MECHANICAL DUG'S.
  8. WALL ASSEMBLY SEE DUG AT1
  9. DOOR SCHEDULE SEE DUG A8J
  10. WINDOW SCHEDULE SEE DUG A9J
  11. EQUIPMENT SCHEDULE SEE DUG A3.4
  12. FINISH SCHEDULE SEE DUG A10I

**13th Street Site Plan**

DATE	SCALE
05-10-23	
JOB NO. 222	DRAWN BY RGM
REVISIONS:	
1	
2	
3	
4	
5	
6	
7	
8	
9	
10	

**A3.1**  
FLOOR PLAN.  
KEY NOTES

