
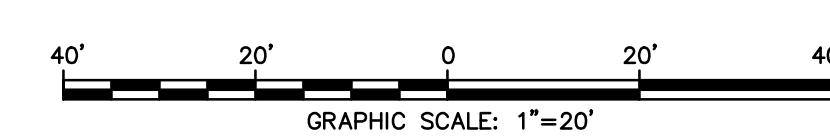
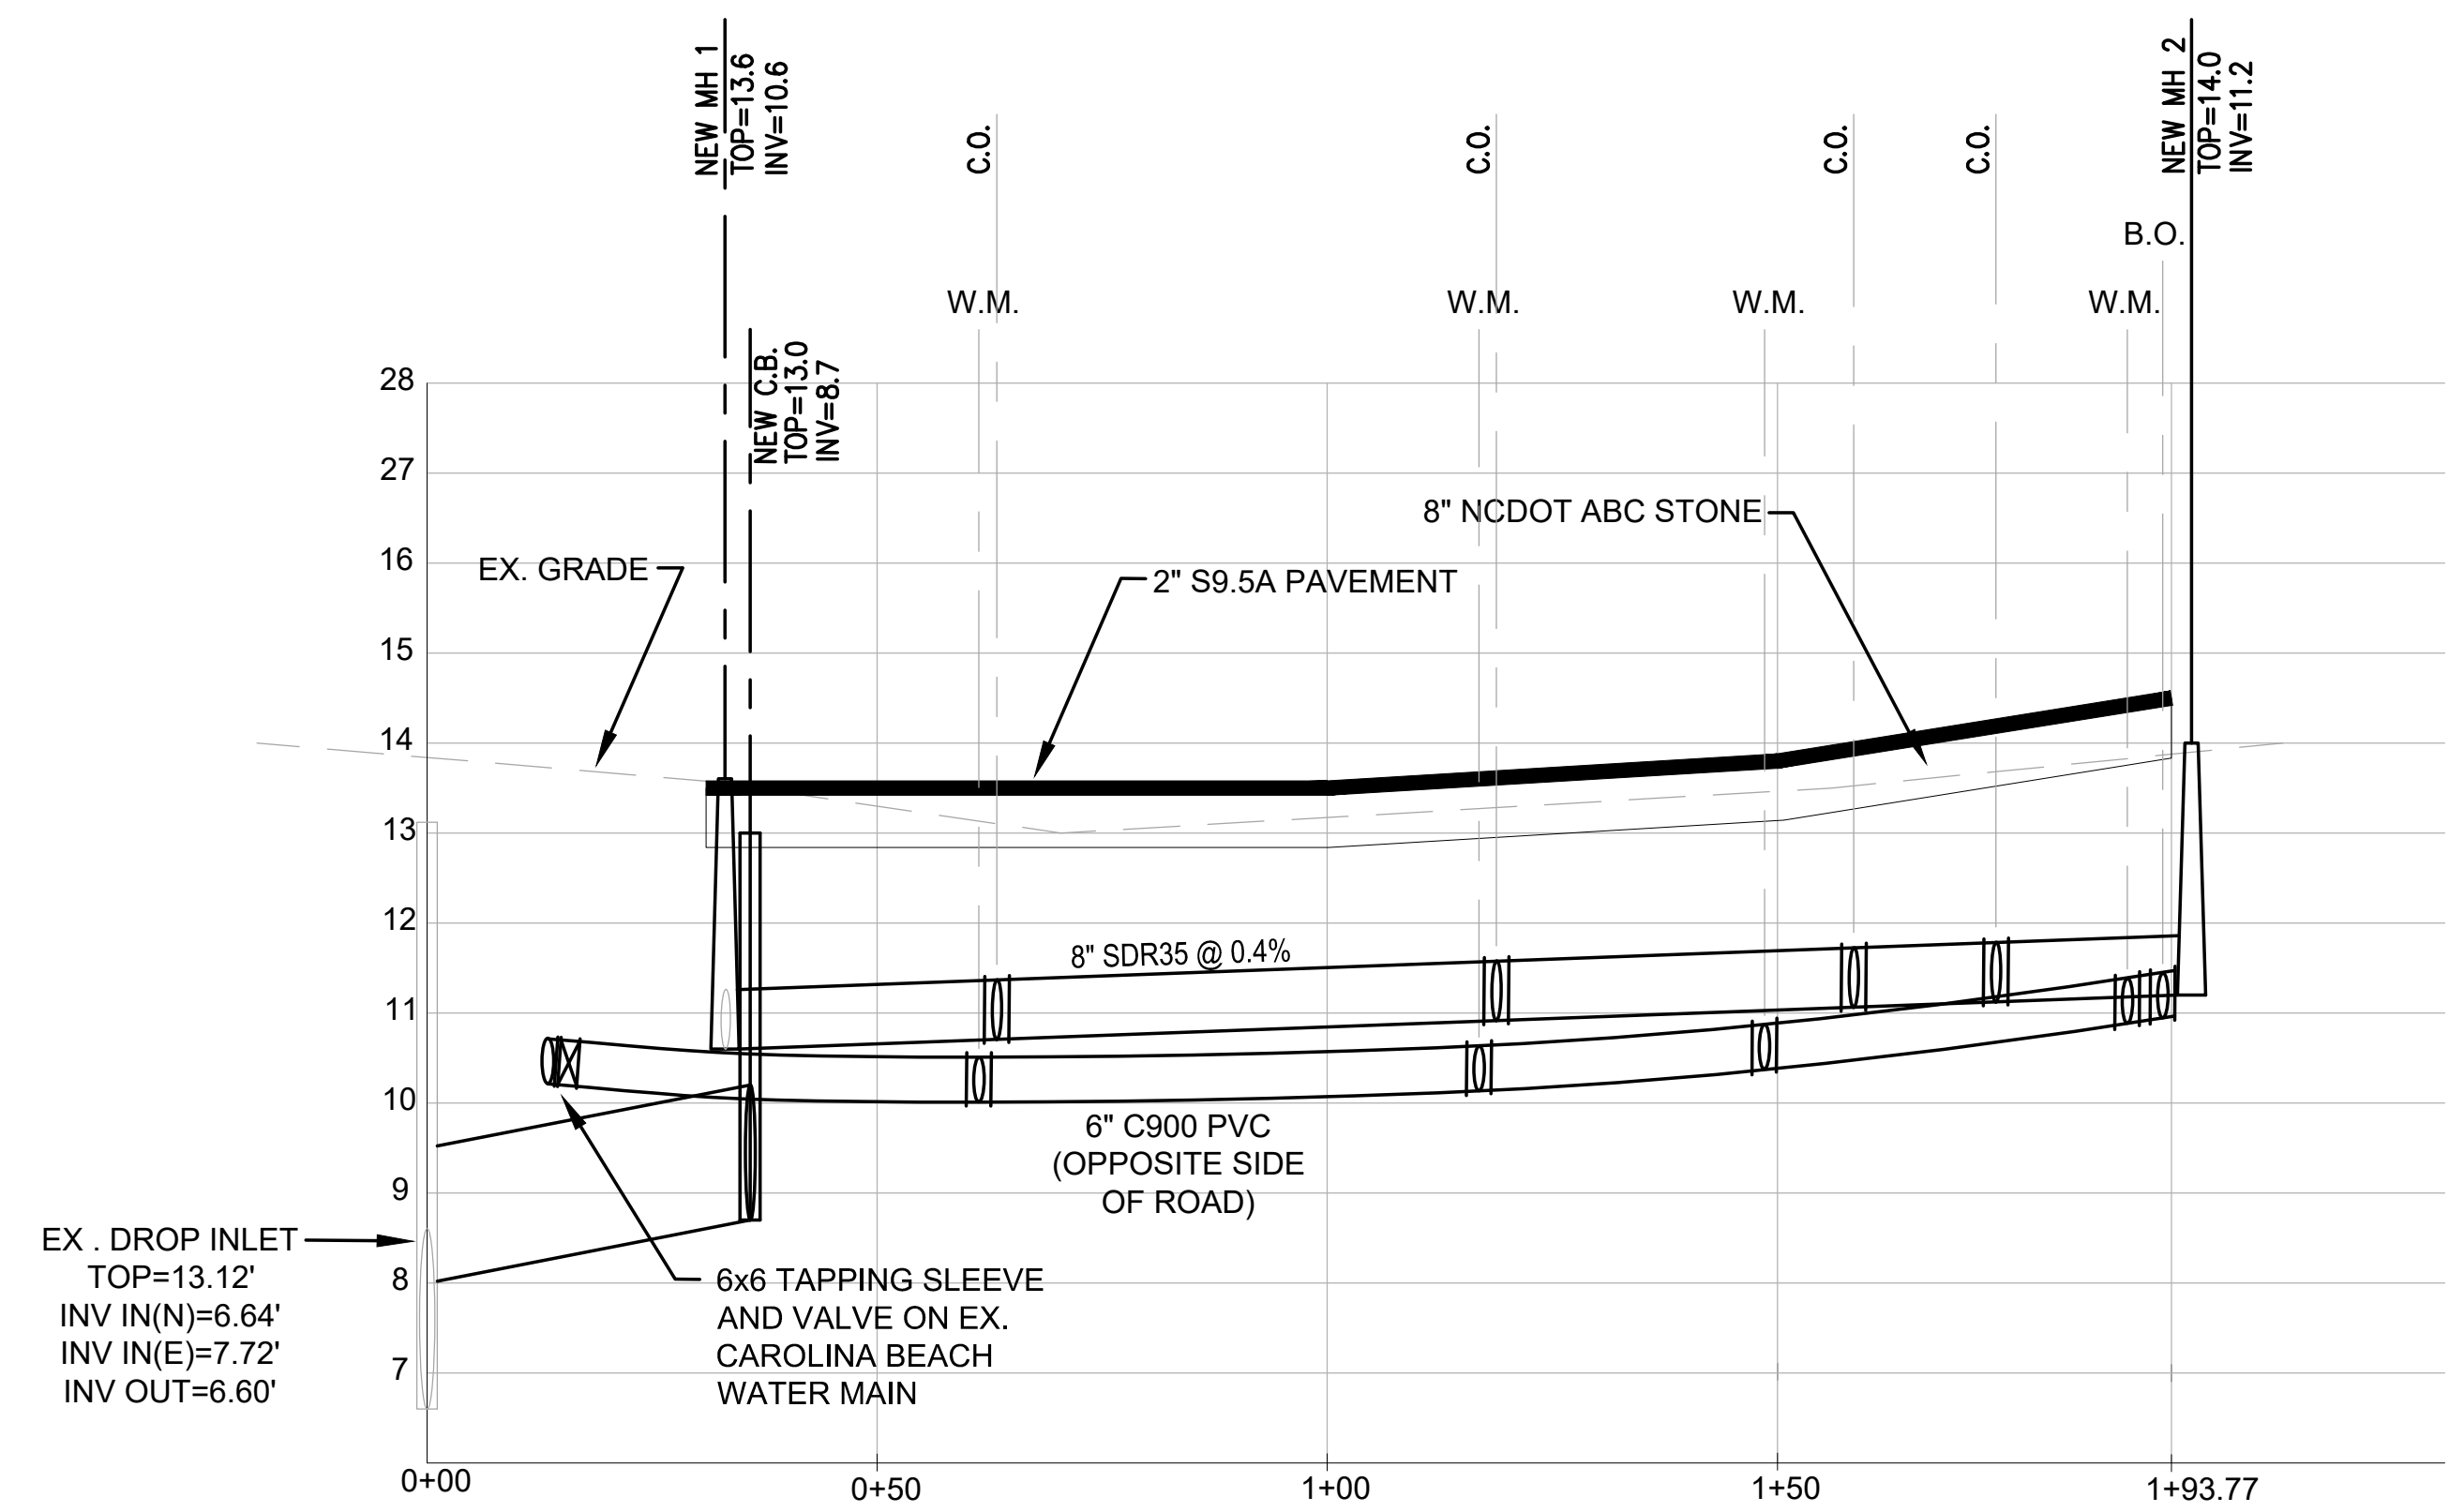


**UTILITY LEGEND**

- CO CLEAN OUT
- ⊗ WATER VALVE
- ⊙ WATER METER
- B.O. BLOW OFF
- ⊕ NEW SEWER MANHOLE

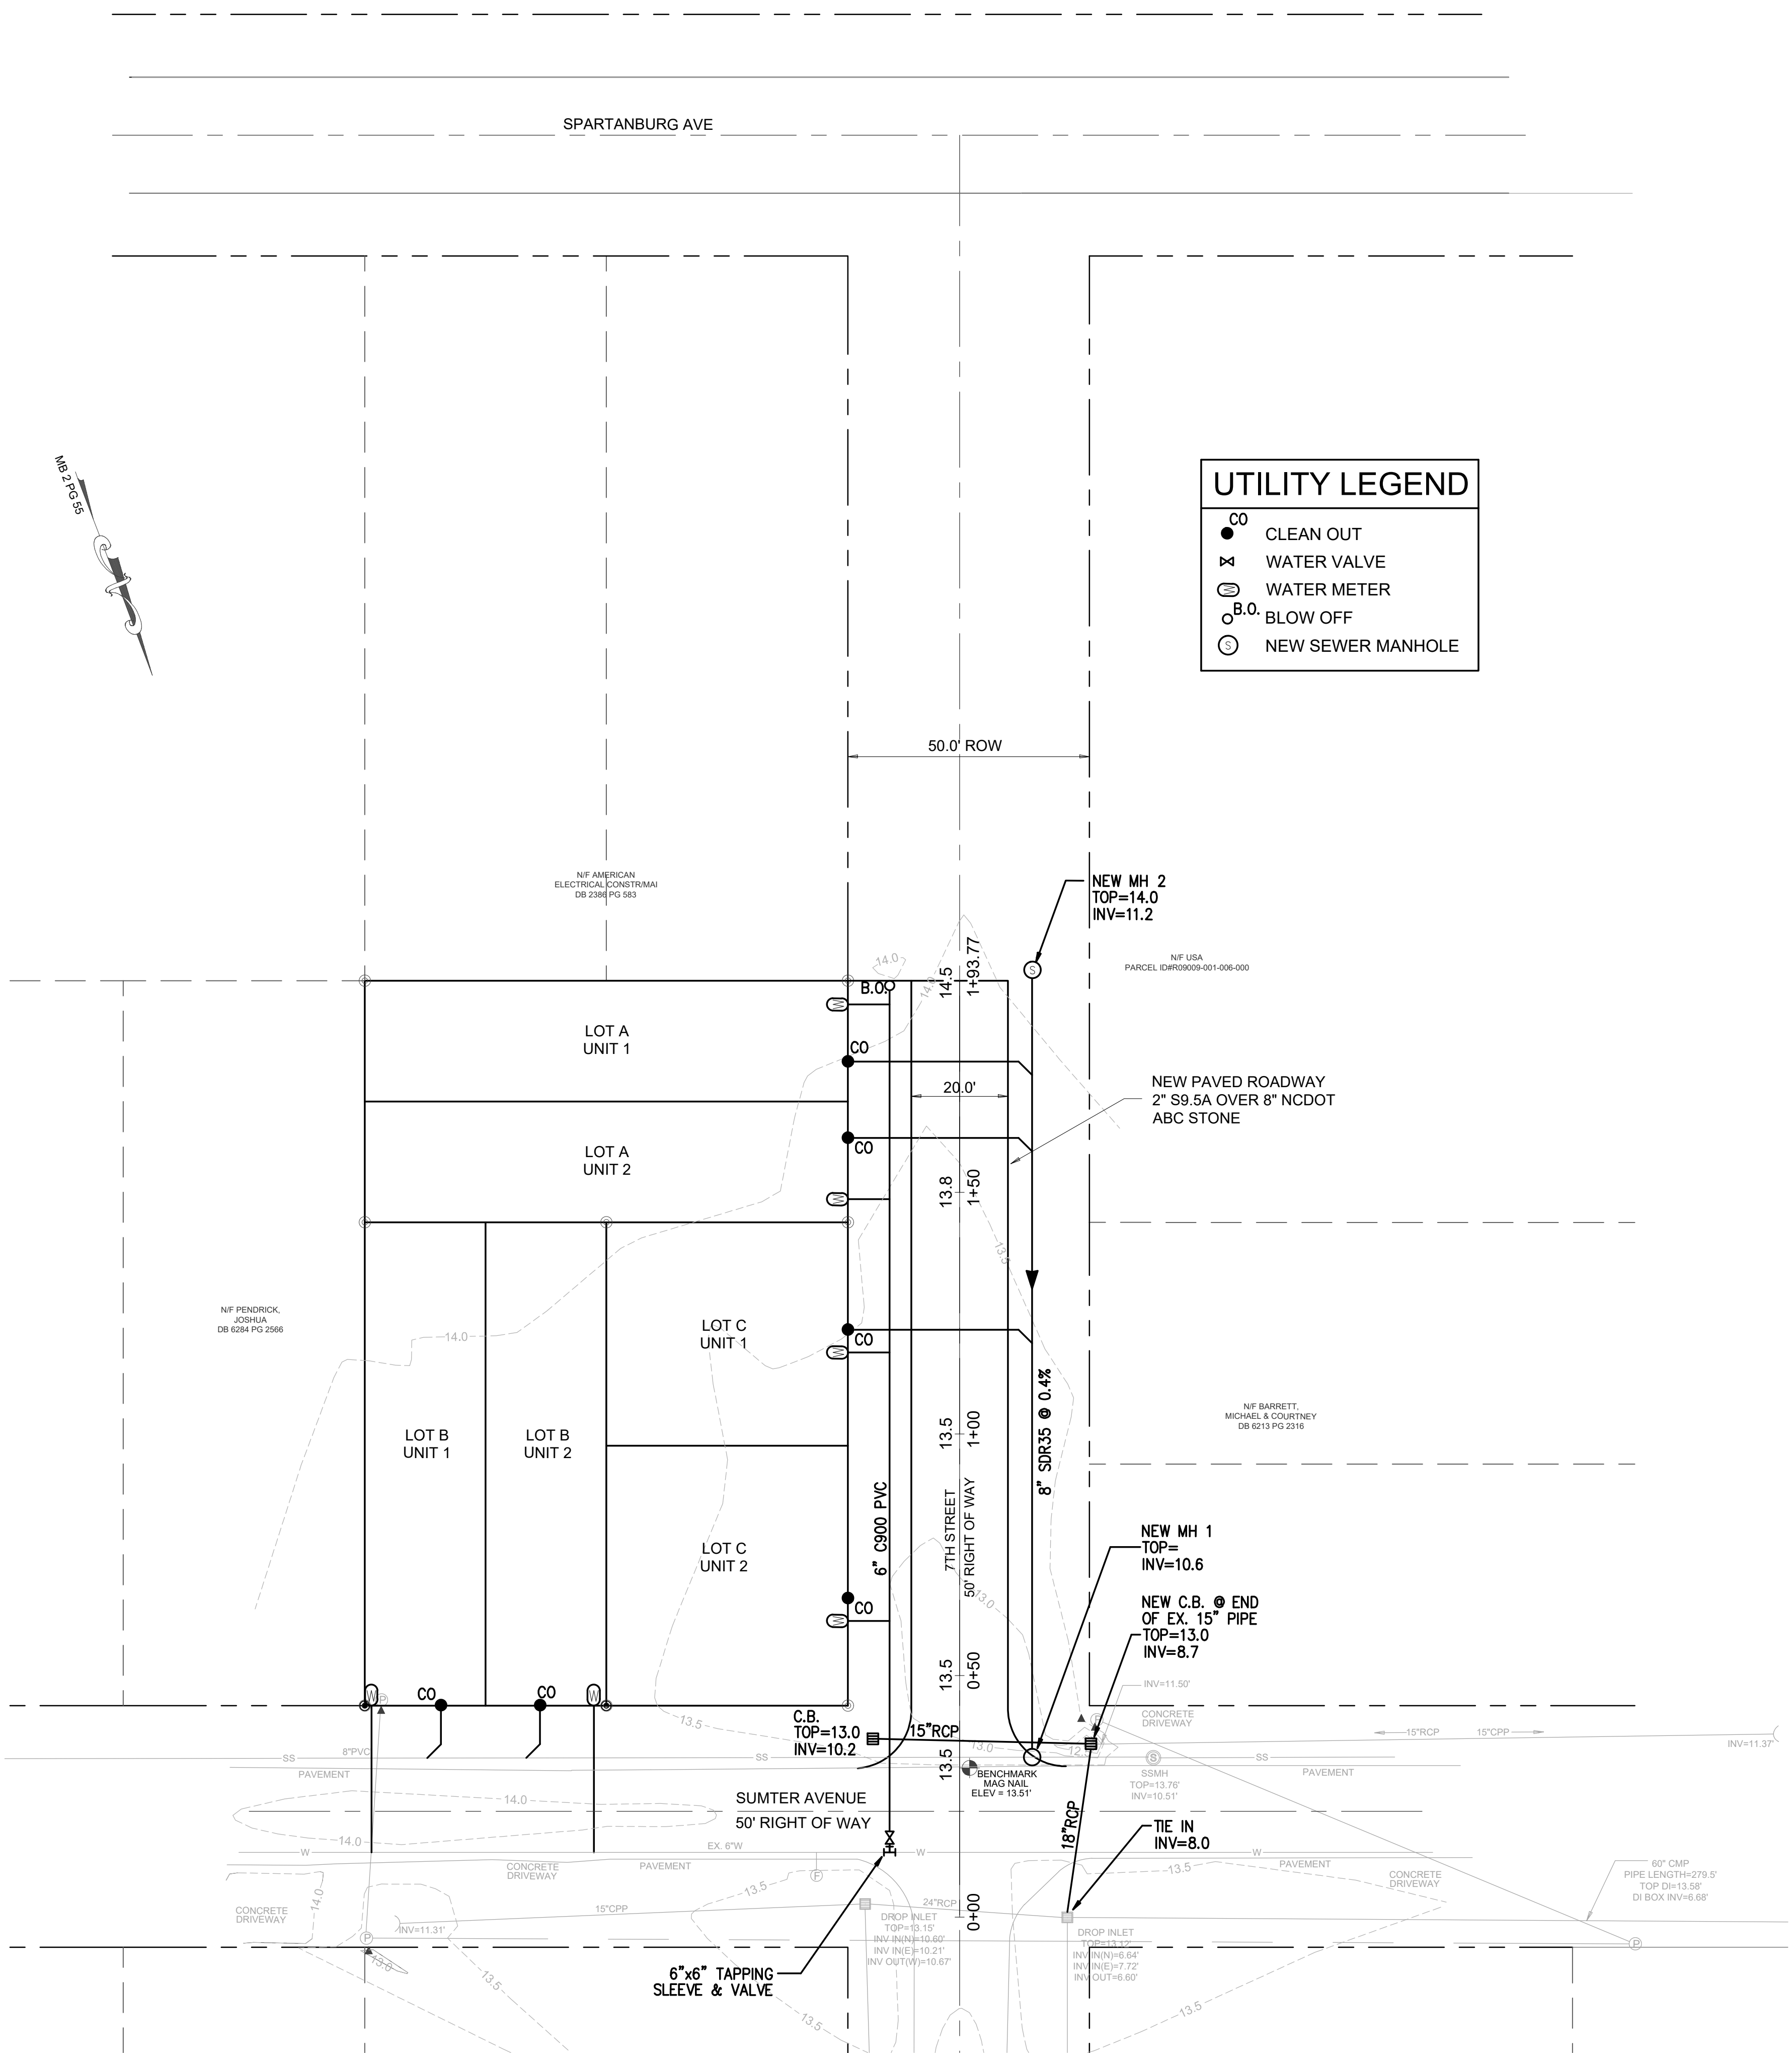

REV. NO.	DESCRIPTION	DATE

**7TH STREET EXTENSION**

CAROLINA BEACH      NEW HANOVER      NORTH CAROLINA

---

PRELIMINARY

---

UTILITY PLAN

---

212 PRINCESS STREET  
WILMINGTON, NC 28401  
(910) 251-8544    FAX (910) 251-2208    FIRM: C-0829

DATE: 10/22/20  
Scale: 1"=20'  
Drawn: NNC  
Checked: WSL  
Project No: HM0220  
Sheet No: **C3**