



CONSULTANTS

OWNER

**ISLAMIC SOCIETY
 OF PALM SPRINGS**

84650 49th AVENUE,
 COACHELLA CA


APN 603-250-008-8 AND
 603-241-005-7

B
L
P
S

**CUP
 PRE APPLICATION # 16-02**

MARK	DATE	DESCRIPTION
PROJECT NO:	100713	
DRAWN BY:	SP	
CHK'D BY:	SP	
SHEET TITLE		

**SITE PLAN
 LIGHTING**

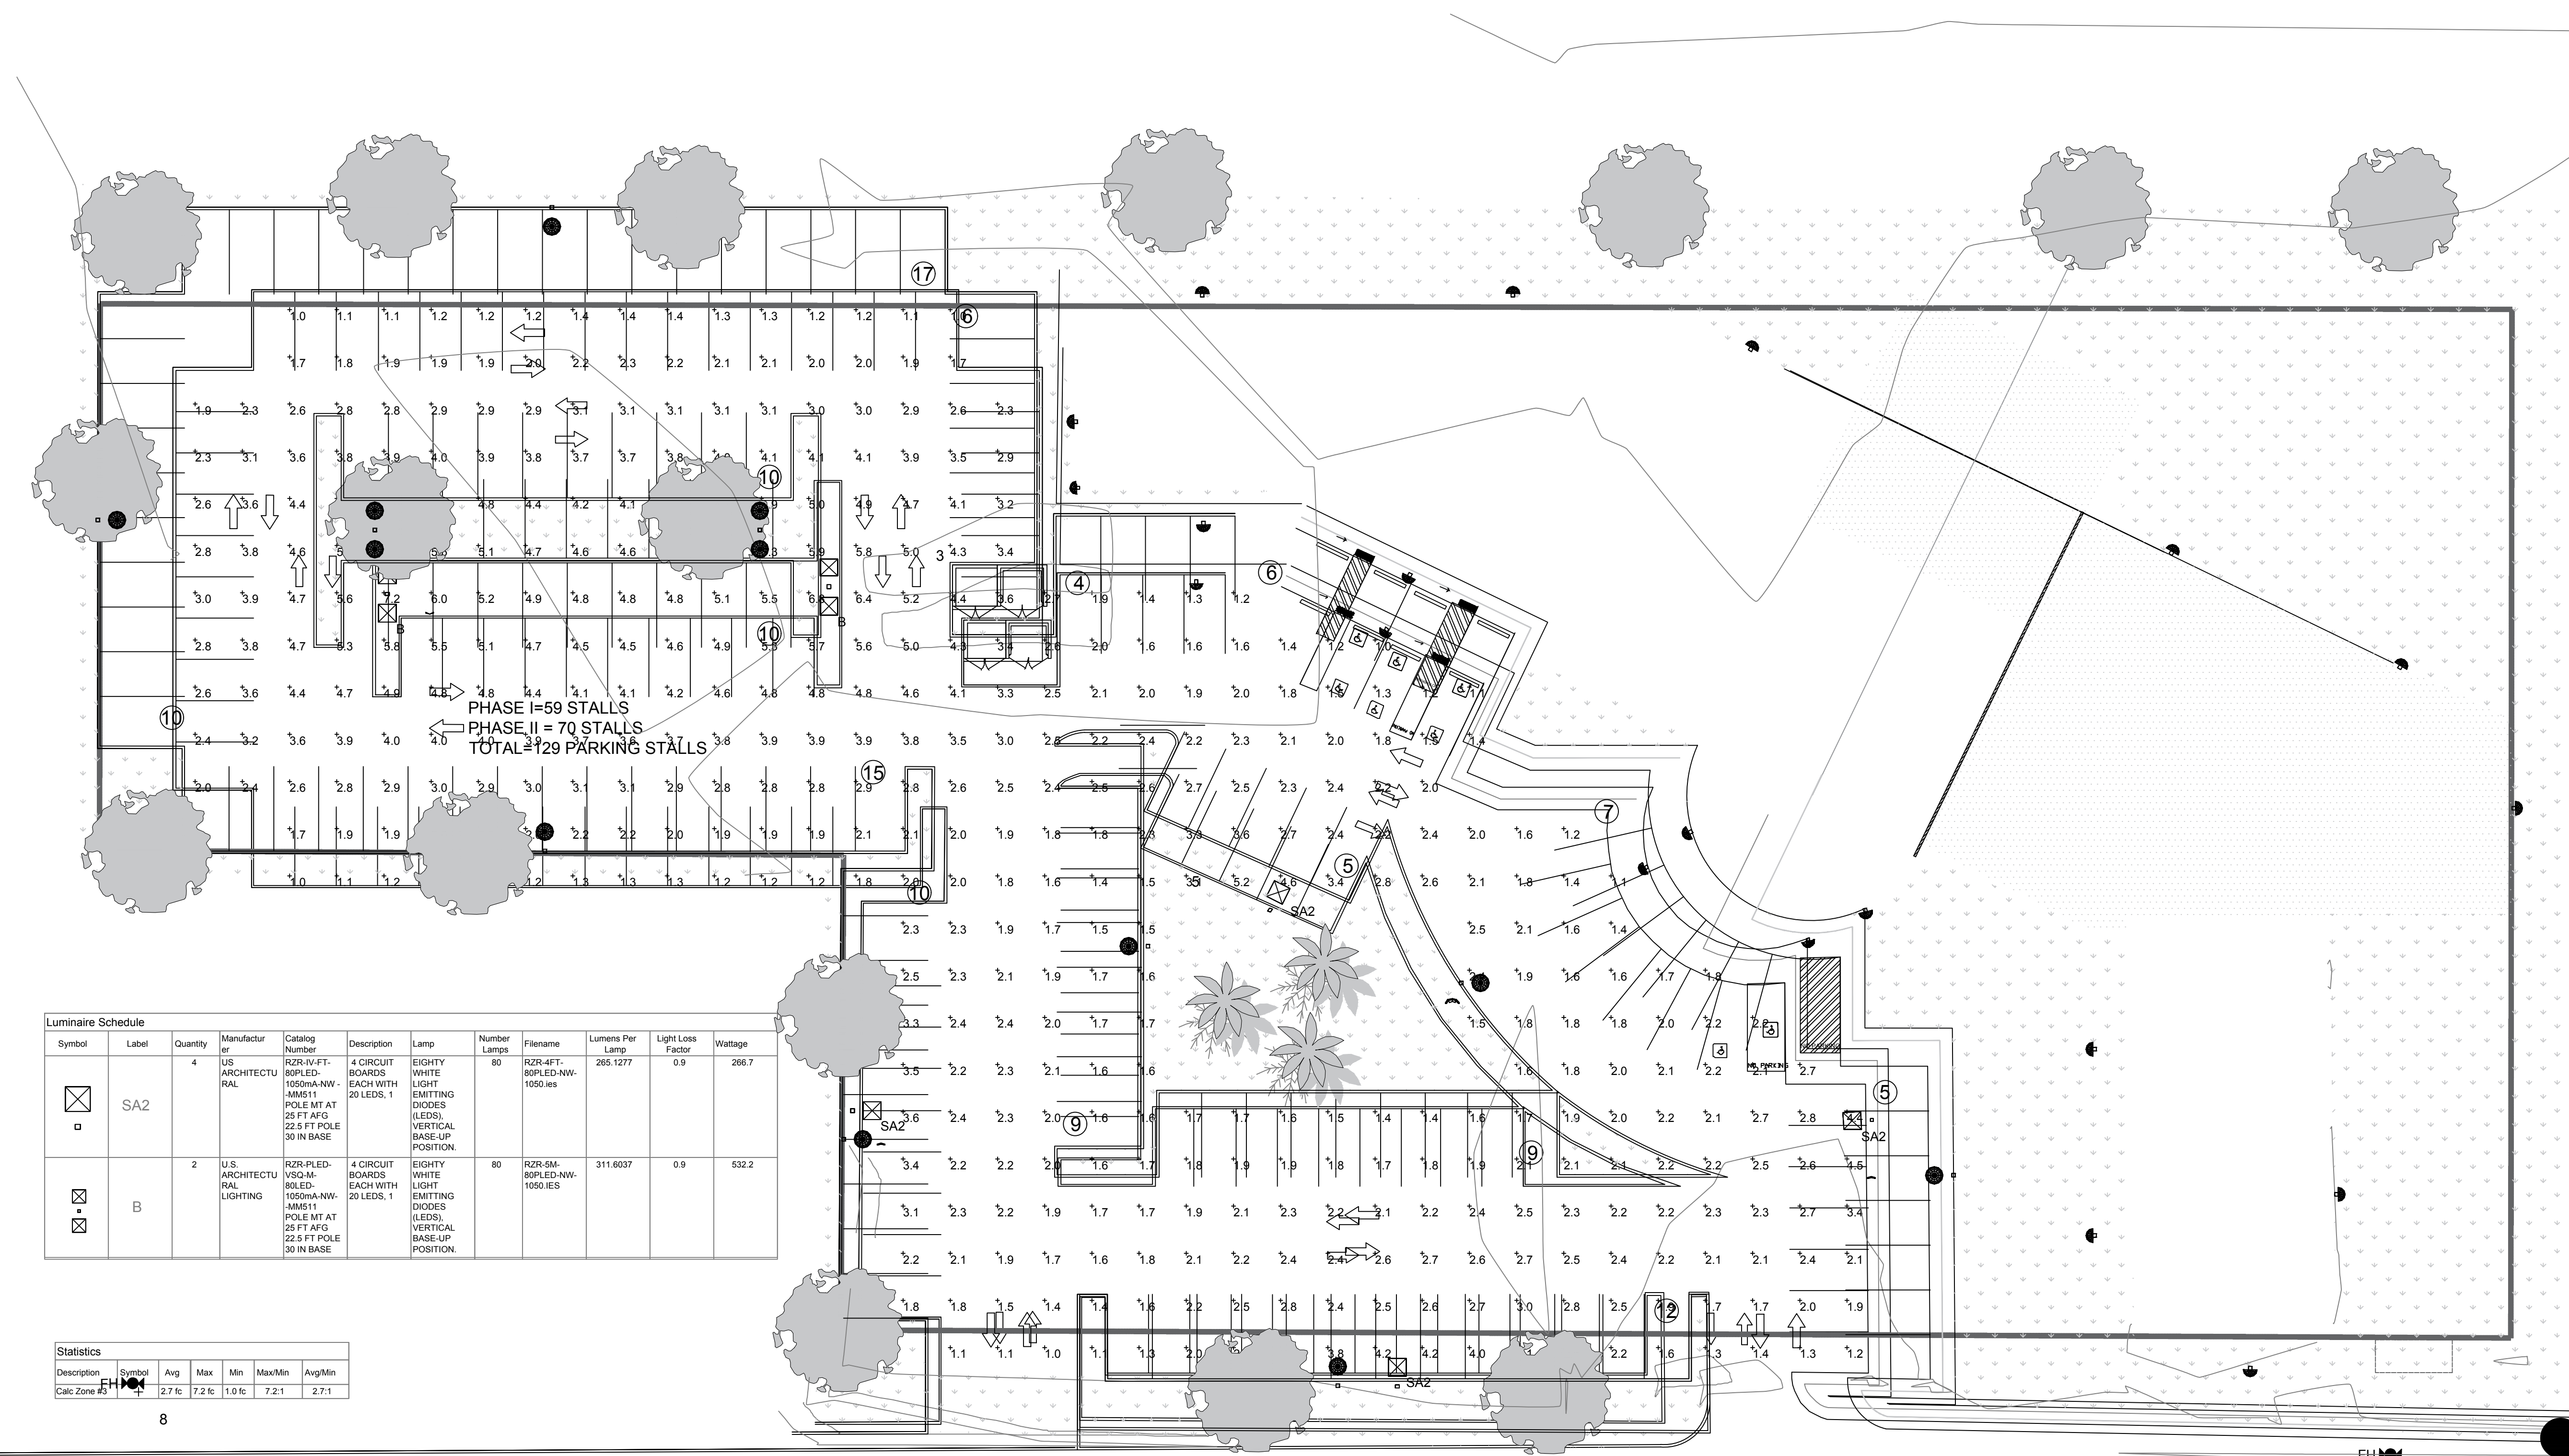

Symbol	Label	Quantity	Manufacturer	Catalog Number	Description	Lamp	Number Lamps	Filename	Lumens Per Lamp	Light Loss Factor	Wattage
⊗	SA2	4	US ARCHITECTURAL LIGHTING	RZR-IV-FT-80LED-1050MA-NW-MM511	4 CIRCUIT BOARD EACH WITH 20 LEDS. 1 POLE MT AT 25 FT AFG 22.5 FT POLE 30 IN BASE	EIGHTY WHITE LIGHT EMITTING DIODES (LEDS). VERTICAL BASE-UP POSITION.	80	RZR-4FT-80LED-NW-1050IES	265.1277	0.9	266.7
⊕	B	2	US ARCHITECTURAL LIGHTING	RZR-PLD-VISCA-80LED-1050MA-NW-MM511	4 CIRCUIT BOARD EACH WITH 20 LEDS. 1 POLE MT AT 25 FT AFG 22.5 FT POLE 30 IN BASE	EIGHTY WHITE LIGHT EMITTING DIODES (LEDS). VERTICAL BASE-UP POSITION.	80	RZR-SM-80LED-NW-1050IES	311.6037	0.9	532.2

Statistics						
Description	Symbol	Avg	Max	Min	Max/Min	Avg/Min
Calc Zone #1	⊗	2.7 fc	7.2 fc	1.0 fc	7.2:1	2.7:1

Plan View
 Scale - 1" = 20'

C:\Users\sana\Desktop\projects\SP\ARCHITECTURE\SPS SITE LIGHTING.dwg, 9/21/2016 8:49:06 PM, DWG To PDF.pc3