


P:\Eng1\Project Folders\Cs Columbus\System Documentation\System Mapping\One-Line Diagrams and Switchgear\C9-22A System One-Line.dwg

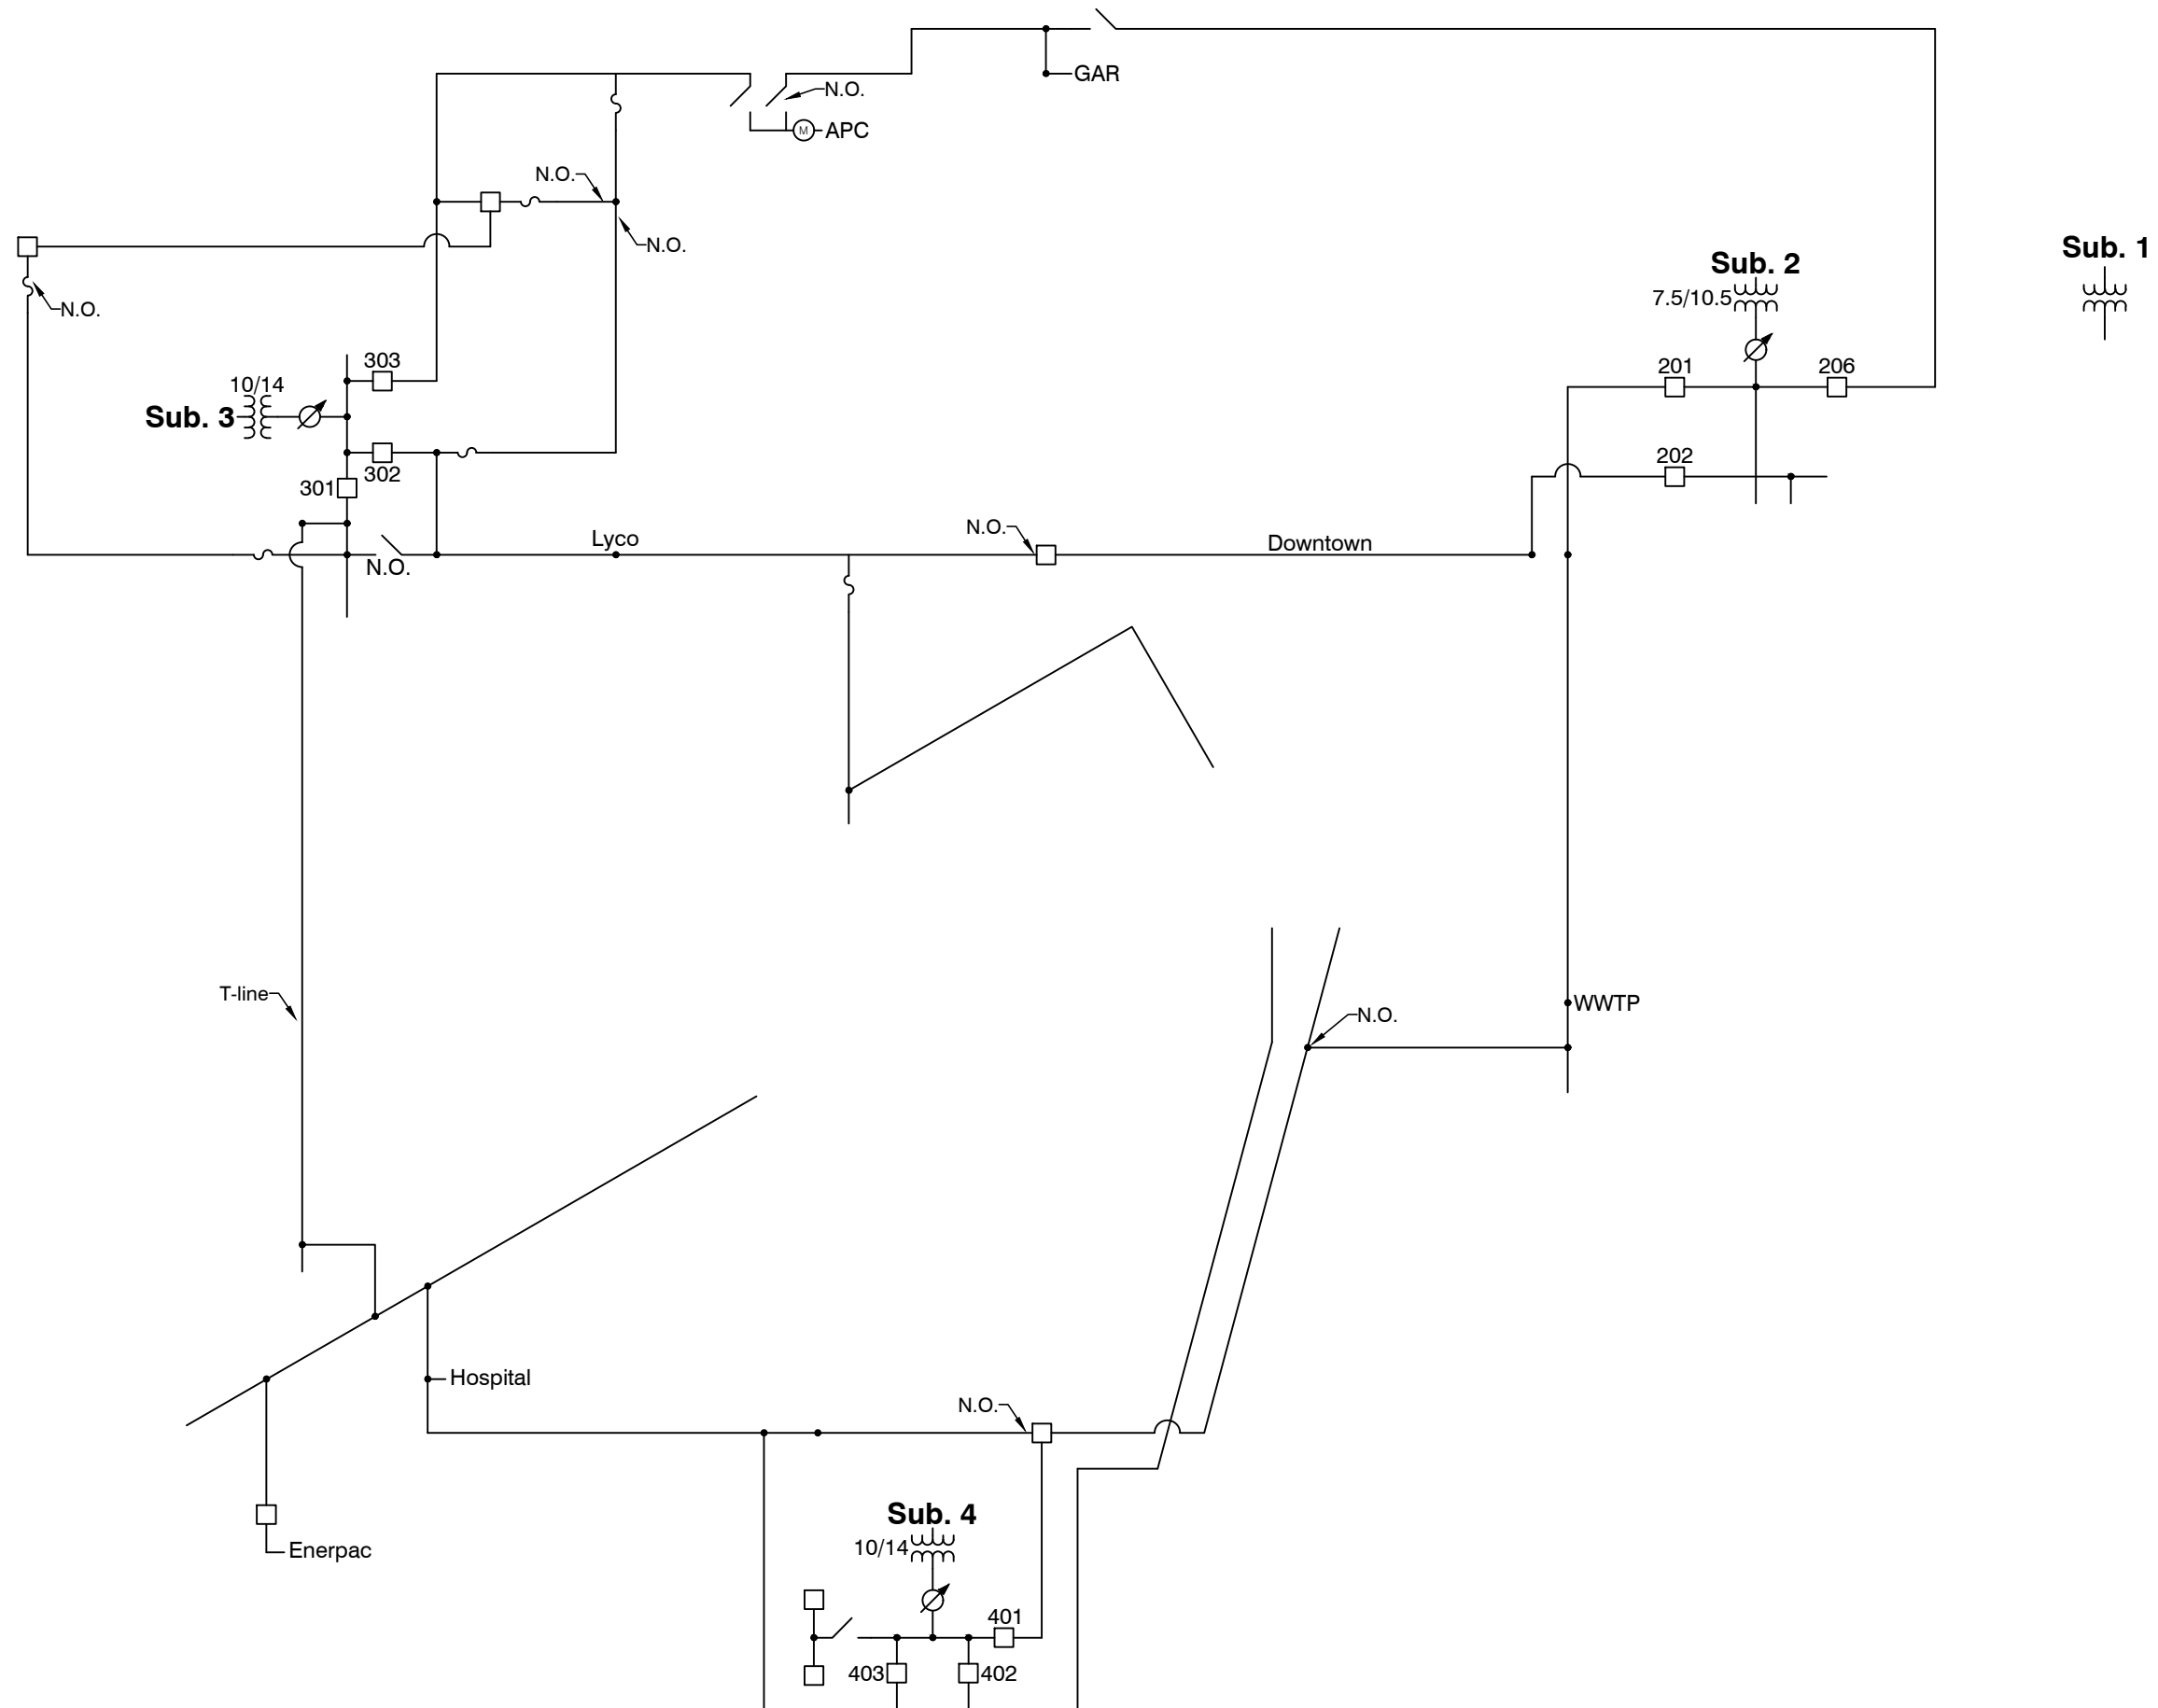

1	03/05/25	Issued for CIP Letter	JAW	JJR	
Rev	Date	Description	Draft	Eng	

**FORSTER**
ELECTRICAL ENGINEERING

Columbus Water & Light Department
CIP Exhibit
System One-Line Existing
Dwg No. **C09-CIP-Exhibit 1**