


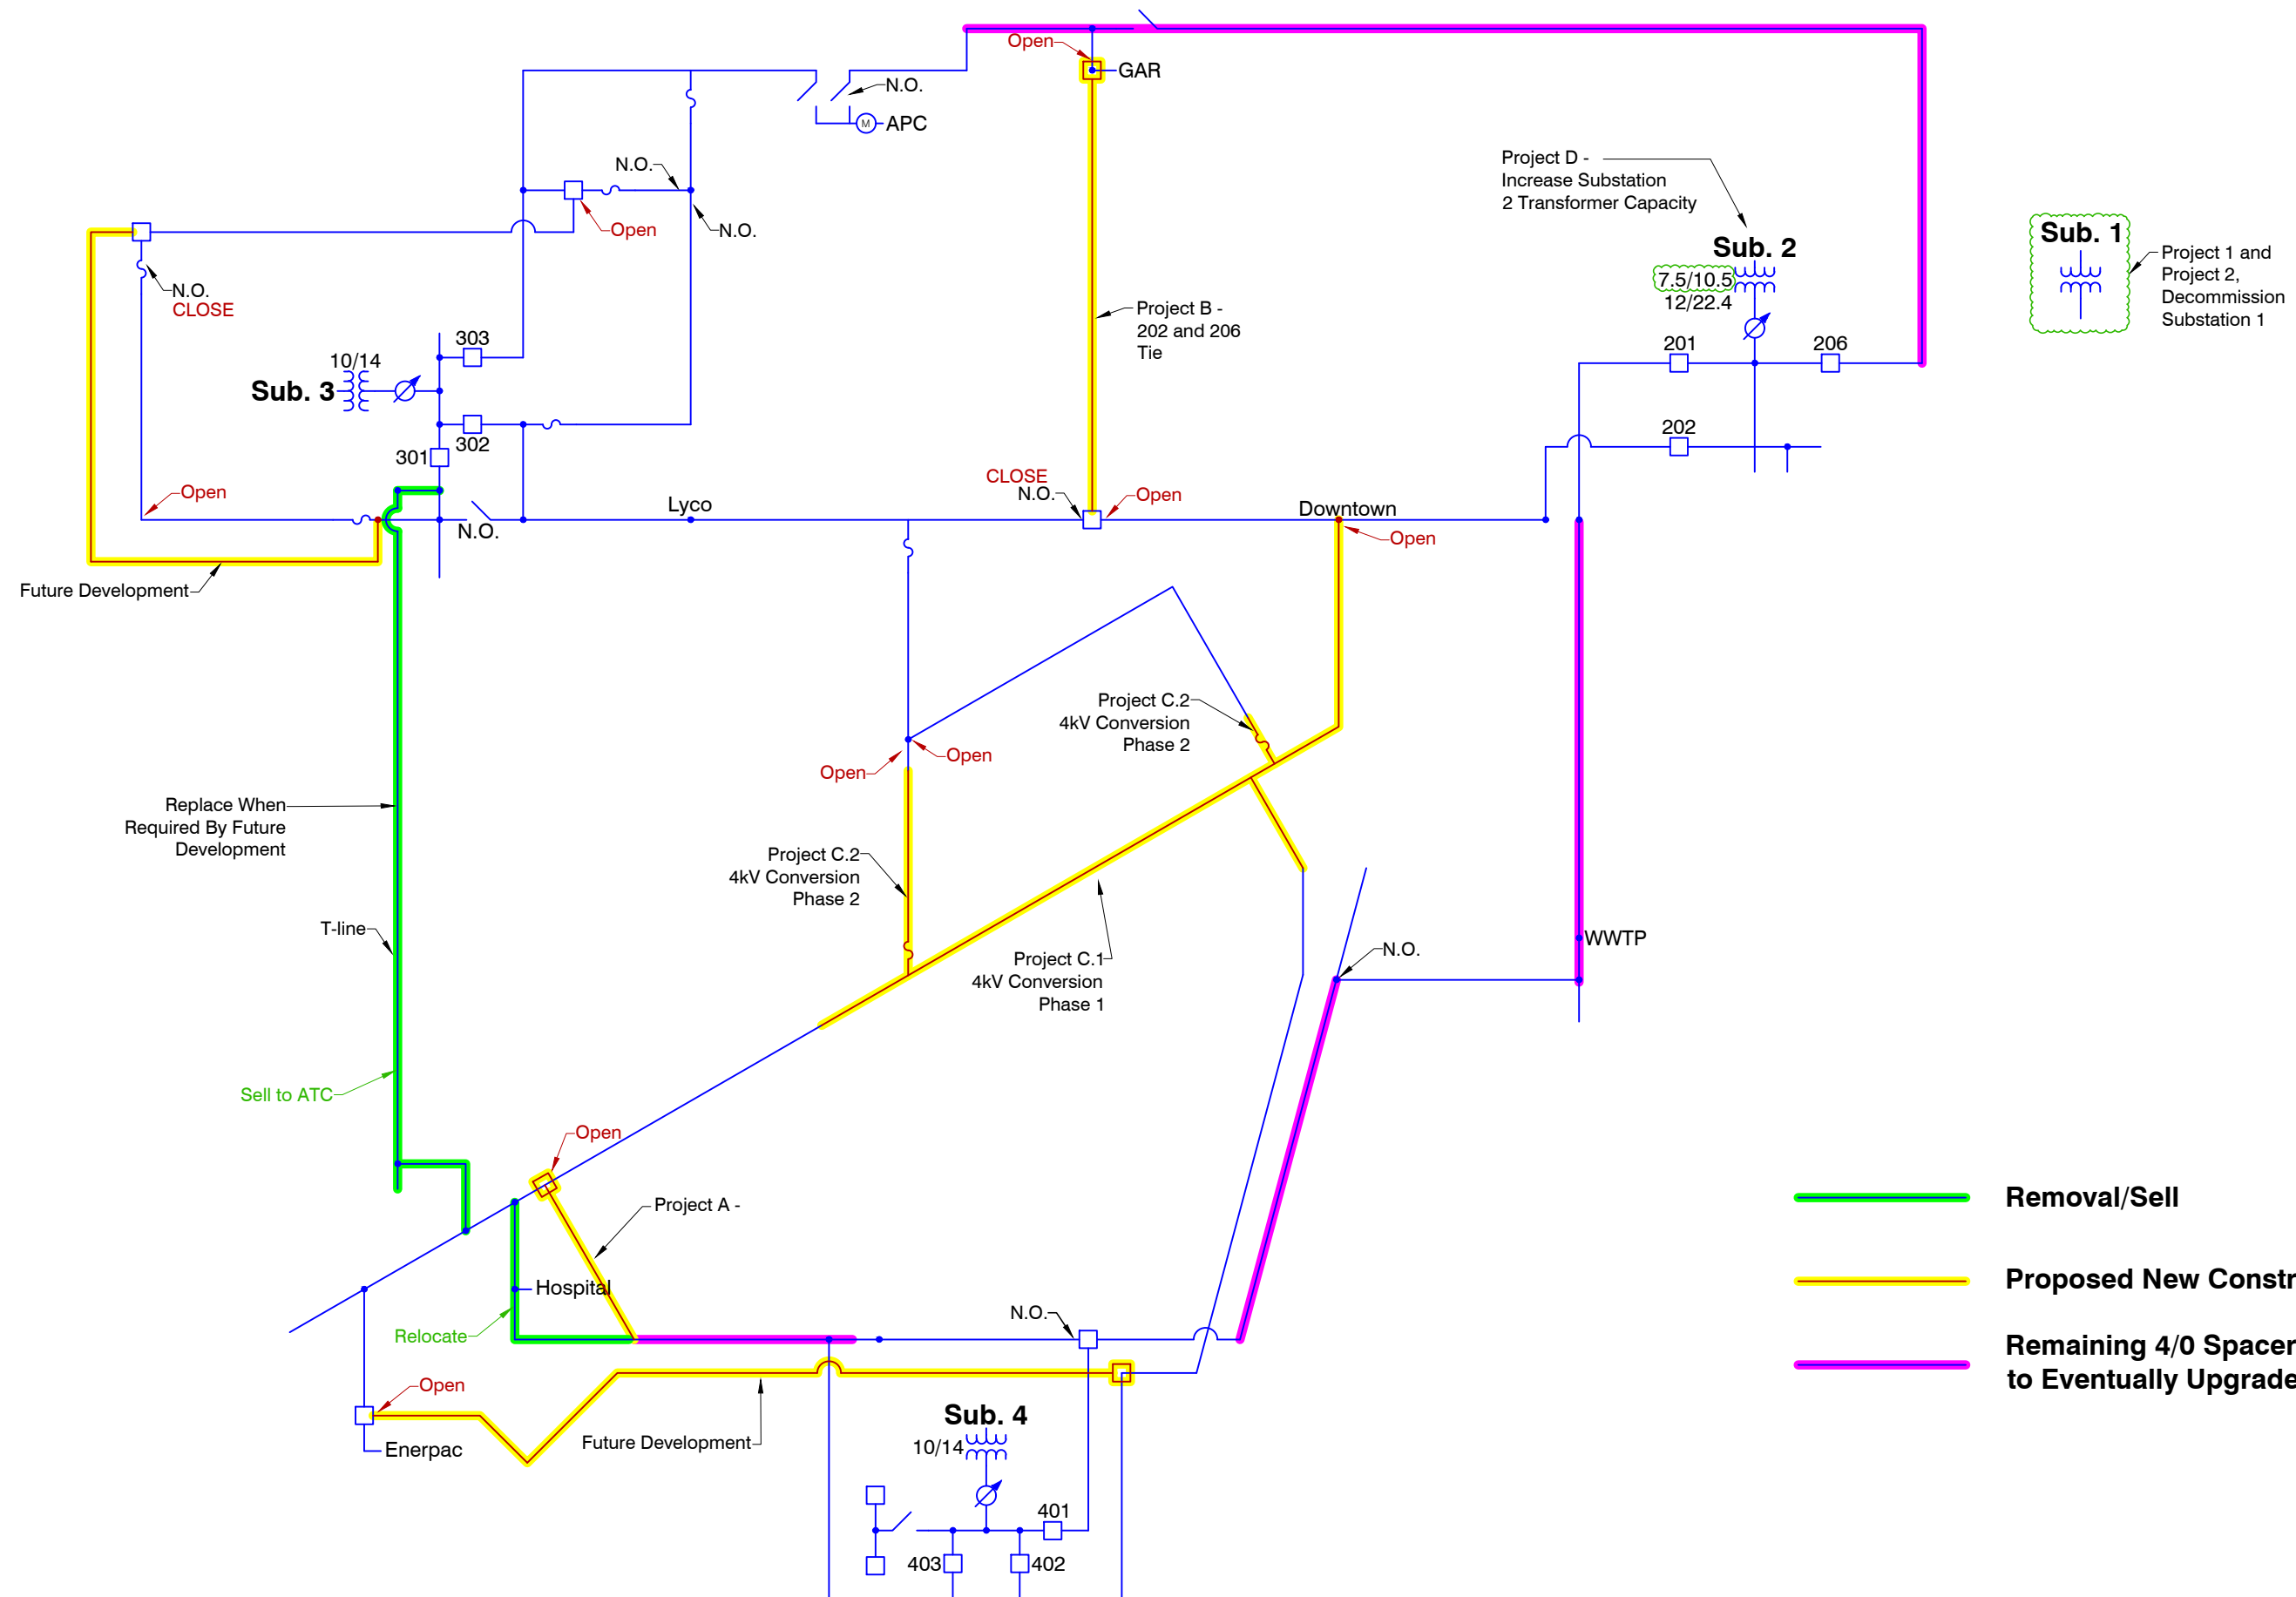

- Removal/Sell
- Proposed New Construction
- Remaining 4/0 Spacer to Eventually Upgrade

1	03/05/25	Issued for CIP Letter		JAW	JJF
Rev	Date	Description		Draft	Eng



FORSTER
ELECTRICAL ENGINEERING

Columbus Water & Light Department
CIP Exhibit
System One-Line - Proposed
Dwg No. **C09-CIP-Exhibit 2**

P:\Eng1\Project Folders\Cs Columbus\System Documentation\System Mapping\One-Line Diagrams and Switchgear\C09-22A System One-Line.dwg