
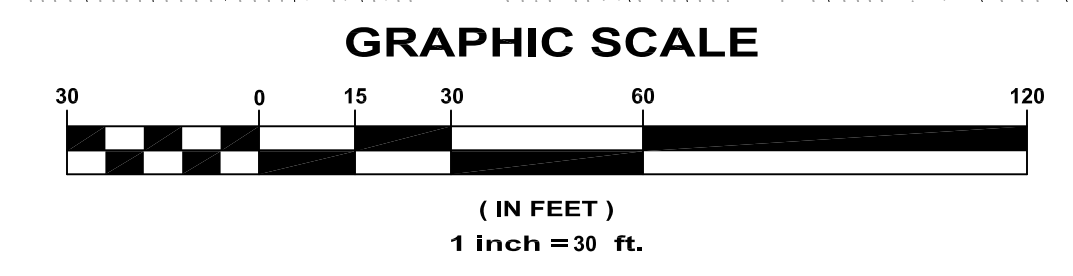
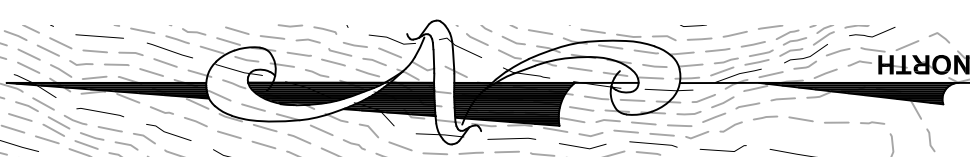


© 2021 Microsoft Corporation © 2021 TomTom

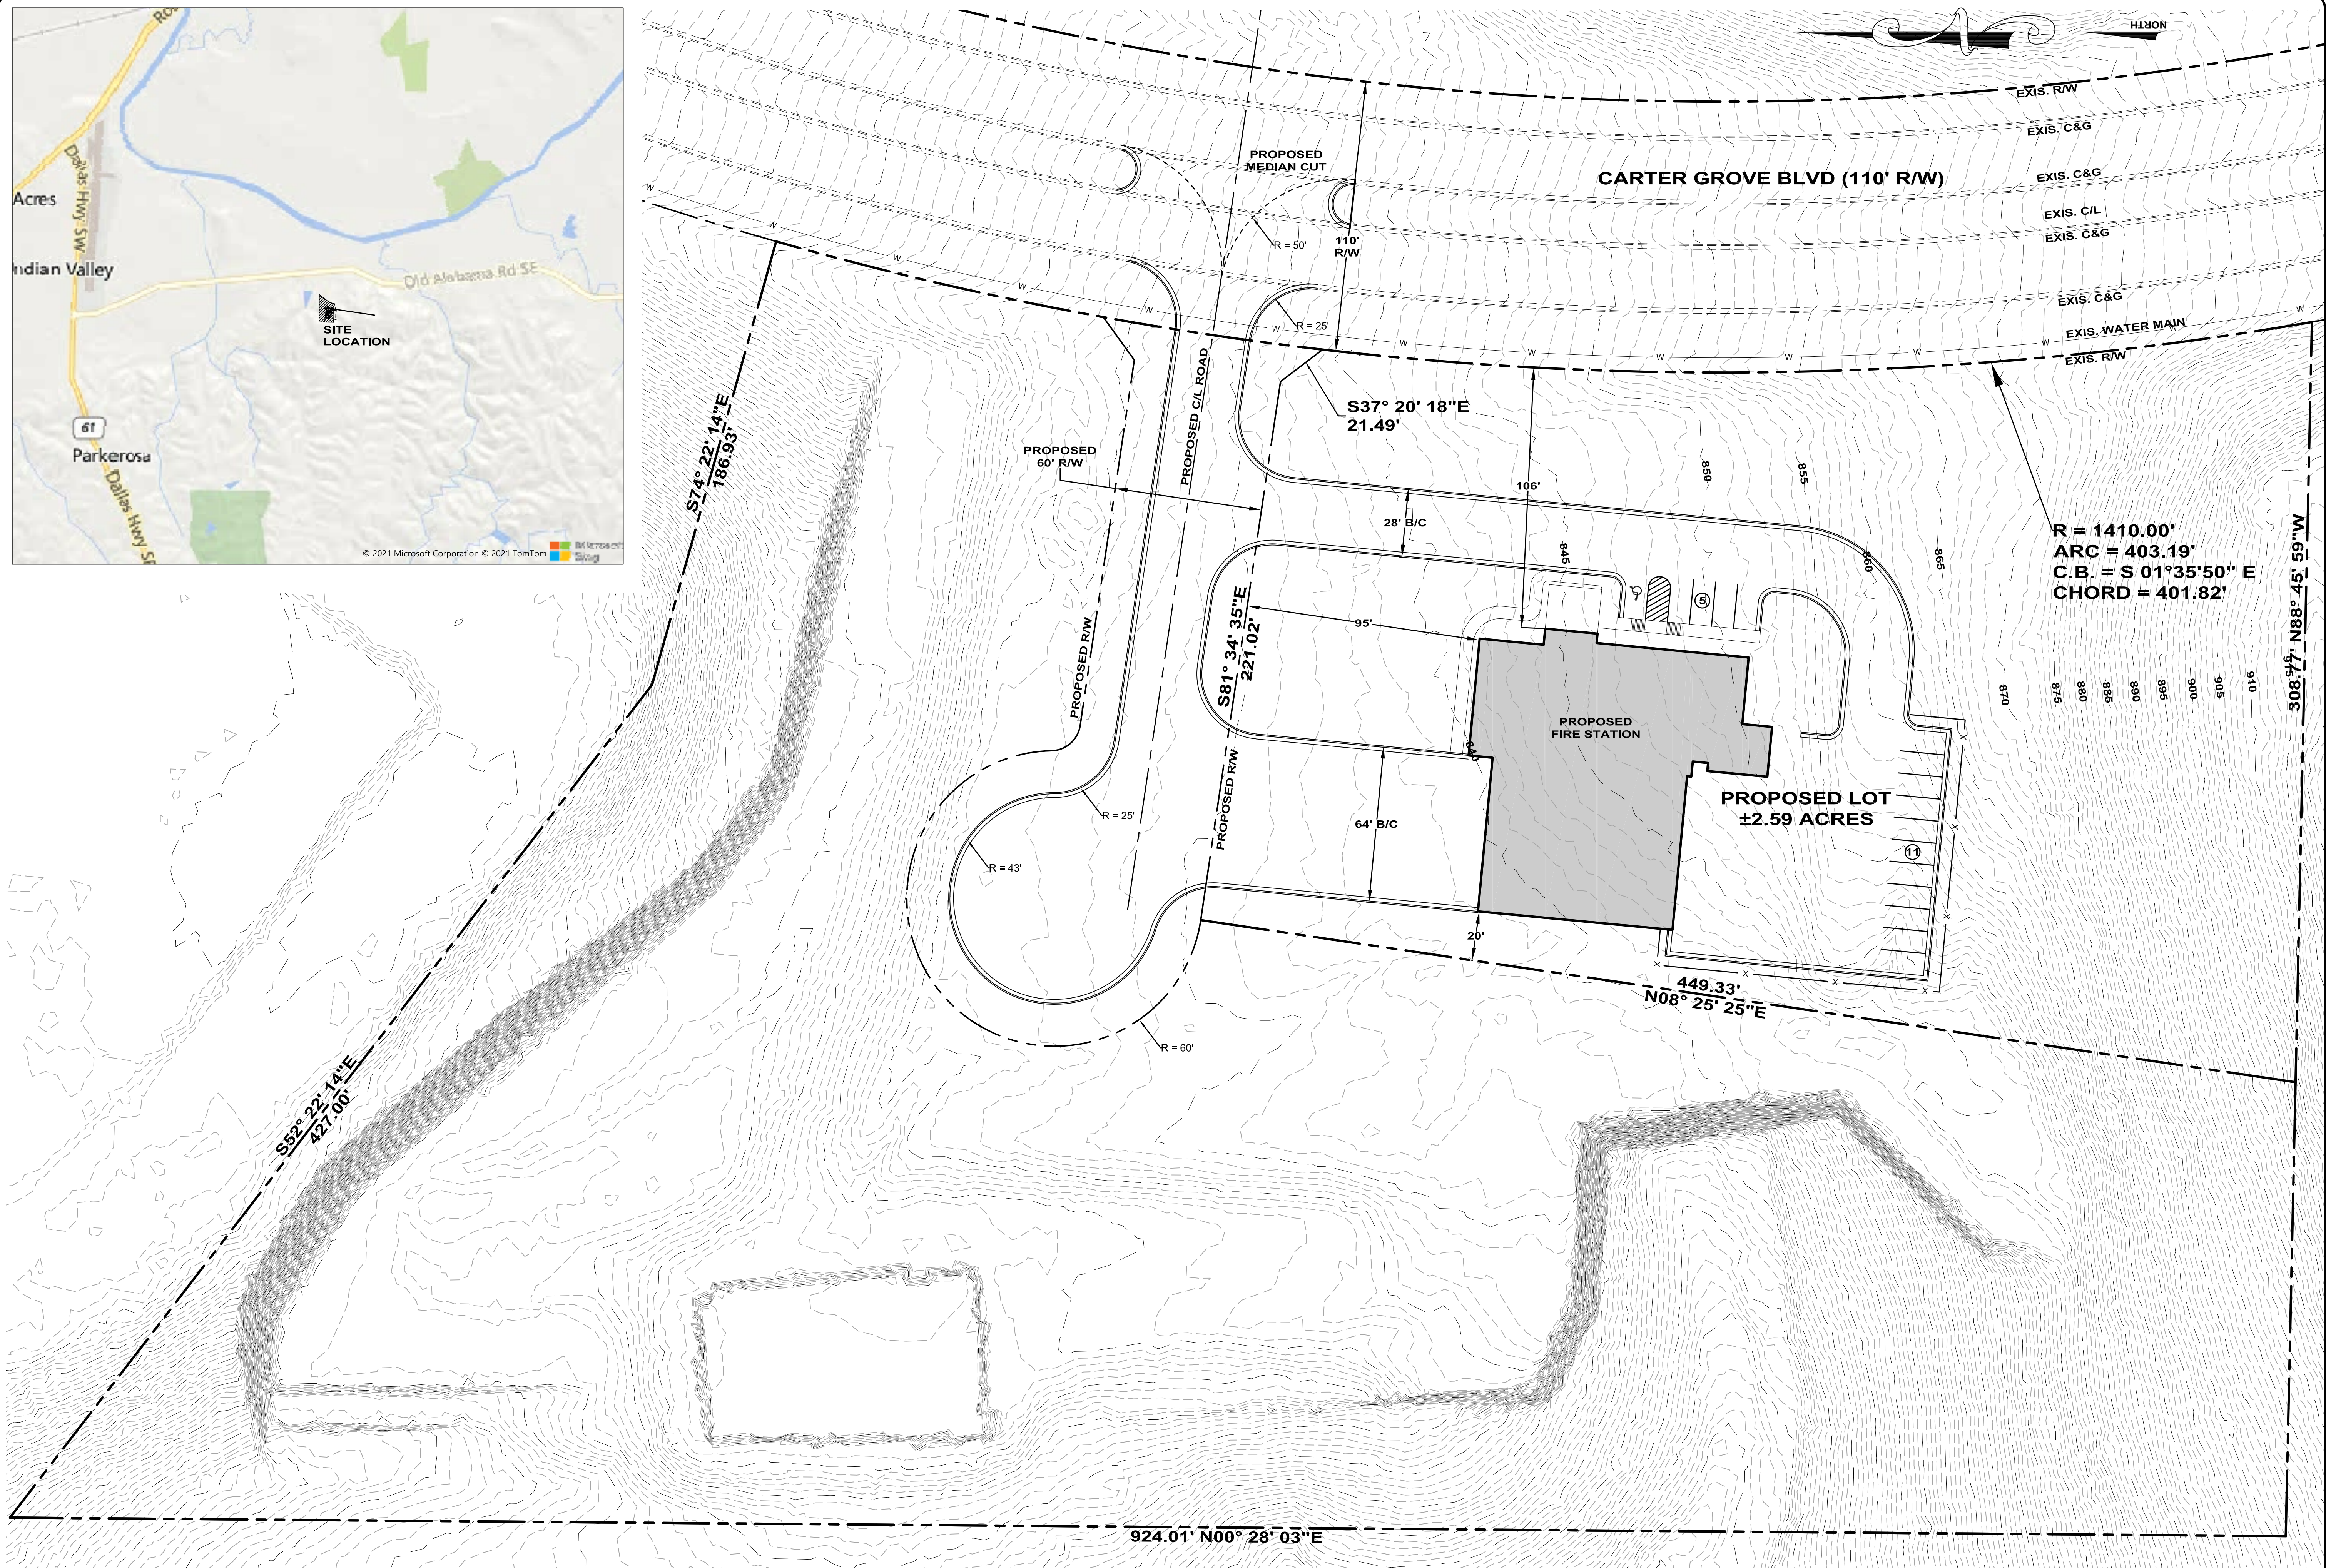

REVISIONS

www.perspectiveeng.com

**PERSPECTIVE ENGINEERING**

4255 Wade Green Road, #625  
Kennesaw, Georgia 30144  
Ph: (678) 567-1203

GA SOS Eng. Firm Lic #PEF003958

JULIAN

DWG.: 665-Concept.dwg      JOB NUMBER: 2016-510  
DATE: 09/30/21              DRAWN BY: J.LJ

PROJECT NAME  
CARTER GROVE FIRE STATION  
LAND LOT 993, 4TH DISTRICT, 3RD SECTION  
CITY OF CARTERSVILLE, BARTOW COUNTY, GEORGIA

CLIENT NAME  
CITY OF CARTERSVILLE  
10 N. ERWIN STREET  
CARTERSVILLE, GEORGIA 30120

SEAL

**PRELIMINARY  
NOT FOR  
CONSTRUCTION**

PRELIMINARY  
SITE PLAN