

TAYLOR&MATHIS

CARTERSVILLE  
COMMERCE CENTER

BUILDING 100

10 HILLVIEW AVE.  
CARTERSVILLE, GA 30121

©2022, Atlas Collaborative, LLC. These drawings are protected by the copyright laws of the United States. These drawings or any part thereof may not be used for any purpose or reproduced in any form or by any means without the written consent of Atlas Collaborative, LLC.

Print Record	
PERMIT SET	07/05/2022


Revisions	

Issue Date	08/10/2022	Job No.	#
Sheet Title	ELECTRICAL SITE PLAN		

Sheet No.	CE.101
ISSUED FOR CONSTRUCTION	

SHEET NAME: Unnamed SHEET NUMBER: A.000 PROJECT NAME: CARTERSVILLE COMMERCE CENTER

FILE PATH: C:\Users\Nikola\OneDrive\Documents\2101024\_Cartersville CC B100\_R21\_mako\Y282.rvt

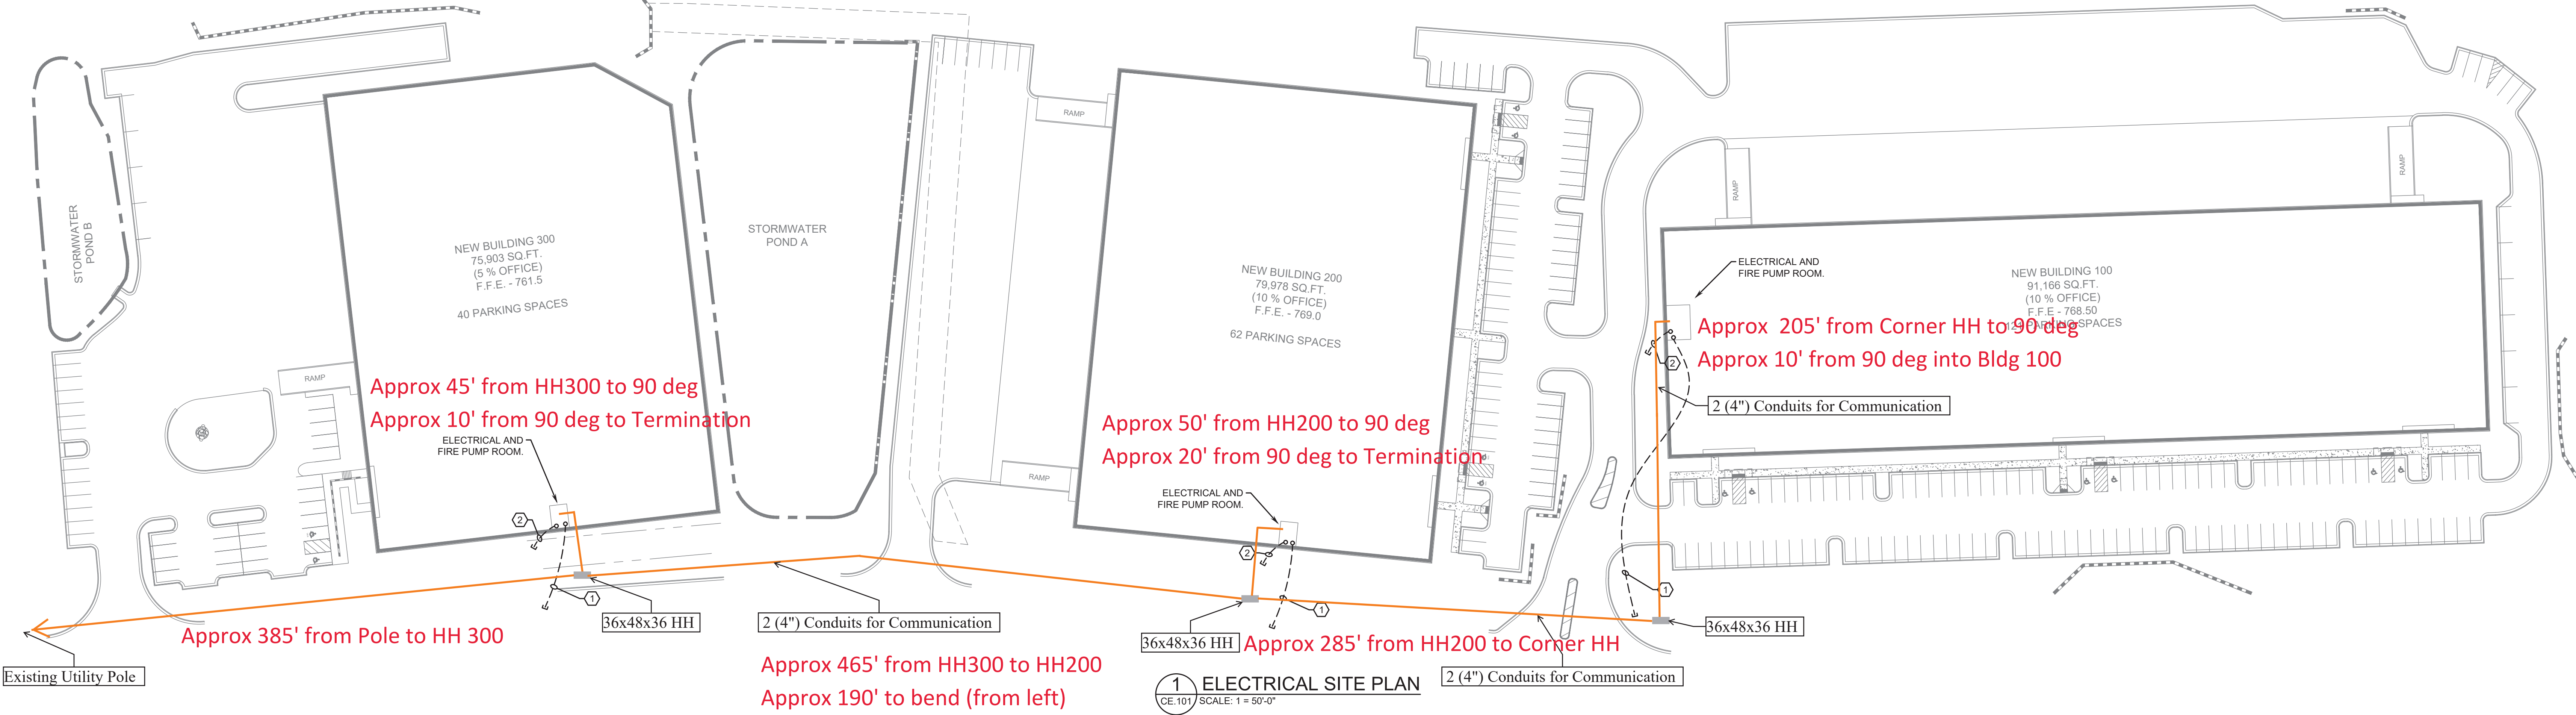

# APPROX TOTAL: 1,475'

KEY NOTES	
①	(2) 4" PVC WITH PULLSTRING TO TELEPHONE COMPANY DEMARCATION POINT. COORDINATE LOCATION WITH TELEPHONE COMPANY.
②	SERVICE ENTRANCE FEEDERS. SEE BUILDING PLANS.