


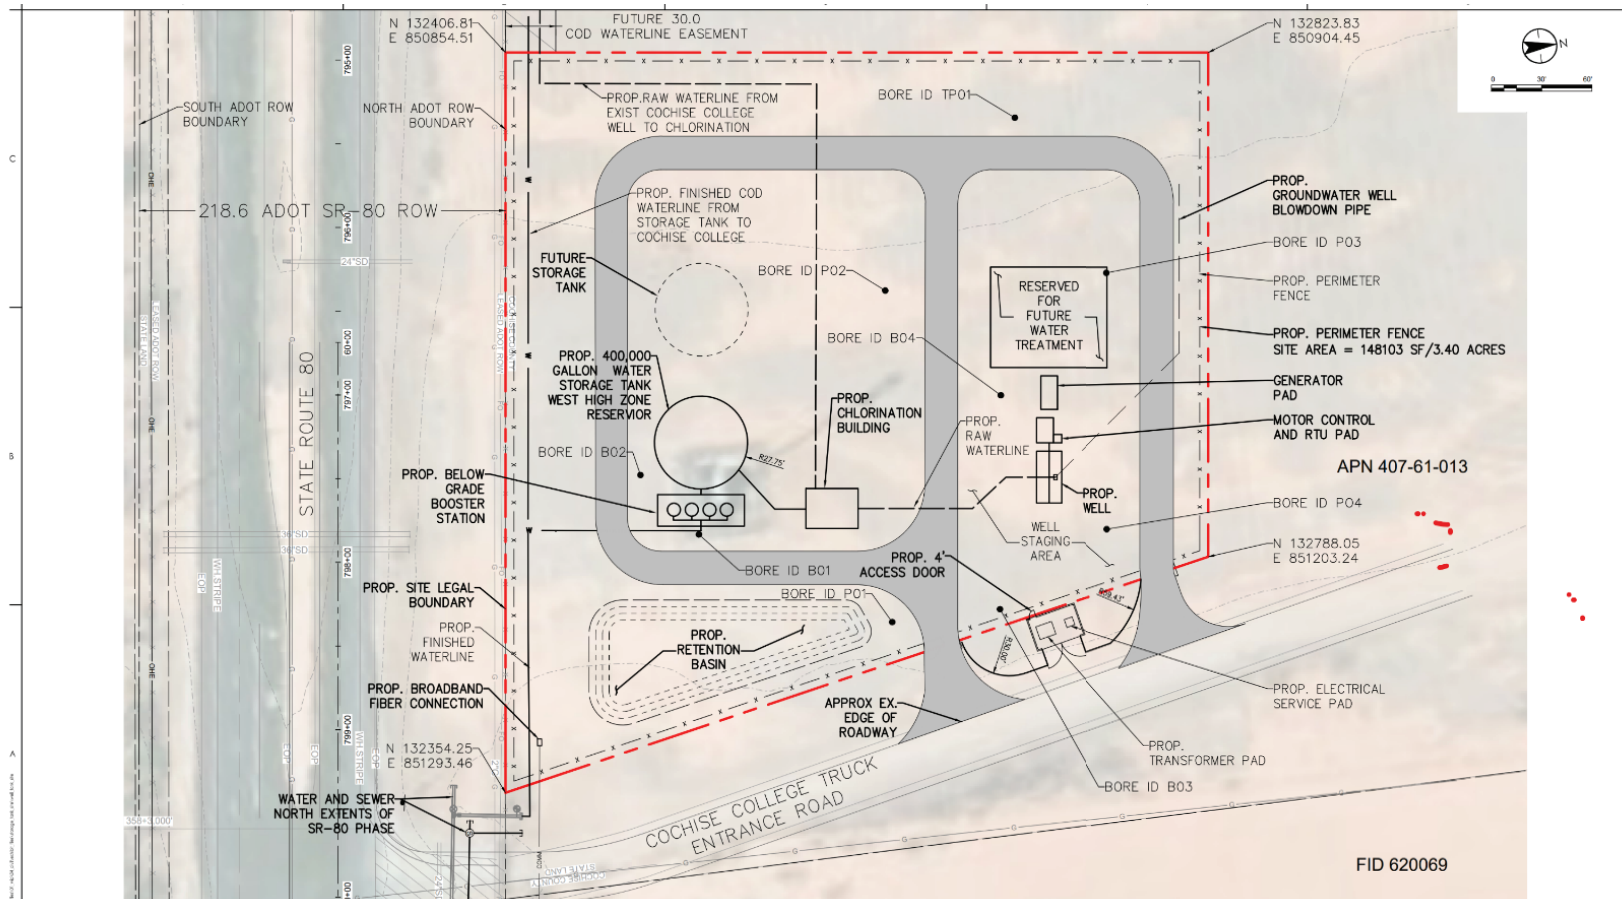

CITY OF DOUGLAS WATER CAMPUS AT COCHISE COLLEGE - DRAFT SITE PLAN FOR THE STORAGE TANK AND GROUNDWATER WELL IN SUPPORT OF THE DOUGLAS POE AND WEST SERVICE AREA

Note:
BORE HOLES WERE DRILLED BY SCE
GEOTECHNICAL UNDER CONTRACT TO
STANTEC / CITY OF DOUGLAS IN DECEMBER
2024



Stantec
3133 W. Pecos Blvd. Suite 300
Chandler, AZ 85226
Tel: 480.987.6100
www.stantec.com

Copyright Reserved

This document is the property of Stantec. It is to be used only for the project and purpose for which it was prepared. It is not to be reproduced, stored in a retrieval system, or transmitted in any form or by any means, electronic, mechanical, photocopying, recording, or by any information storage and retrieval system, without the prior written permission of Stantec.

Client
CITY OF DOUGLAS

Project No.
181301000

Scale
1" = 30'

DOUGLAS, ARIZONA

File Name: WELLS_2024_01

2024.01.15