
 


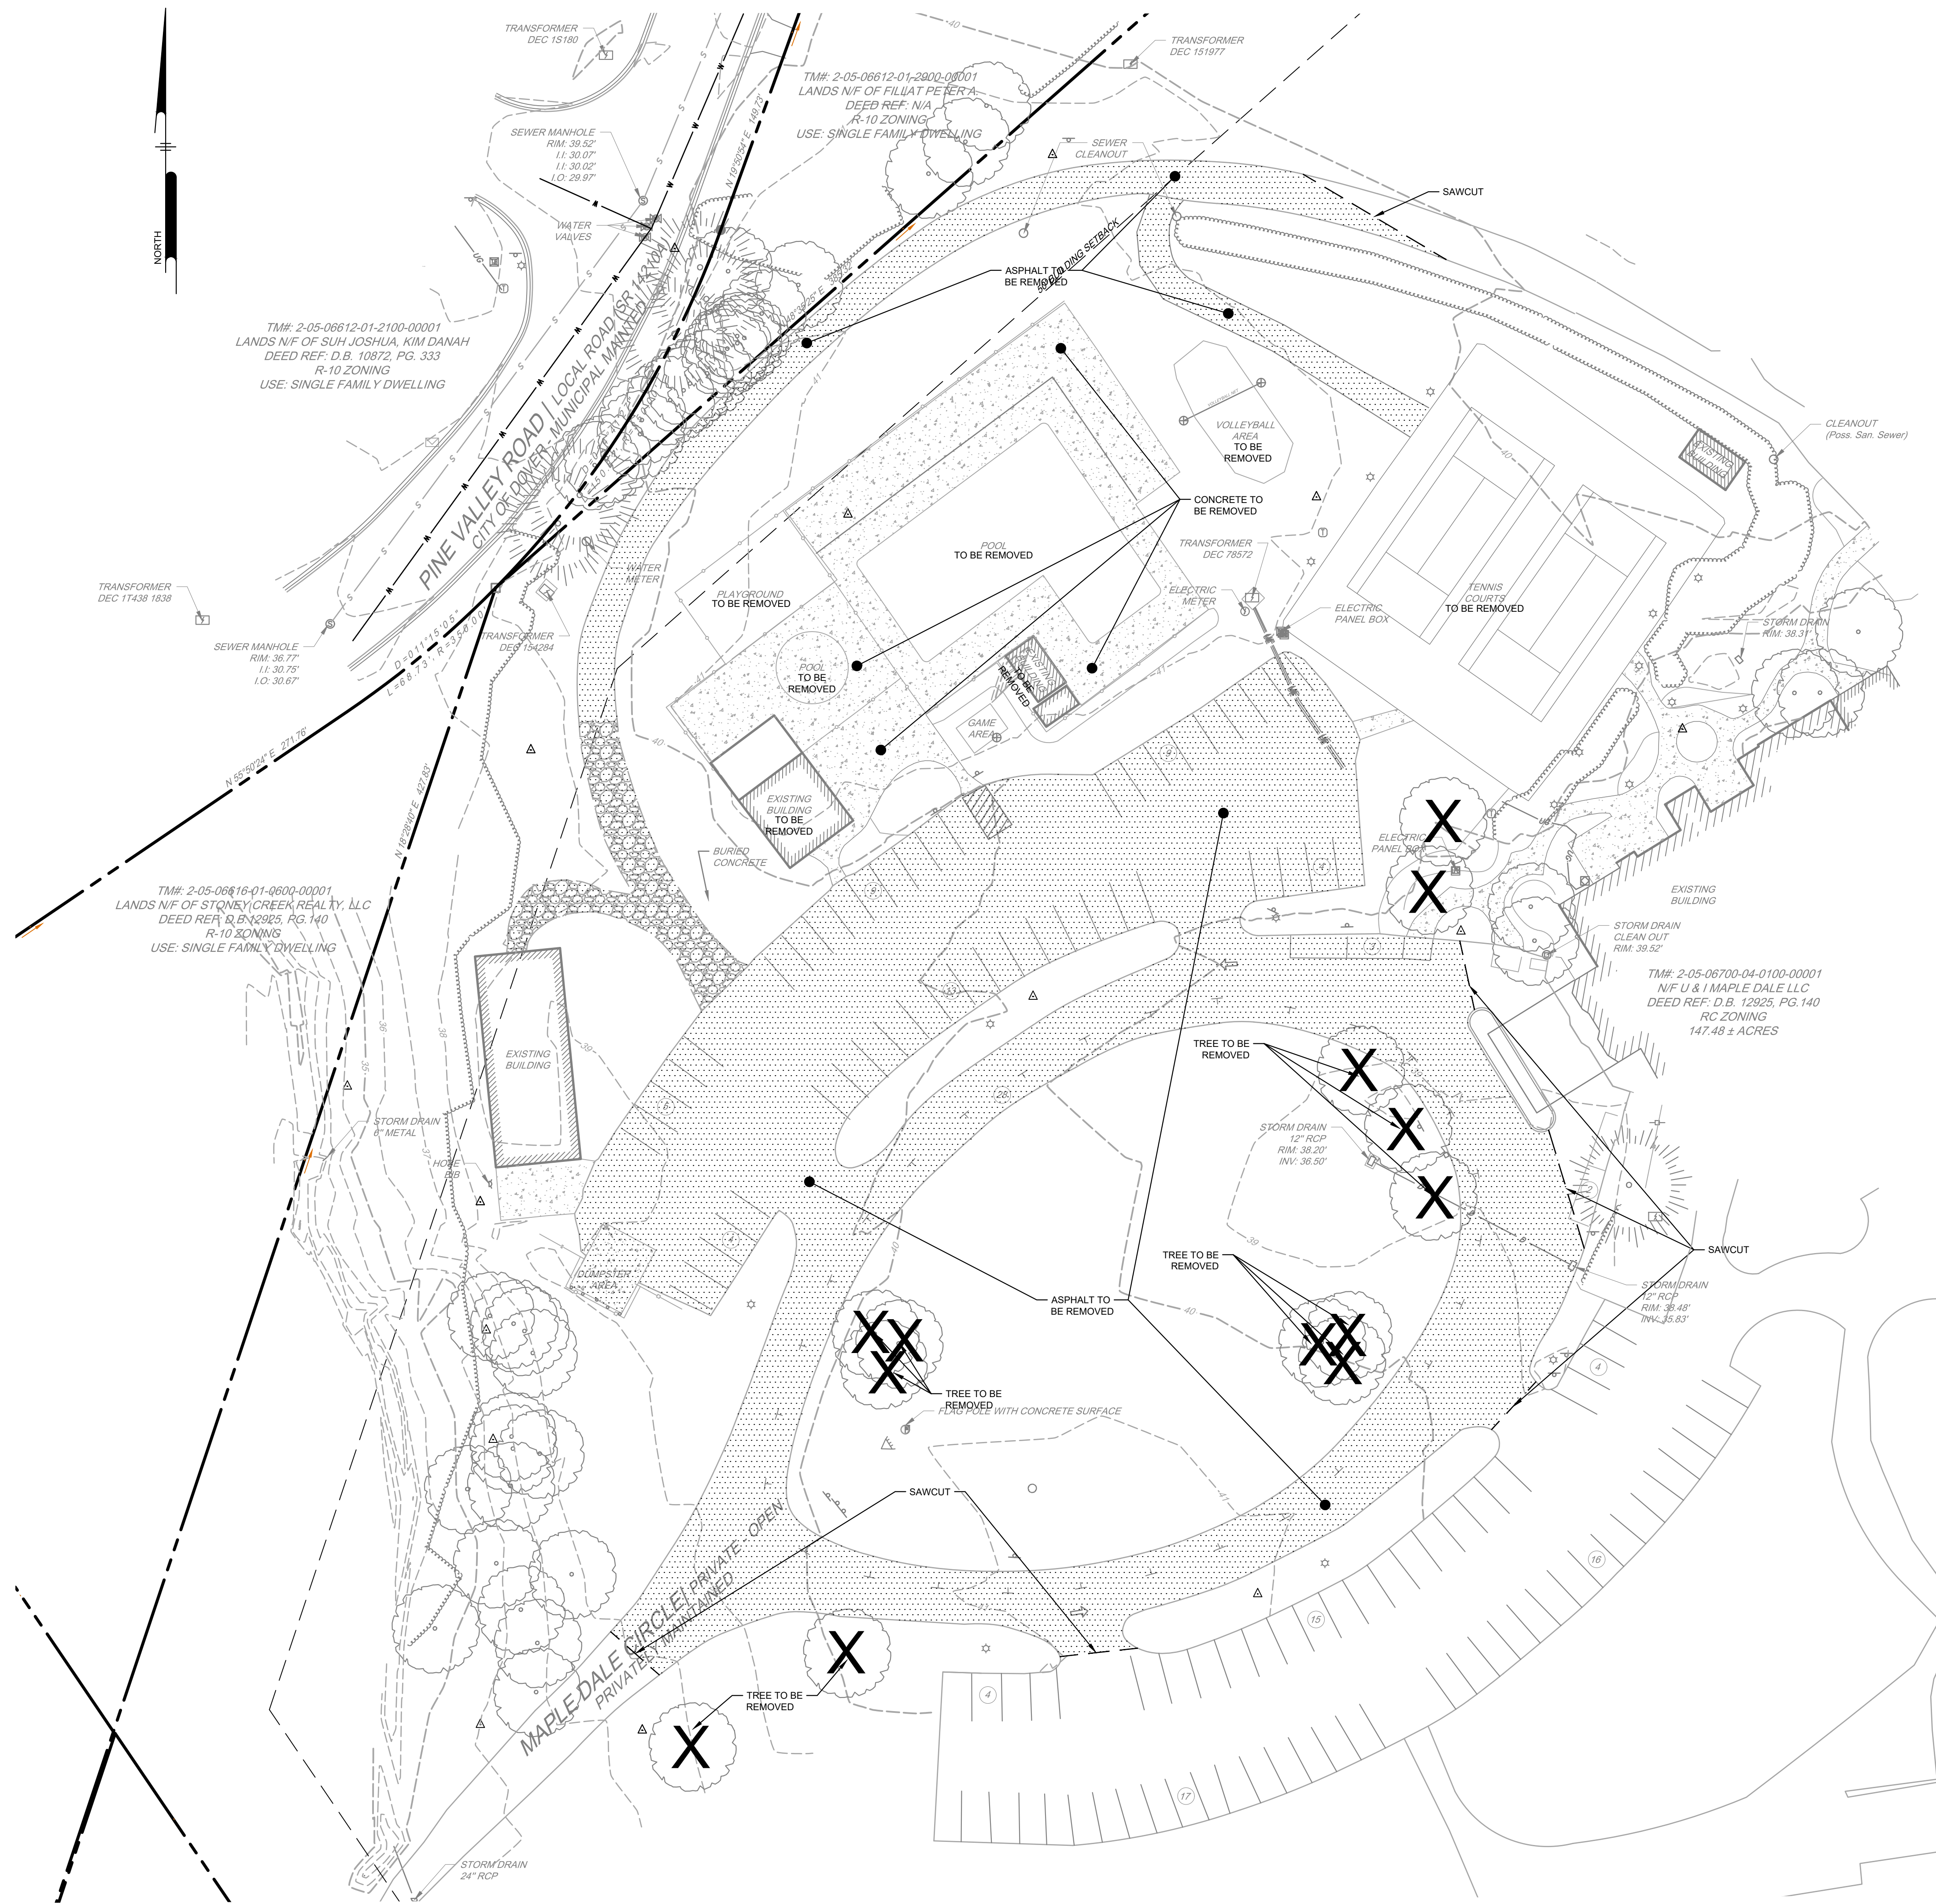


EXISTING CONDITION NOTES:

REFERENCE:
1. SURVEY PERFORMED BY PENNONI ASSOCIATES INC. IN NOVEMBER OF 2024.

GENERAL NOTES:



U:\Account\UAND\UAND24002 - Villages of Maple Dale\DESIGN - SITE\CS1001.dwg PLOTTED: 12/26/25 2:45 PM BY: Steven R. Anderson PLOTSTYLE: Pennoni.ncs,alt

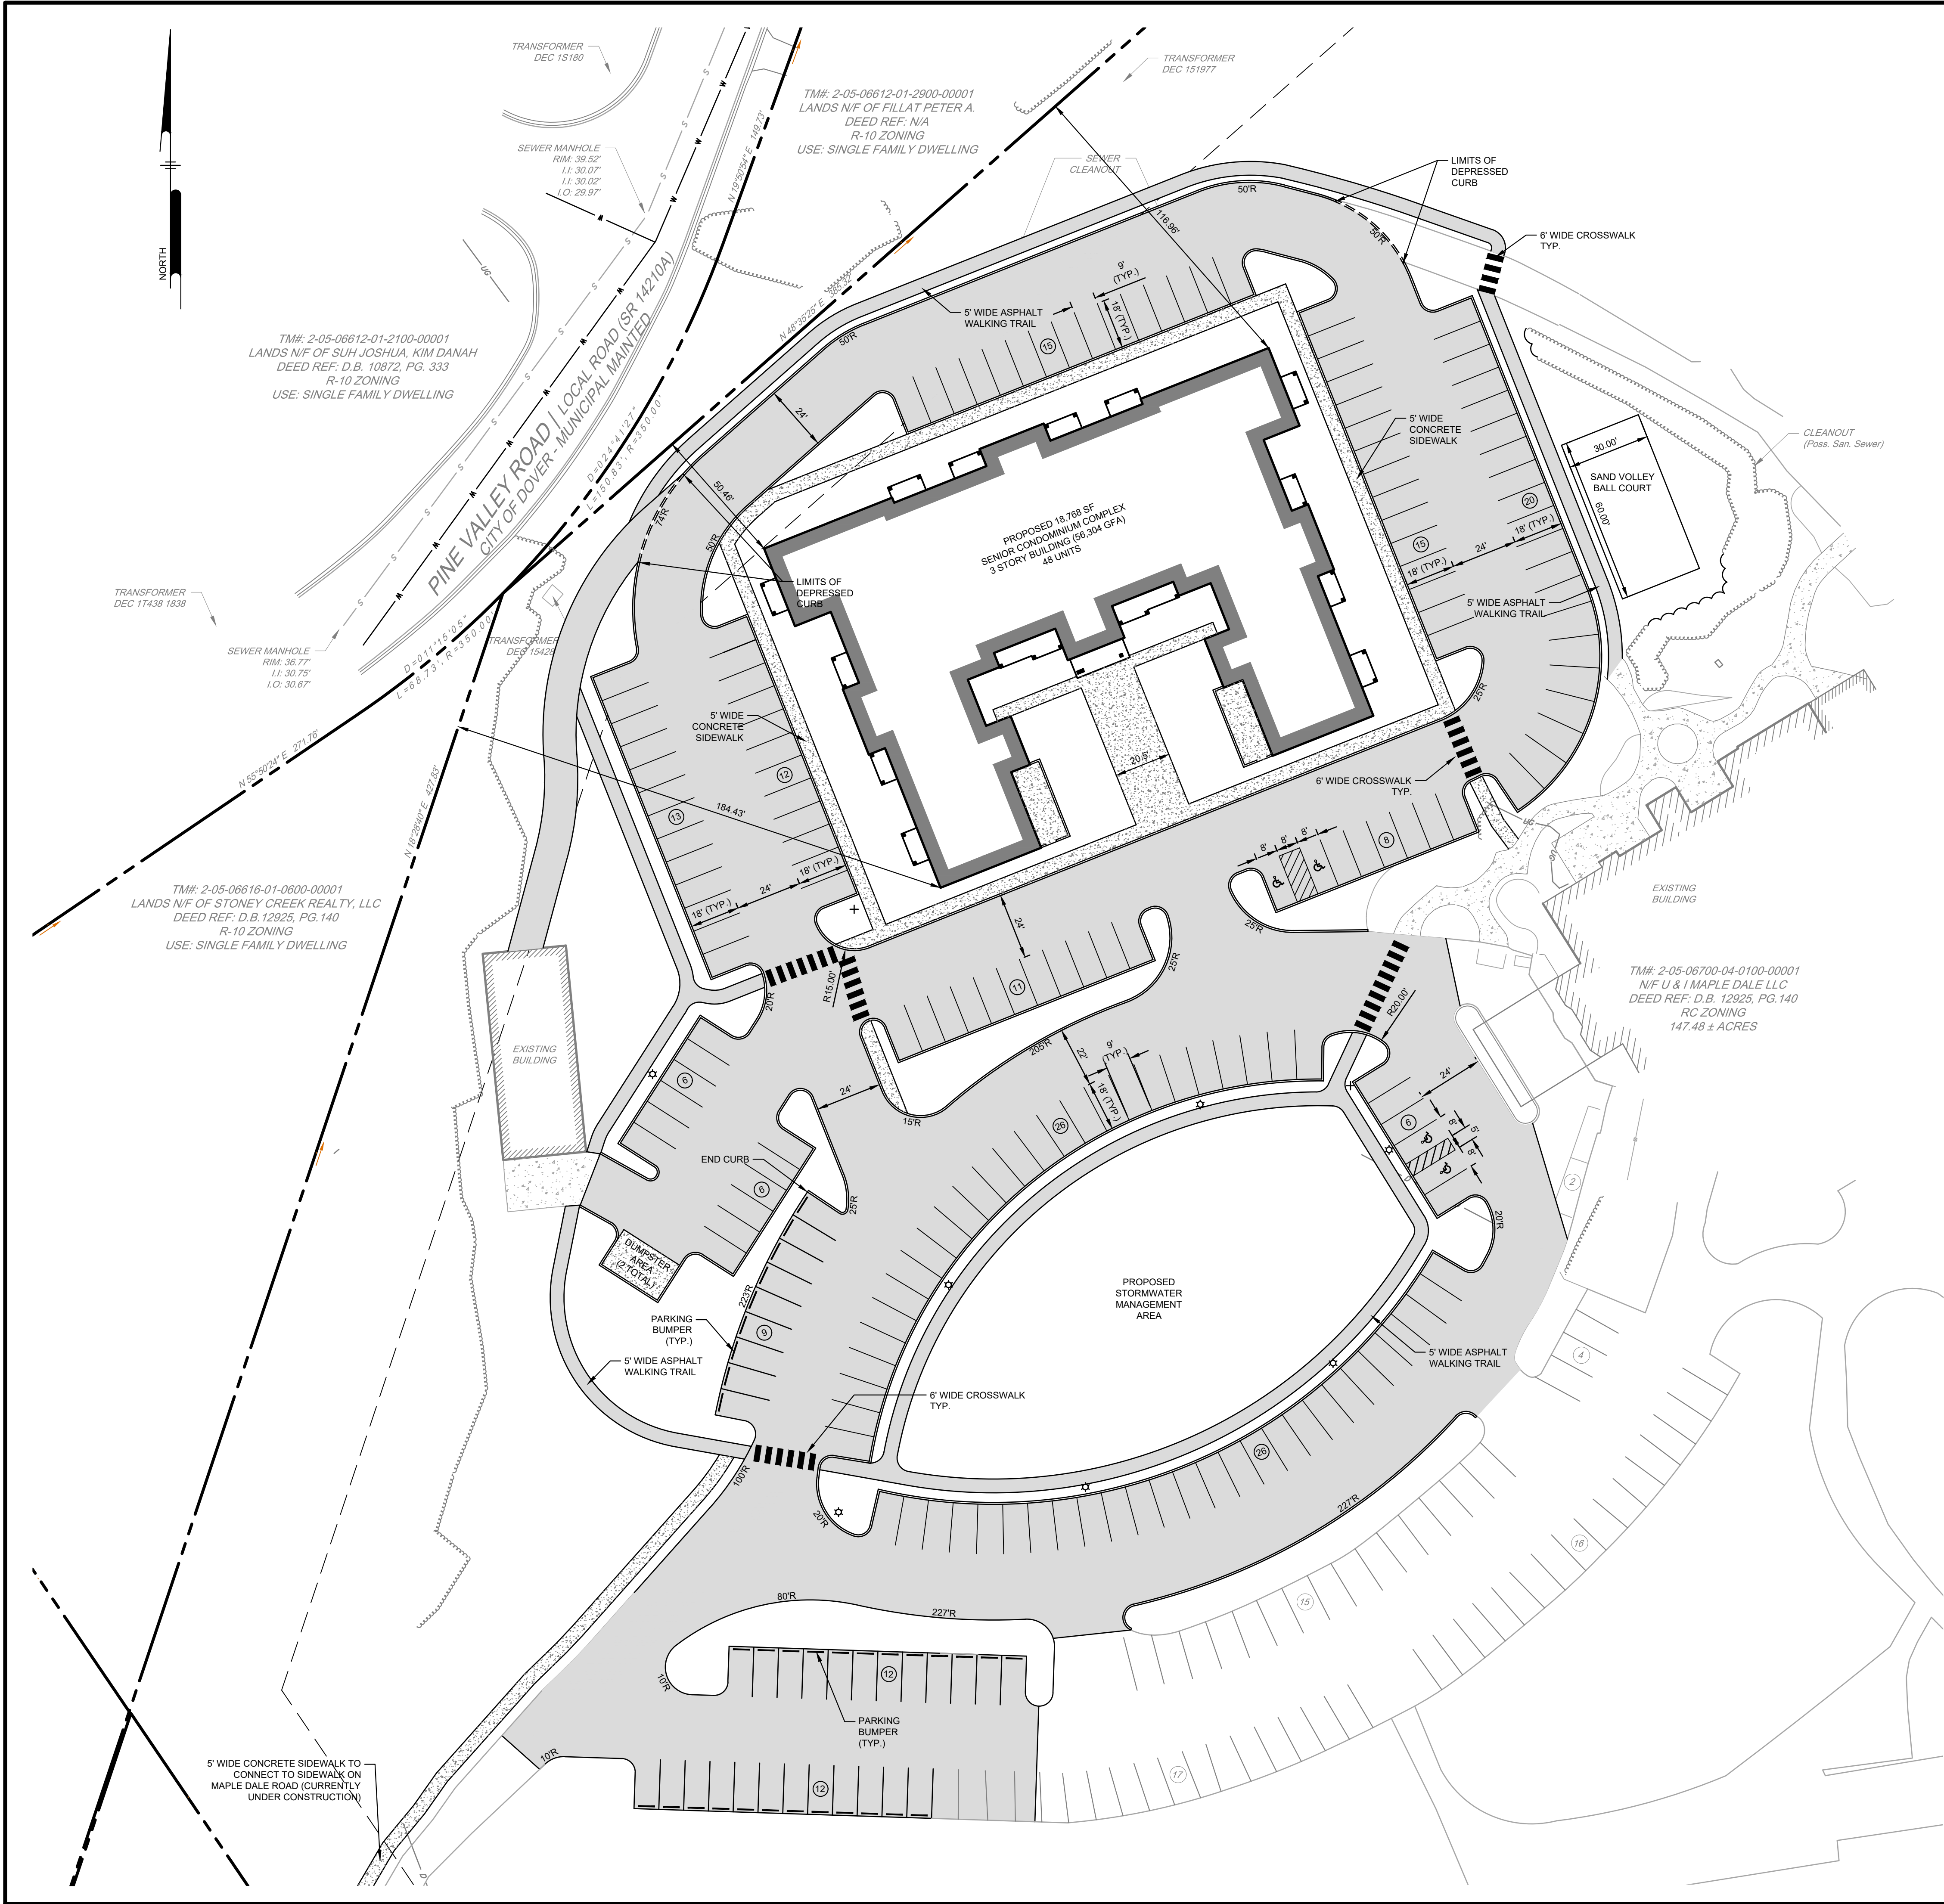

SITE CONSTRUCTION NOTES:

- ALL WORK SHALL COMPLY WITH ALL APPLICABLE STATE, FEDERAL AND LOCAL CODES. ALL NECESSARY LICENSES AND PERMITS SHALL BE OBTAINED BY THE CONTRACTOR AT HIS EXPENSE UNLESS PREVIOUSLY OBTAINED BY OWNER. THE CONTRACTOR SHALL ERECT AND MAINTAIN, AS REQUIRED BY THE CONDITIONS AND PROGRESS OF THE WORK, ALL NECESSARY SAFEGUARDS FOR SAFETY AND PROTECTION.
- THE CONTRACTOR SHALL IMMEDIATELY INFORM THE ENGINEER OF ANY DISCREPANCIES OR ERRORS THEY DISCOVER IN THE PLAN.
- DEVIATION FROM THESE PLANS AND NOTES WITHOUT THE PRIOR CONSENT OF THE OWNER OR HIS REPRESENTATIVE OR THE ENGINEER MAY BE CAUSE FOR THE WORK TO BE REJECTED.
- ALL MATERIALS SHALL BE NEW AND SHALL BE ASBESTOS AND VERMICULITE FREE. ALL MATERIALS SHALL BE STORED SO AS TO ASSURE THE PRESERVATION OF THEIR QUALITY AND FITNESS FOR THE INTENDED WORK.
- DRAWINGS DO NOT INCLUDE NECESSARY COMPONENTS FOR CONSTRUCTION SAFETY. CONTRACTOR SHALL BE RESPONSIBLE FOR ALL WORK TO BE PERFORMED. IT MUST BE IN COMPLIANCE WITH THE OCCUPATIONAL SAFETY AND HEALTH ACT OF 1970, AS AMENDED AND ALL RULES AND REGULATIONS THERETO APPURTENANT.
- PRIOR TO CONSTRUCTION, CONTRACTOR TO FIELD LOCATE AND RECORD AND DAMAGE TO EXISTING PAVING, SIDEWALK, CURB OR STRUCTURES NOT TO BE REMOVED OR REPLACED, ENGINEER TO VERIFY LOCATION AND EXTENT OF DAMAGE.
- THE CONTRACTOR SHALL MAINTAIN ONE COMPLETE SET OF CONTRACT DRAWINGS ON WHICH HE SHALL NOTE, IN RED, THE ALIGNMENTS AND INVERTS OF ALL UNDERGROUND UTILITIES INSTALLED OR ENCOUNTERED DURING THE PROSECUTION OF THE WORK. ALL DISCREPANCIES BETWEEN THE PLAN LOCATIONS AND ELEVATIONS OF BOTH THE EXISTING AND PROPOSED UTILITIES SHALL BE SHOWN ON THE AS-BUILT DRAWINGS TO BE MAINTAINED BY THE CONTRACTOR IN THE FIELD.
- THE CONTRACTOR SHALL OPEN ONLY THAT SECTION OF TRENCH OR ACCESS PITS WHICH CAN BE BACKFILLED AND STABILIZED AT THE END OF EACH WORKING DAY. STEEL PLATES SHALL BE USED ON ANY TRENCH OR ACCESS PITS WHICH MUST REMAIN OPEN OVERNIGHT. THIS REQUIREMENT DOES NOT APPLY TO AREAS COMPLETELY CLOSED AND SECURE FROM VEHICULAR OR PEDESTRIAN TRAFFIC.
- DAMAGE TO EXISTING PAVING, SIDEWALK, CURB OR STRUCTURES NOT TO BE REPLACED OR REMOVED DURING CONSTRUCTION SHALL BE IMMEDIATELY REPORTED TO ENGINEER, CONTRACTOR SHALL REPAIR OR REPLACE ALL DAMAGED WORK WITHOUT CHARGE TO THE OWNER.
- MISS UTILITY SHALL BE NOTIFIED THREE (3) DAYS PRIOR TO EXCAVATION.
- ALL DISTURBED AREAS WITHIN THE LIMIT OF DISTURBANCE, BUT NOT IN PAVEMENT, SHALL BE TOP-SOILED (6" MINIMUM), SEEDED AND MULCHED. IF THE ENGINEER DETERMINES THAT A SATISFACTORY STAND OF GRASS DOES NOT EXIST AT THE TIME OF FINAL INSPECTION, ALL COSTS ASSOCIATED WITH RE-ESTABLISHING A SATISFACTORY STAND OF GRASS SHALL BE AT THE CONTRACTOR'S EXPENSE.
- ALL SIGNING FOR MAINTENANCE OF TRAFFIC IS THE CONTRACTORS RESPONSIBILITY, AND SHALL FOLLOW THE GUIDELINES SHOWN IN LATEST EDITION OF "DELAWARE TRAFFIC CONTROLS" FOR STREETS AND HIGHWAY CONSTRUCTION, MAINTENANCE, UTILITY, AND EMERGENCY OPERATIONS."
- DESIGN, FABRICATION AND INSTALLATION OF ALL PERMANENT SIGNING SHALL BE AS OUTLINED IN THE LATEST VERSION OF THE DE MUTCD.
- DESIGN AND INSTALLATION OF ALL PAVEMENT MARKINGS AND STRIPING SHALL BE AS OUTLINED IN THE LATEST VERSION OF THE DE MUTCD. FOR FINAL PERMANENT PAVEMENT MARKINGS:
 - EPOXY RESIN PAINT SHALL BE REQUIRED FOR LONG LINE STRIPING.
 - THERMO PLASTIC (EXTRUDED OR PREFORMED MATERIAL) WILL BE REQUIRED ON ASPHALT SURFACES, FOR SHORT LINE STRIPING, I.E. SYMBOLS/LEGENDS.
 - PERMANENT PAVEMENT MARKING TAPE (PER DELDOT APPROVED MATERIALS LIST) WILL BE REQUIRED ON CONCRETE SURFACES, FOR SHORT LINE STRIPING, I.E. SYMBOLS/LEGENDS.
- THE CONTRACTOR SHALL NOTIFY THE FOLLOWING, TWO (2) WEEKS PRIOR TO THE START OF CONSTRUCTION:
 - THE OWNER, KENT CONSERVATION DISTRICT, & SITE ENGINEER
- THE CONTRACTOR SHALL MAINTAIN PUBLIC ROADS AND STREETS IN A BROOM SWEEPED CONDITION AT ALL TIMES.
- THE CONTRACTOR SHALL REMOVE AND IMMEDIATELY REPLACE, RELOCATE, RESET OR RECONSTRUCT ALL OBSTRUCTIONS IN THE WORK AREA, INCLUDING, BUT NOT LIMITED TO, MAILBOXES, SIGNS, LANDSCAPING, LIGHTING, PLANTERS, CULVERTS, DRIVEWAYS, PARKING AREAS, CURBS, GUTTERS, FENCES, OR OTHER NATURAL OR MAN-MADE OBSTRUCTIONS. TRAFFIC CONTROL, REGULATORY, WARNING AND INFORMATION SIGNS SHALL REMAIN FUNCTIONAL AND VISIBLE TO THE APPROPRIATE LANES OF TRAFFIC AT ALL TIMES, WITH THEIR RELOCATION KEPT TO A MINIMUM DISTANCE.
- TRANSITIONS FROM PROPOSED SIDEWALK AND CURB TO EXISTING SHALL BE MADE AT THE NEAREST EXISTING JOINT.



VILLAGES OF MAPLE DALE - PHASE 3


180 MAPLE DALE CIRCLE
DOVER, DE 19904 | TAX MAP #: 2-05-06700-04-0100-00


SITE IMPROVEMENT PLAN

U & I MAPLE DALE LLC
1200 SOUTH BAY ROAD
DOVER, DE 19901

ALL DOCUMENTS PREPARED BY PENNONI ASSOCIATES ARE INSTRUMENTS OF SERVICE IN RESPECT OF THE PROJECT. THEY ARE NOT INTENDED OR REPRESENTED TO BE SUITABLE FOR REUSE BY OWNER OR OTHERS ON THE EXTENSIONS OF THE PROJECT OR ON ANY OTHER PROJECT. ANY REUSE WITHOUT WRITTEN VERIFICATION OR ADAPTATION BY PENNONI ASSOCIATES FOR THE SPECIFIC PURPOSE INTENDED WILL BE AT OWNERS SOLE RISK AND WITHOUT LIABILITY OR LEGAL EXPOSURE TO PENNONI ASSOCIATES AND OWNER SHALL INDemnIFY AND HOLD HARMLESS PENNONI ASSOCIATES FROM ALL CLAIMS, DAMAGES, LOSSES AND EXPENSES ARISING OUT OF OR RESULTING THEREFROM.

PROJECT	UAND24002
DATE	2025-01-03
DRAWING SCALE	1" = 30'
DRAWN BY	KRML
APPROVED BY	DDB

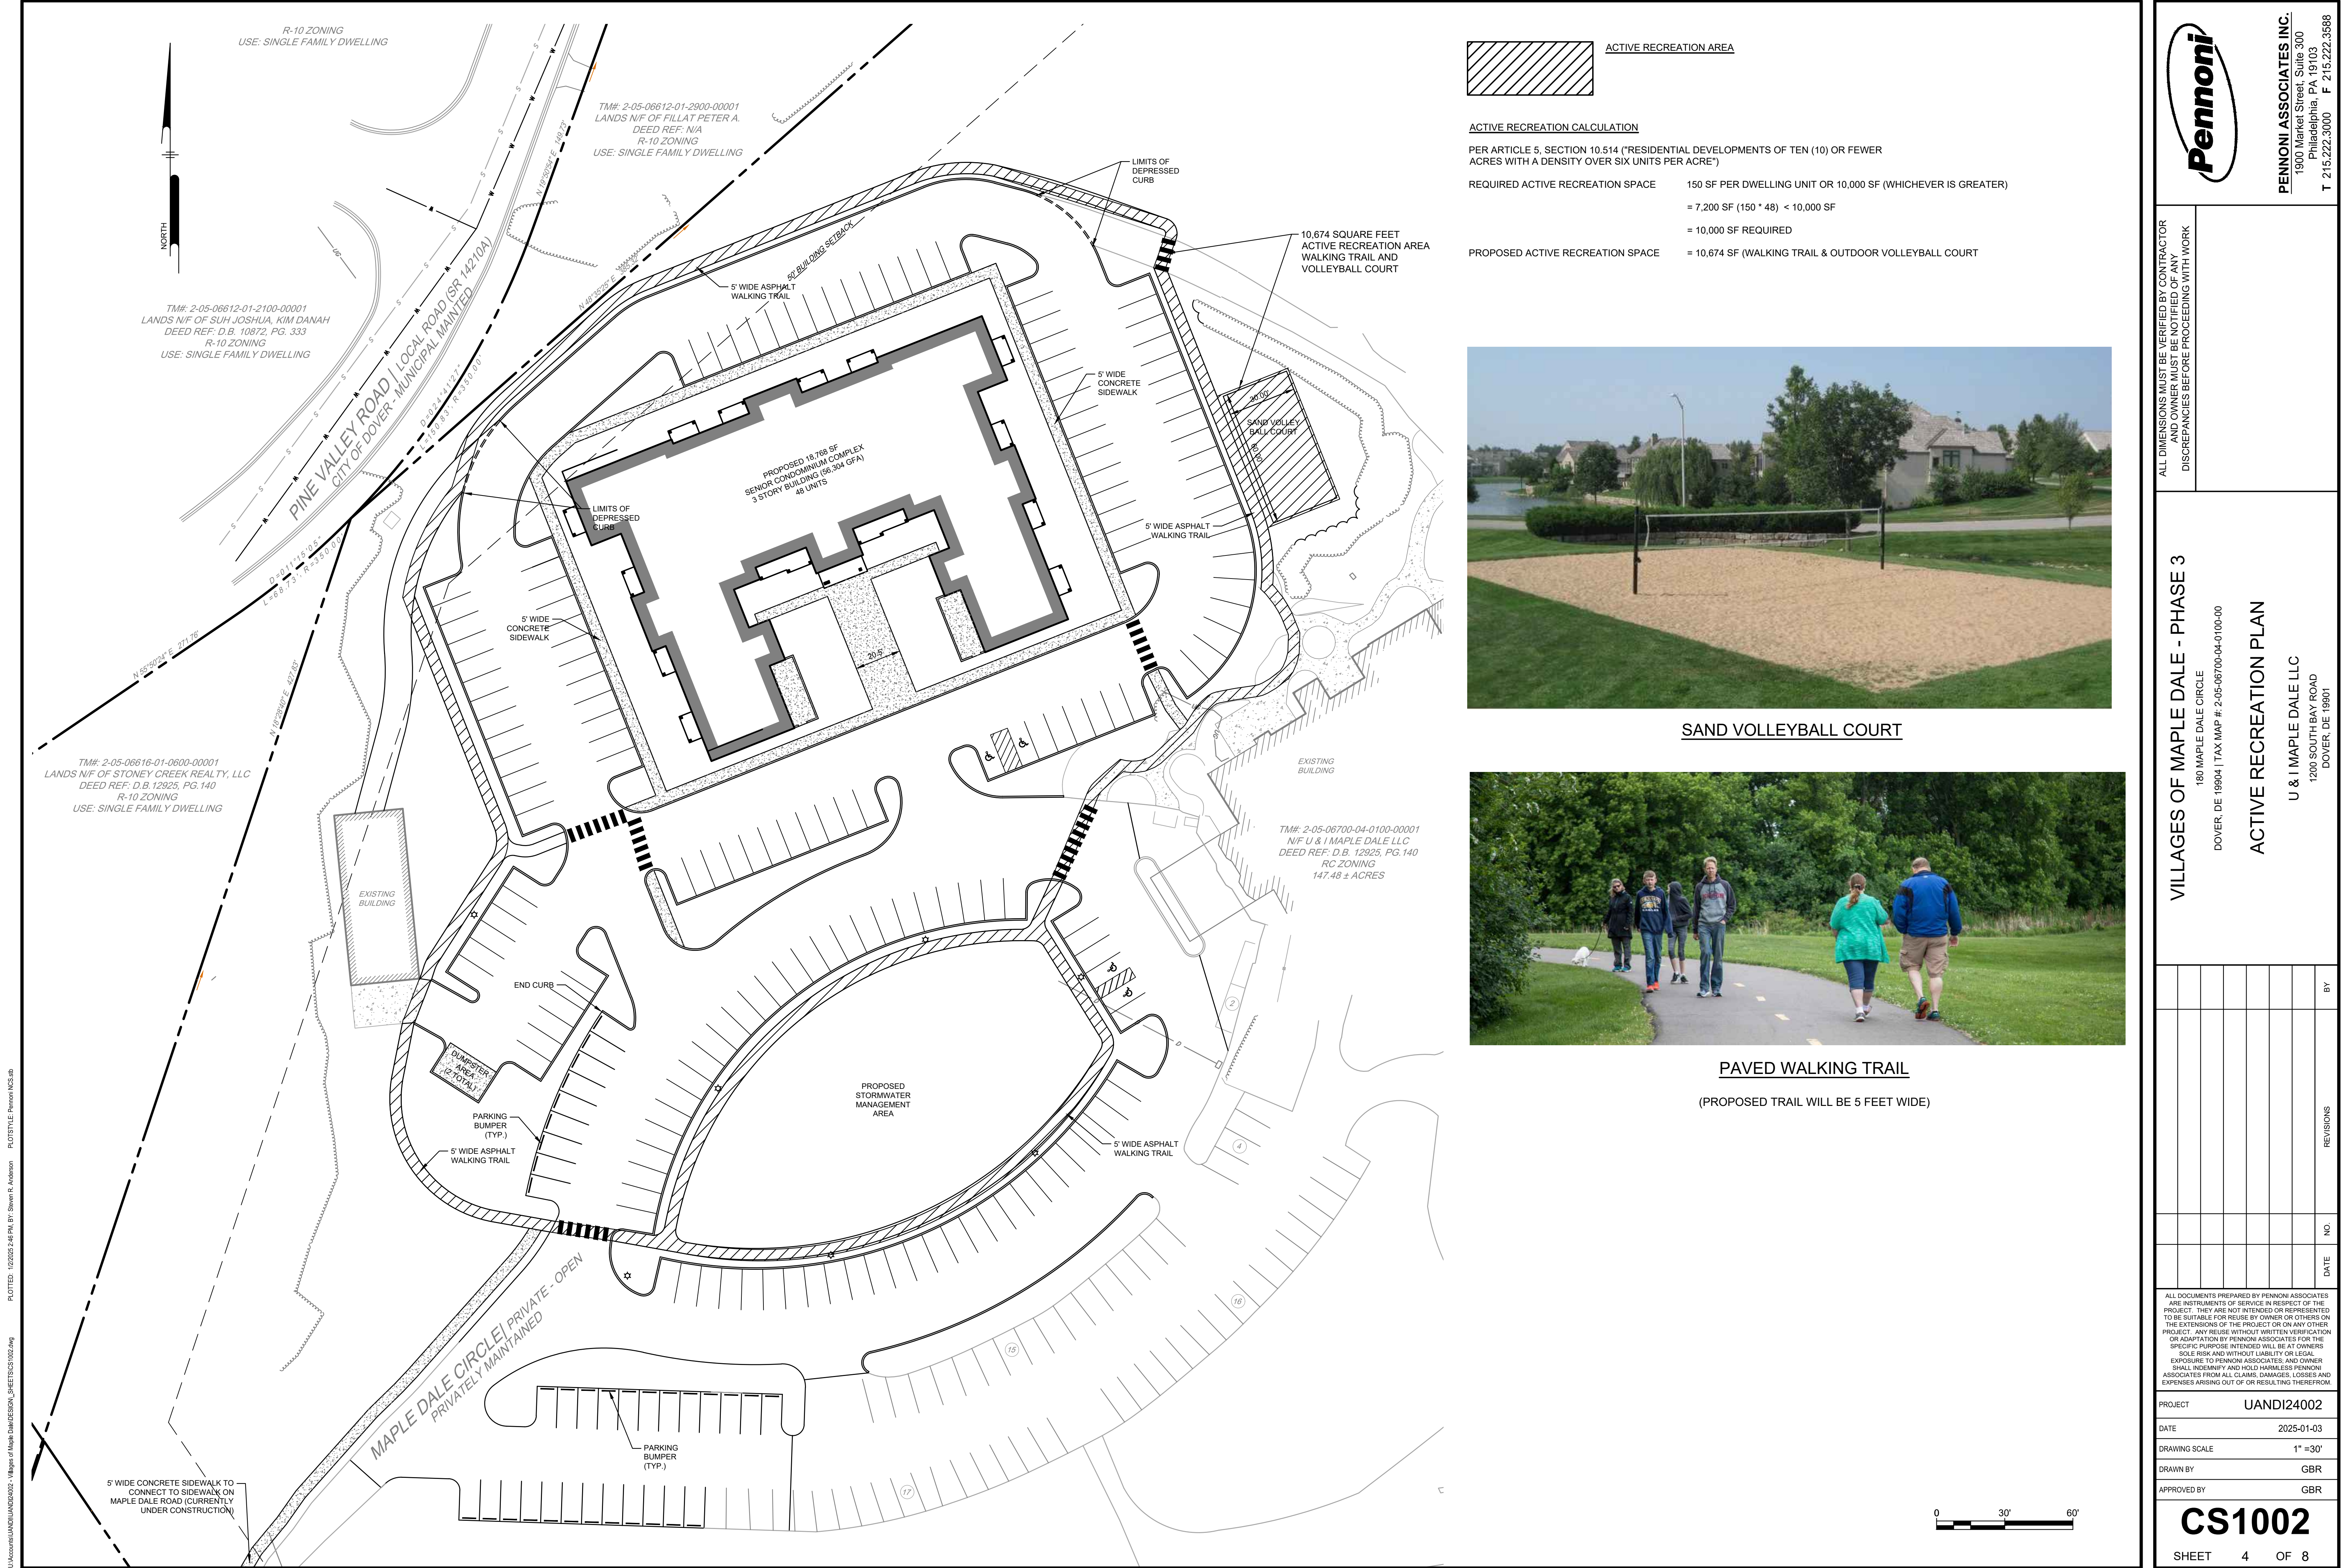

 

1. BEDDING REQUIREMENTS SPECIFIED HEREIN ARE TO BE CONSIDERED AS MINIMUMS FOR RELATIVELY DRY, STABLE EARTH CONDITIONS. ADDITIONAL BEDDING SHALL BE REQUIRED FOR ROCK TRENCHES AND WET AREAS. THE CONTRACTOR SHALL HAVE THE RESPONSIBILITY TO PROVIDE SUCH ADDITIONAL BEDDING AS MAY BE REQUIRED TO PROPERLY CONSTRUCT THE WORK.
2. COMPACTION OF THE BACKFILL OF ALL TRENCHES SHALL BE COMPACTED TO THE DENSITY OF 95% THEORETICAL MAXIMUM DRY DENSITY (ASTM D698). BACKFILL MATERIAL SHALL BE FREE FROM ROOTS, STUMPS, OR OTHER FOREIGN DEBRIS AND SHALL BE PLACED IN LIFTS NOT TO EXCEED 8 INCHES IN COMPACTED FILL THICKNESS. CORRECTION OF ANY TRENCH SETTLEMENT WITHIN A YEAR FROM THE DATE OF FINAL APPROVAL WILL BE THE RESPONSIBILITY OF THE CONTRACTOR. MATERIAL THAT CANNOT BE COMPACTED AS REQUIRED SHALL BE BROUGHT TO THE ATTENTION OF A GEOTECHNICAL ENGINEER, OVER EXCAVATED, AND THEN REPLACED WITH SUITABLE FILL.
3. THE CONTRACTOR WILL INSURE THAT POSITIVE AND ADEQUATE DRAINAGE IS MAINTAINED AT ALL TIMES WITHIN THE PROJECT LIMITS. THIS MAY INCLUDE, BUT NOT BE LIMITED TO, REPLACEMENT OR RECONSTRUCTION OF EXISTING DRAINAGE STRUCTURES THAT HAVE BEEN DAMAGED OR REMOVED OR REGRADED AS REQUIRED BY THE ENGINEER, EXCEPT FOR THOSE DRAINAGE ITEMS SHOWN AT SPECIFIC LOCATIONS AND HAVING SPECIFIC PAY ITEMS IN THE DETAILED ESTIMATE. NO SEPARATE PAYMENT WILL BE MADE FOR ANY COSTS INCURRED TO COMPLY WITH THIS REQUIREMENT.
4. THE CONTRACTOR SHALL PROVIDE ANY AND ALL EXCAVATION AND MATERIAL SAMPLES NECESSARY TO CONDUCT REQUIRED SOIL TESTS, ALL ARRANGEMENTS AND SCHEDULING FOR THE TESTING SHALL BE THE CONTRACTOR'S RESPONSIBILITY.
5. SOILS TESTING AND ON-SITE INSPECTION SHALL BE PERFORMED BY AN INDEPENDENT GEOTECHNICAL ENGINEER. THE SOILS ENGINEER SHALL PROVIDE COPIES OF TEST REPORTS TO THE CONTRACTOR, THE OWNER AND THE OWNER'S REPRESENTATIVE AND SHALL PROMPTLY NOTIFY THE OWNER, HIS REPRESENTATIVE AND THE CONTRACTOR, SHOULD WORK PERFORMED BY THE CONTRACTOR FAIL TO MEET BUILDING STANDARDS.
6. CONTRACTOR SHALL FURNISH AND MAINTAIN ALL NECESSARY BARRICADES AROUND THE WORK AREA AND SHALL PROVIDE PROTECTION AGAINST WATER DAMAGE AND SOIL EROSION.
7. MAXIMUM SIDEWALK CROSS SLOPE IS 2% AND MINIMUM SIDEWALK CROSS SLOPE IS 1% FOR ADA ACCESSIBLE AREAS.
8. VERTICAL ELEVATIONS ARE BASED ON NSR11.
9. ALL SLOPES MAXIMUM 3:1 UNLESS OTHERWISE NOTED.

180 MAPLE DALE CIRCLE
DOVER, DE 19904 | TAX MAP #: 2-05-06700-04-0100-00

U & I MAPLE DALE LLC
1200 SOUTH BAY ROAD
DOVER, DE 19901

[illegible]


ALL DOCUMENTS PREPARED BY PENNONI ASSOCIATES ARE INSTRUMENTS OF SERVICE IN RESPECT OF THE PROJECT. THEY ARE NOT INTENDED OR REPRESENTED TO BE SUITABLE FOR REUSE BY OWNER OR OTHERS ON THE EXTENSIONS OF THE PROJECT OR ON ANY OTHER PROJECT. ANY REUSE WITHOUT WRITTEN REPERMITION OR RE-APPROPRIATION BY PENNONI ASSOCIATES FOR THE SPECIFIC PURPOSE INTENDED WILL BE AT OWNERS SOLE RISK AND WITHOUT LIABILITY OR LEGAL EXPOSURE TO PENNONI ASSOCIATES; AND OWNER SHALL INDEMNIFY AND HOLD HARMLESS PENNONI ASSOCIATES FROM ALL CLAIMS, DAMAGES, LOSSES AND EXPENSES ARISING OUT OF OR RESULTING THEREFROM.

PROJECT	UAND124002
DATE	2025-01-03
DRAWING SCALE	1"=30'
DRAWN BY	KRML
APPROVED BY	DDB

CS1501



 PENNONI ASSOCIATES INC.
Christiana Executive Campus
121 Continental Drive, Suite 207
Newark, DE 19713-4310
T 302.655.4451 F 302.654.2895




1. ALL WORK SHALL COMPLY WITH APPLICABLE STATE, FEDERAL AND LOCAL CODES. ALL NECESSARY LICENSES AND PERMITS SHALL BE OBTAINED BY THE CONTRACTOR AT HIS EXPENSE UNLESS PREVIOUSLY OBTAINED BY THE OWNER.
2. THE CONTRACTOR SHALL IMMEDIATELY INFORM THE ENGINEER OF ANY DISCREPANCIES OR ERRORS THEY DISCOVER IN THE PLAN.
3. DEVIATION FROM THESE PLANS AND NOTES WITHOUT THE PRIOR CONSENT OF THE OWNER OR HIS REPRESENTATIVE OR THE ENGINEER MAY BE CAUSE FOR THE WORK TO BE REJECTED.
4. UTILITIES ENTER THE PREMISES FROM PUBLIC STREETS OR RIGHTS OF WAY.
5. ALL NON-CONDUCTIVE UTILITIES SHALL BE INSTALLED WITH DETECTABLE WARNING TAPE OR TRACER WIRE.
6. ALL PIPE LENGTHS AND DISTANCES BETWEEN STRUCTURES ARE MEASURED FROM CENTER OF STRUCTURE TO CENTER OF STRUCTURE ALONG A HORIZONTAL PLANE.
7. ALL STORM DRAINAGE PIPE SHALL BE LAID ON SMOOTH CONTINUOUS GRADES WITH NO VISIBLE BENDS AT JOINTS.
8. BEDDING REQUIREMENTS SPECIFIED HEREIN ARE TO BE CONSIDERED AS MINIMUMS FOR RELATIVELY DRY, STABLE EARTH CONDITIONS. ADDITIONAL BEDDING SHALL BE REQUIRED FOR ROCK TRENCHES AND WET AREAS. CONTRACTOR SHALL HAVE THE RESPONSIBILITY TO PROVIDE SUCH ADDITIONAL BEDDING AS MAY BE REQUIRED TO PROPERLY CONSTRUCT THE WORK.
9. COMPACTION OF THE BACKFILL OF ALL TRENCHES SHALL BE COMPACTED TO THE DENSITY OF 95% OF THEORETICAL MAXIMUM DRY DENSITY (ASTM D698). BACKFILL MATERIAL SHALL BE FREE FROM ROOTS, STUMPS, OR OTHER FOREIGN DEBRIS AND SHALL BE PLACED IN LIFTS NOT TO EXCEED 8 INCHES IN COMPACTED FILL THICKNESS. CORRECTION OF ANY TRENCH SETTLEMENT WITHIN A YEAR FROM THE DATE OF APPROVAL WILL BE THE RESPONSIBILITY OF THE CONTRACTOR.
10. THE CONTRACTOR WILL INSURE THAT POSITIVE AND ADEQUATE DRAINAGE IS MAINTAINED AT ALL TIMES WITHIN THE PROJECT LIMITS. THIS MAY INCLUDE, BUT NOT BE LIMITED TO, REPLACEMENT OR RECONSTRUCTION OF EXISTING DRAINAGE STRUCTURES. THE CONTRACTOR SHALL REPAIR, REPLACE, DAMAGED OR REGRADE AS REQUIRED BY THE ENGINEER, EXCEPT FOR THOSE DRAINAGE ITEMS SHOWN AT SPECIFIC LOCATIONS AND HAVING SPECIFIC PAY ITEMS IN THE DETAILED ESTIMATE. NO SEPARATE PAYMENT WILL BE MADE FOR ANY COSTS INCURRED TO COMPLY WITH THIS REQUIREMENT.
11. CONTRACTOR MUST APPLY FOR ALL UTILITY CONNECTION APPLICATIONS.
12. CONTRACTOR IS RESPONSIBLE FOR ALL UTILITY CONNECTION FEES.
13. IT IS THE RESPONSIBILITY OF THE CONTRACTOR TO DETERMINE THE LOCATION OF ALL EXISTING UNDERGROUND UTILITIES AND TO TAKE WHATEVER STEPS NECESSARY TO PROVIDE FOR THEIR PROTECTION. THE ENGINEER HAS DILIGENTLY ATTEMPTED TO LOCATE AND IDENTIFY ALL EXISTING FACILITIES ON THESE PLANS. HOWEVER, THIS INFORMATION IS SHOWN FOR THE CONTRACTORS CONVENIENCE. ONLY THE ENGINEER ASSUMES NO RESPONSIBILITY FOR THE LOCATIONS OF UTILITIES SHOWN OR NOT SHOWN. THE CONTRACTOR SHALL CONTACT THE UTILITY COMPANIES FOR EXACT LOCATION OF THEIR UTILITIES PRIOR TO STARTING CONSTRUCTION. IT SHALL BE THE SOLE RESPONSIBILITY OF THE CONTRACTOR TO REPAIR AND REPLACE ANY AND ALL DAMAGE MADE TO UTILITIES BY THE CONTRACTOR.
14. THE CONTRACTOR SHALL COORDINATE LOCATION AND INSTALLATION OF ALL UNDERGROUND UTILITIES AND APPURTENANCES TO MINIMIZE DISTURBANCE TO CURBING, PAVING, AND COMPACTED SUBGRADE.
15. UTILITY COORDINATION SHALL BE INCLUDED IN THE PROJECT SCHEDULE AND IT IS THE EXPLICIT RESPONSIBILITY OF THE CONTRACTOR TO ASSURE THAT THE PROJECT SCHEDULE INCLUDES THE NECESSARY RELOCATION OF THE CONTRACTOR WILL NOT BE PAID ADDITIONALLY FOR THIS COORDINATION. THE CONTRACTOR SHOULD SEEK ASSISTANCE FROM ALL UTILITY COMPANIES TO LOCATE AND PROTECT THEIR FACILITIES.
16. CONTRACTOR SHALL EXCAVATE ONLY AS MUCH TRENCH WHICH PIPE CAN BE INSTALLED AND TRENCH BACKFILLED BY THE END OF EACH WORK DAY.
17. ALL UNDERGROUND UTILITY TRENCHES SHALL BE BACKFILLED WITH SAFE CLEAN FILL.
18. ALL EXISTING CASTING AND INLET TOPS OR GRATES MUST BE ADJUSTED TO THE PROPOSED GRADE, UNLESS OTHERWISE INDICATED.

UTILITY PLAN

U & I MAPLE DALE LLC
1200 SOUTH BAY ROAD
DOVER, DE 19901

PENNONI ASSOCIATES INC.
 Christiana Executive Campus
 121 Continental Drive, Suite 207
 Newark, DE 19713-4310
T 302.655.4451 **F** 302.654.2895

U:\Accounts\UAND\UANDJ24002 - Villages of Maple Dale\DESIGN_SHEETS\CS1701.dwg PLOTTED: 1/2/2025 2:46 PM, BY: Steven R. Anderson PLOTSTYLE: Pennoni NCS.sbt

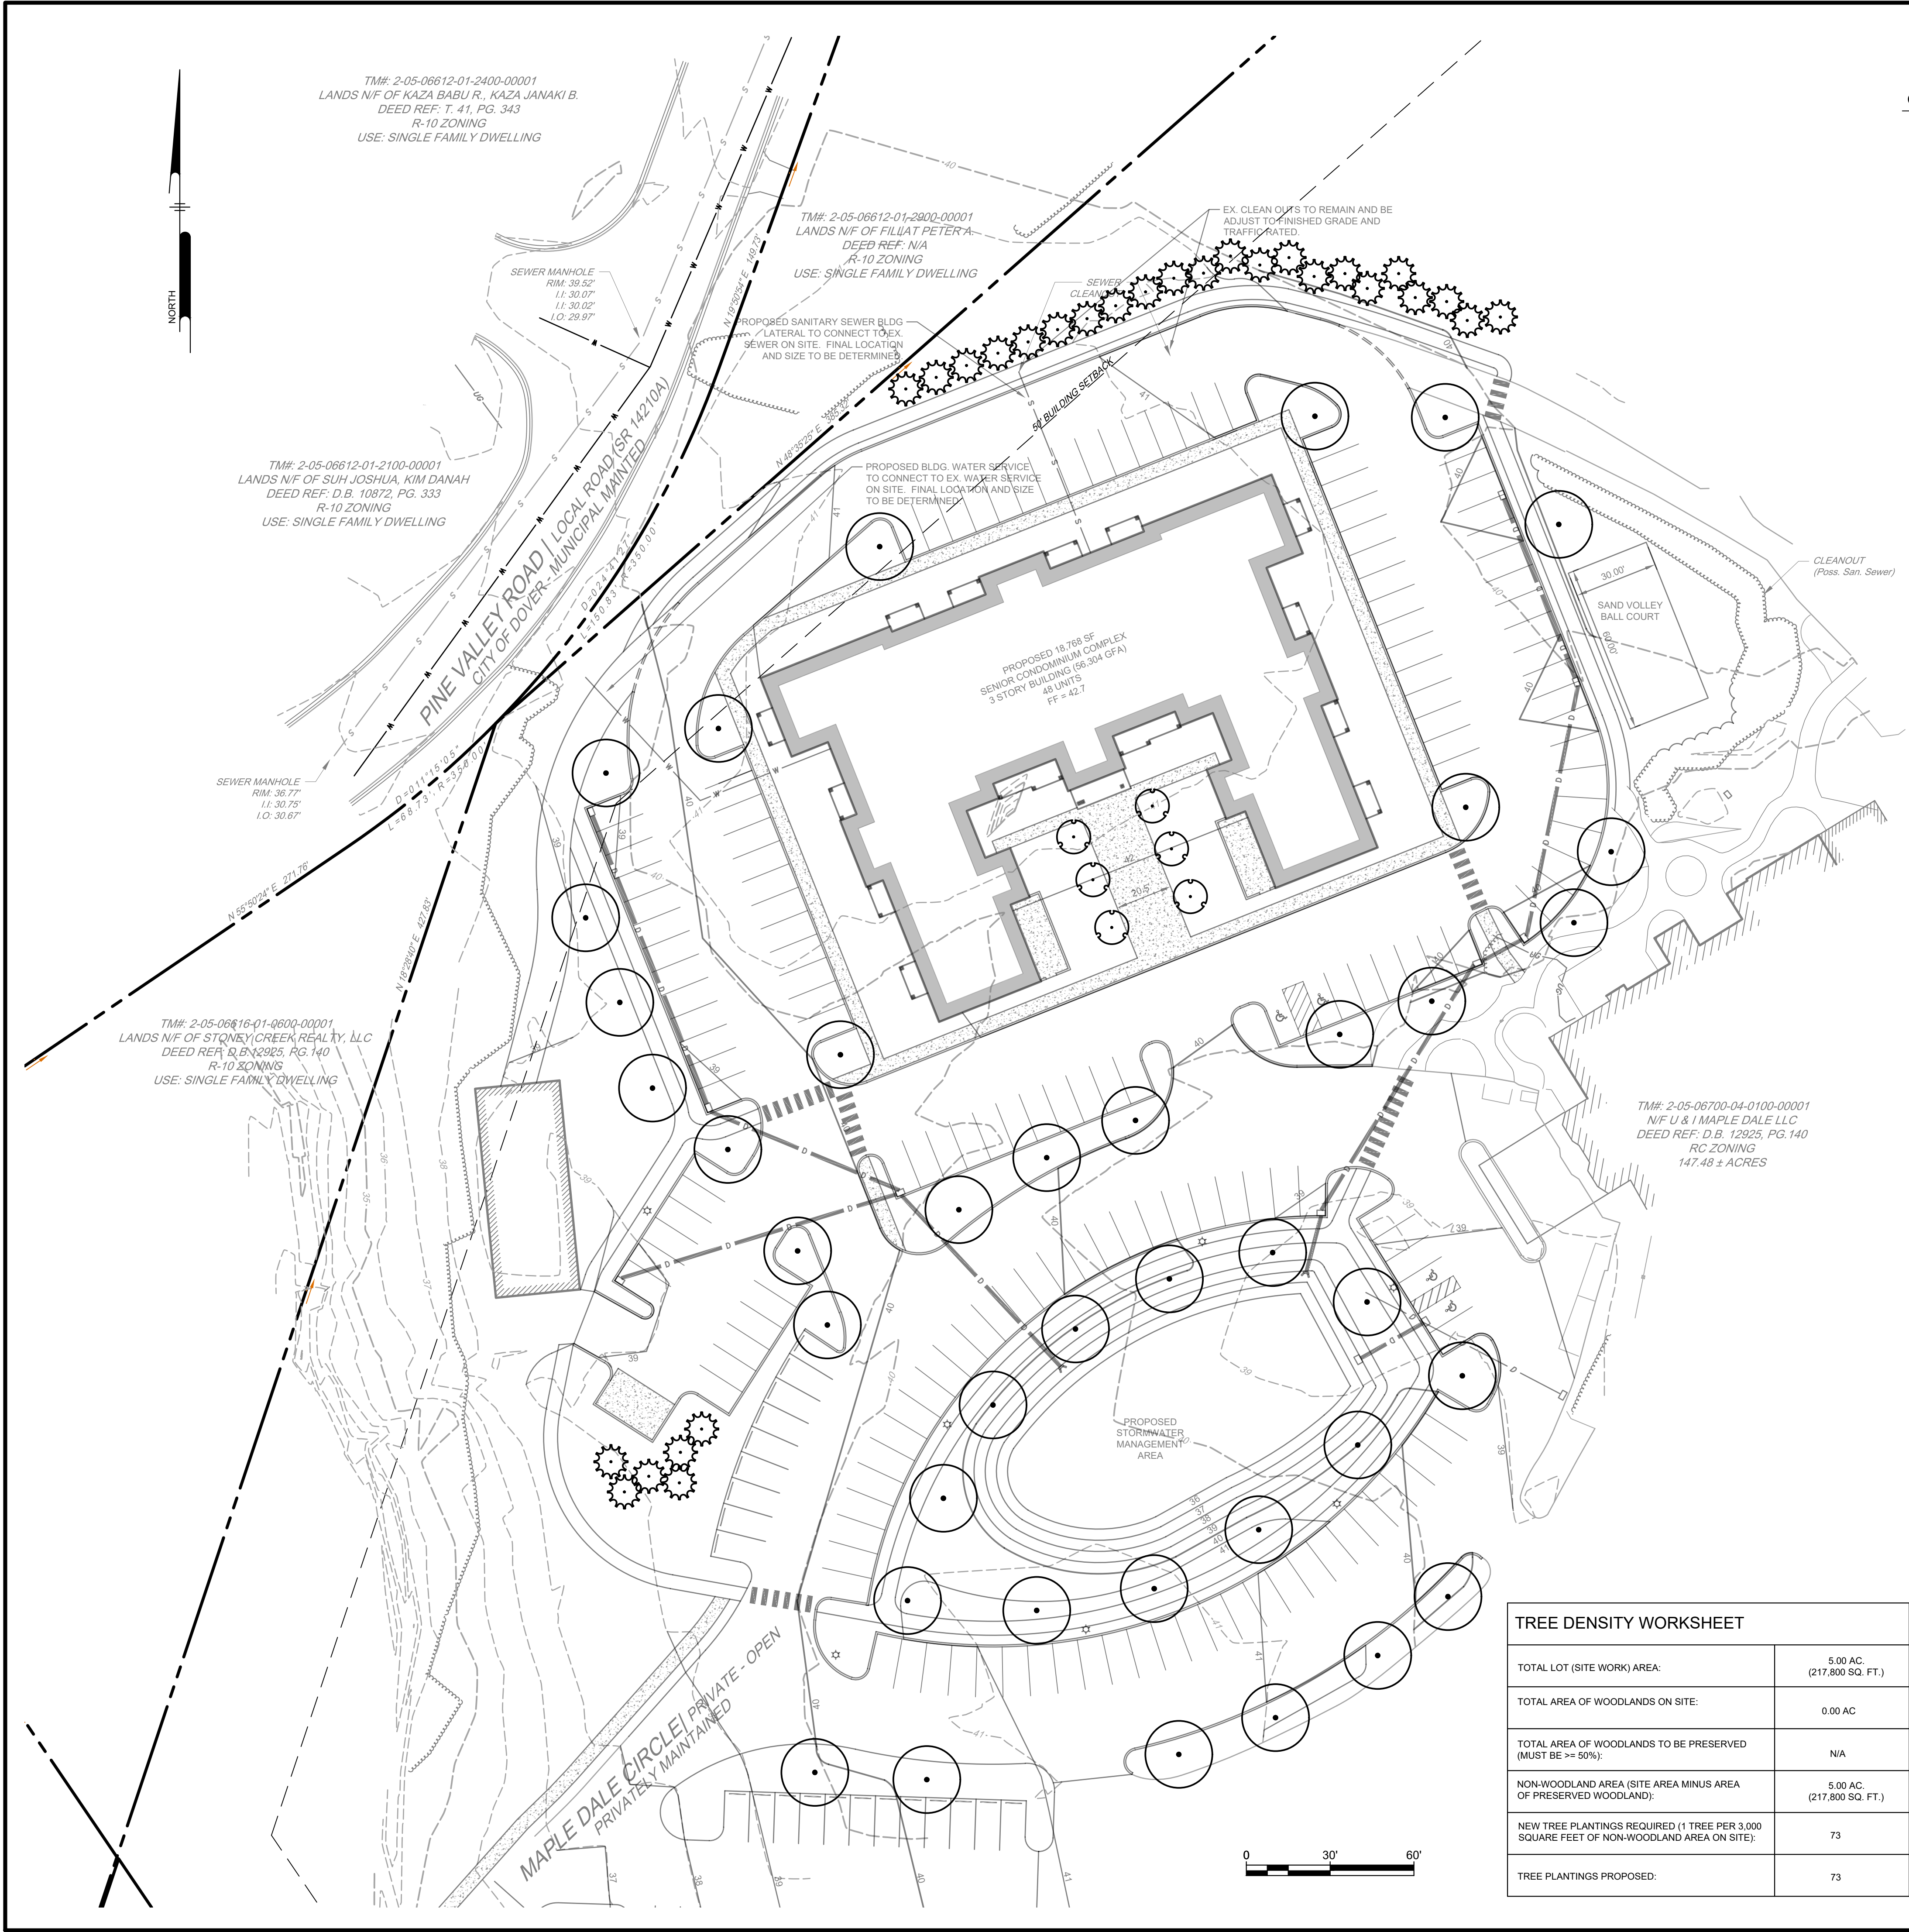

2024-12-30 17:24
CONCEPT PLANT SCHEDULE

	SHADE TREE MIN. 2" CALIPER	39
	EVERGREEN TREE MIN. 5' - 6' TALL	28
	ORNAMENTAL TREE MIN. 5' - 6' TALL	6

PLANTING NOTES AND SPECIFICATIONS

- ALL TOPSOIL SHALL BE A MINIMUM 4" IN ALL SOD AREAS, 6" IN SEEDED AREAS AND 8" IN TREE, SHRUB AND GROUND COVER BEDS, INCLUDING PARKING LOT ISLAND BEDS.
- PLANTING BEHIND PERPENDICULAR PARKING IS TO BE LOCATED A MINIMUM OF 5' BEHIND THE CURB LINE.
- ALL LANDSCAPE AND GRASS AREAS ARE TO BE HAND RAKED AND LEFT CLEAR OF ALL STONES, ROCK, CONSTRUCTION DEBRIS AND ANY UNSUITABLE MATERIALS.
- LANDSCAPE CONTRACTOR WILL LOCATE ALL UNDERGROUND UTILITIES PRIOR TO ANY EXCAVATION AND PLANTING INSTALLATION.
- ALL PROPOSED LANDSCAPING TO BE NURSERY GROWN, TYPICAL OF THEIR SPECIES OR VARIETY. THEY ARE TO HAVE NORMAL VIGOROUS ROOT SYSTEMS, FREE FROM DEFECTS AND INFECTIONS AND IN ACCORDANCE WITH ANSI Z60.1
- ALL PROPOSED PLANTINGS SHOULD BE INSTALLED PER STANDARDS OF THE AMERICAN NURSERY AND LANDSCAPE ASSOCIATION, LATEST EDITION, AND STATE NURSERY LANDSCAPE ASSOCIATIONS WITH REGARD TO PLANTING, PIT SIZE, BACKFILL MIXTURE, STAKING AND GUYING.
- ALL PLANTING CONTAINERS AND BASKETS SHALL BE REMOVED DURING PLANTING. ALL PLANTS SHALL BE SET PLUMB AND POSITIONED SO THAT THE TOP OF THE ROOT COLLAR MATCHES, OR IS NO MORE THAN TWO (2") INCHES ABOVE, FINISHED GRADE. REPLACE AMENDED BACKFILL IN 6-INCH LAYERS AND COMPACT BACKFILL TO ELIMINATE VOIDS. CONTRACTOR SHALL PROVIDE A FOUR-INCH HIGH EARTHEN WATERING SAUCER ALONG THE PERIMETER OF EACH PLANTING PIT. CONTRACTOR SHALL WATER NEWLY PLANTED VEGETATION PRIOR TO MULCHING PLANTING PIT. ALL VOIDS SHALL BE FILLED AND SETTLING MITIGATED AS REQUIRED.
- AFTER INITIAL WATERING AND PRIOR TO MULCHING, CONTRACTOR SHALL APPLY HERBICIDES AND PRE-EMERGENT HERBICIDES AS REQUIRED TO ELIMINATE ANY WEED SEEDS OR PLANTS PRESENT ON ROOT BALL.
- ALL PLANTING BEDS AND PITS SHALL BE MULCHED WITH DOUBLE GROUND HARDWOOD MULCH AT A MINIMUM DEPTH OF 3".
- SEEDBED PREPARATION:
 - APPLY LIMESTONE AND FERTILIZER ACCORDING TO SOIL TESTS OR FERTILIZER MAY BE APPLIED AT THE RATE OF 200 POUNDS PER ACRE OR 6 POUNDS PER 1000 SQUARE FEET USING 10-20-10 OR EQUIVALENT. IN ADDITION, 300 POUNDS 4-1-2 PER ACRE OR EQUIVALENT OF SLOW RELEASE NITROGEN MAY BE USED IN LIEU OF TOP DRESSING.
 - WORK LIME AND FERTILIZER INTO THE SOIL AS PRACTICAL TO A DEPTH OF 4-INCHES WITH A DISC, SPRING TOOTH HARROW OR OTHER SUITABLE EQUIPMENT. THE FINAL HARROWING OR DISKING OPERATION SHOULD PARALLEL TO THE GENERAL CONTOUR. CONTINUE TILLAGE UNTIL A REASONABLE UNIFORM, FINE SEEDBED IS PREPARED. ALL BUT CLAY OR SILTY SOILS AND COARSE SANDS SHOULD BE ROLLED TO FIRM THE SEEDBED WHEREVER FEASIBLE.
 - INSPECT SEEDBED JUST BEFORE SEEDING. IF TRAFFIC HAS LEFT THE SOIL COMPACTED, THE AREA MUST BE RETILLED AND FIRMED AS OUTLINED BELOW.
 - IN AREAS DESIGNATED AS SOD, FESCUE SOD IS TO BE INSTALLED ON MINIMUM 4" TOPSOIL. AREAS TO BE SODDED ARE TO BE PREPARED AS NOTED ABOVE FOR SEEDED AREAS.
- TOPSOIL WITH A QUALITY ORGANIC SOIL AMENDMENT SHALL BE USED FOR ALL PLANTING AND SEEDING OPERATIONS.
- NOTIFY ALL UTILITY COMPANIES AND LOCATE ALL UTILITIES PRIOR TO EXCAVATING PLANT PITS. PLANT LOCATIONS MAY BE ADJUSTED IN THE FIELD TO AVOID INTERFERENCE WITH UNDERGROUND UTILITIES.
- SHOULD ANY DISCREPANCY ARISE BETWEEN THE PLANTING PLAN AND THE PLANTING SCHEDULE, THE PLAN SHALL GOVERN AS TO THE QUANTITY OF PLANT MATERIAL.
- ALL SHADE TREES TO BE PRUNED OF SIDE BRANCHES TO A HEIGHT OF 6' ABOVE GRADE EXCEPT WHERE NOTED IN PLANT SCHEDULE.
- ALL PLANT MATERIAL SHALL BE APPROVED UPON ARRIVAL TO THE SITE, UNLESS OTHERWISE NOTIFIED.
- PROPOSED PLANT MATERIAL MAY BE SUBSTITUTED BY SIMILAR PLANTS PRIOR TO INSTALLATION, SUBJECT TO APPROVAL BY THE LANDSCAPE ARCHITECT AND NEW CASTLE COUNTY.
- DISTURBANCE OF EXISTING VEGETATION SHALL BE LIMITED TO WORK AREA CONTRACTOR IS RESPONSIBLE FOR FINE GRADING AND SEEDING ALL DISTURBED AREAS.
- ALL PLANTS SPACED 7' O.C. OR CLOSER SHALL BE IN CONTINUOUS MULCHED BEDS.
- SEED ALL DISTURBED AREAS WITH GRASS SEED MIX SPECIFIED IN SEDIMENT CONTROL REQUIREMENTS.
- ALL PLANT MATERIAL SHALL BE WARRANTED AGAINST DEATH AND UNSATISFACTORY GROWTH FOR A MINIMUM PERIOD OF ONE YEAR AFTER THE DATE OF WRITTEN FINAL ACCEPTANCE BY THE LANDSCAPE ARCHITECT AND/OR MUNICIPALITY REPRESENTATIVE. ANY PLANT MATERIAL THAT DIES OR PERFORMS POORLY DURING THE WARRANTY PERIOD SHALL BE PROMPTLY REMOVED AND REPLACED IN KIND.

LANDSCAPE MAINTENANCE NOTES

- ANY AND ALL PLANT MATERIAL THAT DIES OR FAILS TO THRIVE SHALL BE IMMEDIATELY REPLACED WITH LIKE SPECIES. RECOMMENDED ANNUAL MAINTENANCE OF SITE VEGETATION TO INCLUDE BUT NOT BE LIMITED TO:
- FERTILIZER:** MOW LAWN - FERTILIZE TWICE PER YEAR.
 - PRUNING:** PRUNING SHALL BE LIMITED OR REMOVAL OF DEAD WOOD OR BRANCHES FOR TREES OR FOR SIGHT DIFFERENCES/SAFETY REASONS. PRUNING OF SHRUBS AND TREES SHALL BE LIMITED TO THE PRUNING NECESSARY TO MAINTAIN THE NATURAL SHAPE OF THE PLANT EXCEPT FOR SHEARED HEDGES.
 - PEST CONTROL:** PRE-EMERGENT WEED CONTROL FOR MOWN LAWNS AND SHRUB BEDS MAY BE APPLIED IN FEBRUARY. CHEMICAL TREATMENT FOR INSECT INFESTATION AND DISEASE MAY BE APPLIED AND SHALL BE SPECIFIC TO THE PROBLEM.
 - MULCHING:** MULCHING SHALL BE MAINTAINED AT A DEPTH OF 3" IN PLANT BEDS AND AROUND BASE OF TREES.
 - MOWING:** MOWN LAWN SEED MIX SHALL BE MOWN AT REGULAR INTERVALS THROUGHOUT THE GROWING SEASON. GRASS HEIGHT SHOULD NOT EXCEED 3 INCHES. MOWER BLADES SHALL BE SET AND 2-1/2 INCHES UNLESS OTHERWISE DIRECTED. WHERE APPLICABLE, RAIN GARDEN AND/OR MEADOW SEED MIXES SHALL BE MOWN ONLY ONCE YEARLY IN LATE WINTER.
 - PLANT PROTECTION:** AVOID EXCESS INTRUSION INTO THE ROOT ZONE AREA OF ESTABLISHED PLANTINGS.
 - WATERING:** UNLESS STATED OTHERWISE IN THESE DOCUMENTS, PROVIDE APPROXIMATELY 1-INCH OF RAINFALL/WATER PER WEEK THROUGHOUT THE GROWING SEASON FOR THE FIRST YEAR.

TREE DENSITY WORKSHEET

TOTAL LOT (SITE WORK) AREA:	5.00 AC. (217,800 SQ. FT.)
TOTAL AREA OF WOODLANDS ON SITE:	0.00 AC
TOTAL AREA OF WOODLANDS TO BE PRESERVED (MUST BE >= 50%):	N/A
NON-WOODLAND AREA (SITE AREA MINUS AREA OF PRESERVED WOODLAND):	5.00 AC. (217,800 SQ. FT.)
NEW TREE PLANTINGS REQUIRED (1 TREE PER 3,000 SQUARE FEET OF NON-WOODLAND AREA ON SITE):	73
TREE PLANTINGS PROPOSED:	73

LANDSCAPE ARCHITECT CERTIFICATION

I, GREGORY B. RISHEL, HEREBY CERTIFY THAT I AM A LICENSED LANDSCAPE ARCHITECT IN THE STATE OF DELAWARE, THAT THE INFORMATION SHOWN HEREON HAS BEEN PREPARED UNDER MY SUPERVISION AND TO THE BEST OF MY BEST KNOWLEDGE AND BELIEF REPRESENTS GOOD LANDSCAPE ARCHITECTURAL PRACTICES AS REQUIRED BY THE APPLICABLE LAWS OF THE STATE OF DELAWARE.

GREGORY B. RISHEL, P.L.A. DELAWARE LA LICENSE #S1-0000435 DATE



PENNONI ASSOCIATES INC.
Christiana Executive Campus
121 Continental Drive, Suite 207
Newark, DE 19713-4310
T 302.655.4451 F 302.654.2895

ALL DIMENSIONS MUST BE VERIFIED BY CONTRACTOR
AND OWNER MUST BE NOTIFIED OF ANY
DISCREPANCIES BEFORE PROCEEDING WITH WORK

VILLAGES OF MAPLE DALE - PHASE 3

180 MAPLE DALE CIRCLE
DOVER, DE 19904 | TAX MAP # 2-05-06700-04-0100-00

LANDSCAPE PLAN


U & I MAPLE DALE LLC

1200 SOUTH BAY ROAD
DOVER, DE 19901

NO.	DATE	REVISIONS	BY

ALL DOCUMENTS PREPARED BY PENNONI ASSOCIATES ARE INSTRUMENTS OF SERVICE IN RESPECT OF THE PROJECT. THEY ARE NOT INTENDED OR REPRESENTED TO BE SUITABLE FOR REUSE BY OWNER OR OTHERS ON THE EXTENSIONS OF THE PROJECT OR ON ANY OTHER PROJECT. ANY REUSE WITHOUT WRITTEN VERIFICATION OR ADAPTATION BY PENNONI ASSOCIATES FOR THE SPECIFIC PURPOSE INTENDED WILL BE AT OWNERS SOLE RISK AND WITHOUT LIABILITY OR LEGAL EXPOSURE TO PENNONI ASSOCIATES AND OWNER SHALL INDEMNIFY AND HOLD HARMLESS PENNONI ASSOCIATES FROM ALL CLAIMS, DAMAGES, LOSSES AND EXPENSES ARISING OUT OF OR RESULTING THEREFROM.

PROJECT	UAND124002
DATE	2025-01-03
DRAWING SCALE	1" = 30'
DRAWN BY	GBR
APPROVED BY	GBR

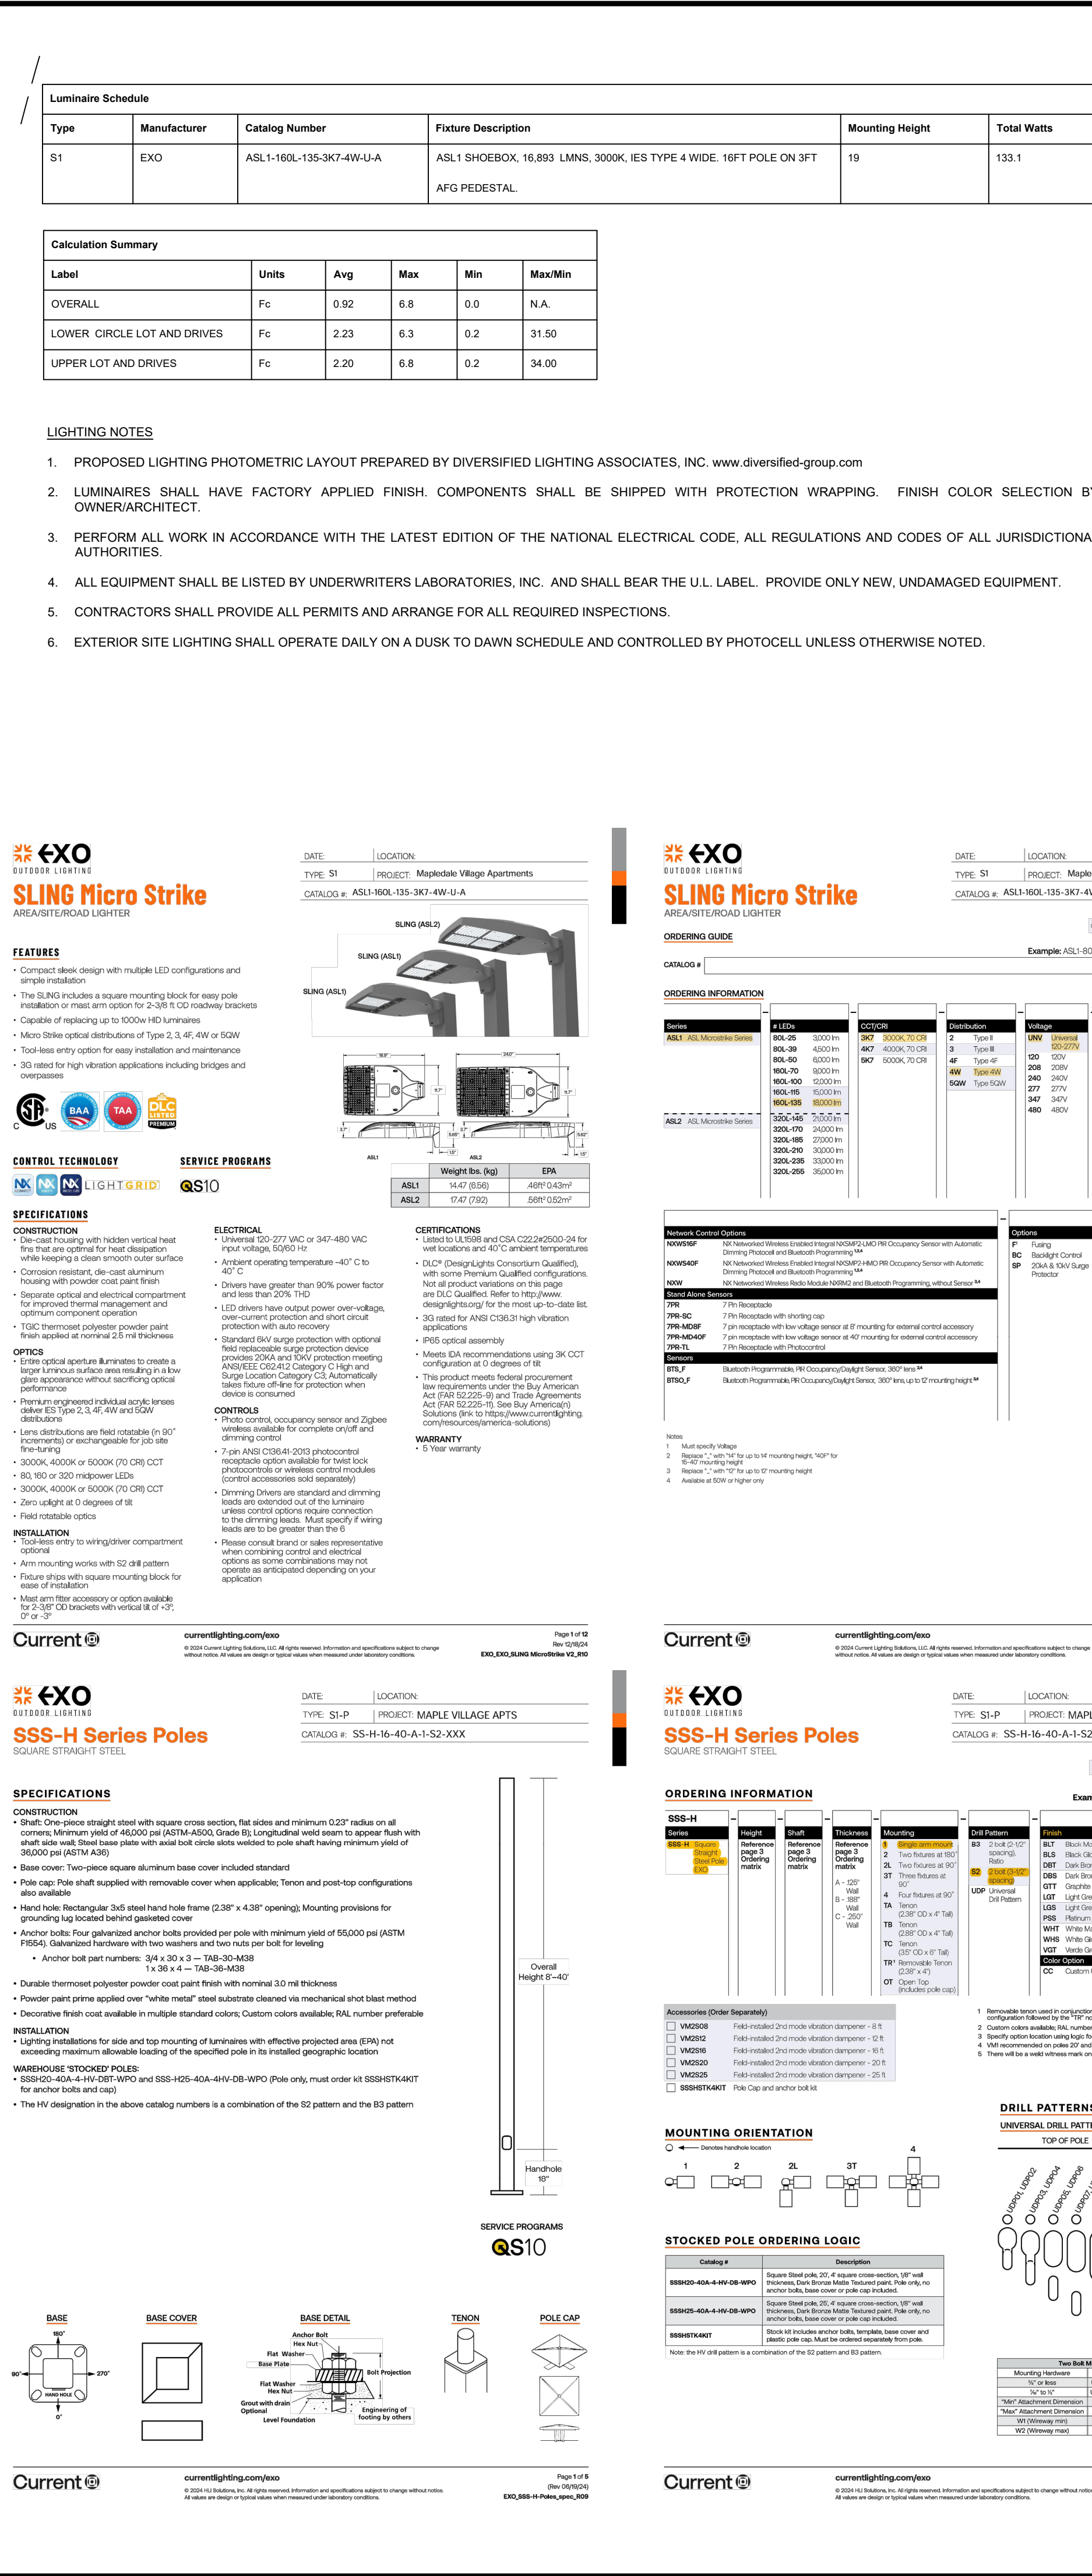

Calculation Summary					
Label	Units	Avg	Max	Min	Max/Min
OVERALL	Fc	0.92	6.8	0.0	N.A.
LOWER CIRCLE LOT AND DRIVES	Fc	2.23	6.3	0.2	31.50
UPPER LOT AND DRIVES	Fc	2.20	6.8	0.2	34.00

LIGHTING NOTES

1. PROPOSED LIGHTING PHOTOMETRIC LAYOUT PREPARED BY DIVERSIFIED LIGHTING ASSOCIATES, INC. www.diversified-group.com
2. LUMINAIRES SHALL HAVE FACTORY APPLIED FINISH. COMPONENTS SHALL BE SHIPPED WITH PROTECTION WRAPPING. FINISH COLOR SELECTION BY OWNER/ARCHITECT.
3. PERFORM ALL WORK IN ACCORDANCE WITH THE LATEST EDITION OF THE NATIONAL ELECTRICAL CODE, ALL REGULATIONS AND CODES OF ALL JURISDICTIONAL AUTHORITIES.
4. ALL EQUIPMENT SHALL BE LISTED BY UNDERWRITERS LABORATORIES, INC. AND SHALL BEAR THE U.L. LABEL. PROVIDE ONLY NEW, UNDAMAGED EQUIPMENT.
5. CONTRACTORS SHALL PROVIDE ALL PERMITS AND ARRANGE FOR ALL REQUIRED INSPECTIONS.
6. EXTERIOR SITE LIGHTING SHALL OPERATE DAILY ON A DUSK TO DAWN SCHEDULE AND CONTROLLED BY PHOTOCELL, UNLESS OTHERWISE NOTED.

SSS-H Series Poles

SQUARE STRAIGHT STEEL

DATE:	LOCATION:
TITLE: SLP	PROJECT: MAPLE VILLAGE APPTS
CATALOG#:	SS-H 16-40-A-1-S2-XXX

SPECIFICATIONS

CONSTRUCTION

- Shaft: One-piece straight steel with square cross section, flat sides and minimum .023" radius on all corners. Minimum yield of 60,000 psi (ASTM A400, Grade B). Longitudinal weld seams to appear flush with shaft side metal. Shaft base ends with vinyl bolt circle inside shaft welded to plate showing minimum yield of 36,000 psi (ASTM A36).
- Base cover: Two-piece square aluminum base cover, included standard.
- Pole cap: Pole cap supplied with removable base when applicable. Tenor and post-top configurations also available.
- Hand hole: Rectangular 3x5 steel hand hole frame (2.38" x 4.38" openings). Mounting provisions for mounting lug bolt located behind gasketed cover.
- Anchor bolts: Four galvanized anchor bolts provided per shaft with minimum yield of 65,000 psi (ASTM F1554). Galvanized hardware with two washers and two nuts per bolt for leveling.
 - Anchor bolt part numbers: 3/4" x 30 x 3 = TAB-20-A308
1/2" x 30 x 4 = TAB-20-A308
- Durable thermoplastic powder-coat paint standard with normal 10 mil thickness.
- Decorative finish applied over "white metal" steel substrate obtained via mechanical and blast media.
- Positive finish coat available in many different colors. Custom colors available; RAL number preferable.

INSTALLATION

- Lighting installations for side and top mounting of luminaires with reflective geographic area (SRA) not exceeding maximum allowable loading of the specified pole in its intended project location.

WAREHOUSE STOCKED POLES

- SSS-H10-40-A-1-V-02F-WFO and SSS-H25-40-A-1H-04F-WFO (pole only, must order kit SSS-HSTKIT47 for anchor bolts and cap)

- The "H" designation in the above catalog numbers is a combination of the S2 pattern and the S3 pattern.

SERVICE PROGRAMS

QS10

Current

currentlighting.com/seo

© 2014 Current Lighting, Inc. All rights reserved. Information and specifications subject to change without notice.

Page 1 of 6
(Rev. 01/14)

[illegible]

Pennoni

PENNONI ASSOCIATES INC.
Christiana Executive Campus
121 Continental Drive, Suite 207
Newark, DE 19713-4310
T 302.655.4451 **F** 302.654.2895

ALL DIMENSIONS MUST BE VERIFIED BY CONTRACTOR
AND OWNER MUST BE NOTIFIED OF ANY
DISCREPANCIES BEFORE PROCEEDING WITH WORK

VILLAGES OF MAPLE DALE - PHASE 3

DOVER, DE 19904 | TAX MAP #: 2-05-06700-04-0100-00

LIGHTING PLAN

U & I MAPLE DALE LLC

1200 SOUTH BAY ROAD

DOVER, DE 19901

[illegible]

ALL DOCUMENTS PREPARED BY PENNONI ASSOCIATES ARE INSTRUMENTS OF SERVICE IN RESPECT OF THE PROJECT. THEY ARE NOT INTENDED OR REPRESENTED TO BE SUITABLE FOR REUSE BY OWNER OR OTHERS ON THE EXTENSIONS OF THE PROJECT OR ON ANY OTHER PROJECT. ANY REUSE WITHOUT WRITTEN VERIFICATION OR ADAPTATION BY PENNONI ASSOCIATES FOR THE SPECIFIC PURPOSE INTENDED WILL BE AT OWNERS' SOLE RISK AND WITHOUT LIABILITY OR LEGAL EXPOSURE TO PENNONI ASSOCIATES; AND OWNER SHALL INDEMNIFY AND HOLD HARMLESS PENNONI ASSOCIATES FROM ALL CLAIMS, DAMAGES, LOSSES AND EXPENSES ARISING OUT OF OR RESULTING THEREFROM.

PROJECT UANDI24002

DATE 2025-01-03

DRAWN BY GBR

APPROVED BY _____ GBR

CS2201

SHEET 8 OF 8