


Panasonic
WhisperCeiling 290 CFM 2 Sones Ceiling Mounted Energy Star Rated Bath Fan with 6" Duct Diameter for Light Commercial Applications
Model: FV-30VQ3 | Item: bci305793
★★★★☆ (23)

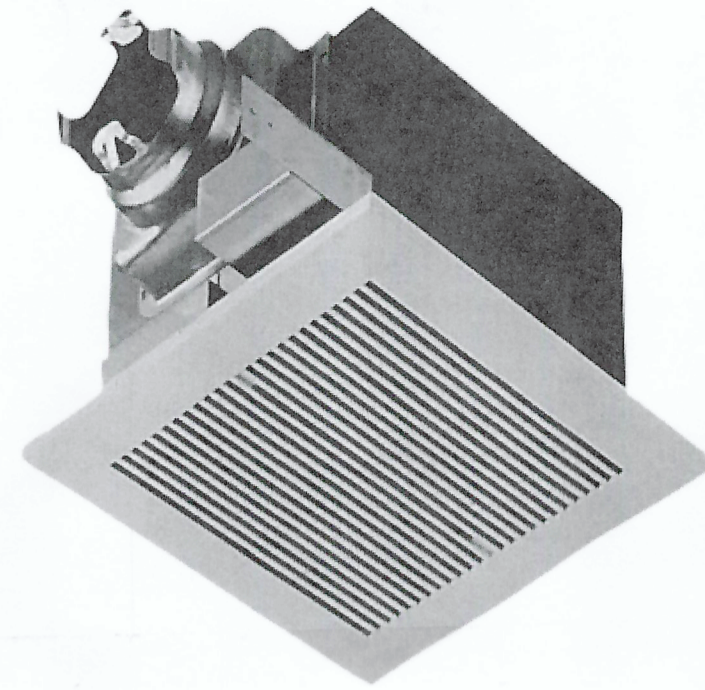


PROJECT INFORMATION

2024 O.B.C. CODE


USE GROUP :	B BUSINESS
CONSTRUCTION TYPE:	5 - B
REQUIRED EXITS	REQUIRED = 2 EXIT - MIN. 36" WIDTH PROVIDED = 2 EXITS - MIN. 36" WIDTH
FLOOR AREA :	ENCLOSED FLOOR PLAN = 800 SQ. FT.
OCCUPANT LOAD :	1 / 100 SQ.FT. = 8 PERSONS

Item Depth 14.2 inches

Item dimensions L x W x H
53.3 x 14.2 x 42.5 inches

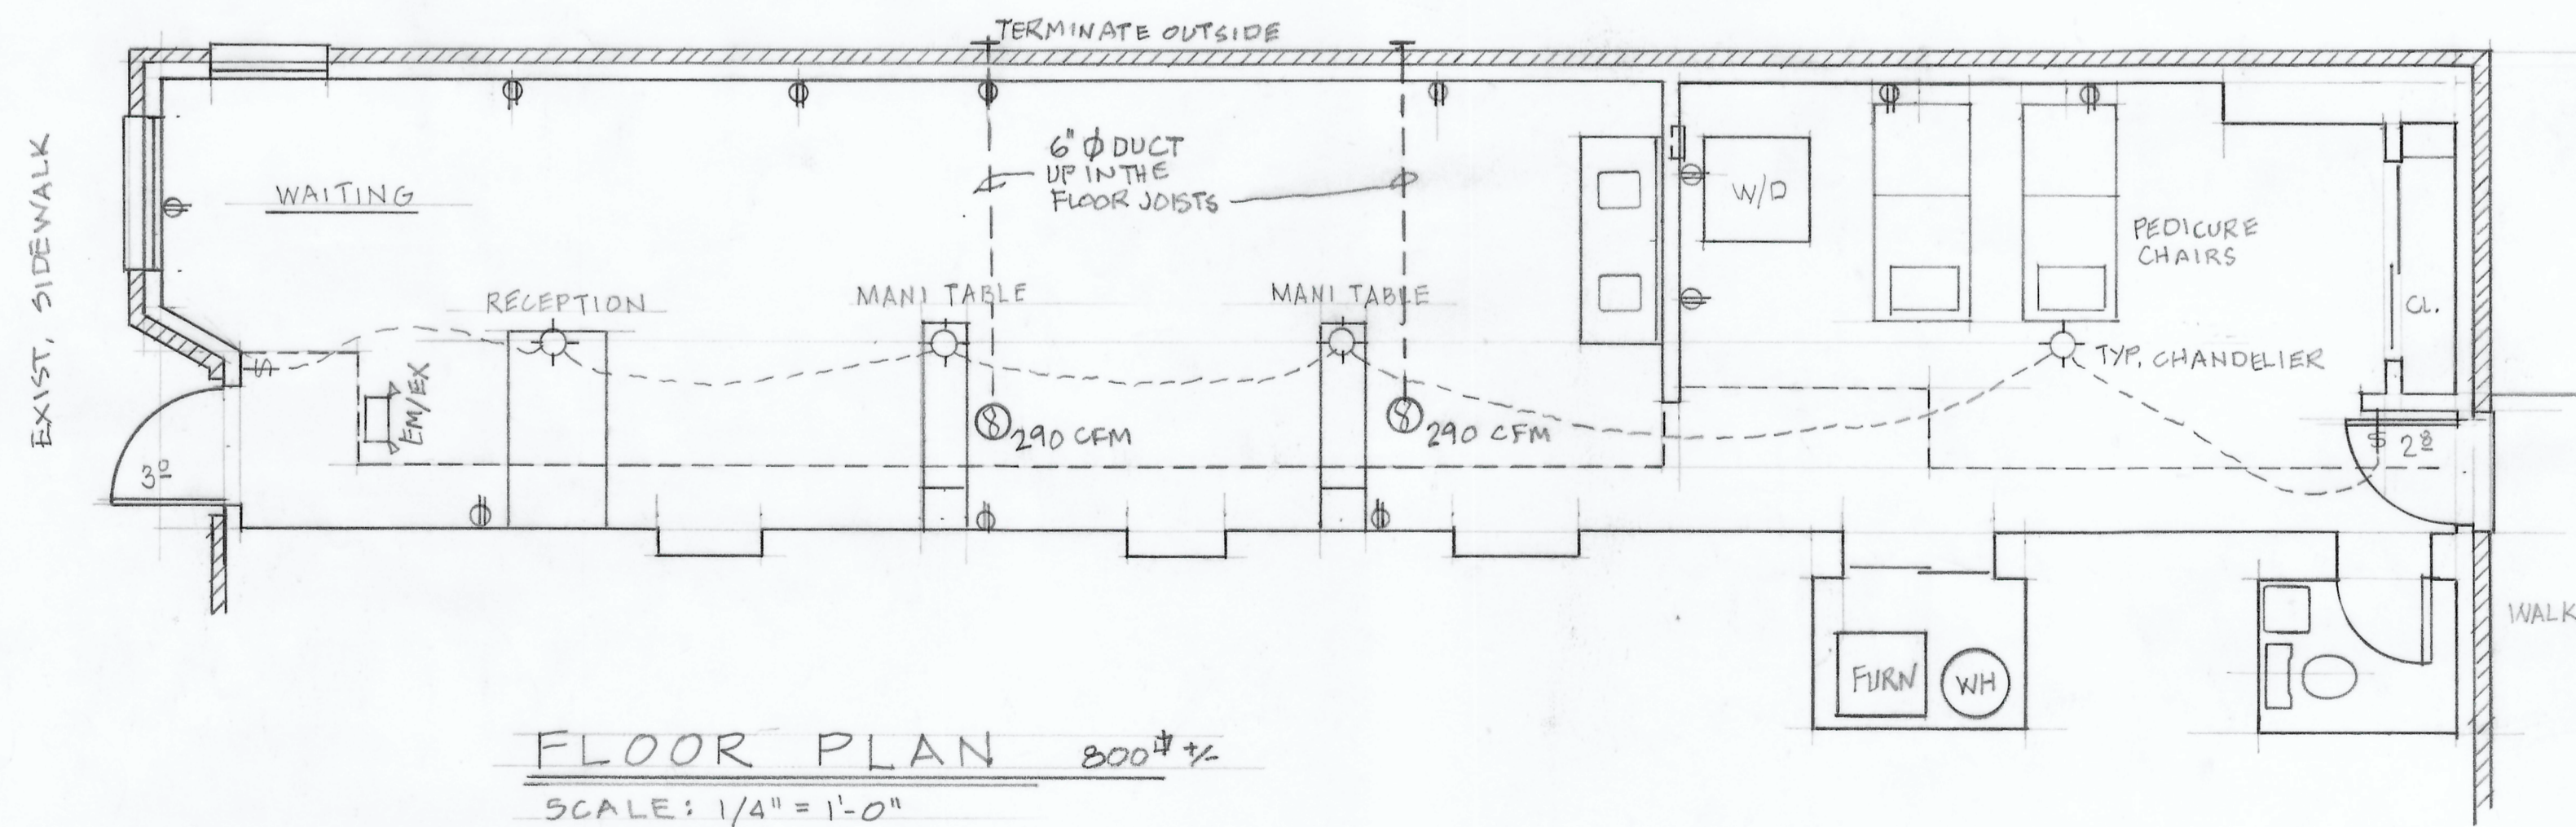

DENNIS R. BEATTY, License #10919
Expiration Date: 12/31/2025

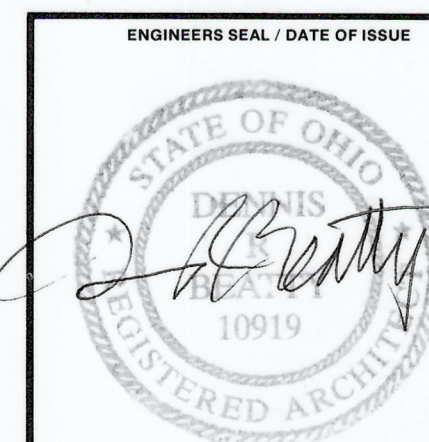

APPROVAL		NO.	DATE	REVISIONS	REV. BY
CLIENT					

CLIENT	ROD LITTERAL
TITLE	SERENITY NAIL ROOM 515 S. MAIN STREET FRANKLIN, OHIO 45005
DRAWN BY	D.R. BEATTY
DATE	9-10-24
CHECKED	DRB
DATE	9-10-24
SCALE	1/4" = 1'-0"
CUSTOMER DWG. NO.	A-1
REV.	