


NOTE:
 ALTHOUGH EVERY EFFORT HAS BEEN TAKEN TO PREPARE THESE DRAWINGS TO COMPLY WITH LOCAL BUILDING CODES, CONTINUOUS CODE CHANGES MAY REQUIRE ADDITIONAL DRAWINGS, ENGINEERING SERVICES, AND/OR CHANGES TO THESE DRAWINGS TO MEET CODE COMPLIANCE. POSSESSION OF THESE PLANS ACKNOWLEDGES THAT THE PURCHASER HAS BEEN INFORMED OF THIS INFORMATION AND ASSUMES THE RESPONSIBILITY TO PROVIDE ALL ADDITIONAL REQUIREMENTS OF LOCAL BUILDING OFFICIALS TO MEET COMPLIANCE.



This drawing is an instrument of service and is the property of GDH Architects, P.A. It shall never be reproduced in whole or in part without the express written permission of GDH Architects.

Seal:

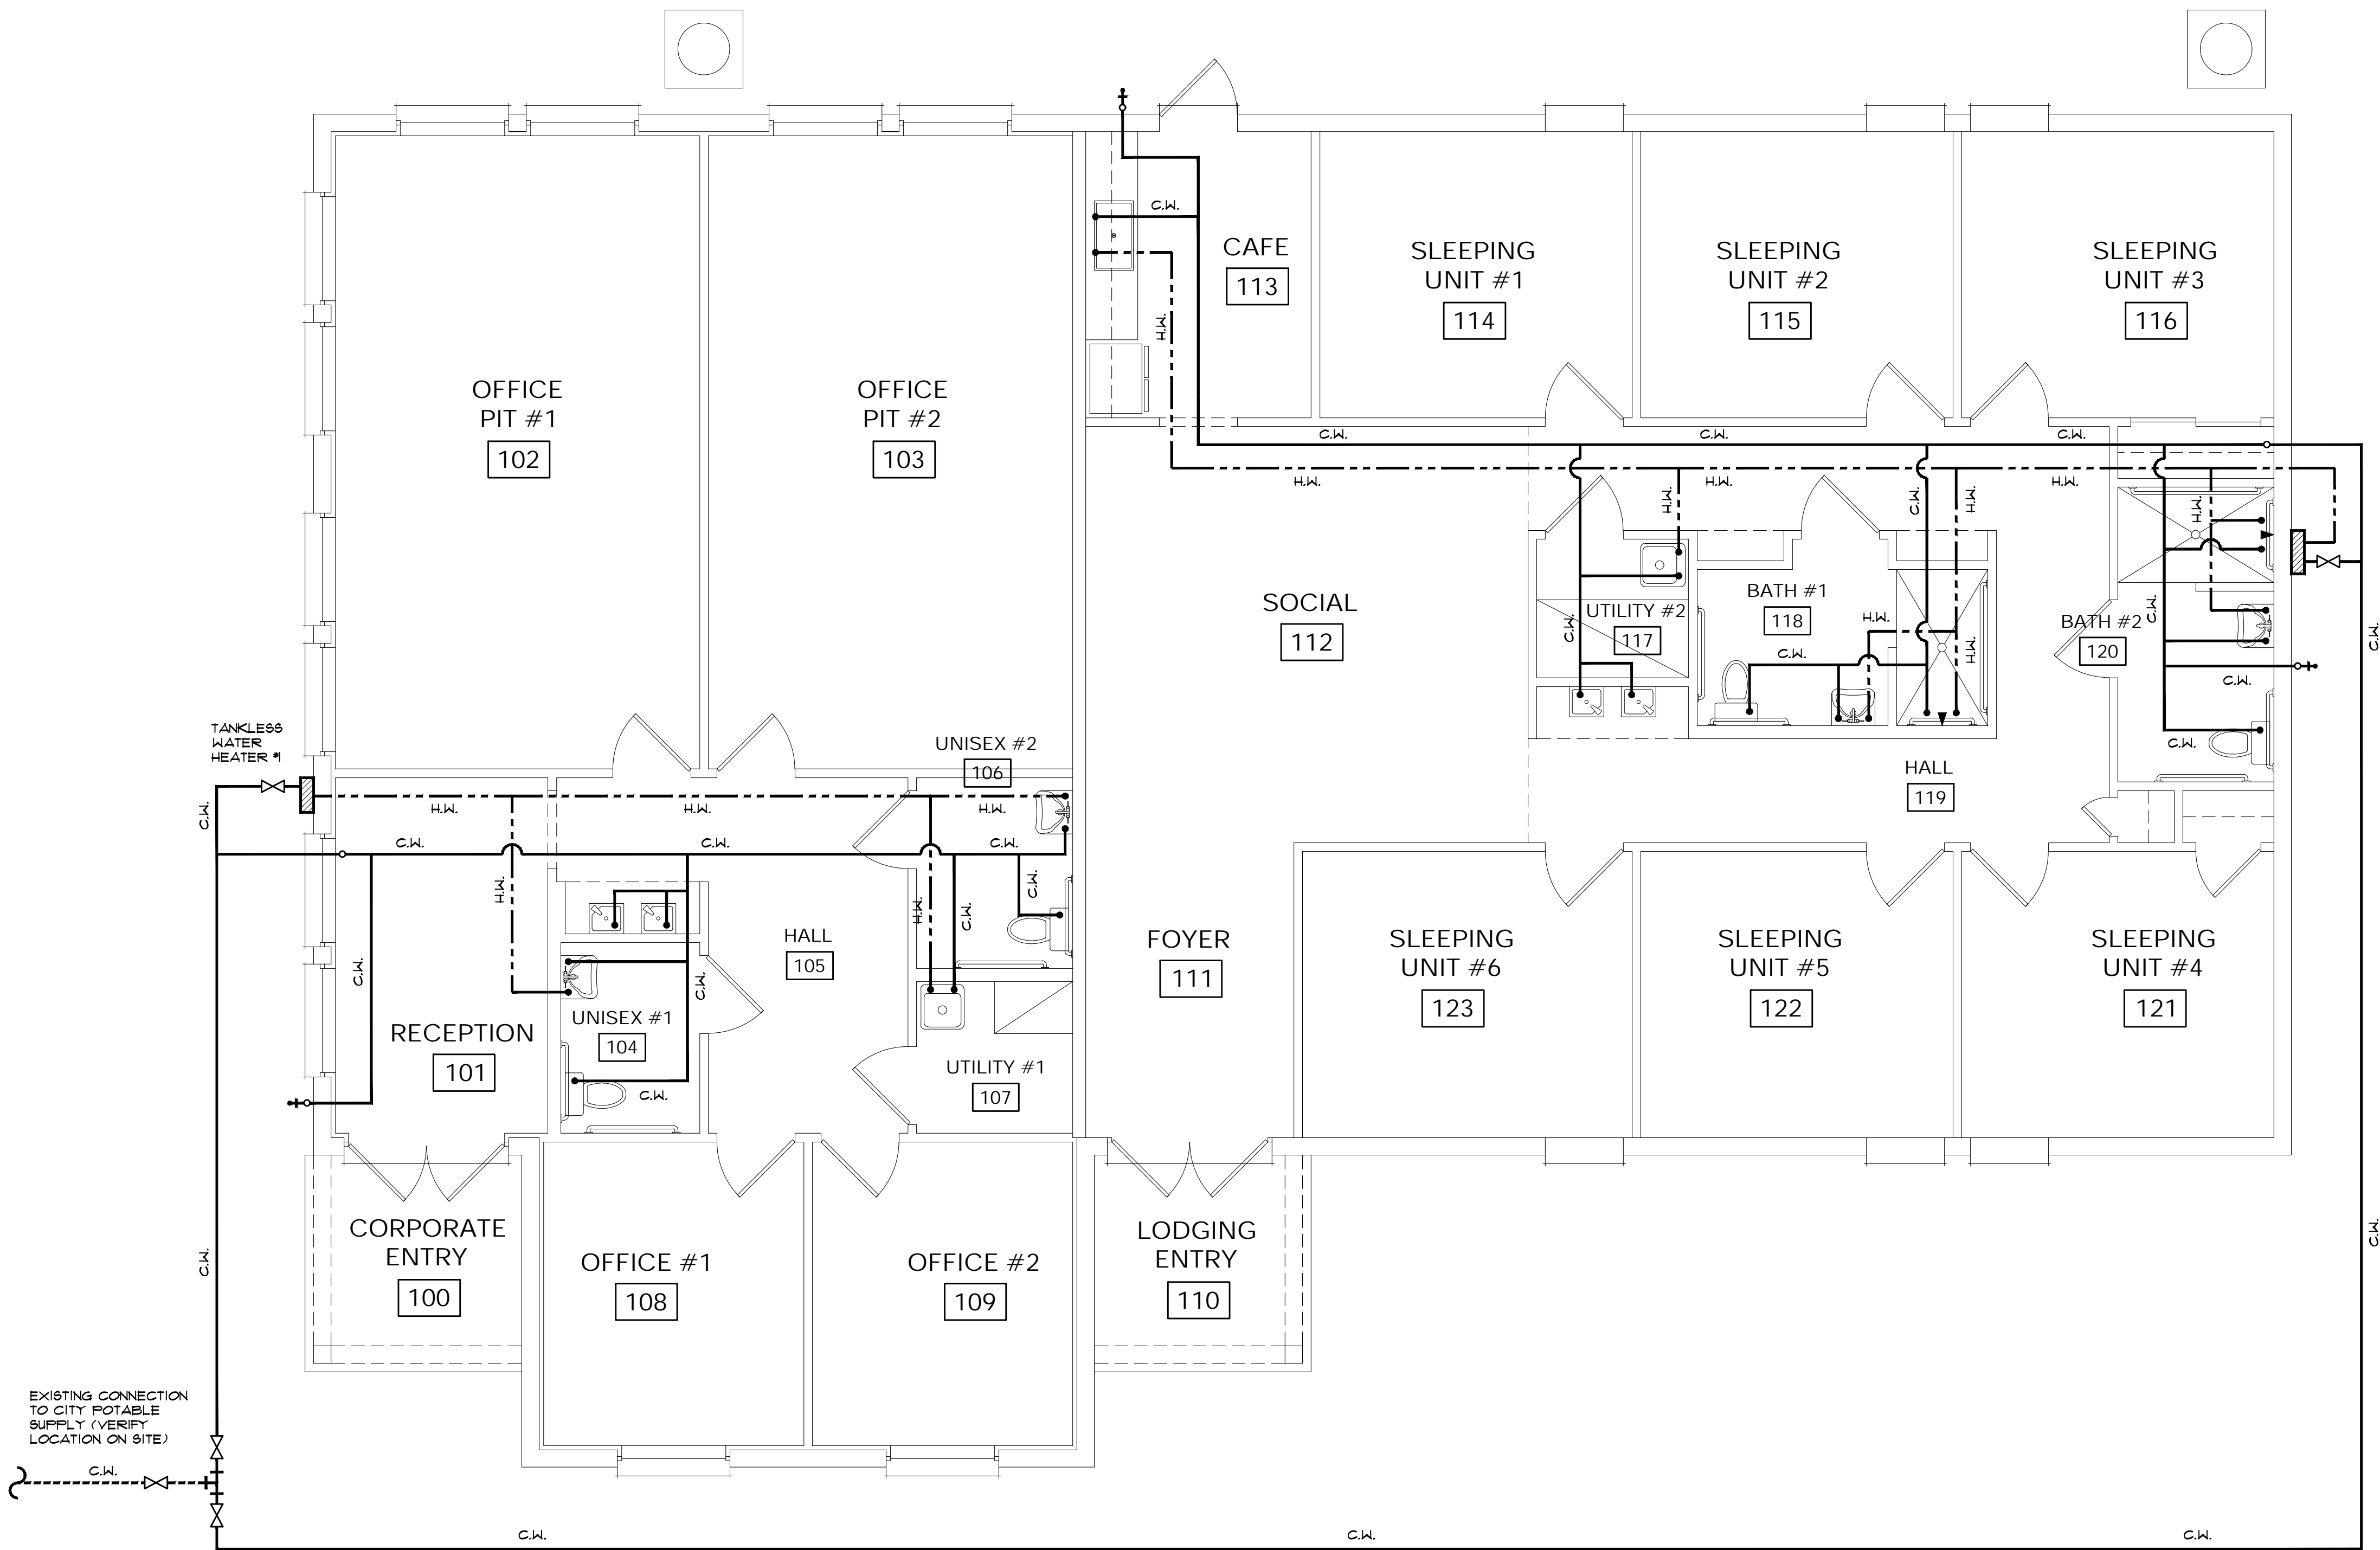

POTABLE (SUPPLY) PLUMBING LINE LEGEND

	NEW COLD-WATER SUPPLY LINE
	NEW HOT WATER SUPPLY LINE
	EXISTING POTABLE SUPPLY LINE
	SHUT-OFF VALVE

PROVIDE APPROVED WATER TEMPERATURE LIMITING DEVICE (ASSE 1070) AT RESTROOM LAVATORIES FOR THE DELIVERY OF TEMPERED WATER

1 PLUMBING PLAN POTABLE (SUPPLY)
 SCALE: 1/4" = 1'-0"

PLUMBING CONTRACTOR: _____
 ADDRESS: _____
 LICENSE #: _____
 TELEPHONE: _____

VINEYARD TRANSITIONAL CENTER
 518 NORTH PINE AVENUE
 GREEN COVE SPRINGS, FL 32043

Contract Stage:
 REVIEW SET

Revisions:

Project No: 23-1066 (23_0xx)
 Drawn By: JBF
 Checked By: GDH

PLUMBING PLAN POTABLE (SUPPLY)

Sheet No:
P1
 Last Plot Date: 9/1/2023
 CAD File: