


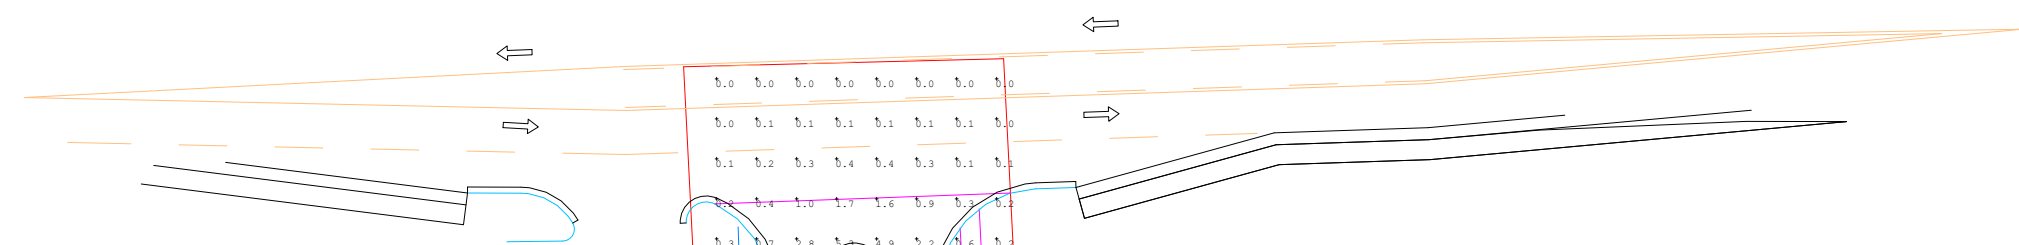

THE CROSSING



Luminaire Schedule				
Symbol	Qty	Label	Description	
⬢	3	C	GC6220-NL_G2LED115-T4-40K	
⊙	80	D	GC6220-NL_G2LED115-T3-40K	
⬢	23	E	GB03_GBR50_CA_G5BOL26-T5-30K	
⊙	3	D2	GC6220-NL_G2LED115-T3-40K	

Calculation Summary				
Label	Units	Avg	Max	Min
CalcPts_1	Fc	2.00	28.3	0.0

MH: 12'



PROP LANDSCAPE BERM

BLDG 1

BLDG 2

BLDG 3

 DRAWN BY: S.H.
DATE: 10/09/25
REV: 2

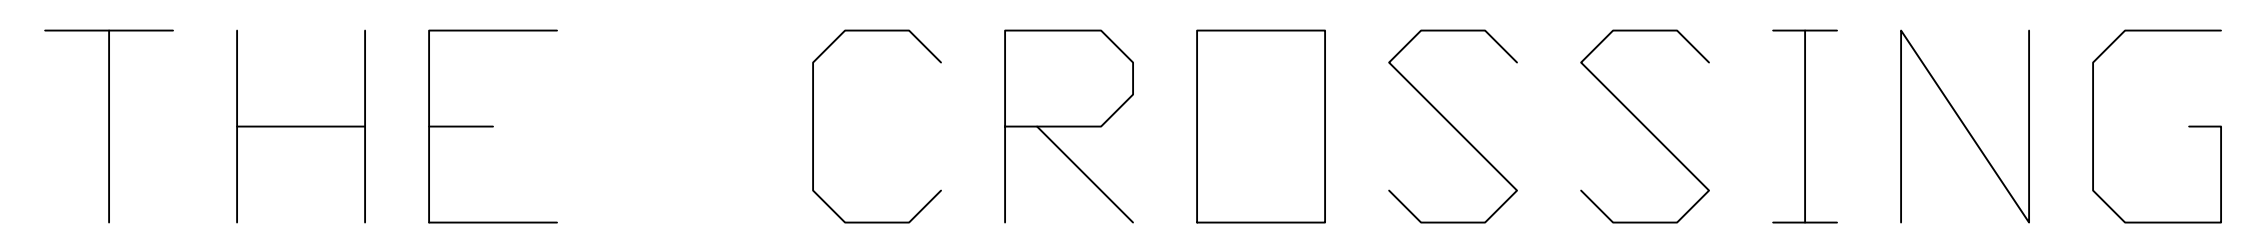

Calculation Summary				
Label	Units	Avg	Max	Min
CalcPts 1	Fc	2.00	28.3	0.0

DRAWN BY: S.H.
DATE: 10/09/25
REV: 2