

CITY OF HERMISTON, OREGON

REGIONAL WATER SYSTEM PHASE 2 PIPELINE IMPROVEMENTS 2024




CITY COUNCIL

DR. DAVID DROTZMANN, MAYOR
 ROY BARRON
 JACKIE C. MYERS
 MARIA DURON
 ROD S. HARDIN
 NANCY PETERSON
 DOUG PRIMMER
 DAVID MCCARTHY
 JACKIE LINTON

CITY OFFICIALS

BYRON SMITH, CITY MANAGER
 MARK MORGAN, ASSISTANT CITY MANAGER
 CLINT SPENCER, CITY PLANNER
 RON SIVEY, STREET SUPERINTENDENT
 ROY BICKNELL, WATER SUPERINTENDENT
 BILL SCHMITTLE, RECYCLED WATER SUPERINTENDENT

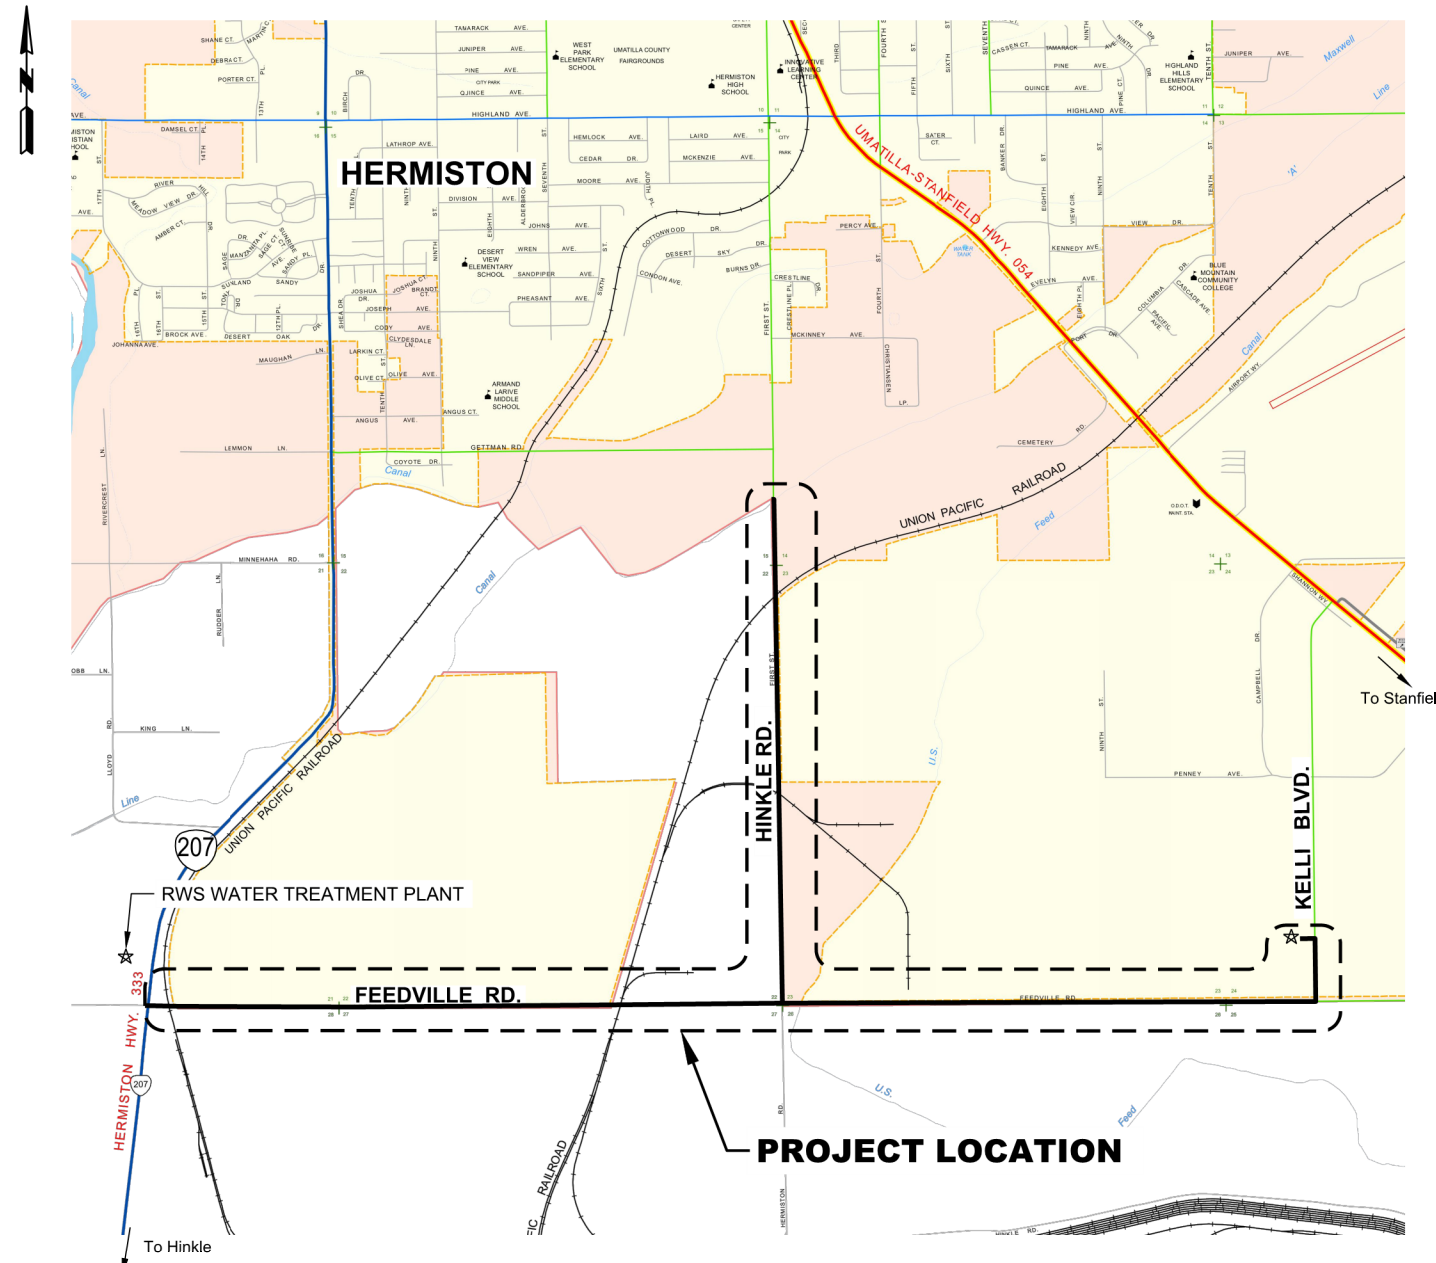

VICINITY MAP
N. T.S.

INDEX

---	COVER
G-001	LEGEND AND GENERAL NOTES
G-101	SHEET INDEX
U-101	PLAN AND PROFILE STA. A1+00 TO STA. A9+50
U-102	PLAN AND PROFILE STA. A9+50 TO STA. A19+50
U-103	PLAN AND PROFILE STA. A19+50 TO STA. A29+50
U-104	PLAN AND PROFILE STA. A29+50 TO STA. A39+50
U-105	PLAN AND PROFILE STA. A39+50 TO STA. A49+50
U-106	PLAN AND PROFILE STA. A49+50 TO STA. A59+50
U-107	PLAN AND PROFILE STA. A59+50 TO STA. A69+50
U-108	PLAN AND PROFILE STA. A69+50 TO STA. A80+00
U-109	PLAN AND PROFILE STA. A80+00 TO STA. A90+00
U-110	PLAN AND PROFILE STA. A90+00 TO STA. A100+00
U-111	PLAN AND PROFILE STA. A100+00 TO STA. A110+00
U-112	PLAN AND PROFILE STA. A110+00 TO STA. A120+00
U-113	PLAN AND PROFILE STA. A120+00 TO STA. A130+00
U-114	PLAN AND PROFILE STA. A130+00 TO STA. A140+00
U-115	PLAN AND PROFILE STA. A140+00 TO STA. A150+10
U-116	PLAN AND PROFILE STA. B1+00 TO STA. B10+50
U-117	PLAN AND PROFILE STA. B10+50 TO STA. B20+50
U-118	PLAN AND PROFILE STA. B20+50 TO STA. B30+50
U-119	PLAN AND PROFILE STA. B30+50 TO STA. B40+50
U-120	PLAN AND PROFILE STA. B40+50 TO STA. B50+50
U-121	PLAN AND PROFILE STA. B50+50 TO STA. B60+50
U-401	RAW WATER VAULT
U-501	TYPICAL DETAILS I
U-502	TYPICAL DETAILS II



Engineering Surveying Natural Resources Cultural Resources GIS
 1901 N. Fir Street - La Grande, OR 97850 Ph: (541) 963-8309 Fax: (541) 963-5456
 LA GRANDE, OR WALLA WALLA, WA REDMOND, OR HERMISTON, OR ENTERPRISE, OR
 COPYRIGHT 2023 BY ANDERSON PERRY & ASSOCIATES, INC.

X:\Clients\Hermiston_OR\1736-137_Req_Wtr_Sys_Ph2\CAD\1736-137-WS-G-000.dwg Layout_10/4/2023 2:04 PM Imurphy




10/04/2023

RENEWS 12-31-24

FINAL ELECTRONIC DOCUMENTS AVAILABLE UPON REQUEST




X:\Clients\Hermiston OR\736-137 Reg. Wtr. Sys. P12\CAD\736-137-WS-G-101.dwg, Layout, 10/04/2023 2:05 PM, lmurphy

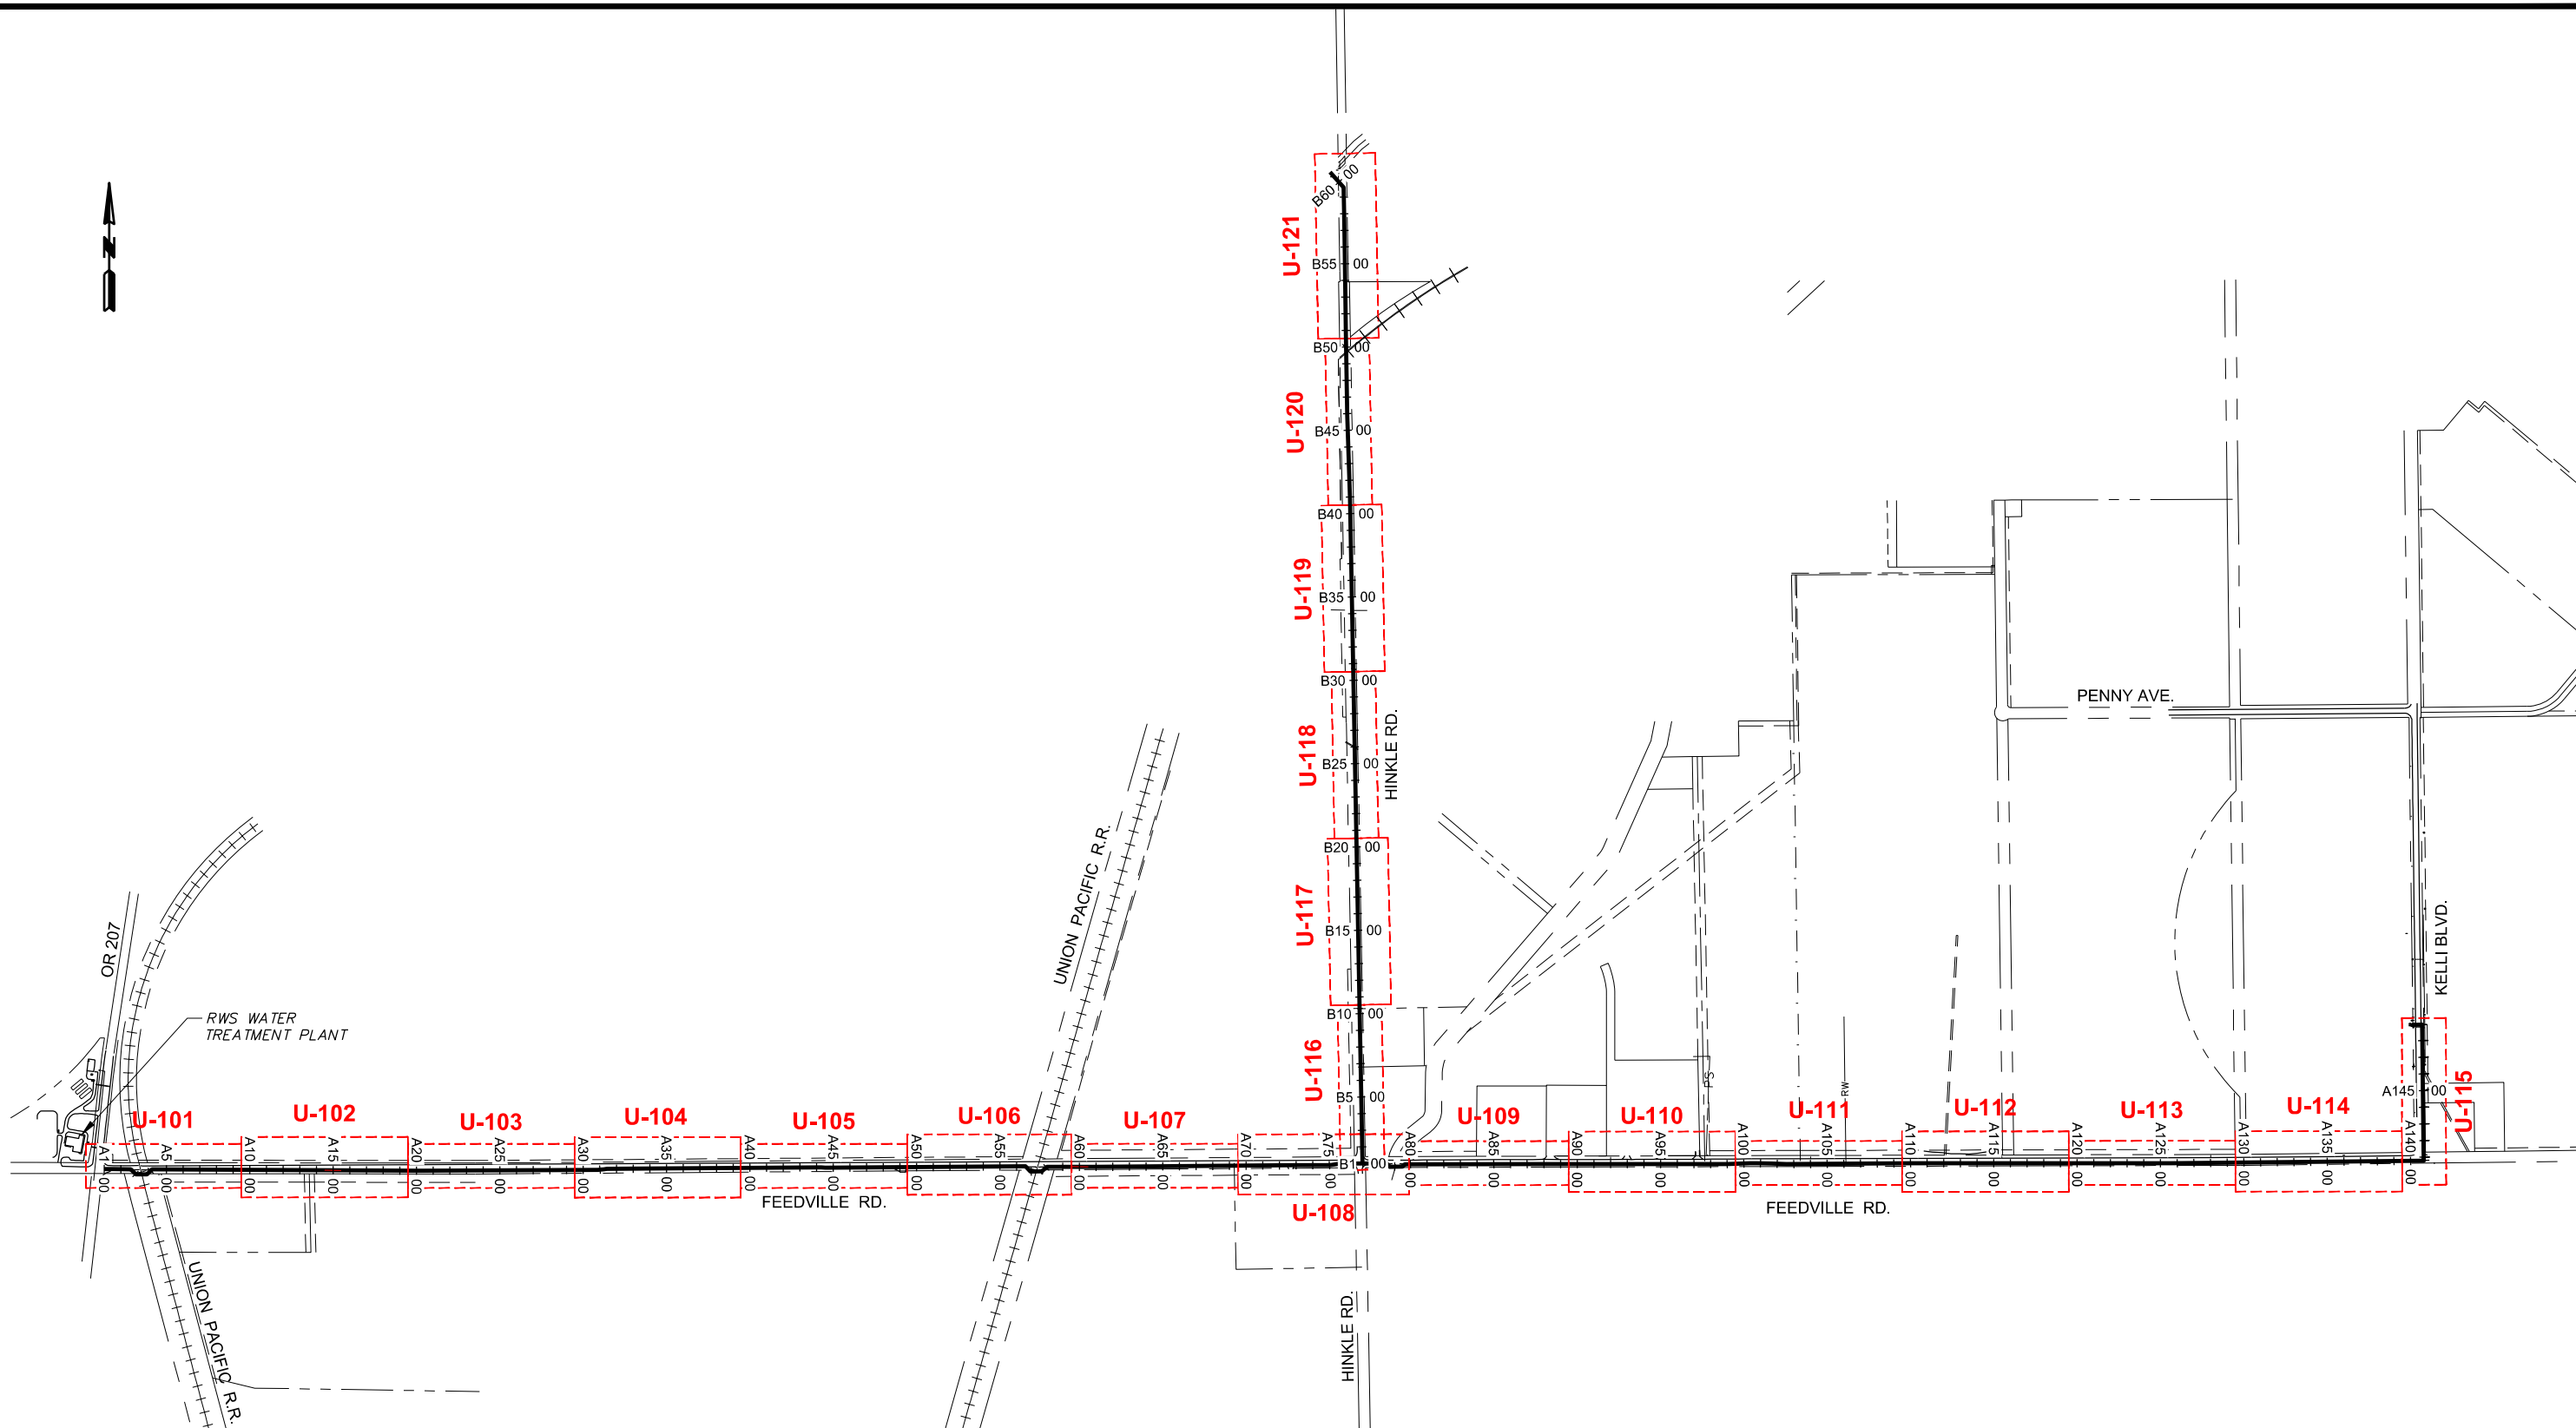

10/04/2023

REVISION	BY	DATE
DESIGNED BY	M. VAN TASSELL	
DRAWN BY	G. SAURBIER	
REVIEWED BY	J. MARLOW	

 

JOB NUMBER	736-137	DATE	2023
ACAD FILE:	736-137-WS-G-101.dwg		
COPYRIGHT 2023 BY ANDERSON PERRY & ASSOC., INC.			



HERMISTON, OREGON
 REGIONAL WATER SYSTEM PHASE 2
 PIPELINE IMPROVEMENTS

SHEET INDEX

SHEET
G-101
 2 OF 26