




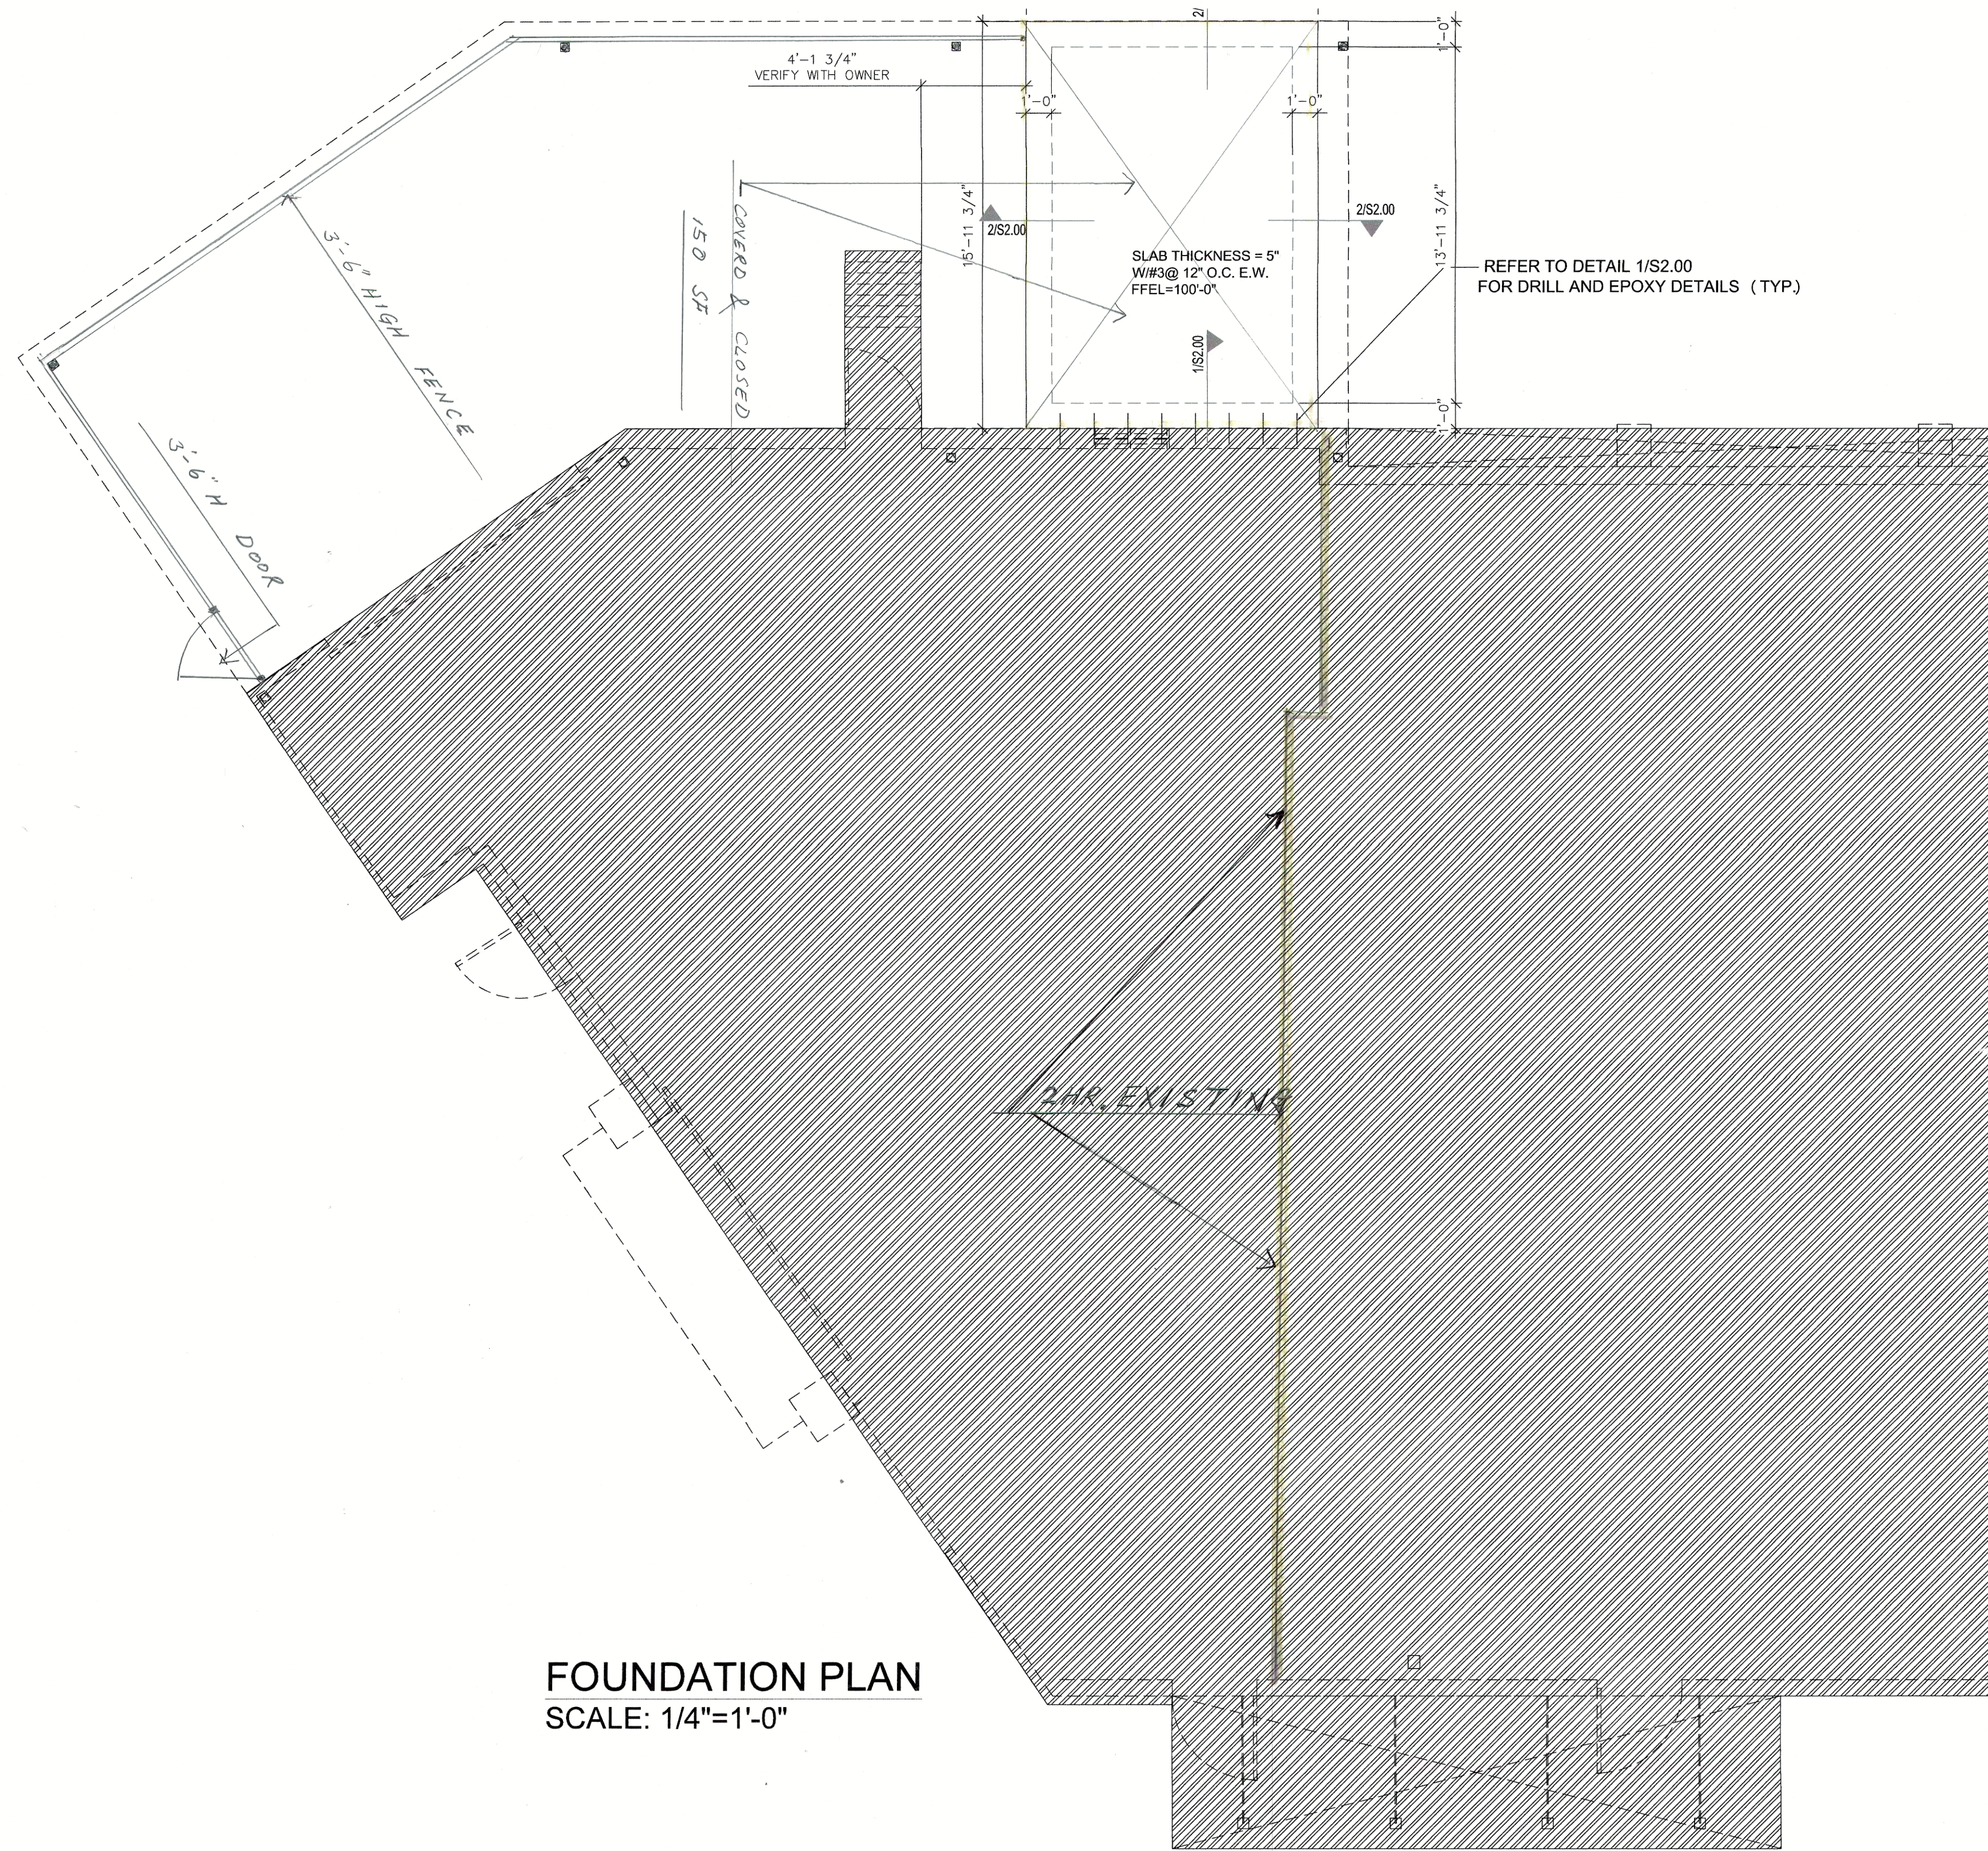


FOUNDATION PLAN
SCALE: 1/4"=1'-0"

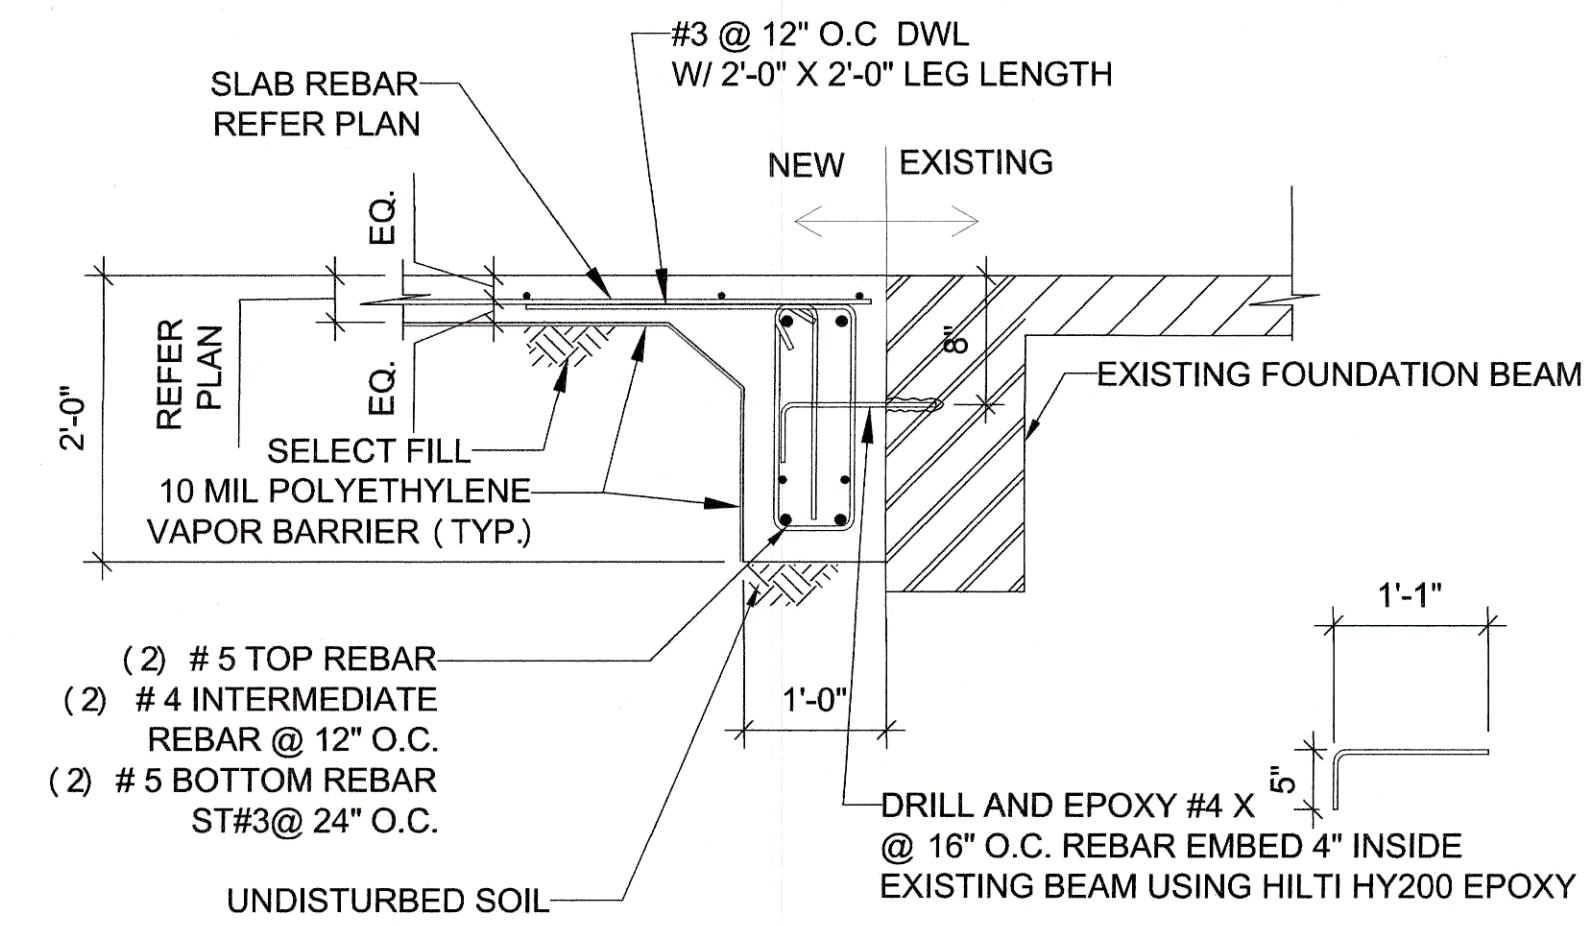

TYPICAL DETAIL
CONNECTING NEW
BEAM TO EXISTING BEAM

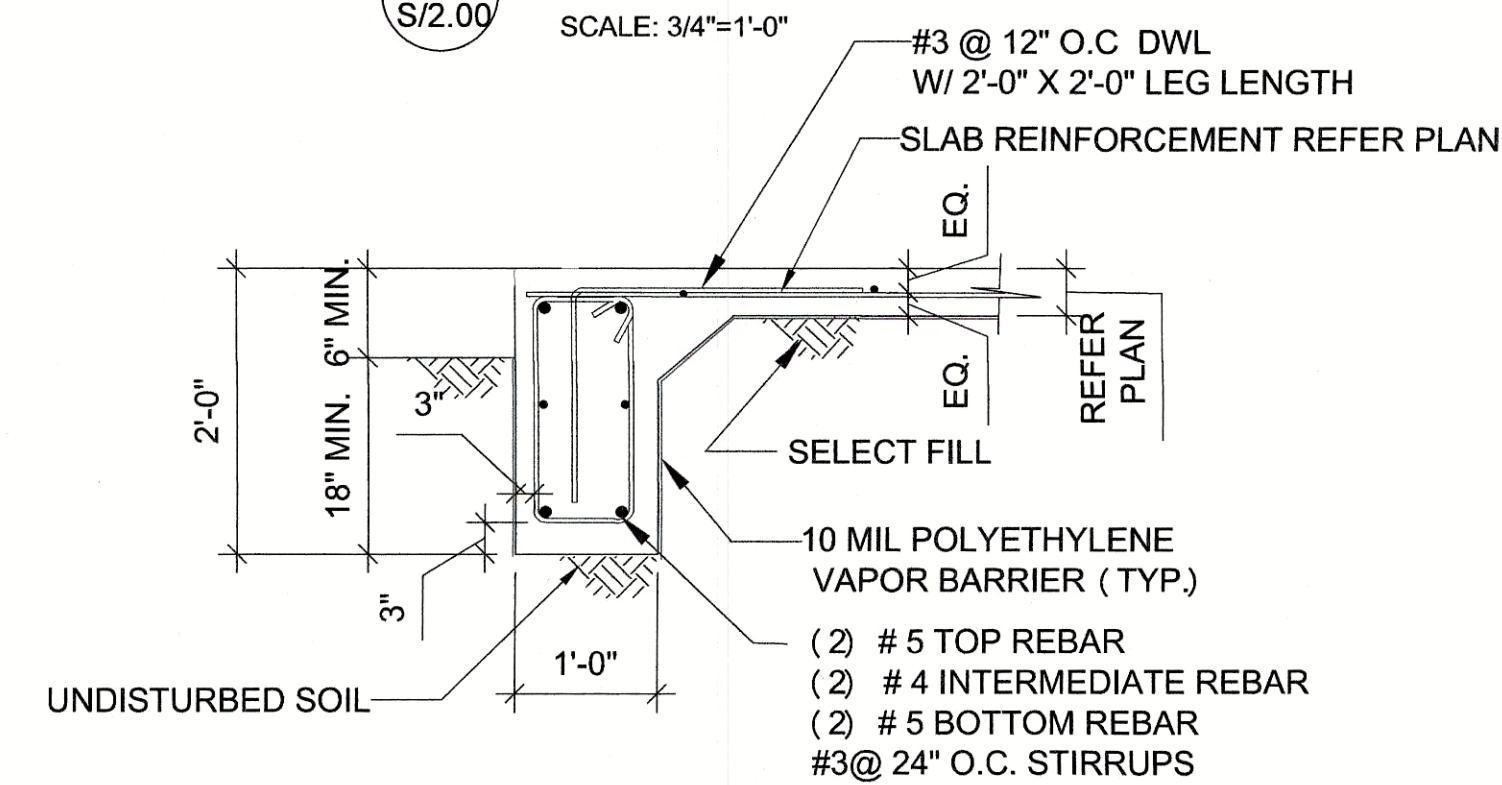

DETAIL

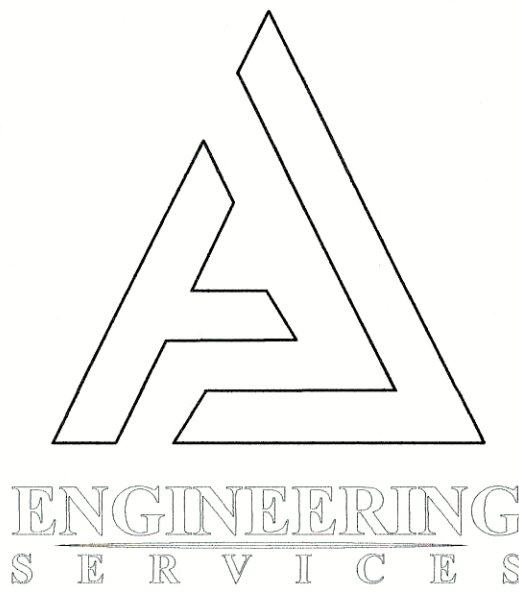

AJ
ENGINEERING
SERVICES LLC
FIRM# F-19793
OFFICE@AJENGINEERING.COM
WWW.AJENGINEERING.COM
PHONE: (469) 432-6093
8500 N STEMMONS FWY, SUITE 4006,
DALLAS TX 75247

COPYRIGHT 2025
AJ ENGINEERING SERVICES LLC

DRAWINGS ISSUED FOR:
REVIEW: 08/16/2025
PERMIT: 08/16/2025
PRICING:
CONSTRUCTION:
DRAWING BY: AJ
CHECKED BY: AJ

REVISIONS:

PROJECT:

COOLER
FOUNDATION
ADDITION

LOCATION:

801 W PALESTINE ST,
HUTCHINS, TX 75141
UNIT 107

SHEET TITLE:

PROPOSED
FOUNDATION PLAN

SHEET# **S2.01**

SHEET 3 OF 3

SCALE: AS NOTED

PRINT ON 24"X36" SHEET

PROJECT # AJ22136

