
 


Wintergreen Rd.

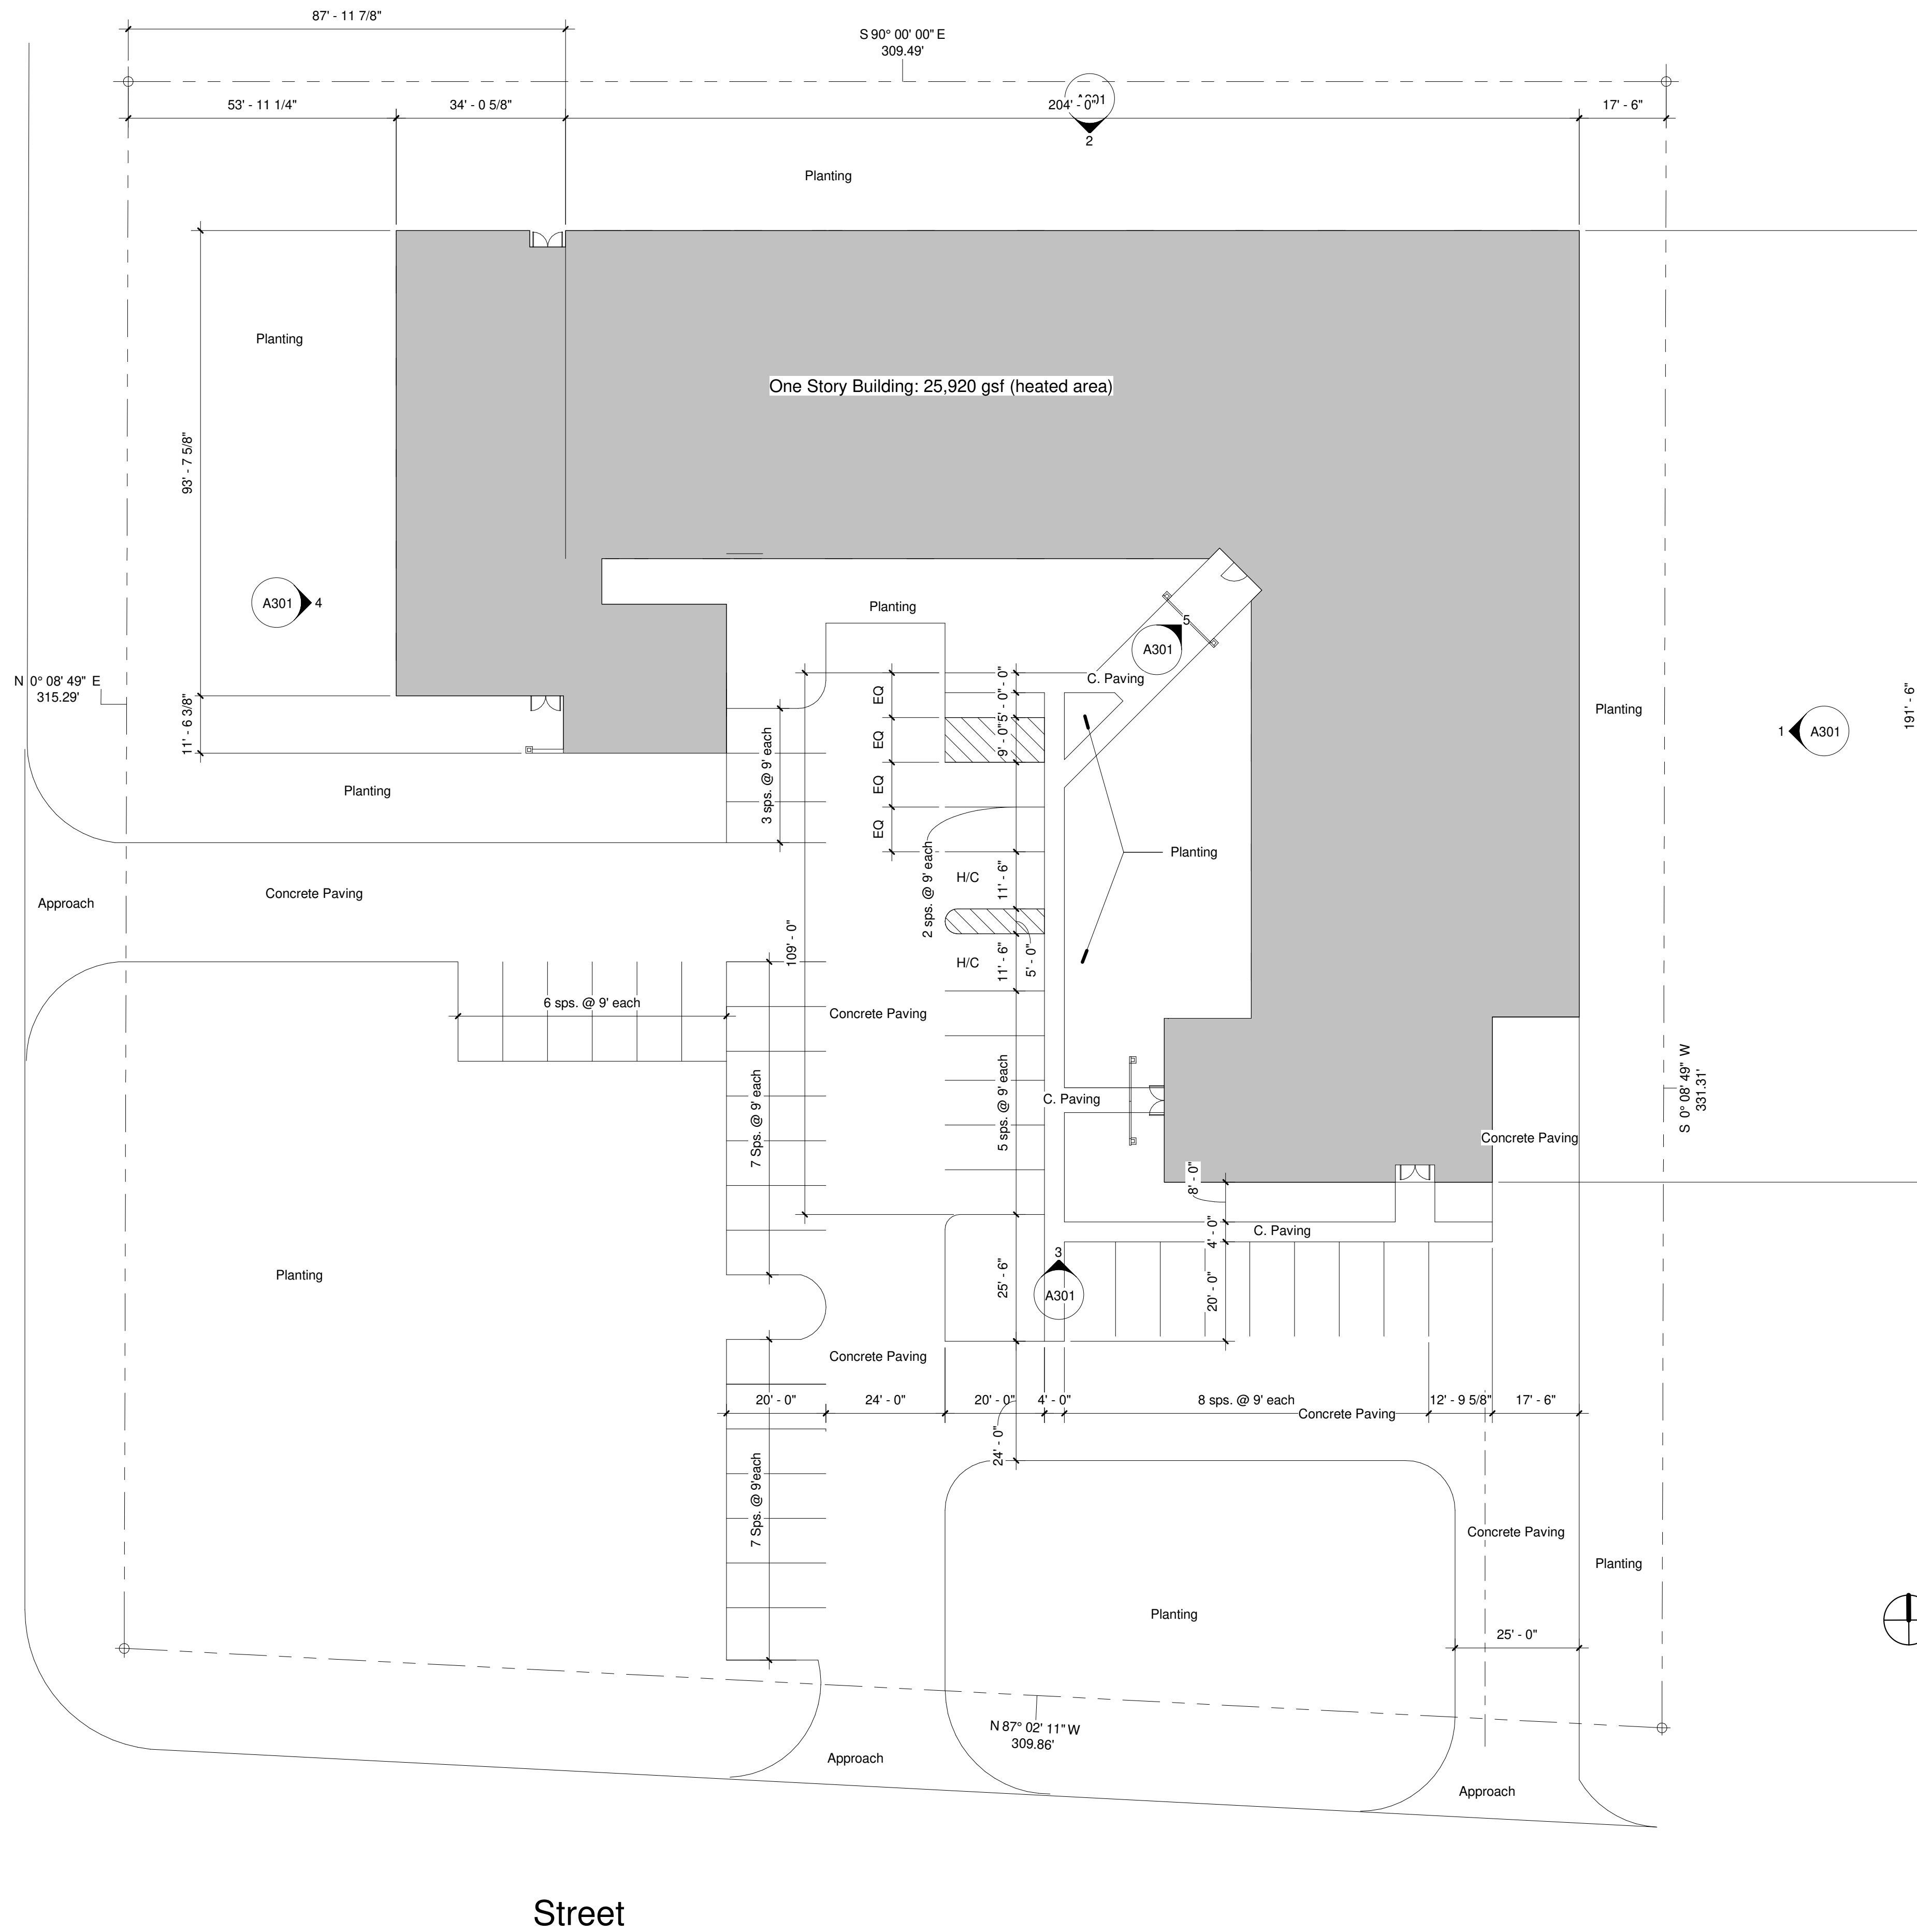

1 Site  
1" = 20'-0"



Reference  
Not For  
Construction

Copyright 2018  
Robert Durham Architecture

Residential Facility - Existing  
Volunteers of America - Texas  
800 W. Wintergreen Rd.  
Hutchins, TX 75141


No.	Description	Date

Site Plan

Project #	2017-301
Date	Issue Date
Drawn by	Author
Checked by	Checker

A101

Scale 1" = 20'-0"

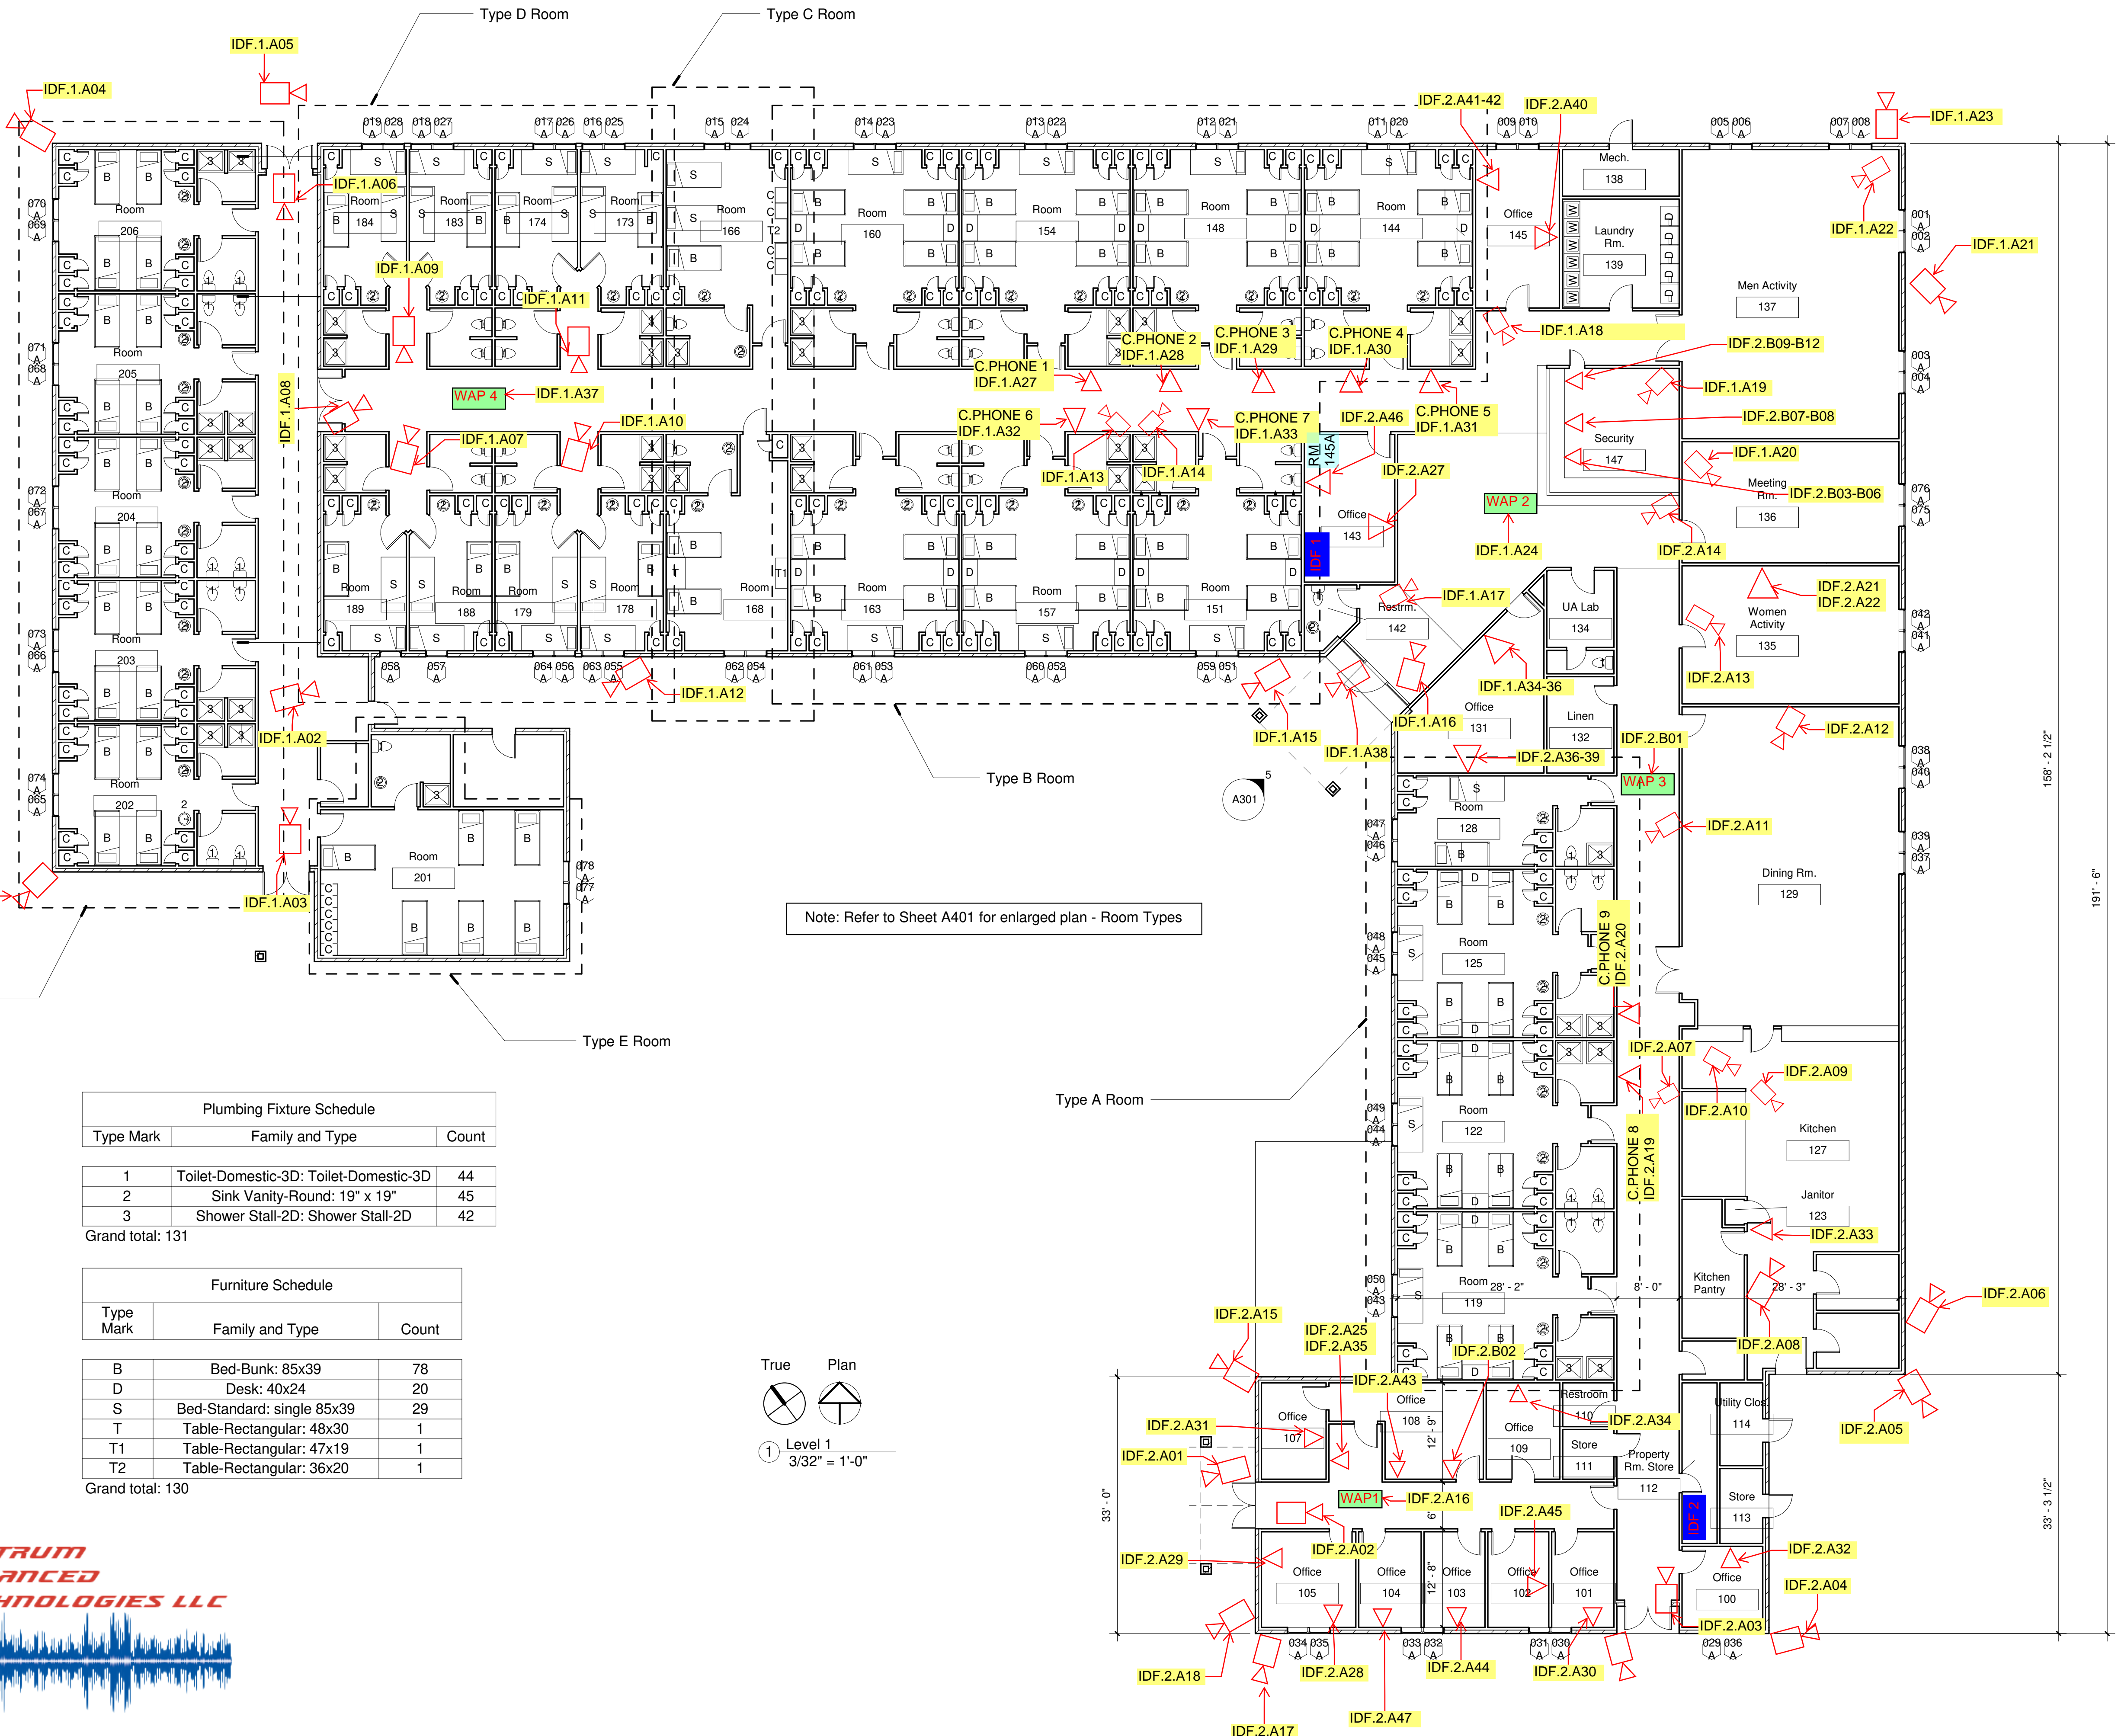


Note: Refer to Sheet A401 for enlarged plan - Room Types

**Plumbing Fixture Schedule**

Type Mark	Family and Type	Count
1	Toilet-Domestic-3D: Toilet-Domestic-3D	44
2	Sink Vanity-Round: 19" x 19"	45
3	Shower Stall-2D: Shower Stall-2D	42
Grand total: 131		

**Furniture Schedule**

Type Mark	Family and Type	Count
B	Bed-Bunk: 85x39	78
D	Desk: 40x24	20
S	Bed-Standard: single 85x39	29
T	Table-Rectangular: 48x30	1
T1	Table-Rectangular: 47x19	1
T2	Table-Rectangular: 36x20	1
Grand total: 130		

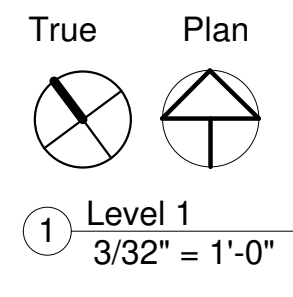

Reference Not For Construction



Copyright 2018 Robert Durham Architecture

Residential Facility - Existing  
Volunteers of America - Texas  
800 W. Wintergreen Rd.  
Hutchins, TX 75141

No.	Description	Date

Plan - Level 1

Project #	2017-301
Date	Issue Date
Drawn by	Author
Checked by	Checker

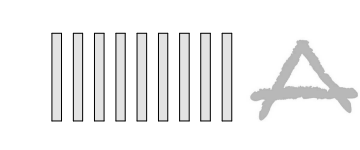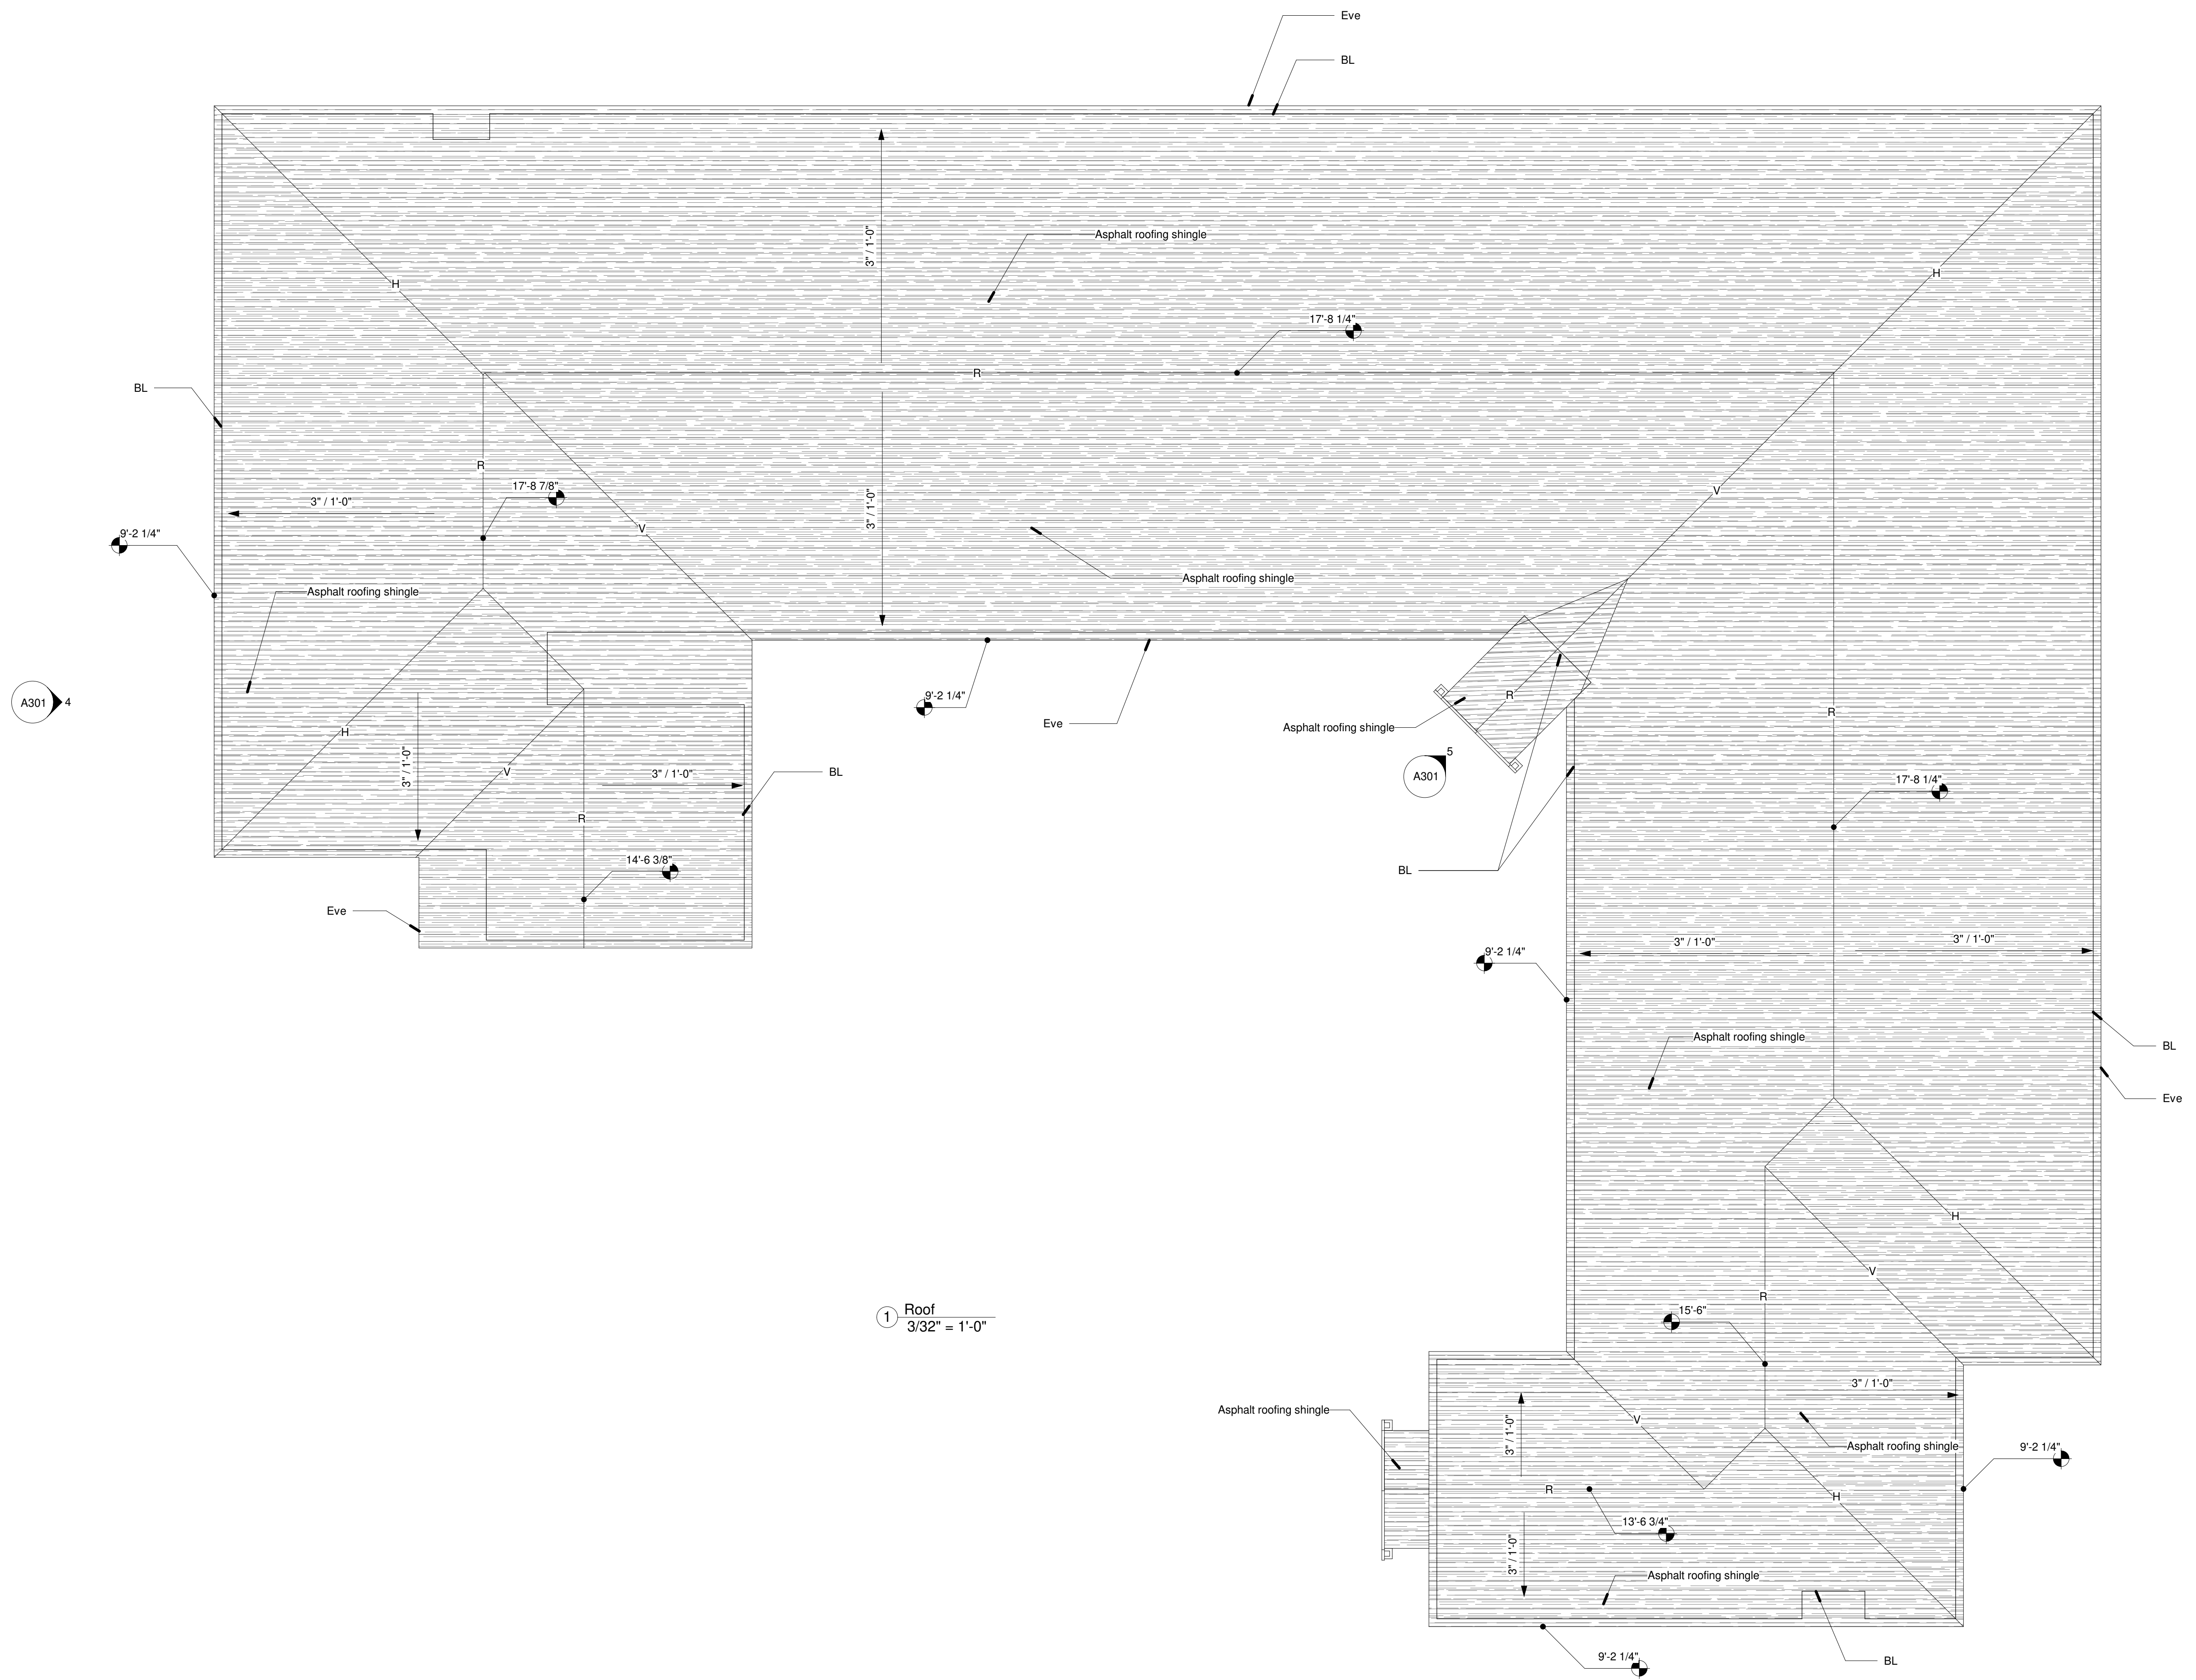

Reference  
Not For  
Construction

Copyright 2018  
Robert Durham Architecture

Residential Facility - Existing  
Volunteers of America - Texas  
800 W. Wintergreen Rd.  
Hutchins, TX 75141


No.	Description	Date

Plan - Roof


Project #	2017-301
Date	Issue Date
Drawn by	Author
Checked by	Checker

A202


Scale 3/32" = 1'-0"

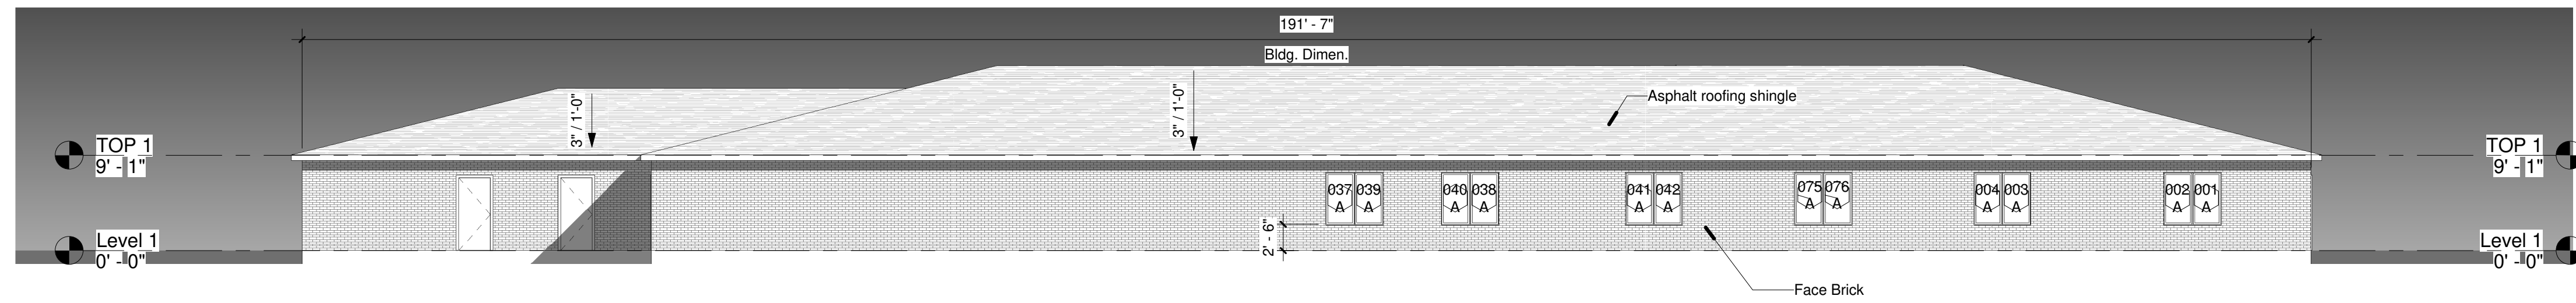


① East Elevation  
3/32" = 1'-0"

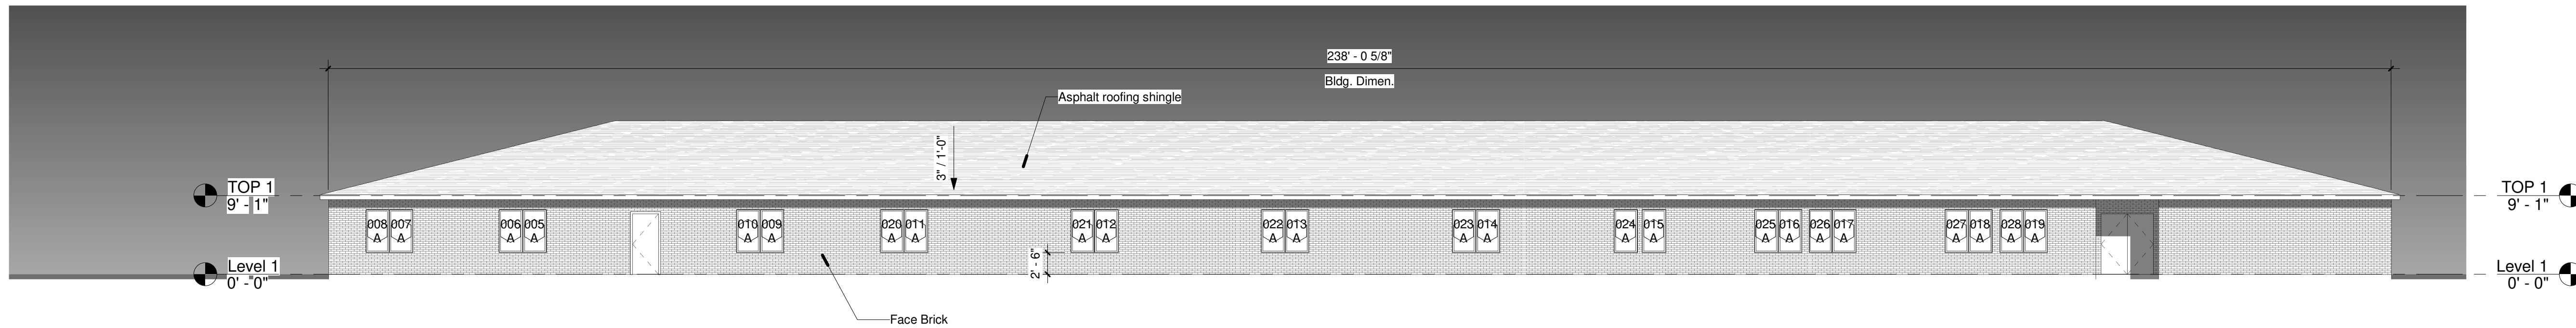


② North Elevation  
3/32" = 1'-0"

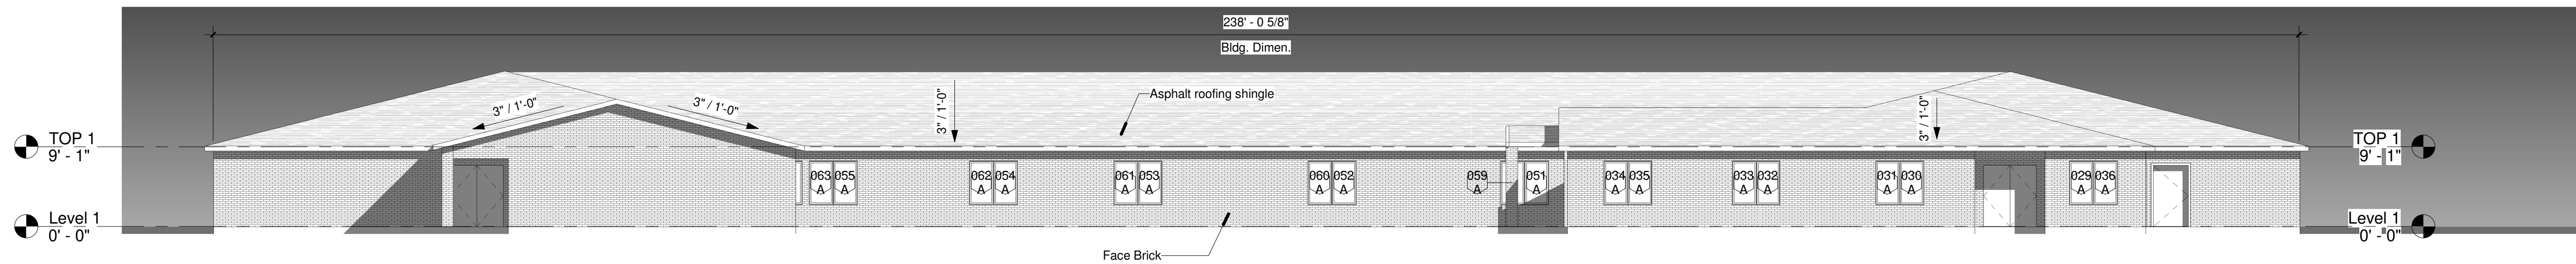


③ South Elevation  
3/32" = 1'-0"

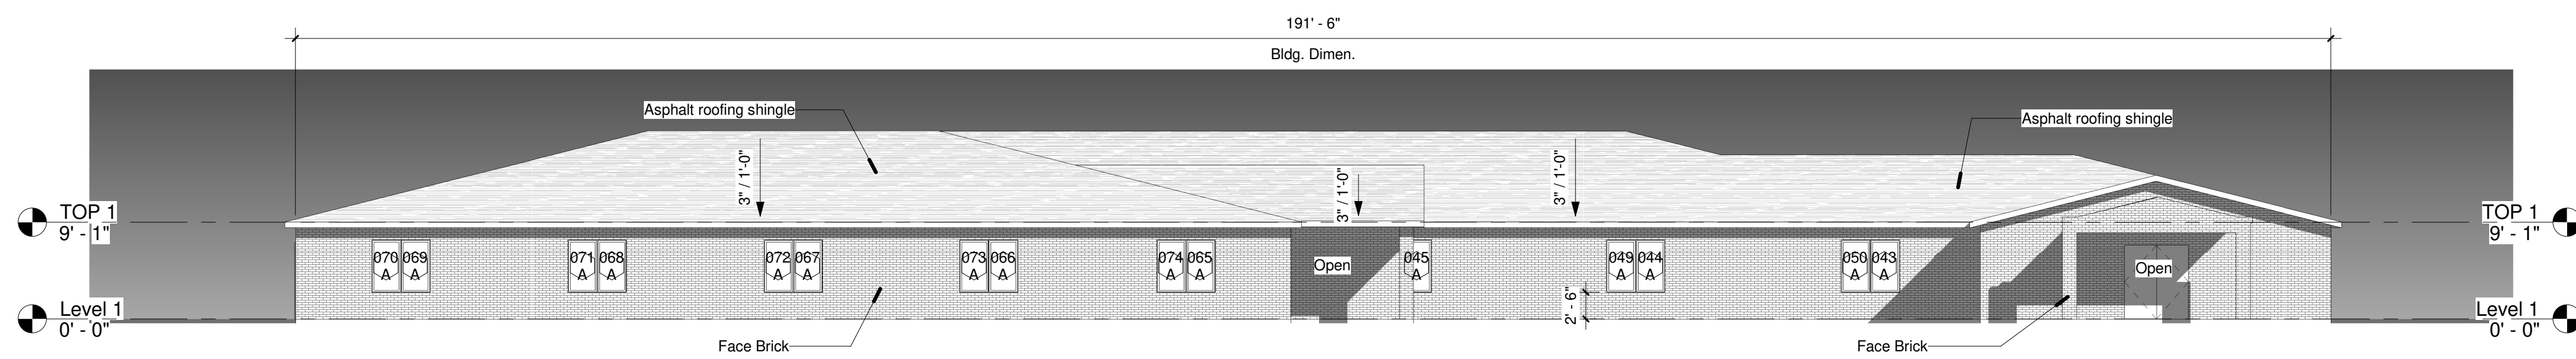

④ West Elevation  
3/32" = 1'-0"

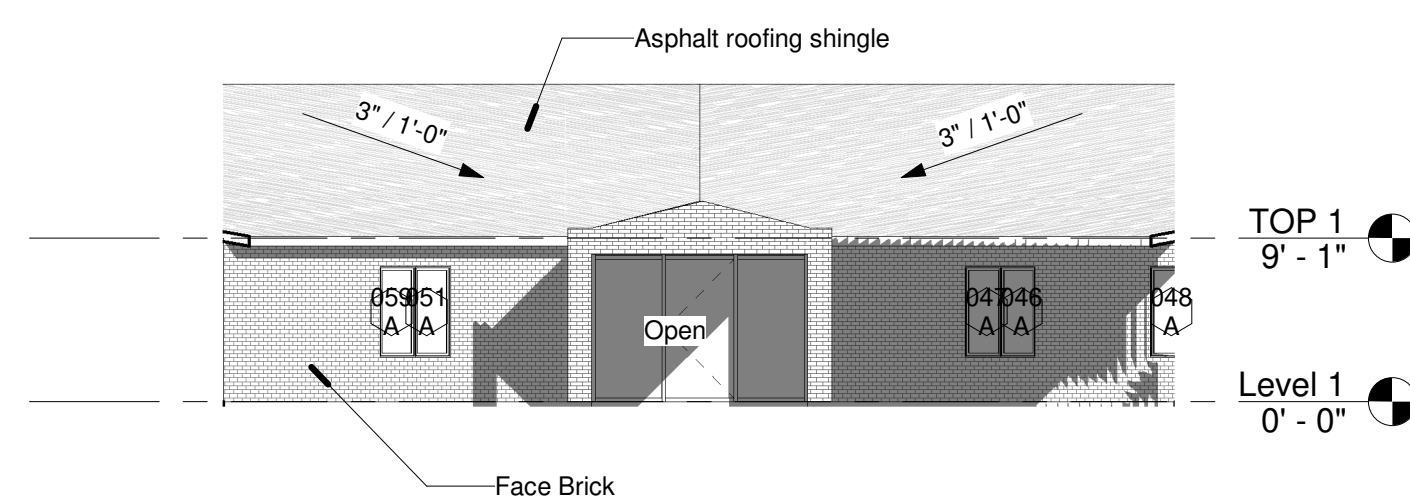

⑤ Main Entry  
3/32" = 1'-0"

 

Reference  
Not For  
Construction

Copyright 2018  
Robert Durham Architecture

Residential Facility - Existing  
Volunteers of America - Texas  
800 W. Wintergreen Rd.  
Hutchins, TX 75141

No.	Description	Date

Building  
Elevation

Project # 2017-301  
Date Issue Date  
Drawn by Author  
Checked by Checker

A301

Scale 3/32" = 1'-0"

1/9/2018 2:59:37 PM