



FITTINGS

- ① - 20° 45° Bend
- ② - 6° 45° Bend
- ③ - 12" GATE VALVE w/VALVE BOX AND COLLAR
- ④ - 12"x6" TEE
- ⑤ - 12" 90° BEND
- ⑥ - 12" TEE
- ⑦ - 12" 11.25° BEND
- ⑧ - 12" 45° BEND
- ⑨ - 12" M.J. PLUG
- ⑩ - 1" 45° BEND
- ⑪ - 1" 90° BEND

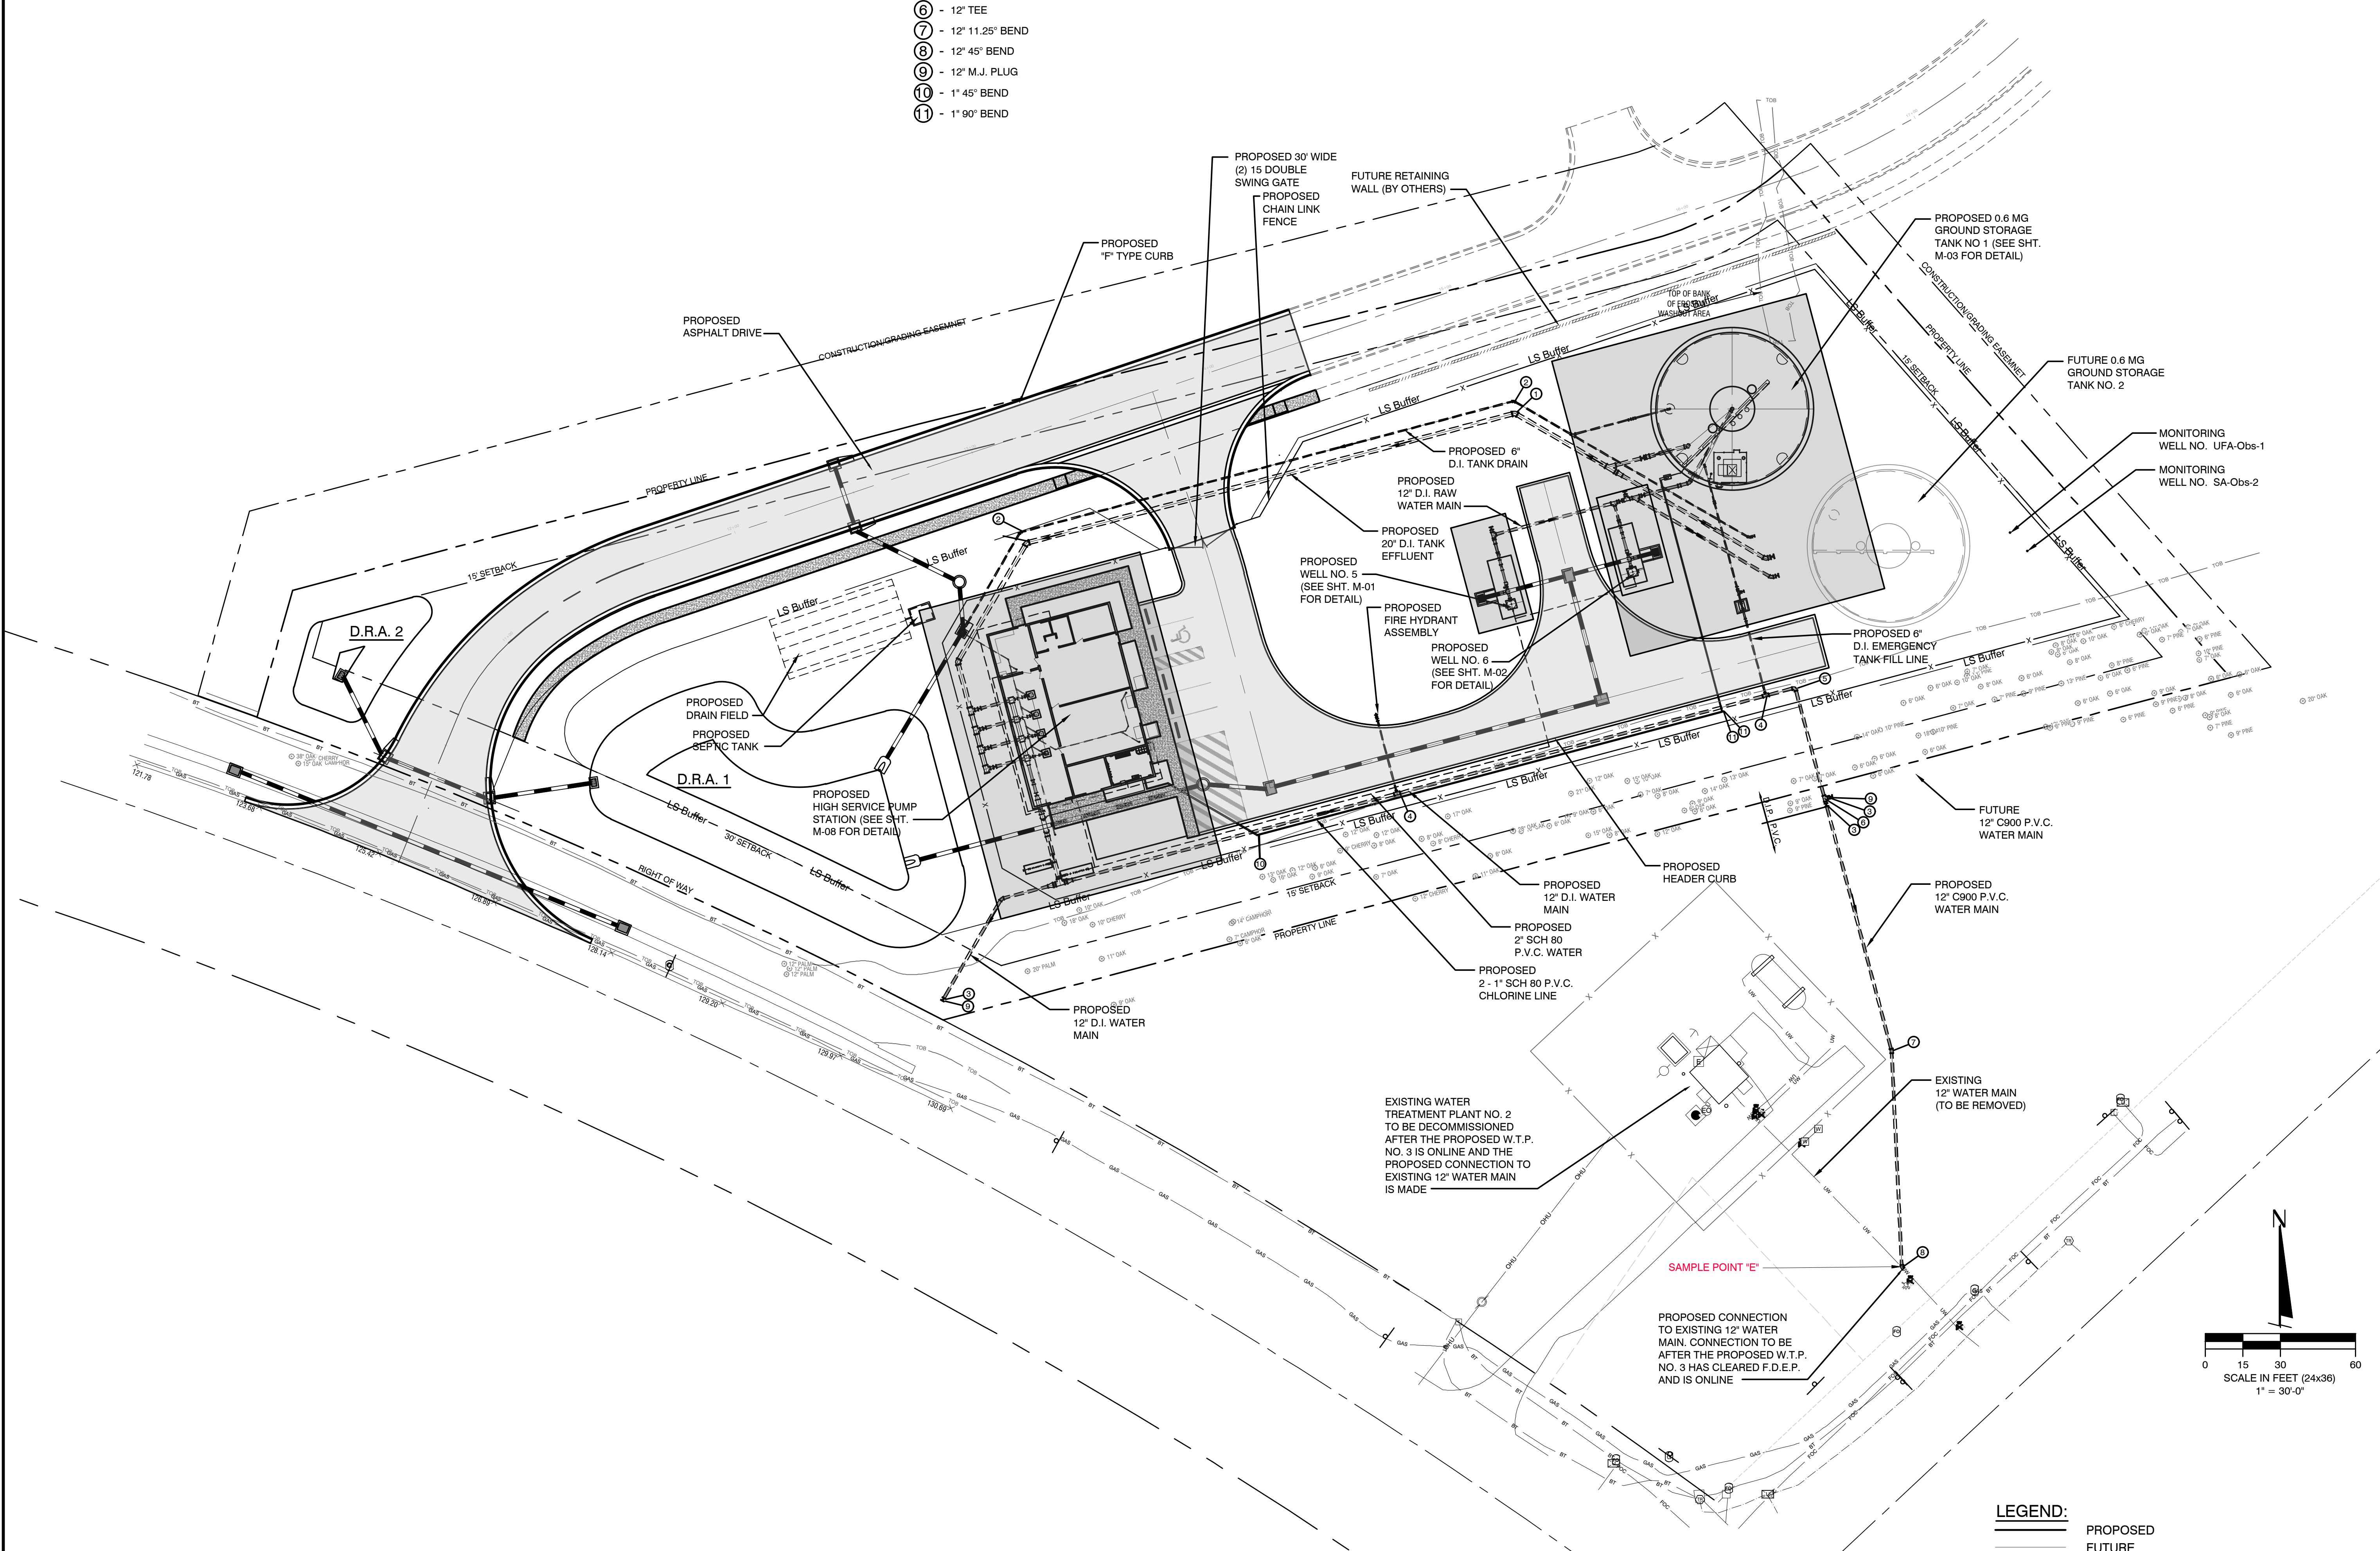

REVISION	DATE	DESCRIPTION
1	11-26-24	60% REVIEW SET

 
HOWEY-IN-THE-HILLS, FLORIDA
WATER TREATMENT PLANT No. 3
YARD PIPING PLAN



902 North Sinclair Ave.
 Tavares, Florida 32778
 Office: 352.343.8481
 Fax: 352.343.8485
 Certificate of Authorization Number: 33380

DATE: NOVEMBER 19, 2024
 DESIGNED BY: TEM
 DRAWN BY: -
 CHECKED BY: TEM
 JOB NO.: 055783.001
 FILE NAME: -
SHEET C-04

TROY E. MITCHELL, PE
 REGISTERED ENG. 60190

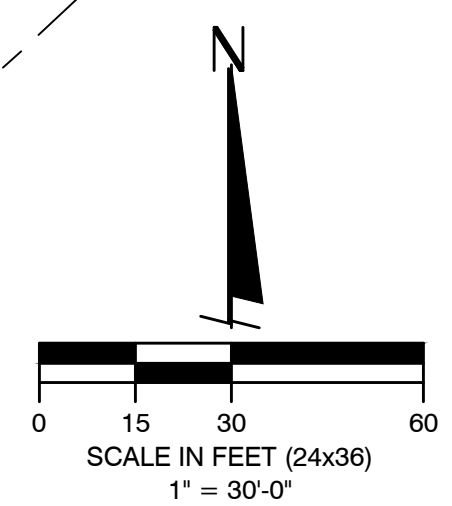

LEGEND:
 — PROPOSED
 - - - FUTURE