


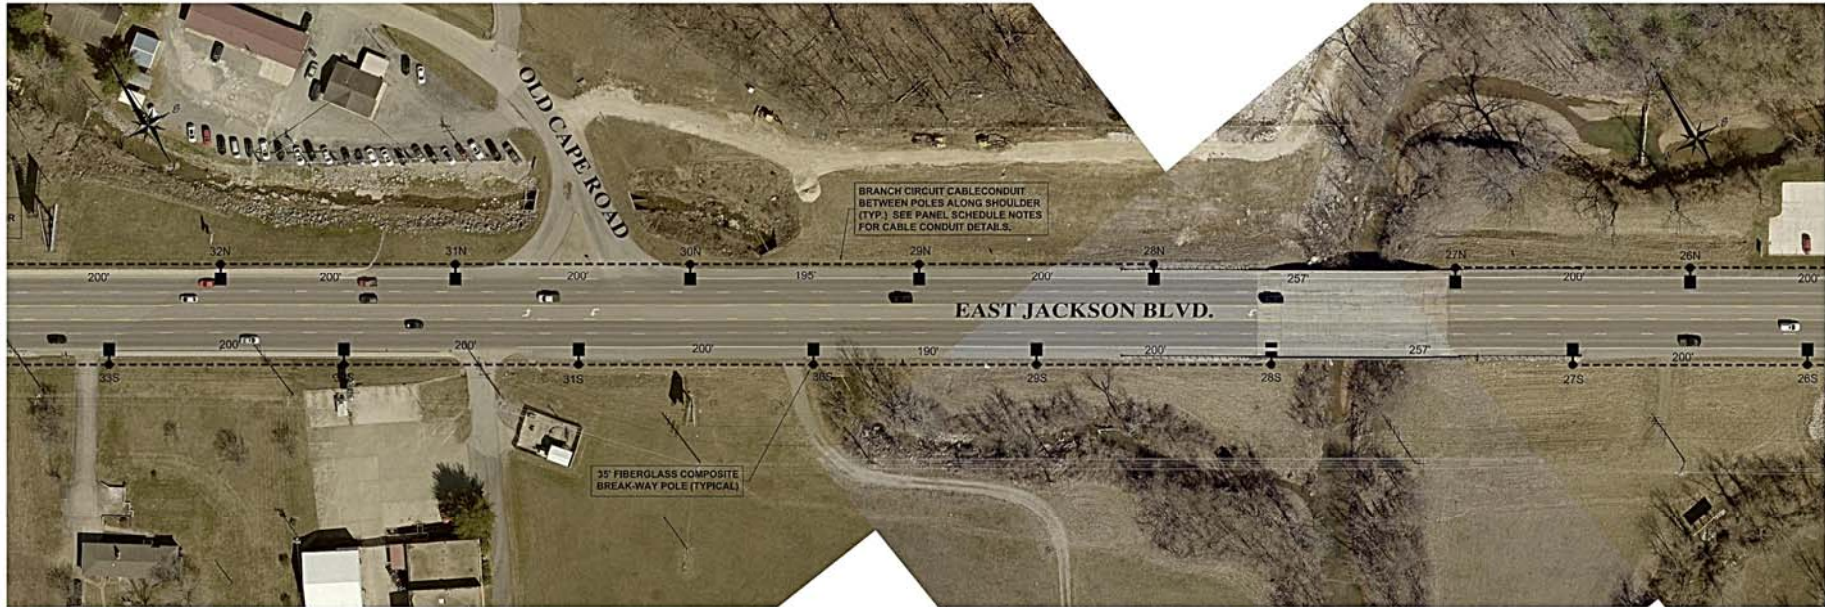

1 ROADWAY LIGHTING LAYOUT - SECTION 3
E1.2 SCALE: 1" = 50'



2 ROADWAY LIGHTING LAYOUT - SECTION 4
E1.2 SCALE: 1" = 50'

REV	DESCRIPTION	DATE	REV	DESCRIPTION	DATE

**EAST JACKSON BOULEVARD
ROADWAY LIGHTING PROJECT**

**STRICKLAND
ENGINEERING**

113 WEST MAIN STREET
JACKSON, MISSISSIPPI 39205
PHONE: 601-373-6200
FAX: 601-373-6201

CIVIL - MECHANICAL - PLUMBING - ELECTRICAL ENGINEERING
LAND SURVEYING

DRAWING TITLE
**LIGHTING
LAYOUT PLAN**

SCALE As Noted
DATE 9/25/2023
DRAWN BY SW/AW
JOB NO. 23-135
DRAWING NUMBER **E1.2**

CONSECUTIVE NUMBER
OF

95% REVIEW SET
- 09/25/2023