


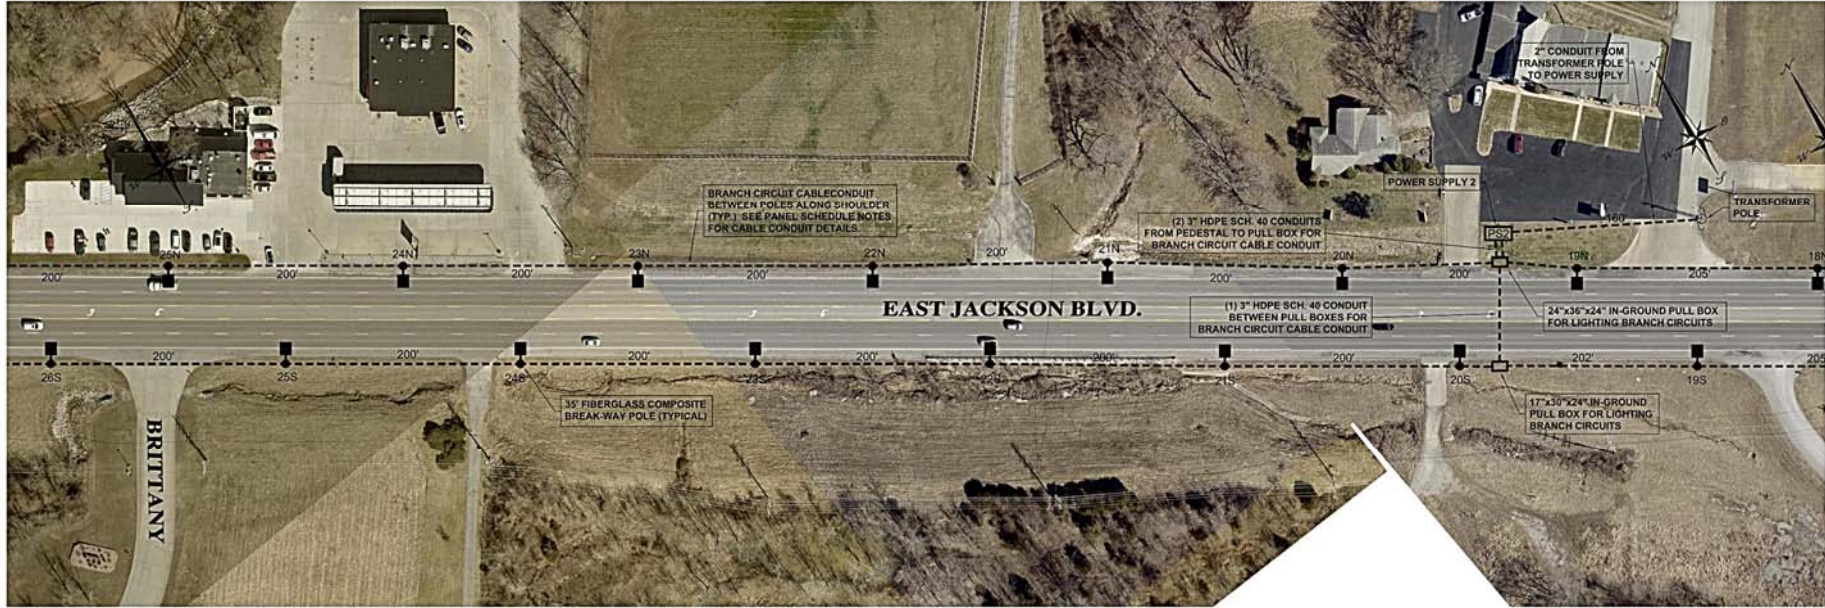

1 ROADWAY LIGHTING LAYOUT - SECTION 5
E1.3 SCALE: 1" = 50'



2 ROADWAY LIGHTING LAYOUT - SECTION 6
E1.3 SCALE: 1" = 50'

REV	DESCRIPTION	DATE	REV	DESCRIPTION	DATE

**EAST JACKSON BOULEVARD
ROADWAY LIGHTING PROJECT**
JACKSON, MISSOURI

**STRICKLAND
ENGINEERING**
113 WEST MAIN STREET
JACKSON, MISSOURI 63705
PHONE: 661-2200
FAX: 661-2201

CIVIL - MECHANICAL - PLUMBING - ELECTRICAL ENGINEERING
LAND SURVEYING

DRAWING TITLE	
LIGHTING LAYOUT PLAN	
SCALE	As Noted
DATE	9/25/2023
DRAWN BY	SW/AW
JOB NO.	23-135
DRAWING NUMBER	E1.3
CONSECUTIVE NUMBER	OF

© COPYRIGHT 2023 STRICKLAND ENGINEERING, L.C.
STRICKLAND ENGINEERING, L.C. MISSOURI LICENSE NO. 200101349

See 95% REVIEW SET
- 09/25/2023