



Thursday, November 12, 2020 1:25:07 PM
 G:\2019\19000966.01\CAD-BM FOLDERS\CIVIL\DWG\SOURCE\19000966_01-LIFT STATION_PROP_CENTRAL-20201016.DWG

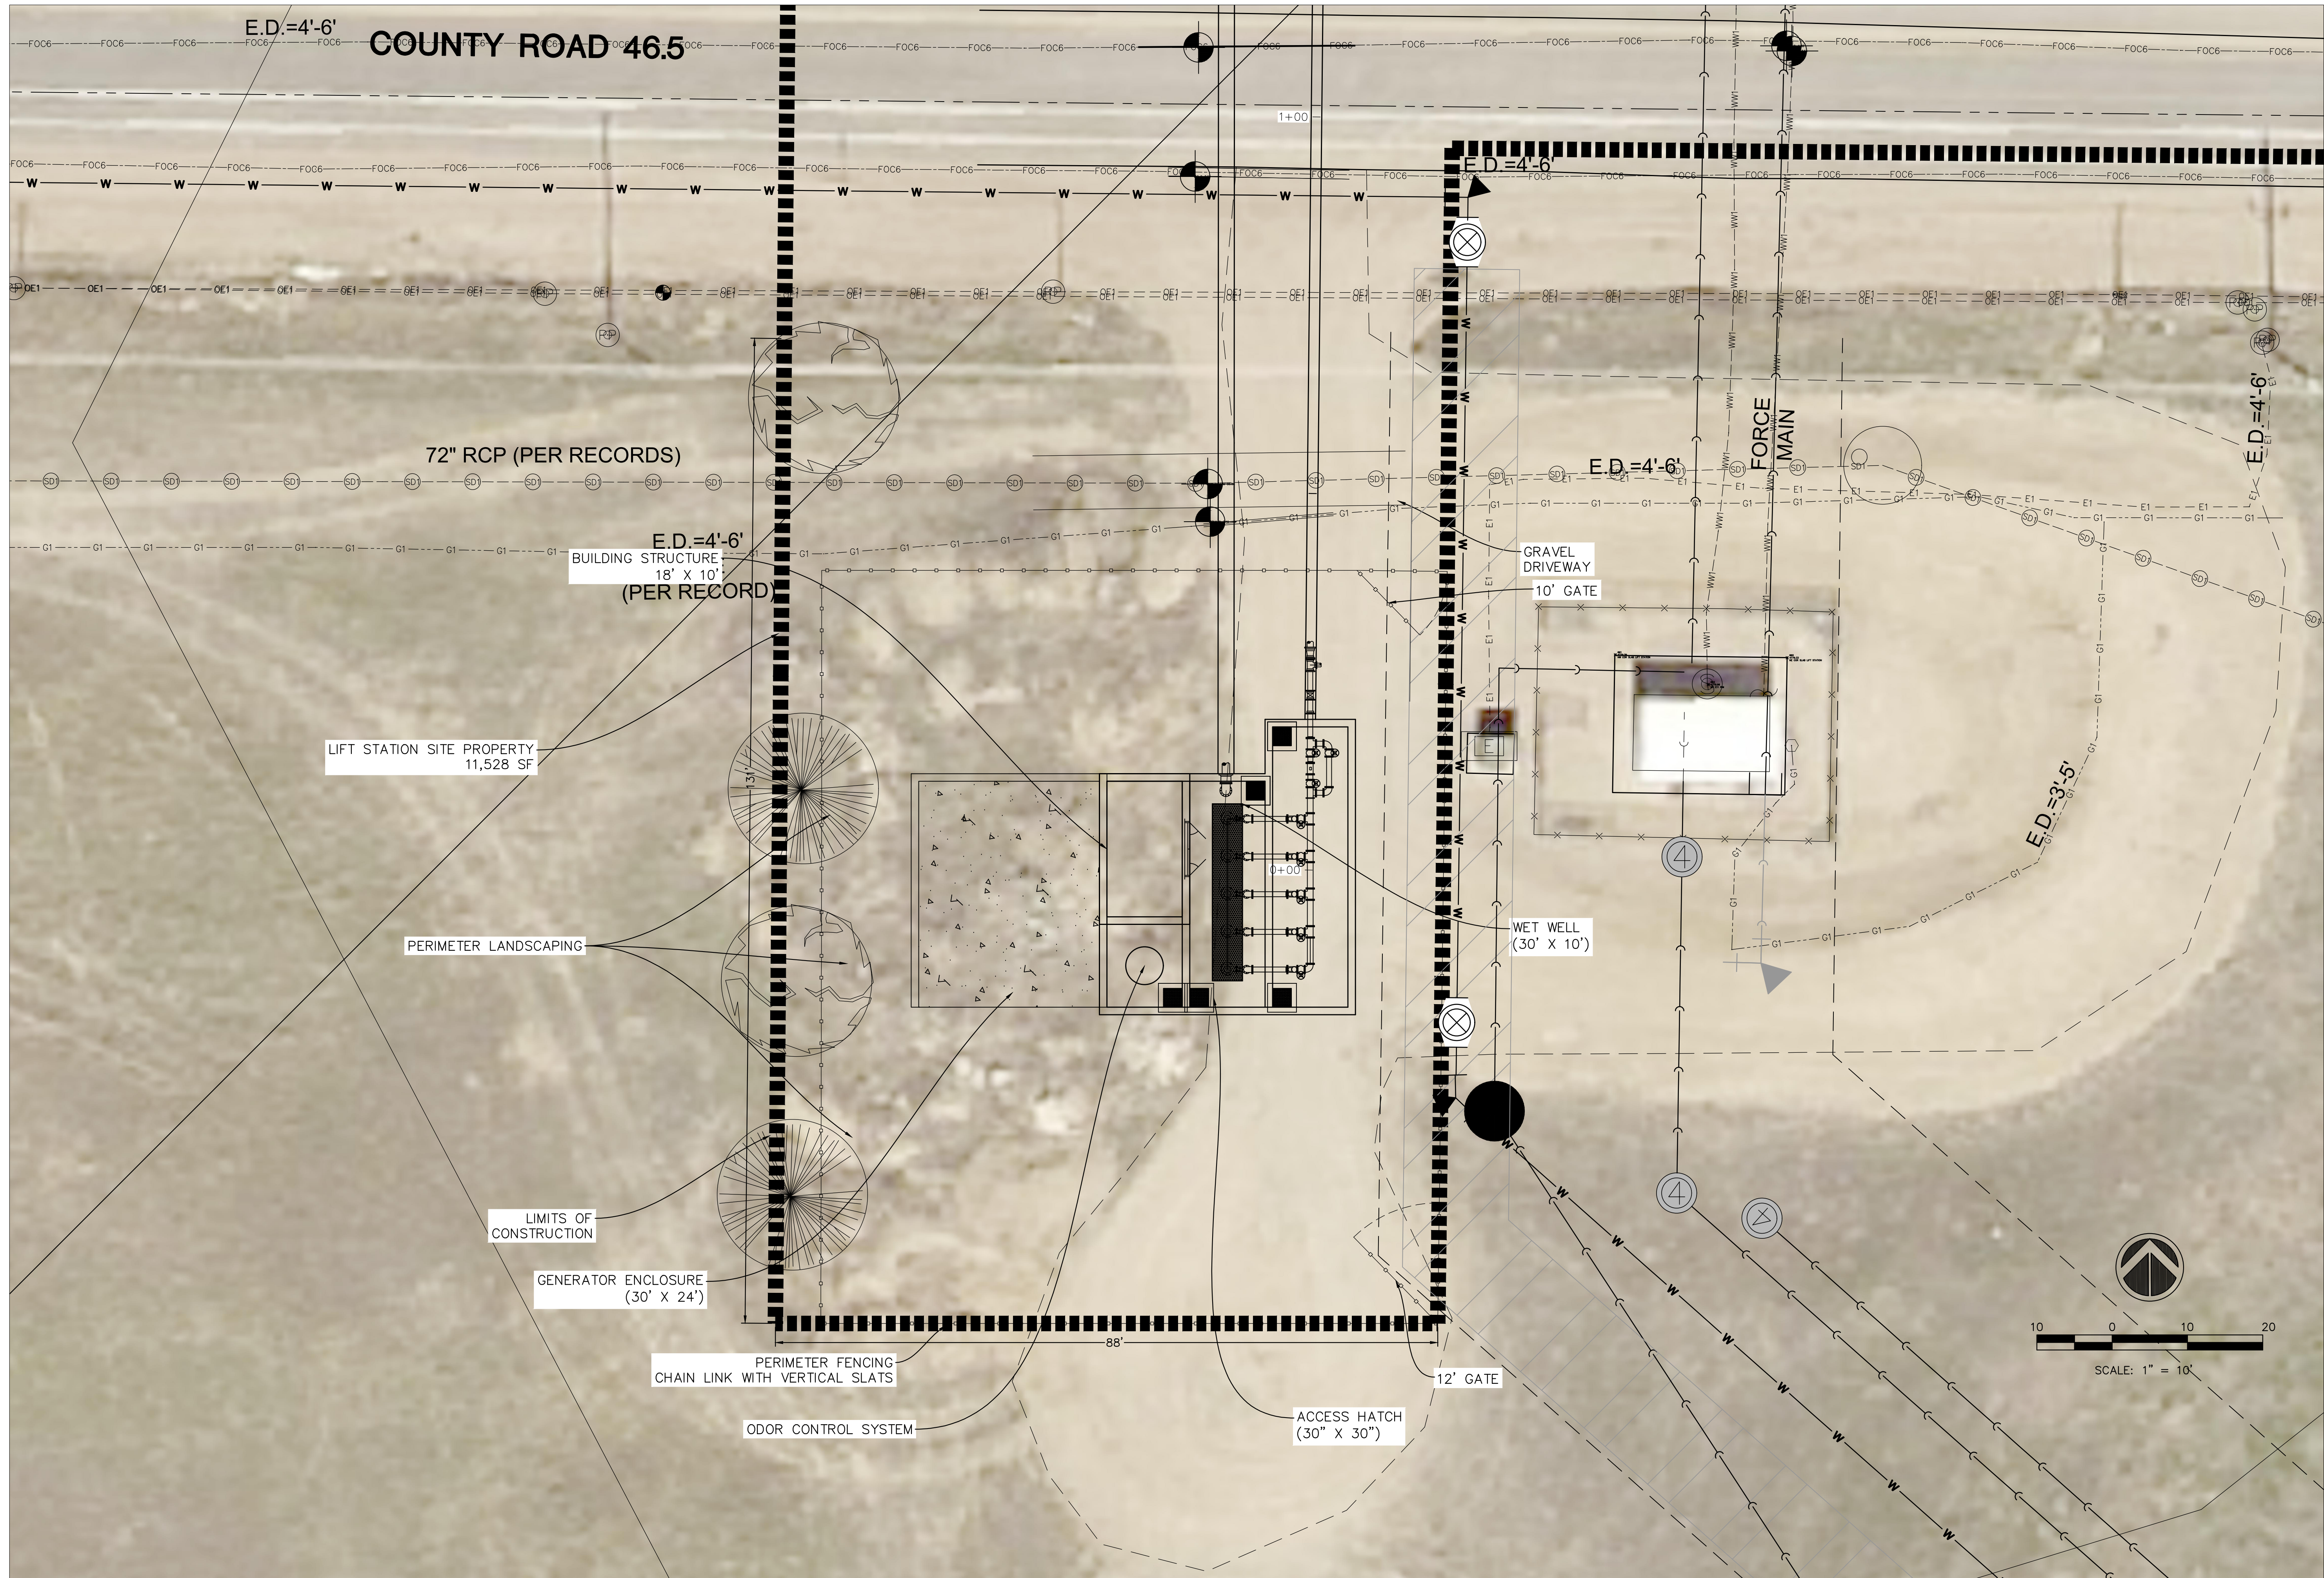

NO.	REVISIONS	DESCRIPTION	DATE

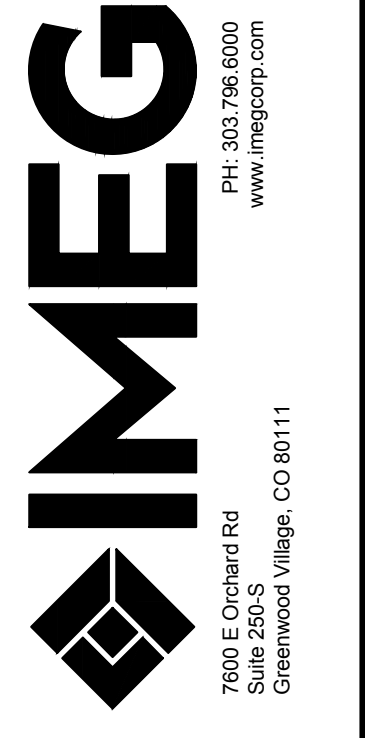

CENTRAL SEWER EXPANSION - PHASE 1
 JOHNSTOWN, CO
SITE PLAN - LIFT STATION

IMEG Project No:
 19000966.01
 File Name:
 19000966_01-01 station_prop_central-20201016.dwg
 © COPYRIGHT 2020
 ALL RIGHTS RESERVED
 Field Book No:
 Drawn By: XXX
 Checked By: XXX
 Date: 11/15/2020

SC01
 Sheet 5 of #