


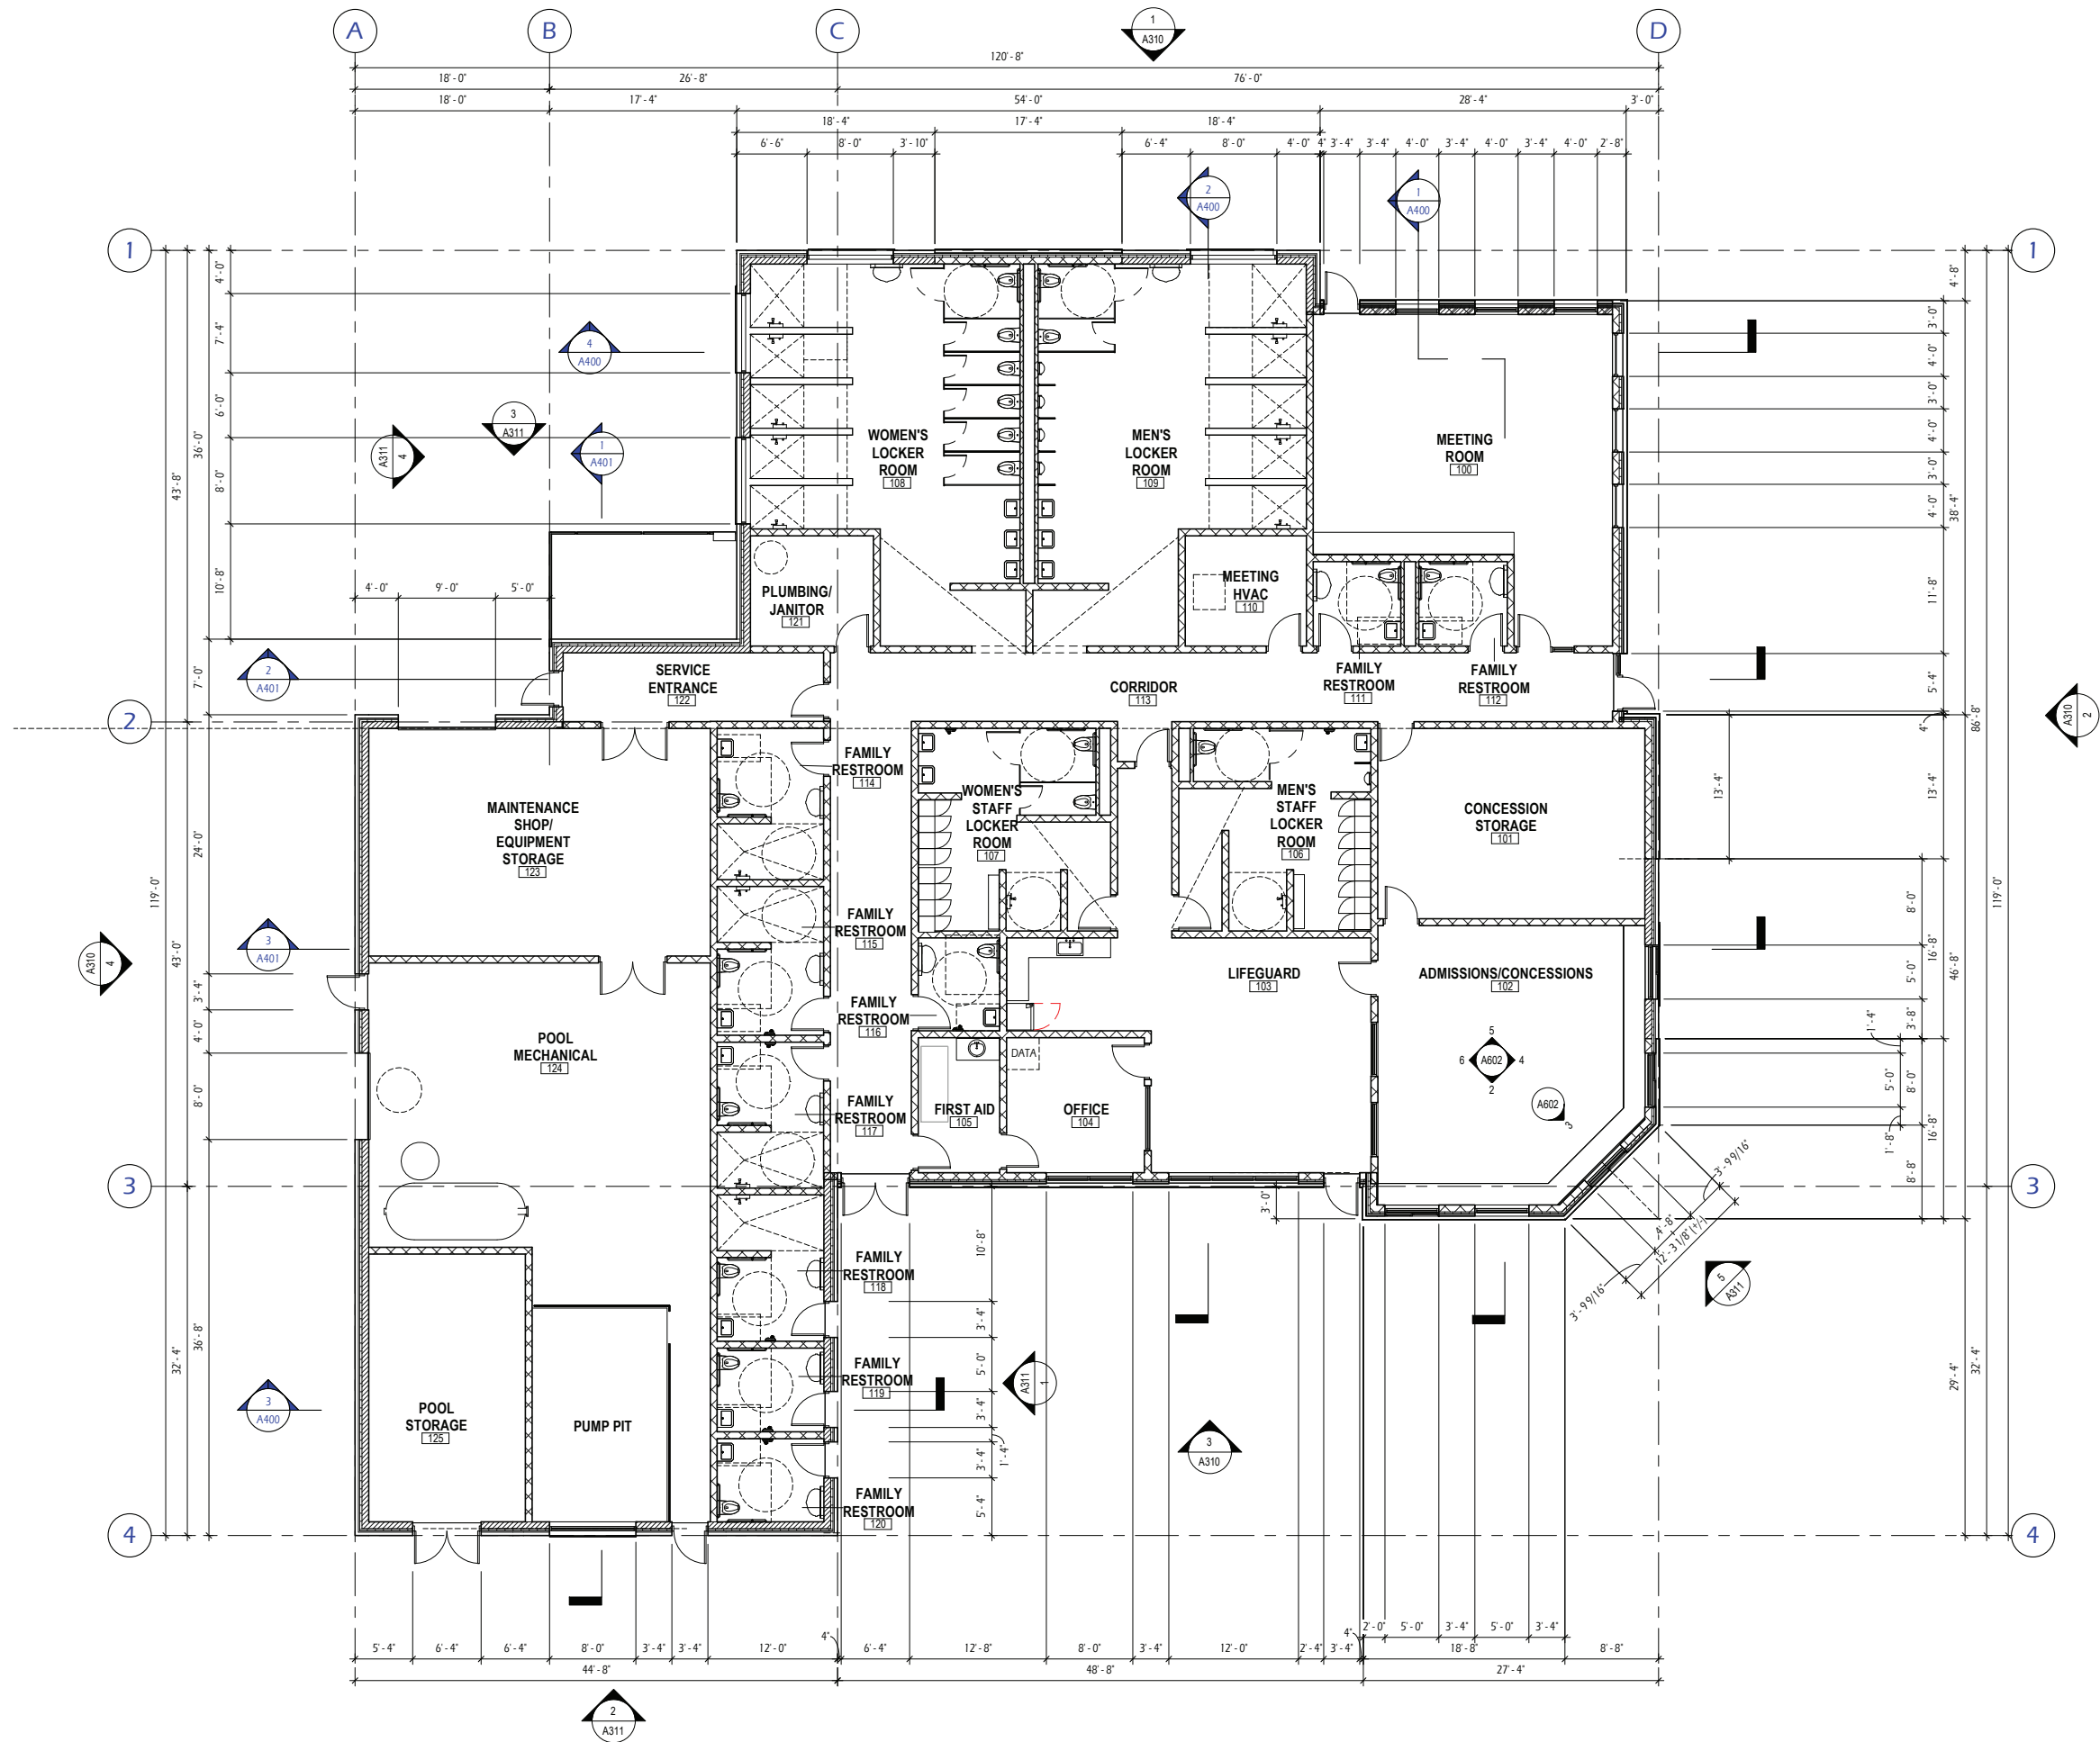


1 FLOOR PLAN
1/8" = 1'-0"

REVISIONS:		
ISSUE	DESCRIPTION	DATE

Project #: 20.008
Issued For: 30% SET
Date: 9/16/2022

Sheet Number
A100

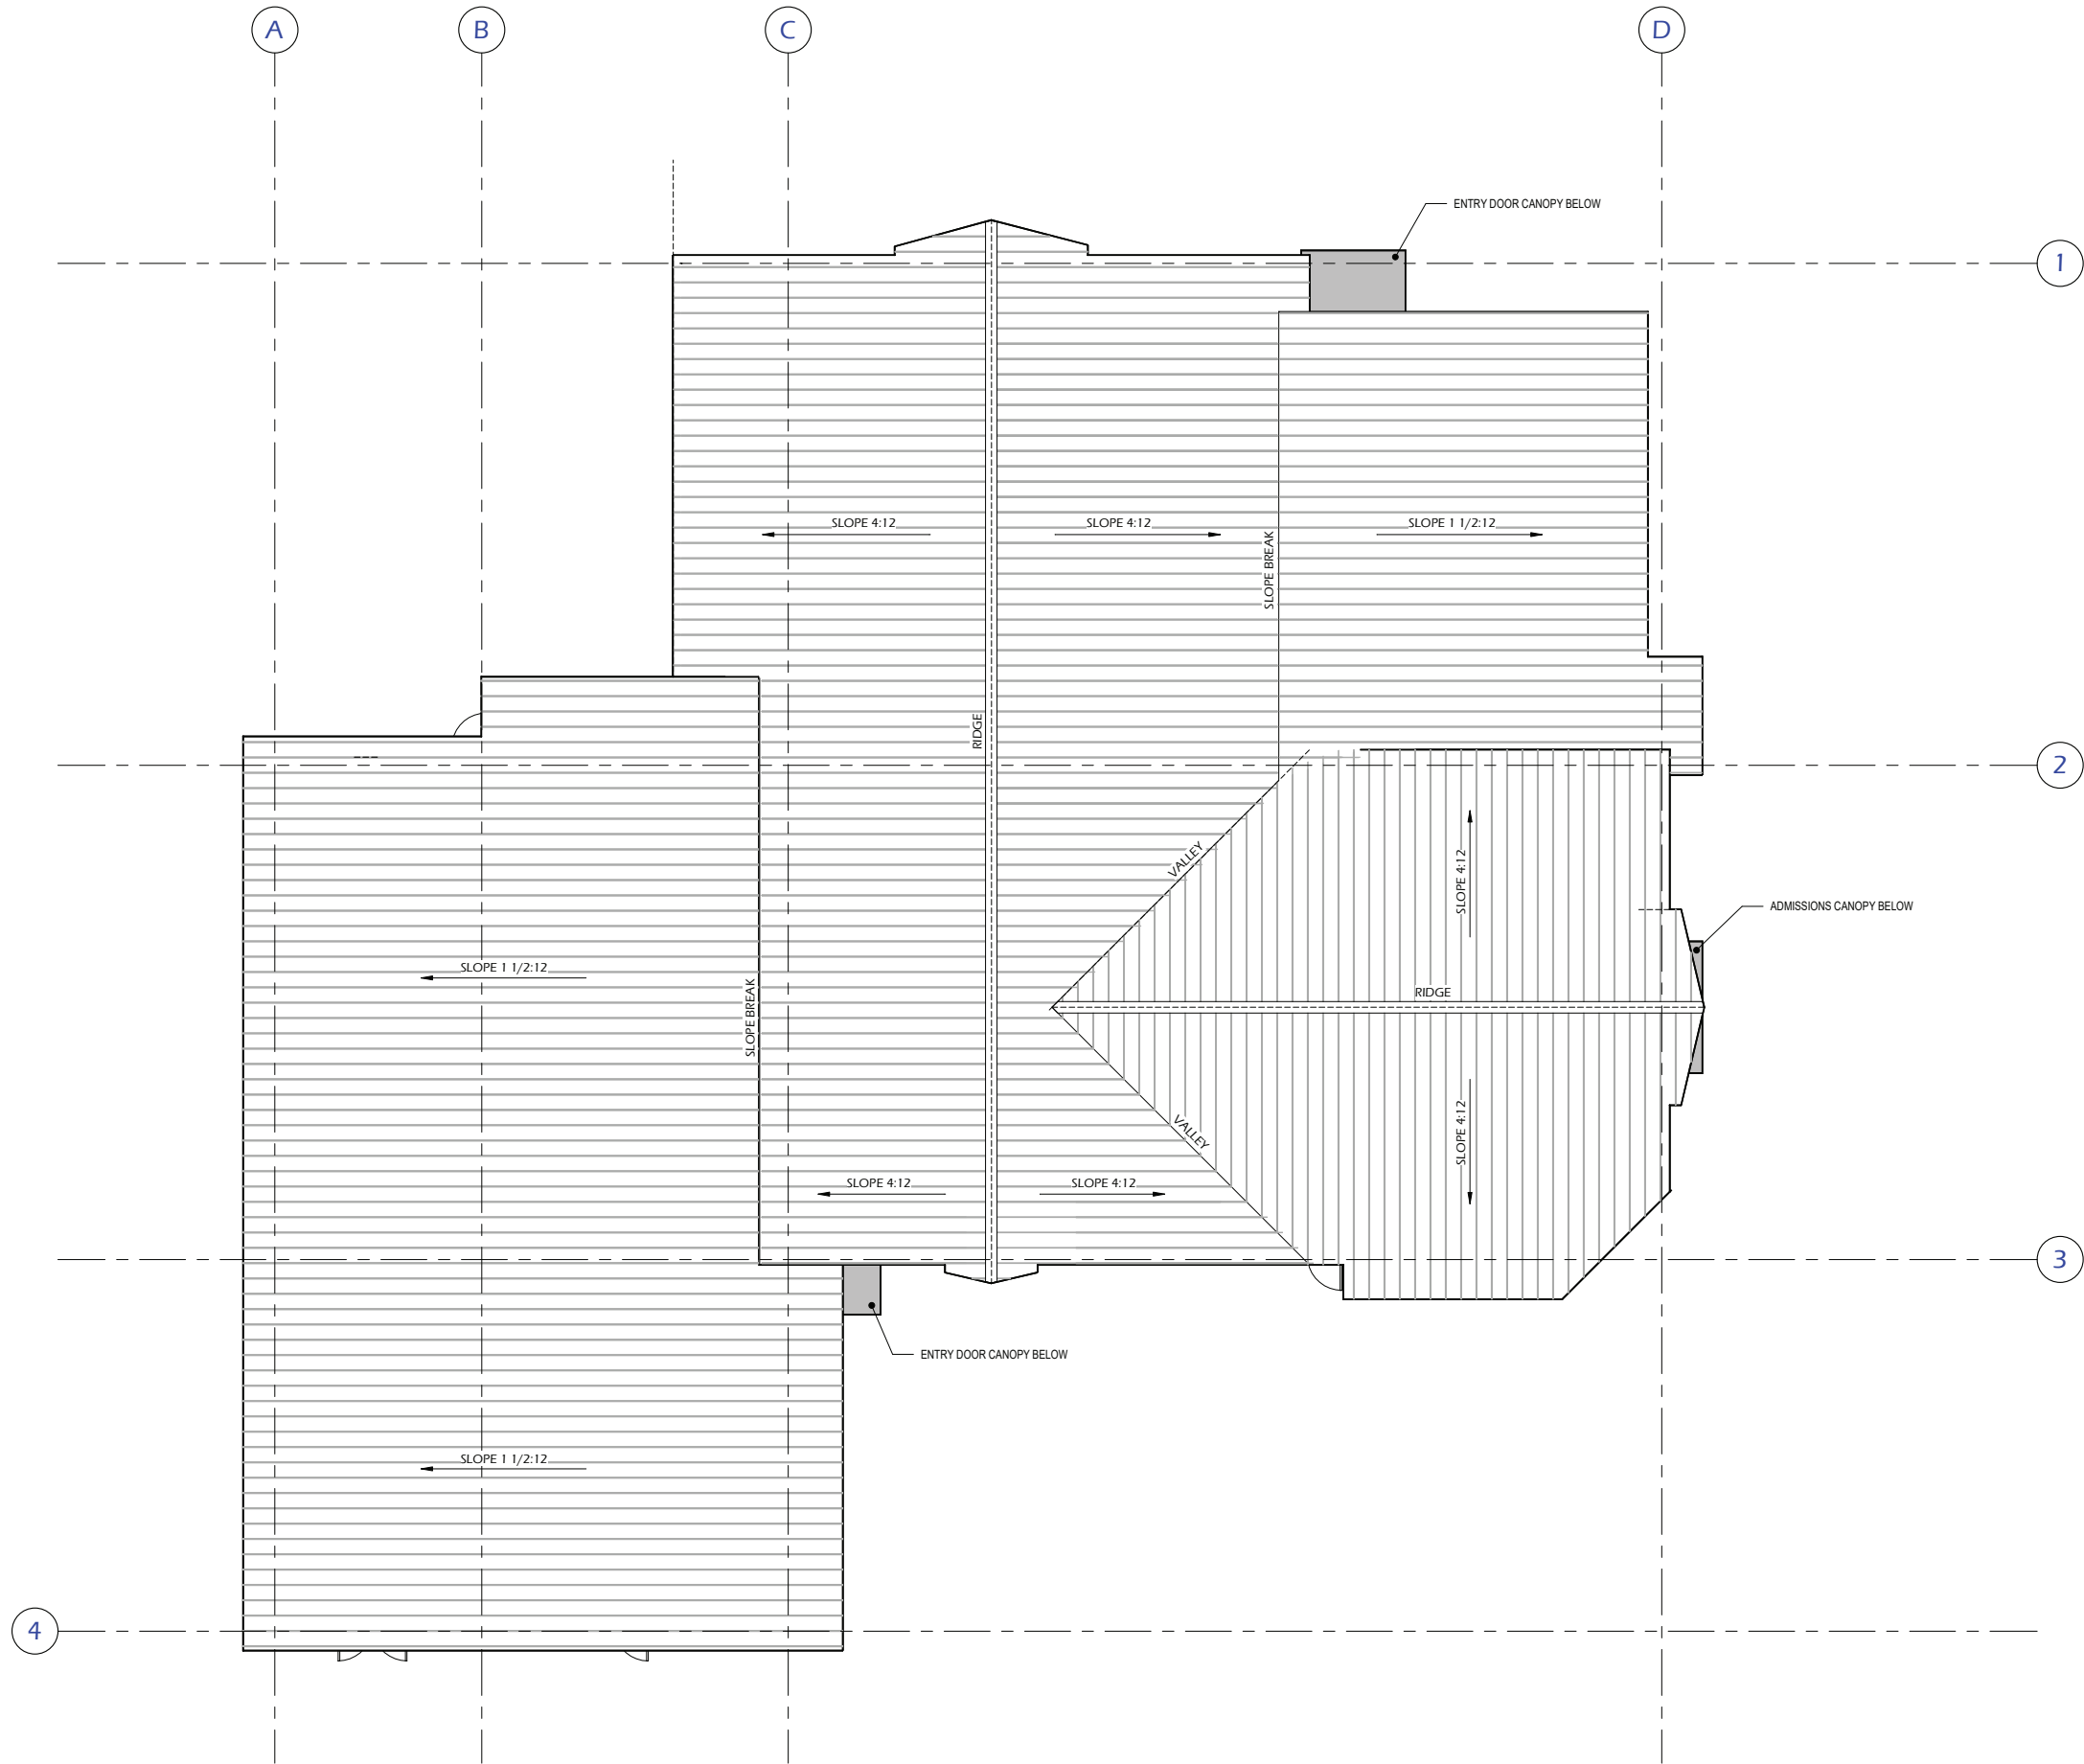

1
A110
1/8" = 1'-0"

ROOF PLAN



REVISIONS:		
ISSUE	DESCRIPTION	DATE
Project #:	20.008	
Issued For:	30% SET	
Date:	9/16/2022	
Sheet Number	A110	



3 SOUTH ELEVATION - BUILDING MATERIALS
A310 3/16" = 1'-0"



2 EAST ELEVATION - BUILDING - MATERIALS
A310 3/16" = 1'-0"



1 NORTH ELEVATION - BUILDING MATERIALS
A310 3/16" = 1'-0"



4 WEST ELEVATION - BUILDING MATERIALS
A310 3/16" = 1'-0"

EXTERIOR MATERIALS			
MARK	DESCRIPTION	COLOR	NOTES
AA1	ANNODIZED ALUMINUM	BLACK	4
M1	SMOOTH-FACE MASONRY	BLACK GRANITE	2
M2	SMOOTH-FACE MASONRY	SALT AND PEPPER	2
P1	PAINTED FINISH	BLACK	
R1	ROOF & ROOF ACCESSORIES	COPPER PENNY	3
S1	VERTICAL PANELS (SMOOTH)	GRAPHITE	1
S2	VERTICAL PANELS (SMOOTH)	LIGHT GREY	1
S3	VERTICAL WOOD - ASH	WEATHERED	1
T1	HROIZONTAL TRIM BOARD	GRAPHITE	3
NOTES: 1. COLOR SELECTED FROM LP BUILDING SOLUTIONS STANDARD COLORS. 2. COLOR SELECTED FROM COUNTY MATERIALS "PREMIER ULTRA" SERIES BURNISHED BLOCK STANDARD COLORS. 3. COLOR SELECTED FROM PAC-CLAD STANDARD COLORS. 4. COLOR SELECTED FROM KAWNEER ANNODIZED ALUMINUM STANDARD COLORS.			



WOOD SIDING (S-3)
(AGED THERMALLY MOD. ASH)




SMOOTH PANEL SIDING (S-2)
(LIGHT GREY)



SMOOTH PANEL SIDING (S-1)
(GRAPHITE)



ROOFING (R-1)
(KYNAR - COPPER PENNY)

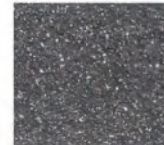

MASONRY (M-1)
(BLACK GRANITE)



MASONRY (M-2)
(SALT AND PEPPER)



5
A311
3/16" = 1'-0"

EAST ELEVATION (CONCESSIONS) - BUILDING MATERIALS



4
A311
3/16" = 1'-0"

WEST ELEVATION (LOCKERROOMS) - BUILDING MATERIALS




3
A311
3/16" = 1'-0"

NORTH ELEVATION (MAINTENANCE) - BUILDING MATERIALS



2
A311
3/16" = 1'-0"

SOUTH ELEVATION (POOL MECHANICAL) - BUILDING MATERIALS

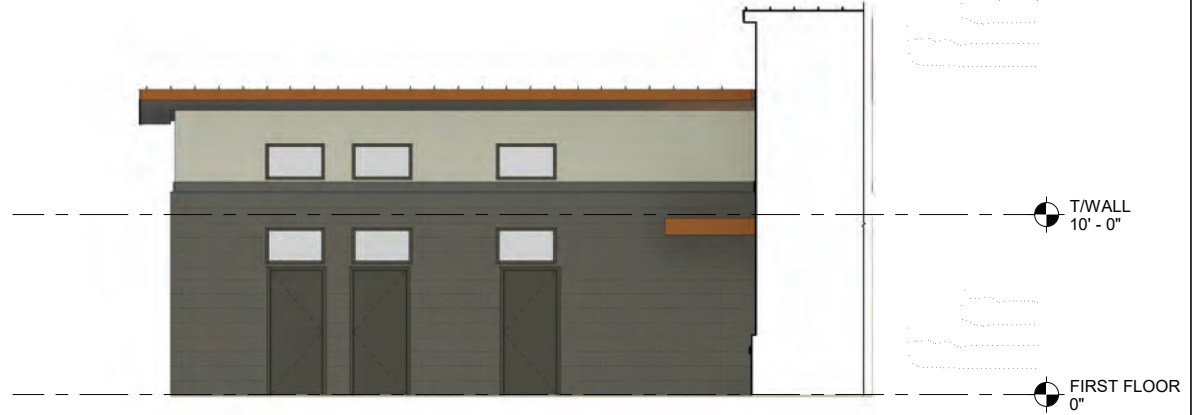

1
A311
3/16" = 1'-0"

EAST ELEVATION (RESTROOMS) - BUILDING MATERIALS

REVISIONS:		
ISSUE	DESCRIPTION	DATE

Project #: 20.008
Issued For: 30% SET
Date: 9/16/2022

Sheet Number
A311



WEST ELEVATION



NORTHWEST ELEVATION

REVISIONS:		
ISSUE	DESCRIPTION	DATE

Project #:

20.008

Issued For:

30% SET

Date:

9/16/2022

Sheet Number

A320



NORTHEAST ELEVATION




EAST ELEVATION


REVISIONS:		
ISSUE	DESCRIPTION	DATE

Project #: 20.008
Issued For: 30% SET
Date: 9/16/2022


Sheet Number
A321

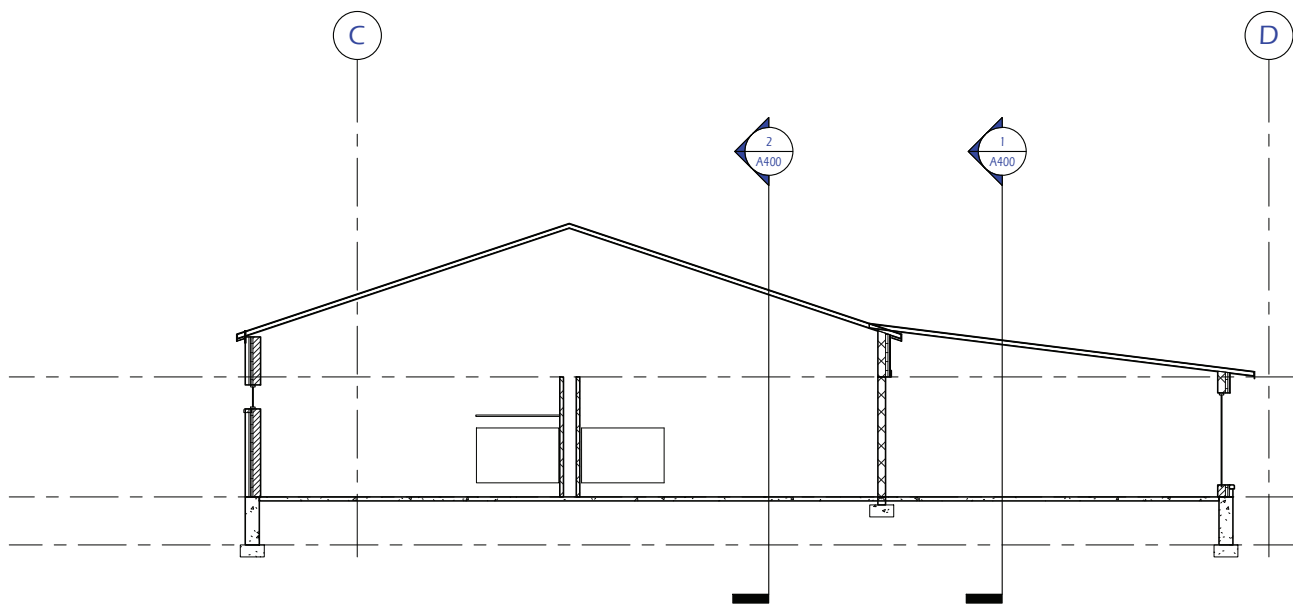


4 Section 33
A400 1/8" = 1'-0"

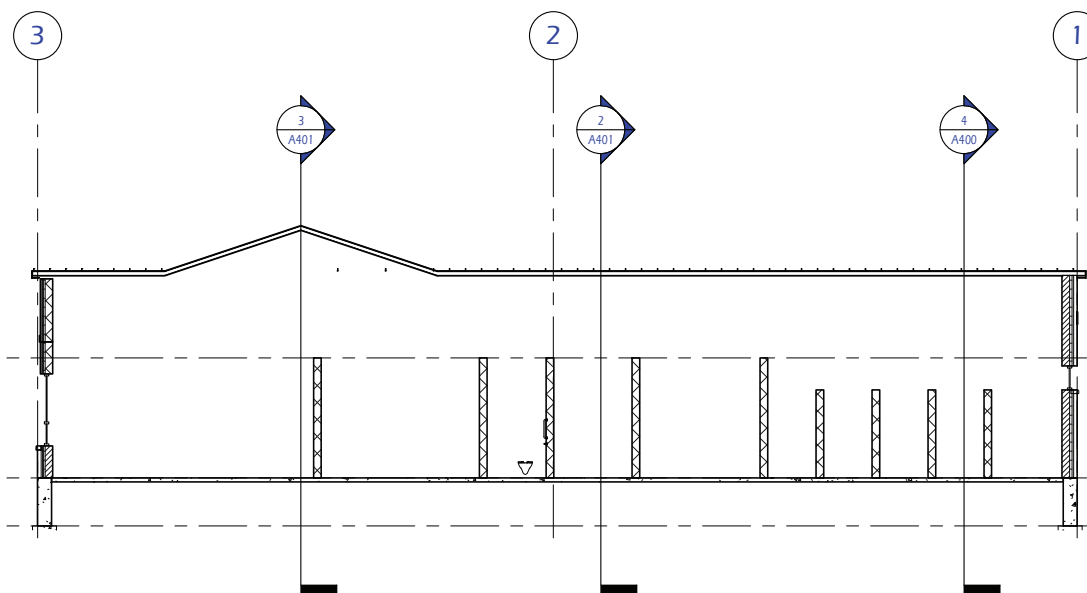

2 Section 36
A400 1/8" = 1'-0"

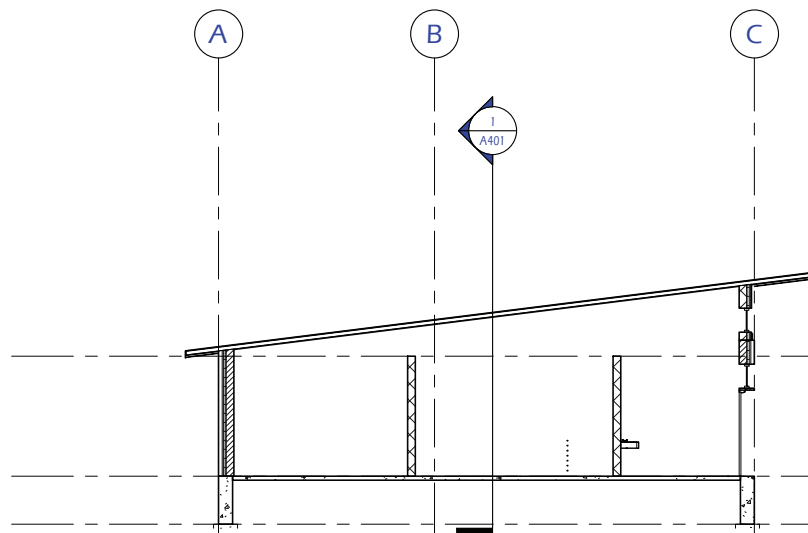

3 Section 37
A400 1/8" = 1'-0"

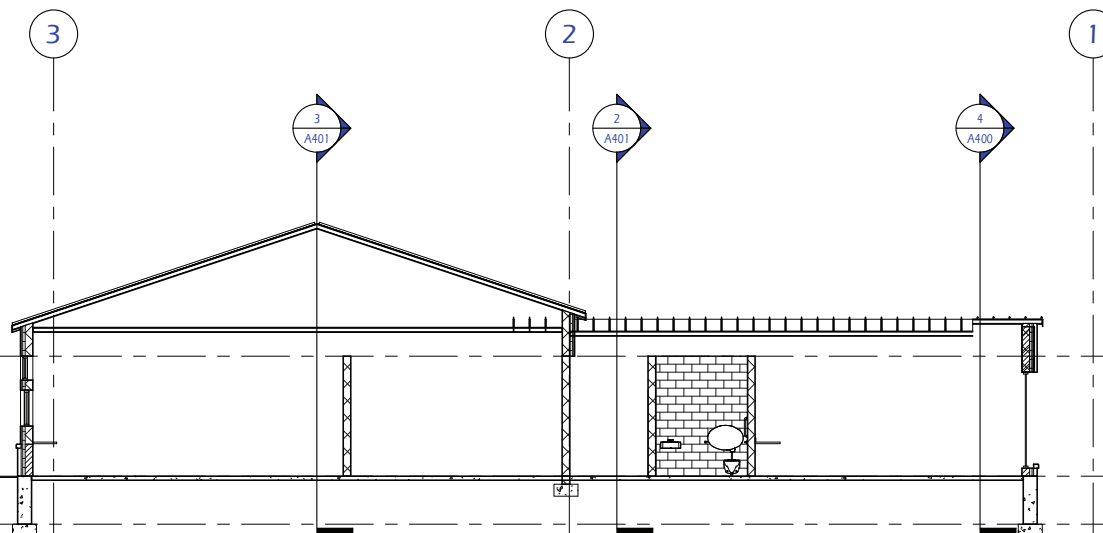


1 Section 34
A400 1/8" = 1'-0"


REVISIONS:		
ISSUE	DESCRIPTION	DATE

Project #: 20.008
Issued For: 30% SET
Date: 9/16/2022

Sheet Number
A400

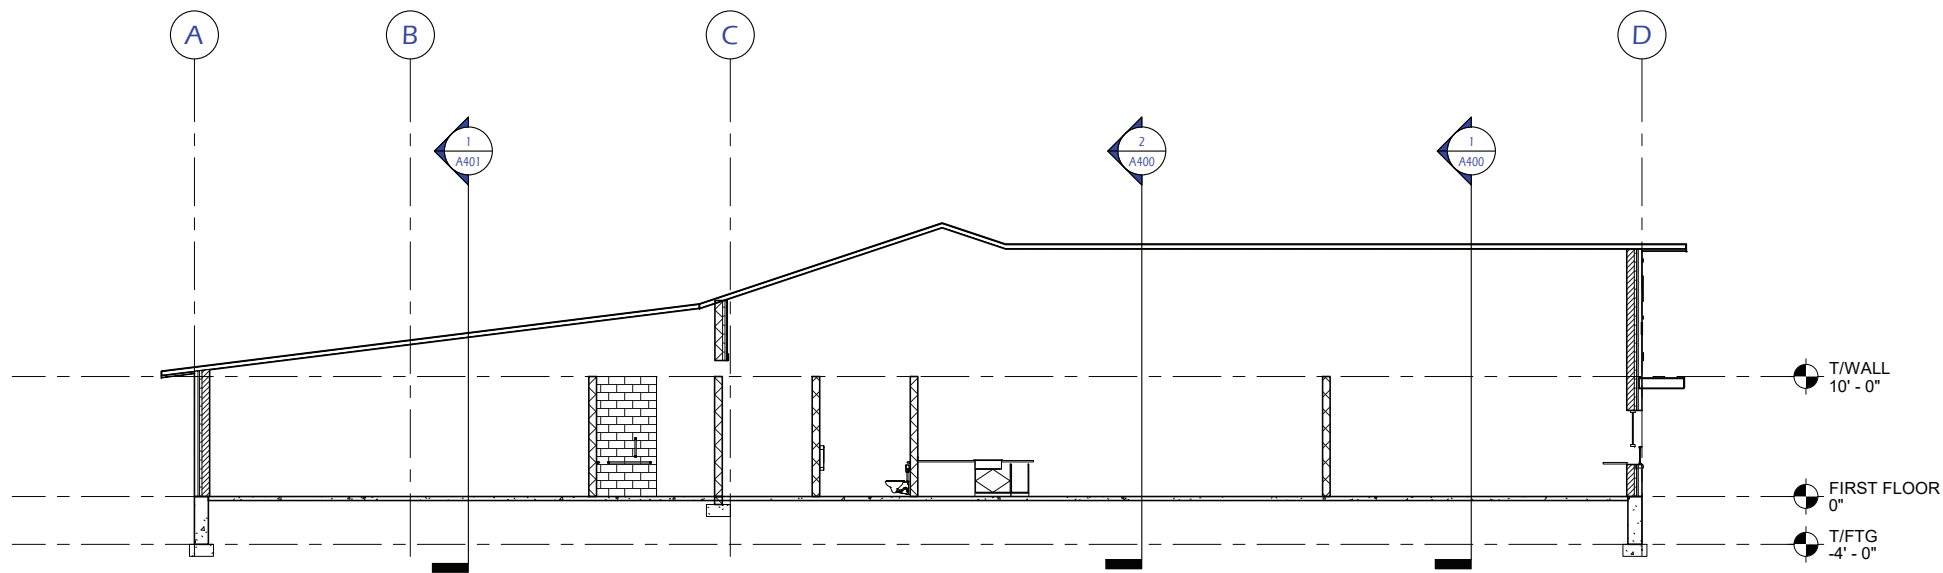


3 Section 3
A401 1/8" = 1'-0"

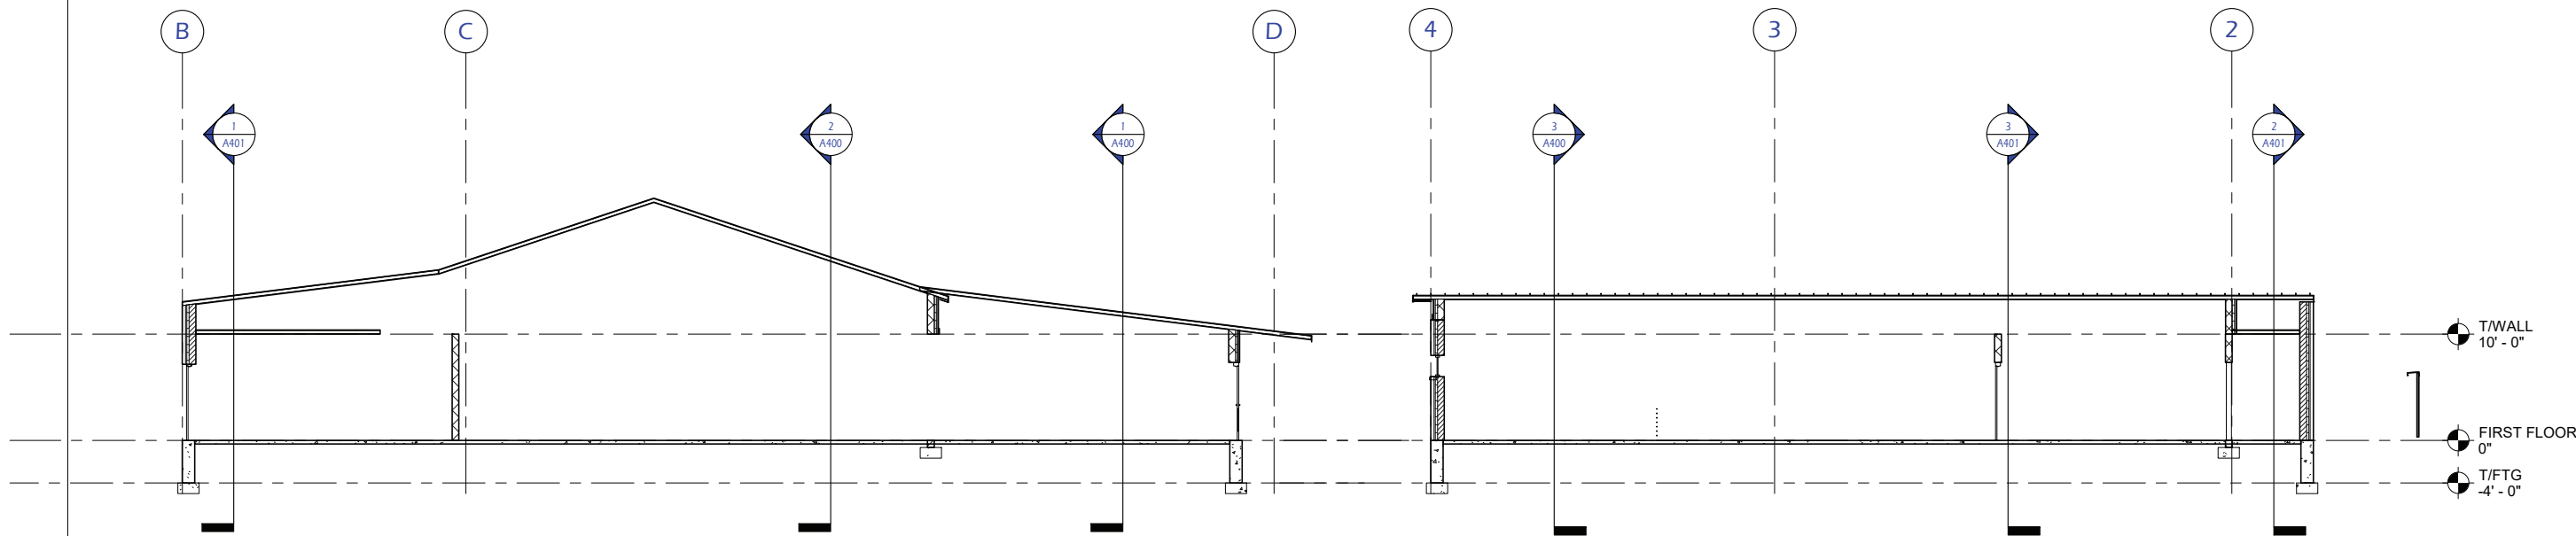


2 Section 1
A401 1/8" = 1'-0"

1 Section 2
A401 1/8" = 1'-0"


BATHROOM ACCESSORIES				ROOMS/QUANTITIES												
MARK	DESCRIPTION	MAKE	MODEL #	MEN'S STAFF LOCKER ROOM 106	WOMEN'S STAFF LOCKER ROOM 107	WOMEN'S LOCKER ROOM 108	MEN'S LOCKER ROOM 109	RESTROOM 111	RESTROOM 112	RESTROOM 114	RESTROOM 115	RESTROOM 116	RESTROOM 117	RESTROOM 118	RESTROOM 119	RESTROOM 120
BCS	BABY CHANGING STATION	BRADLEY	963	1	1	1	1	1	1	1	1	1	1	1	1	1
M	24"W x 36"H STAINLESS STEEL MIRROR	BRADLEY	748-2436	1	2	2	1	1	1	1	1	1	1	1	1	1
SD	SOAP DISPENSER	BRADLEY	6562	1	1	1	1	1	1	1	1	1	1	1	1	1
WR	WASTE RECEPTACLE	BRADLEY	357	1	1	1	1	1	1	1	1	1	1	1	1	1
TTD	TOILET TISSUE DISPENSER	BRADLEY	5425	1	3	1	1	1	1	1	1	1	1	1	1	1
SN	SANITARY NAPKIN DISPOSAL	BRADLEY	4A10-11	1	3		1	1	1	1	1	1	1	1	1	1
GB-1	18" VERTICAL GRAB BAR	BRADLEY	812	1	1	1	1	1	1	1	1	1	1	1	1	1
GB-2	36" HORIZONTAL GRAB BAR	BRADLEY	812	1	1	1	1	1	1	1	1	1	1	1	1	1
GB-3	42" HORIZONTAL GRAB BAR	BRADLEY	812	1	1	1	1	1	1	1	1	1	1	1	1	1
TP	SOLID PHENOLIC TOILET PARTITION	BRADLEY	400 SERIES		3											
UP	SOLID PHENOLIC URINAL PARTITION	BRADLEY	400 SERIES			2										
AD	ELECTRIC HAND DRYER	EXCEL	XL-BW-120	1	1	1	1	1	1	1	1	1	1	1	1	1

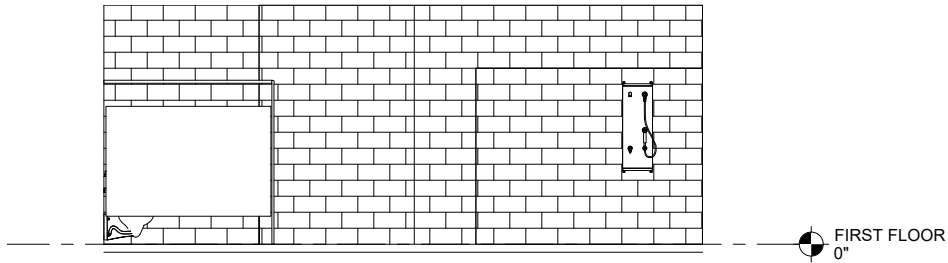


5
A600
Elevation 1 - b
1/4" = 1'-0"

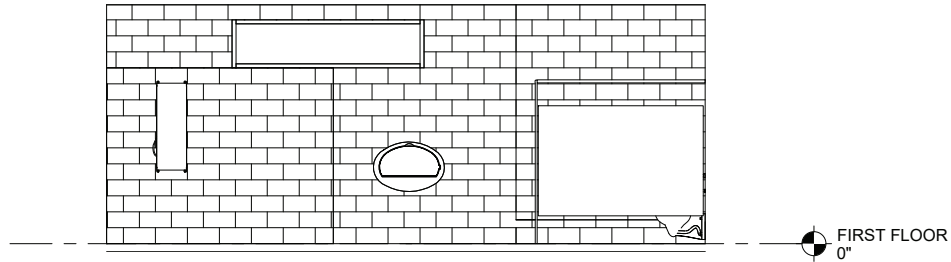


4
A600
Elevation 1 - d
1/4" = 1'-0"

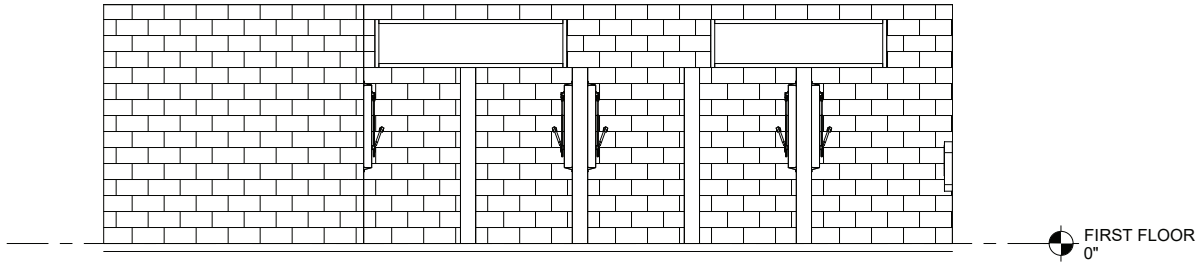


3
A600
Elevation 1 - c
1/4" = 1'-0"

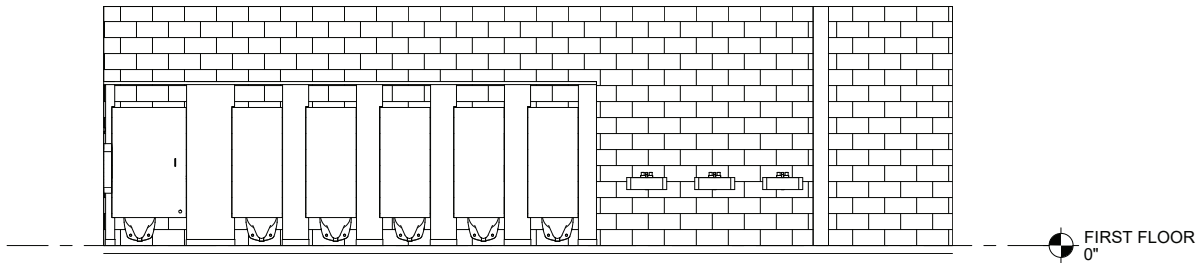

2
A600
Elevation 1 - a
1/4" = 1'-0"

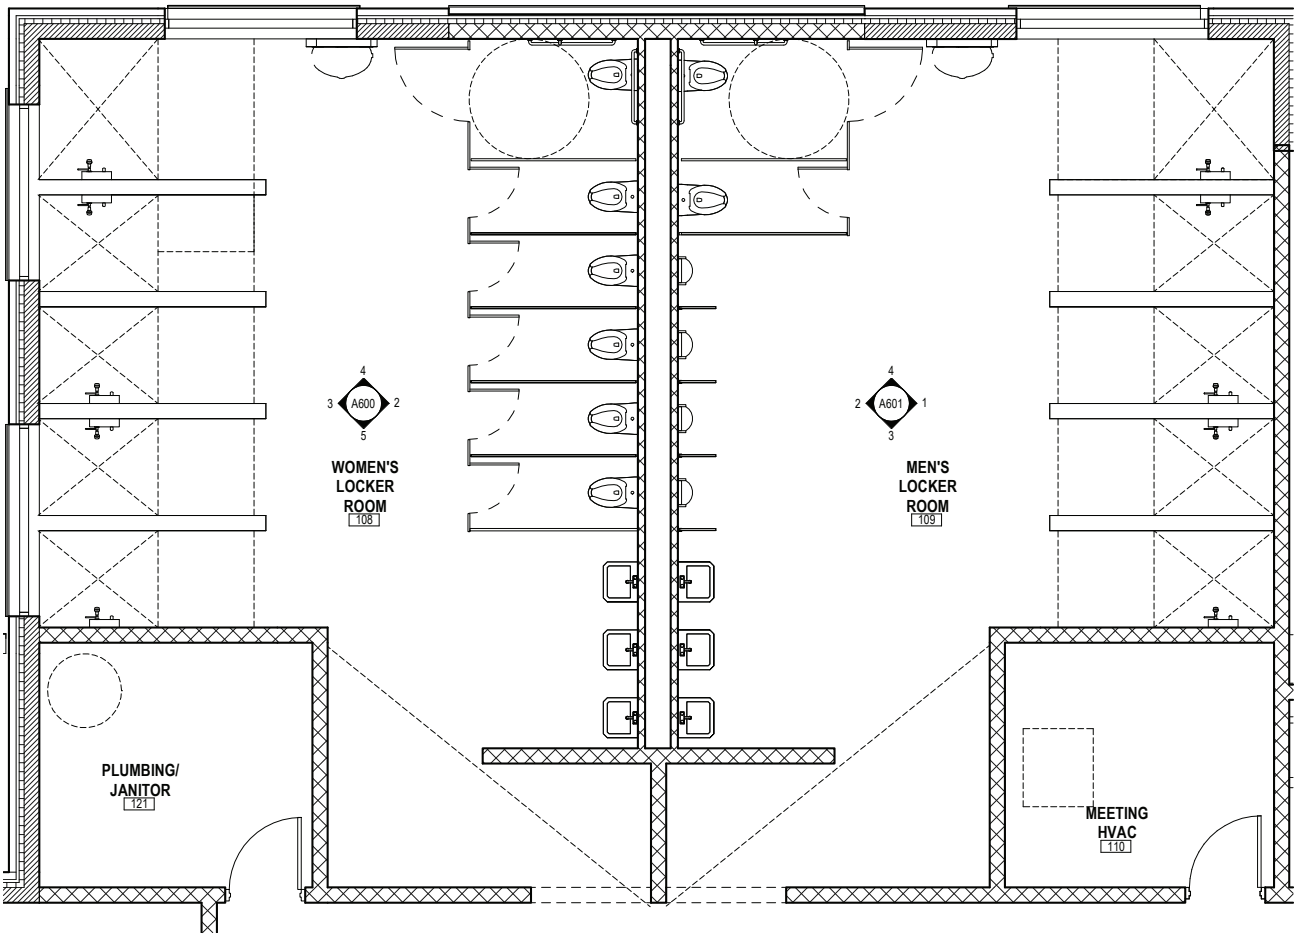


1
A600
Locker Room Plan
1/4" = 1'-0"

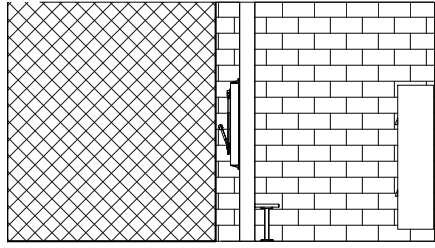

9
A602

Elevation 2 - d


1/4" = 1'-0"

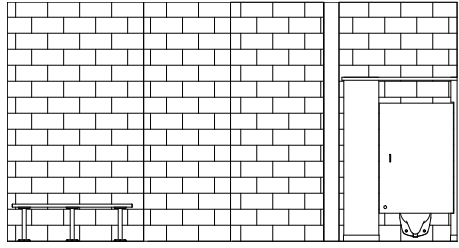

5
A602

1 - d


1/4" = 1'-0"

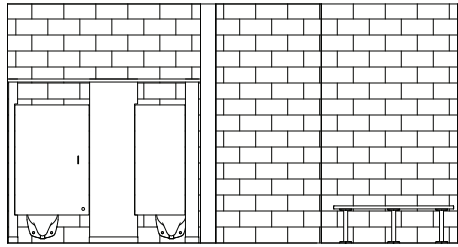

8
A602

1 - c


1/4" = 1'-0"

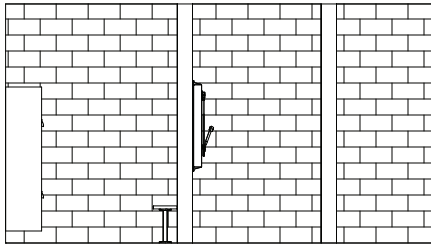

4
A602

Elevation 2 - c


1/4" = 1'-0"

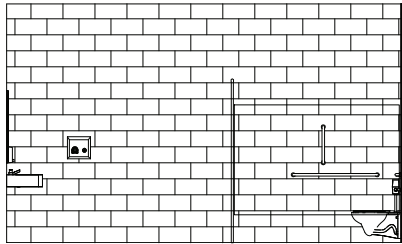

7
A602

Elevation 3 - b


1/4" = 1'-0"

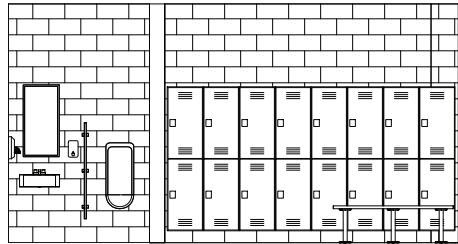

3
A602

Elevation 2 - b


1/4" = 1'-0"

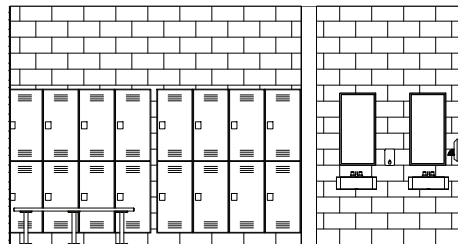

6
A602

Elevation 3 - a


1/4" = 1'-0"

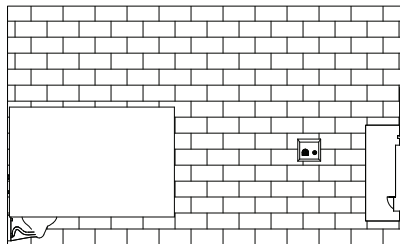

2
A602

Elevation 2 - a

1/4" = 1'-0"

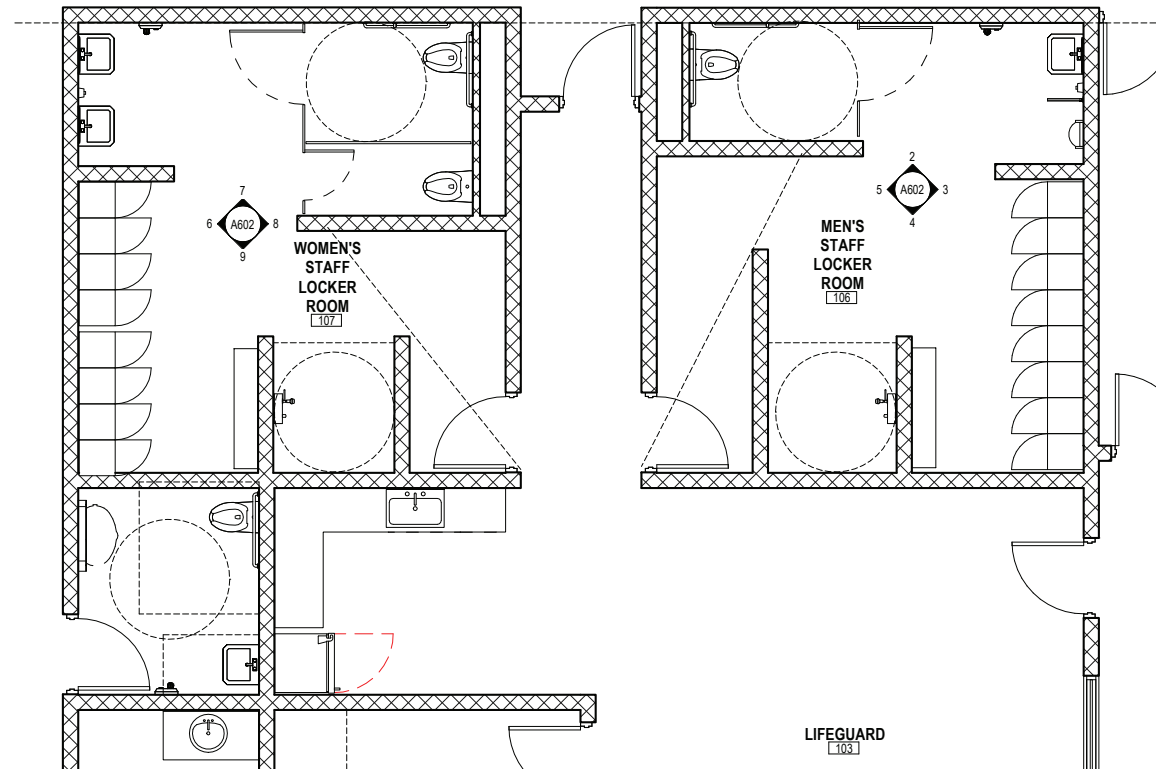

1
A602

STAFF LOCKER ROOMS


1/4" = 1'-0"

10


REVISIONS:		
ISSUE	DESCRIPTION	DATE

Project #: 20.008
Issued For: 30% SET
Date: 9/16/2022


Sheet Number
A602

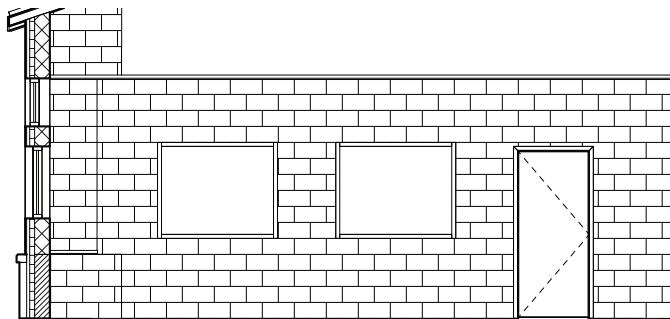


6 CONCESSIONS - WEST WALL
A603 1/4" = 1'-0"

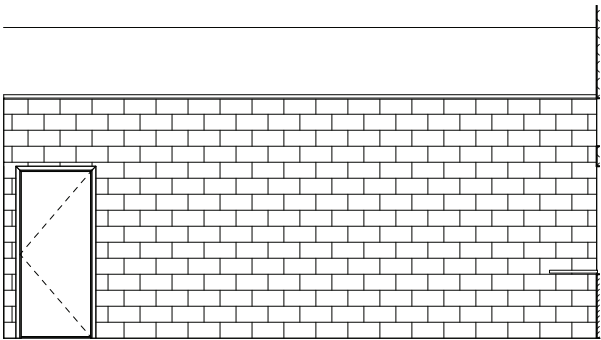


5 CONCESSIONS - NORTH WALL
A603 1/4" = 1'-0"

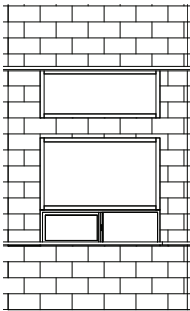

4 CONCESSIONS - EAST WALL
A603 1/4" = 1'-0"

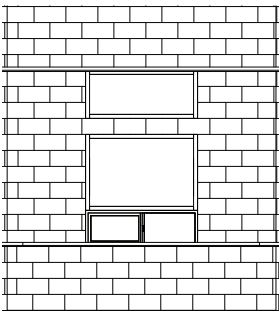


3 CONCESSIONS - SOUTHEAST WALL
A603 1/4" = 1'-0"

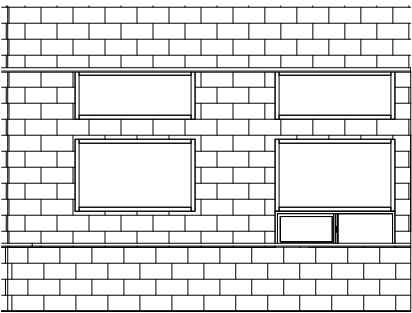

2 CONCESSIONS - SOUTH WALL
A603 1/4" = 1'-0"

EQUIPMENT SCHEDULE						
MARK	DESCRIPTION	MANUFACTURER	MODEL NO.	VOLTS	AMPS	RECEPTACLE
1	FROZEN DRINK DISPENSER	BUNN	ULTRA 2	120	15	5-20R
2	PIZZA WARMING CABINET	WISCO	695-S	120	12	5-15R
3	NACHO CHEESE DISPENSER	GEHL	2.0	110	2.5	5-15R
4	HOT DOG STEAMER	GOLD MEDAL	8552	120	10.2	5-15R
	PROTECTIVE SHIELD	GOLD MEDAL	8572			
5	PIZZA MAKER	WISCO	421	120	12.5	5-20R
6	COUNTERTOP OVEN	TURBO CHEF	I5-9500	208/240	48	6-50R
7	POPCORN MACHINE	GOLD MEDAL	2656	120	8	5-15R
8	COUNTERTOP SOFT SERVE MACHINE	AUREL	CS-162	208/230	2.76KW	L6-30R
9	REACH-IN REFRIGERATOR - 49"	MASTERBILT	MBR49-S	115	7.5	5-20R
10	REACH-IN FREEZER (2 DOOR) - 72"	MASTERBILT	MBF72-S	208/230	9	L14-20R
11	FLAT LID DISPLAY FREEZER	BY VENDOR		115	1.1	5-15R
12	WIRE CUP DISPENSER (5 SLOT)	DISPENSE-RITE	WR-5			
13	30" x 48" STAINLESS STEEL TABLE	ULINE	H-4999			
14	30" x 60" STAINLESS STEEL TABLE	ULINE	H-5000			
15	30" x 60" STAINLESS STEEL TABLE W/CASTERS	ULINE	H-5000 & H-5746			
16	48" x 18" x 86" CHROME WIRE SHELVEING	ULINE	H-2941-86			
17	48" x 24" x 86" CHROME WIRE SHELVEING	ULINE	H-2946-86			
18	GLASS DISPLAY MERCHANDISING REFRIGERATOR	BY VENDOR		115	4.5	5-15R
19	ELECTRIC OVEN & RANGE TOP	BY OWNER		208	7.6	
						14-30R

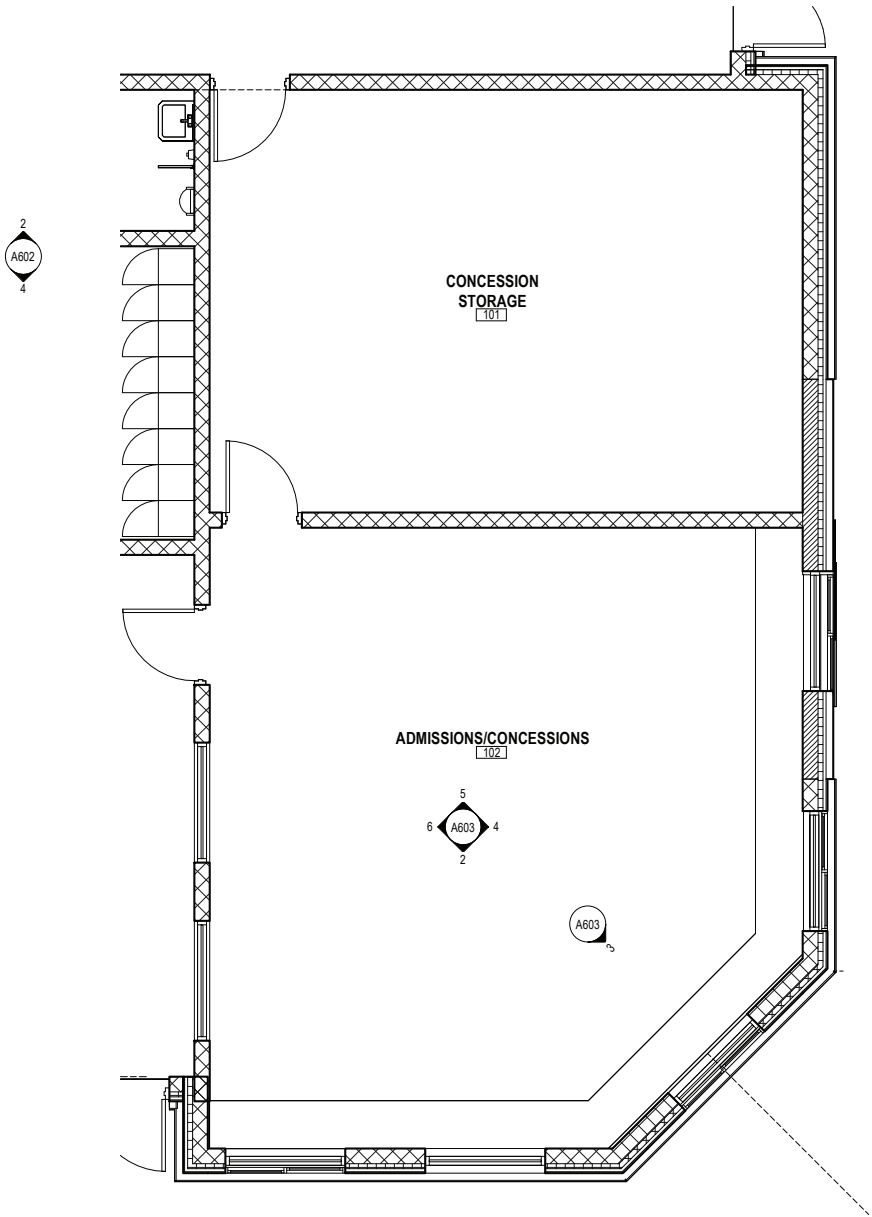


1 CONCESSIONS PLAN
A603 1/4" = 1'-0"

REVISIONS:		
ISSUE	DESCRIPTION	DATE

Project #: 20.008
Issued For: 30% SET
Date: 9/16/2022

Sheet Number
A603

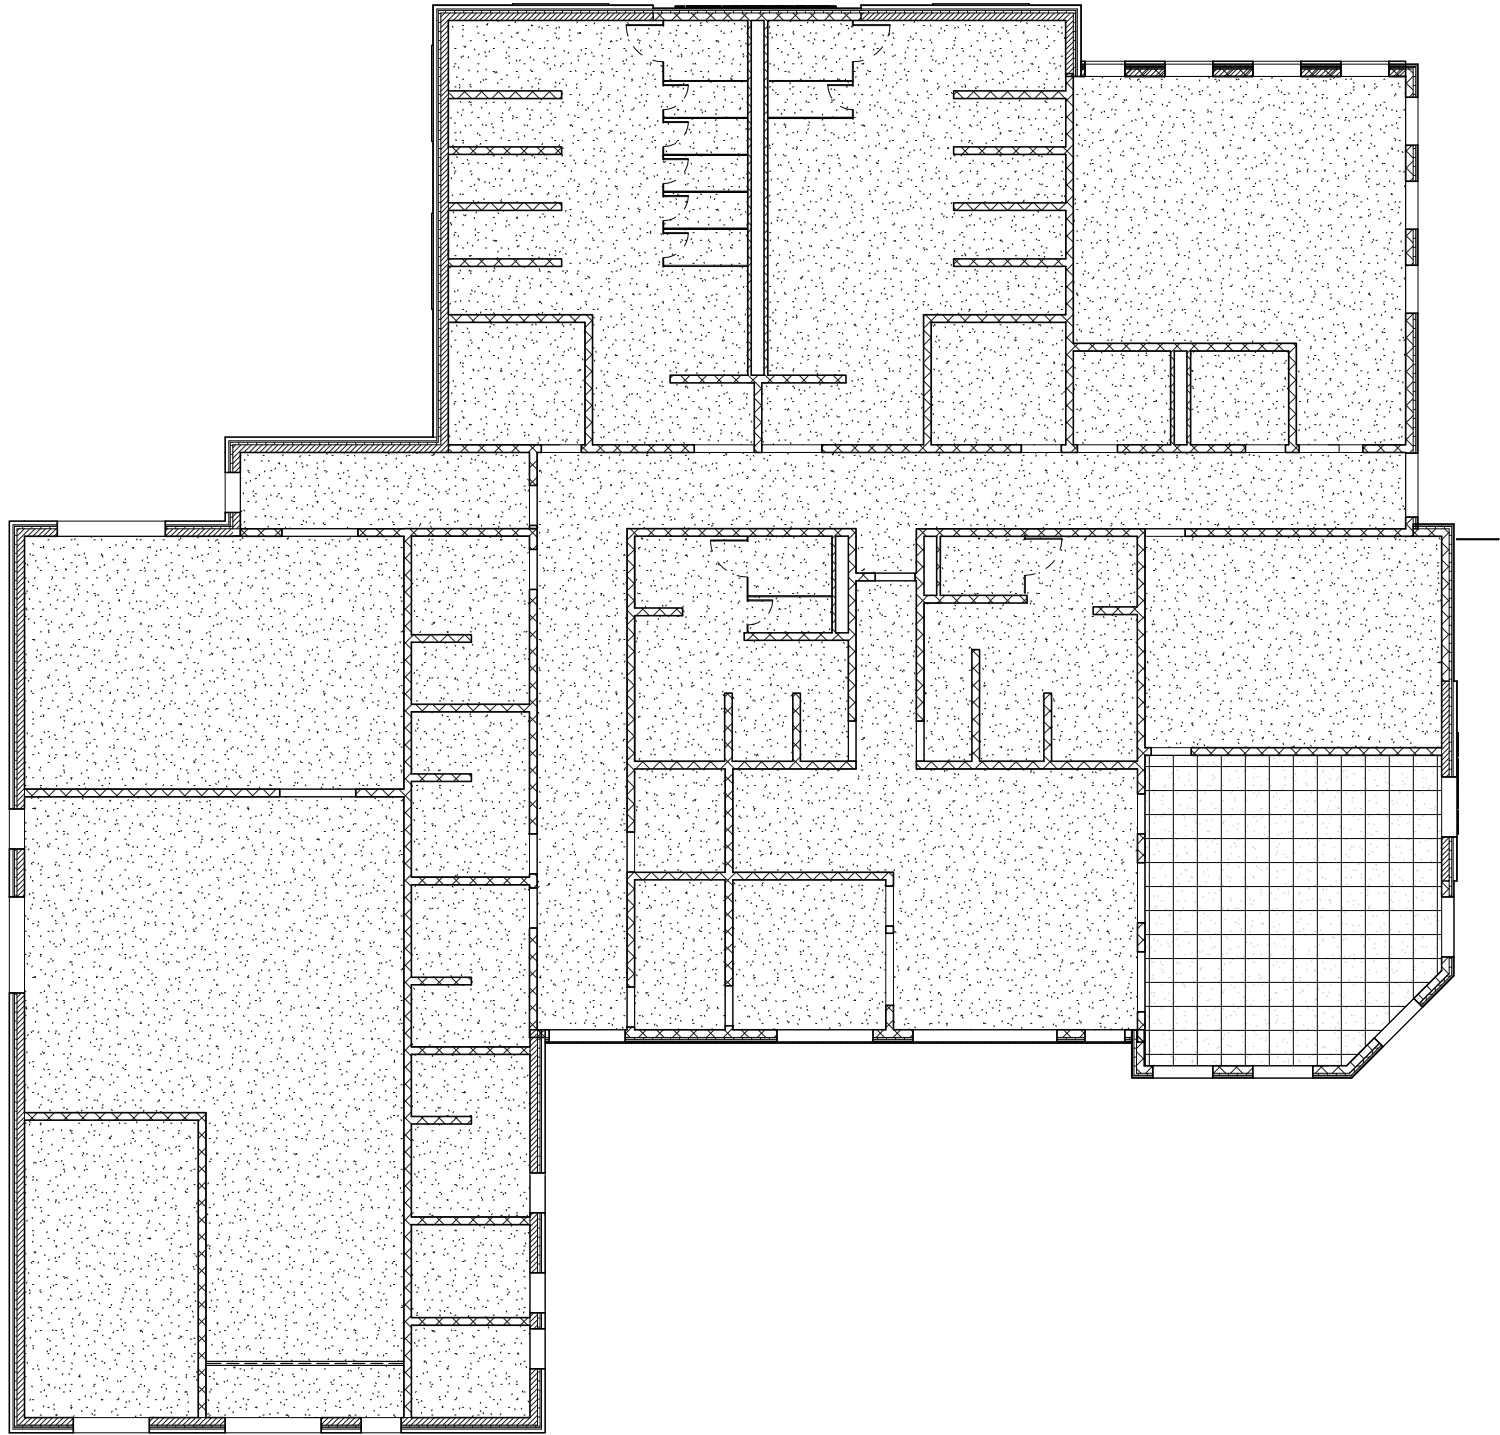

REFLECTED CEILING PLAN LEGEND

(+) X'-X"

GWB-X

CEILING HEIGHT
ABOVE FINISHED
FLOOR TYPE

GWB-1:
5/8" GYP. BOARD (LEVEL 4 FINISH)

WD-1:
3/8" PLYWOOD W/ 1"x2" (NOM.)
BATTENS (PAINTED FINISH - SEE I1.0)

AS-1:
PRE-FINISHED 24 GA. VENTED ALUMINUM
SOFFIT (COLOR TO MATCH ROOF METAL -
SEE A3.10)

WT-1:
1"x3" PAINTED PINE TRIM (SEE I1.1 FOR
COLOR)

WT-2:
1"x2" PAINTED PINE TRIM (MATCH WD-1
FOR COLOR)

SURFACE MOUNTED LINEAR
LIGHT

RECESSED DOWNLIGHT

CEILING DIFFUSER

FIRE ALARM DEVICE

NOTE:
REFER TO ELECTRICAL AND MECHANICAL PLANS FOR CEILING
MOUNTED DEVICES AND AIR TERMINALS



REVISIONS:		
ISSUE	DESCRIPTION	DATE

Project #: 20.008
Issued For: 30% SET
Date: 9/16/2022

WALL FINISH		
CODE P1(*)	PAINT SHERWIN WILLIAMS COLOR: NATURAL TAN SHADE SW7567 FINISH: SEMI GLOSS	REMARKS: ADMISSIONS, OFFICE, CONCESSIONS, MEN'S WOMEN'S RESTROOMS, FAMILY ROOM 104
CODE P2(*)	PAINT SHERWIN WILLIAMS COLOR: SANDBAR SW7547 FINISH: SATIN	REMARKS: WARMING ROOM, RESTROOM 108
CODE P3(*)	PAINT SHERWIN WILLIAMS COLOR: CEILING WHITE FINISH: SATIN	REMARKS: GYPBOARD CEILINGS
CODE P4	PAINT SHERWIN WILLIAMS COLOR: RESORT TAN SW7550 FINISH: SEMI GLOSS	REMARKS: HOLLOW METAL DOORS & FRAMES
CODE P5	PAINT SHERWIN WILLIAMS COLOR: PURE WHITE SW 7005 FINISH: SATIN	REMARKS: STORAGE, MECHANICAL

(*) DENOTES EPOXY PAINT - WHERE INDICATED ON PLAN


WOOD TRIM		
CODE WT-1	DESCRIPTION 1x3 PINE TRIM PAINT: MATCH WALL PAINTING SYSTEM COLOR: MATCH WALL COLOR FINISH: SATIN	REMARKS: ALL FINISHED BLOCK WALL TO EXPOSED GYPBOARD CEILINGS - SEE DETAIL 6/11.1 SEE A8.1 - "REFLECTED CEILING PLAN" FOR LOCATIONS OF WOOD CEILING TRIM
CODE WT-2	DESCRIPTION 1x2 PINE BATTENS PAINT: MATCH CEILING PAINTING SYSTEM COLOR: MATCH CEILING COLOR FINISH: SATIN	REMARKS: COVERED SHELTER AREA
CODE WT-3	DESCRIPTION 1x OAK BOARDS & TRIM STAIN: OLYMPIC SEMI-TRANSPARENT INTERIOR STAIN COLOR: HICKORY FINISH: 2 COATS POLYURETHANE - SEMI GLOSS	REMARKS: WINDOW SILL & APRON TRIM

WALL BASE		
CODE B1	DESCRIPTION COVE WALL BASE DAL TILE QUARRY TEXTURE WALL BASE SIZE: 6" COLOR: ARID GRAY	REMARKS: RESTROOMS ONLY
CODE B2	DESCRIPTION VINYL WALL BASE JOHNSONITE TRADITIONAL WALL BASE SIZE: 4" COLOR: 47 BROWN	REMARKS: TYPICAL

PLASTIC LAMINATES		
CODE PL-1	DESCRIPTION PLASTIC LAMINATE WILSONART STYLE: WHITE COLOR: 1570	REMARKS: ADMISSIONS & CONCESSIONS COUNTER TOPS
CODE PL-2	DESCRIPTION PLASTIC LAMINATE WILSONART STYLE: LANDMARK WOOD COLOR: 7981K-12	REMARKS: ADMISSIONS & CONCESSIONS BASE SHELVING

FLOORING		
CODE SC	DESCRIPTION SEALED CONCRETE SONNEBORNE: KURE-N-SEAL (2) COATS	REMARKS: 1ST COAT BY CONCRETE CONTRACTOR 2ND COAT BY GC - COORDINATE INITIAL PRODUCT INSTALLED

BASE AND WALL COLORS ARE PROVIDED FOR BIDDING PURPOSES. FINAL SELECTION TO BE MADE BY ARCHITECT AND OWNER DURING CONSTRUCTION

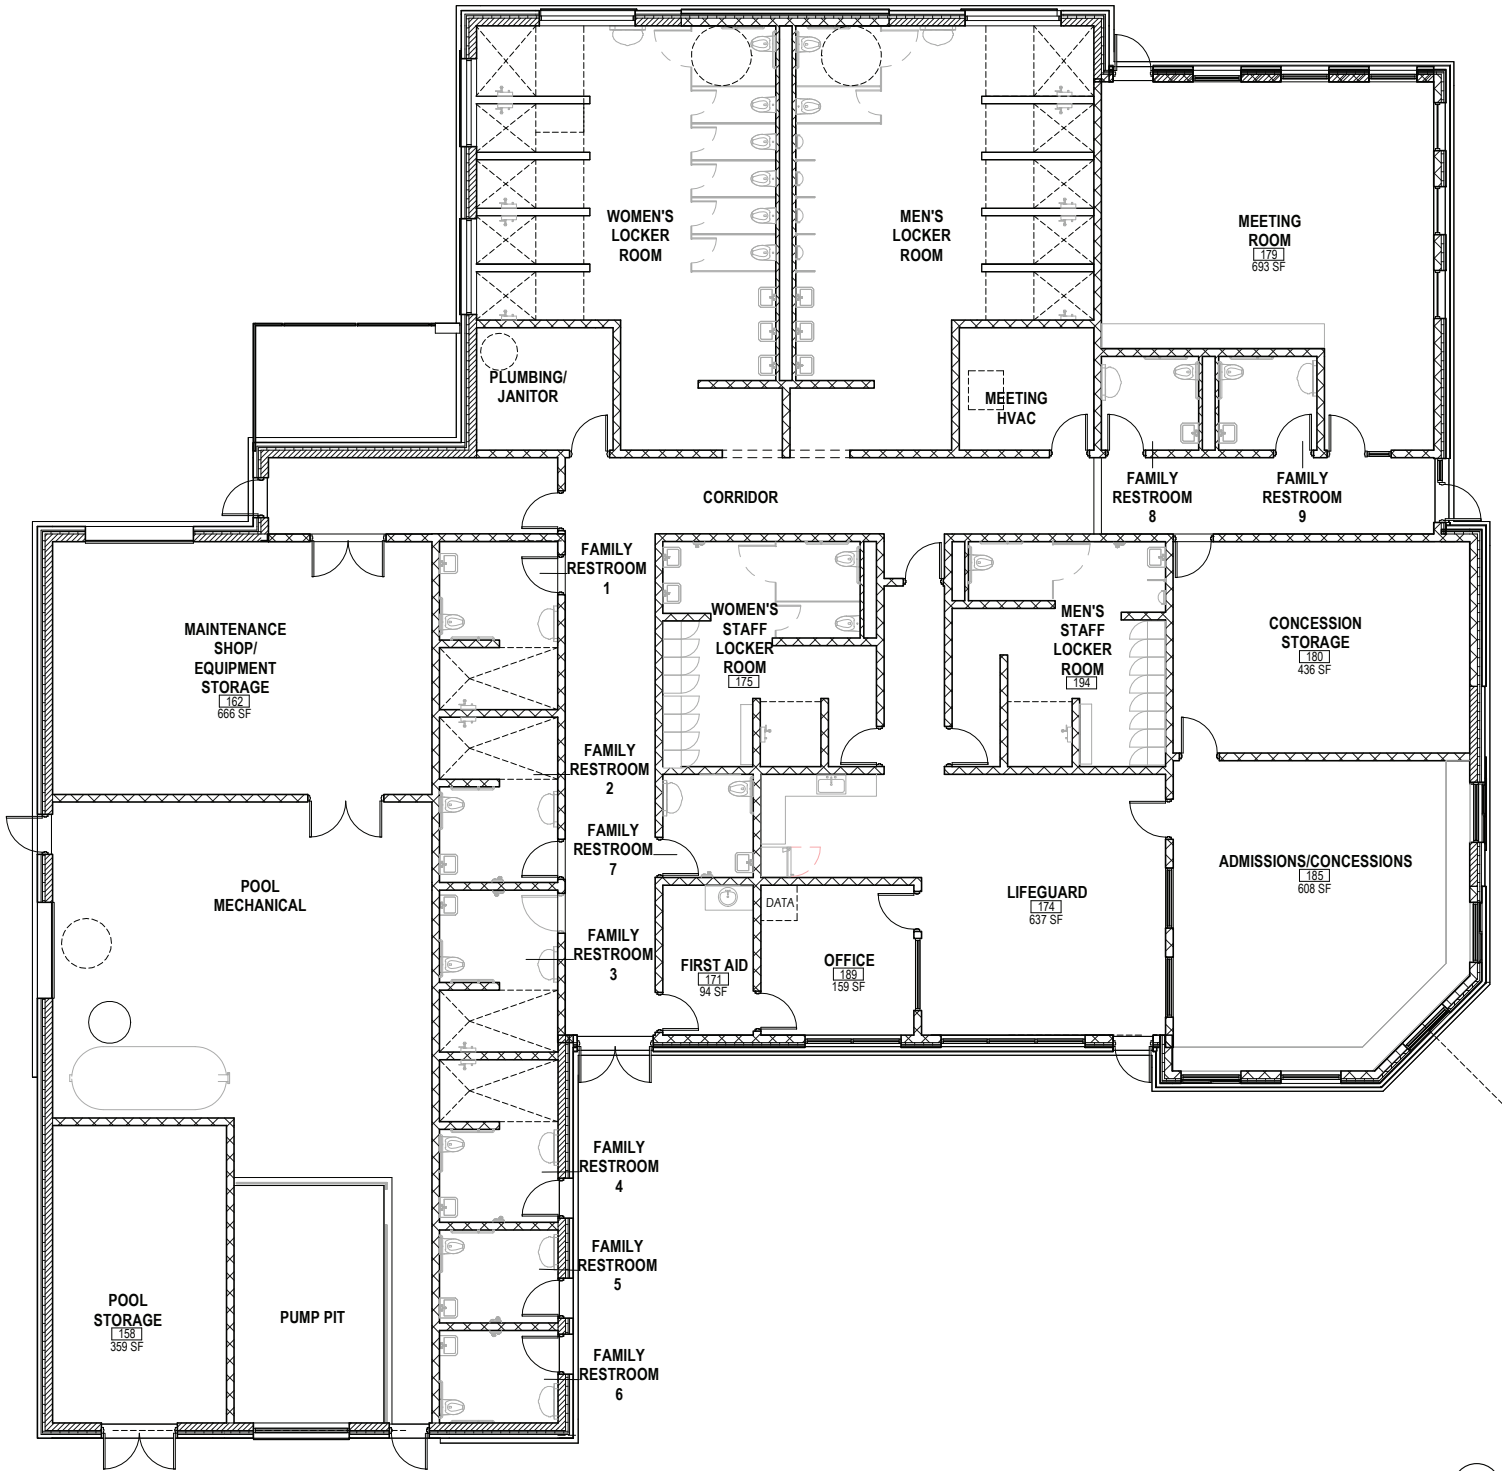

INTERIOR WINDOW SILLS & APRONS			
ROOM	SILL	APRON	FINISH
100	1x4 MAPLE	1x4 MAPLE	MATCH "WT-3"
101	1x4 MAPLE	1x4 MAPLE	MATCH "WT-3"
107	1x6 MAPLE	1x4 MAPLE	MATCH "WT-3"
NOTES: 1. ROOMS NOT SHOWN IN SCHEDULE DO NOT RECIEVE WINDOW SILL OR APRON TRIM.			


INTERIOR PAINTING SYSTEMS	
BASED ON DIAMOND VOGEL PRODUCT LINES, ALTERNATE MANUFACTURERS ACCEPTED WITH ARCHITECT'S APPROVAL	
BLOCK /CONCRETE WALLS (TYPICAL) PRIMER: 16 MIL WET; DIAPRO BLOCK FILLER 1ST COAT: 4 MIL; VANTAGE PLUS LATEX 2ND COAT: 4 MIL; VANTAGE PLUS LATEX	
BLOCK WALLS (EPOXY) PRIMER: 16 MIL WET; VERS-E-POXY 100 BLOCK FILLER 1ST COAT: 4 MIL WET; EAS-E-POXY 2ND COAT: 4 MIL WET; EAS-E-POXY	
GYPSUM BOARD (TYPICAL) PRIMER: 4 MIL; DIAMOND PRIME UNIVERSAL ACRYLIC PRIMER: 1ST COAT: 6-8 MIL WET; VANTAGE PLUS LATEX 2ND COAT: 6-8 MIL WET; VANTAGE PLUS LATEX	
GYPSUM BOARD (EPOXY) PRIMER: 16 DIAMOND PRIME UNIVERSAL ACRYLIC PRIMER 1ST COAT: 4 MIL; EAS-E-POXY 2ND COAT: 4 MIL; EAS-E-POXY	
FERROUS METALS PRIMER: 4 MIL; DIAMOND PRIME UNIVERSAL ACRYLIC PRIMER: 1ST COAT: 6-8 MIL WET; VANTAGE PLUS LATEX 2ND COAT: 6-8 MIL WET; VANTAGE PLUS LATEX	
WOOD TRIM PRIMER: 4 MIL; DIAMOND PRIME UNIVERSAL ACRYLIC PRIMER: 1ST COAT: 6-8 MIL WET; VANTAGE PLUS LATEX 2ND COAT: 6-8 MIL WET; VANTAGE PLUS LATEX	

INTERIOR FINISH TAG KEY

- C-# ← CEILING FINISH
W-# ← WALL FINISH
B-# ← WALL BASE
F-# ← FLOORING




REVISIONS:	ISSUE	DESCRIPTION	DATE
------------	-------	-------------	------

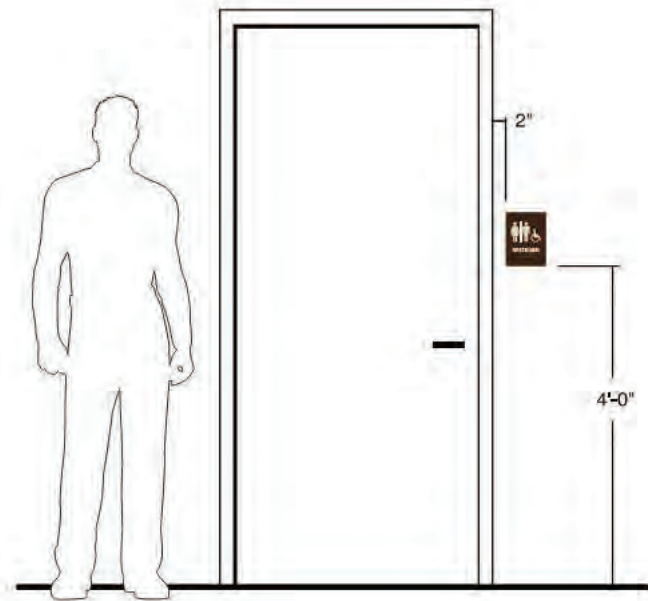


ELEVATION - TYPICAL
SCALE: 1/2"=1'

STANDARD WALL MOUNTING ELEVATION

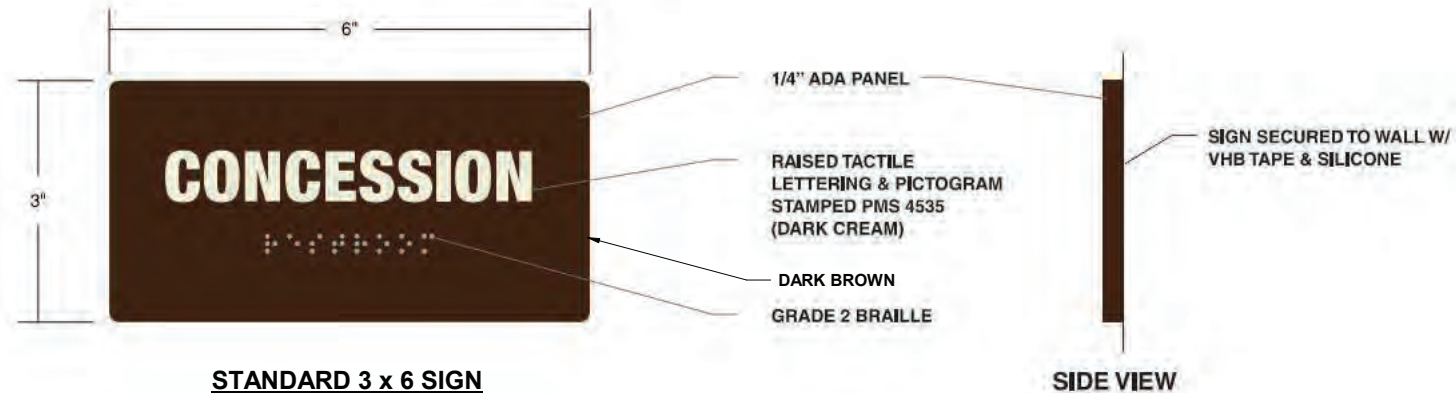

STANDARD 3 x 6 SIGN

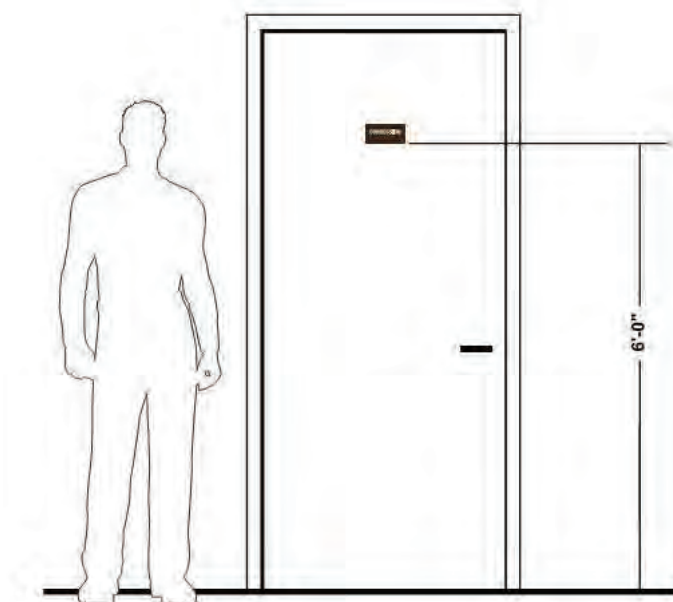


ELEVATION - TYPICAL
SCALE: 1/2"=1'

STANDARD DOOR MOUNTING ELEVATION




STANDARD 6 x 8 SIGN

INTERIOR DOOR SIGNAGE							
DOOR	LABEL	MOUNTING LOCATION	SIZE	SIGNAGE SYMBOLS			
				M	F	M/F	HANDICAP
100	ADMISSIONS	WALL	3x6				
101	OFFICE	WALL	3x6				
103	CONCESSION STORAGE	WALL	3x6				
104	RESTROOM	DOOR	6x8			X	X
105	WOMENS RESTROOM	DOOR	6x8		X		X
106	MENS RESTROOM	DOOR	6x8	X			X
107A	WARMING ROOM	DOOR	3x6				
107B	WARMING ROOM	DOOR	3x6				
110	RESTROOM	WALL	6x8			X	X

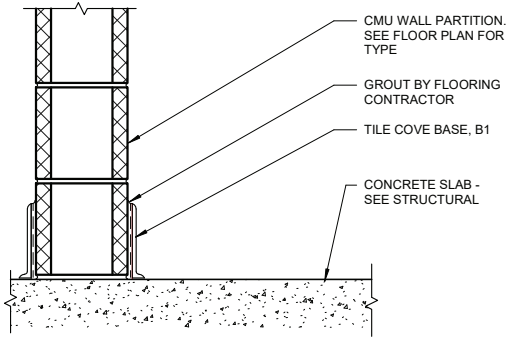


4
1200
1 1/2" = 1'-0"

TILE FLOOR AND WALL BASE

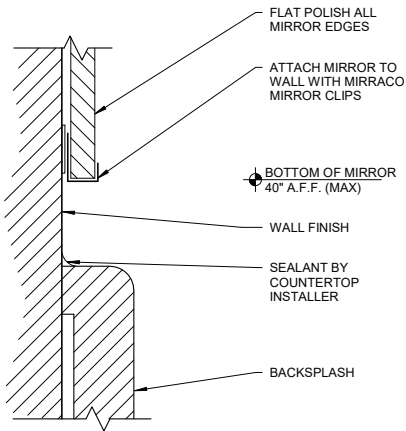


5
1200
12" = 1'-0"

MIRROR ABOVE BACKSPLASH

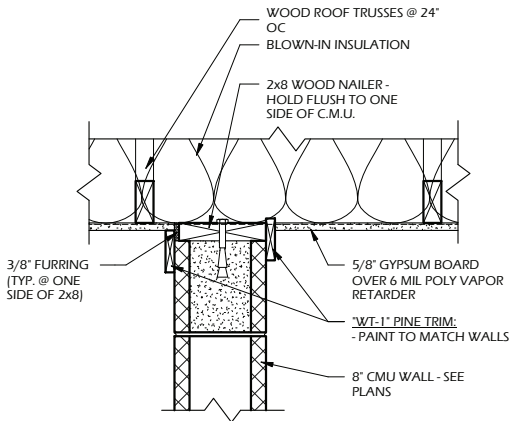


6
1200
1 1/2" = 1'-0"

CEILING TRIM DETAIL

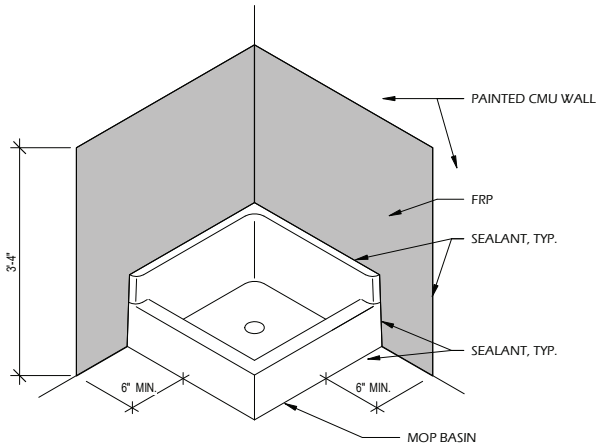

3
1200
3/4" = 1'-0"

MOP BASIN ISOMETRIC VIEW

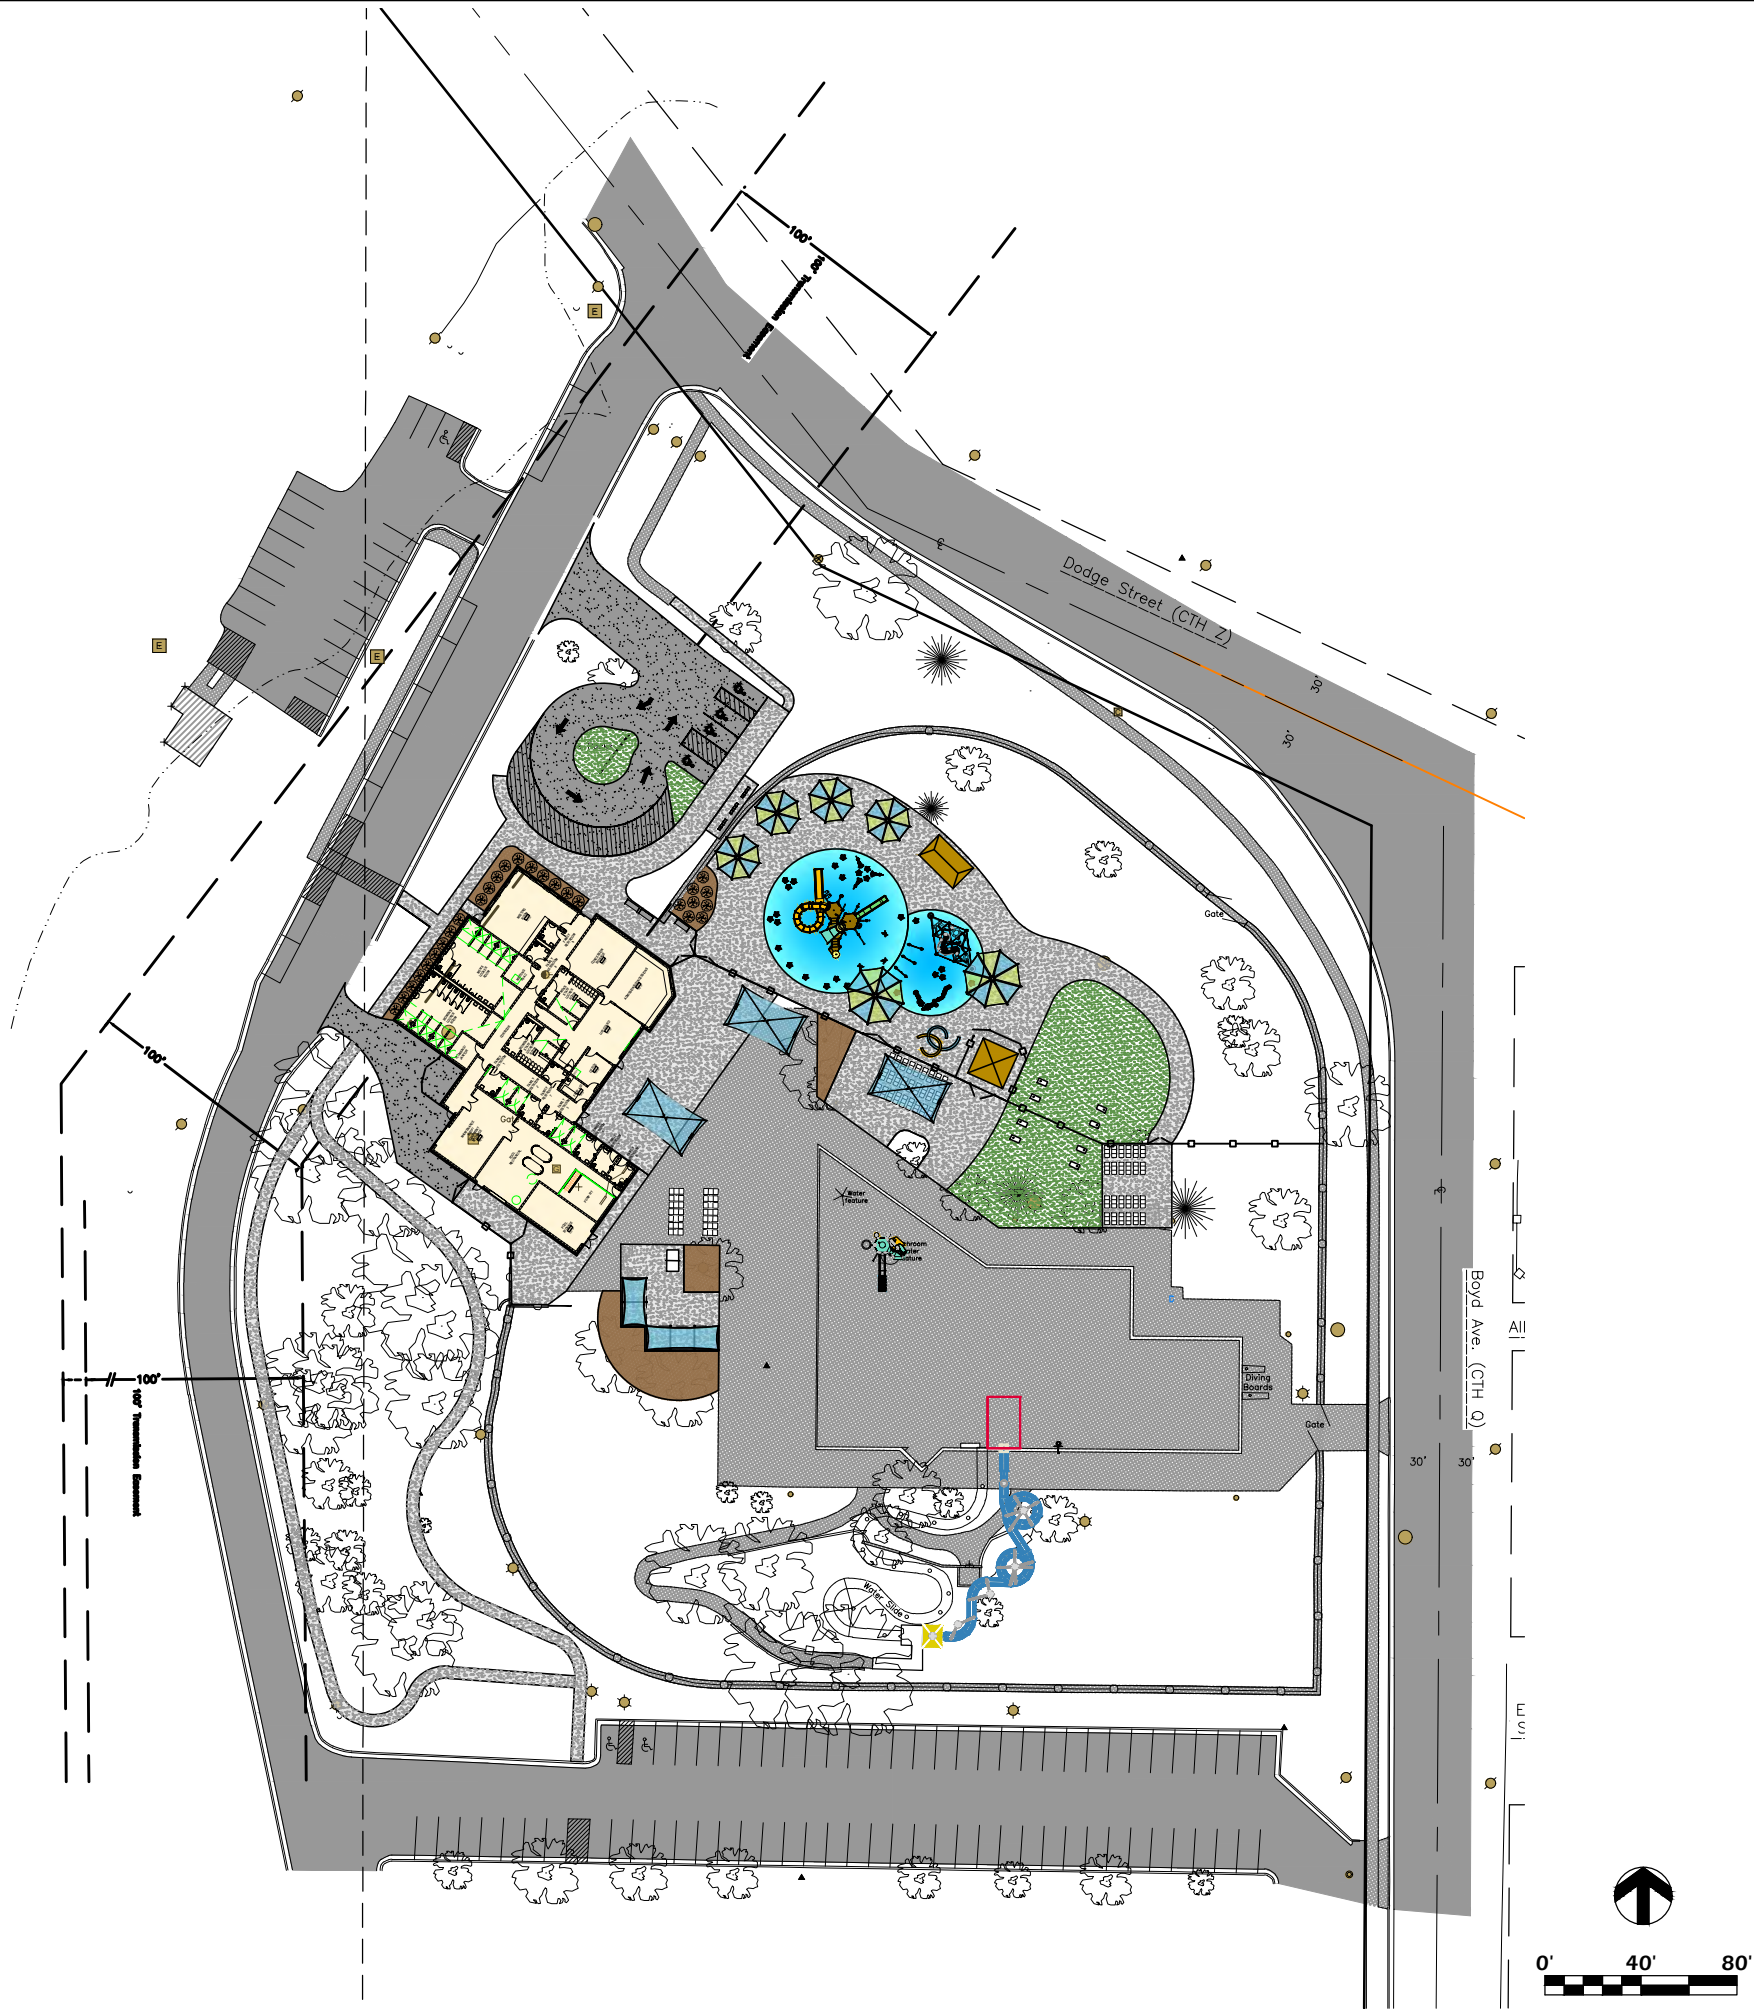

SITE LAYOUT NOTES

1. CONTACT DIGGER'S HOTLINE 5 WORKING DAYS PRIOR TO THE START OF CONSTRUCTION.
2. ALL PROPOSED DIMENSIONS ARE REFERENCED PARALLEL OR PERPENDICULAR TO THE PROPOSED FEATURES SHOWN. WRITTEN DIMENSIONS SUPERSEDE ANY SCALED DIMENSIONS.
3. PROPOSED GRADE AND LEVEL SHALL BE PERIODICALLY REVIEWED IN THE FIELD BY THE OWNER OR A/E.
4. CONCRETE JOINTING IS SHOWN FOR DESIGN INTENT. FINAL SCORING PLANS SHALL BE SUBMITTED TO THE A/E FOR REVIEW AS A SHOP SUBMITTAL.
5. CONTRACTOR TO IMPORT SOIL AS NEEDED TO PREPARE TURF AREAS. CONTRACTOR TO FINE GRADE ALL AREAS TO FINISH GRADE.
6. ANY EXISTING STRUCTURES AND/OR UTILITIES NOT SHOWN ON THESE DOCUMENTS WHICH NEED TO BE REMOVED, RELOCATED, AND OR ADJUSTED SHALL BE THE RESPONSIBILITY OF THE SITE CONTRACTOR AND INCLUDED IN THE BASE BID.
7. CONTRACTOR SHALL BE RESPONSIBLE FOR SITE STAKING. DIGITAL PLAN FILES MAY BE AVAILABLE FROM THE A/E.

LANDSCAPE AND RESTORATION NOTES

1. CONTRACTOR SHALL MEET EXISTING GRADE AT GRADING LIMITS WITH A SMOOTH AND CONTINUOUS TRANSITION.
2. SEED/SOIL PLACEMENT SHALL EXTEND TO THE LIMITS OF CONSTRUCTION DISTURBANCE.
3. ALL GENERAL LANDSCAPE AREAS DISTURBED DURING CONSTRUCTION SHALL BE RESTORED WITH 4" MINIMUM TOPSOIL DEPTH AND SEEDED IN ACCORDANCE WITH THE SPECIFICATIONS. THIS SHALL INCLUDE ANY AREAS OUTSIDE OF THE PROJECT LIMITS THAT ARE DISTURBED BY CONTRACTOR ACTIVITY. WATERING SHALL BE BY CITY.

Project Name: **KAUKAUNA POOL RENOVATION**

607 Dodge Street
Kaukauna, WI 54130

Sheet Title:

SITE LAYOUT PLAN OVERVIEW

Revisions:

Project #: 21.039
Issued For: Review
Date: 4/7/2022

Sheet Number


C200

ONE DESIGN & ENGINEERING
Est. 2020

302 Ash St. Cambridge, WI 53023 • 608.577.0113 • www.onedesign.com

PARKITECTURE + PLANNING
901 Deming Way, Suite 102
Madison, WI 53717
608.886.6808

File: V:\21.039 Kaukauna Pool CAD\P-SF.dwg Layout: C210 User: Blake Plotted: Sep 13, 2022 -- 10:54pm

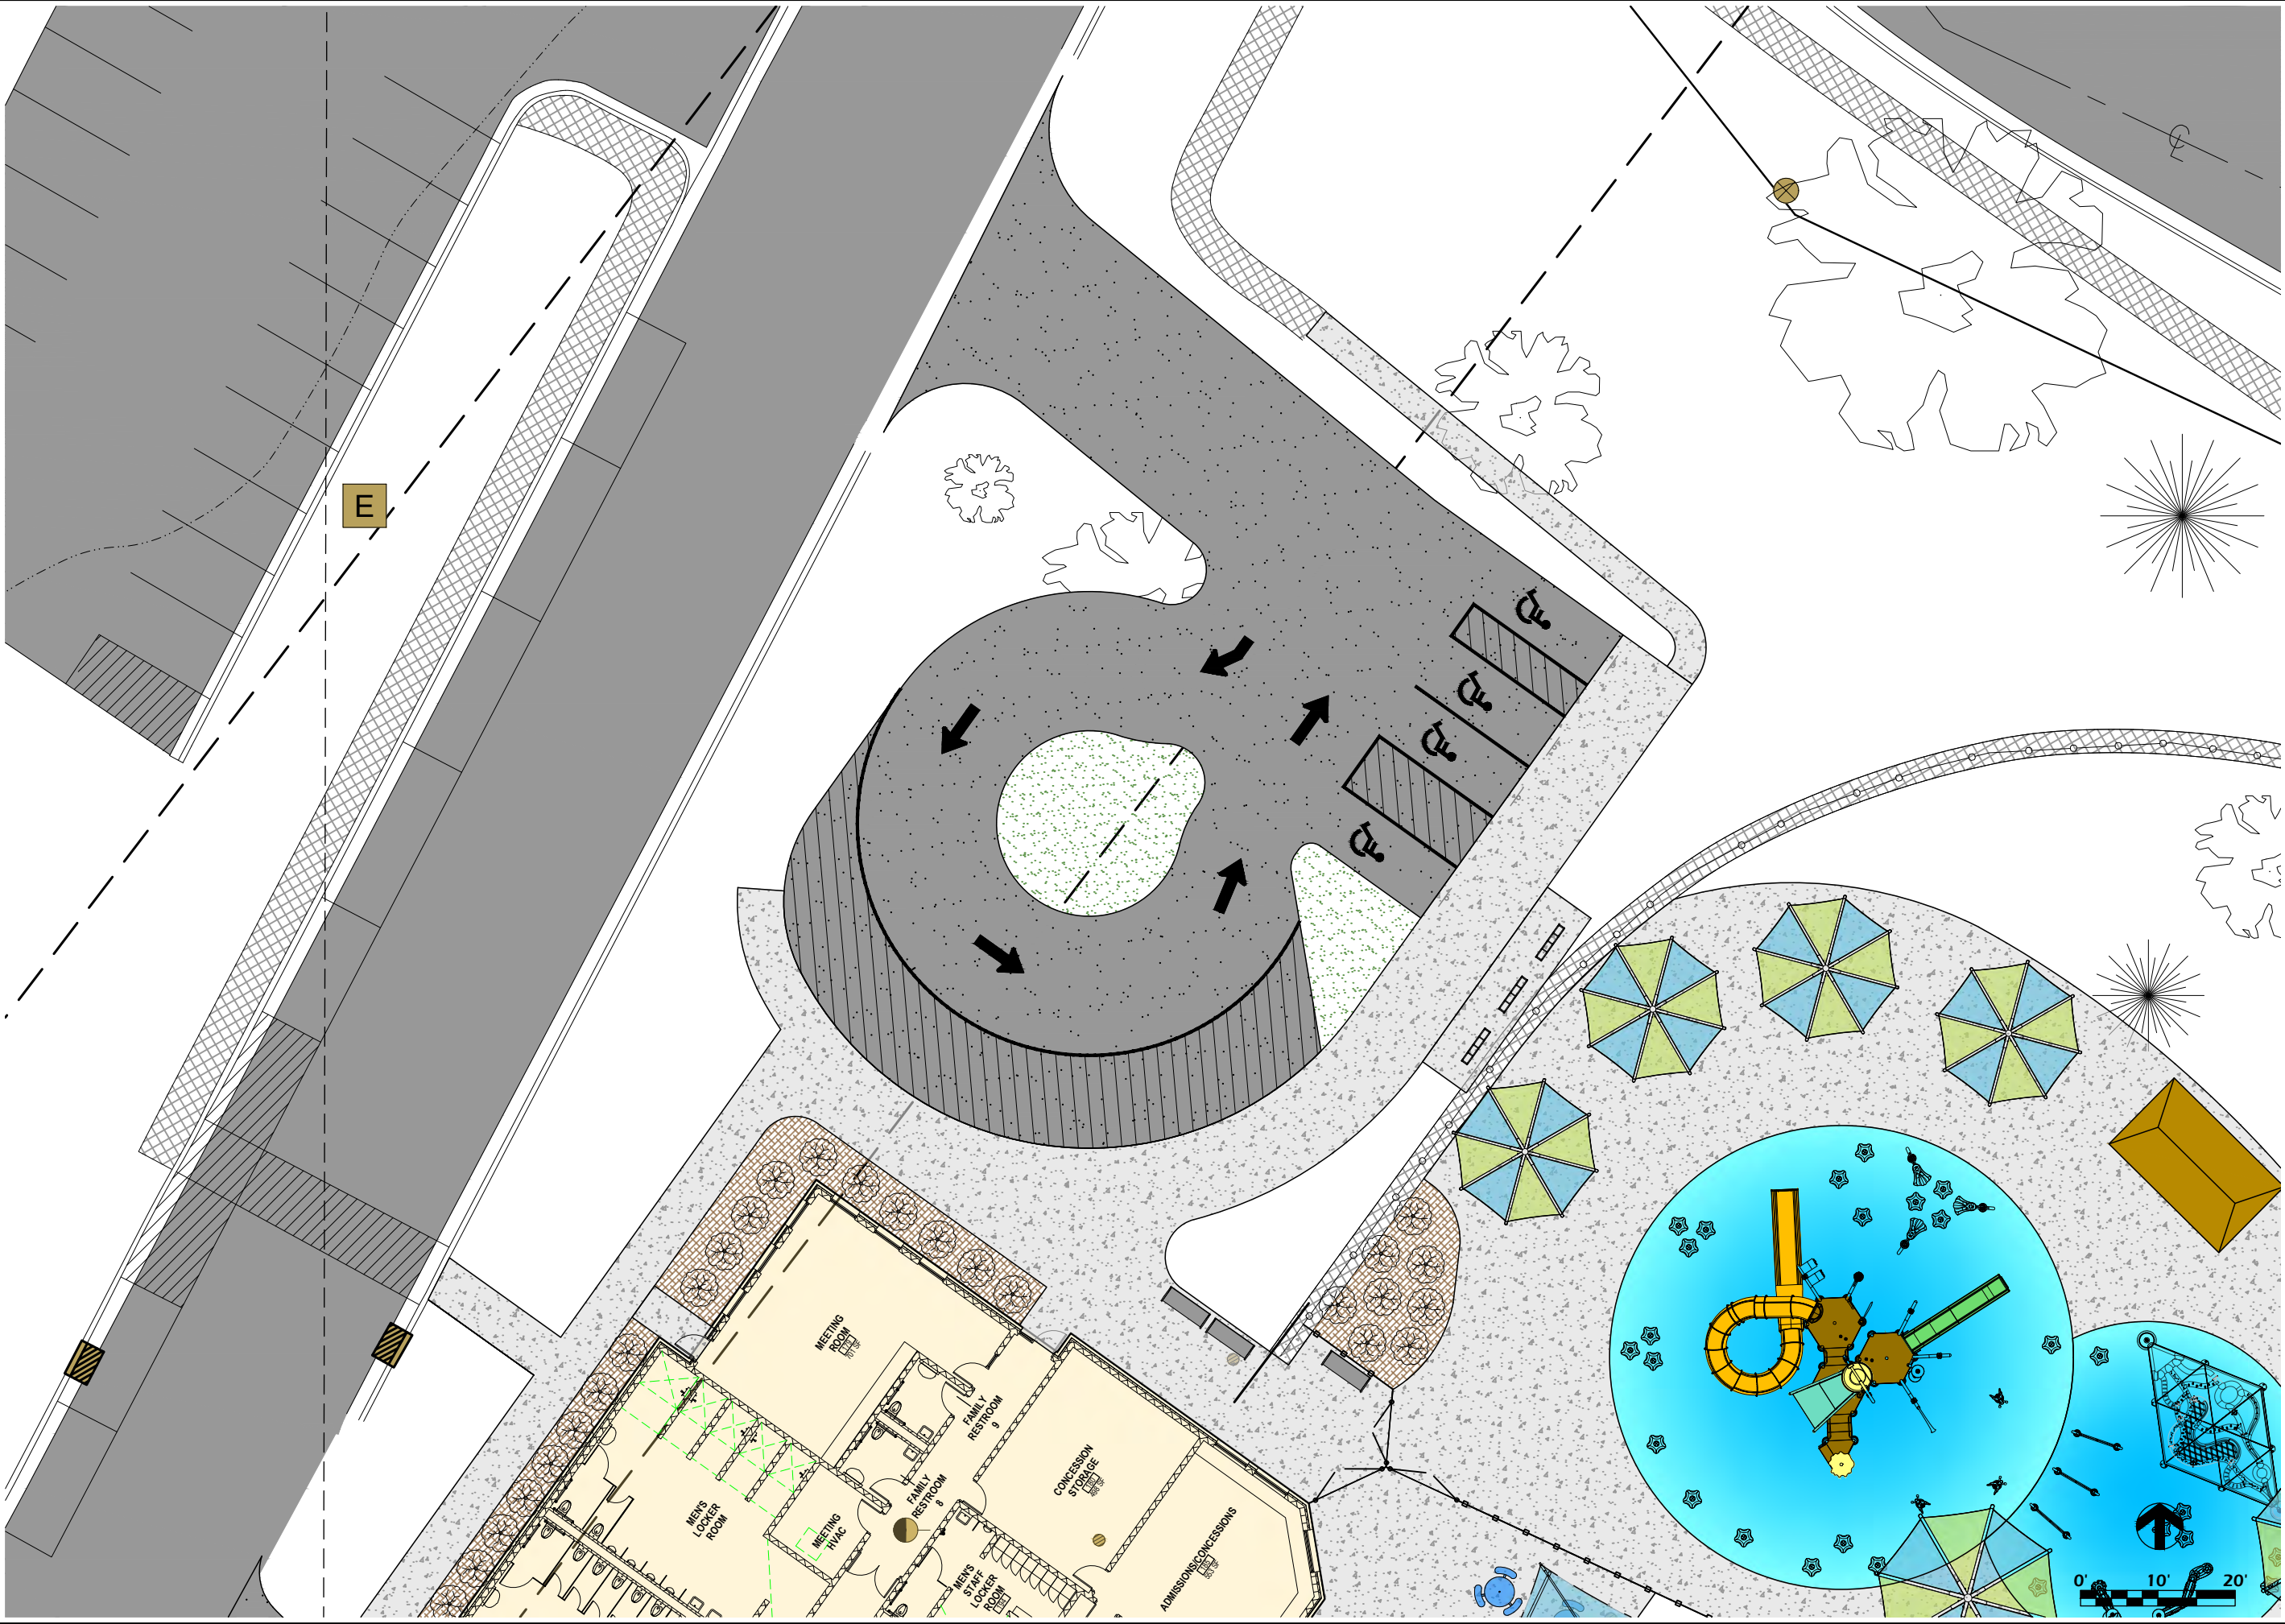

Project Name: KAUKAUNA POOL RENOVATION 607 Dodge Street Kaukauna, WI 54130		Project #: 21.039	
Revisions:		Issued For: Review	
Date:		Date: 4/7/2022	
Sheet Title: SITE LAYOUT PLAN		Sheet Number: C210	
ONE DESIGN & ENGINEERING Est. 2020 306 Ash St. Cambridge, WI 53623 • 800.377.0113 • www.oneandco.com		PARKITECTURE + PLANNING 901 Deming Way, Suite 102 Madison, WI 53717 608.886.6808 Parkitecture	

File: V:\21.039 Kaukauna Pool CAD\P-SF.dwg Layout: C211 User: Blake Plotted: Sep 13, 2022 -- 10:55pm



Project Name: KAUKAUNA POOL RENOVATION 607 Dodge Street Kaukauna, WI 54130		Sheet Title: SITE LAYOUT PLAN
Revisions:		
Project #: Issued For: Date:		21.039 Review 4/7/2022
Sheet Number		C211

ONE DESIGN & ENGINEERING
Est. 2020

304 Ash St. Cambridge, WI 53623 • 800.377.0143 • www.onedesign.com

PARKITECTURE + PLANNING

901 Deming Way, Suite 102
Madison, WI 53717
608.886.6808

File: V:\21.039 Kaukauna Pool CDs\CAD\P-SF.dwg Layout: C212 User: Blake Plotted: Sep 13, 2022 -- 10:56pm




Project Name: KAUKAUNA POOL RENOVATION 607 Dodge Street Kaukauna, WI 54130	
Sheet Title: SITE LAYOUT PLAN	
Revisions:	
Project #: Issued For: Date:	21.039 Review 4/7/2022
Sheet Number C212	

ONE DESIGN & ENGINEERING
Est. 2020
306 Ash St. Cambridge, WI 53628 • 800.377.0143 • www.onedn.com

PARKITECTURE + PLANNING
901 Deming Way, Suite 102
Madison, WI 53717
608.886.6808

File: V:\21.039 Kaukauna Pool CDs\CAD\P-SF.dwg Layout: C213 User: Blake Plotted: Sep 13, 2022 -- 10:57pm

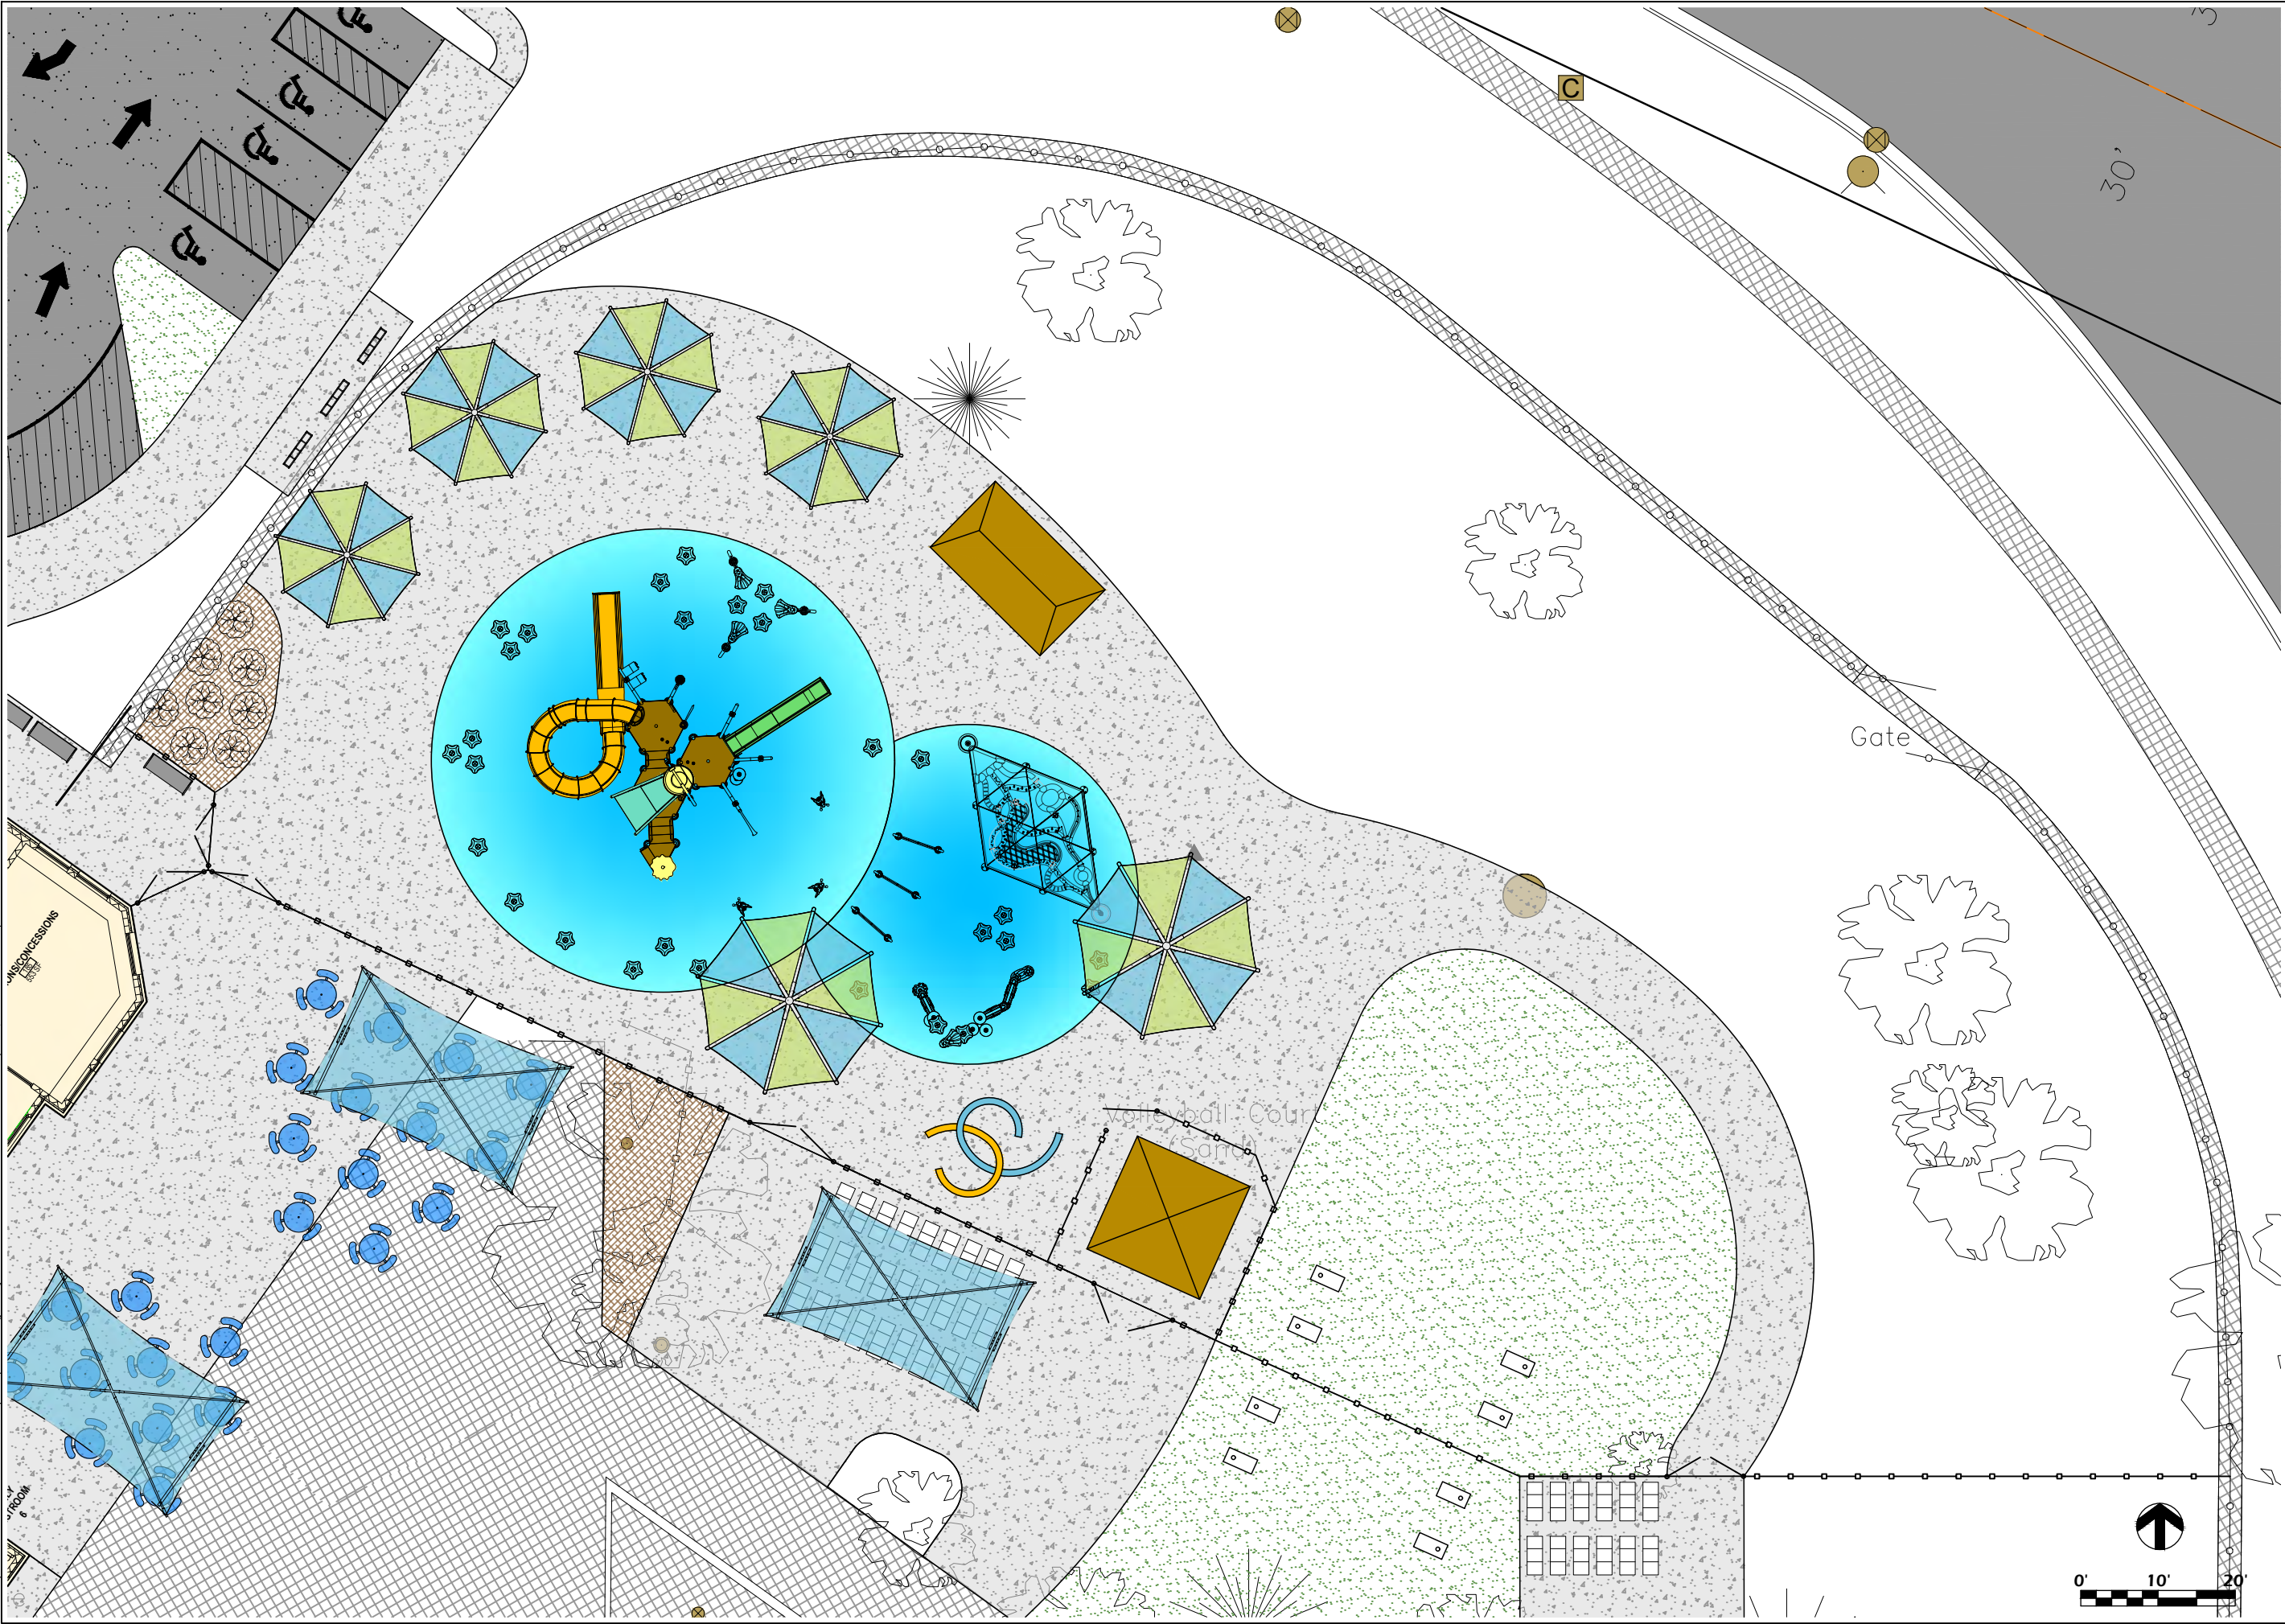


Project Name: KAUKAUNA POOL RENOVATION 607 Dodge Street Kaukauna, WI 54130		Sheet Title: SITE LAYOUT PLAN
Revisions:		
Project #: Issued For: Date:	21.039 Review 4/7/2022	
Sheet Number C213		

ONE DESIGN & ENGINEERING Est. 2020	306 Ash St. Cambridge, WI 53628 • 800.377.0143 • www.onednre.com
--	--

PARKITECTURE + PLANNING	901 Deming Way, Suite 102 Madison, WI 53717 608.886.6808
--------------------------------	--

File: V:\21.039 Kaukauna Pool CDs\CAD\ P-SF.dwg Layout: C215 User: Blake Plotted: Sep 13, 2022 -- 10:59pm

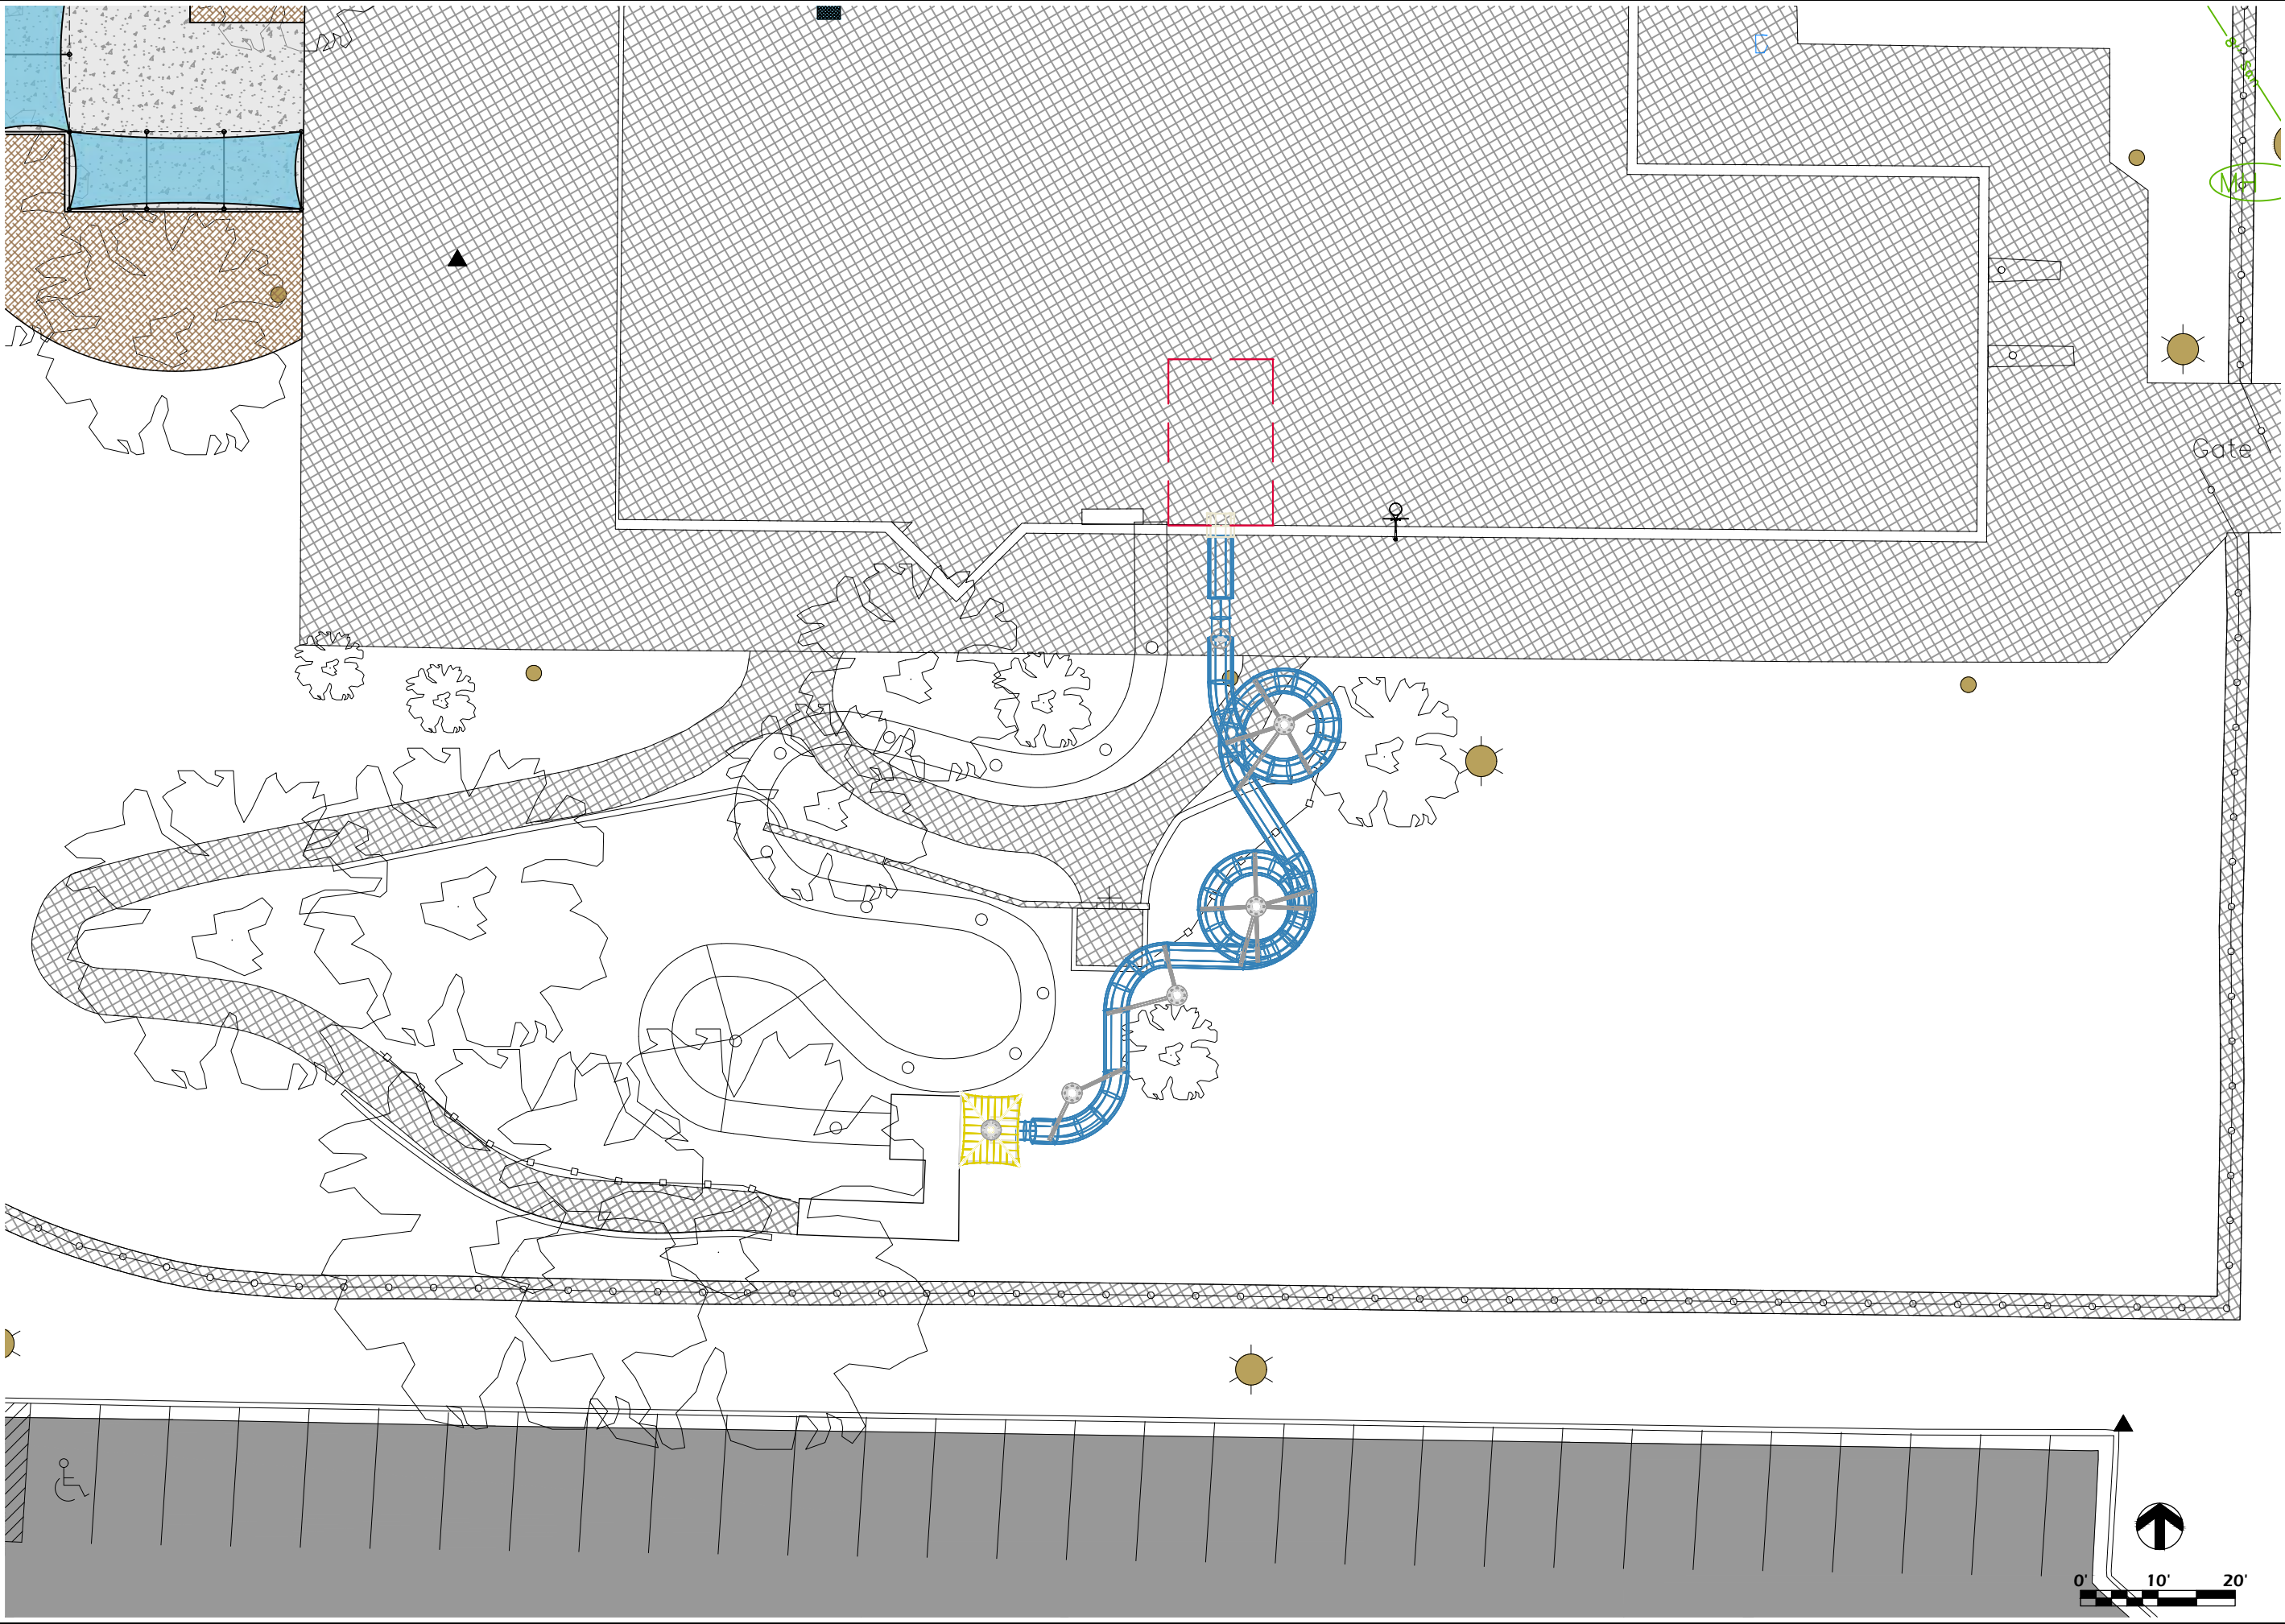

Project Name: KAUKAUNA POOL RENOVATION 607 Dodge Street Kaukauna, WI 54130		Sheet Title: SITE LAYOUT PLAN
Revisions:		
Project #: Issued For: Date:	21.039 Review 4/7/2022	
Sheet Number C215		

ONE DESIGN & ENGINEERING
Est. 2020
302 Ash St. Cambridge, WI 53628 • 800.577.0143 • www.one-dte.com

PARKITECTURE + PLANNING
901 Deming Way, Suite 102
Madison, WI 53717
608.886.6808

File: V:\21.039 Kaukauna Pool CDs\CAD\KaukaunaWI-SLD1-3D.dwg Layout: C600 User: Blake Plotted: Sep 13, 2022 - 9:35pm




3 WATERSLIDE PERSPECTIVE
C600 SCALE: N.T.S



2 WATERSLIDE PERSPECTIVE
C600 SCALE: N.T.S

MARK	SLIDE TYPE	GPM	HEIGHT (ft)	LENGTH (ft)
A	32" ENCLOSED BODY SLIDE	300-500	29.70'	190.66'
TOTAL LENGTH:				190.66'

Slide height is from finished pool/runout deck to finished start deck.
Water level is assumed to be (6) inches BELOW finished pool deck.

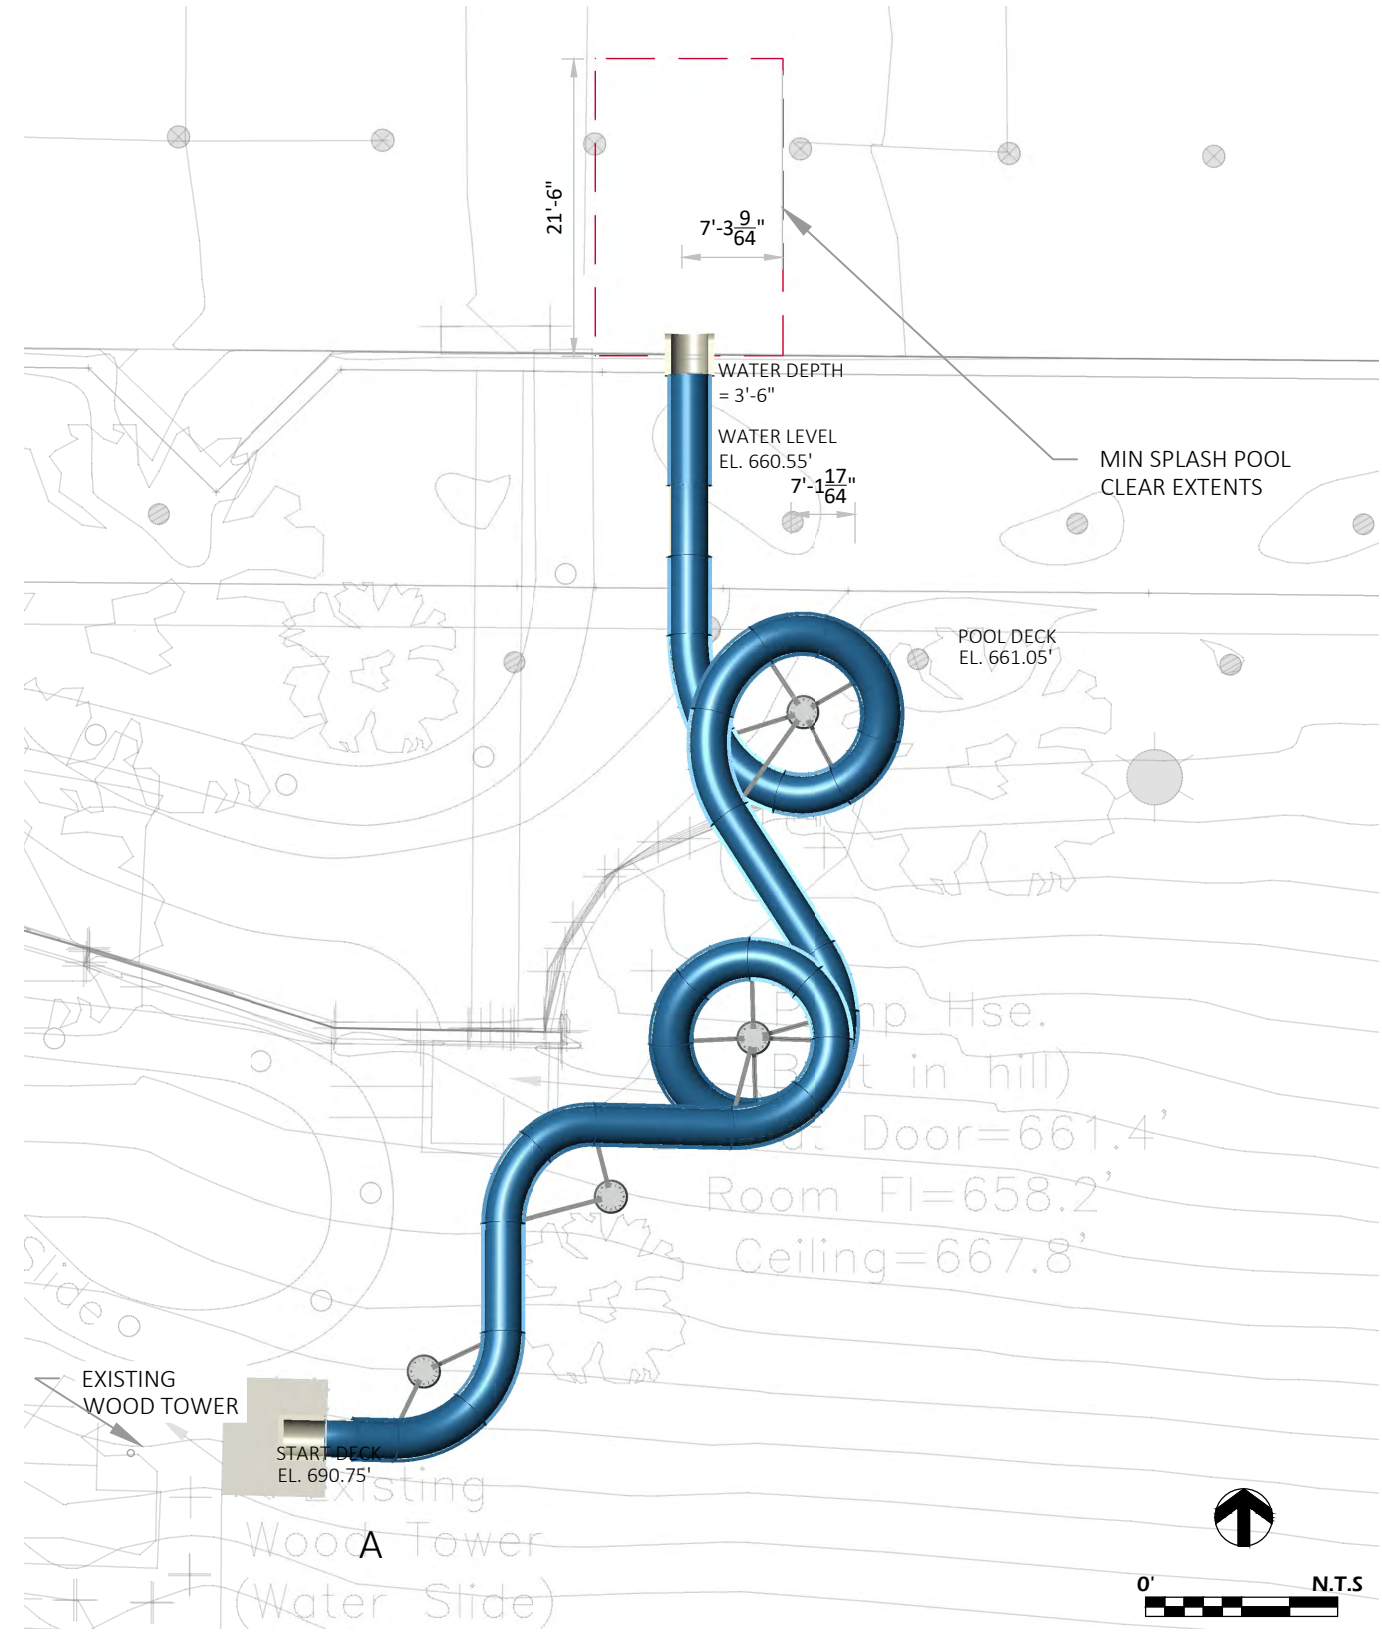


1 WATERSLIDE PLAN VIEW
C600 SCALE: N.T.S

File: V:\21.039 Kaukauna Pool CDs\CAD\image board.dwg Layout: EXHIBIT 4 User: bluem Plotted: Sep 14, 2022 -- 12:14pm

CODE	SKU	COMPONENT NAME	QTY	CODE	SKU	COMPONENT NAME	QTY	CODE	SKU	COMPONENT NAME	QTY
1	0010-4055	FS ANETH BLOOM 1	1	11	0010-5834	FS WATER WEAVER 1	1	21	0010-7478	GS GEYSER	4
2	0010-1655	FS DAISY MAE WINDY	1	12	0010-5724	FS WATER WEAVER 2	1	22	0010-7495	GS Group Volcano	1
3	0011-0845	FS FLUTTERBY	1	13	0010-5836	FS WATER WEAVER 3	1	23	0010-7492	GS GUSHER	1
4	0010-0485	FS FUN-BRELLA	1	14	0010-4591	FS WATERFALL 2	1	24	0010-7479	GS MISTY MOUNTAIN	1
5	0010-1709	FS RAIN FOREST	3	15	0010-0417	FS WIGGLY JR	1	25	0010-7480	GS MONSTER 5	1
6	0010-5099	FS SPIN SPRAY 1	1	16	0010-7474	GS BUTTERCUP	1	26	0010-7493	GS MOP TOP	1
7	0010-5100	FS SPIN SPRAY 2	1	17	0010-7475	GS CHARLOTTE WEB	1	27	0010-5845	GS playPHASE HIGH	1
8	0010-0377	FS SPIRAL TUNNEL	1	18	0010-7476	GS CONFETTI SPRAY	1	28	0010-9816	GS TEAM EFFECT	1
9	0010-1670	FS TRILLI LILY WINDY	1	19	0010-7494	GS DOUGHNUT	1	29	0010-7488	GS TOWER SPRAY	1
10	0010-0526	FS USO	1	20	0010-7477	GS FOUNTAIN MOUNTAIN	3	30	0010-7489	GS TULIP	3

NOT FOR CONSTRUCTION
PURPOSES

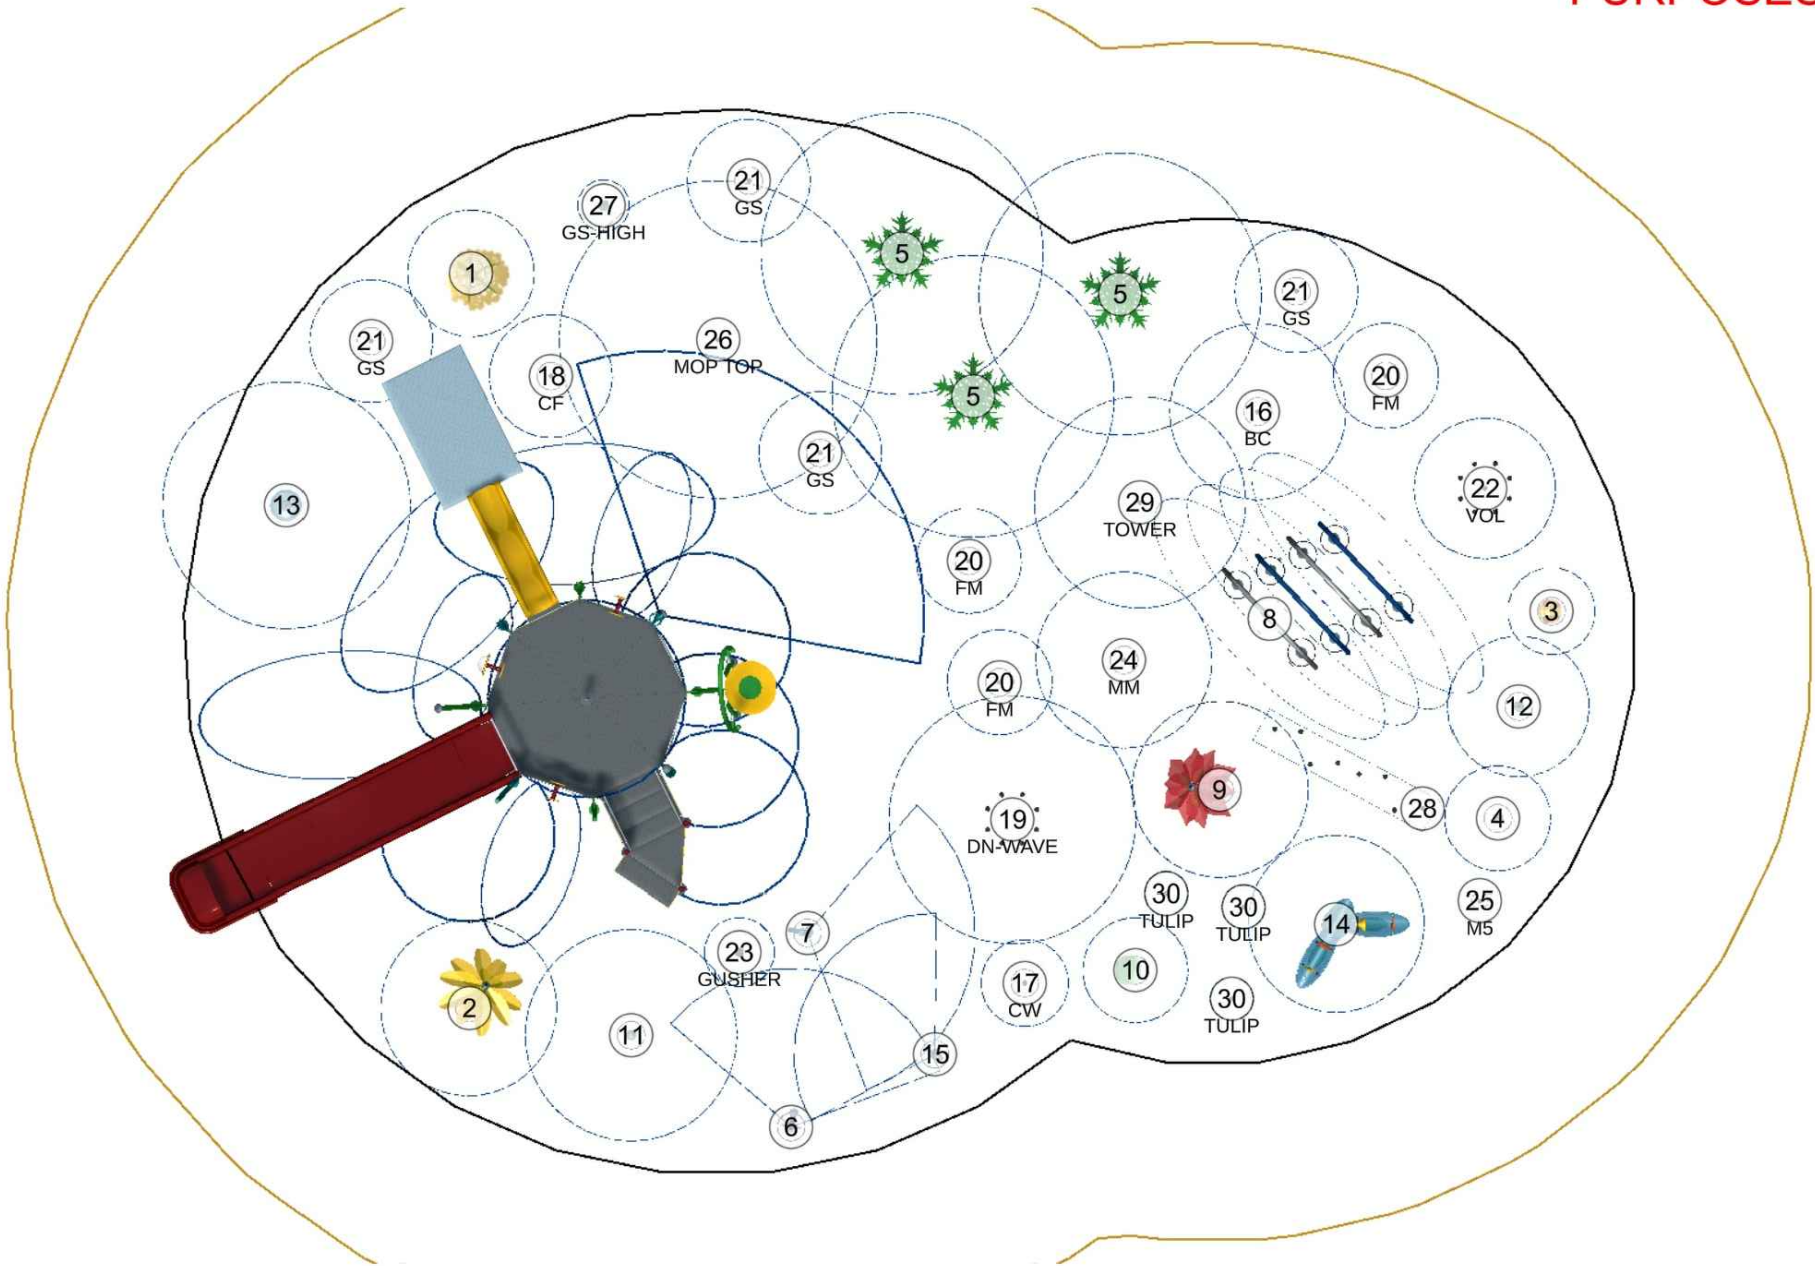

Project Name:
KAUKAUNA POOL RENOVATION

607 Dodge Street
Kaukauna, WI 54130

Revisions:

Project #:
Issued For:
Date:

21.039
Review
9/14/2022

Sheet Number

C700

ONE DESIGN & ENGINEERING
Est. 2020

202 Ash St. Cambridge, WI 53523 • 608.577.0443 • www.onedn.com

PARKITECTURE
+ PLANNING
901 Deming Way, Suite 102
Madison, WI 53717
608.886.6808



Project Name:
KAUKAUNA POOL RENOVATION

**607 Dodge Street
Kaukauna, WI 54130**

Sheet Title:
SPLASHPAD ACTIVITY TOWER

Revisions:

Project #: 21.039
Issued For: Review
Date: 9/14/2022

Sheet Number

C701

ONE DESIGN & ENGINEERING
Est. 2020
202 Ash St, Cambridge, WI 53523 • 608.577.0443 • www.onednae.com



**PARKITECTURE
+ PLANNING**
901 Deming Way, Suite 102
Madison, WI 53717
608.886.6808
Parkitecture

File: V:\21.039 Kaukauna Pool CDs\CAD\image board.dwg Layout: C702 User: bluem Plotted: Sep 14, 2022 -- 12:27am



Project Name:
KAUKAUNA POOL RENOVATION

607 Dodge Street
Kaukauna, WI 54130

Sheet Title:
SPLASHPAD RENDERINGS

Revisions:

Project #:
Issued For:
Date:

21.039
Review
9/14/2022

Sheet Number

C702

ONE DESIGN & ENGINEERING
Est. 2020

202 Ash St. Cambridge, WI 53523 ♦ 608.577.0443 ♦ www.onedte.com

**PARKITECTURE
+ PLANNING**
901 Deming Way, Suite 102
Madison, WI 53717
608.886.6808

File: V:\21.039 Kaukauna Pool CDs\CAD\image board.dwg Layout: C703 User: bluem Plotted: Sep 14, 2022 -- 12:30am



Project Name: KAUKAUNA POOL RENOVATION 607 Dodge Street Kaukauna, WI 54130		Sheet Title: SPLASHPAD RENDERINGS
Revisions:		
Project #: Issued For: Date:		21.039 Review 9/14/2022
Sheet Number C703		

ONE DESIGN & ENGINEERING Est. 2020	202 Ash St. Cambridge, WI 53523 • 608.577.0443 • www.onedte.com
--	---

PARKITECTURE + PLANNING	901 Deming Way, Suite 102 Madison, WI 53717 608.886.6808
--------------------------------	--

File: V:\21.039 Kaukauna Pool CD\CAD\image board.dwg Layout: C704 User: bluem Plotted: Sep 14, 2022 -- 12:32pm



Project Name:
KAUKAUNA POOL RENOVATION

607 Dodge Street
Kaukauna, WI 54130

Revisions:

Project #:
Issued For:
Date:

21.039
Review
9/14/2022

Sheet Number

C704

ONE DESIGN & ENGINEERING
Est. 2020

202 Ash St. Cambridge, WI 53523 ♦ 608.577.0443 ♦ www.onedte.com

PARKITECTURE
+ **PLANNING**

901 Deming Way, Suite 102
Madison, WI 53717
608.886.6808

File: V:\21.039 Kaukauna Pool CDS\CAD\image board.dwg Layout: Image 1 User: blium Plotted: Sep 13, 2022 -- 9:58pm



E BASKETBALL HOOP
EX 1 SCALE: N.T.S



B PLAY STRUCTURE
EX 1 SCALE: N.T.S




D CLIMBING WALL
EX 1 SCALE: N.T.S



1 CONCEPT PLAN - POOL AREA
EX 1 SCALE: N.T.S

File: V:\21.039 Kaukauna Pool CAD\image board.dwg Layout: EXHIBIT 2 User: bluem Plotted: Sep 13, 2022 - 10:25pm

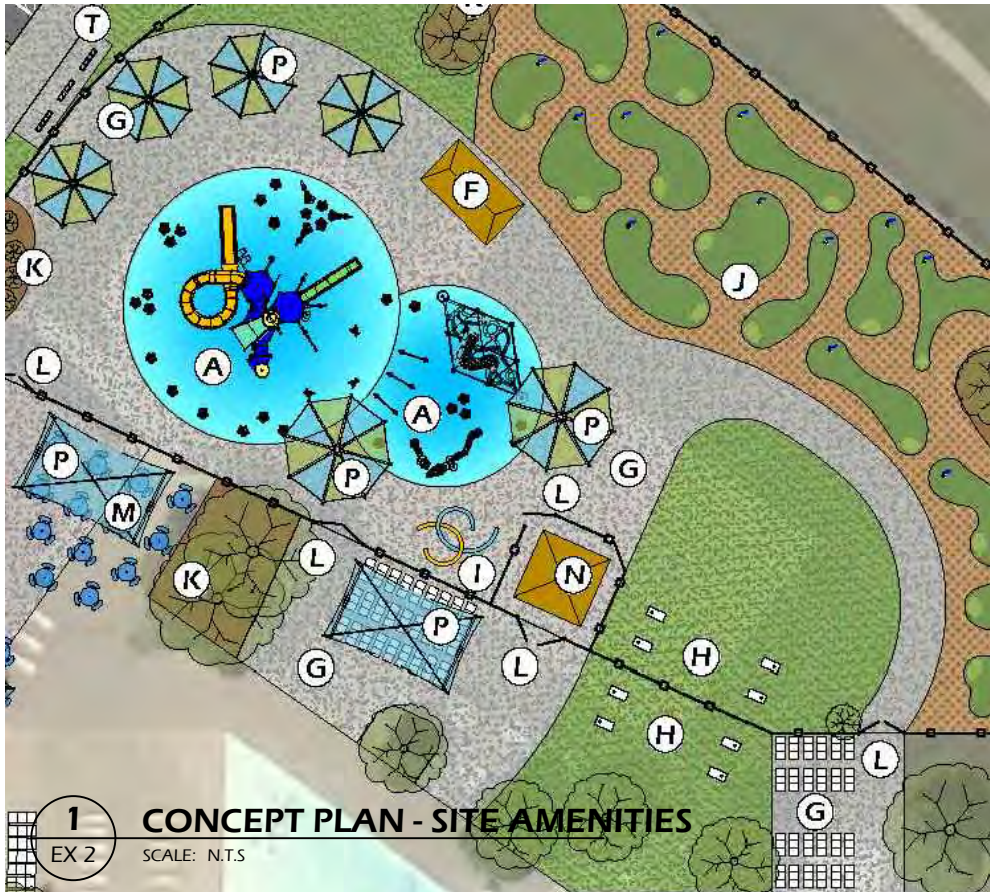

File: V:\21.039 Kaukauna Pool CAD\image board.dwg Layout: EXHIBIT 3 User: bluem Plotted: Sep. 13, 2022 - 10:39pm



KAUKAUNA POOL RENOVATION 607 Dodge Street Kaukauna, WI 54130		CHARACTER IMAGES - MINIATURE GOLF
Project Name:		Sheet Title:
Revisions:		Revisions:
Project #: 21.039 Issued For: Review Date: 9/14/2022		Sheet Number
EXHIBIT 3		

PARKITECTURE + PLANNING
901 Deming Way, Suite 102
Madison, WI 53717
608.886.6808

ONE DESIGN & ENGINEERING
Est. 2020
202 Ash St. Cambridge, WI 53523 • 608.577.0443 • www.onedte.com