


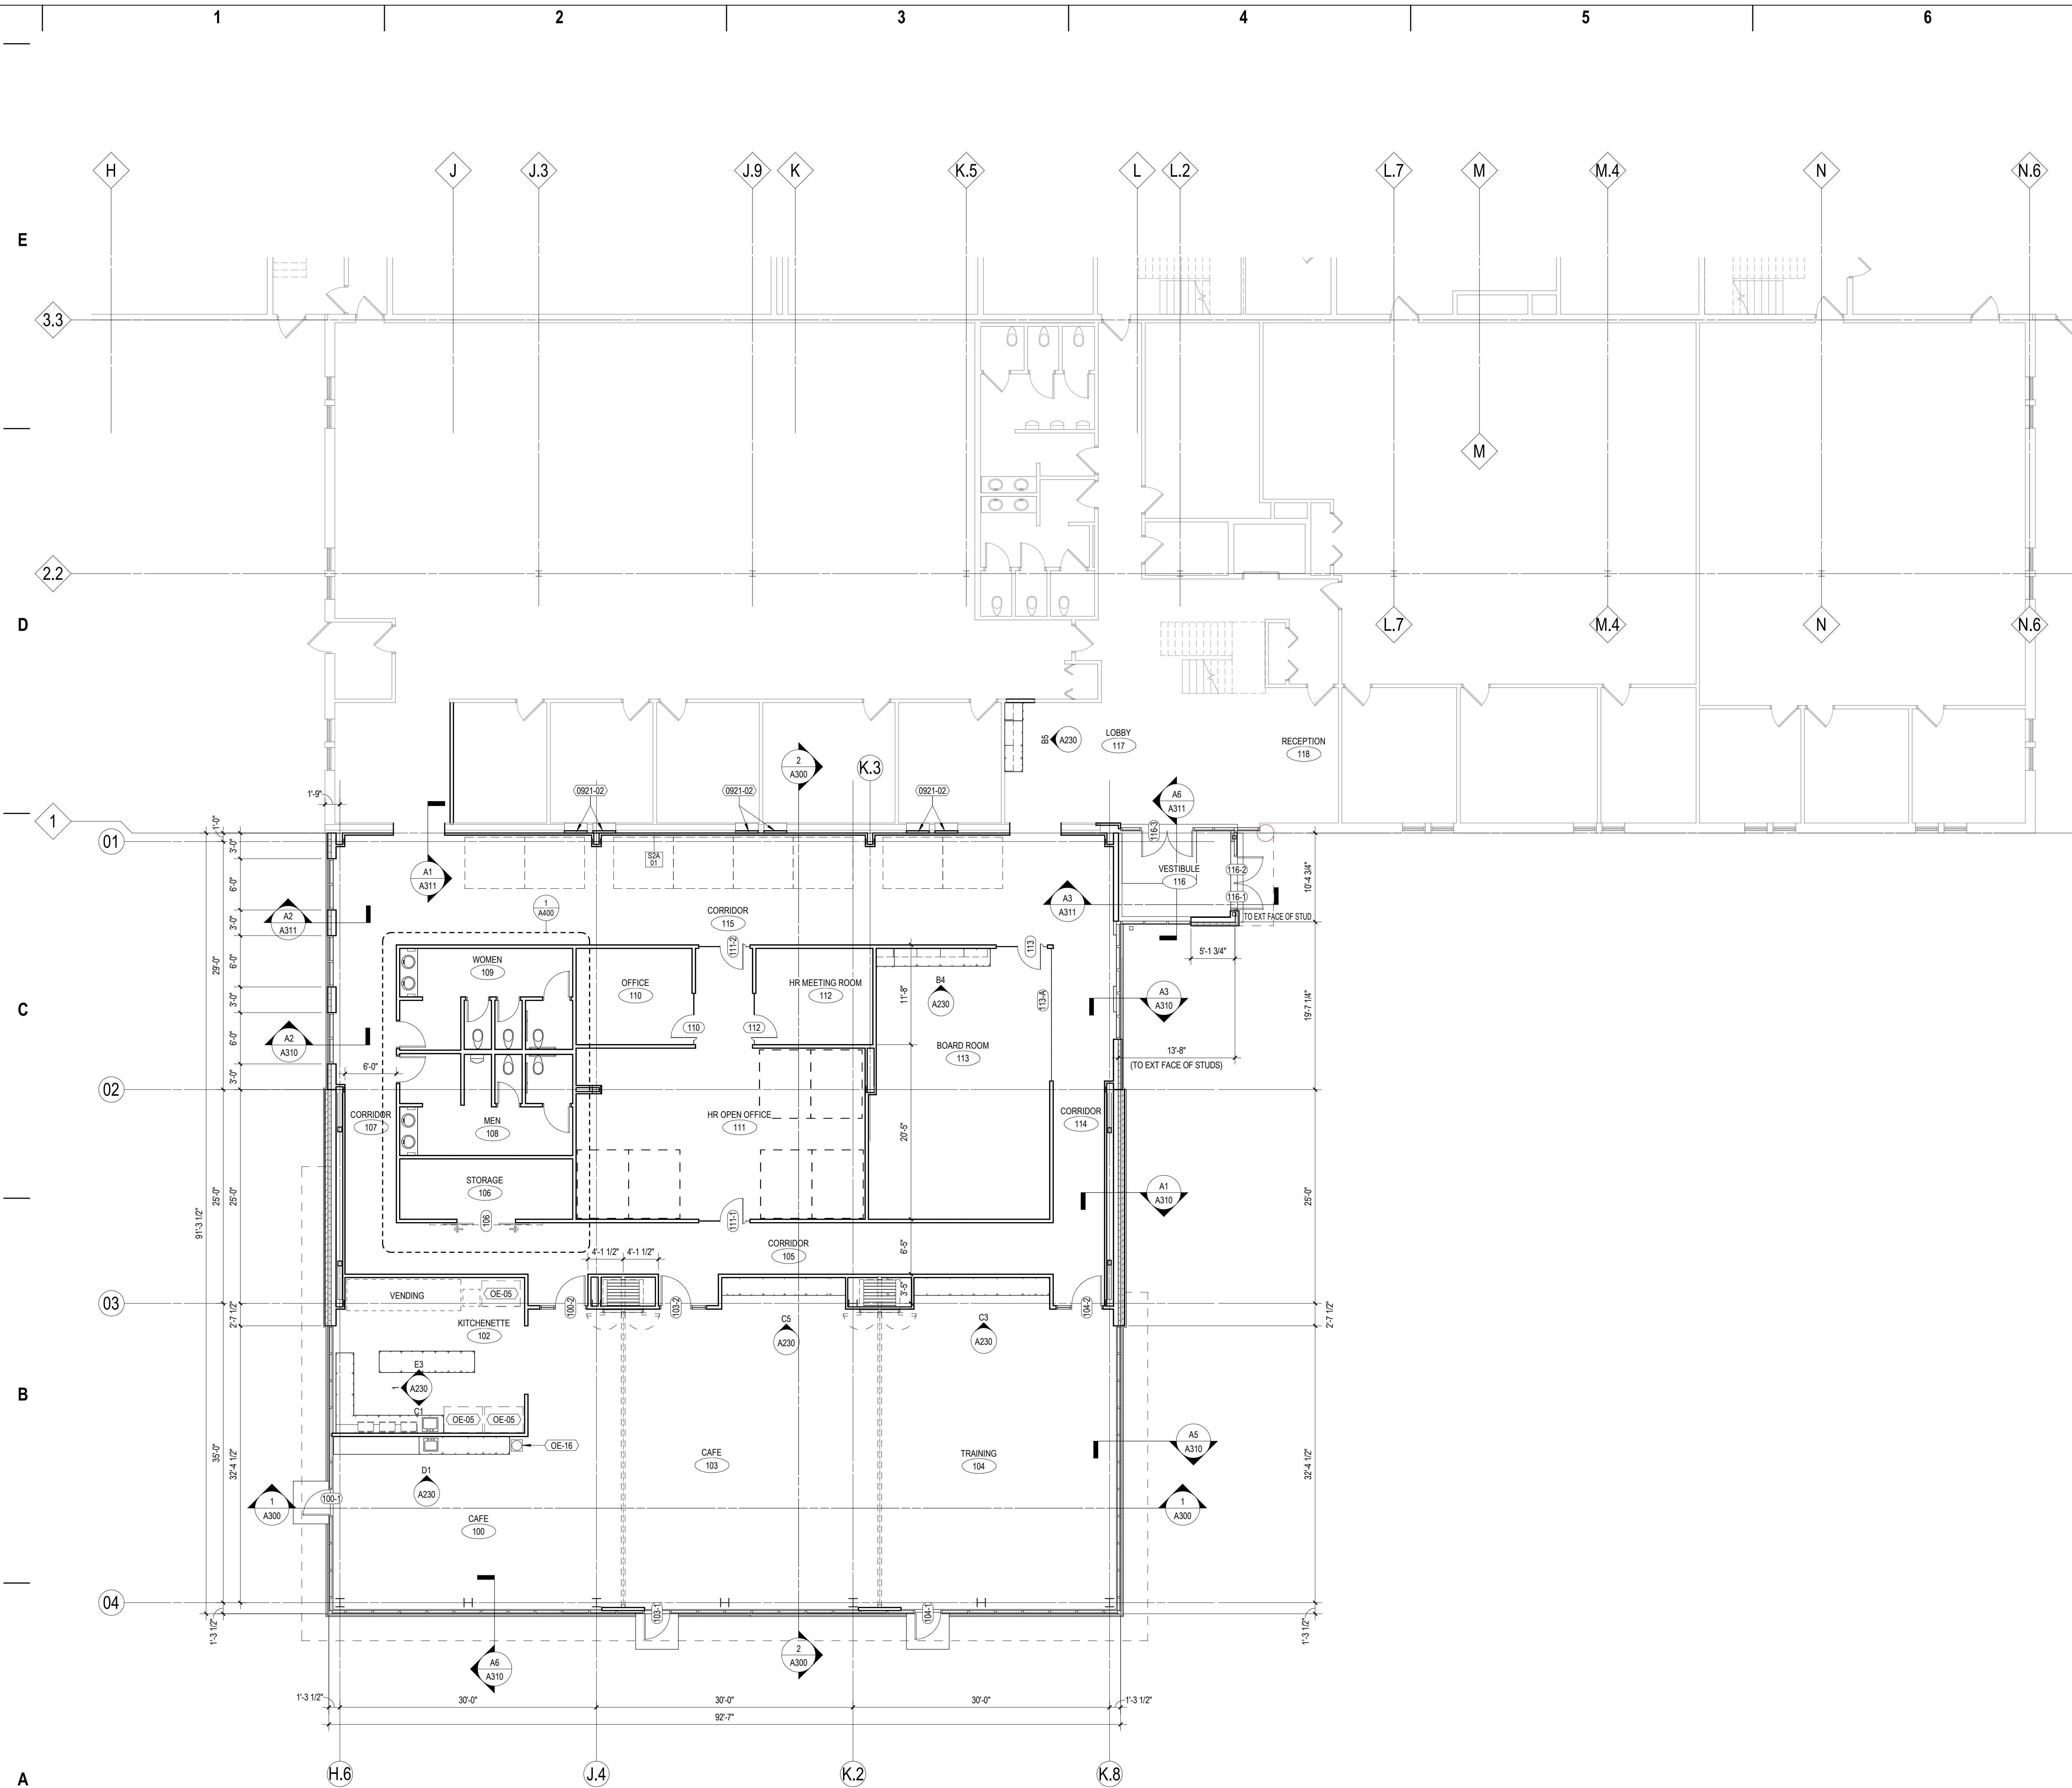

SHEET NOTES - FLOOR PLAN	
1.	ALL DIMENSION STRINGS ARE TO FINISH FACE OF WALL, UNLESS NOTED OTHERWISE.
2.	REFER TO SHEET A000 FOR REFERENCED PARTITION TYPES AND DETAILS. WALLS NOT TAGGED ON THESE PLANS SHALL BE PARTITION TYPE S3A-S11.
3.	ALL WALLS DIRECTLY BEHIND OR ADJACENT TO PLUMBING FIXTURES SHALL RECEIVE MOISTURE- AND MOLD-RESISTANT GYPSUM BOARD, UNLESS NOTED OTHERWISE.
4.	LOCATE ALL DOOR JAMBS 4" FROM ADJACENT PERPENDICULAR WALL, UNLESS NOTED OTHERWISE.
5.	PROVIDE BLOCKING AND FRAMING AS INDICATED AND AS REQUIRED TO SUPPORT FACING MATERIALS, FIXTURES, SPECIALTY ITEMS, MILLWORK AND TRIM.

KEYNOTES PER SHEET	
0921-02	DEMOLISHED WINDOW AREA: IN-FILL WHERE WINDOW WAS REMOVED WITH METAL STUD FRAMING, GYP BO & SOUND INSULATION. PROVIDE GYP BO RETURN WHERE SILL WAS REMOVED & PATCH JAMB WHERE BLIND WAS REMOVED.
OE-05	REFRIGERATOR OR FREEZER - OWNER SUPPLIED, OWNER INSTALLED
OE-16	WATER COOLER - OWNER SUPPLIED, OWNER INSTALLED



milwaukee | madison | green bay | denver | atlanta

PROJECT INFORMATION

Bassett Mechanical
Office Addition

1215 Hyland Ave.
Kaukauna, WI 54130

ISSUANCE AND REVISIONS

DATE	DESCRIPTION
------	-------------

KEY PLAN

SHEET INFORMATION

**PROGRESS DOCUMENTS
NOT FOR CONSTRUCTION**

These documents reflect progress and intent and may be subject to change, including additional detail. These are not final construction documents and shall not be used for final bidding or construction-related purposes.


PROJECT MANAGER PM
PROJECT NUMBER 922140

1ST FLR PLAN

A101

© 2022 Epstein Uhen Architects, Inc.

1ST FLR PLAN
1/8" = 1'-0"

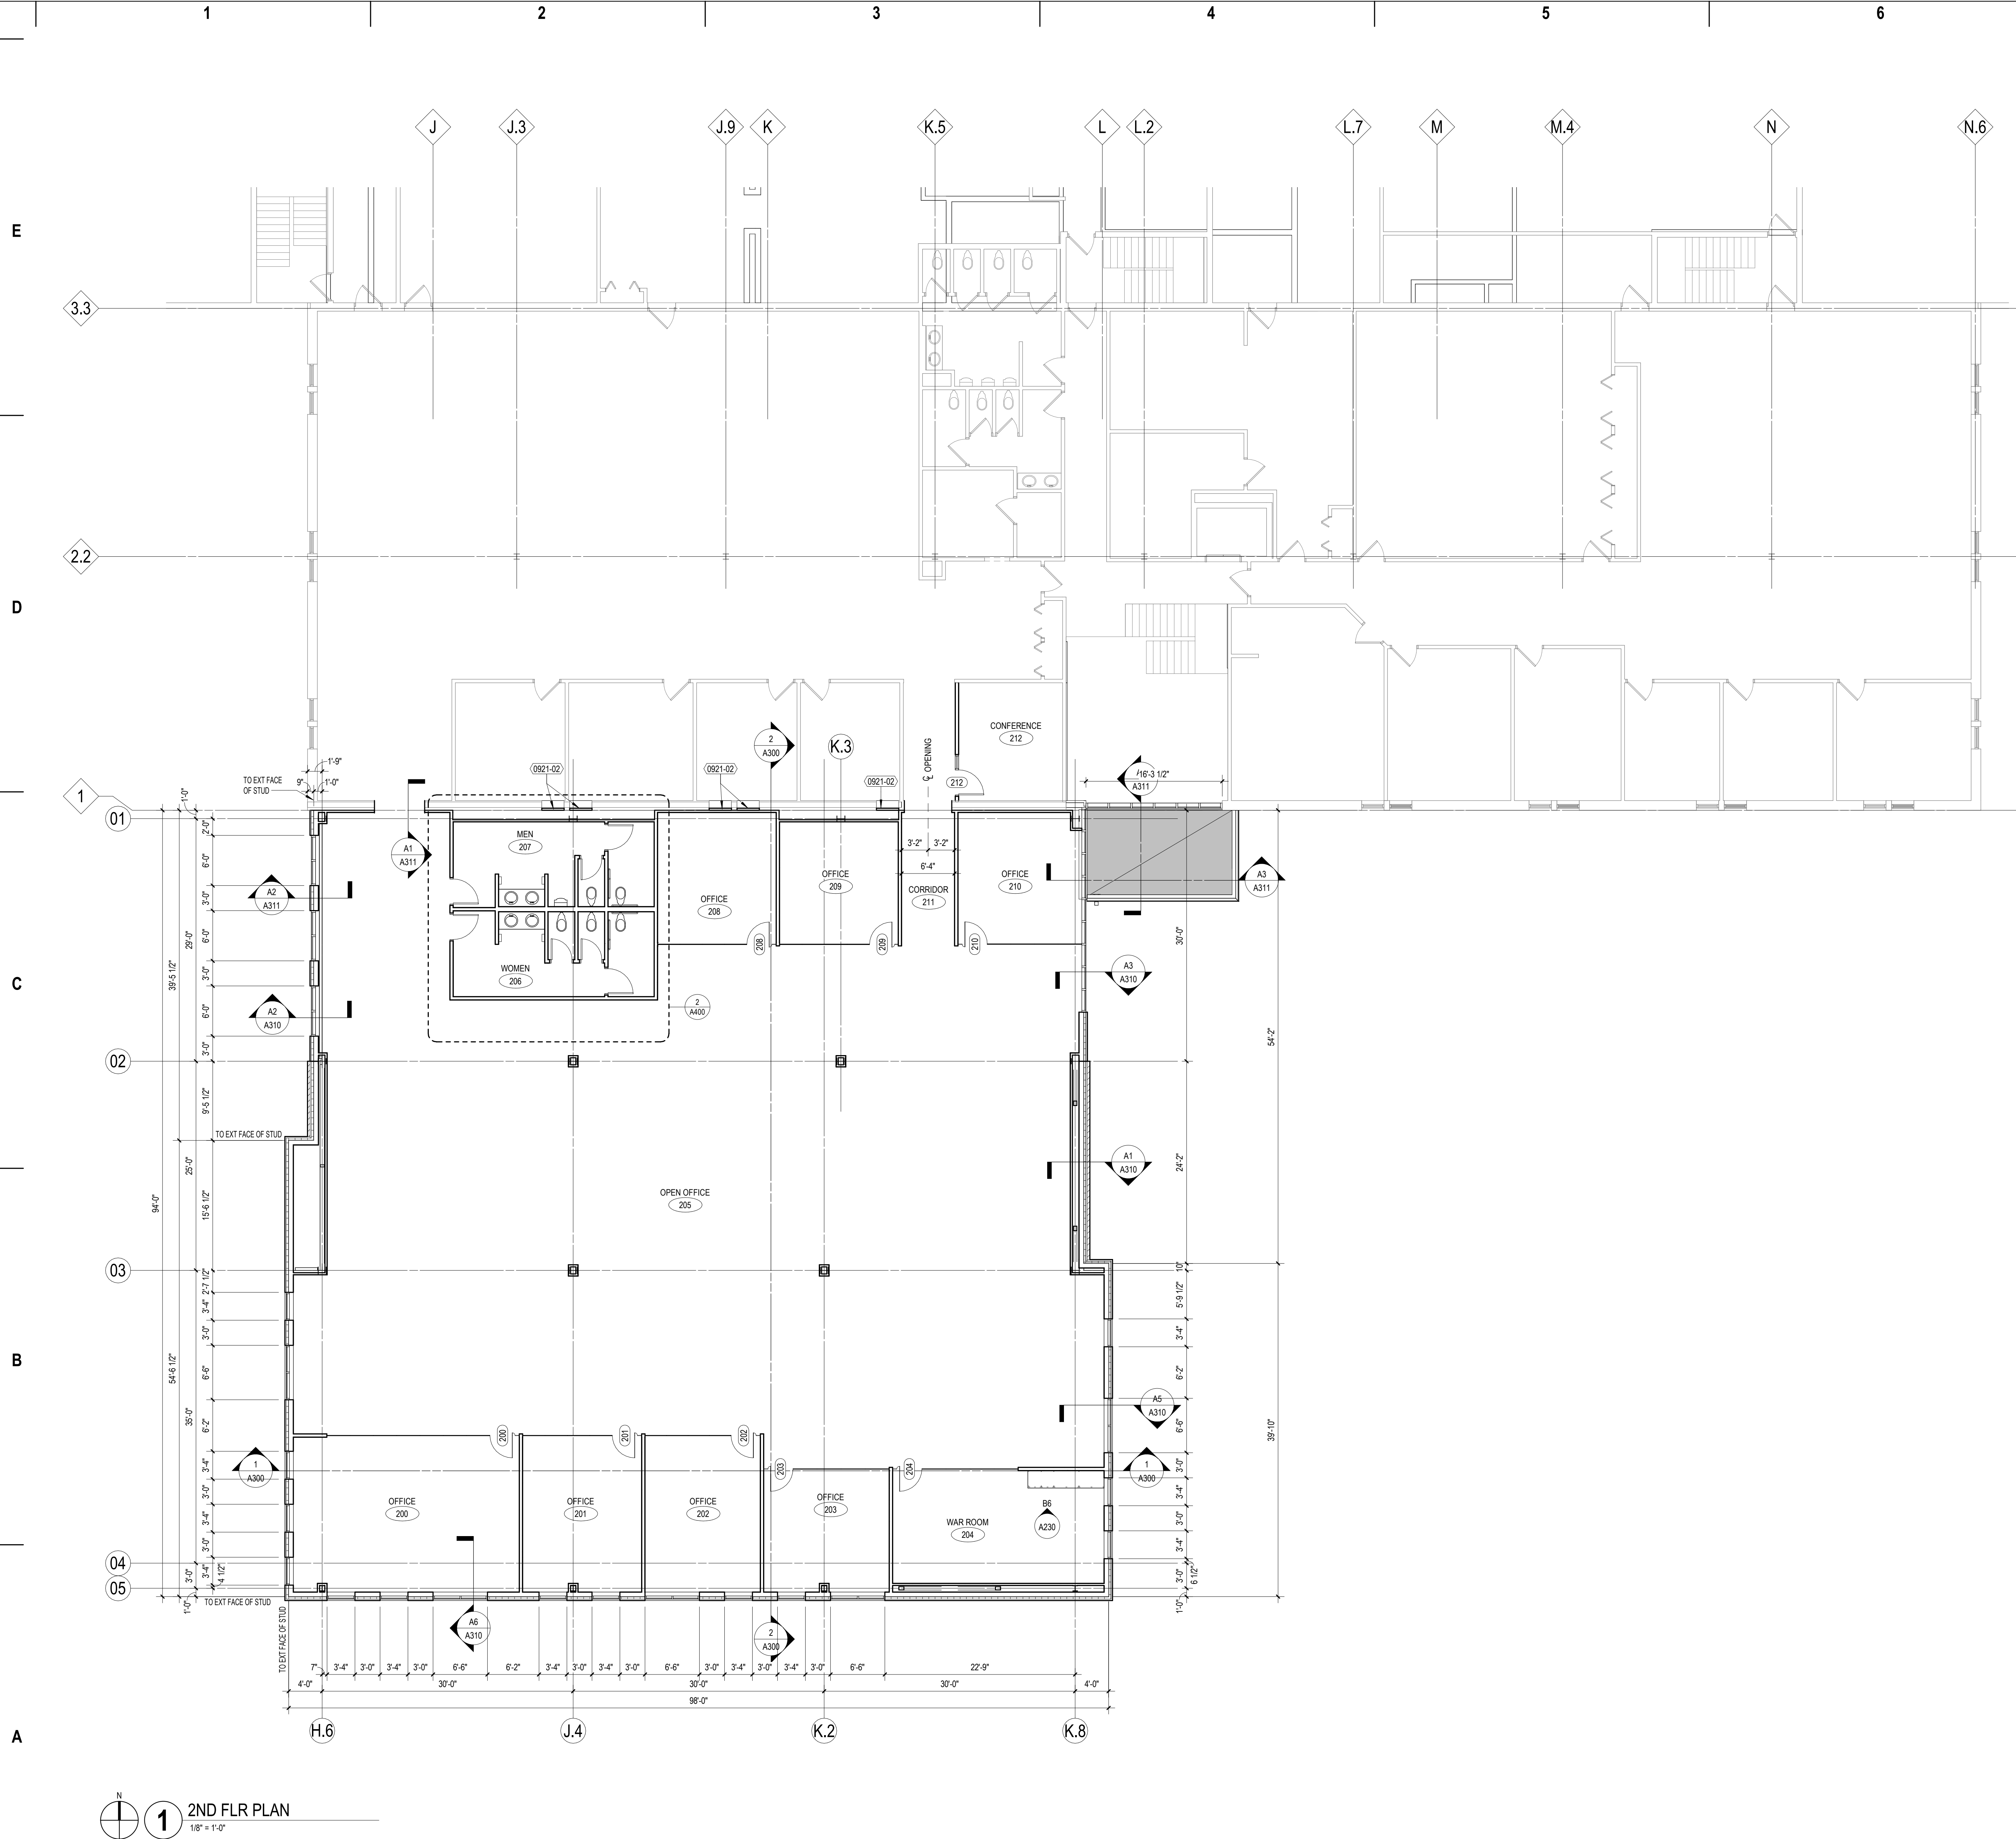

SHEET NOTES - FLOOR PLAN	
1.	ALL DIMENSION STRINGS ARE TO FINISH FACE OF WALL, UNLESS NOTED OTHERWISE.
2.	REFER TO SHEET A000 FOR REFERENCED PARTITION TYPES AND DETAILS. WALLS NOT TAGGED ON THESE PLANS SHALL BE PARTITION TYPE S3A-S11.
3.	ALL WALLS DIRECTLY BEHIND OR ADJACENT TO PLUMBING FIXTURES SHALL RECEIVE MOISTURE- AND MOLD-RESISTANT GYPSUM BOARD, UNLESS NOTED OTHERWISE.
4.	LOCATE ALL DOOR JAMBS 4" FROM ADJACENT PERPENDICULAR WALL, UNLESS NOTED OTHERWISE.
5.	PROVIDE BLOCKING AND FRAMING AS INDICATED AND AS REQUIRED TO SUPPORT FACING MATERIALS, FIXTURES, SPECIALTY ITEMS, MILLWORK AND TRIM.

KEYNOTES PER SHEET	
0921-02	DEMOLISHED WINDOW AREA: IN-FILL WHERE WINDOW WAS REMOVED WITH METAL STUD FRAMING, GYP BO & SOUND INSULATION. PROVIDE GYP BO RETURN WHERE SILL WAS REMOVED & PATCH JAMB WHERE BLIND WAS REMOVED.

milwaukee | madison | green bay | denver | atlanta

PROJECT INFORMATION

**Bassett Mechanical
Office Addition**

**1215 Hyland Ave.
Kaukauna, WI 54130**

ISSUANCE AND REVISIONS	
DATE	DESCRIPTION

KEY PLAN

SHEET INFORMATION

**PROGRESS DOCUMENTS
NOT FOR CONSTRUCTION**

These documents reflect progress and intent and may be subject to change, including additional detail. These are not final construction documents and shall not be used for final bidding or construction-related purposes.

PROJECT MANAGER	PM
PROJECT NUMBER	922140

2ND FLR PLAN

A102

© 2022 Epstein Uhen Architects, Inc.

E

D

C

B

A

1

2

3

4

5

6

7

EXTERIOR BUILDING MATERIAL LEGEND

	FB-1 (FACE BRICK)		MJ = MOVEMENT JOINT
	MCMP (METAL COMPOSITE MATERIAL PANEL)		
	MCMP-1		
	(MP) METAL PANEL		
	MP-1		
PATTERN:			
• MIN. 8" STARTING VERTICAL PANEL.			
• 12" VERTICAL:			
• 8" VERTICAL:			
• 8" VERTICAL:			
• 12" VERTICAL:			
• 12" VERTICAL:			
• REPEAT PATTERN			

SHEET NOTES - EXTERIOR ELEVATIONS

1.	SEE SHEET A200 FOR EXTERIOR FRAME TYPES AND DIMENSIONS.
2.	FOR MOVEMENT JOINTS IN CMU REFERENCE STRUCTURAL DRAWINGS.
3.	PAINT ALL EXPOSED STEEL LINTELS.
4.	EXTERIOR SIGNAGE ON BUILDING TO BE COORDINATED AND VERIFIED WITH OWNER AND SIGNAGE VENDOR.
5.	ALL VERTICAL INSIDE CORNERS TO HAVE 1/2" MOVEMENT JOINT.

KEYNOTES PER SHEET

0742-03	PREFINISHED METAL STANDING SEAM WALL PANEL
0762-05	PREFINISHED METAL ROOF EDGE
0843-01	ALUMINUM-FRAMED STOREFRONT
0844-01	ALUMINUM-FRAMED CURTAIN WALL



milwaukee | madison | green bay | denver | atlanta

E

PROJECT INFORMATION

Bassett Mechanical
Office Addition

1215 Hyland Ave.
Kaukauna, WI 54130

ISSUANCE AND REVISIONS

DATE	DESCRIPTION
------	-------------

KEY PLAN

B

SHEET INFORMATION

**PROGRESS DOCUMENTS
NOT FOR CONSTRUCTION**

These documents reflect progress and intent and may be subject to change, including additional detail. These are not final construction documents and shall not be used for final bidding or construction-related purposes.

PROJECT MANAGER PM

PROJECT NUMBER 922140

EXTERIOR
ELEVATIONS

A200

© 2022 Epstein Uhen Architects, Inc.

