


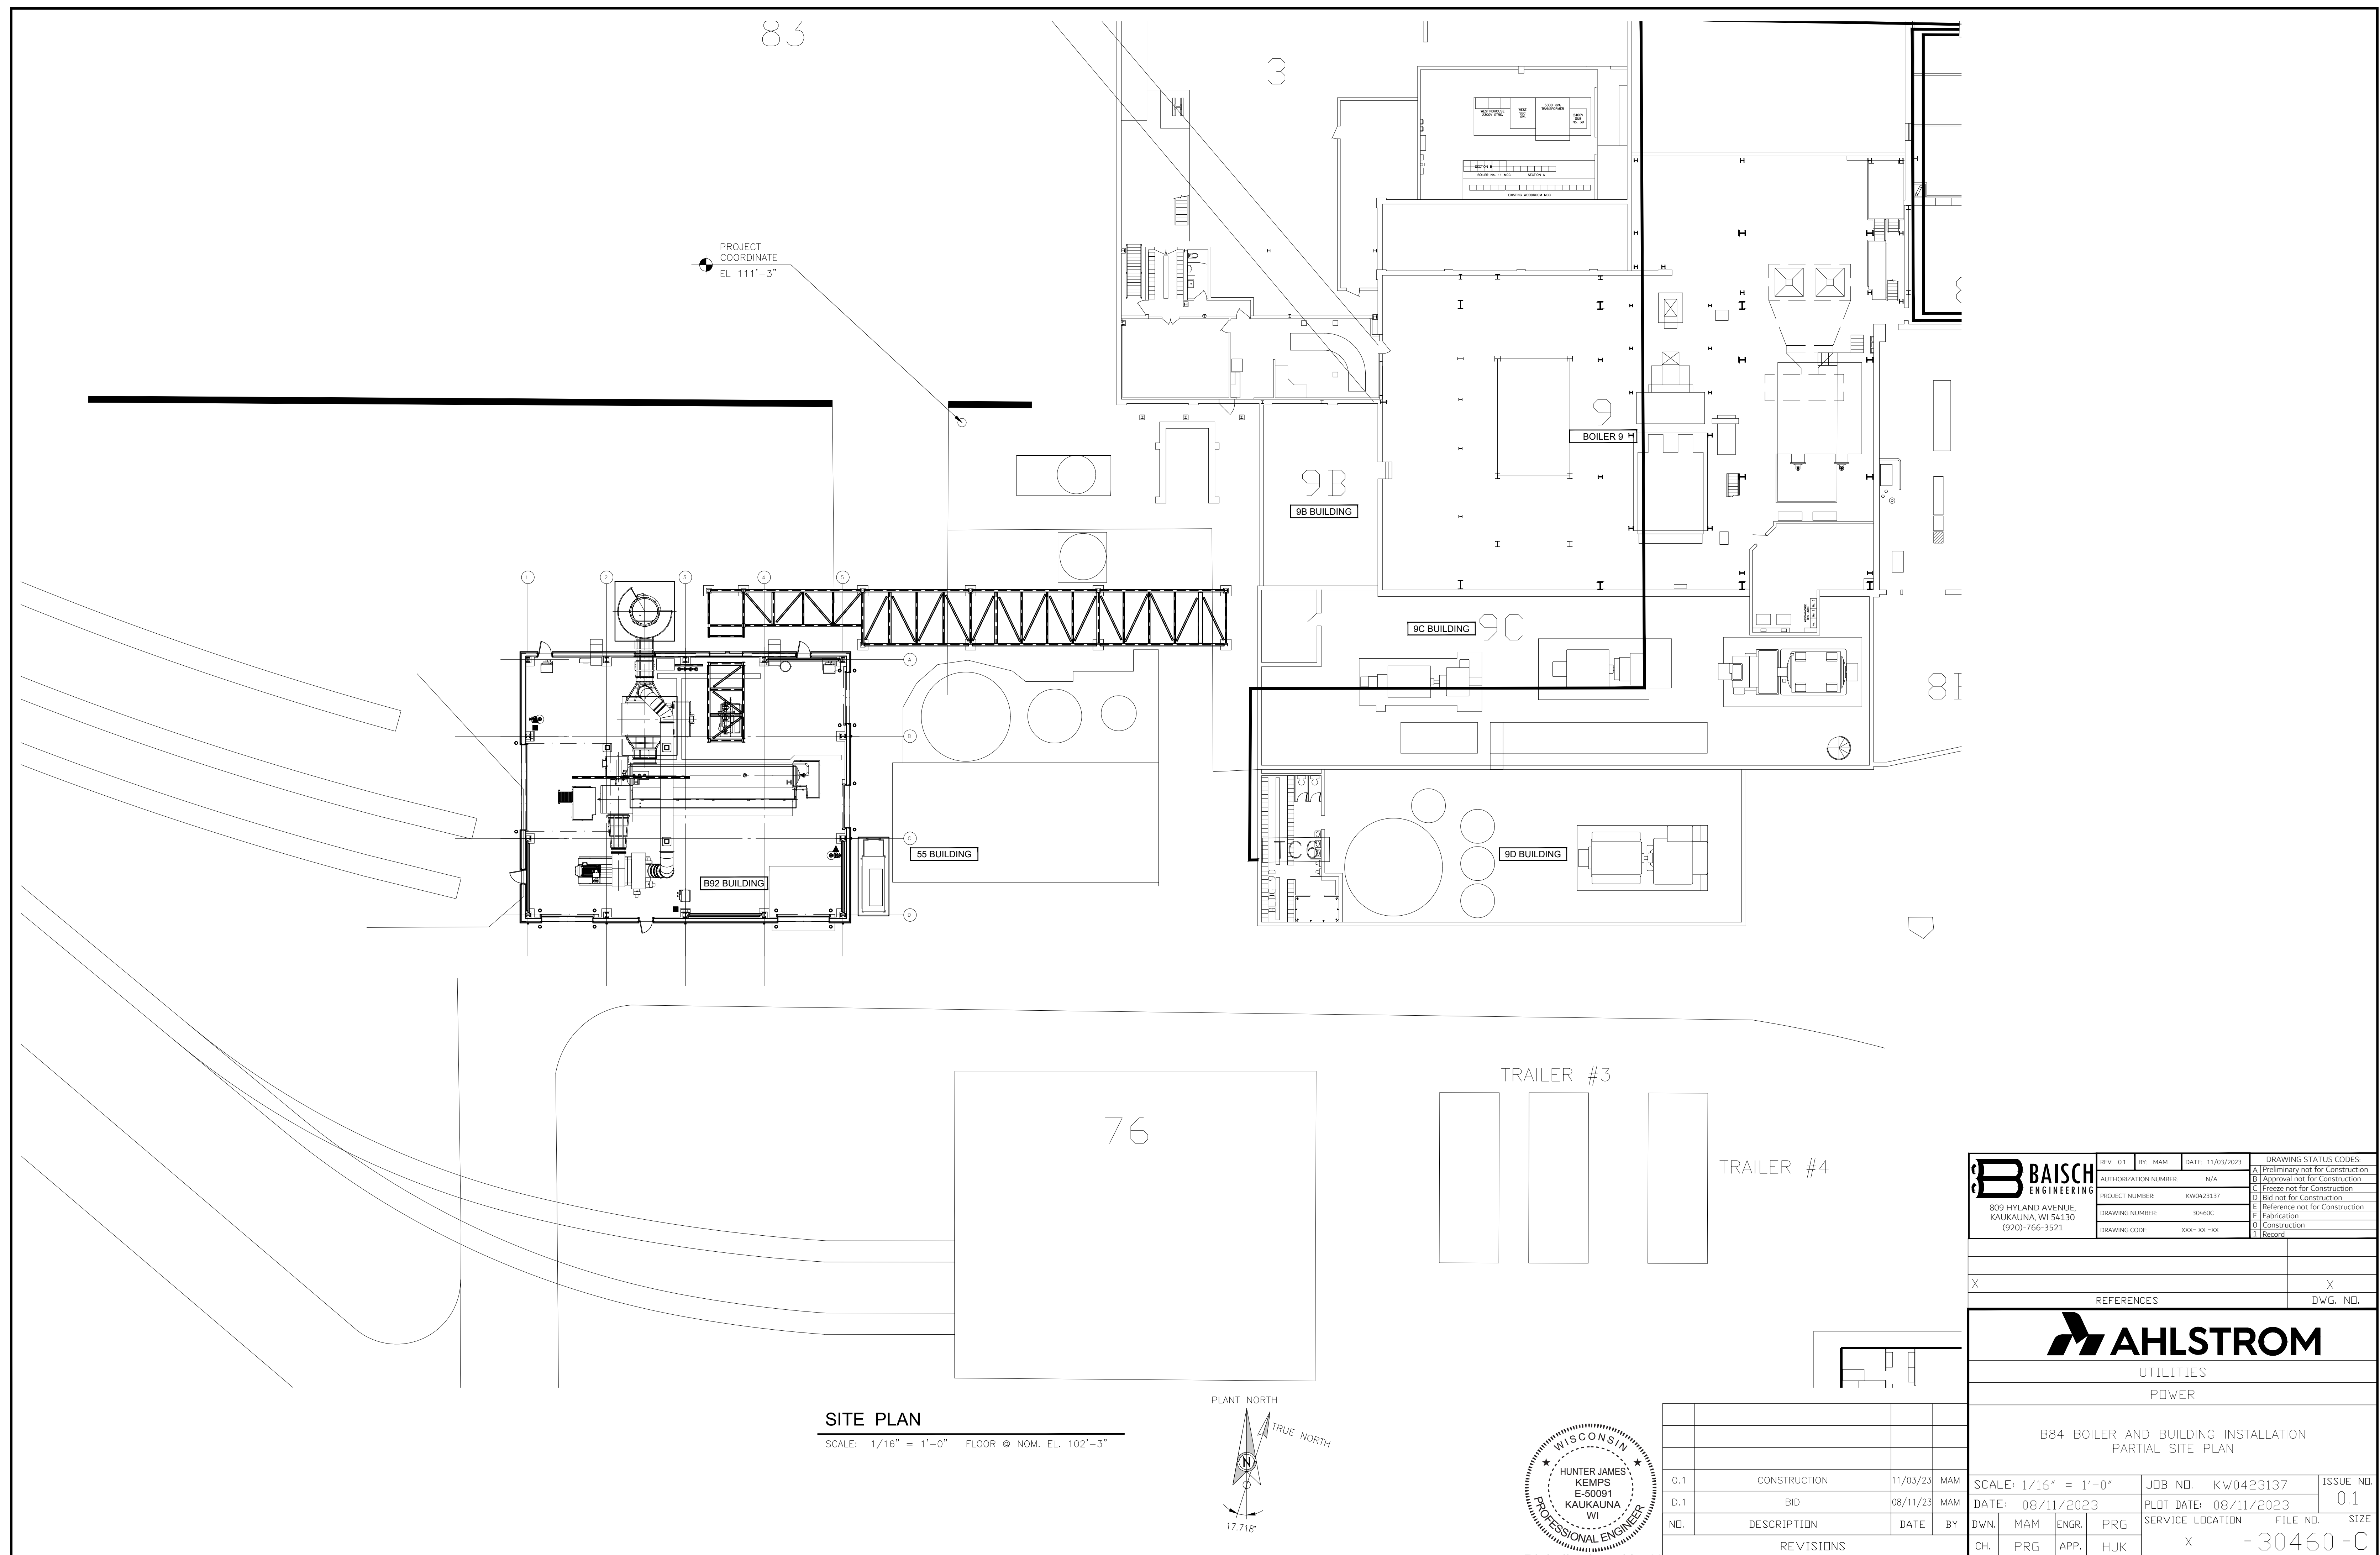

 BAISCH ENGINEERING 809 HYLAND AVENUE, KAUKAUNA, WI 54130 (920)-766-3521	REV: 01	By: MAM	DATE: 11/03/2023	DRAWING STATUS CODES
	AUTHORIZATION NUMBER	N/A		A Preliminary not for Construction
	PROJECT NUMBER	KW2042337		B Approval not for Construction
	DRAWING NUMBER	3040G		C Freeze not for Construction
	DRAWING CODE	XXX -XX -XX		D Bid not for Construction
				E Reference not for Construction
				F Fabrication
				G Construction
				H Rework

X	X
REFERENCES	DWG. NO.



UTILITIES

POWER

B84 BOILER AND BUILDING INSTALLATION
PARTIAL SITE PLAN

SCALE: 1/16" = 1'-0"				JOB NO. KW0423137		ISSUE NO. 0.1	
DATE: 08/11/2023				PLOT DATE: 08/11/2023			
DWN.		MAM	ENGR.	PRG	SERVICE LOCATION		FILE NO. SIZE
CH.		PRG	APP.	HJK	X - 30460 - C		

Digitally signed by James Kemps
DN: E=hkemps@baisch.com,
CN=Hunter James Kemps,
O=Baisch Engineering Inc.,
L=Kaukauna, S=Wisconsin,
C=US