

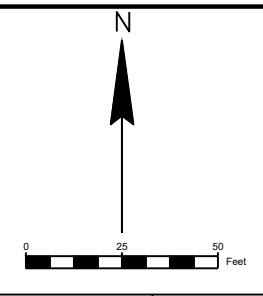


P:\KAUKA\24001 - WATER TREATMENT SYSTEM IMPROVEMENTS\CAD\C3D\MAIN WATER TREATMENT PLANT EXISTING SITE PLAN_C100.DWG

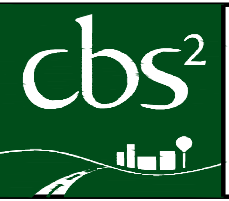

KANKAPOT CREEK

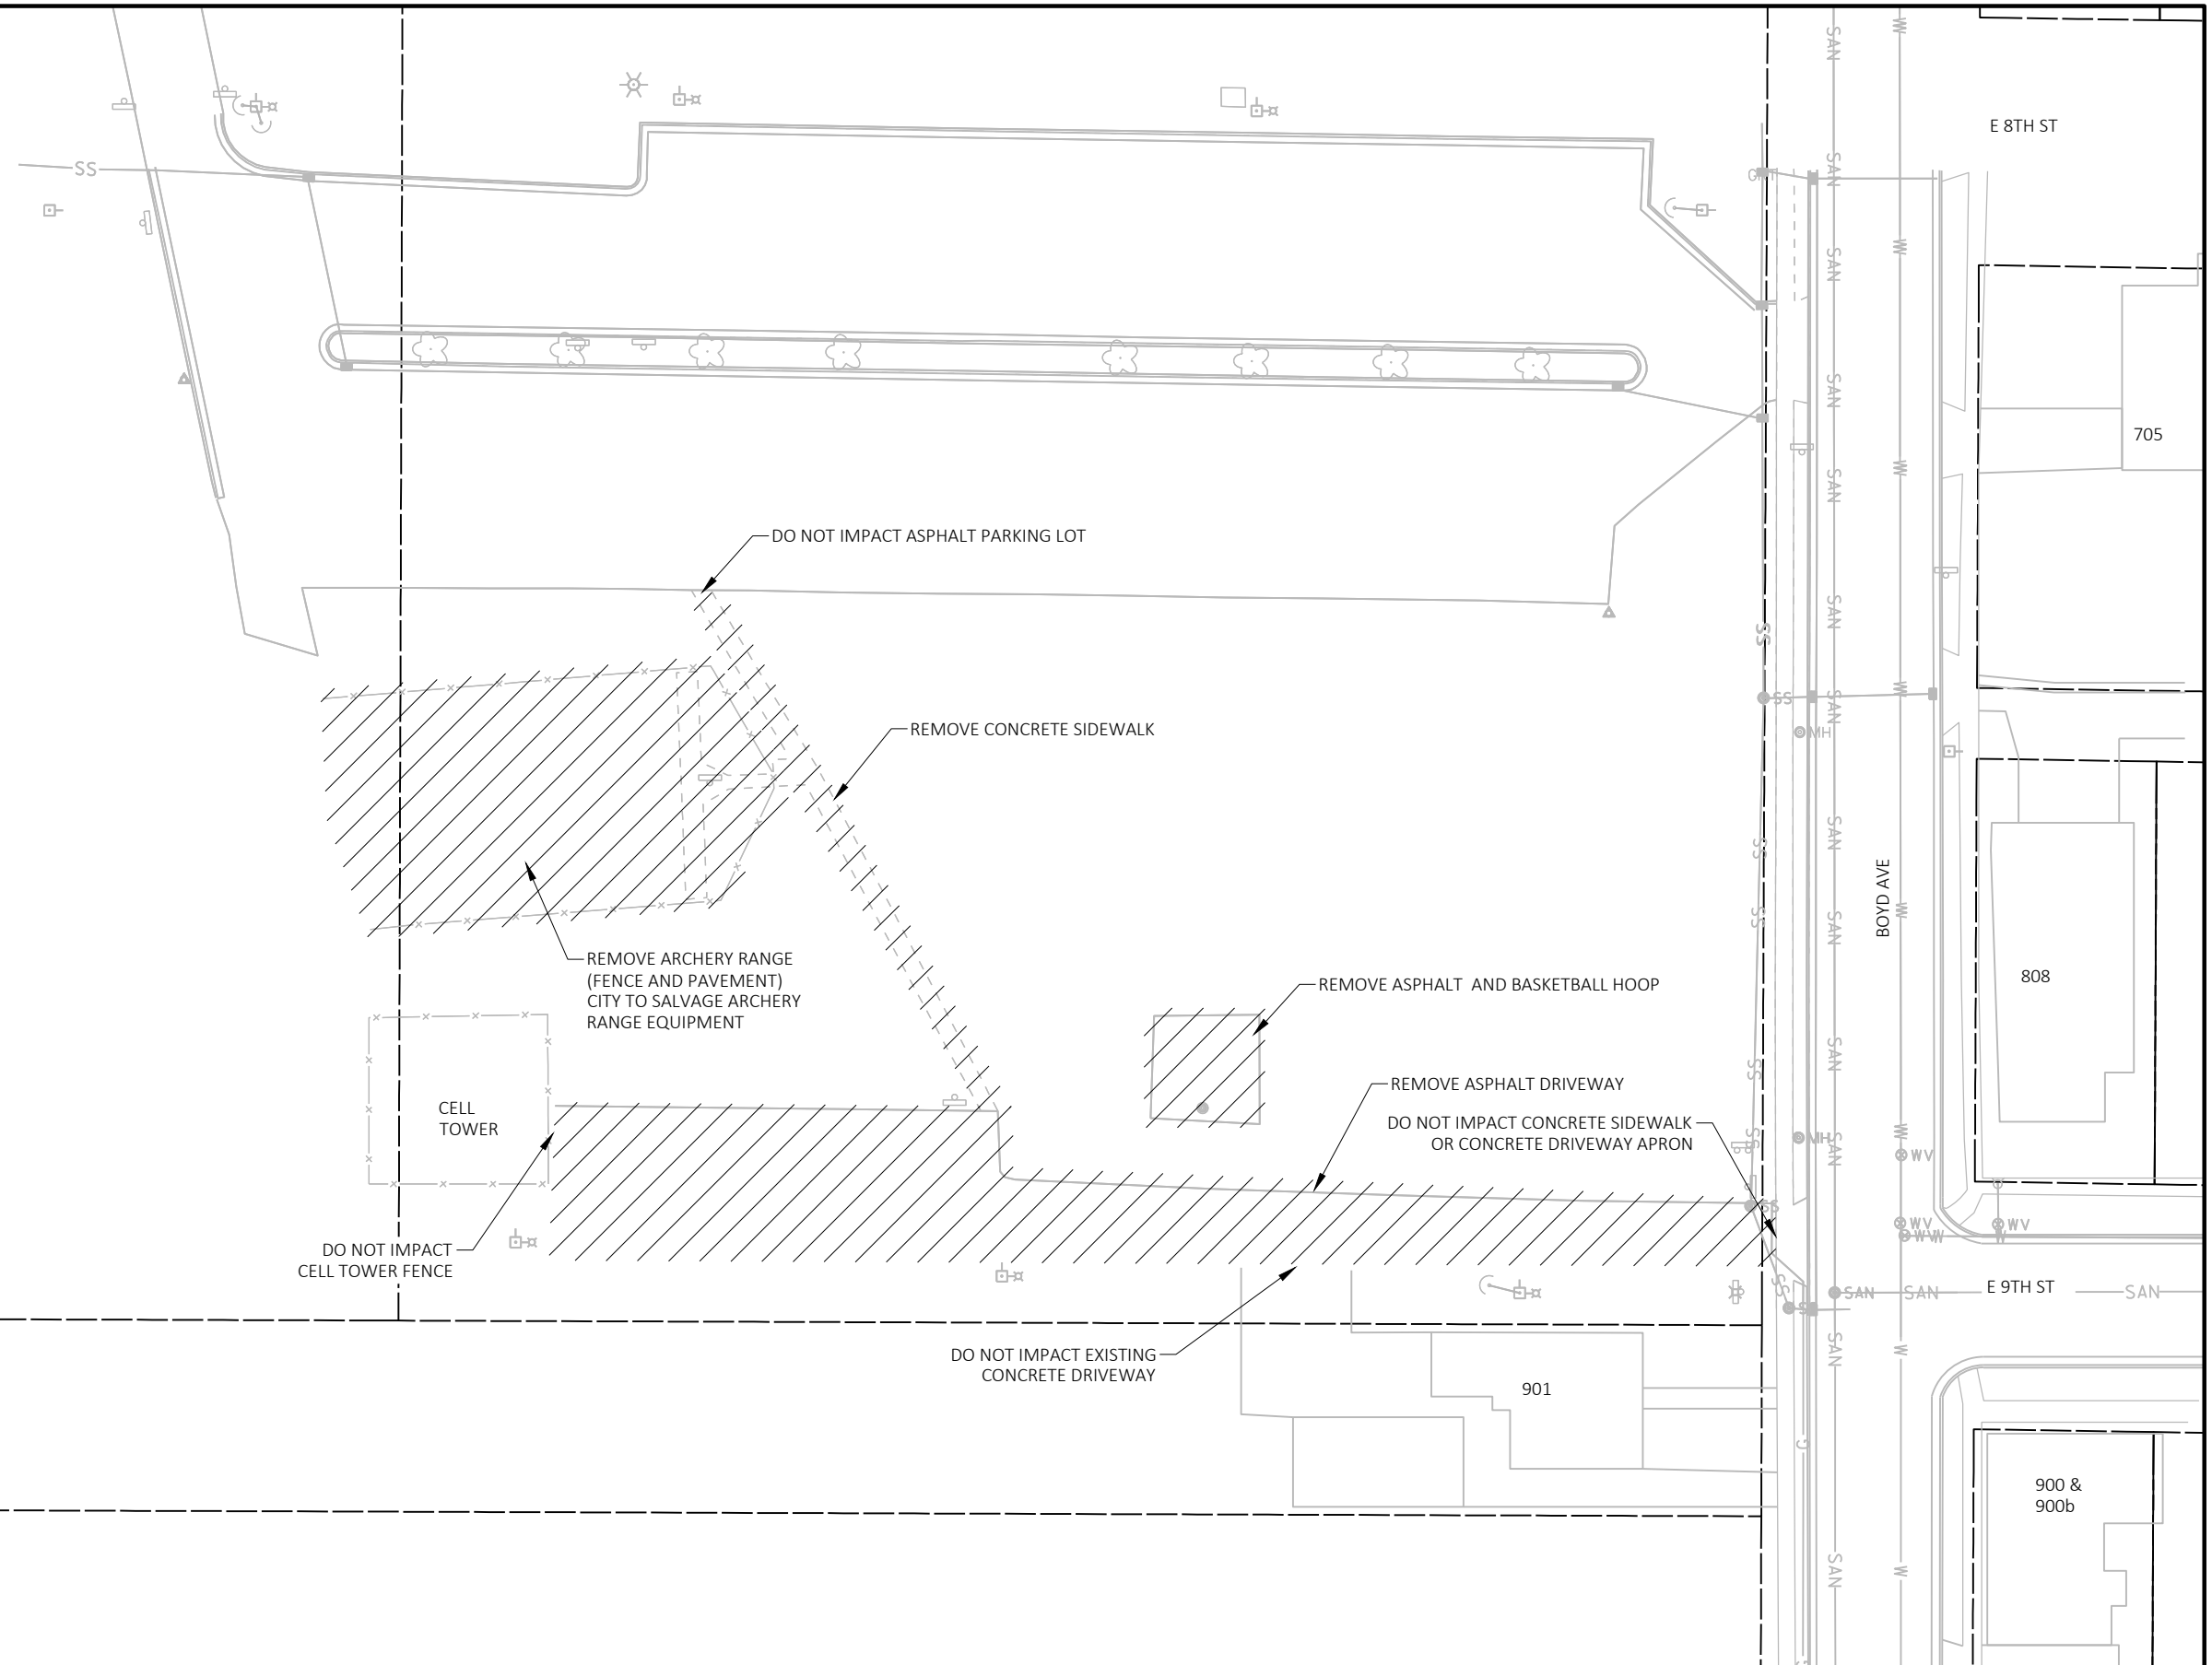

ENGINEERS - SURVEYORS - ARCHITECTS
 2500 E. Enterprise Ave., Suite A
 Appleton, WI 54913
 Phone: 920.574.3135
 www.cbssquaredinc.com


DRAWN BY:	JNW	REVISIONS
DATE:	02/11/2025	DATE: DESCRIPTION:
CHECKED BY:	JW	
HORIZ. SCALE:	1" = 50'	
VERT. SCALE:	1" = 50'	
PROJECT NO.	KAUKA-24001	

**WATER TREATMENT
 SYSTEM IMPROVEMENTS
 KAUKAUNA, WI**

**WATER TREATMENT PLANT 1
 DEMOLITION PLAN**

**SHEET
 C102**

P:\KAUKA\24001 - WATER TREATMENT SYSTEM IMPROVEMENTS\CAD\C3D\MAIN WATER TREATMENT PLANT_C110.DWG

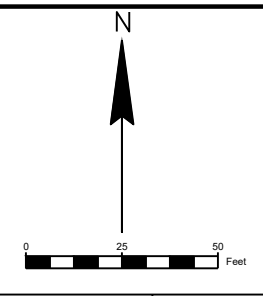

PARCEL ID:
325-821900

PARCEL ID:
325-021600

30'X45' PERMANENT UTILITY/ACCESS EASEMENT

45' WIDE PERMANENT UTILITY/ACCESS EASEMENT

WATER PARK
PARKING LOT

PROPOSED PROPERTY LINE

KANKAPOT CREEK

STORM WATER BASIN

FUTURE 0.75 MG
RESERVOIR 68' DIA

SANITARY BACKWASH
MANHOLE

CONCRETE GENERATOR PAD
ENGINE GENERATOR

SANITARY MANHOLE

CURRENT PROPERTY IS
ZONED: INSTITUTIONAL

WATER TREATMENT
PLANT 1
56'X90'

0.75 MG RESERVOIR
68' DIA

CELL
TOWER

PROPOSED PROPERTY LINE

DRIVEWAY

33' WIDE PERMANENT ACCESS EASEMENT

BOYD AVE

E 8TH ST

E 9TH ST

705

808

901

900 &
900b



ENGINEERS - SURVEYORS - ARCHITECTS
2500 E. Enterprise Ave., Suite A
Appleton, WI 54913
Phone: 920.574.3135
www.cbssquaredinc.com

DRAWN BY: JNW		REVISIONS	
DATE:	02/26/2025	DATE:	DESCRIPTION:
CHECKED BY:	JW		
HORIZ. SCALE:	1" = 50'		
VERT. SCALE:	1" = 50'		
PROJECT NO. KAUKA-24001			

**WATER TREATMENT
SYSTEM IMPROVEMENTS
KAUKAUNA, WI**

**WATER TREATMENT PLANT 1 SITE
PLAN**

SHEET
C111

P:\KAUKA\24001 - WATER TREATMENT SYSTEM IMPROVEMENTS\CAD\C3D\MAIN WATER TREATMENT PLANT_C110.DWG



cbs²
 ENGINEERS - SURVEYORS - ARCHITECTS
 2500 E. Enterprise Ave., Suite A
 Appleton, WI 54913
 Phone: 920.574.3135
 www.cbssquaredinc.com

DRAWN BY: JNW		REVISIONS	
DATE:	02/11/2025	DATE:	DESCRIPTION:
CHECKED BY:	JW		
HORIZ. SCALE:	1" = 50'		
VERT. SCALE:	1" = 50'		
PROJECT NO. KAUKA-24001			

**WATER TREATMENT
 SYSTEM IMPROVEMENTS
 KAUKAUNA, WI**

**WATER TREATMENT PLANT 1 SITE
 PLAN (AERIAL)**

SHEET
C112