


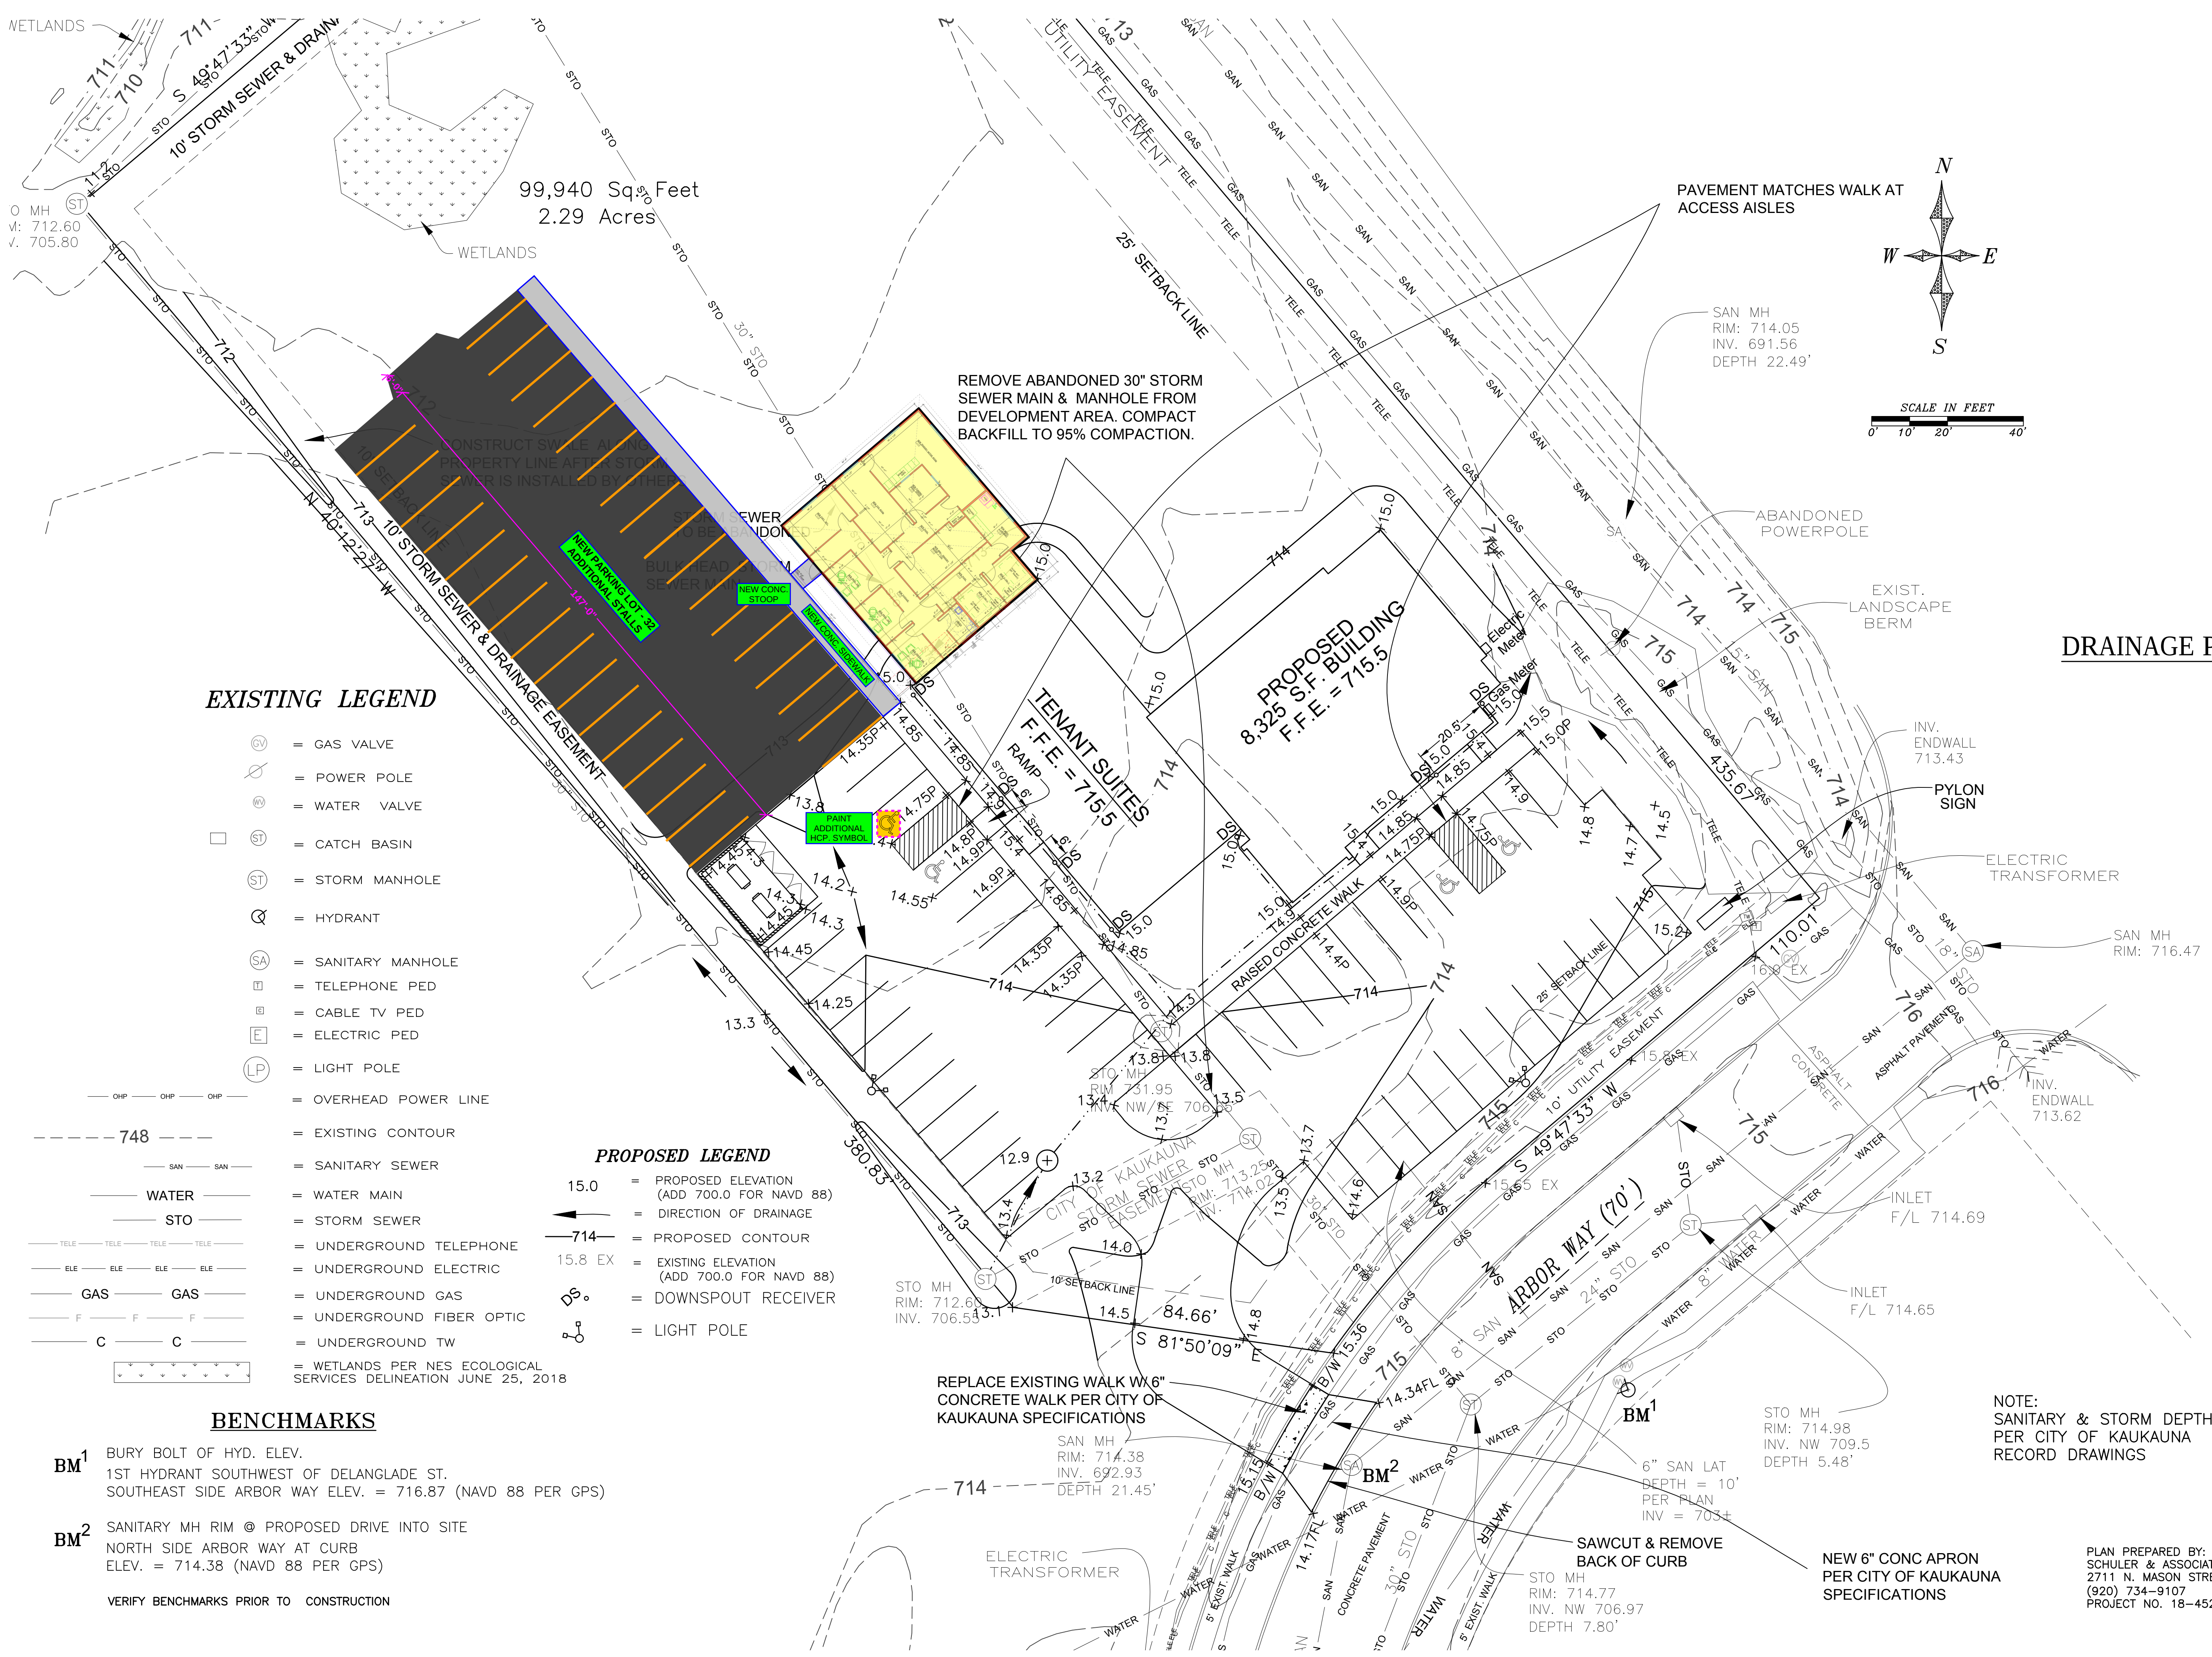

EXISTING LEGEND

- ⊙ = GAS VALVE
- ⊕ = POWER POLE
- ⊙ = WATER VALVE
- = CATCH BASIN
- ⊙ = STORM MANHOLE
- ⊙ = HYDRANT
- ⊙ = SANITARY MANHOLE
- ⊙ = TELEPHONE PED
- ⊙ = CABLE TV PED
- ⊙ = ELECTRIC PED
- ⊙ = LIGHT POLE
- OHP — OHP — OHP — = OVERHEAD POWER LINE
- 748 --- = EXISTING CONTOUR
- SAN — SAN — = SANITARY SEWER
- WATER — = WATER MAIN
- STO — = STORM SEWER
- TELE — TELE — TELE — TELE — = UNDERGROUND TELEPHONE
- ELE — ELE — ELE — ELE — = UNDERGROUND ELECTRIC
- GAS — GAS — = UNDERGROUND GAS
- F — F — F — F — = UNDERGROUND FIBER OPTIC
- C — C — = UNDERGROUND TW
- ⊙ = WETLANDS PER NES ECOLOGICAL SERVICES DELINEATION JUNE 25, 2018


PROPOSED LEGEND

- 15.0 = PROPOSED ELEVATION (ADD 700.0 FOR NAVD 88)
- = DIRECTION OF DRAINAGE
- 714 --- = PROPOSED CONTOUR
- 15.8 EX = EXISTING ELEVATION (ADD 700.0 FOR NAVD 88)
- ⊙ = DOWNSPOUT RECEIVER
- ⊙ = LIGHT POLE

BENCHMARKS

- BM¹ BURY BOLT OF HYD. ELEV. 1ST HYDRANT SOUTHWEST OF DELANGLADE ST. SOUTHEAST SIDE ARBOR WAY ELEV. = 716.87 (NAVD 88 PER GPS)
- BM² SANITARY MH RIM @ PROPOSED DRIVE INTO SITE NORTH SIDE ARBOR WAY AT CURB ELEV. = 714.38 (NAVD 88 PER GPS)
- VERIFY BENCHMARKS PRIOR TO CONSTRUCTION

DRAINAGE PLAN

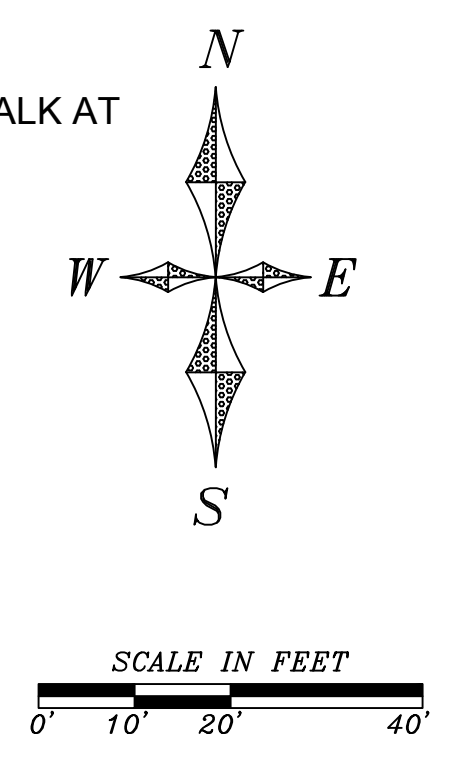

Keller
PLANNERS ARCHITECTS BUILDERS

FOX CITIES
N216 State Road 55
P.O. Box 620
Kaukauna, WI 54130
PHONE (920)766-5795
1-800-236-2534
FAX (920)766-5004

MADISON
3308 Nursery Drive
Middleton, WI 53562
PHONE (608)445-2245

MILWAUKEE
W177 N9856 Rivercrest
Dr. Suite 104
Germantown, WI 53022
PHONE (262)250-9710
1-800-236-2534
FAX (262)250-9740

WAUSAU
3600 Stewart Avenue
Suite B
Wausau, WI 54401
PHONE (715)849-3141
FAX (715)849-3181

www.kellerbuilds.com

WISCONSIN

BERKERS FAMILY DENTISTRY

KAUKAUNA

"COPYRIGHT NOTICE"
This design, drawing and detail is the copyrighted property of KELLER, INC. No part hereof shall be copied, duplicated, distributed, disclosed or made available to anyone without the expressed written consent of KELLER, INC.

REVISIONS	
6-29-2018	DOWNSPOUT COLLECTORS
7-19-2018	ISSUED FOR CONSTRUCTION

PROJECT MANAGER: _____

DESIGNER: _____

DRAWN BY: _____

EXPEDITOR: _____

SUPERVISOR: _____

PRELIMINARY NO: _____

CONTRACT NO: _____

DATE: 03.13.2013

SHEET: C1.3

PLAN PREPARED BY:
SCHULER & ASSOCIATES, INC.
2711 N. MASON STREET, SUITE F
(920) 734-9107
PROJECT NO. 18-4525