
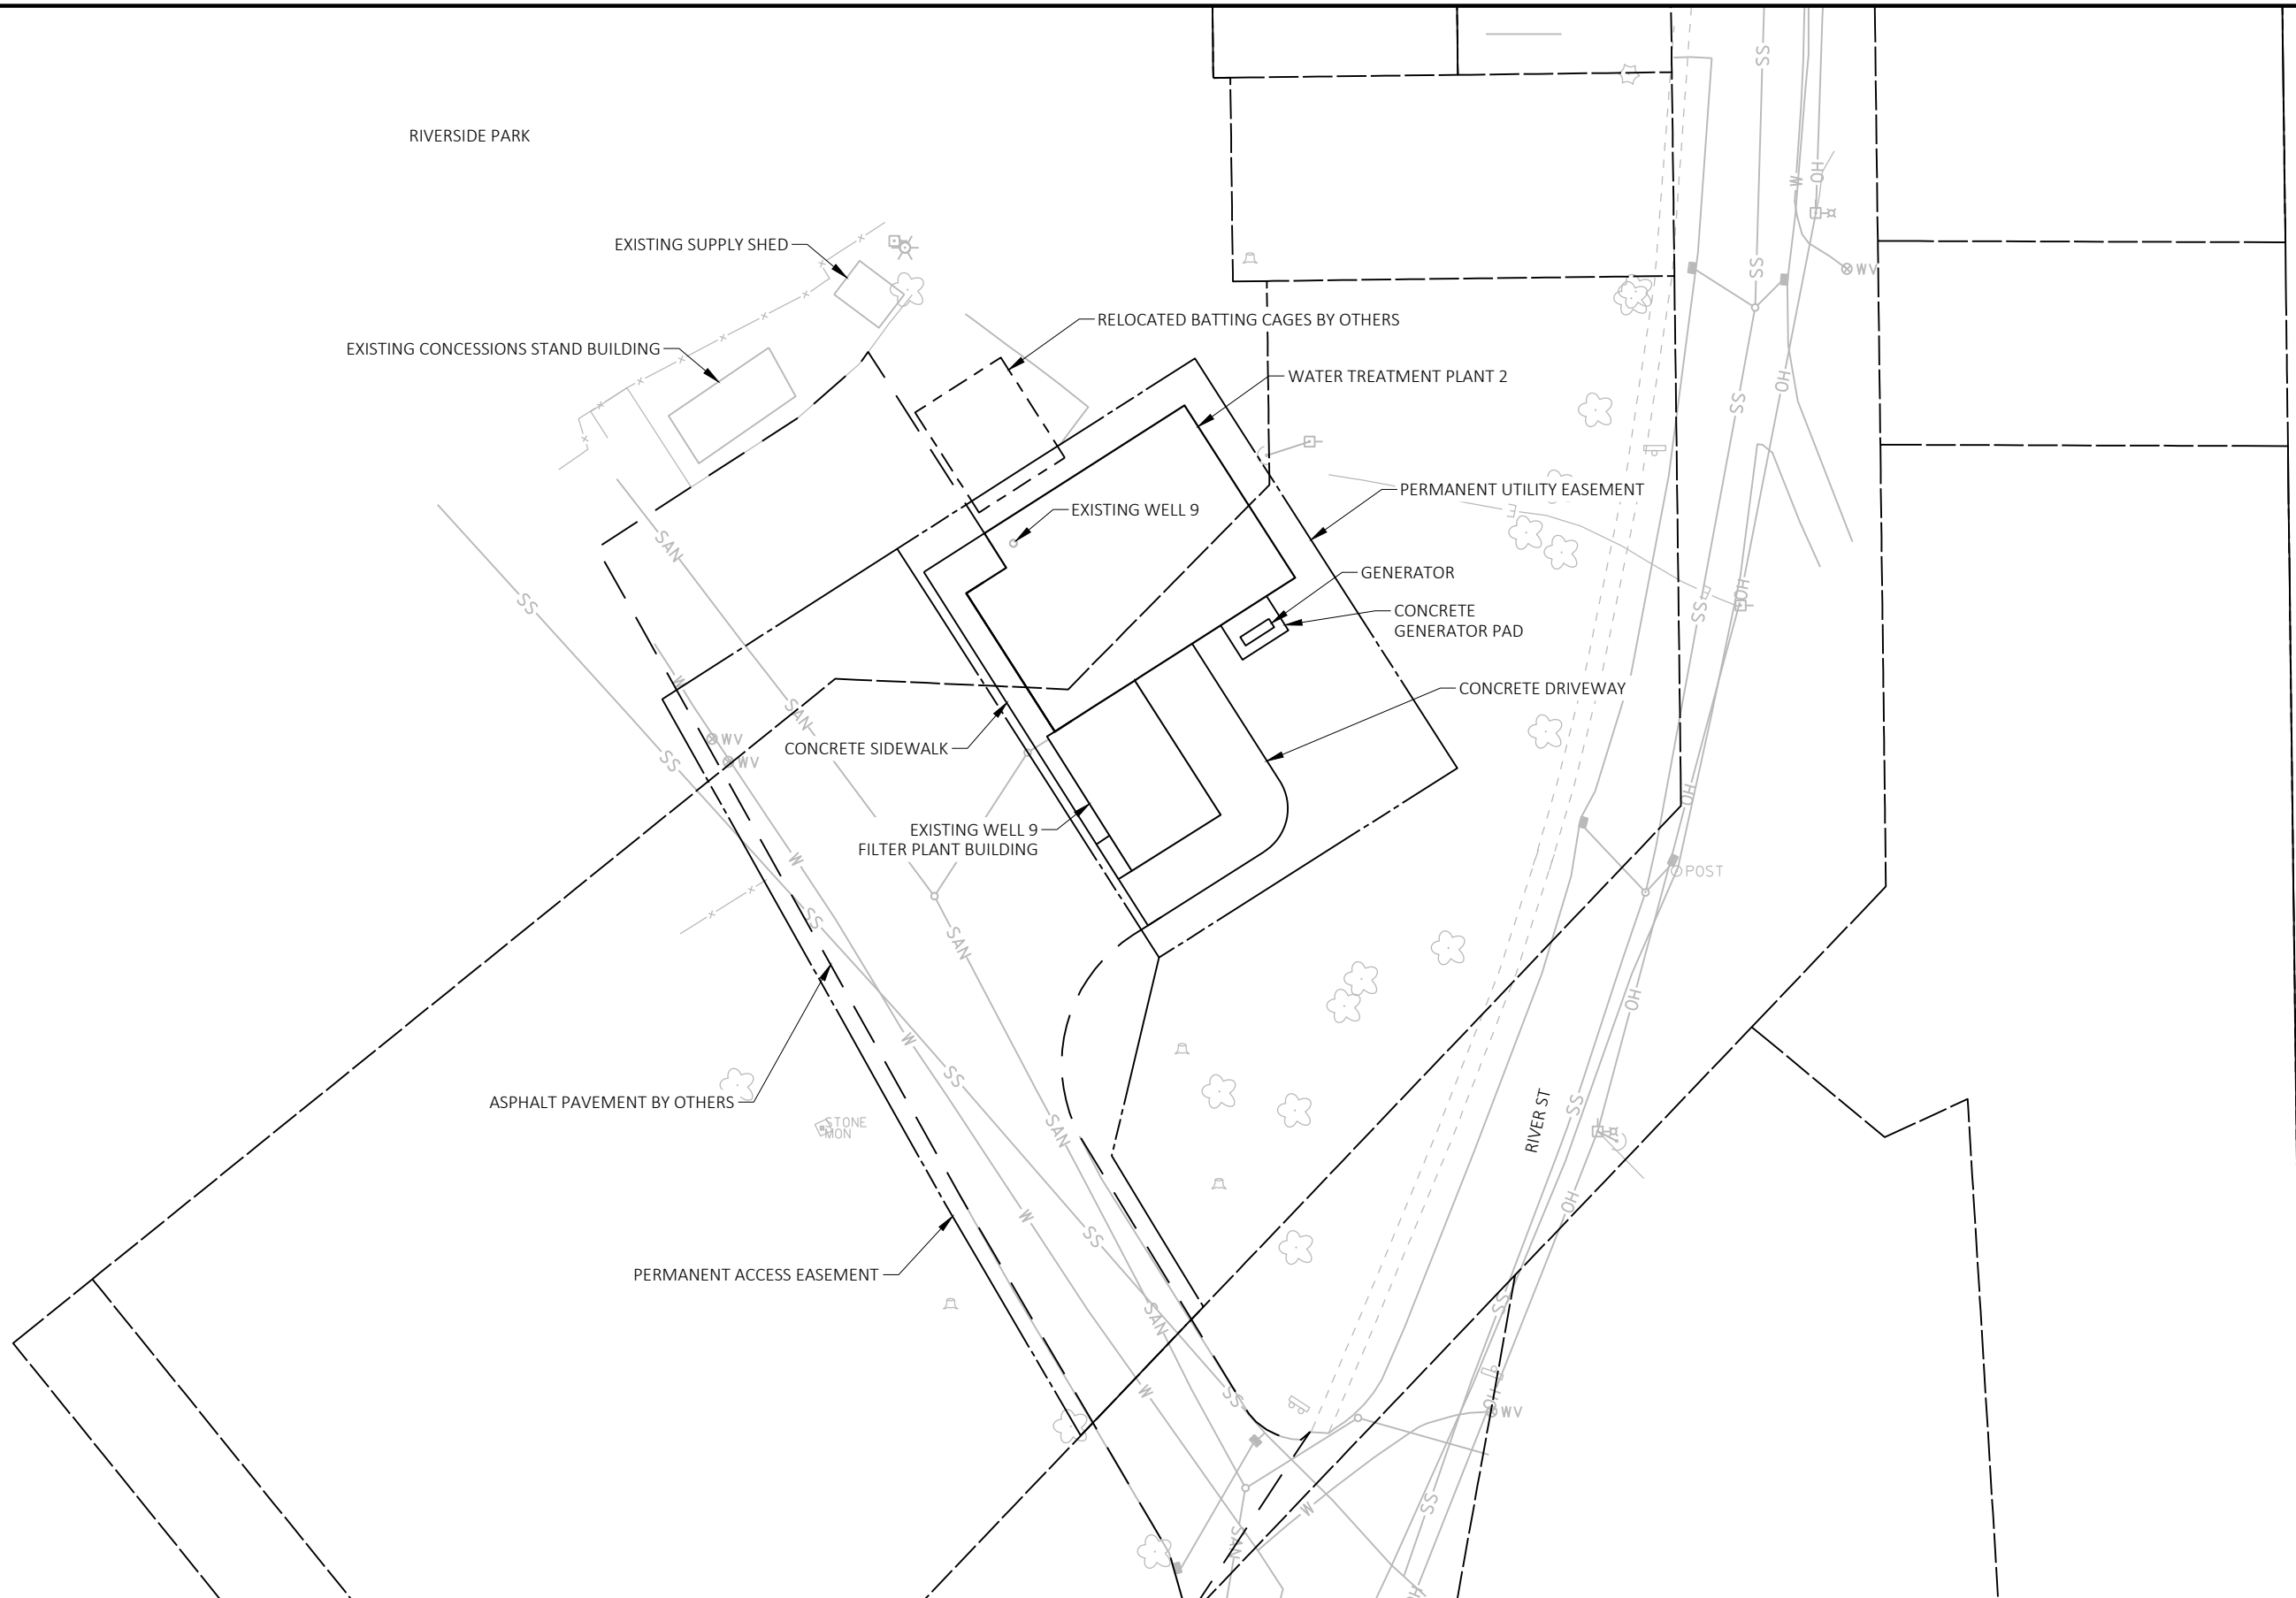


P:\KAUKA\24001 - WATER TREATMENT SYSTEM IMPROVEMENTS\CAD\C3D\WELL_9_0200 SERIES\KAUKA_24001_WATER TREATMENT PLANT 2_PROPOSED SITE_PLAN.210.DWG

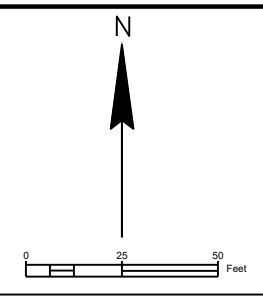

cbs²
 ENGINEERS - SURVEYORS - ARCHITECTS
 2500 E. Enterprise Ave., Suite A
 Appleton, WI 54913
 Phone: 920.574.3135
 www.cbssquaredinc.com

DRAWN BY: JNW		REVISIONS	
DATE:	02/11/2025	DATE:	DESCRIPTION:
CHECKED BY:	JW		
HORIZ. SCALE:	1" = 50'		
VERT. SCALE:	1" = 50'		
PROJECT NO. KAUKA-24001			

**WATER TREATMENT
 SYSTEM IMPROVEMENTS
 KAUKAUNA, WI**

**WATER TREATMENT PLANT 2 SITE
 PLAN**

SHEET
C211

P:\KAUKA\24001 - WATER TREATMENT SYSTEM IMPROVEMENTS\CAD\C3D\WELL_9 (200 SERIES)\KAUKA_24001_WATER TREATMENT PLANT 2_PROPOSED SITE PLAN_210.DWG



cbs²
 ENGINEERS - SURVEYORS - ARCHITECTS
 2500 E. Enterprise Ave., Suite A
 Appleton, WI 54913
 Phone: 920.574.3135
 www.cbssquaredinc.com

DRAWN BY: JNW		REVISIONS	
DATE:	02/11/2025	DATE:	DESCRIPTION:
CHECKED BY:	JW		
HORIZ. SCALE:	1" = 50'		
VERT. SCALE:	1" = 50'		
PROJECT NO. KAUKA-24001			

**WATER TREATMENT
 SYSTEM IMPROVEMENTS
 KAUKAUNA, WI**

**WATER TREATMENT PLANT 2 SITE
 PLAN WITH AERIAL**

SHEET
C212