

General Note

- 1. SEE SCHEDULE FOR LUMINAIRE MOUNTING HEIGHT.
- 2. SEE LUMINAIRE SCHEDULE FOR LIGHT LOSS FACTOR.
- 3. CALCULATIONS ARE SHOWN IN FOOTCANDLES AT:

THE ENGINEER AND/OR ARCHITECT MUST DETERMINE APPLICABILITY OF THE LAYOUT TO EXISTING / FUTURE FIELD CONDITIONS. THIS LIGHTING LAYOUT REPRESENTS ILLUMINATION LEVELS CALCULATED FROM LABORATORY DATA TAKEN UNDER CONTROLLED CONDITIONS IN ACCORDANCE WITH ILLUMINATING ENGINEERING SOCIETY APPROVED METHODS. ACTUAL PERFORMANCE OF ANY MANUFACTURER'S LUMINAIRE MAY VARY DUE TO VARIATION IN ELECTRICAL VOLTAGE, TOLERANCE IN LAMPS, AND OTHER VARIABLE FIELD CONDITIONS. MOUNTING HEIGHTS INDICATED ARE FROM GRADE AND/OR FLOOR UP.

THESE LIGHTING CALCULATIONS ARE NOT A SUBSTITUTE FOR INDEPENDENT ENGINEERING ANALYSIS OF LIGHTING SYSTEM SUITABILITY AND SAFETY. THE ENGINEER AND/OR ARCHITECT IS RESPONSIBLE TO REVIEW FOR MICHIGAN ENERGY CODE AND LIGHTING QUALITY COMPLIANCE.

UNLESS EXEMPT, PROJECT MUST COMPLY WITH LIGHTING CONTROLS REQUIRMENTS DEFINED IN ASHRAE 90.1 2019. FOR SPECIFIC INFORMATION CONTACT GBA CONTROLS GROUP AT CONTROLS@GASSERBUSH.COM OR 734-266-6705.

Alternates Note

THE USE OF FIXTURE ALTERNATES MUST BE RESUBMITTED TO THE CITY FOR APPROVAL.

Drawing Note

THIS DRAWING WAS GENERATED FROM AN ELECTRONIC IMAGE FOR ESTIMATION PURPOSE ONLY. LAYOUT TO BE VERIFIED IN FIELD BY OTHERS.

Ordering Note


FOR INQUIRIES CONTACT GASSER BUSH AT QUOTES@GASSERBUSH.COM OR 734-266-6705.

Mounting Height Note

MOUNTING HEIGHT IS MEASURED FROM GRADE TO FACE OF FIXTURE. POLE HEIGHT SHOULD BE CALCULATED AS THE MOUNTING HEIGHT LESS BASE HEIGHT.


Statistics

Description	Symbol	Avg	Max	Min	Max/Min	Avg/Min
Overall/Grade	+	0.3 fc	45.5 fc	0.0 fc	N/A	N/A
Parking & Drive Lanes	✖	1.5 fc	2.9 fc	0.0 fc	N/A	N/A
Property Line	+	0.0 fc	0.0 fc	0.0 fc	N/A	N/A

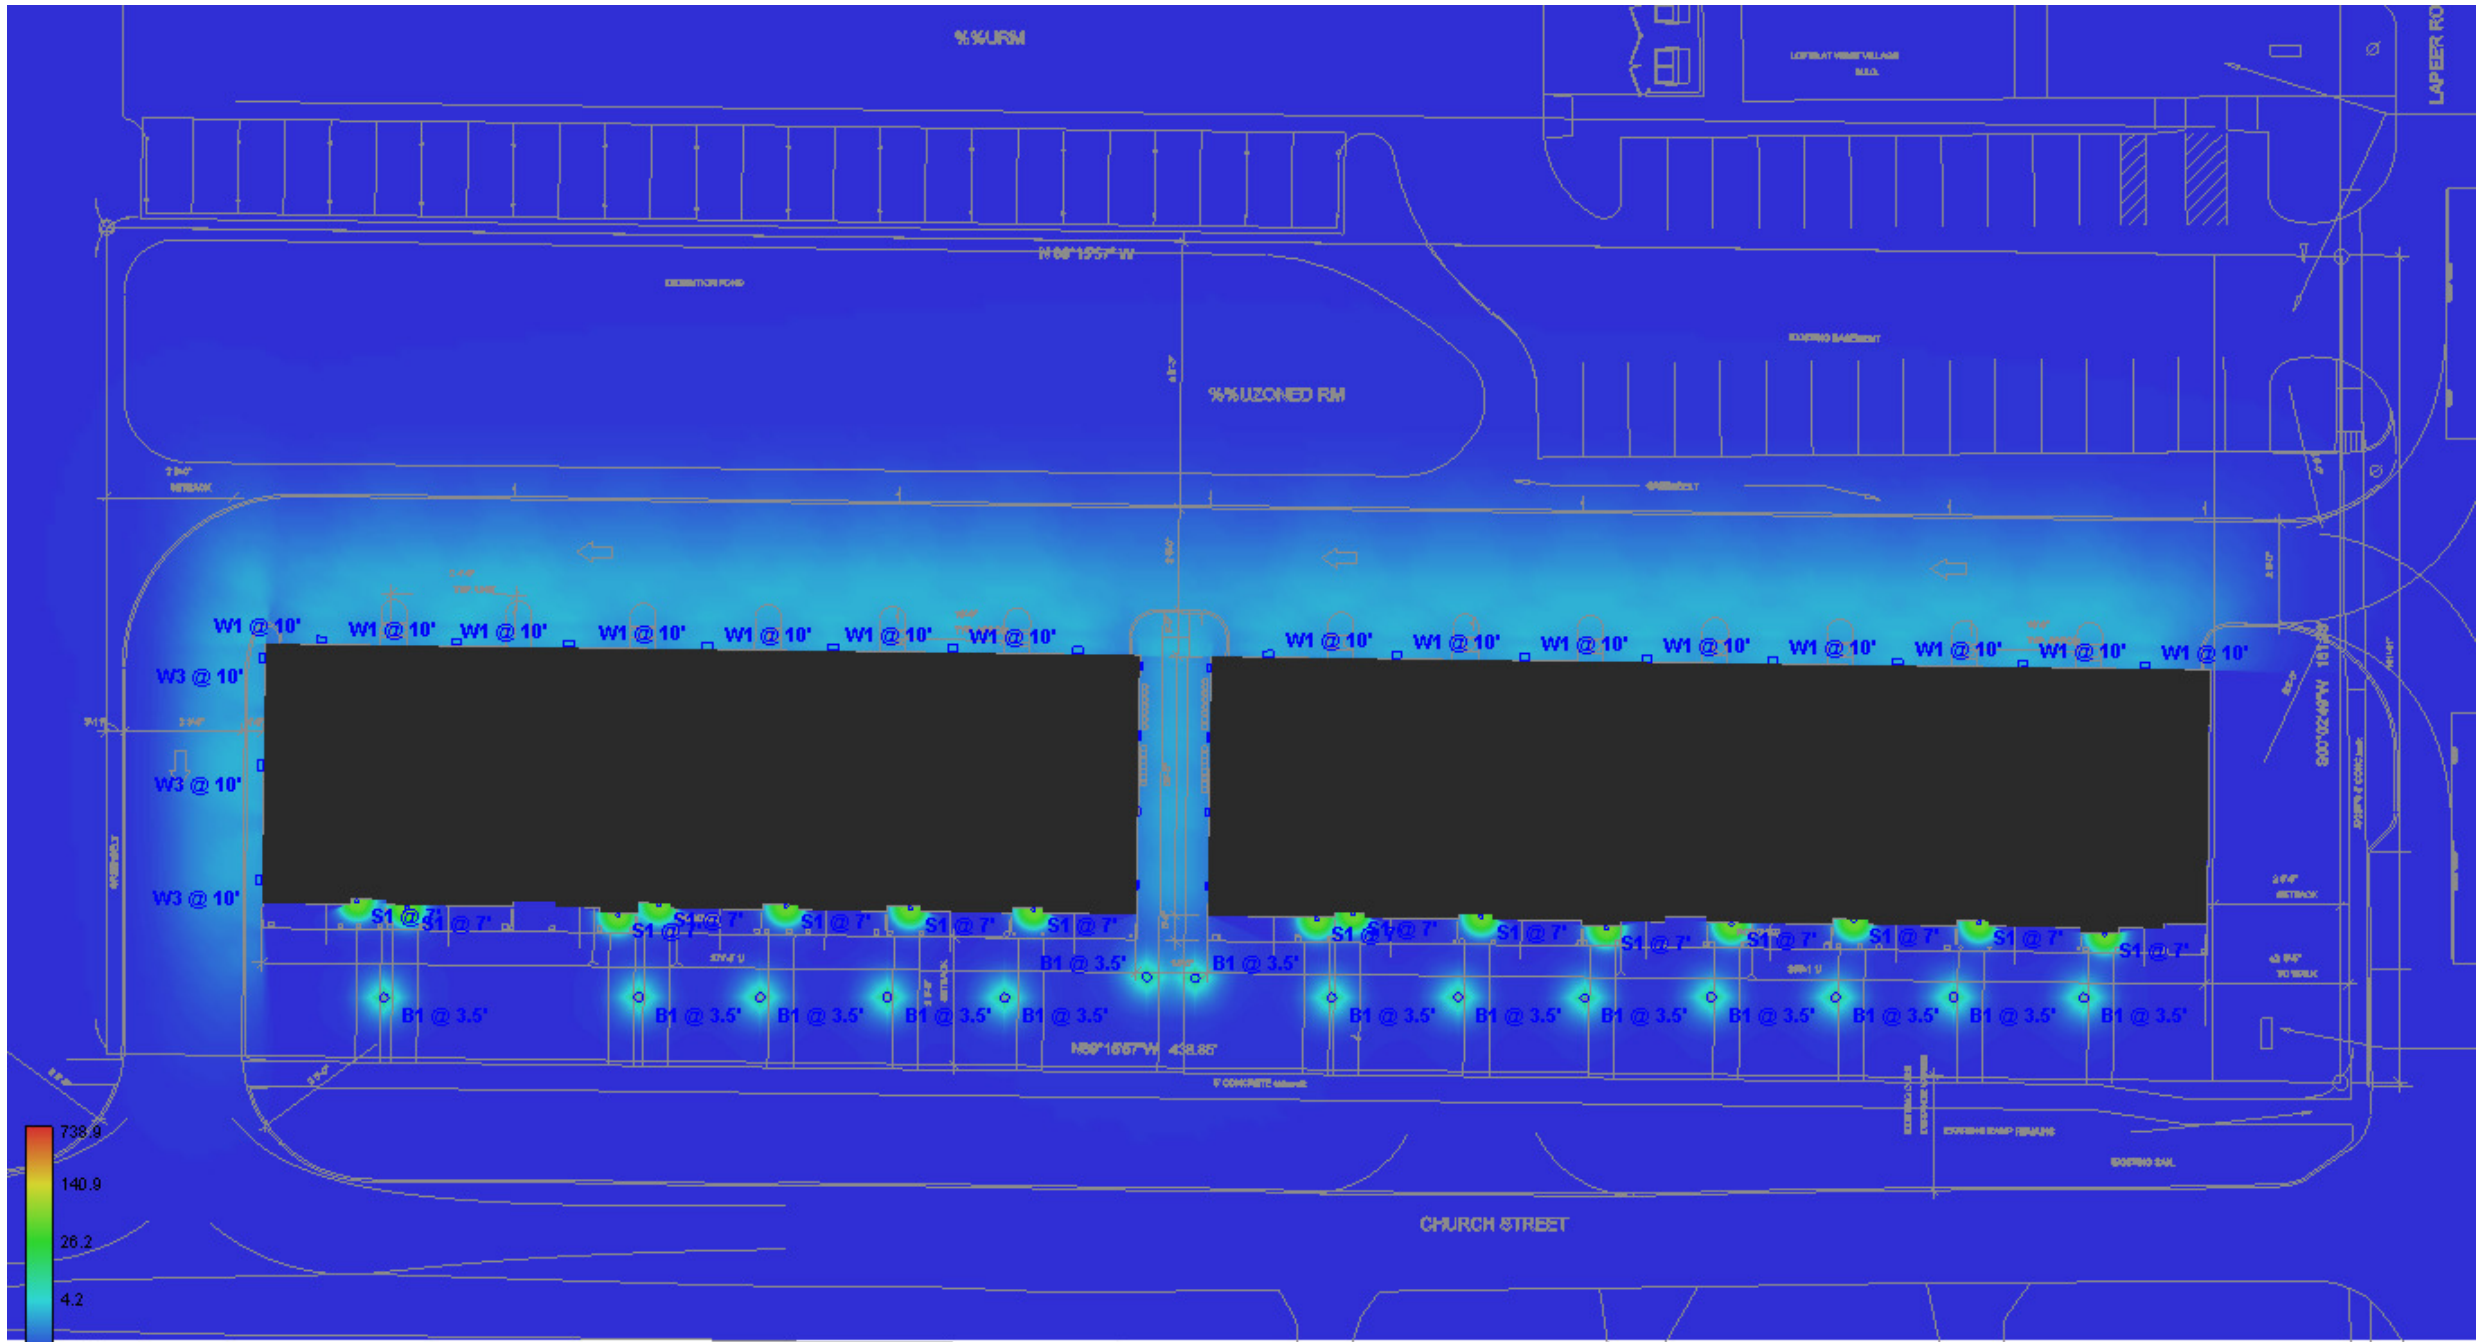

Plan View Pseudo

Schedule								
Symbol	Label	QTY	Manufacturer	Catalog Number	Description	Lumens per Lamp	LLF	Wattage
○	B1	14	Lithonia Lighting	RADB LED P1 40K SYM DDBXD	RADB LED P1 40K SYM DDBXD	331	0.9	5.21
□	W1	15	Lithonia Lighting	WDGE2 LED P2 40K 80CRI TFTM	WDGE2 LED WITH P2 - PERFORMANCE PACKAGE, 4000K, 80CRI, TYPE FORWARD THROW MEDIUM OPTIC	2030	0.9	18.9815
▭	W2	8	BEGA	33 509 K4	33 509 K4	923	0.9	13
▭	W3	3	Lithonia Lighting	WDGE2 LED P1 40K 80CRI T2M	WDGE2 LED WITH P1 - PERFORMANCE PACKAGE, 4000K, 80CRI, TYPE 2 MEDIUM OPTIC	1264	0.9	11.1658
○	S1	15	KUZCO LIGHTING	LD3-WS09W14-3036-BK-UNV-010	CYLINDER	1290	0.9	14.8

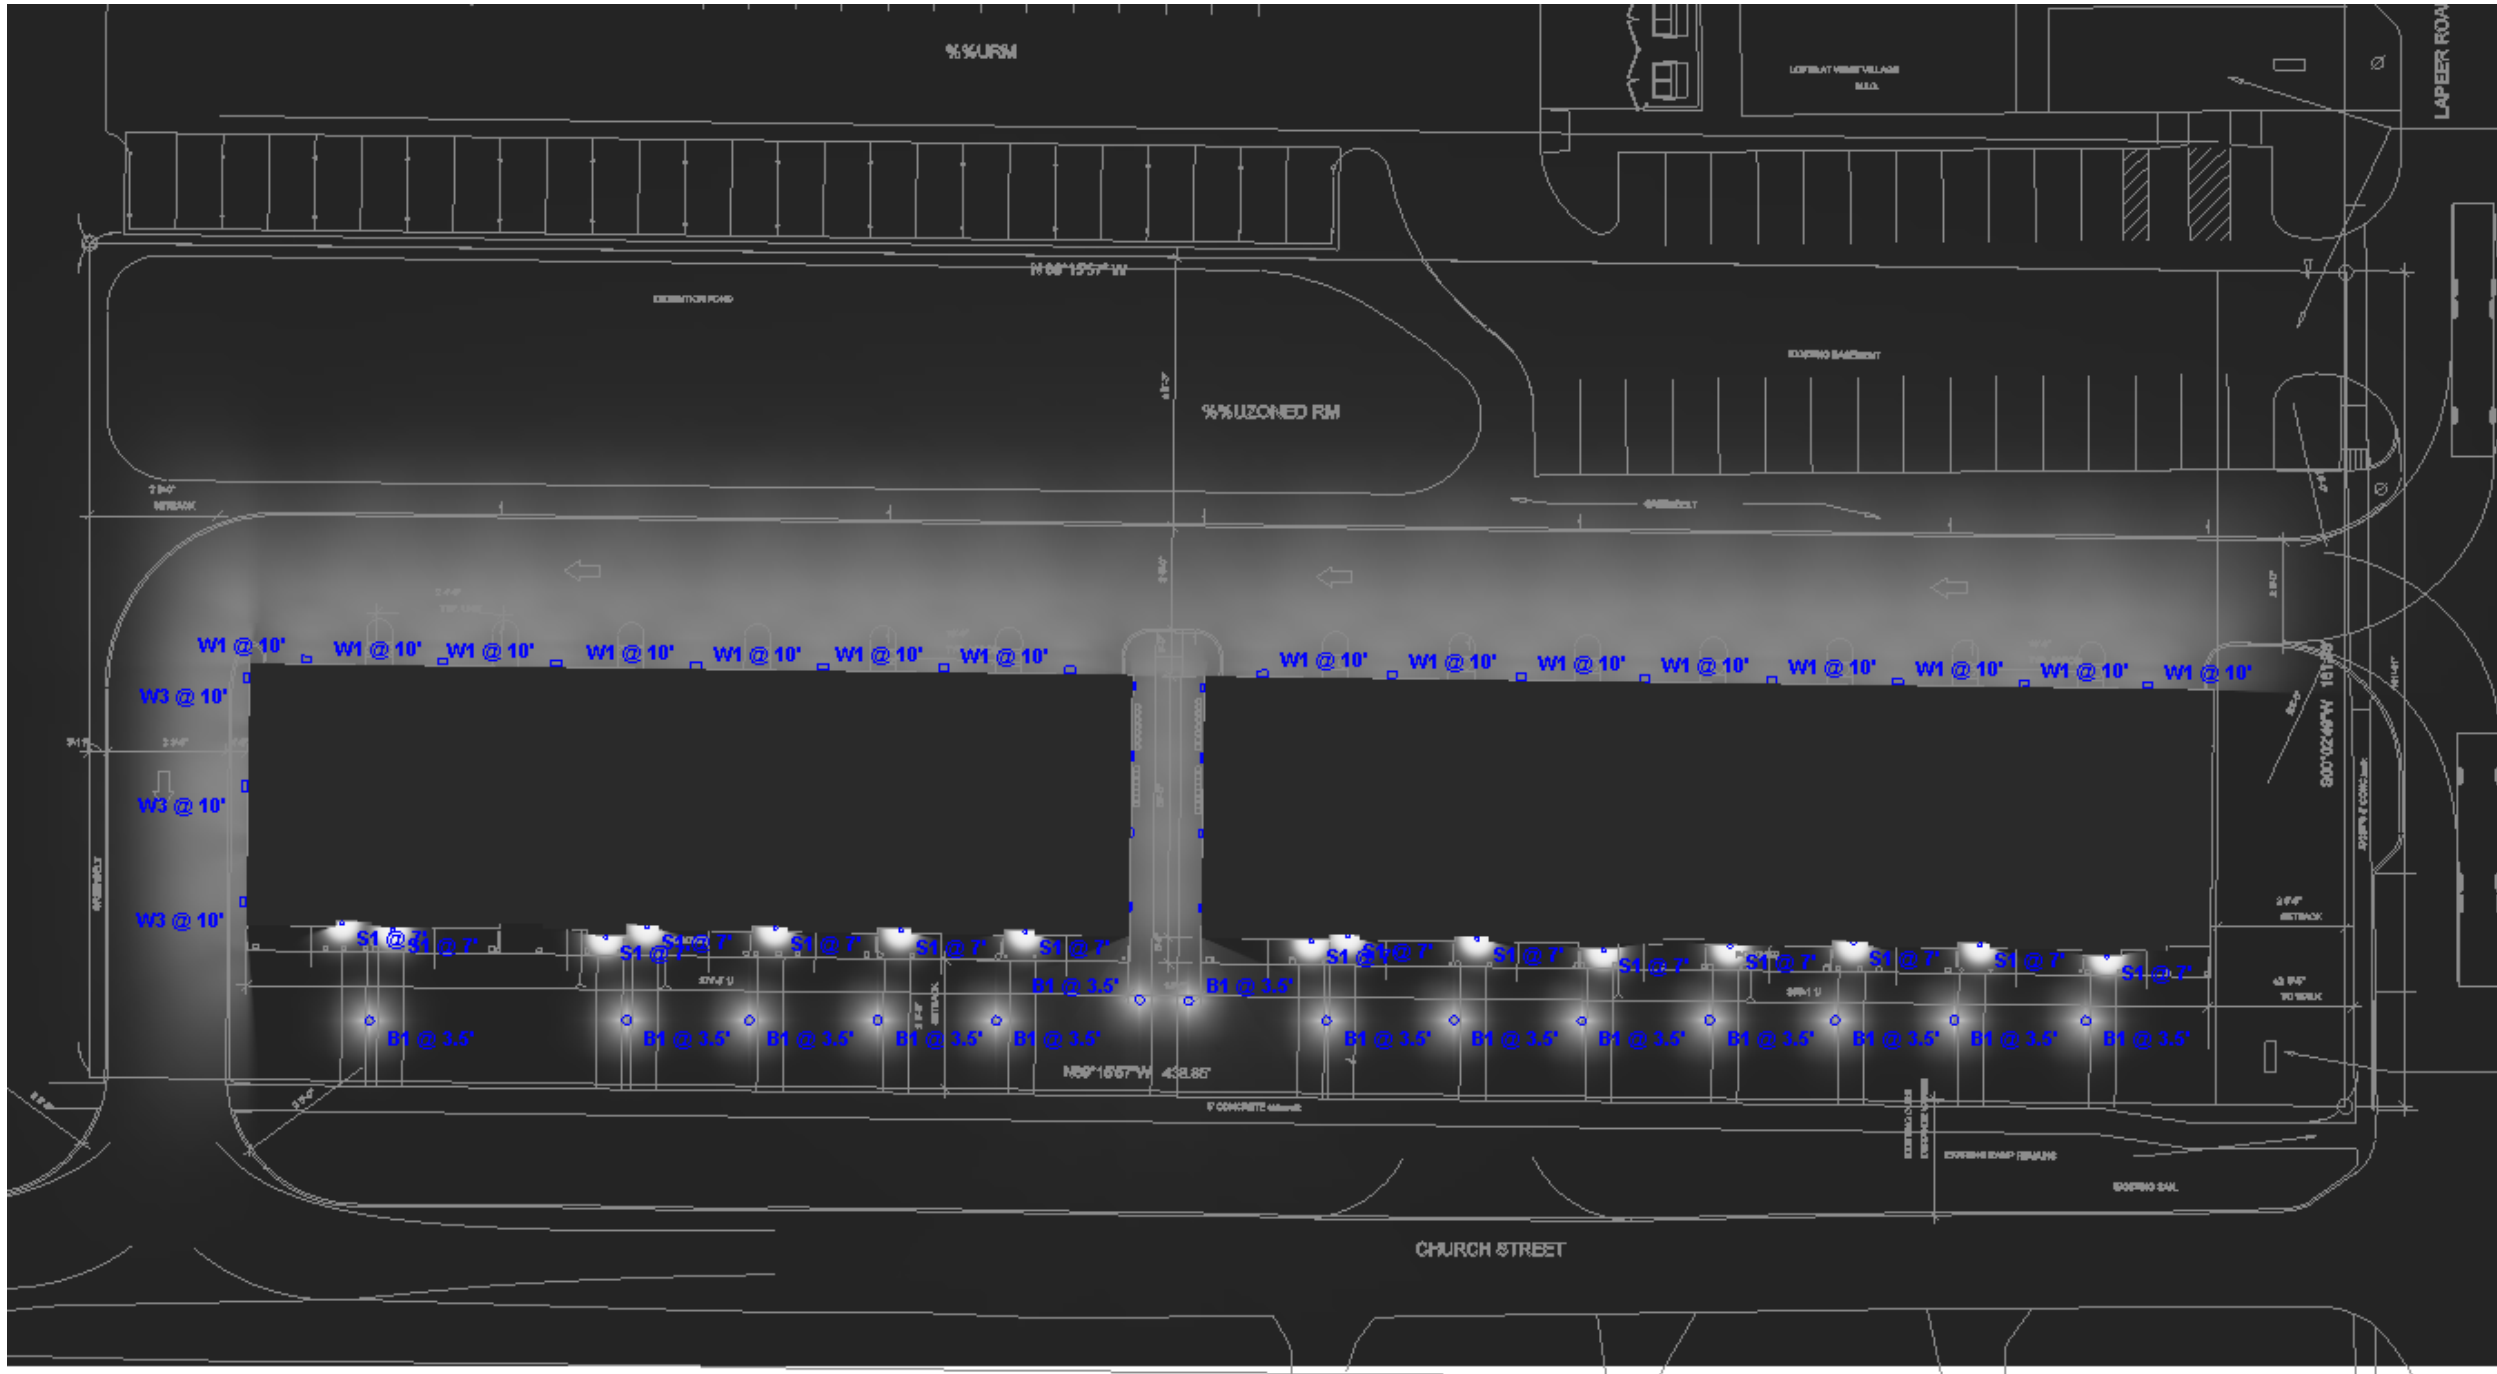

Plan View Rendered


Plan View

Scale - 1" = 25ft




WEST VILLAGE RESIDENCE
EXTERIOR PHOTOMETRIC PLAN
GASSER BUSH ASSOCIATES
WWW.GASSERBUSH.COM


Designer
BK
Date
06/23/2026
Scale
Not to Scale
Drawing No.
#25-46696 V6

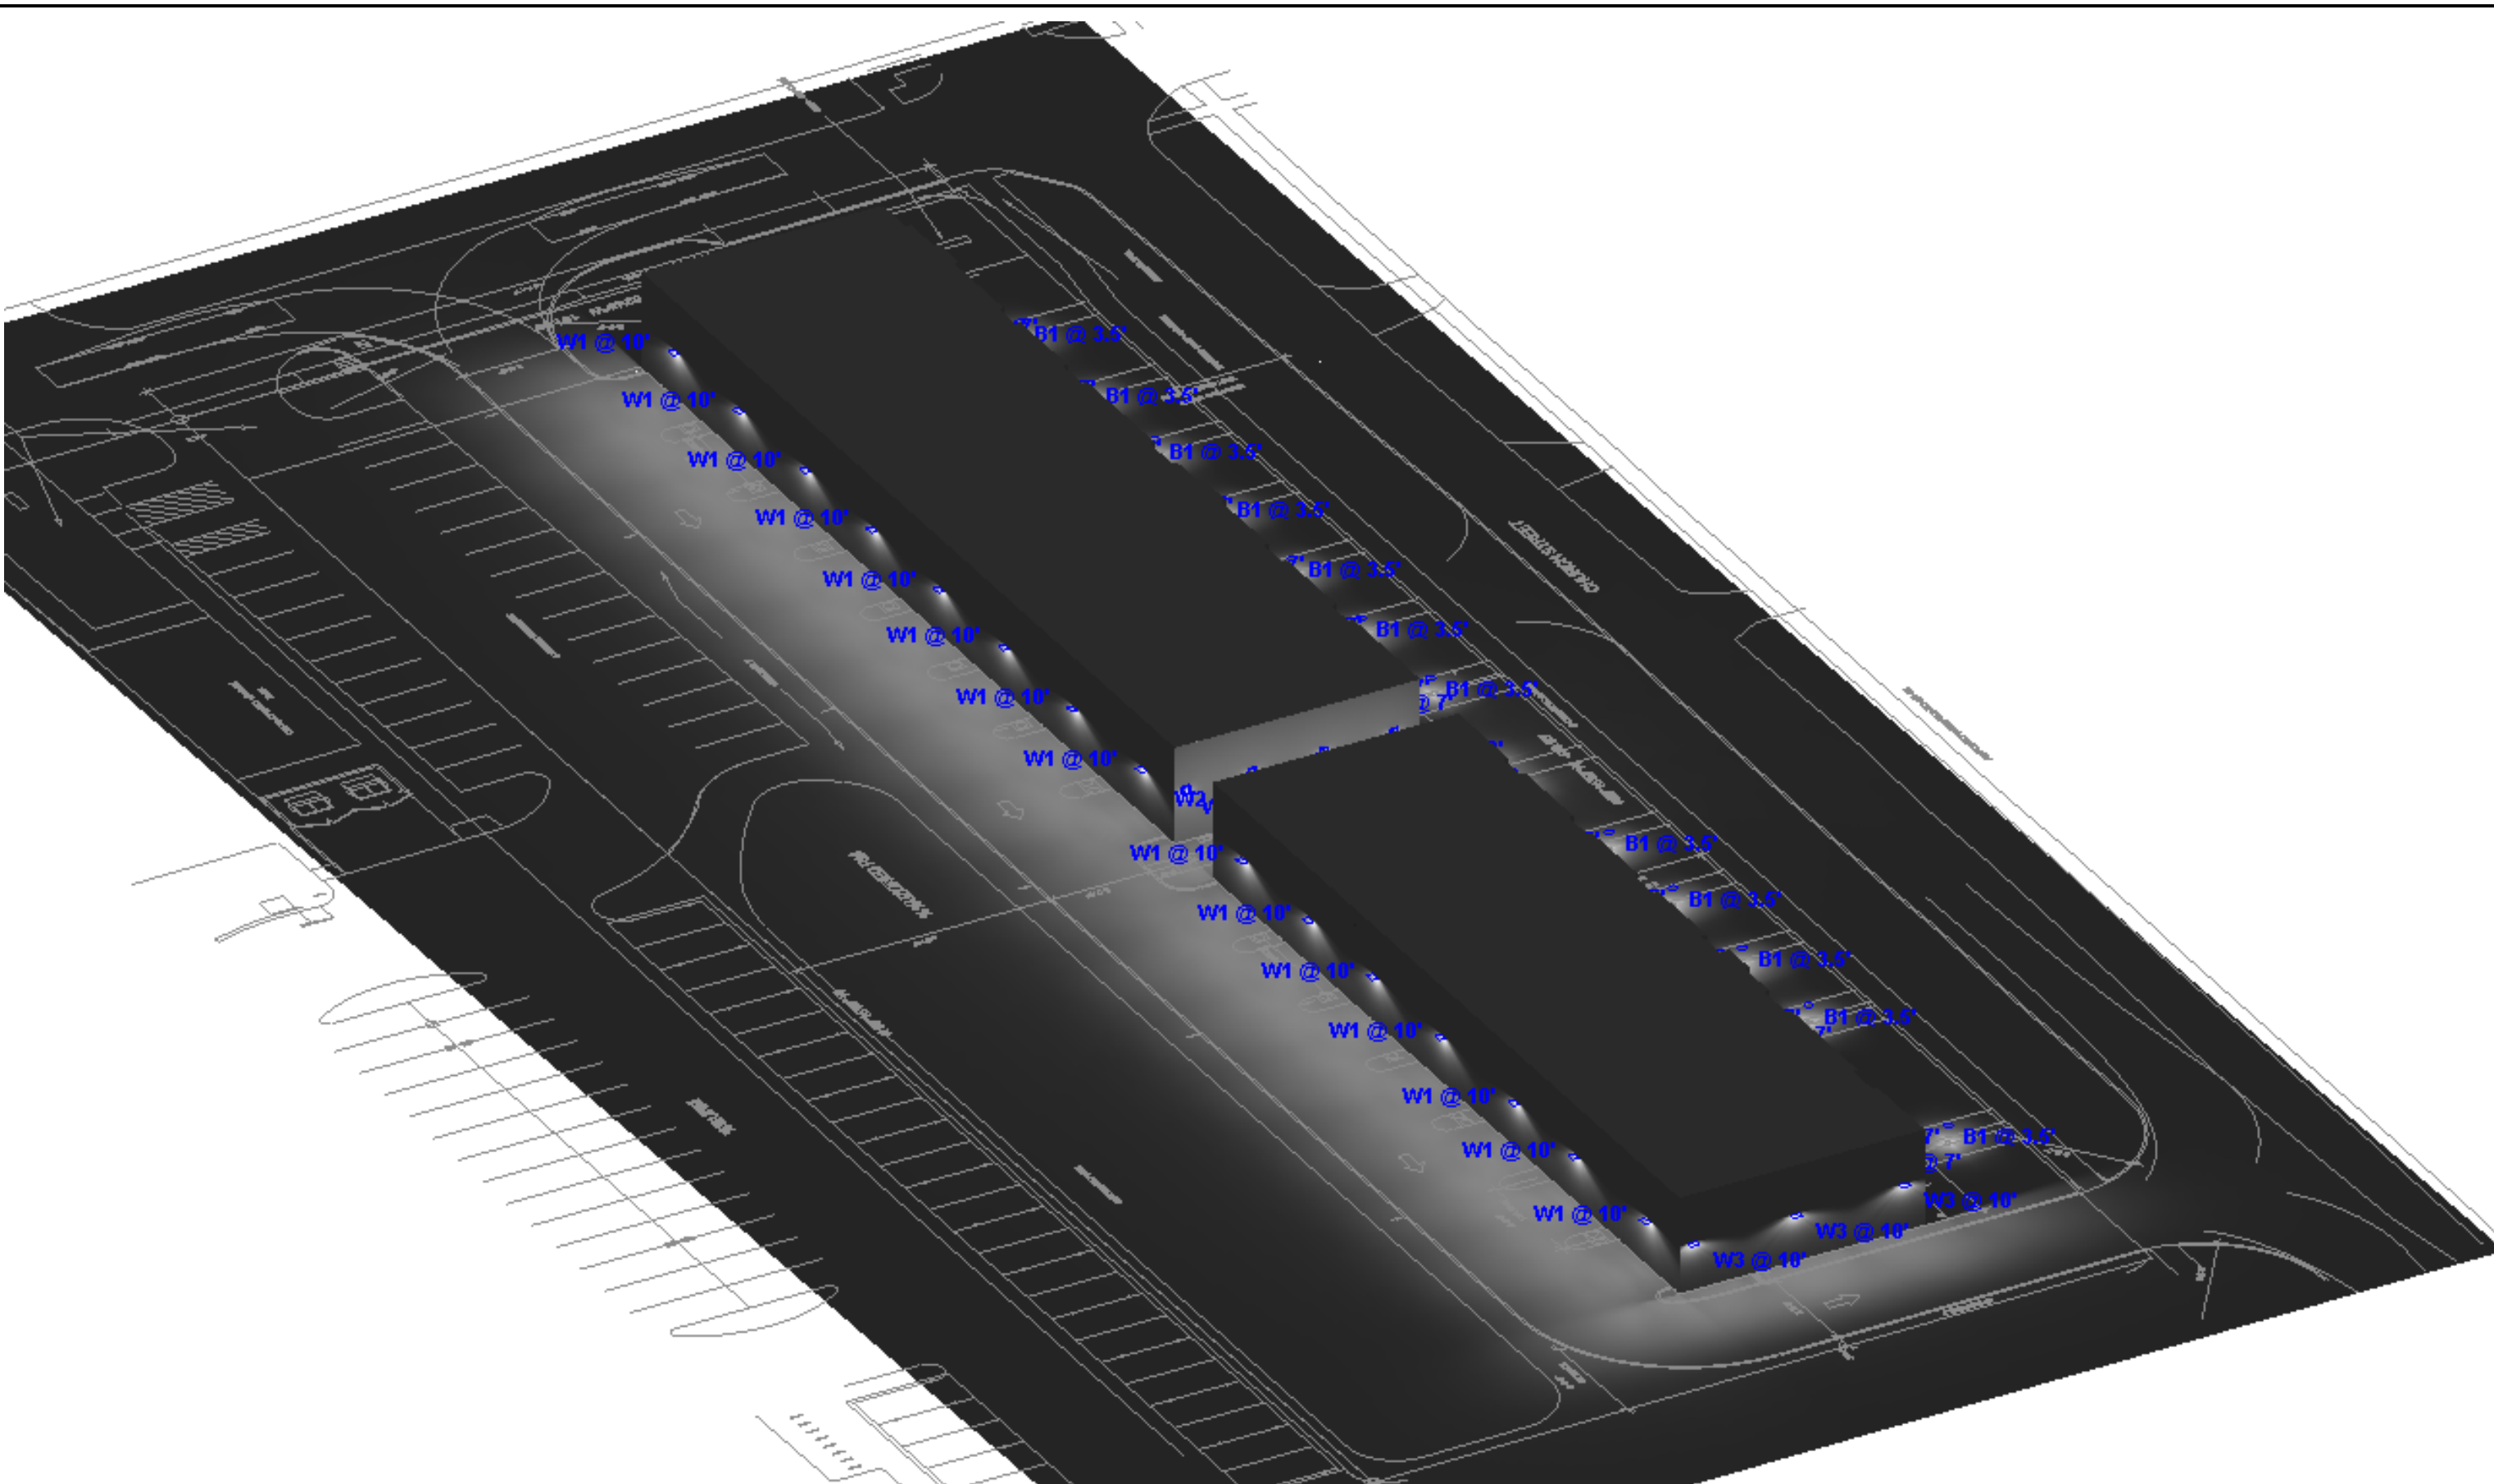


NW Rendered

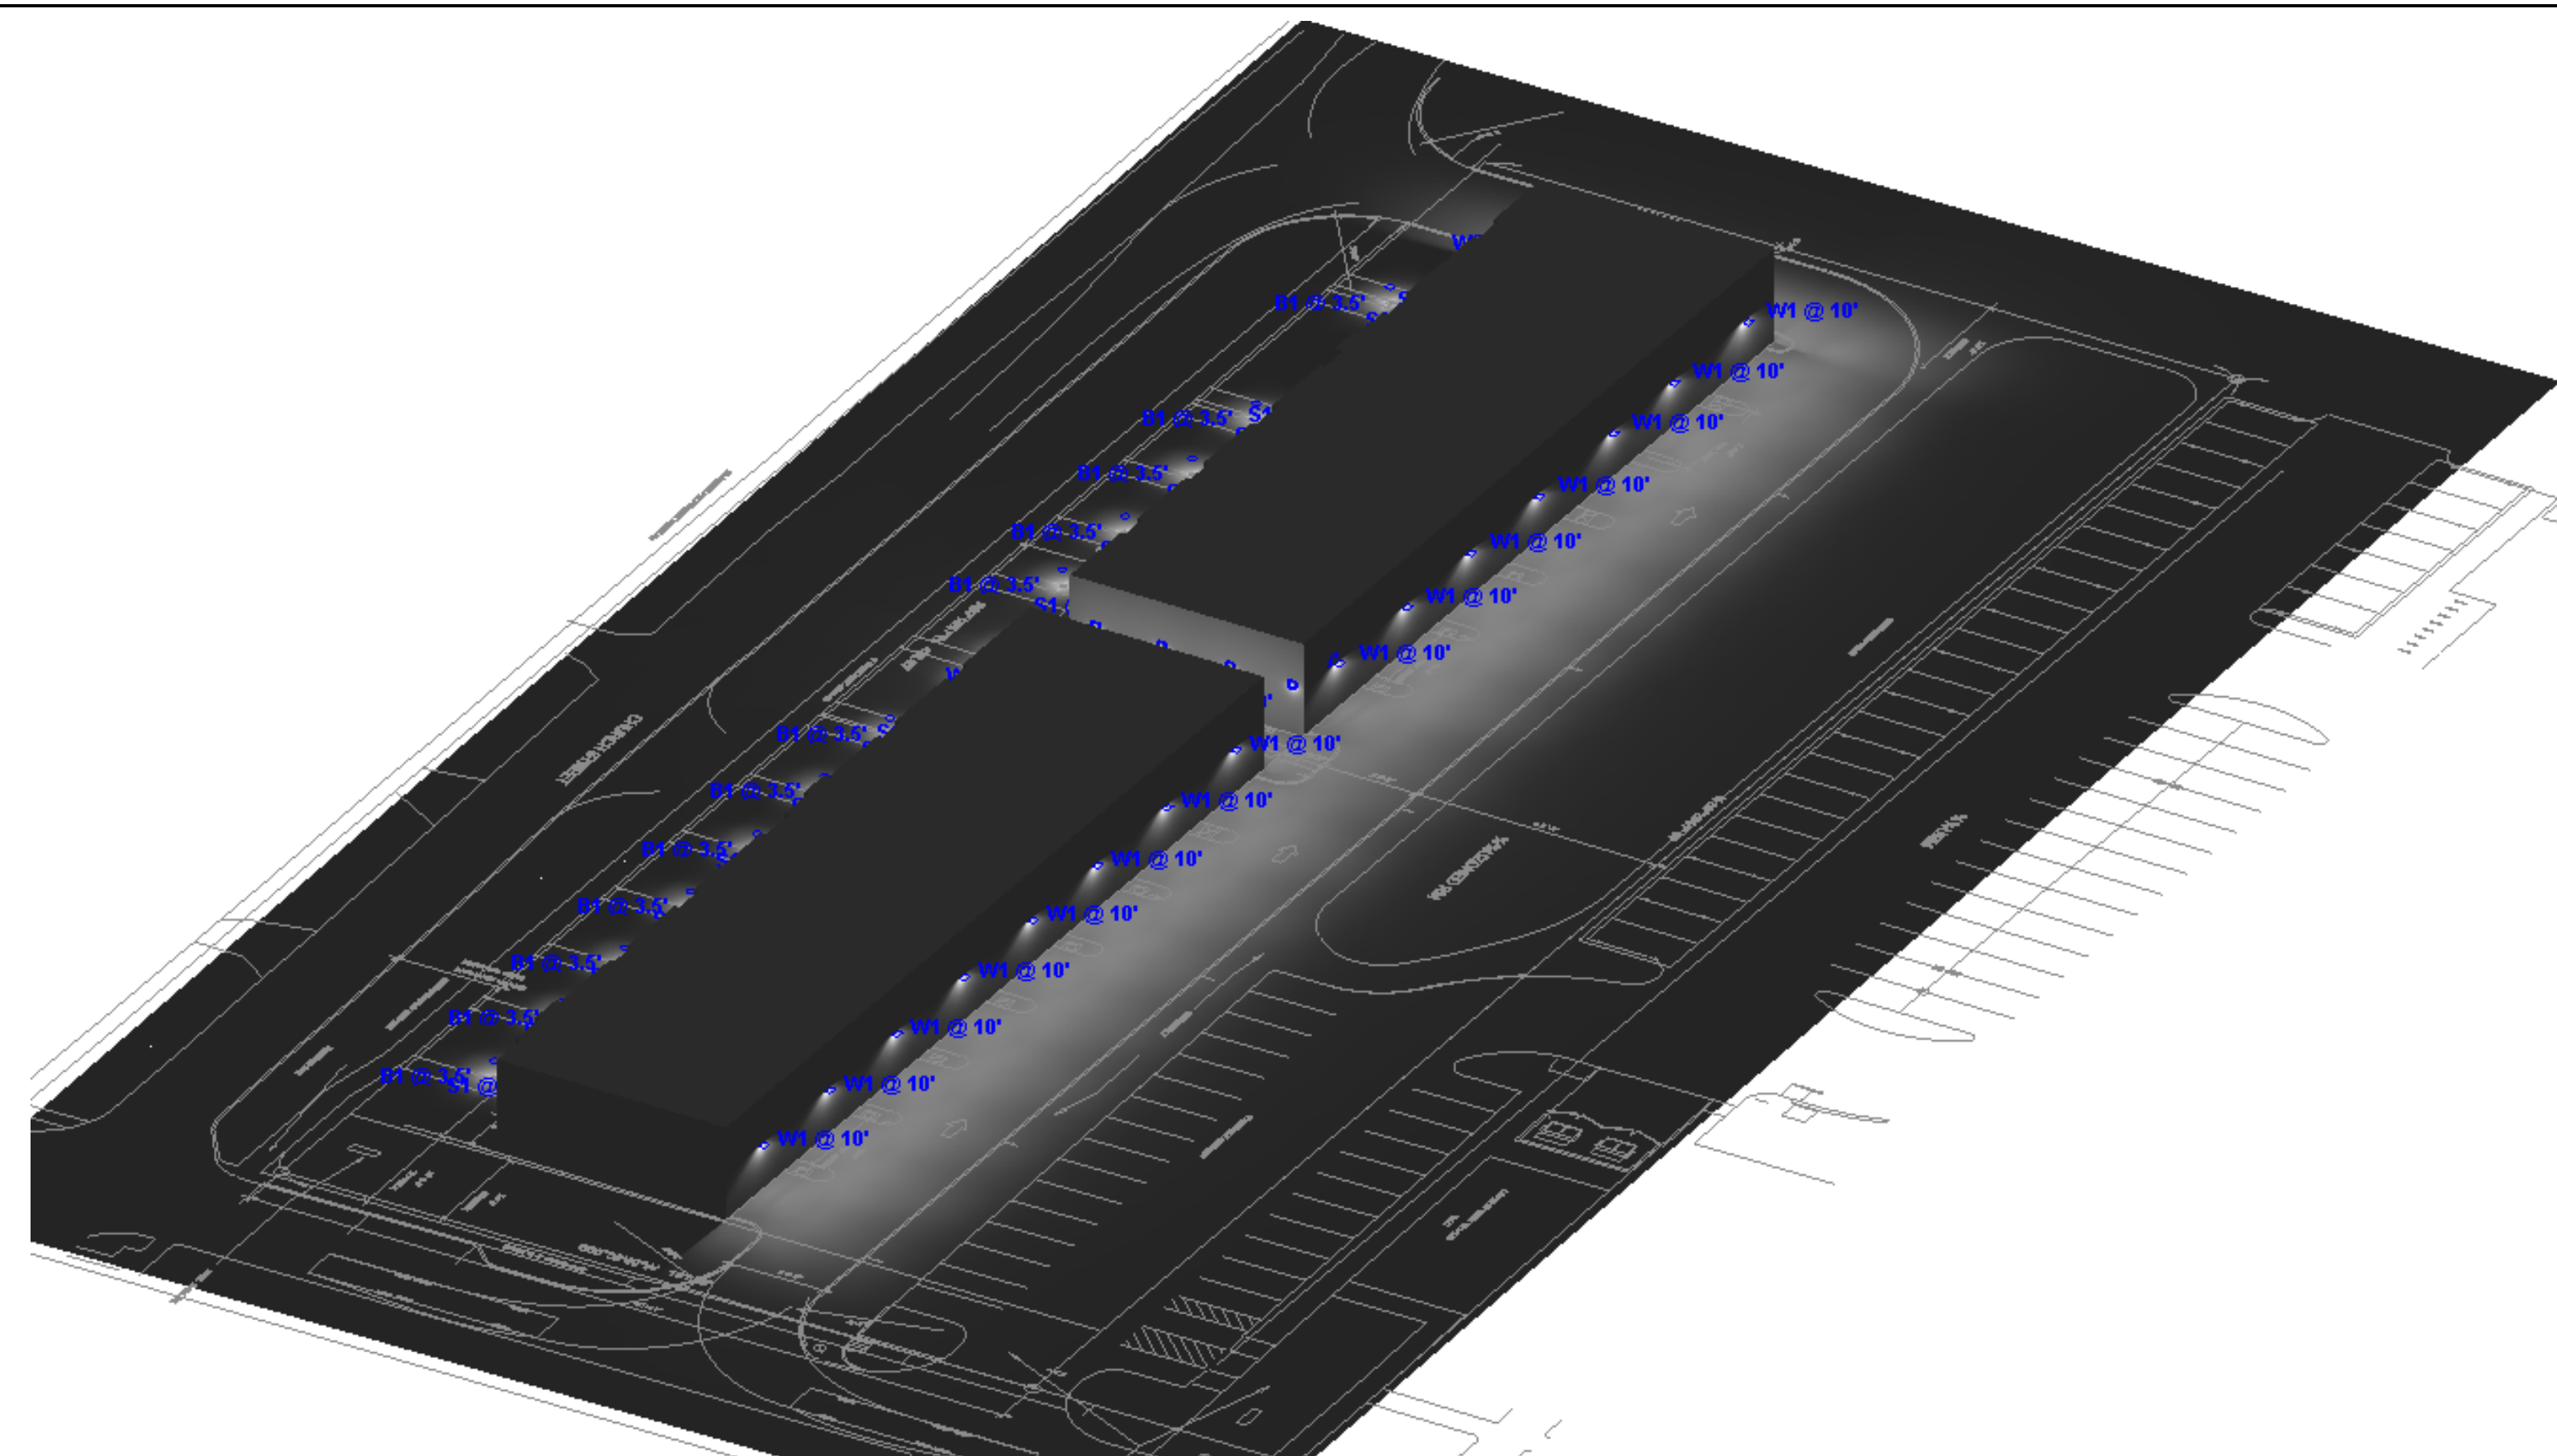


NE Rendered

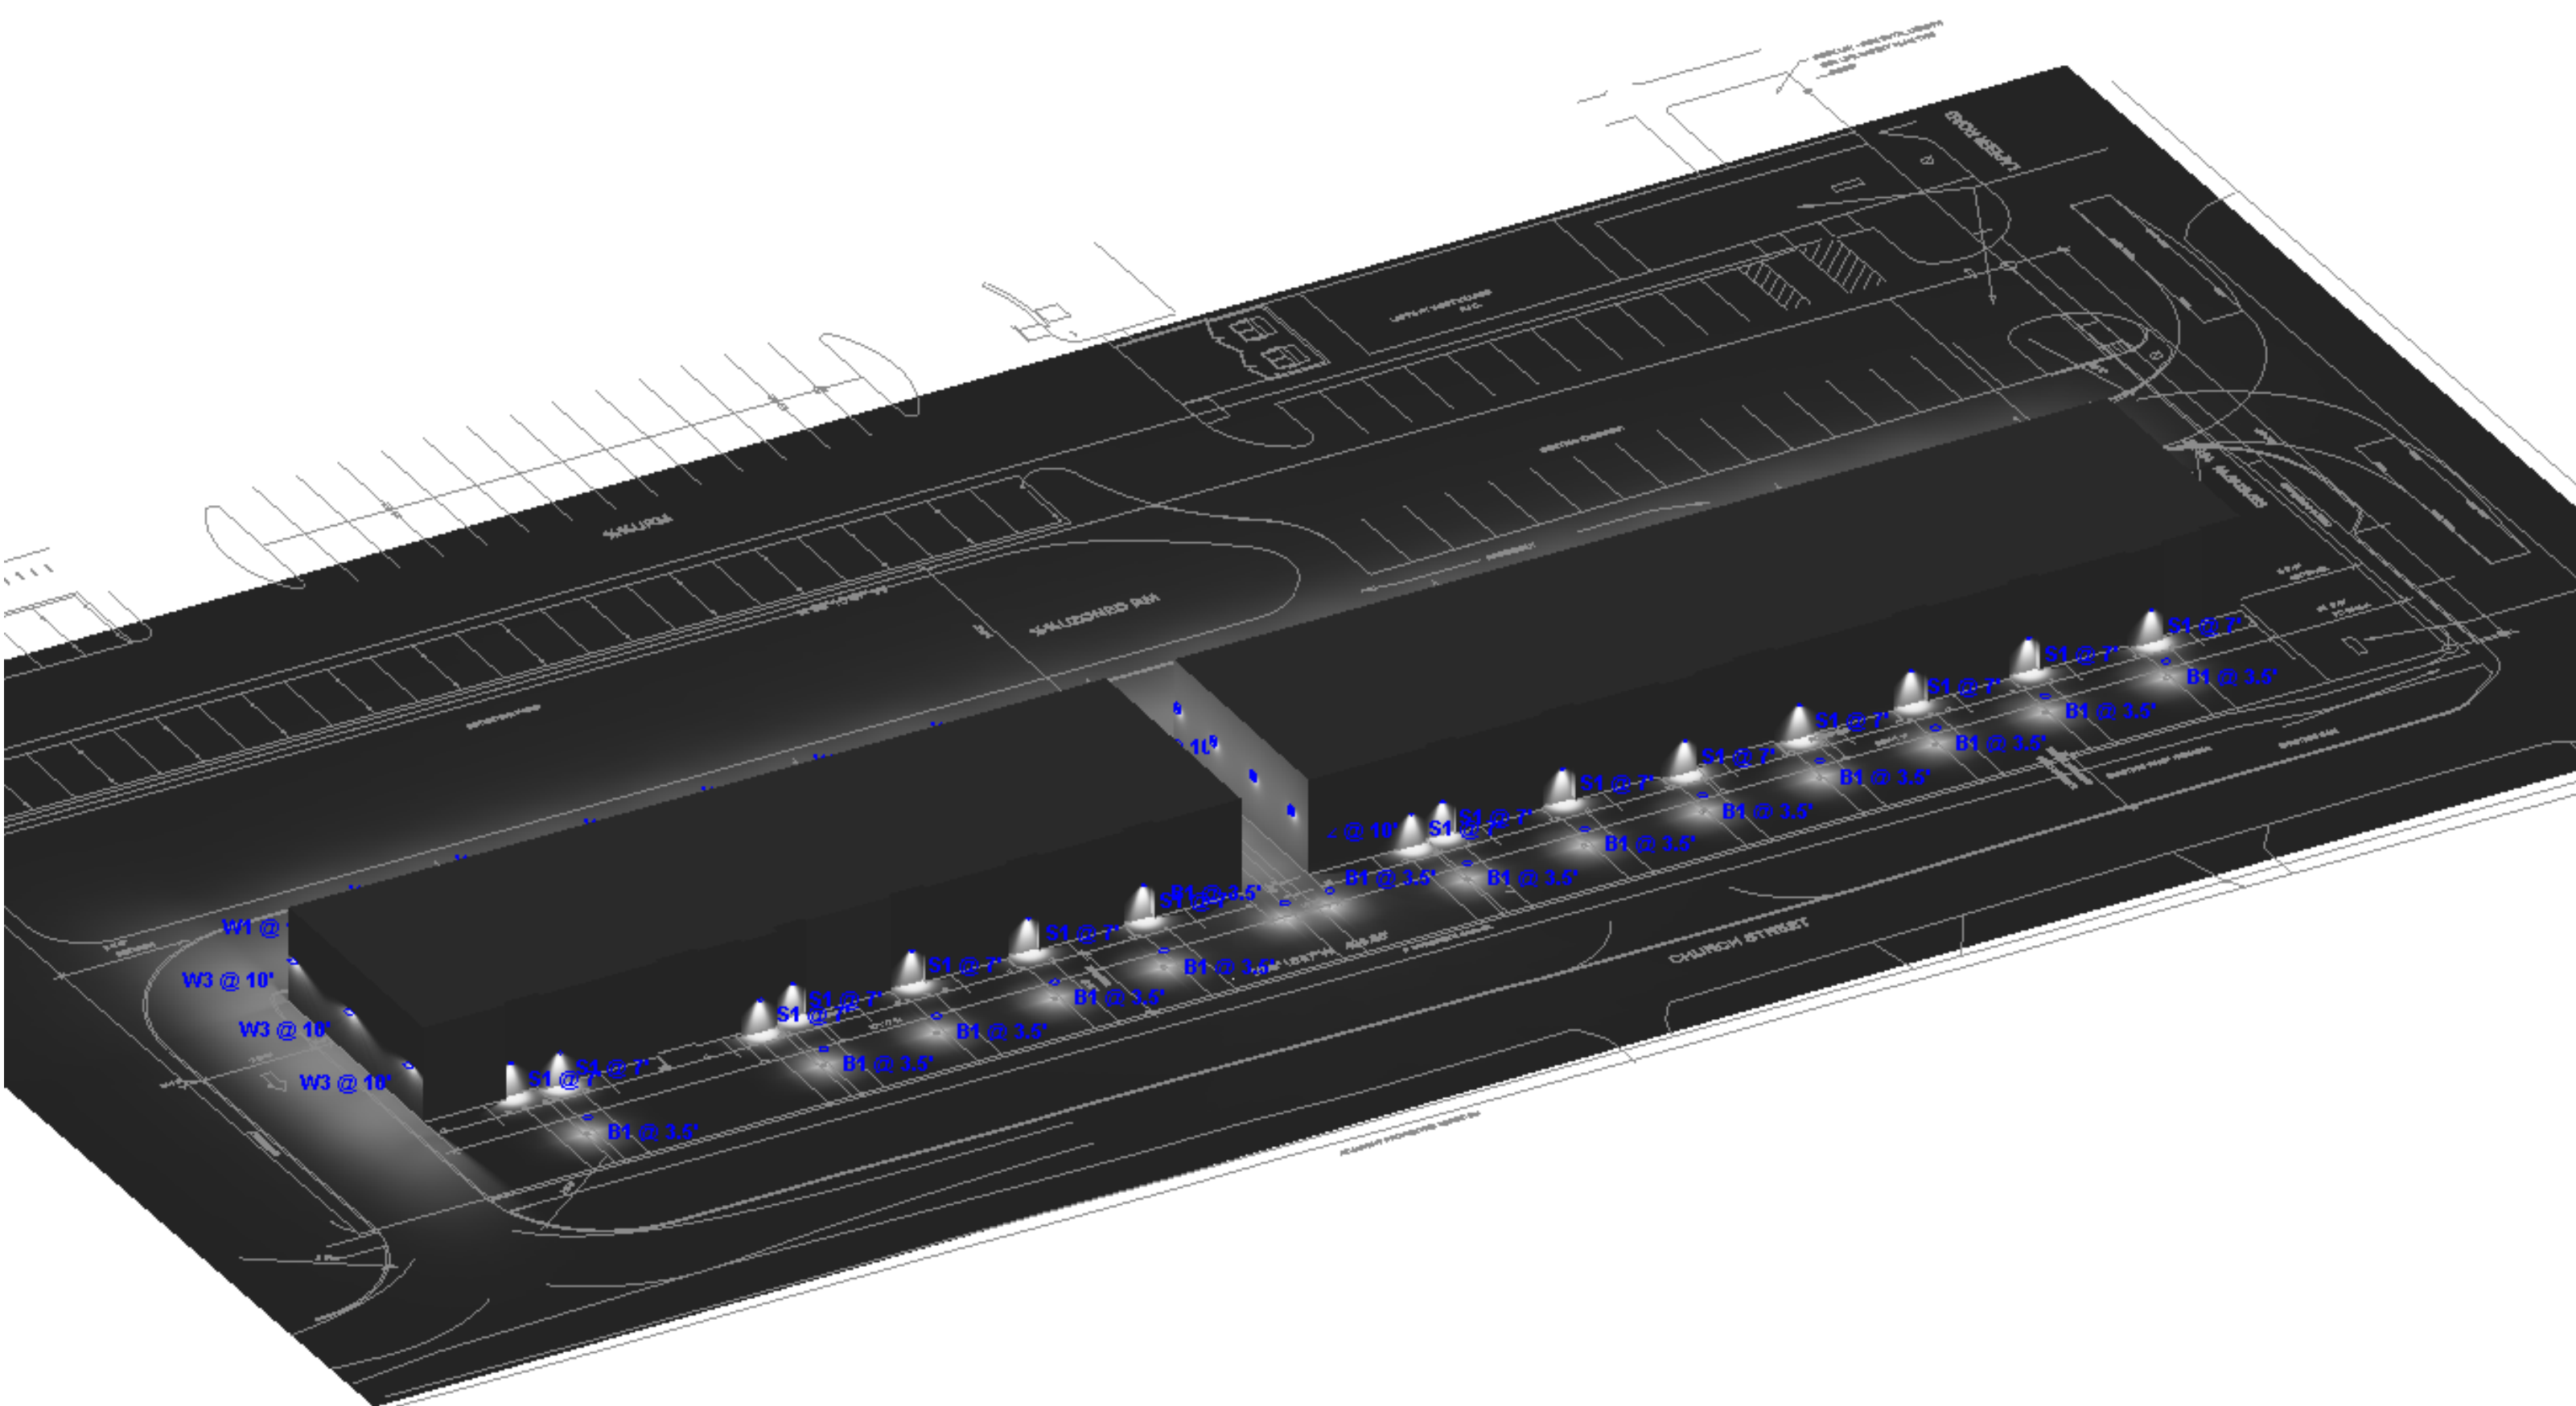


SW Rendered

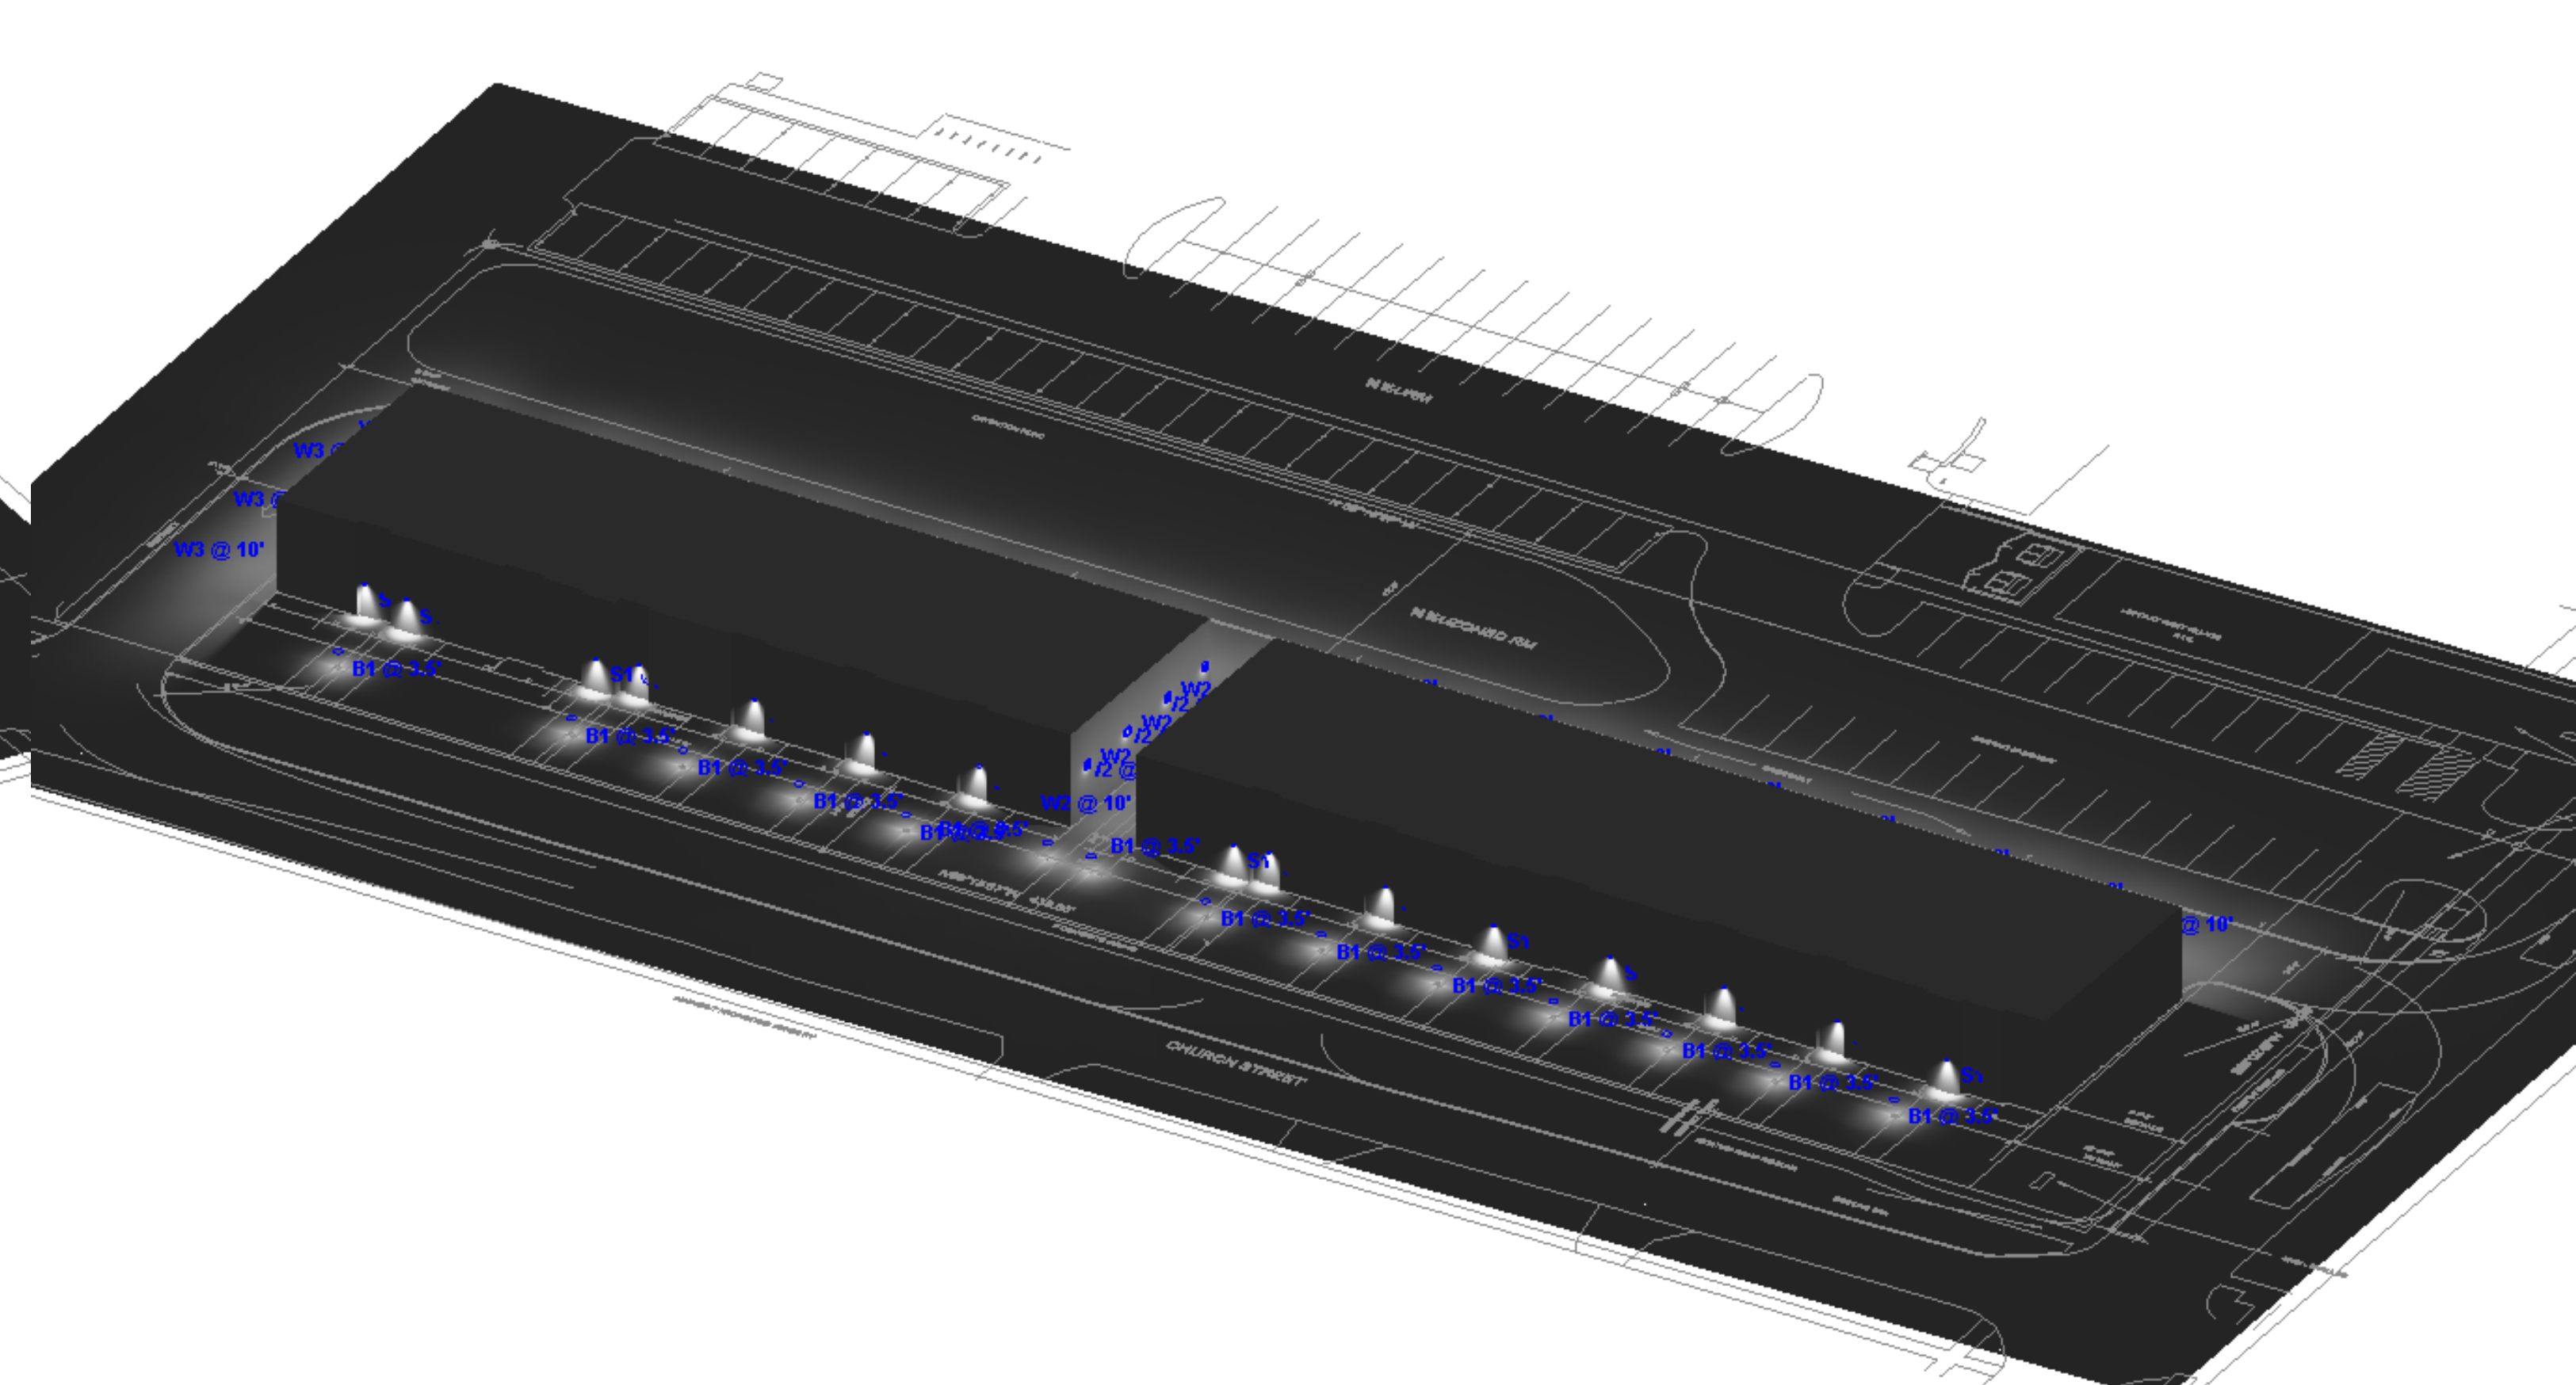


SE Rendered

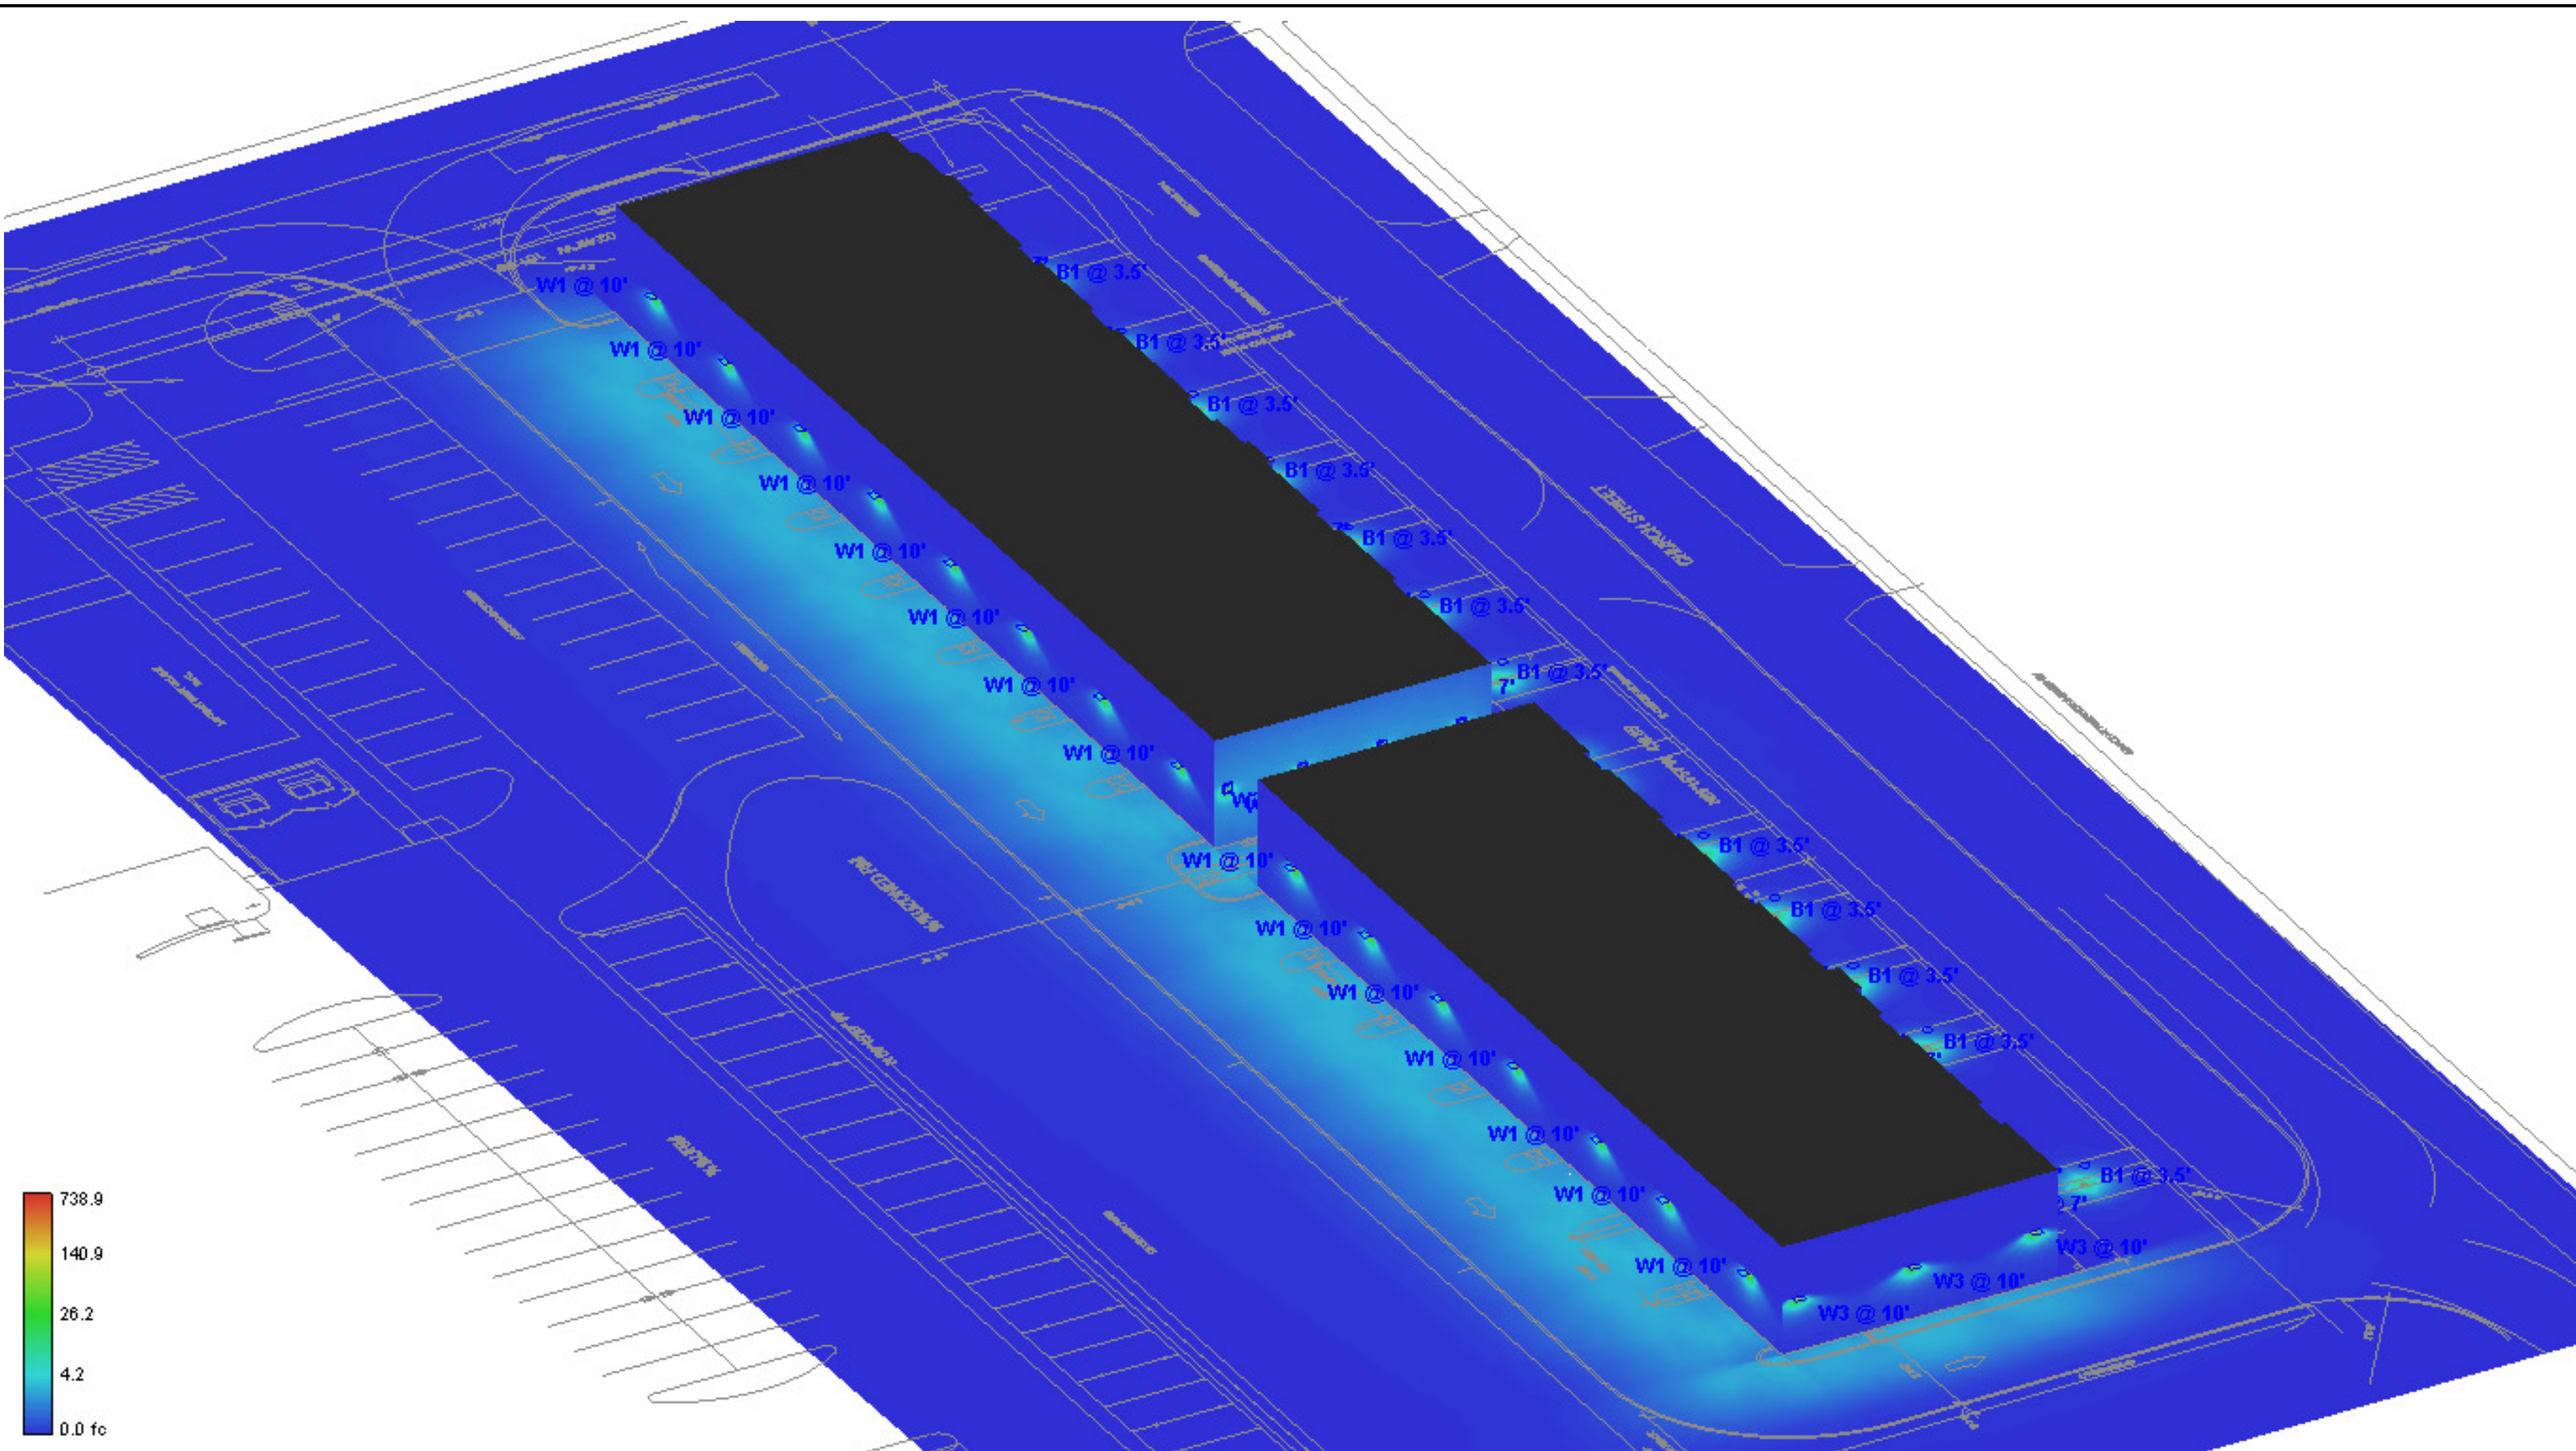


NW Pseudo

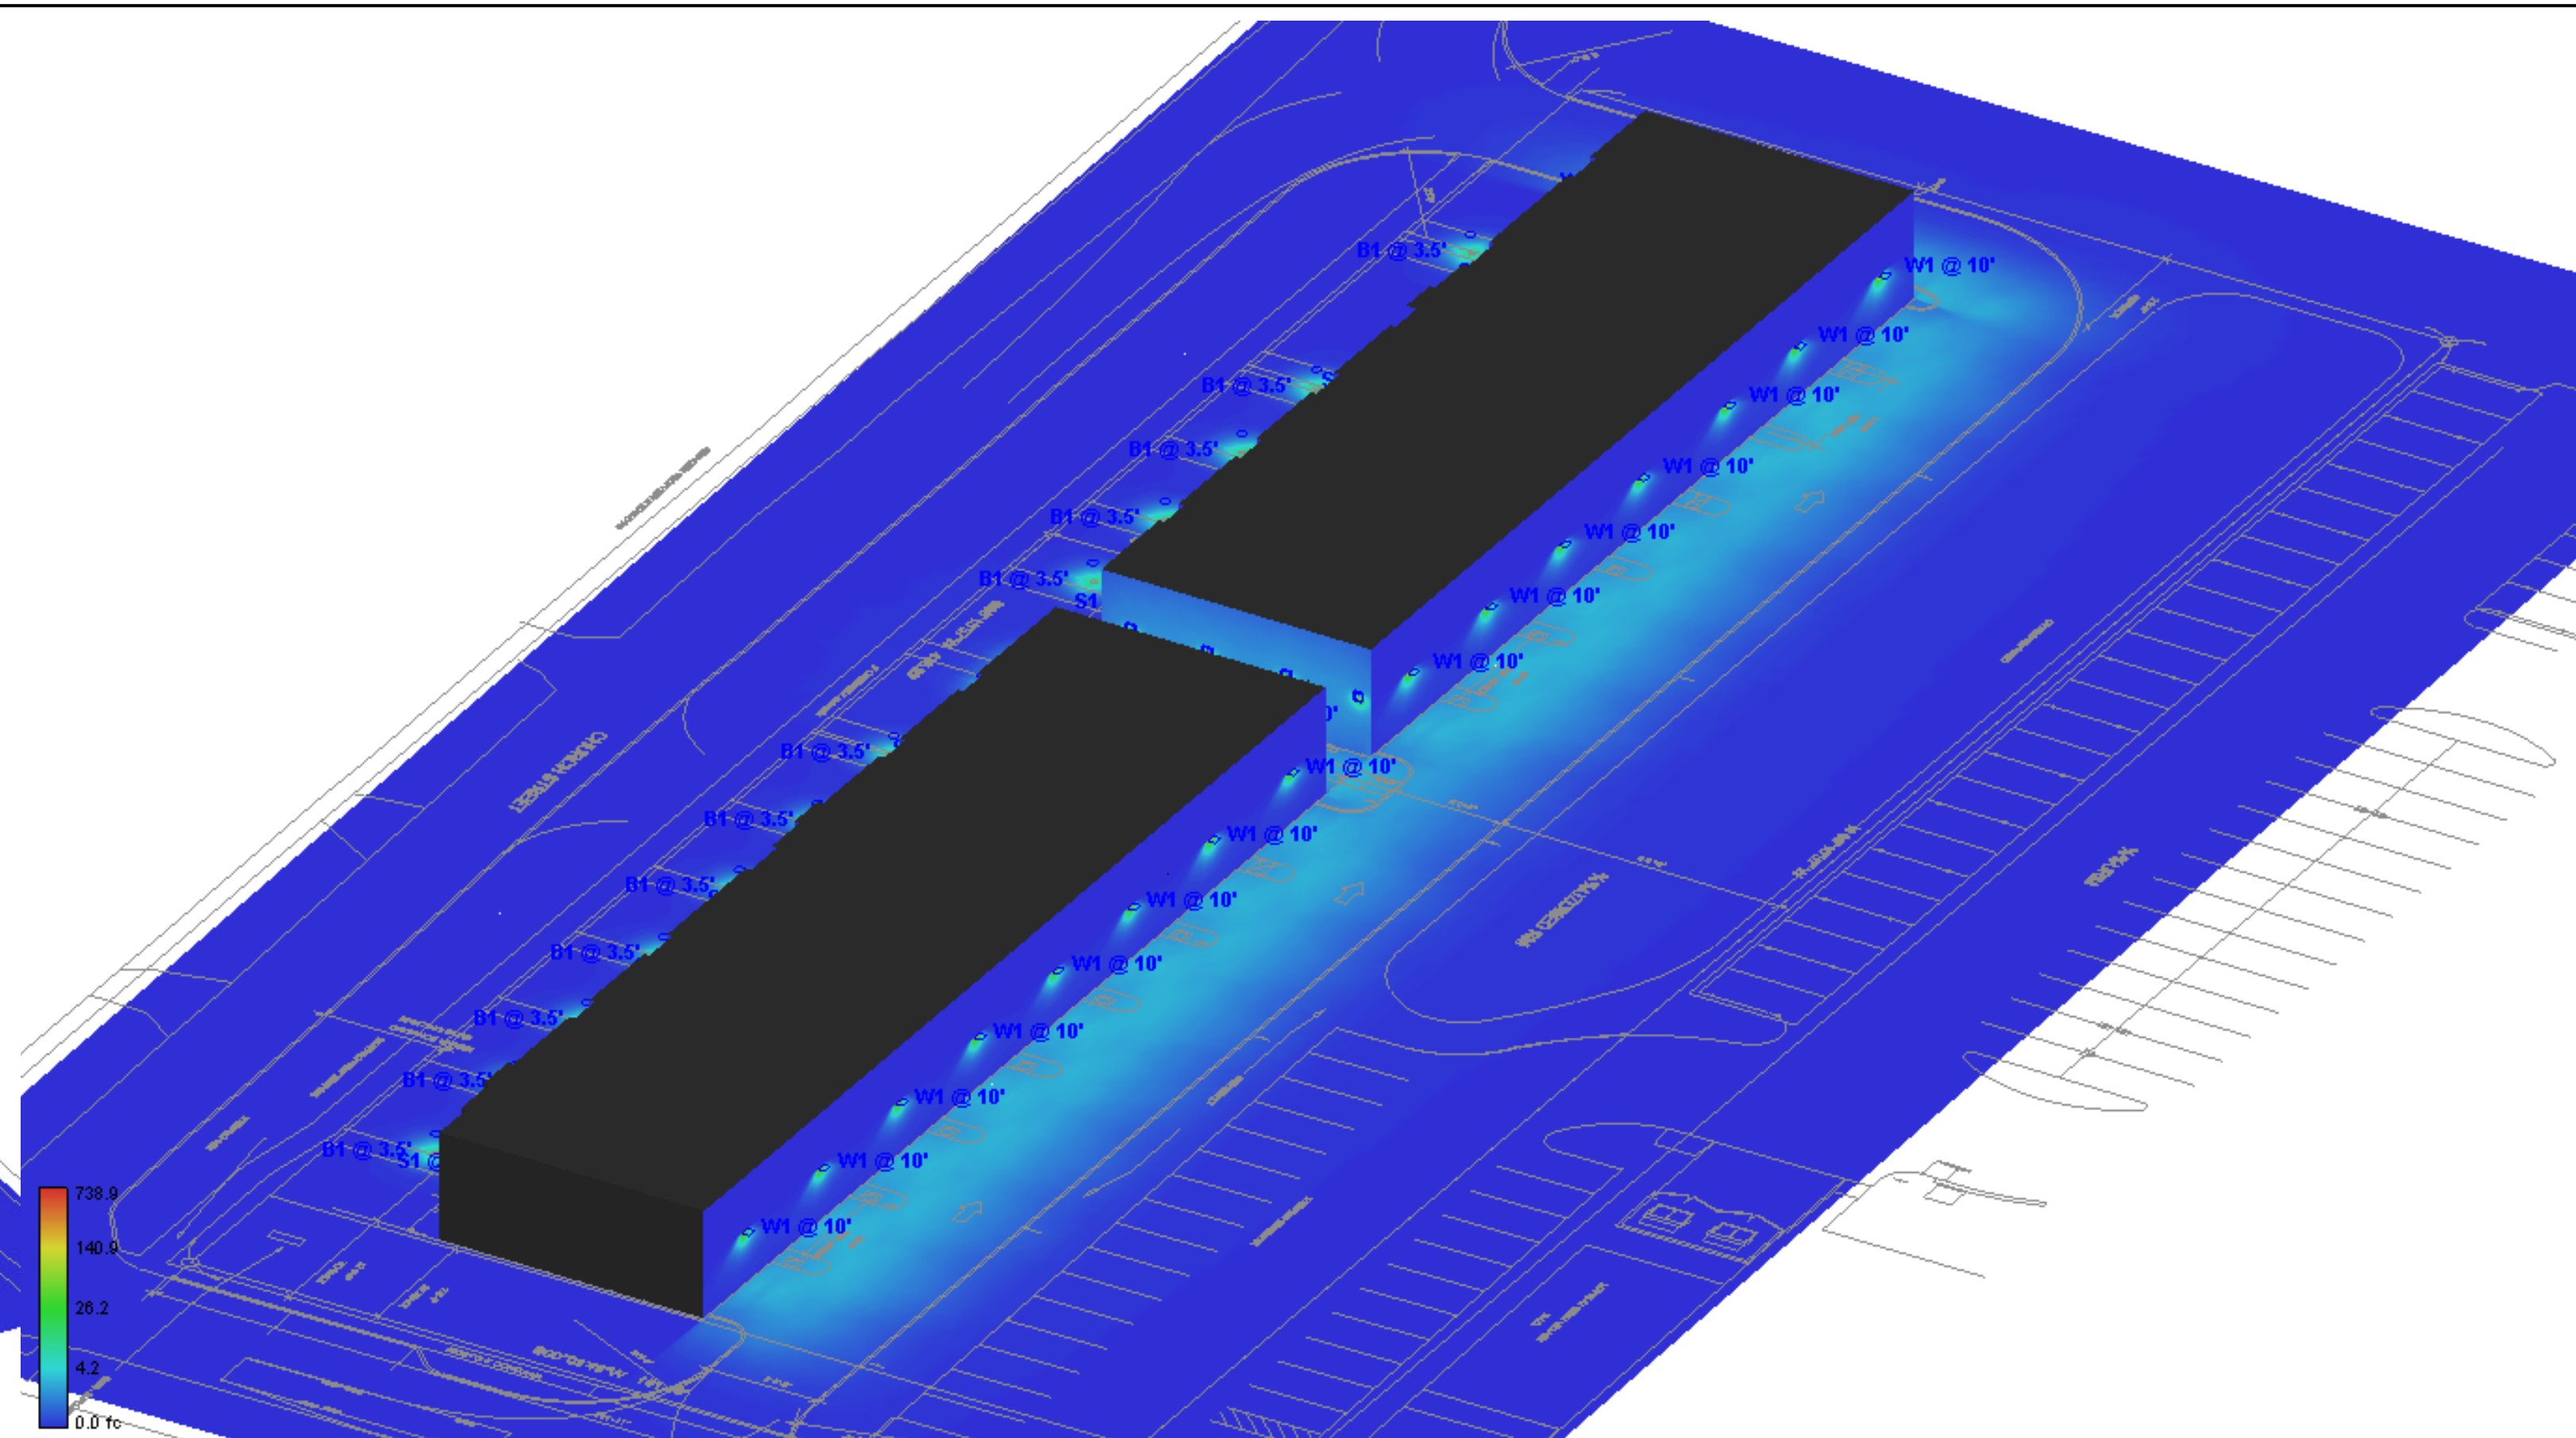


NE Pseudo

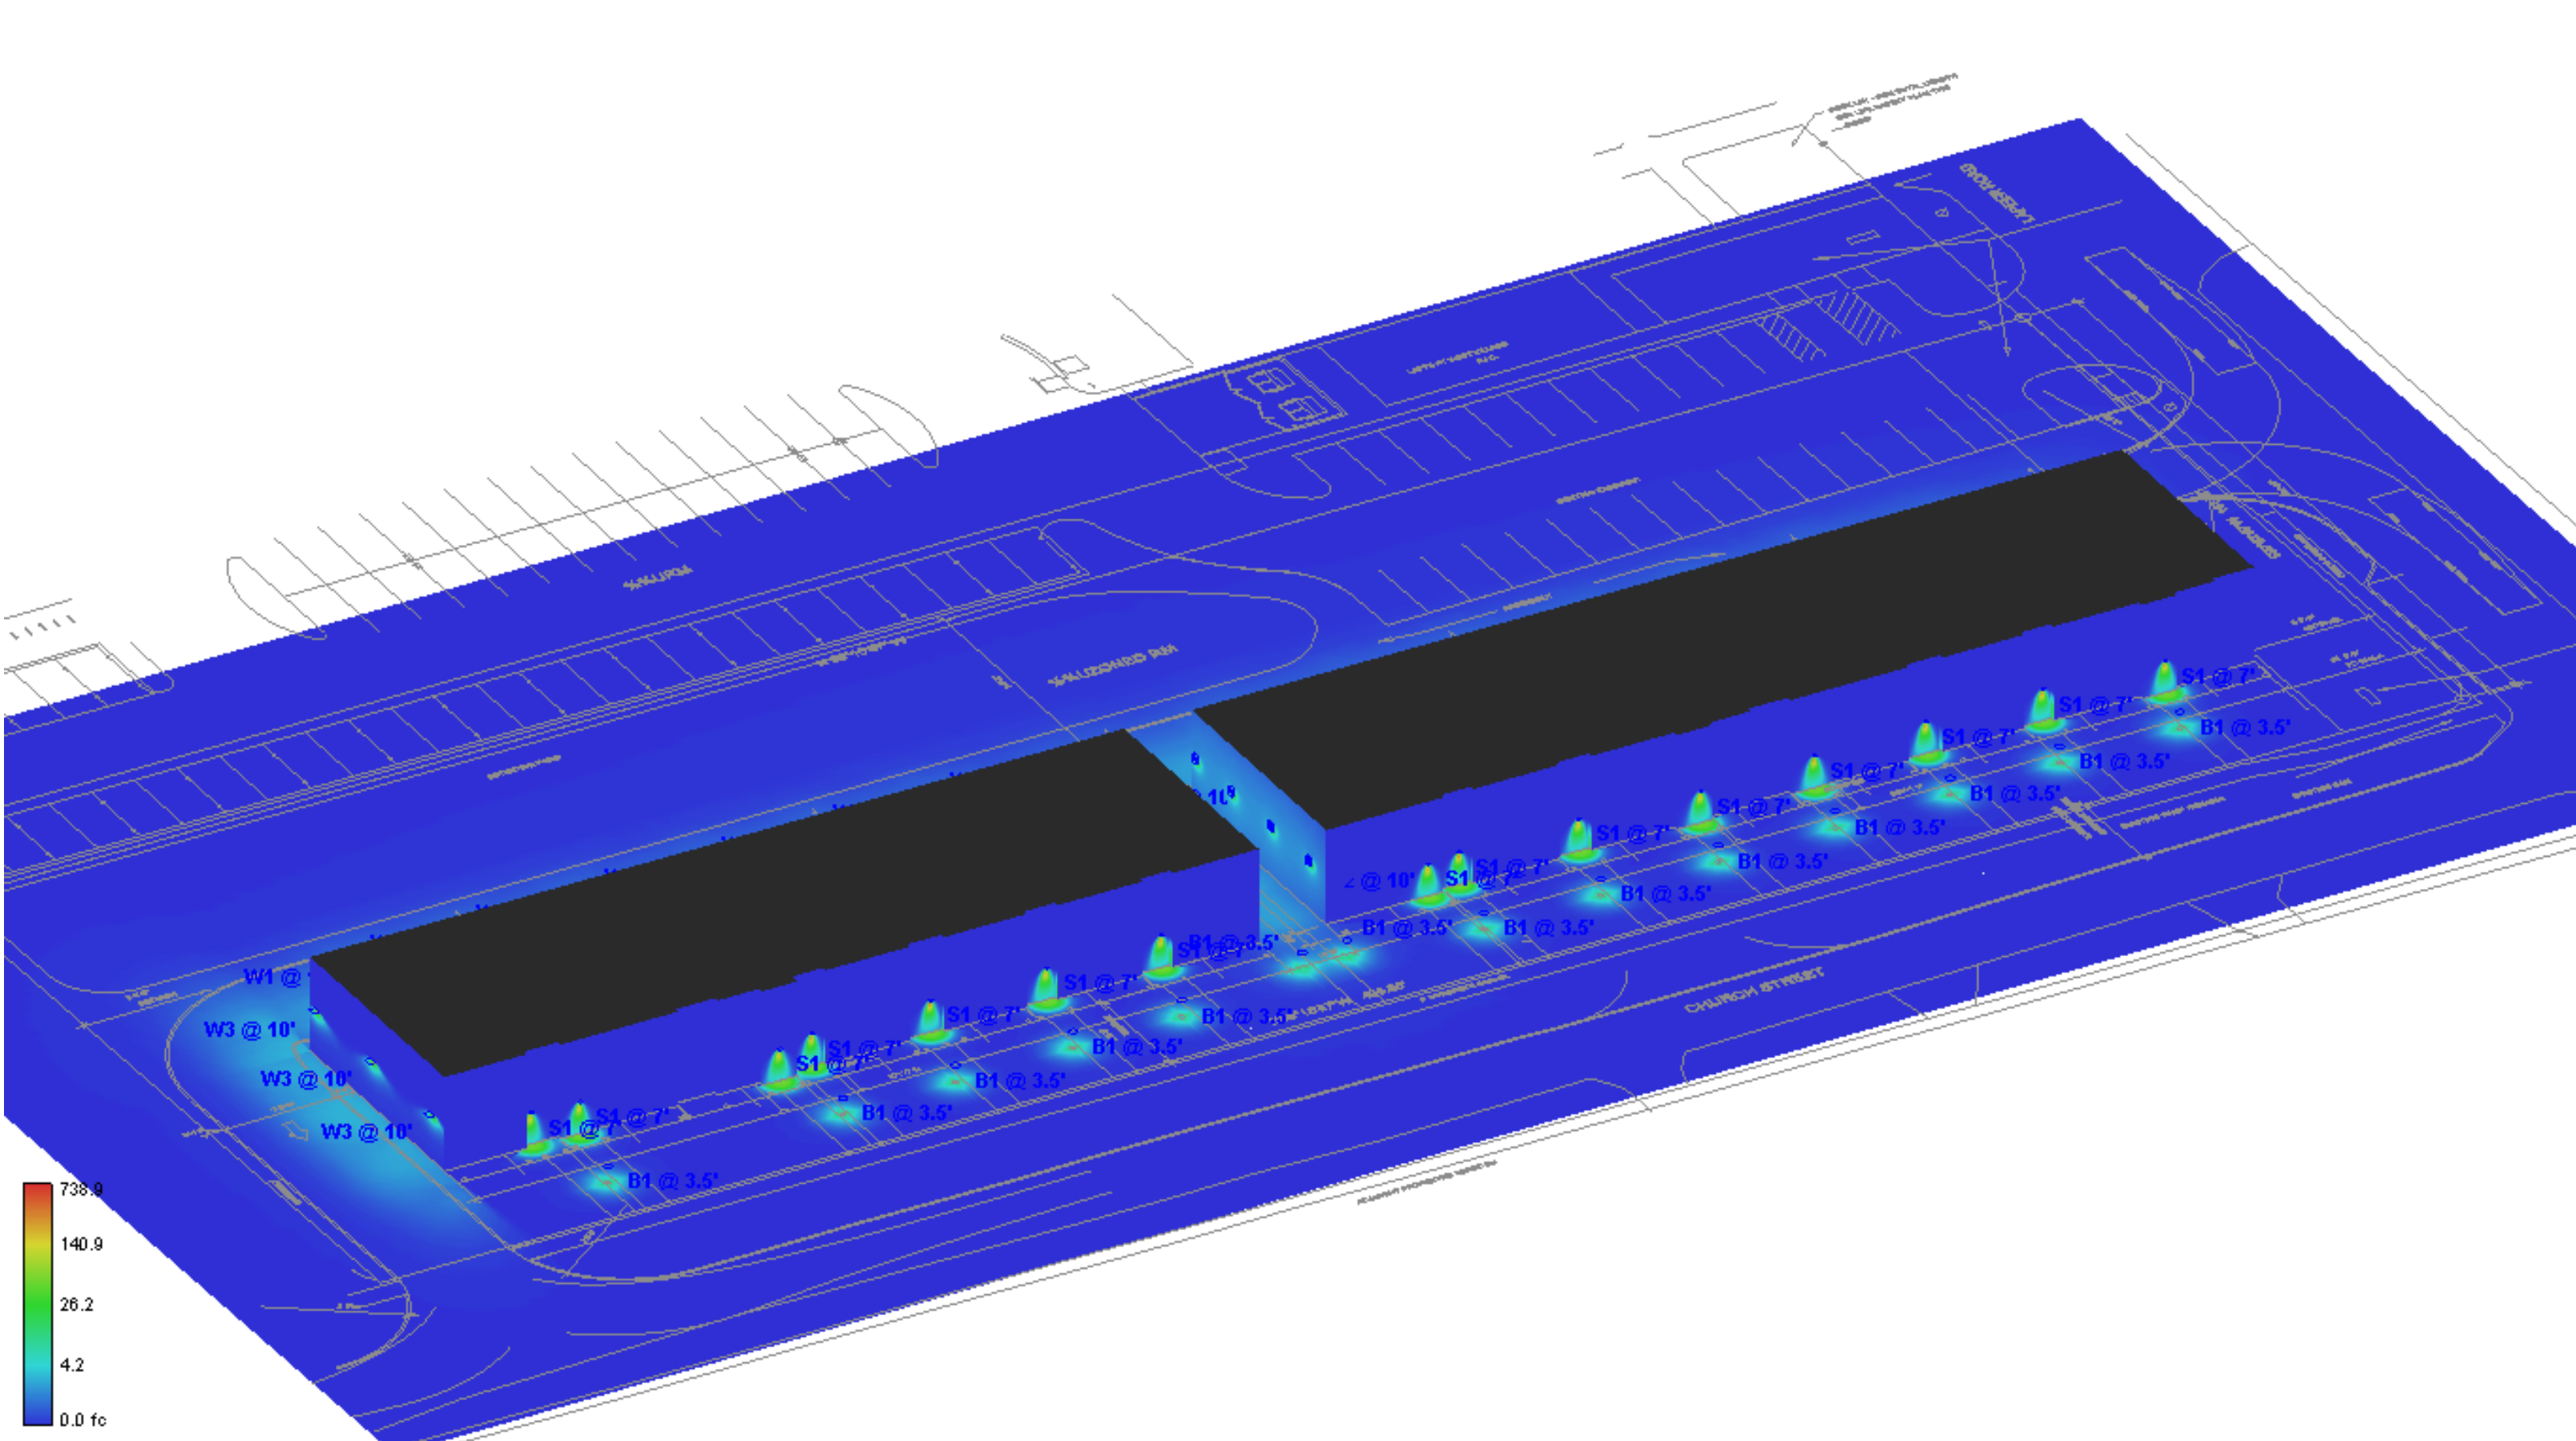


SW Pseudo

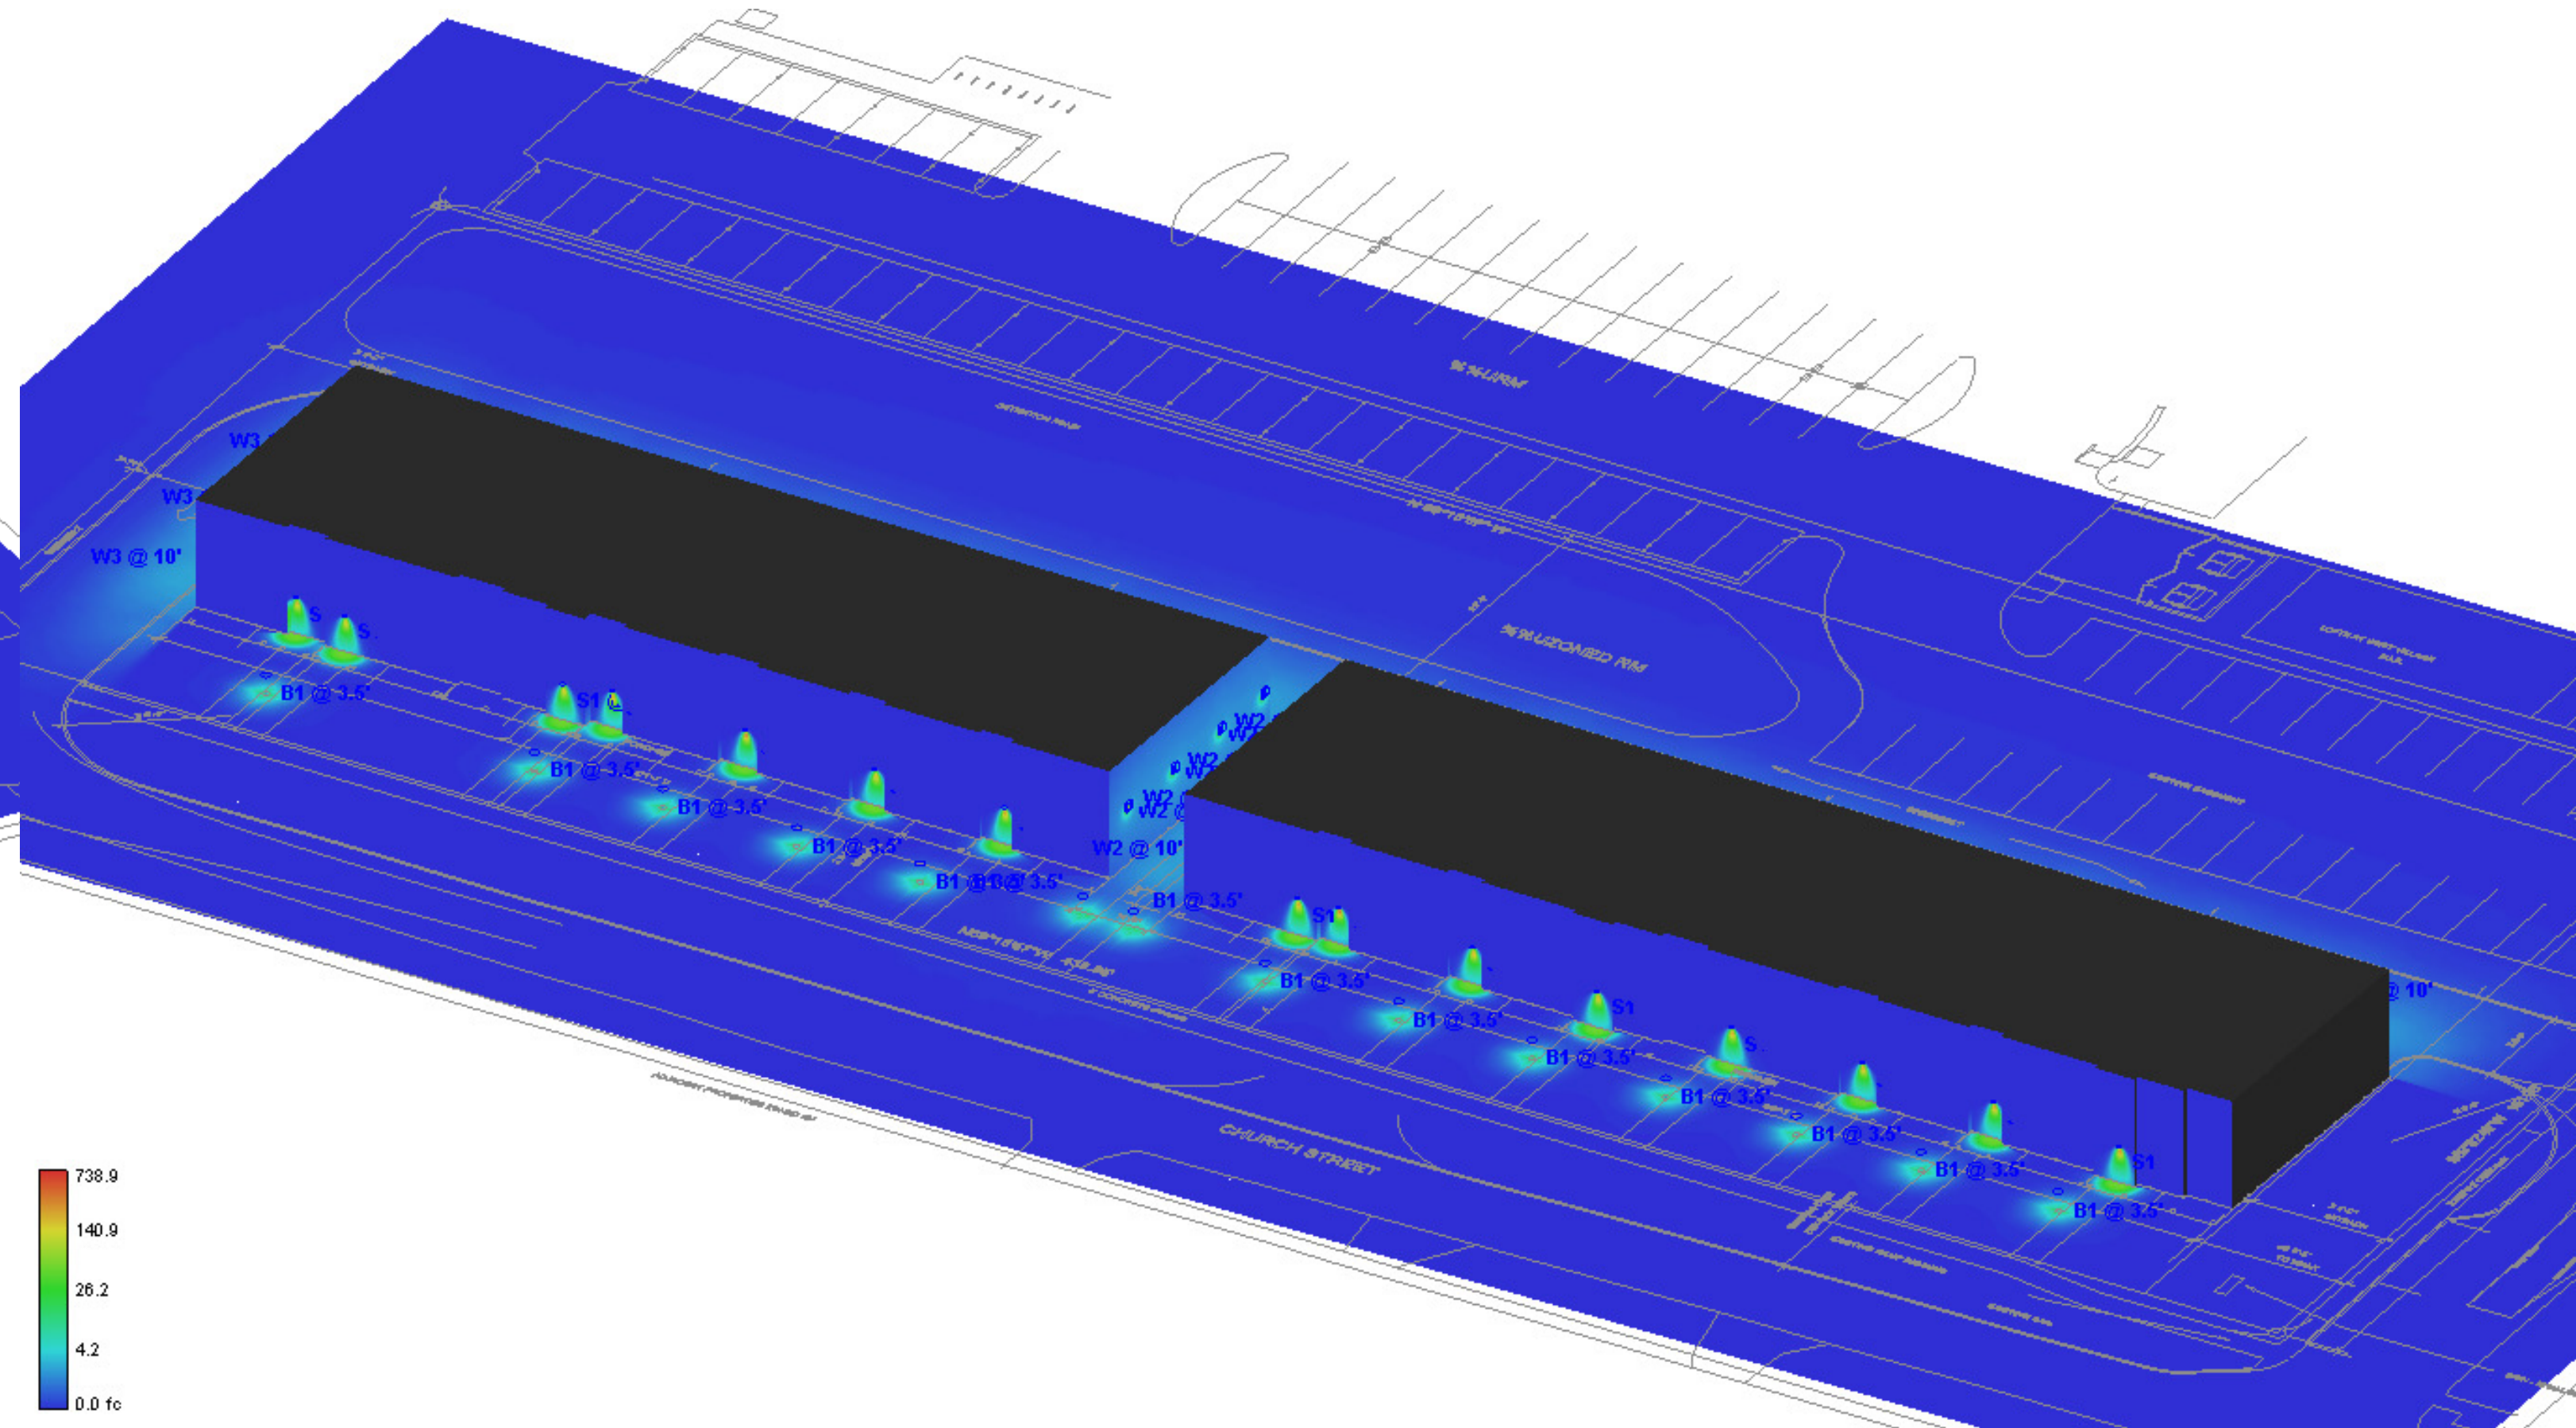


SE Pseudo

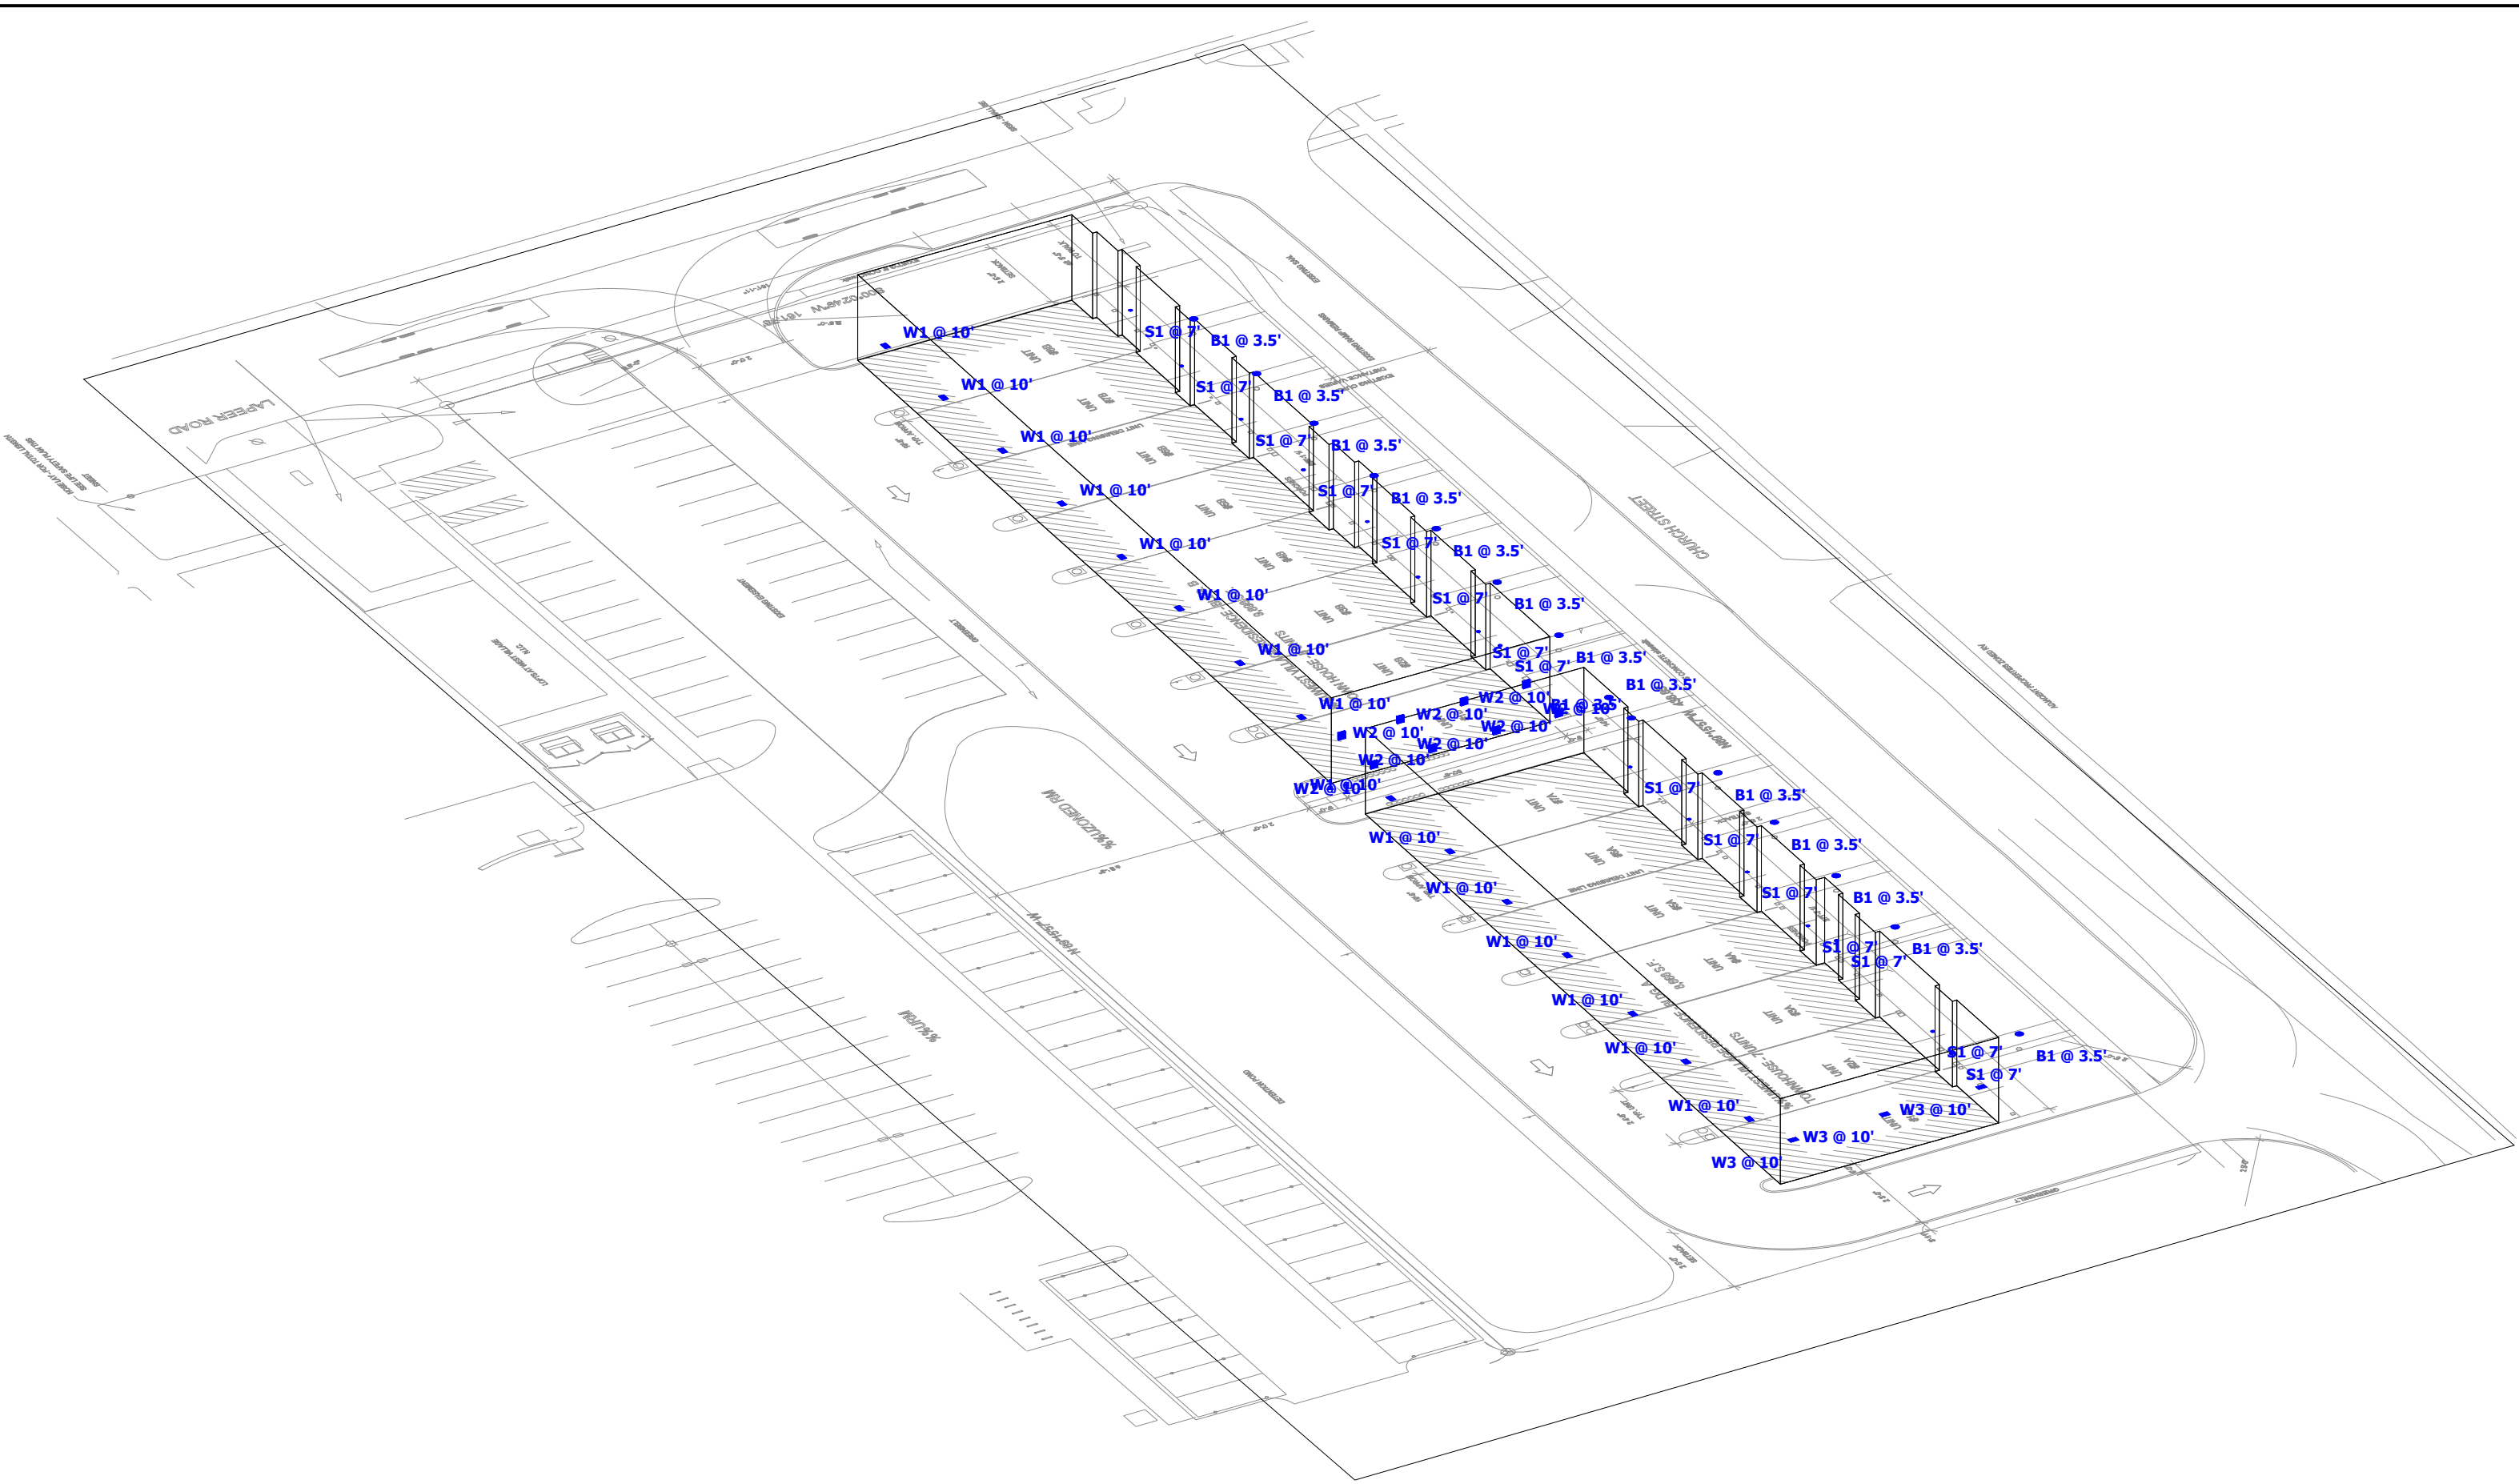


North West View

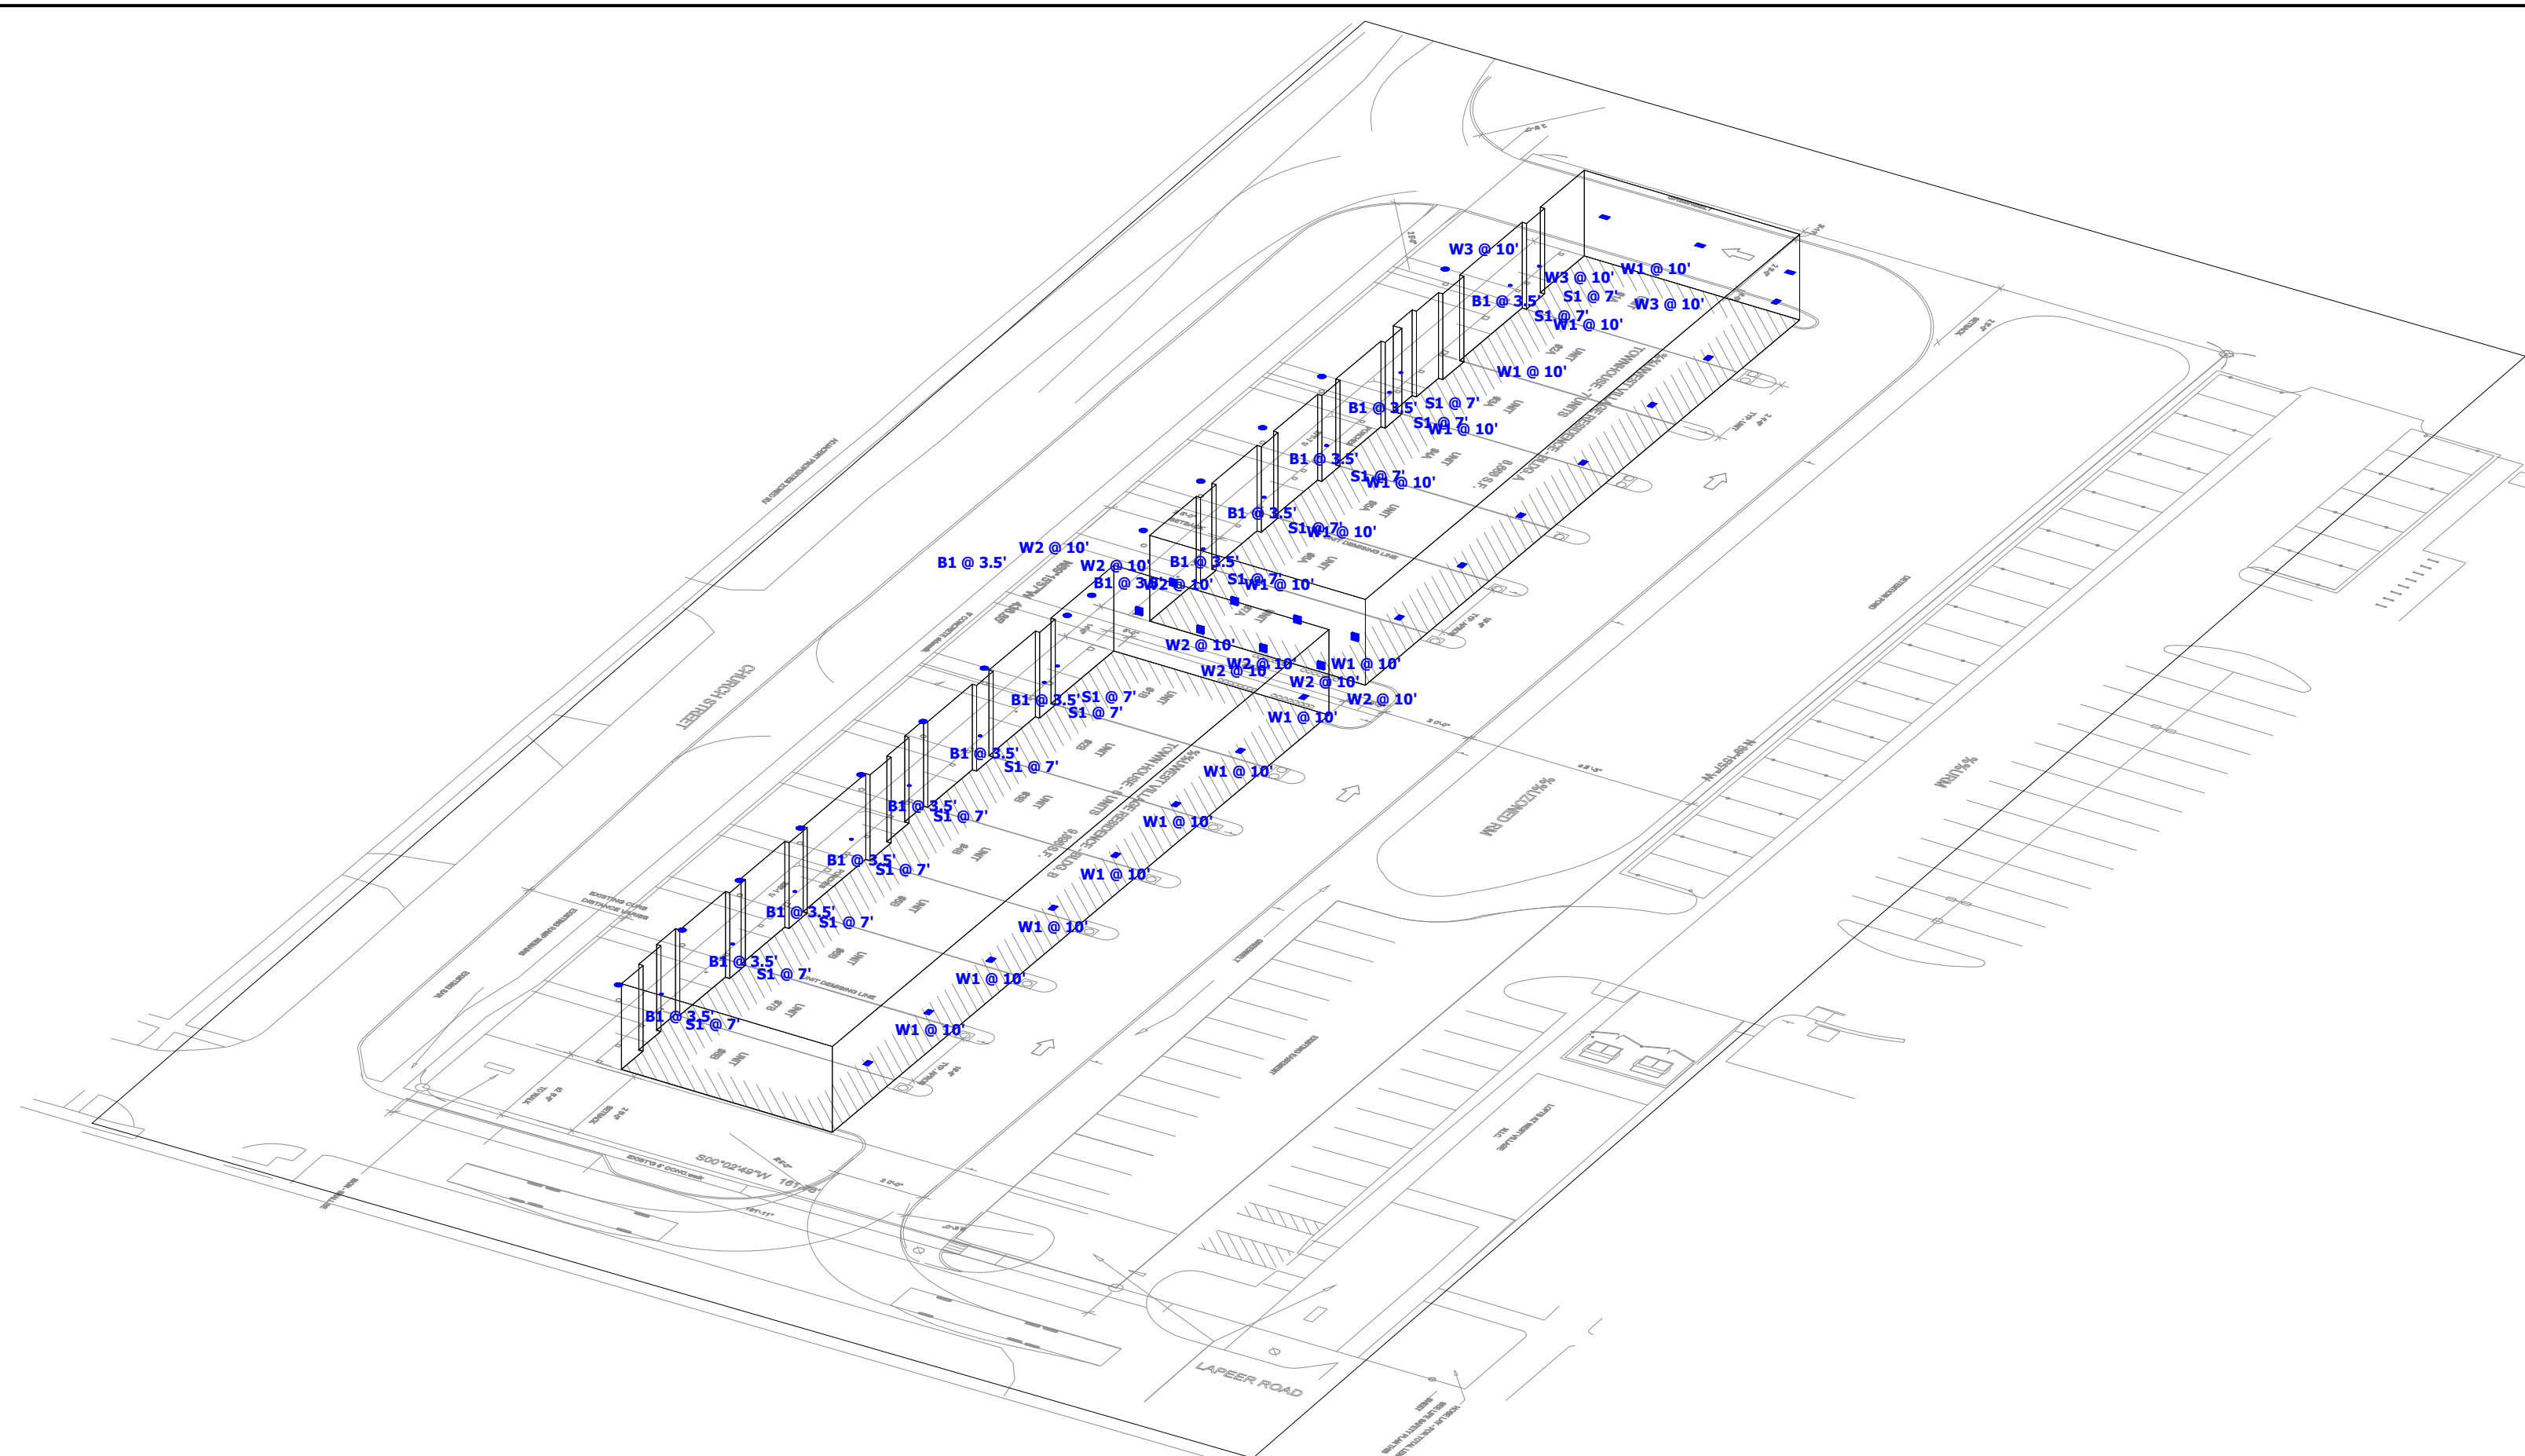

North East View

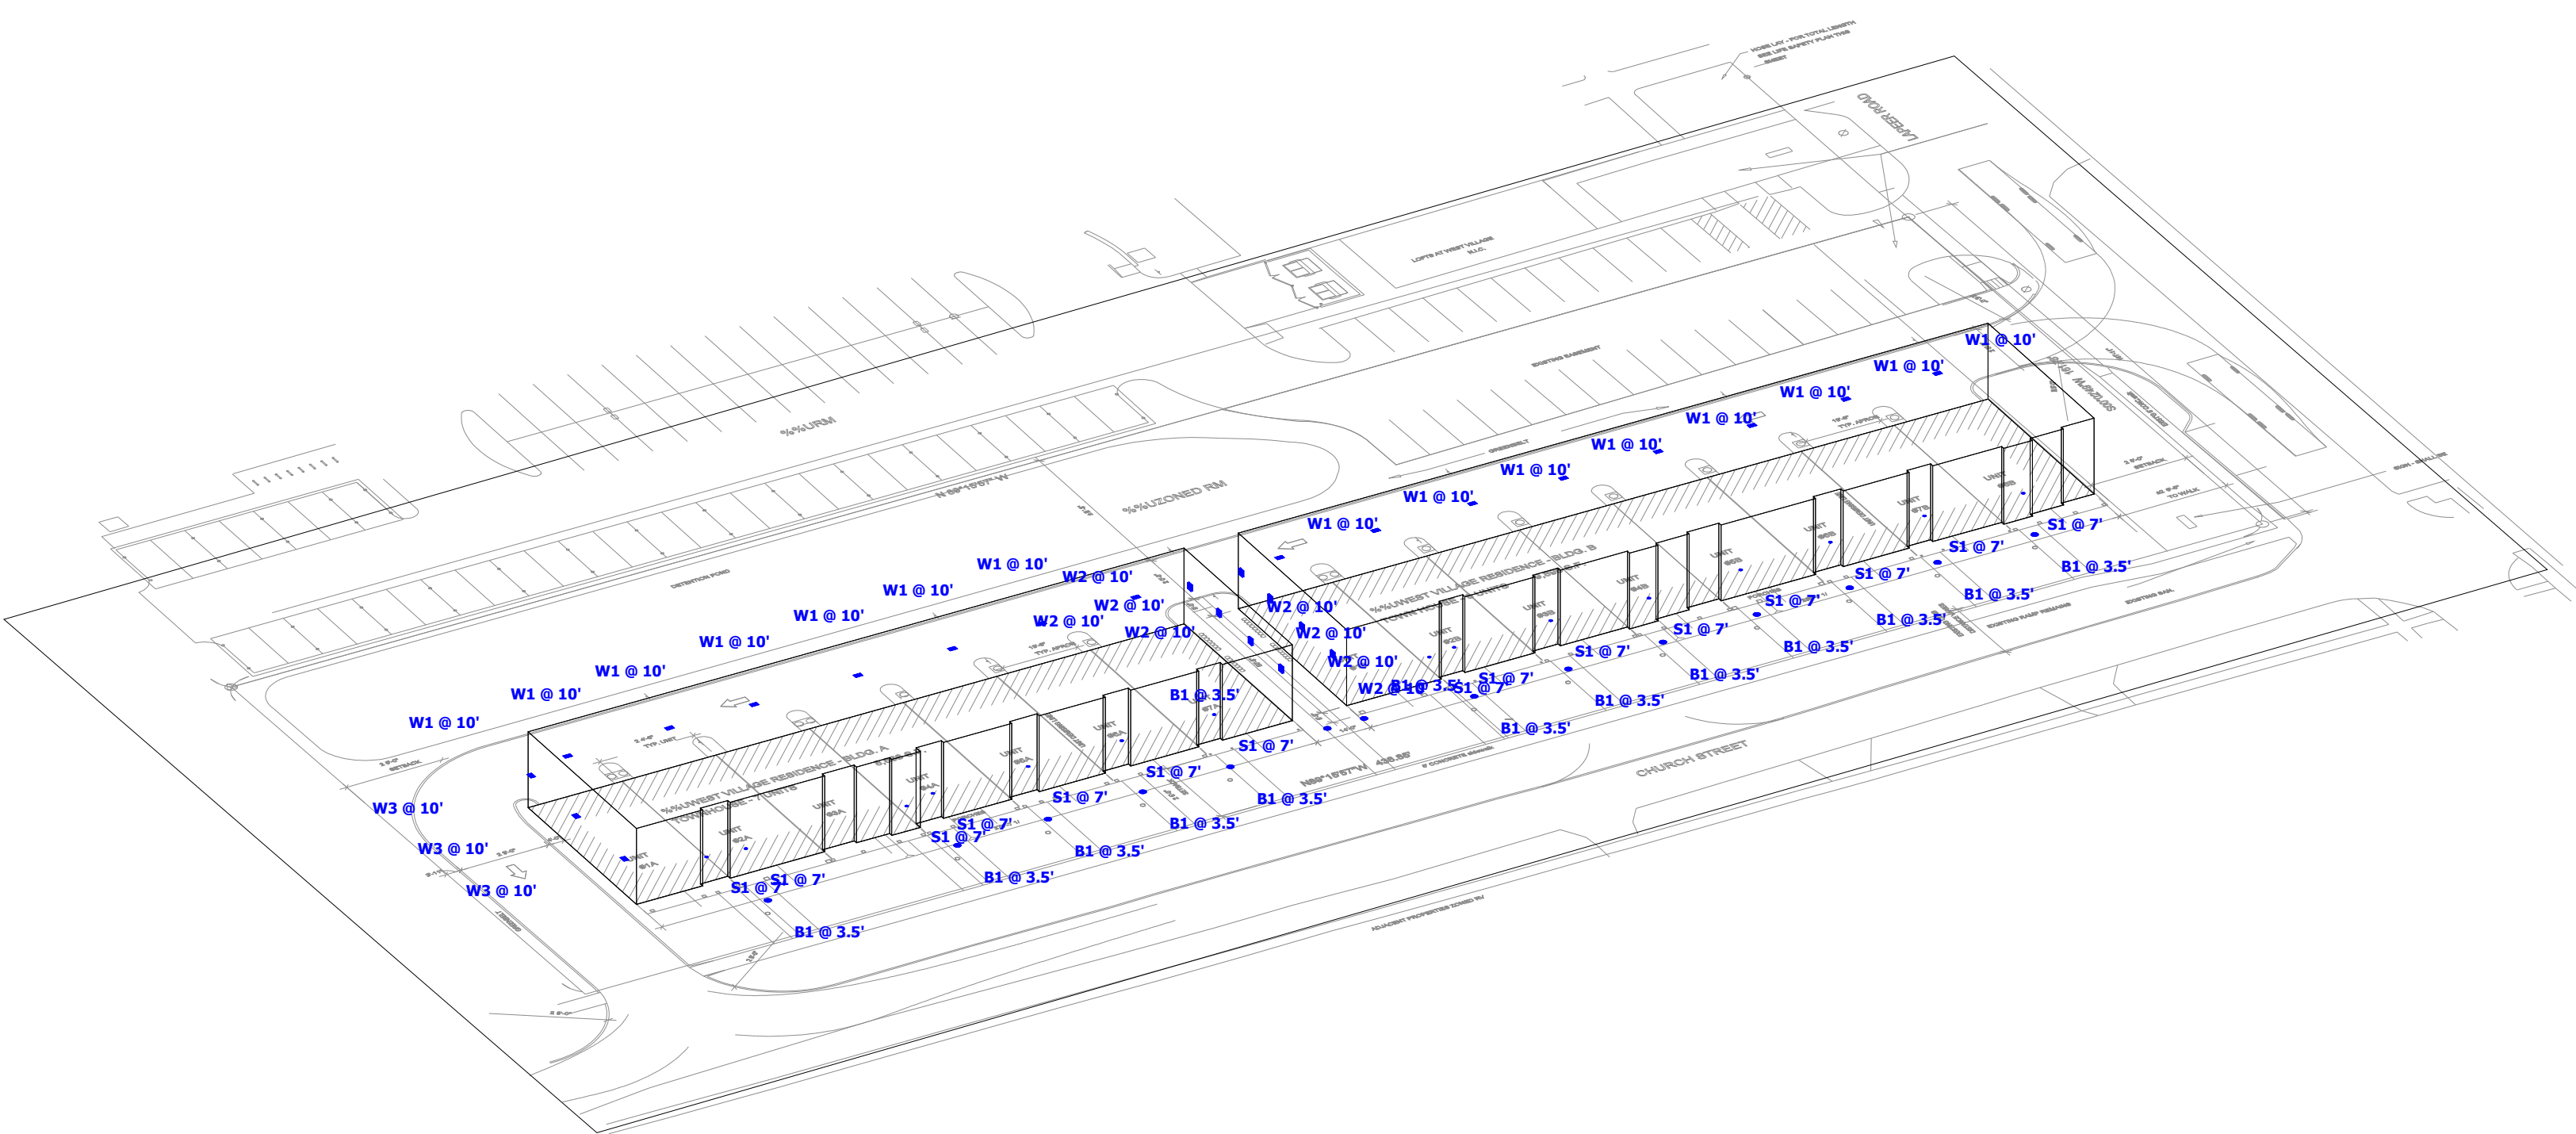

South West View

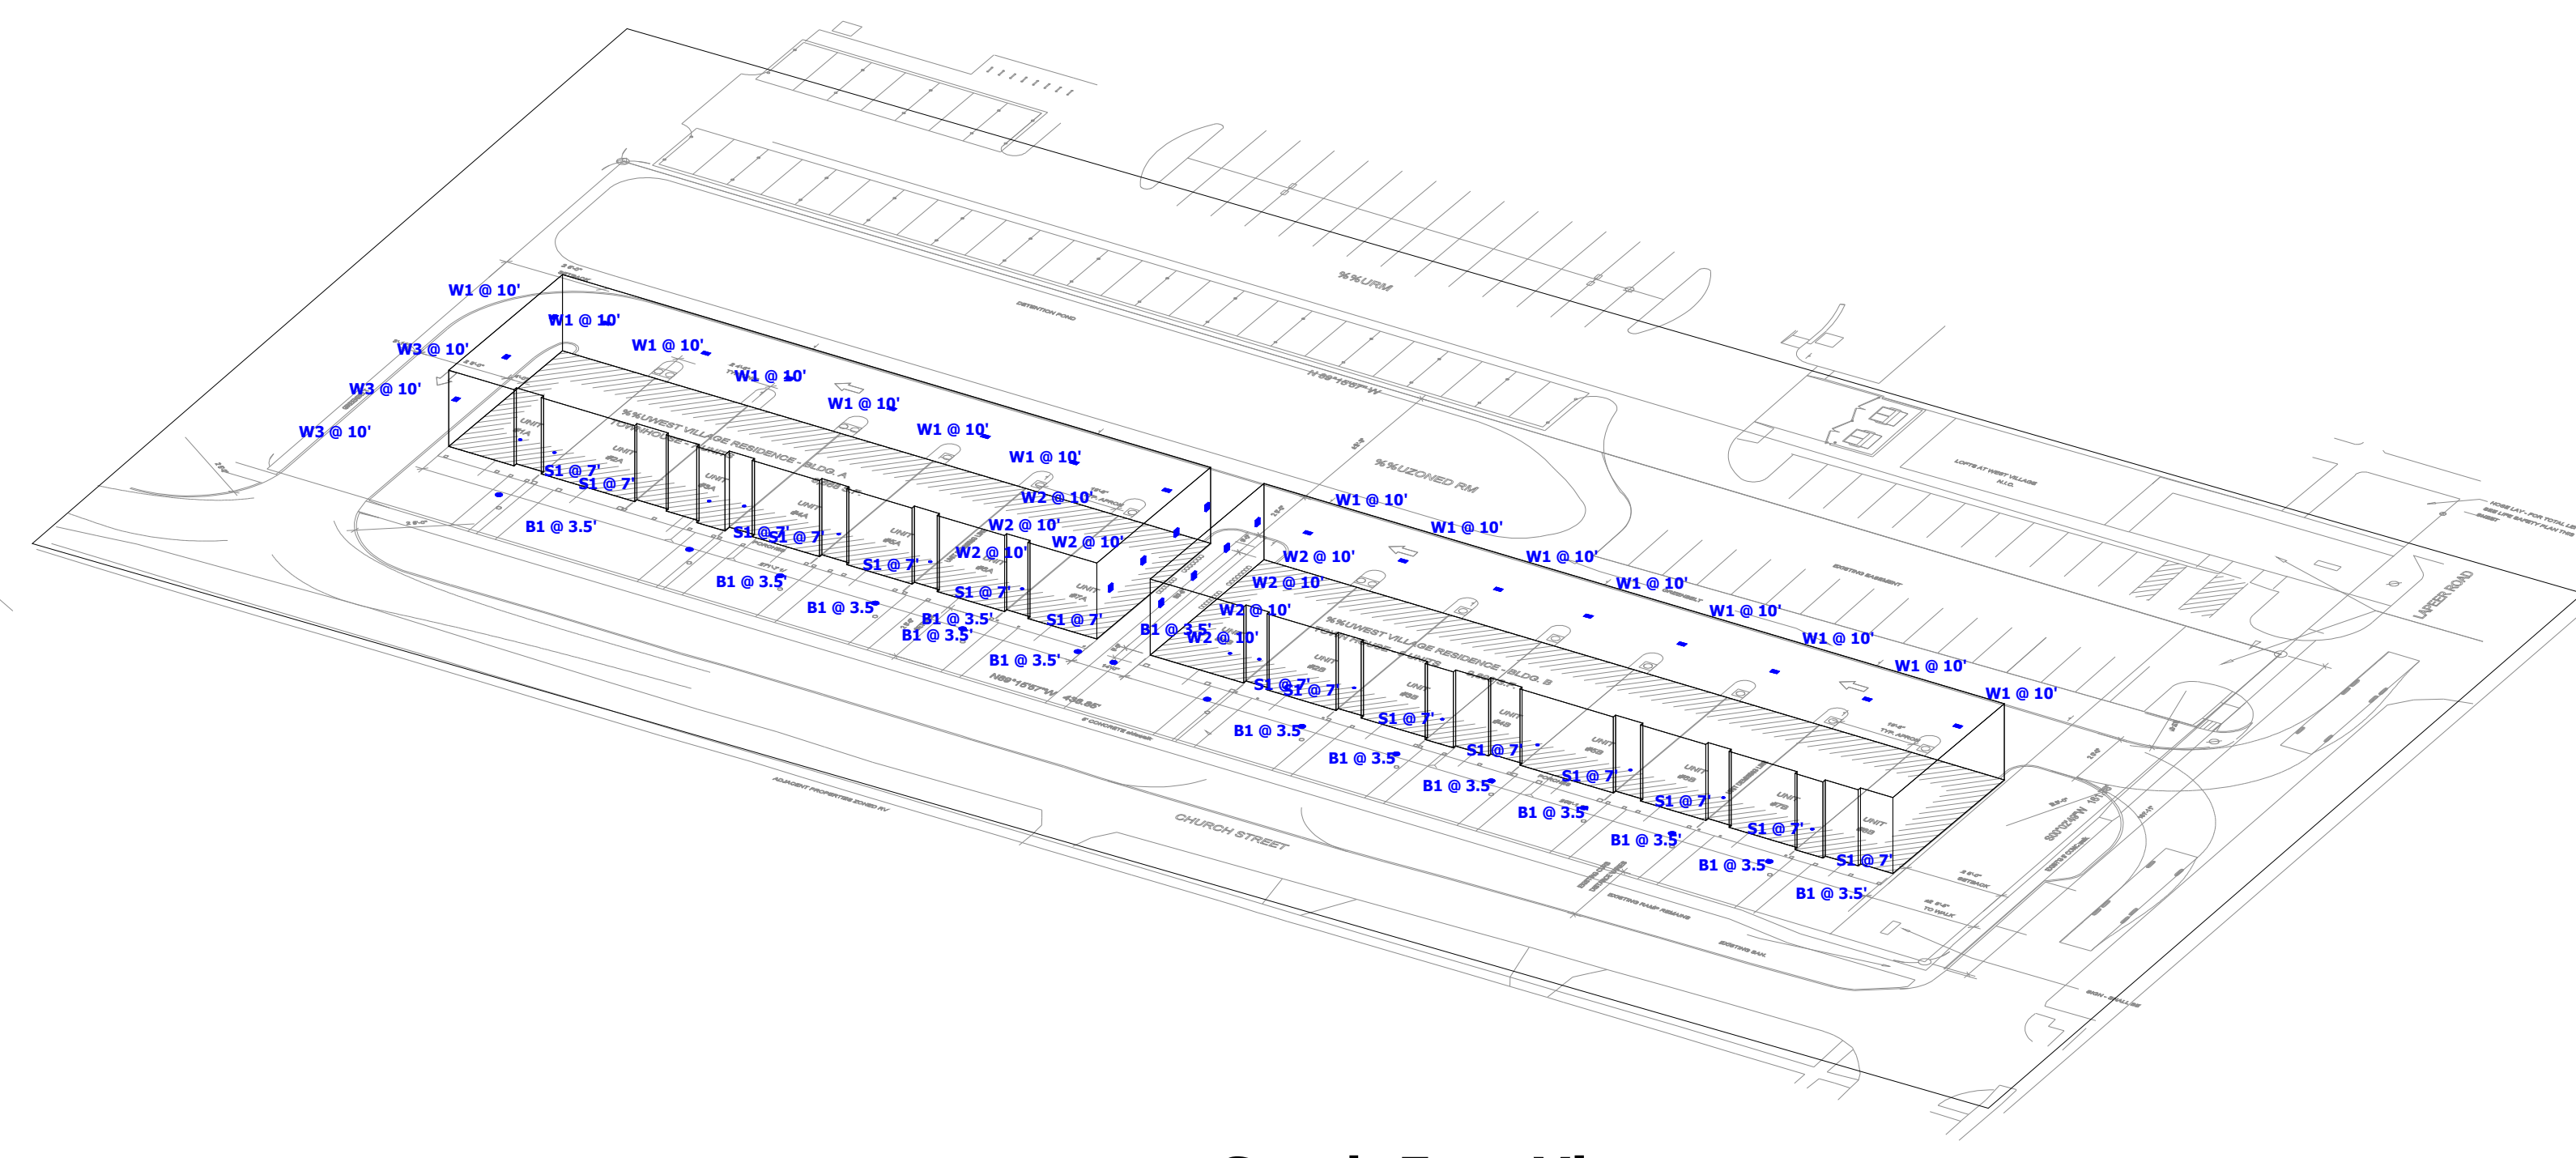

South East View



WEST VILLAGE RESIDENCE
EXTERIOR PHOTOGRAMETRIC PLAN
GASSER BUSH ASSOCIATES
WWW.GASSERBUSH.COM

Designer
BK
Date
06/23/2026
Scale
Not to Scale
Drawing No.
#25-46696 V6

UNIT
#4A

UNIT
#5A

UNIT DEM

UNIT
#6A

PORCHES

271'-7 1/2"

25'-0" SETBACK

Typ. Front Entries

