

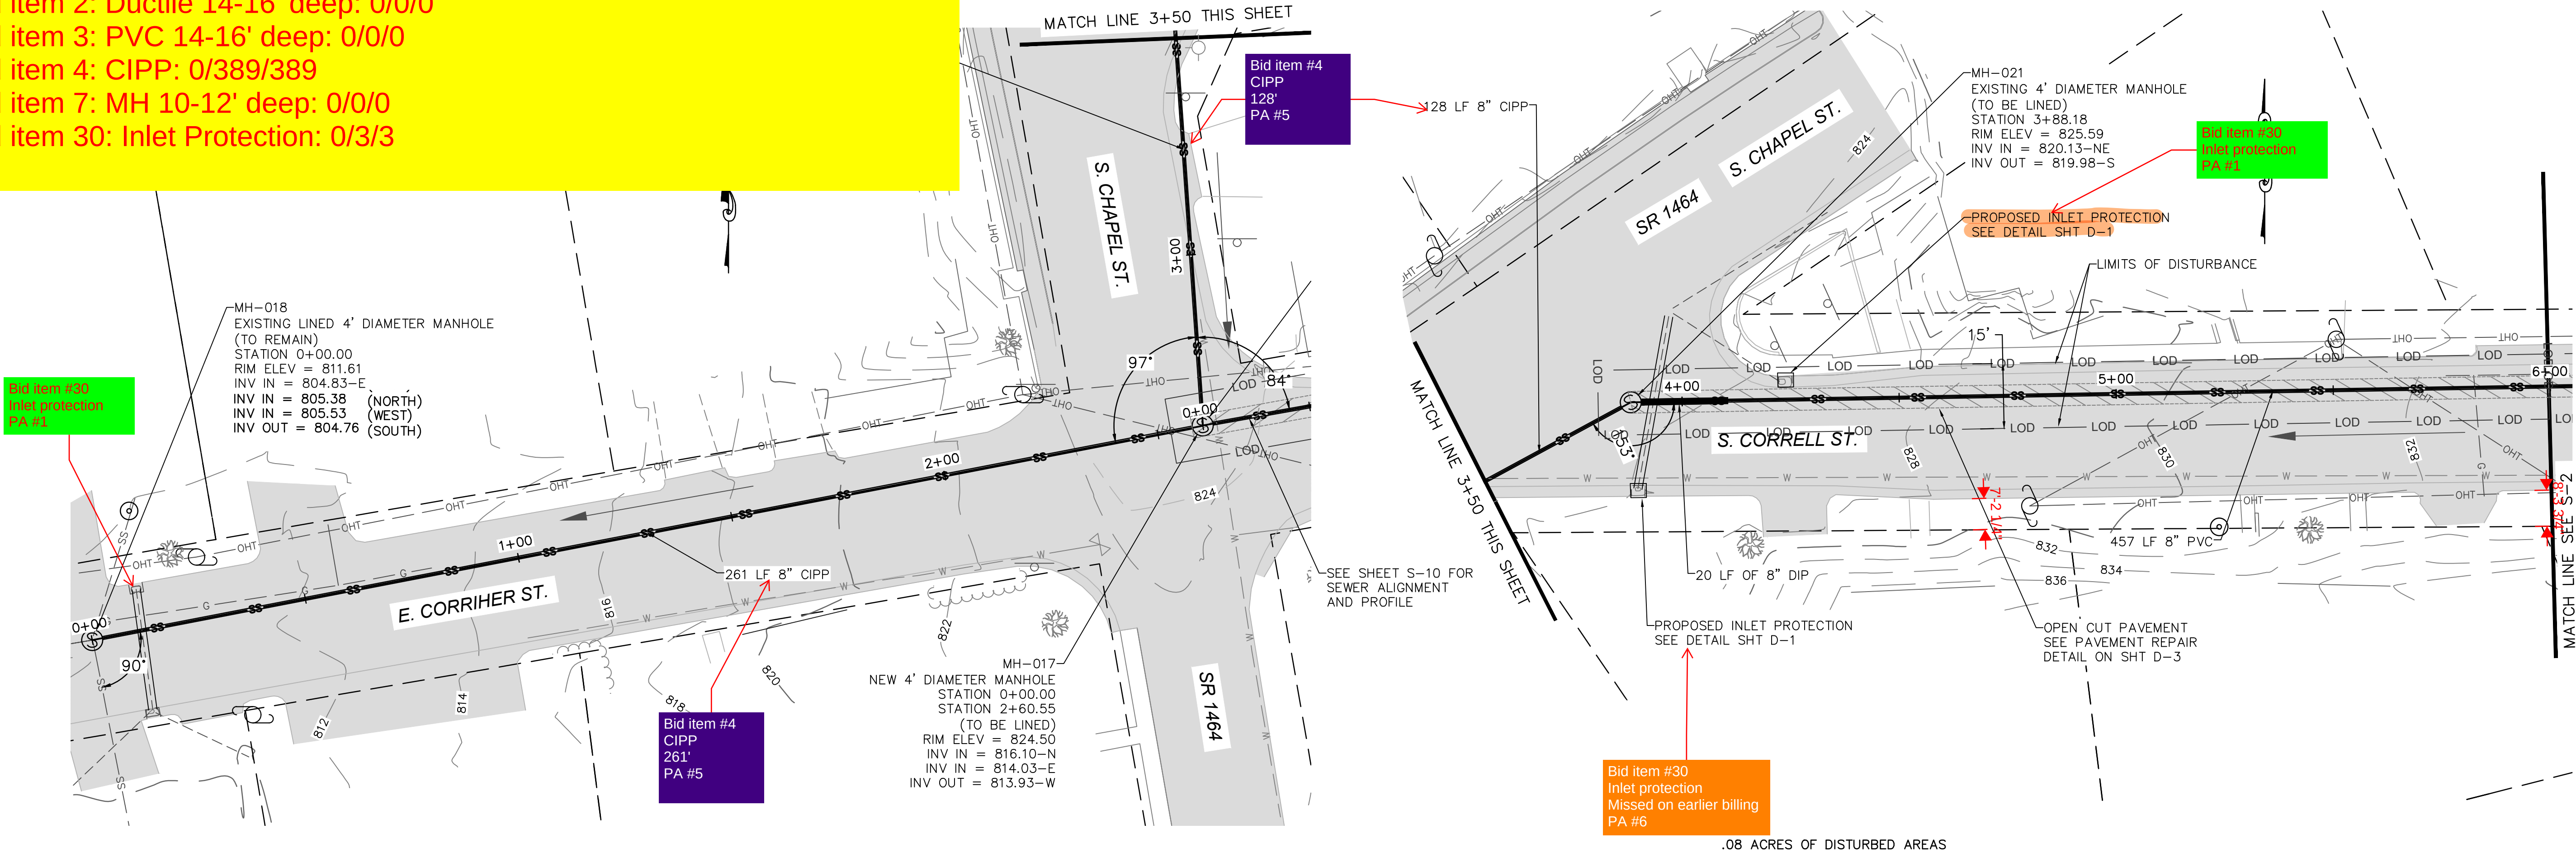
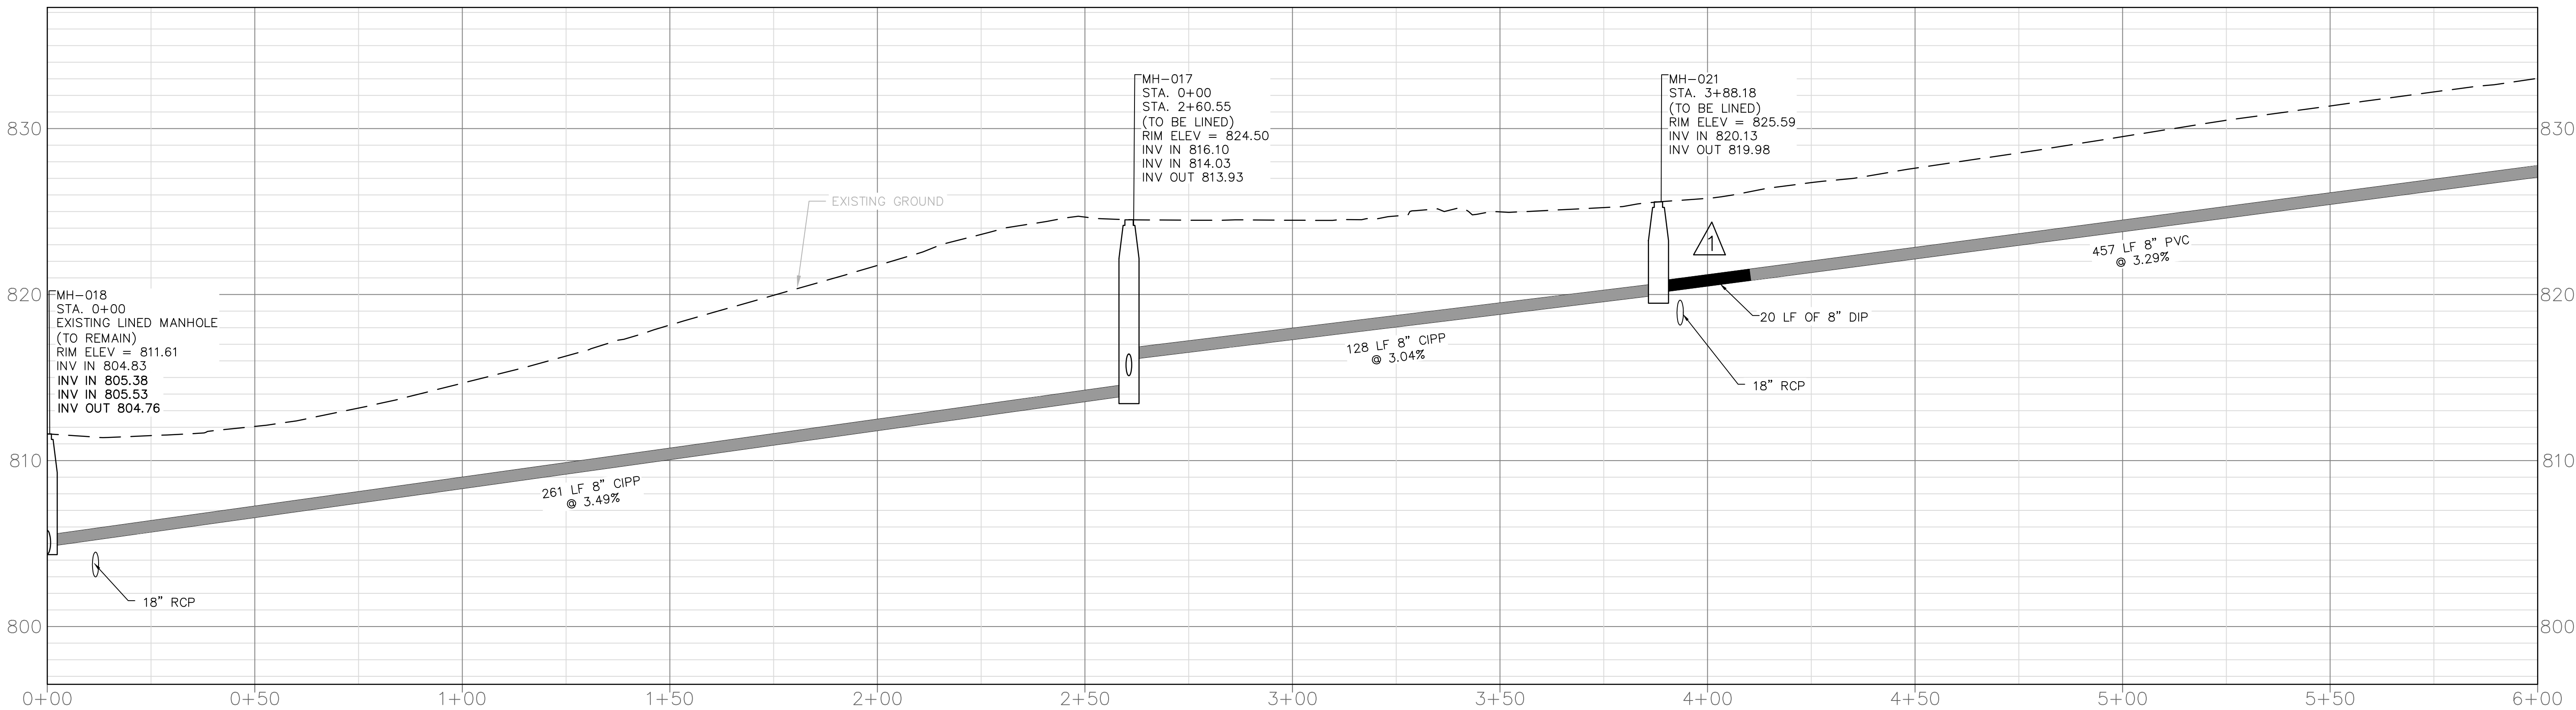




Change Order # 3 data.
Format (## / ## / ##) = (Previous page total / This Page total / Over all total)
Bid item 2: Ductile 14-16' deep: 0/0/0
Bid item 3: PVC 14-16' deep: 0/0/0
Bid item 4: CIPP: 0/389/389
Bid item 7: MH 10-12' deep: 0/0/0
Bid item 30: Inlet Protection: 0/3/3

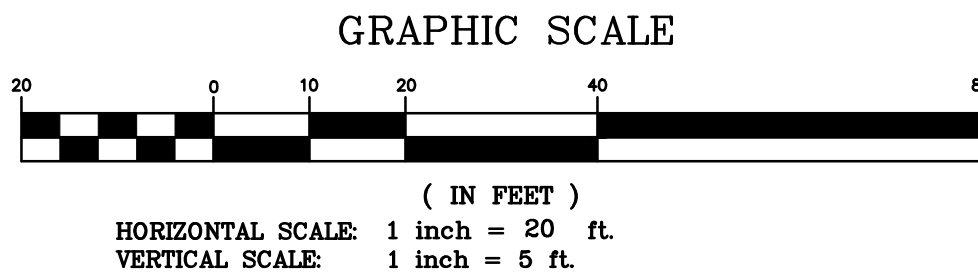


- NOTE:
1. CONTRACTOR RESPONSIBLE FOR FIELD VERIFYING ALL EXISTING UTILITIES PRIOR TO SEWER LINE INSTALLATION. EVEN IF EXISTING UTILITIES ARE SHOWN ON THE PLANS
 2. CONTRACTOR RESPONSIBLE FOR RECONNECTING ALL SEWER LATERALS INCLUDING THOSE THAT MAY NOT BE SHOWN ON PLAN SHEETS.
 3. RIGHT-OF-WAY AND PROPERTY LINES ARE SHOWN PER ROWAN COUNTY GIS INFORMATION AND HAVE NOT BEEN SURVEYED.

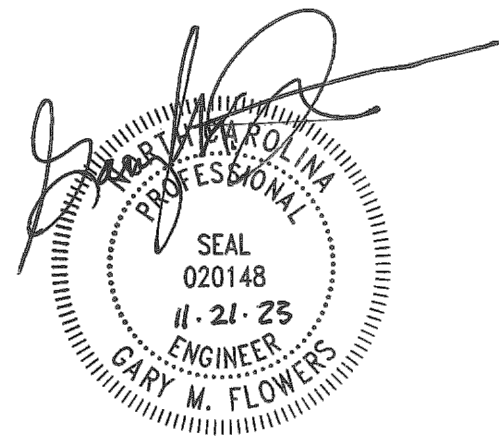



Change Order # 3 data.
Format (## / ## / ##) = (Previous page total / This Page total / Over all total)
Bid item 2: Ductile 14-16' deep: 0/0/0
Bid item 3: PVC 14-16' deep: 0/0/0
Bid item 4: CIPP: 389/805/1194
Bid item 7: MH 10-12' deep: 0/0/0
Bid item 30: Inlet Protection: 3/0/3

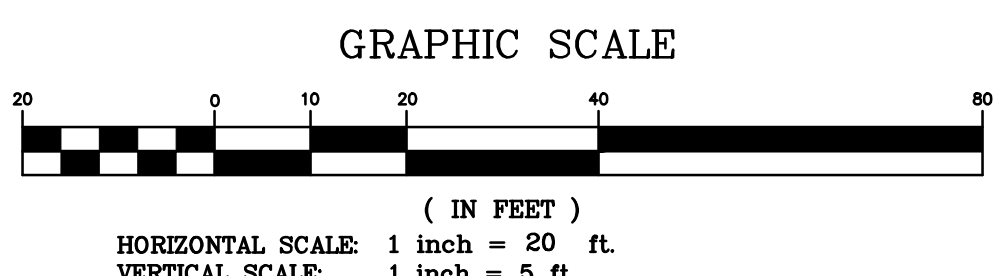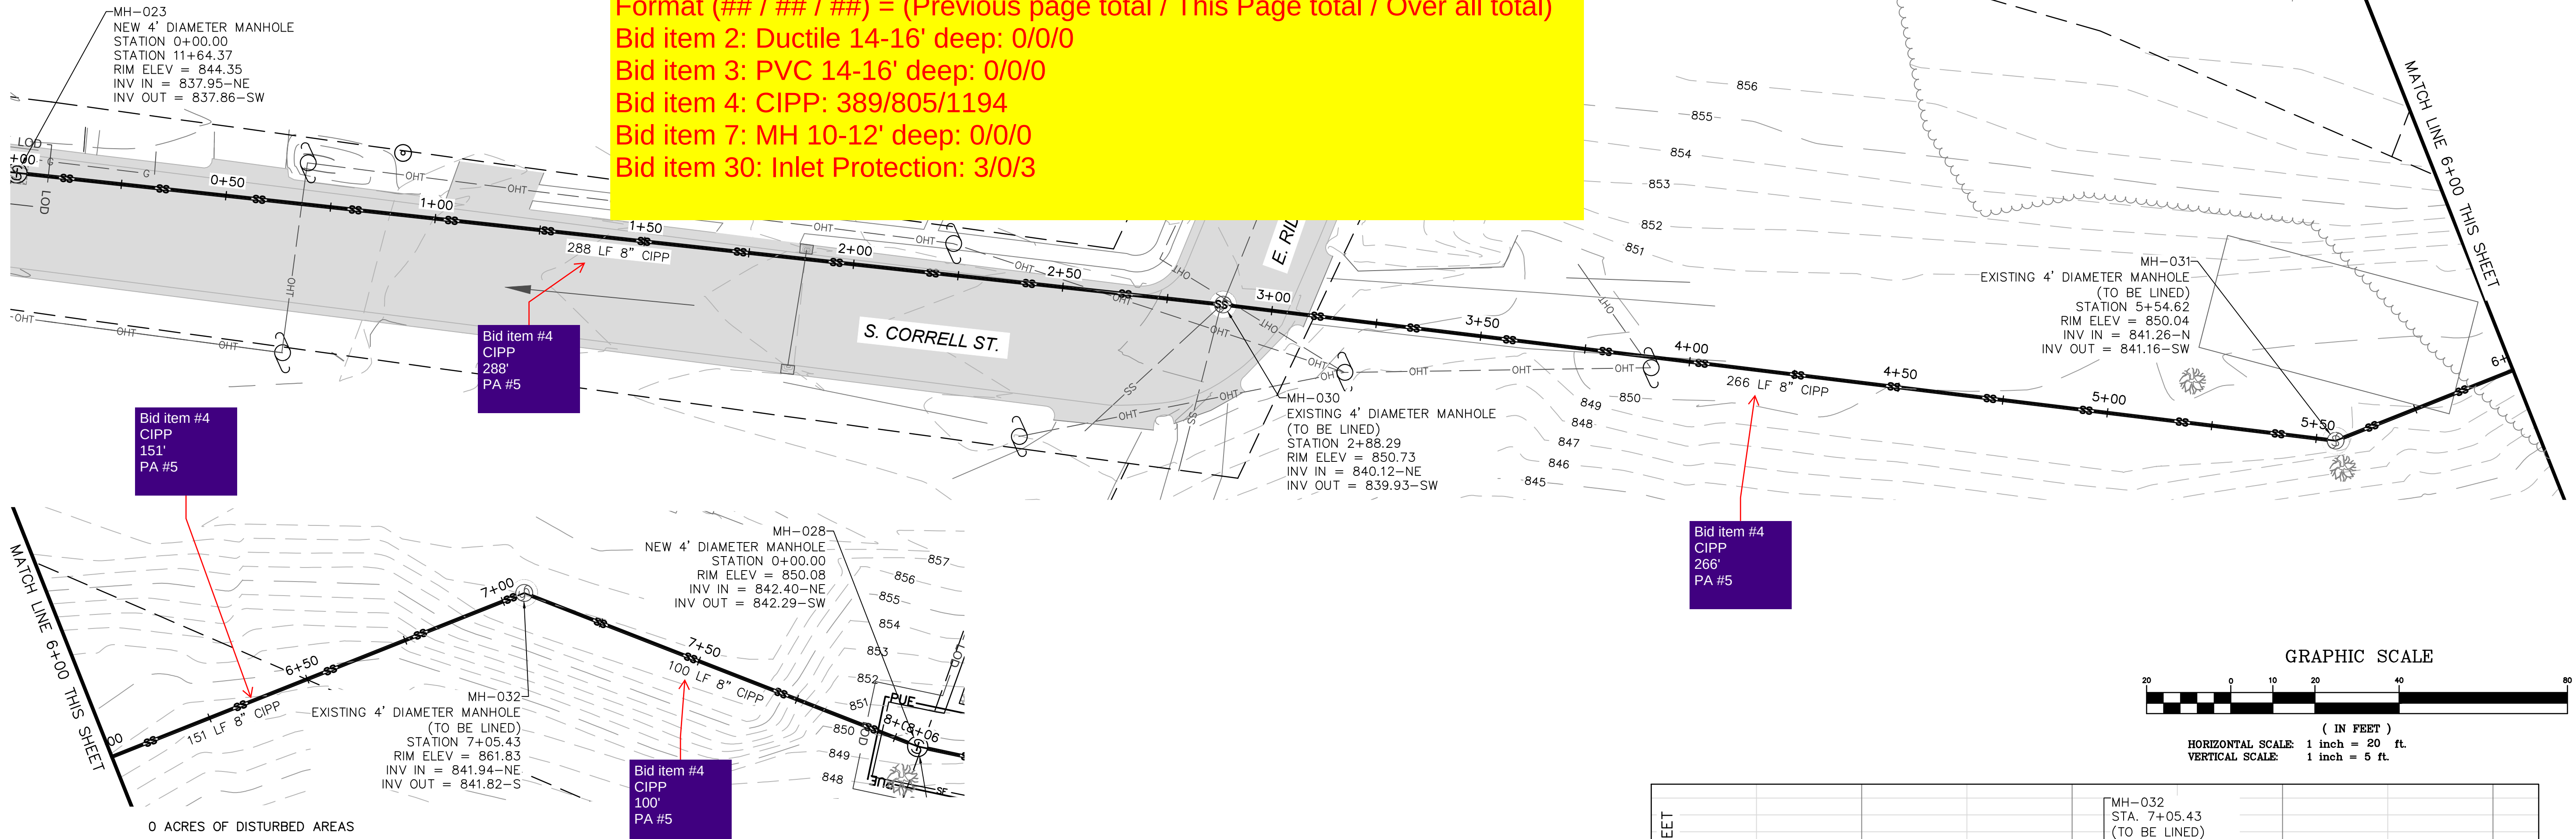

NOTE: SEWER SEGMENT (STA. 2+88.29 TO STA. 8+06) IS LESS THEN THE REQUIRED MINIMUM SLOPE OF 0.40% AND IS THEREFORE DEEMED A "HIGH PRIORITY" SEWER LINE.

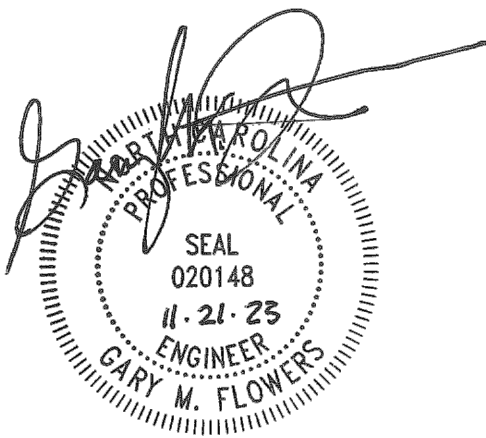

- NOTE:
1. CONTRACTOR RESPONSIBLE FOR FIELD VERIFYING ALL EXISTING UTILITIES PRIOR TO SEWER LINE INSTALLATION. EVEN IF EXISTING UTILITIES ARE SHOWN ON THE PLANS
 2. CONTRACTOR RESPONSIBLE FOR RECONNECTING ALL SEWER LATERALS INCLUDING THOSE THAT MAY NOT BE SHOWN ON PLAN SHEETS.
 3. RIGHT-OF-WAY AND PROPERTY LINES ARE SHOWN PER ROWAN COUNTY GIS INFORMATION AND HAVE NOT BEEN SURVEYED.

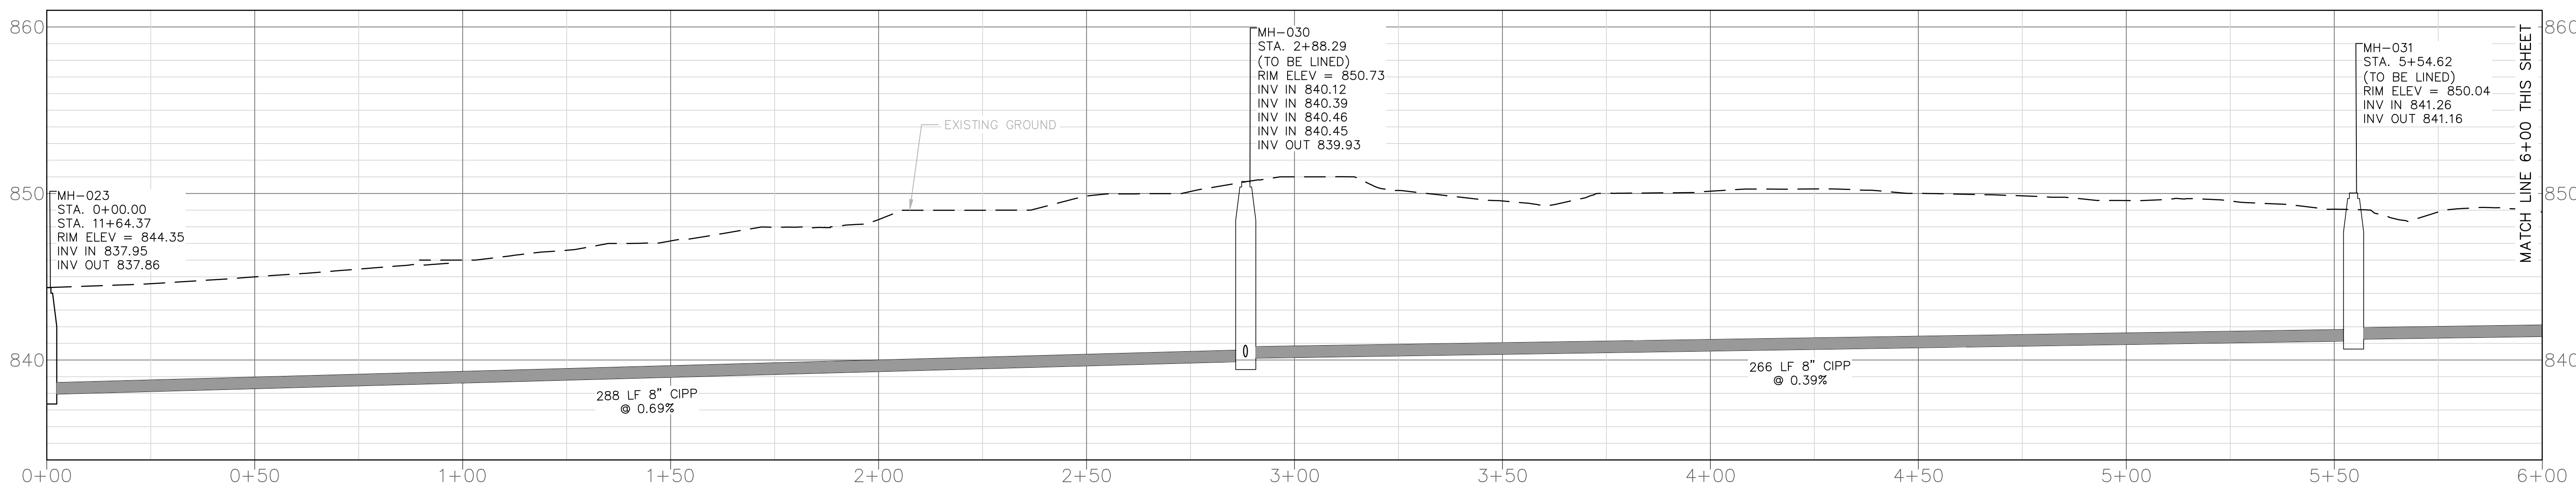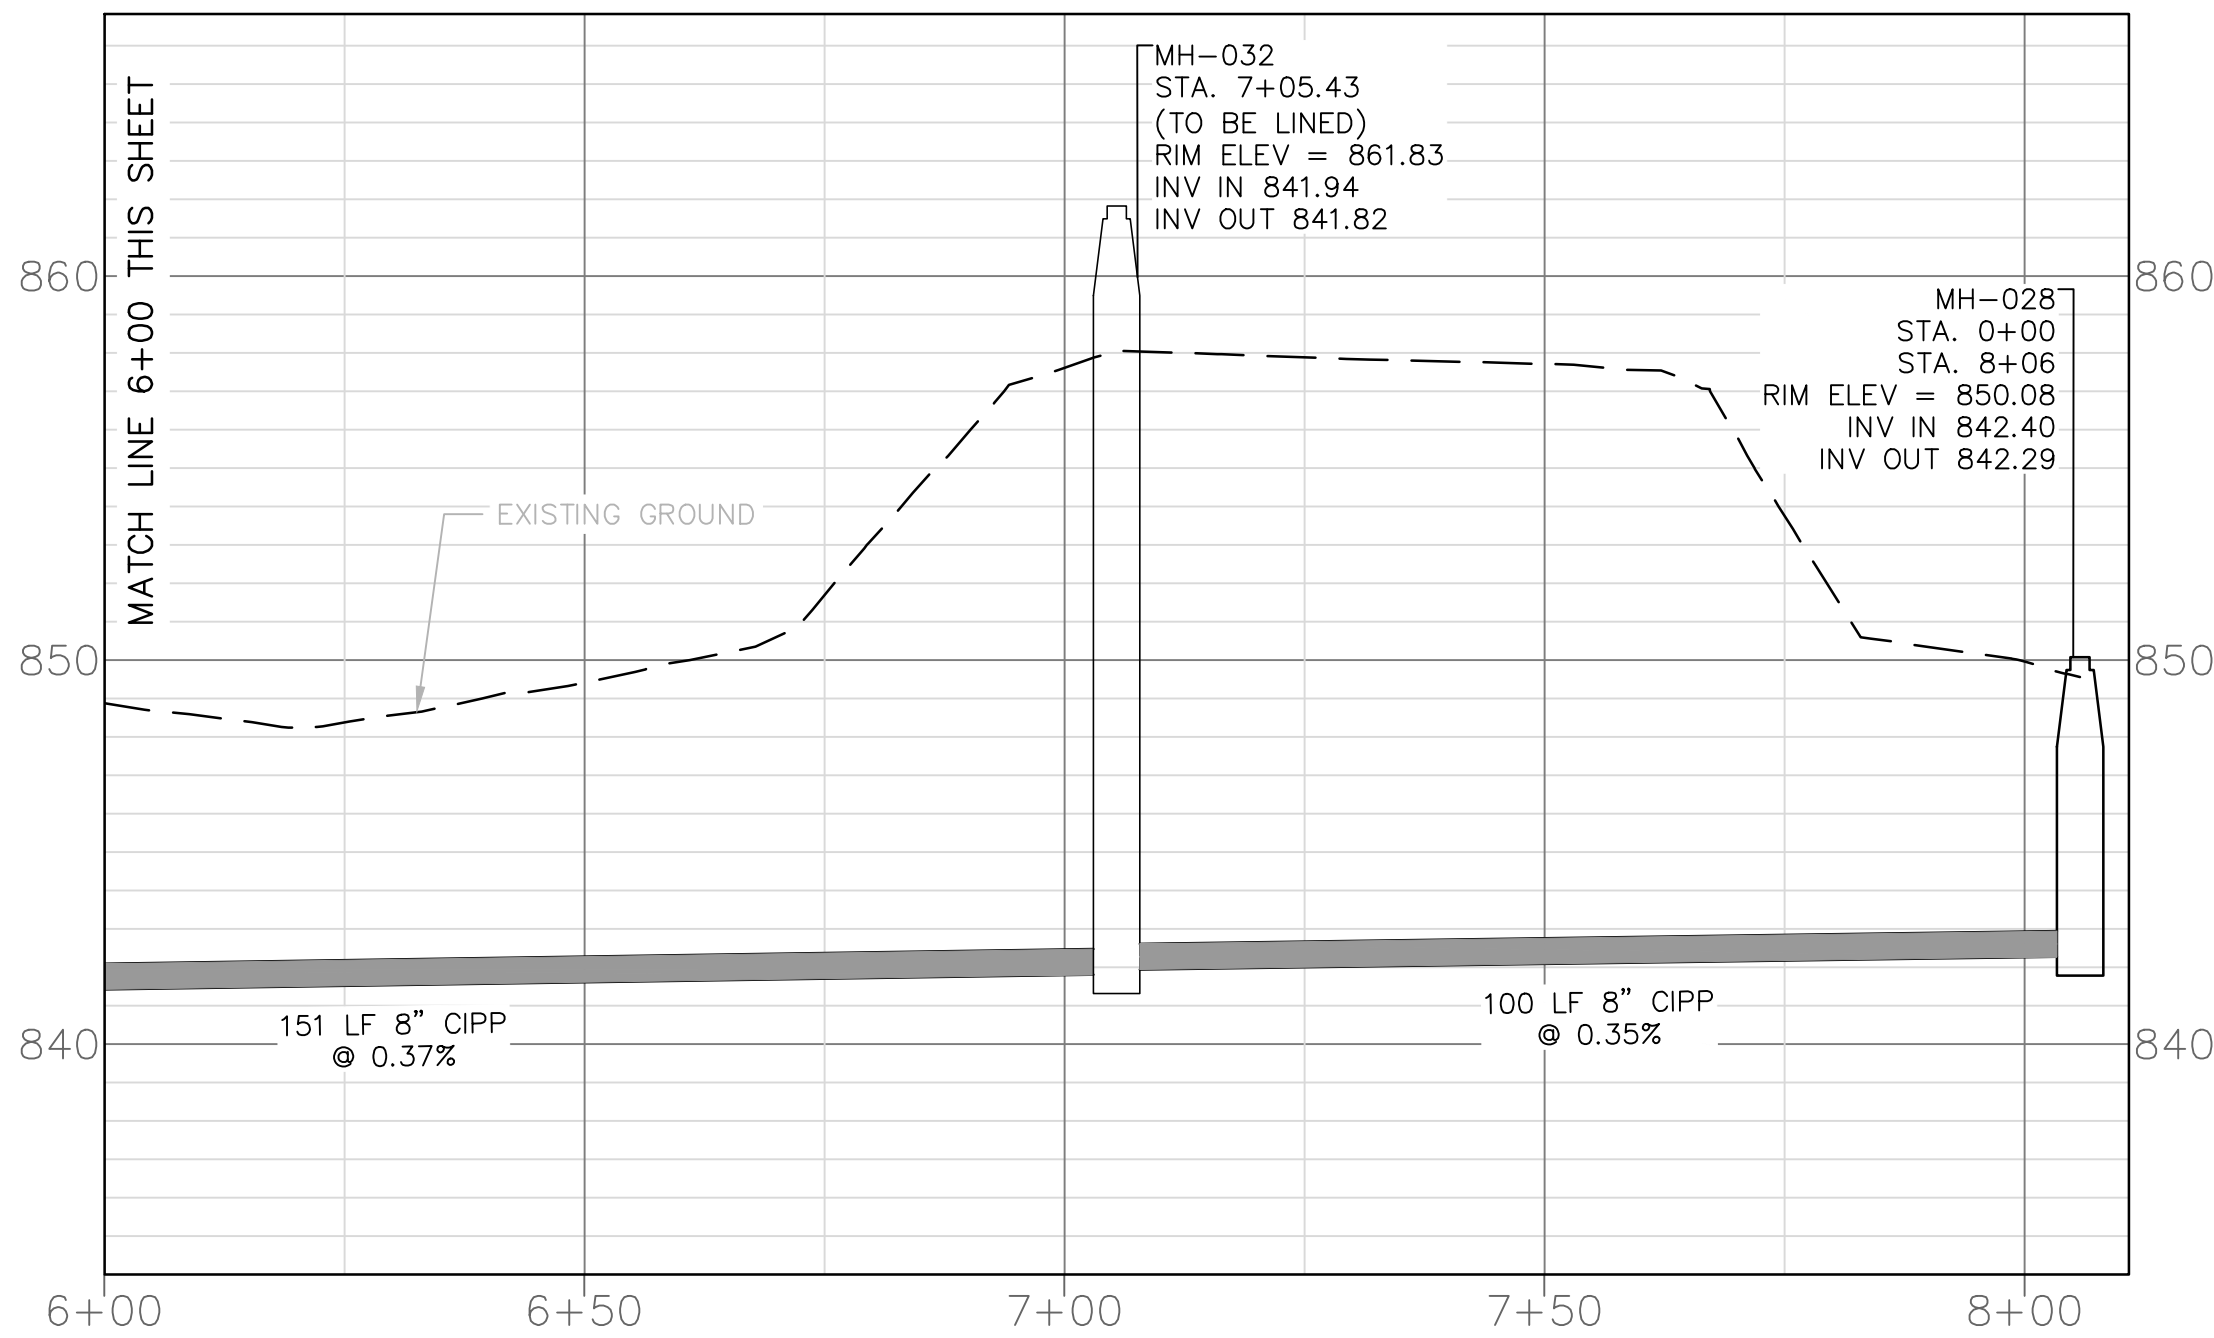

MUNICIPAL ENGINEERING, INC.
68 SHIPWASH DRIVE, GARNER, NC 27529 • PHONE: 919-772-5393
P.O. BOX 349, BOONE, NC 28607 • PHONE: 828-262-1767
LICENSE NUMBERS: F-0812 & C-586


MUNICIPAL ENGINEERING, INC.

TOWN OF LANDIS
SANITARY SEWER SYSTEM REHAB
ROWAN COUNTY, NORTH CAROLINA


DATE	BY	REV.	DESCRIPTION
11-21-23	R. MOSS	1	AS SHOWN

SCALE: AS SHOWN
DATE: 9-22-2022
DRWN. BY: R. MOSS
CHKD. BY: G. FLOWERS
PROJECT NUMBER: G20053.0
DRAWING NO.: S-2A
SHEET NO.: 6

Change Order # 3 data.
Format (## / ## / ##) = (Previous page total / This Page total / Over all total)
Bid item 2: Ductile 14-16' deep: 0/0/0
Bid item 3: PVC 14-16' deep: 0/0/0
Bid item 4: CIPP: 1194/0/1194
Bid item 7: MH 10-12' deep: 0/1/1
Bid item 30: Inlet Protection: 3/0/3


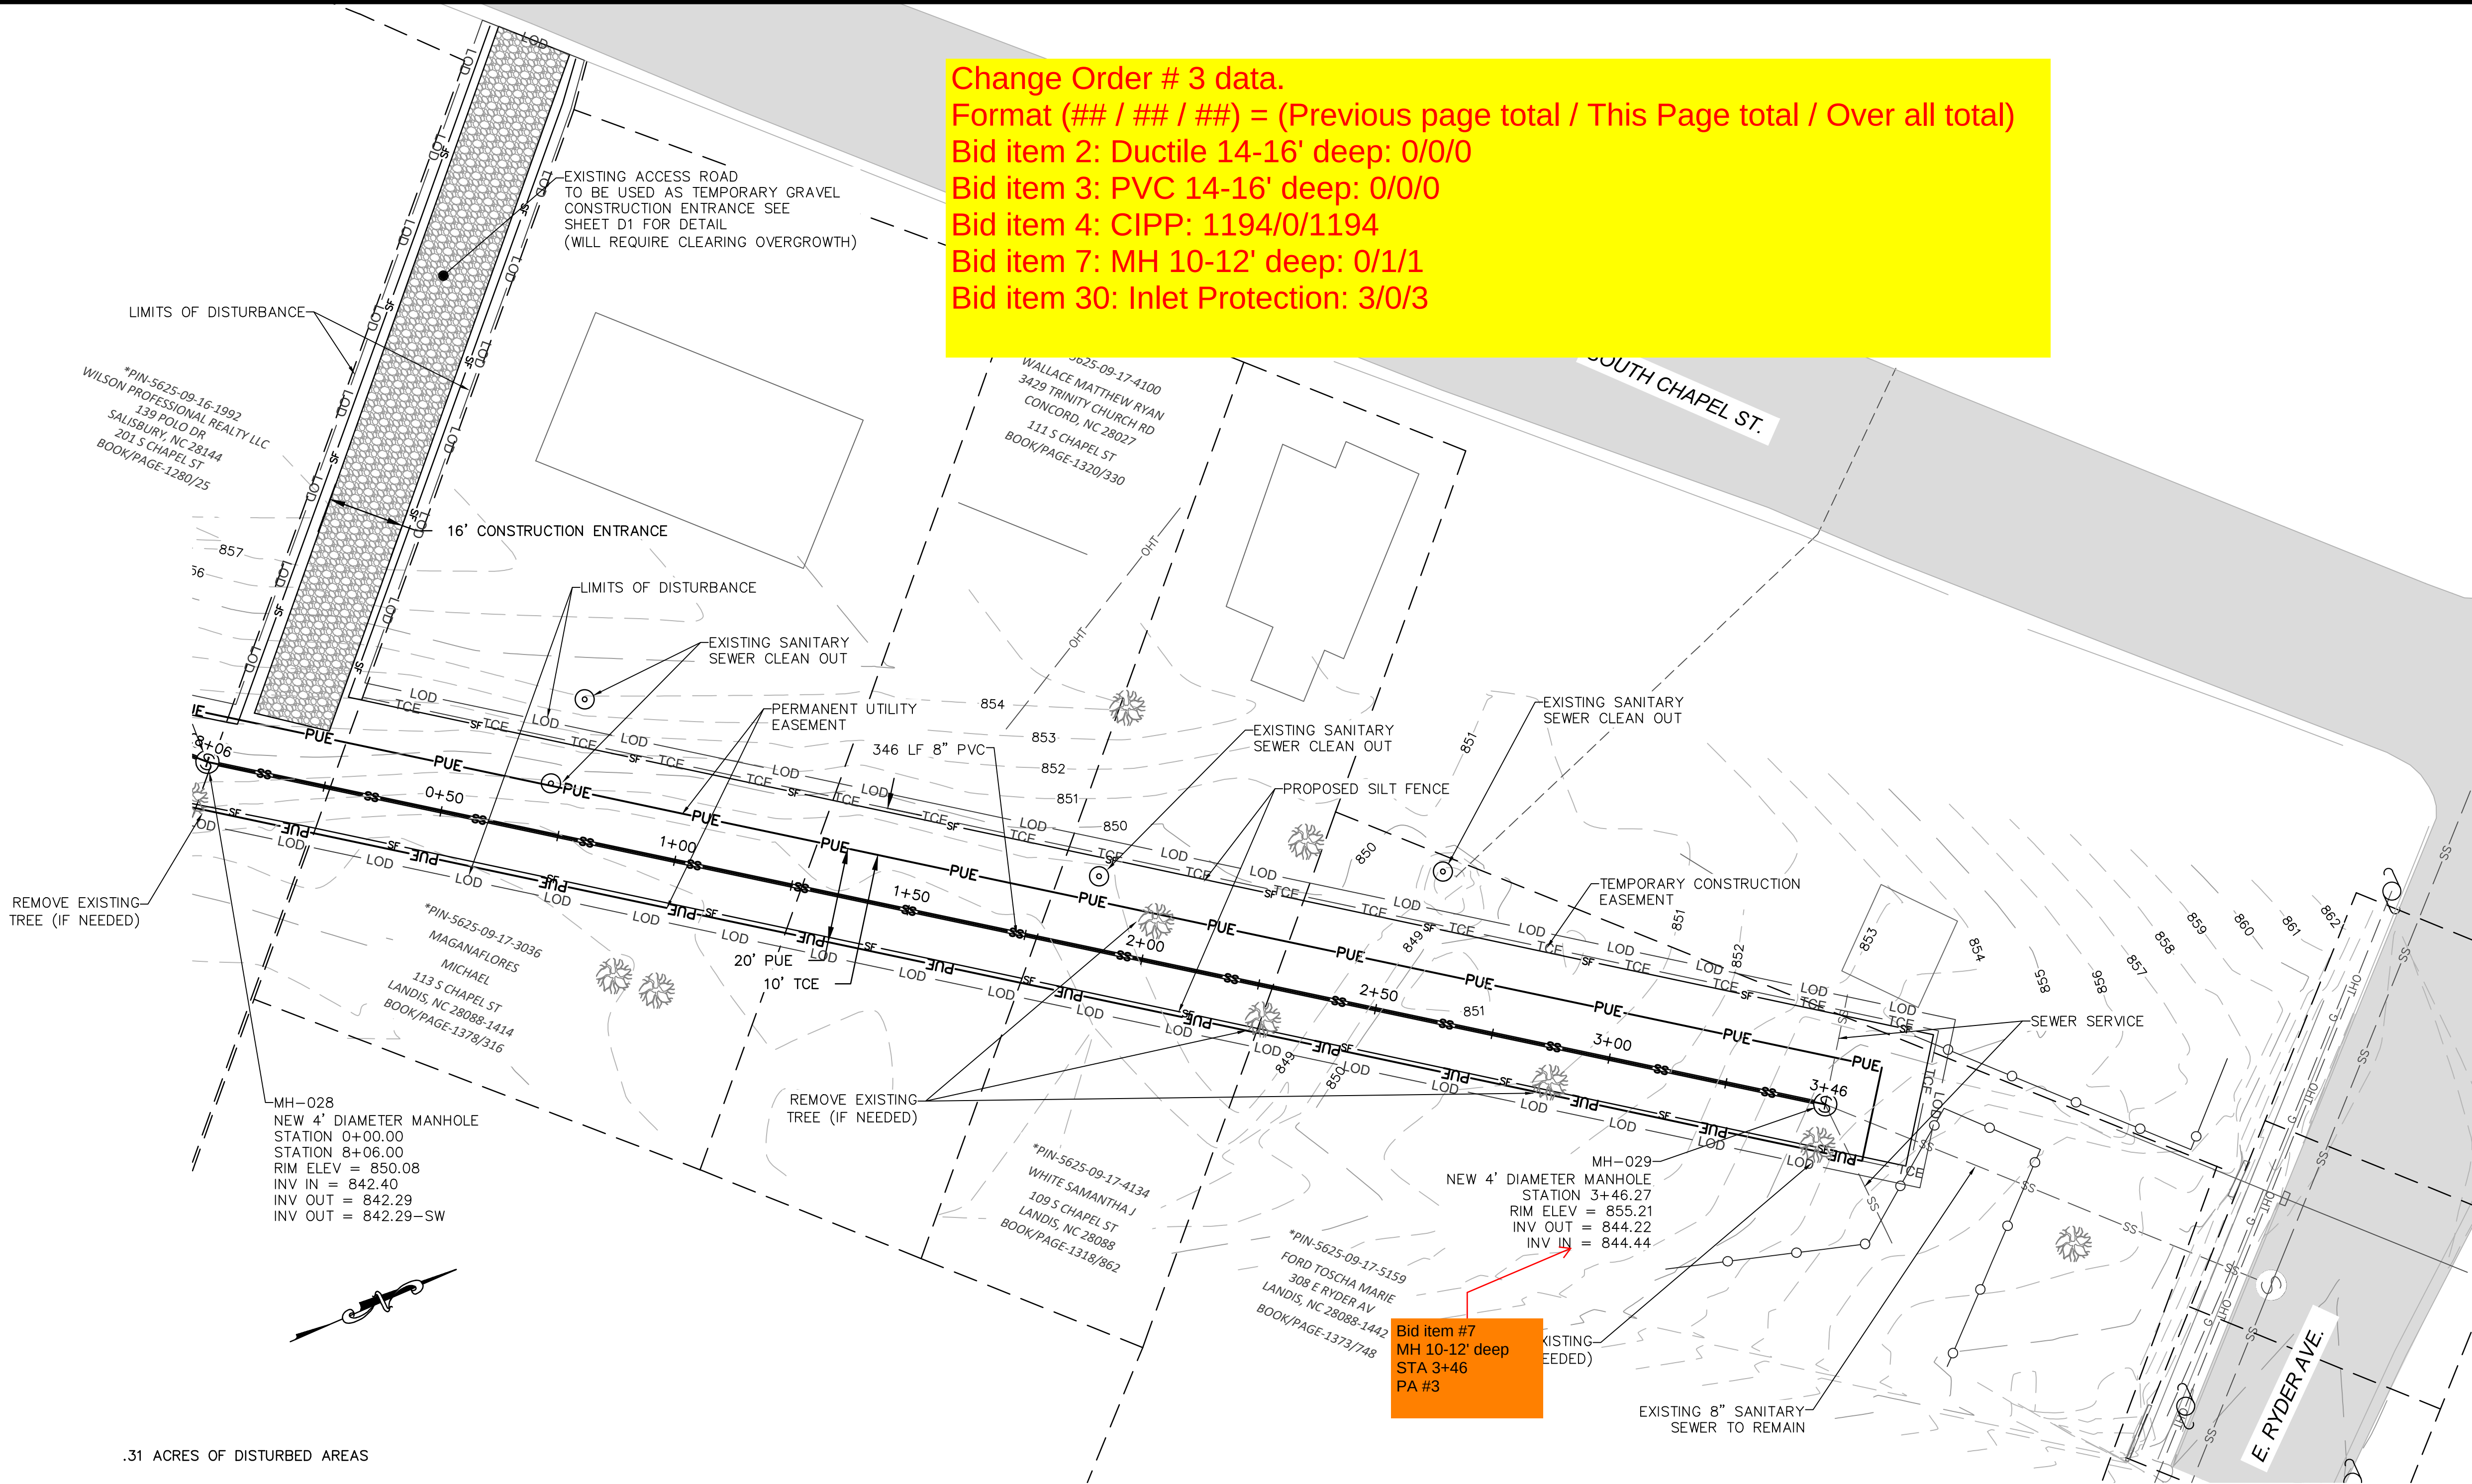


.31 ACRES OF DISTURBED AREAS

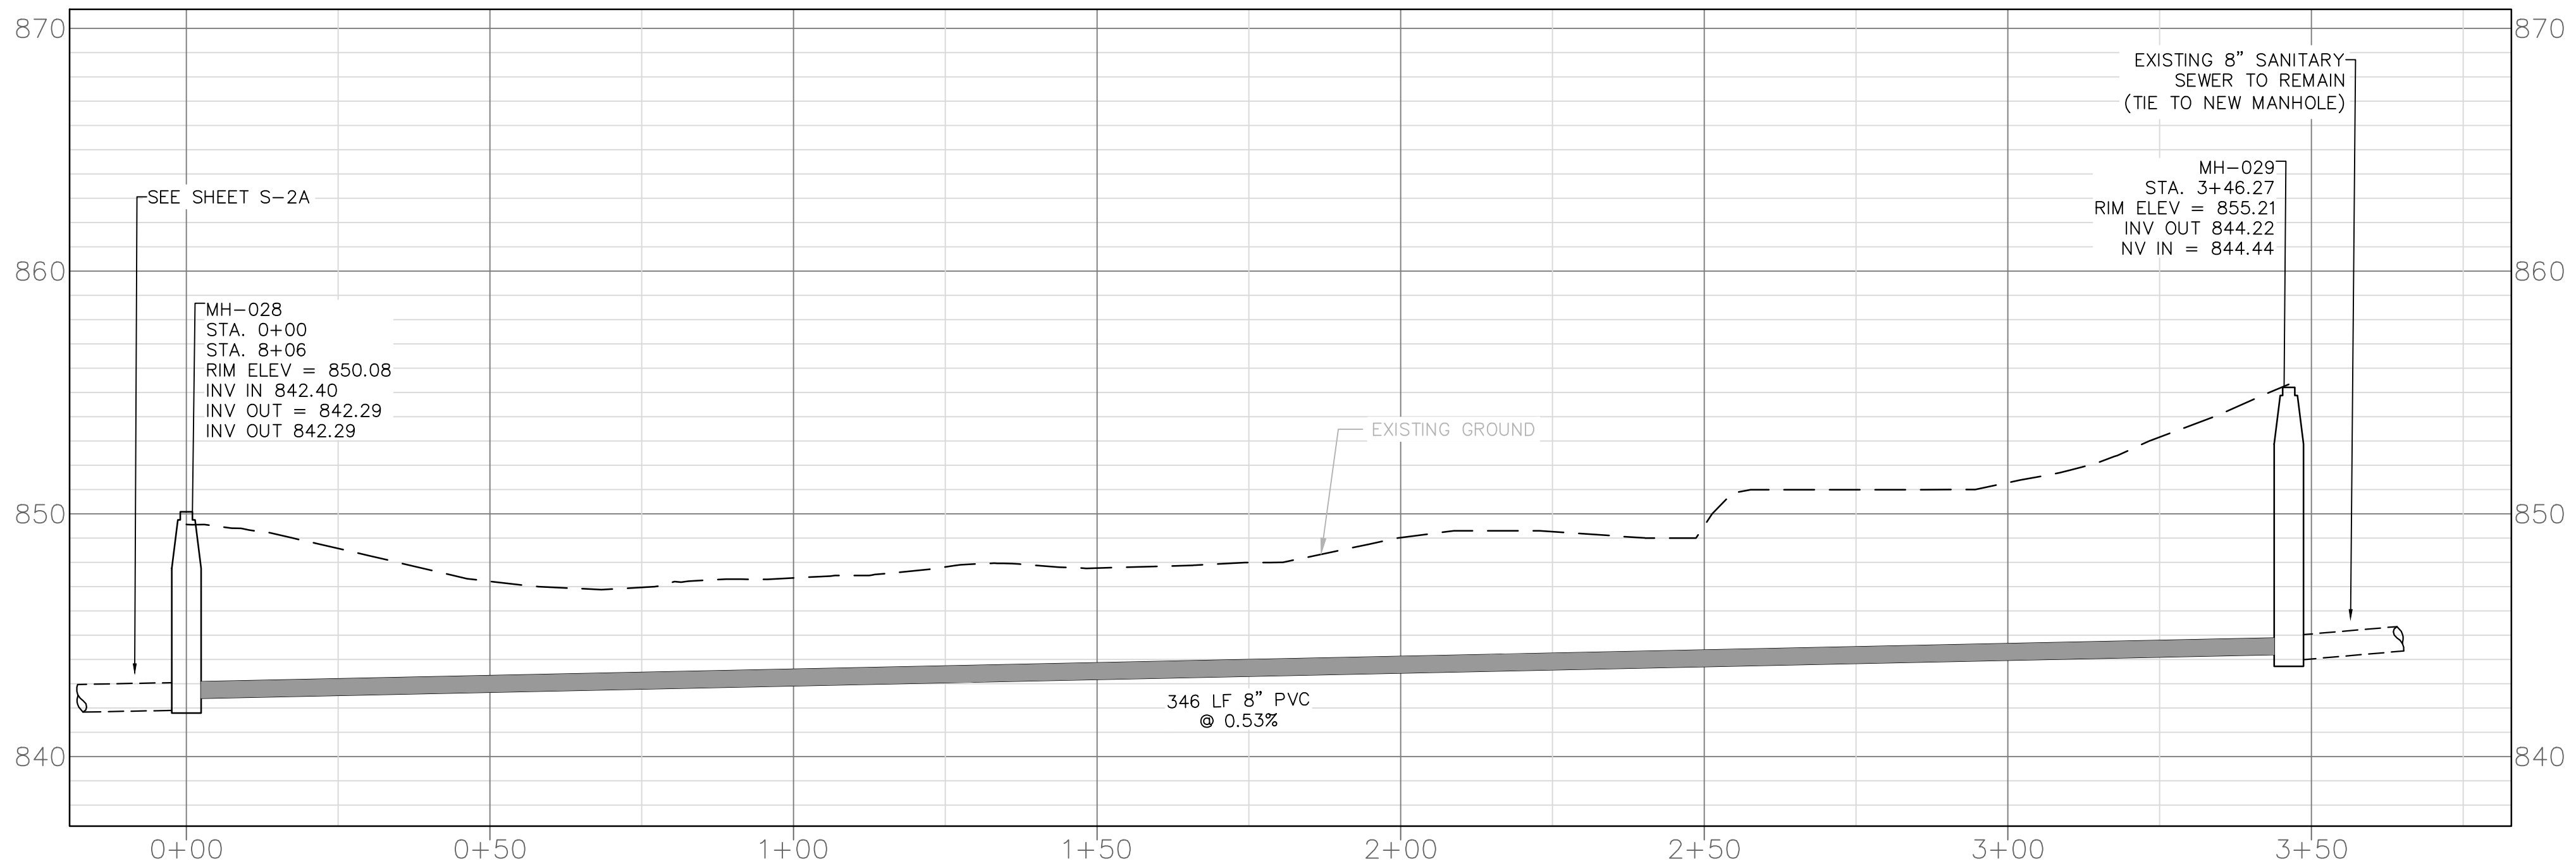

NOTE:

- CONTRACTOR RESPONSIBLE FOR FIELD VERIFYING ALL EXISTING UTILITIES PRIOR TO SEWER LINE INSTALLATION. EVEN IF EXISTING UTILITIES ARE SHOWN ON THE PLANS
- CONTRACTOR RESPONSIBLE FOR RECONNECTING ALL SEWER LATERALS INCLUDING THOSE THAT MAY NOT BE SHOWN ON PLAN SHEETS.
- RIGHT-OF-WAY AND PROPERTY LINES ARE SHOWN PER ROWAN COUNTY GIS INFORMATION AND HAVE NOT BEEN SURVEYED.

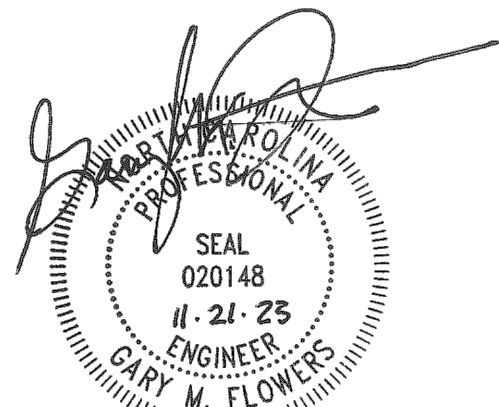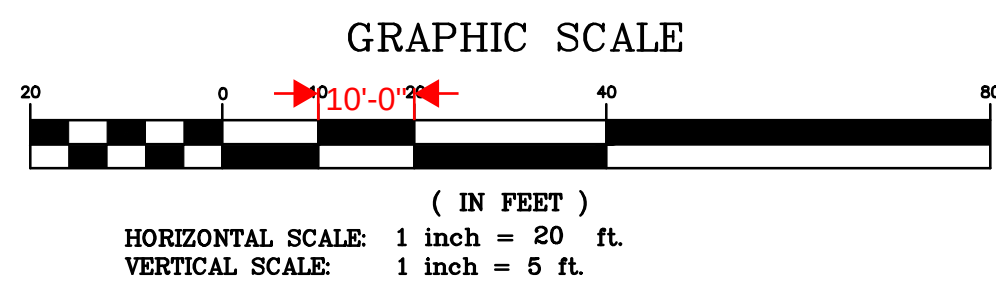


MUNICIPAL ENGINEERING, INC.
68 SHIPWASH DRIVE, GARNER, NC 27529 • PHONE: 919-772-5393
P.O. BOX 349, BOONE, NC 28607 • PHONE: 828-262-1767
LICENSE NUMBERS: F-0812 & C-586



TOWN OF LANDIS
SANITARY SEWER SYSTEM REHAB
ROWAN COUNTY, NORTH CAROLINA




DATE	BY	REV.	DESCRIPTION
			PLAN AND PROFILE
SCALE: AS SHOWN			
DATE: 9-22-2022			
DRWN. BY: R. MOSS			
CHKD. BY: G. FLOWERS			
PROJECT NUMBER			
G20053.0			
DRAWING NO.		SHEET NO.	
S-3		7	

Change Order # 3 data.
Format (## / ## / ##) = (Previous page total / This Page total / Over all total)
Bid item 2: Ductile 14-16' deep: 0/0/0
Bid item 3: PVC 14-16' deep: 0/0/0
Bid item 4: CIPP: 1194/0/1194
Bid item 7: MH 10-12' deep: 1/0/1
Bid item 30: Inlet Protection: 3/1/4

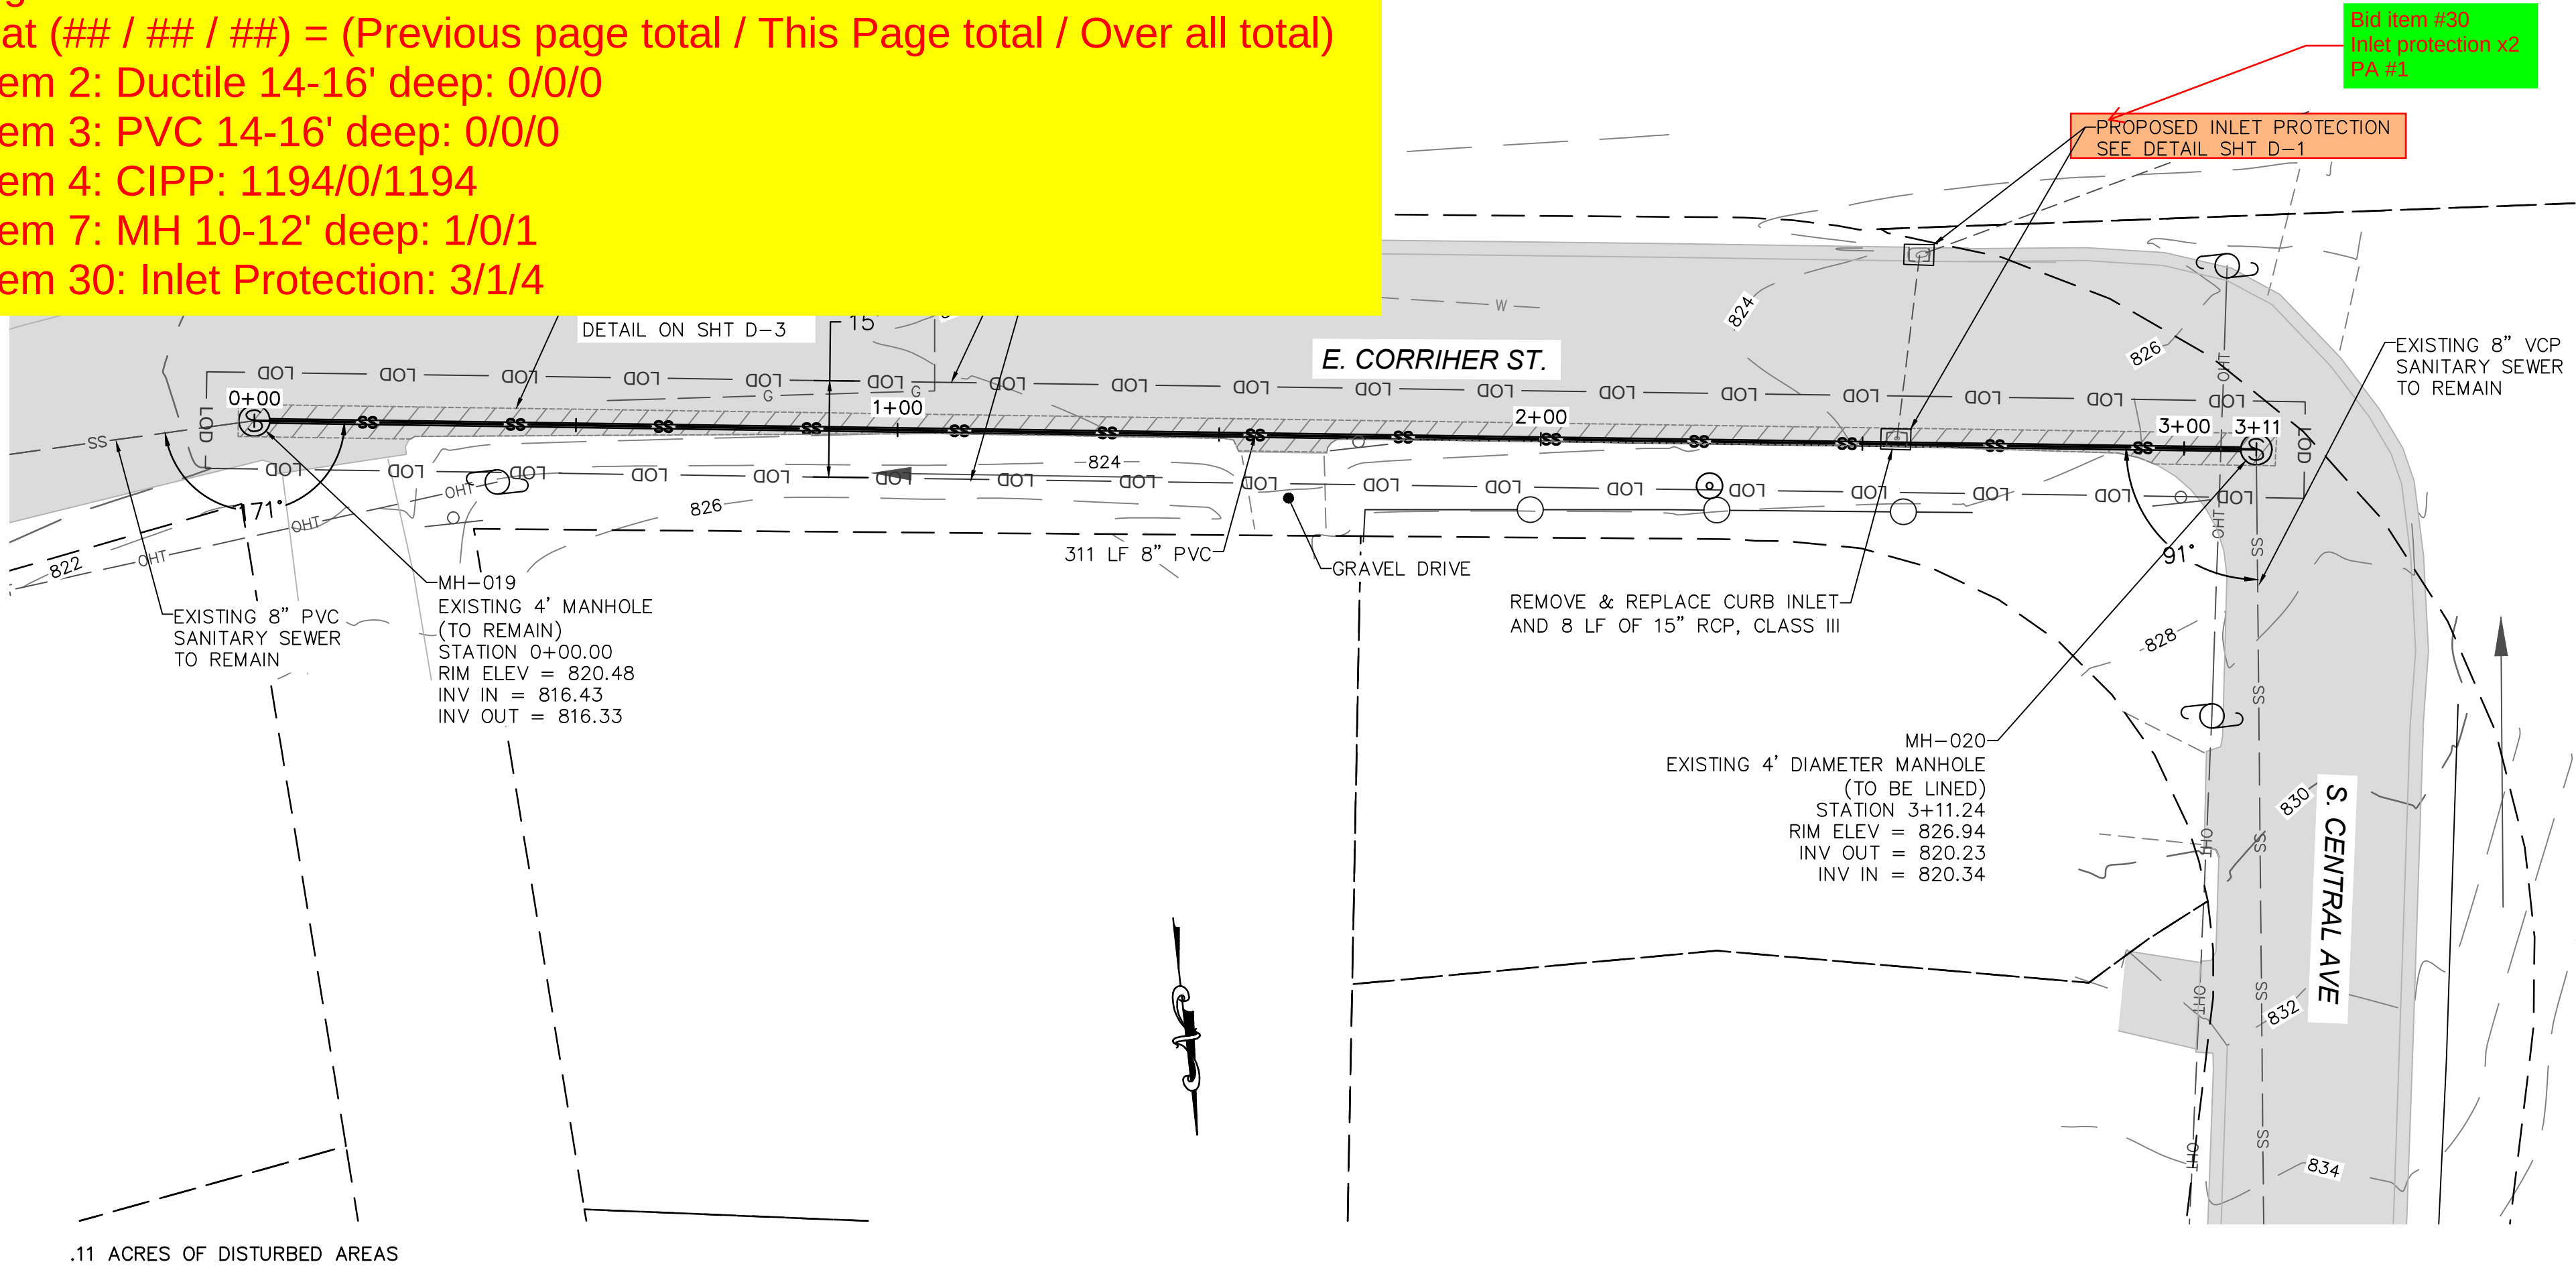

NOTE:




1. CONTRACTOR RESPONSIBLE FOR FIELD VERIFYING ALL EXISTING UTILITIES PRIOR TO SEWER LINE INSTALLATION. EVEN IF EXISTING UTILITIES ARE SHOWN ON THE PLANS
2. CONTRACTOR RESPONSIBLE FOR RECONNECTING ALL SEWER LATERALS INCLUDING THOSE THAT MAY NOT BE SHOWN ON PLAN SHEETS.
3. RIGHT-OF-WAY AND PROPERTY LINES ARE SHOWN PER ROWAN COUNTY GIS INFORMATION AND HAVE NOT BEEN SURVEYED.

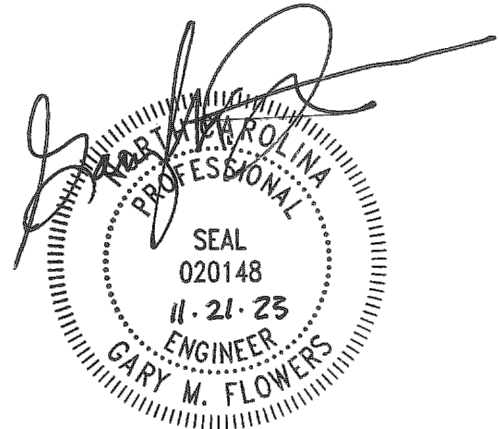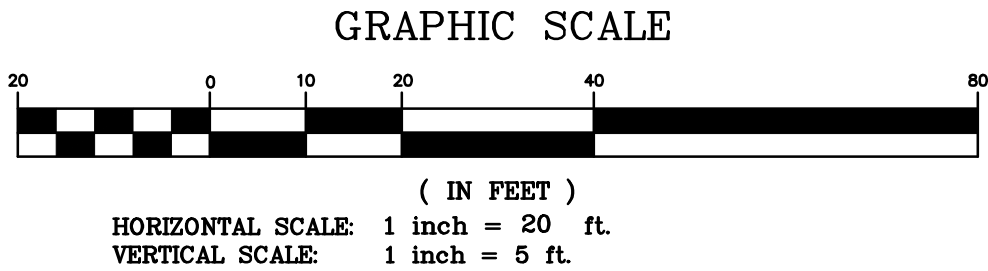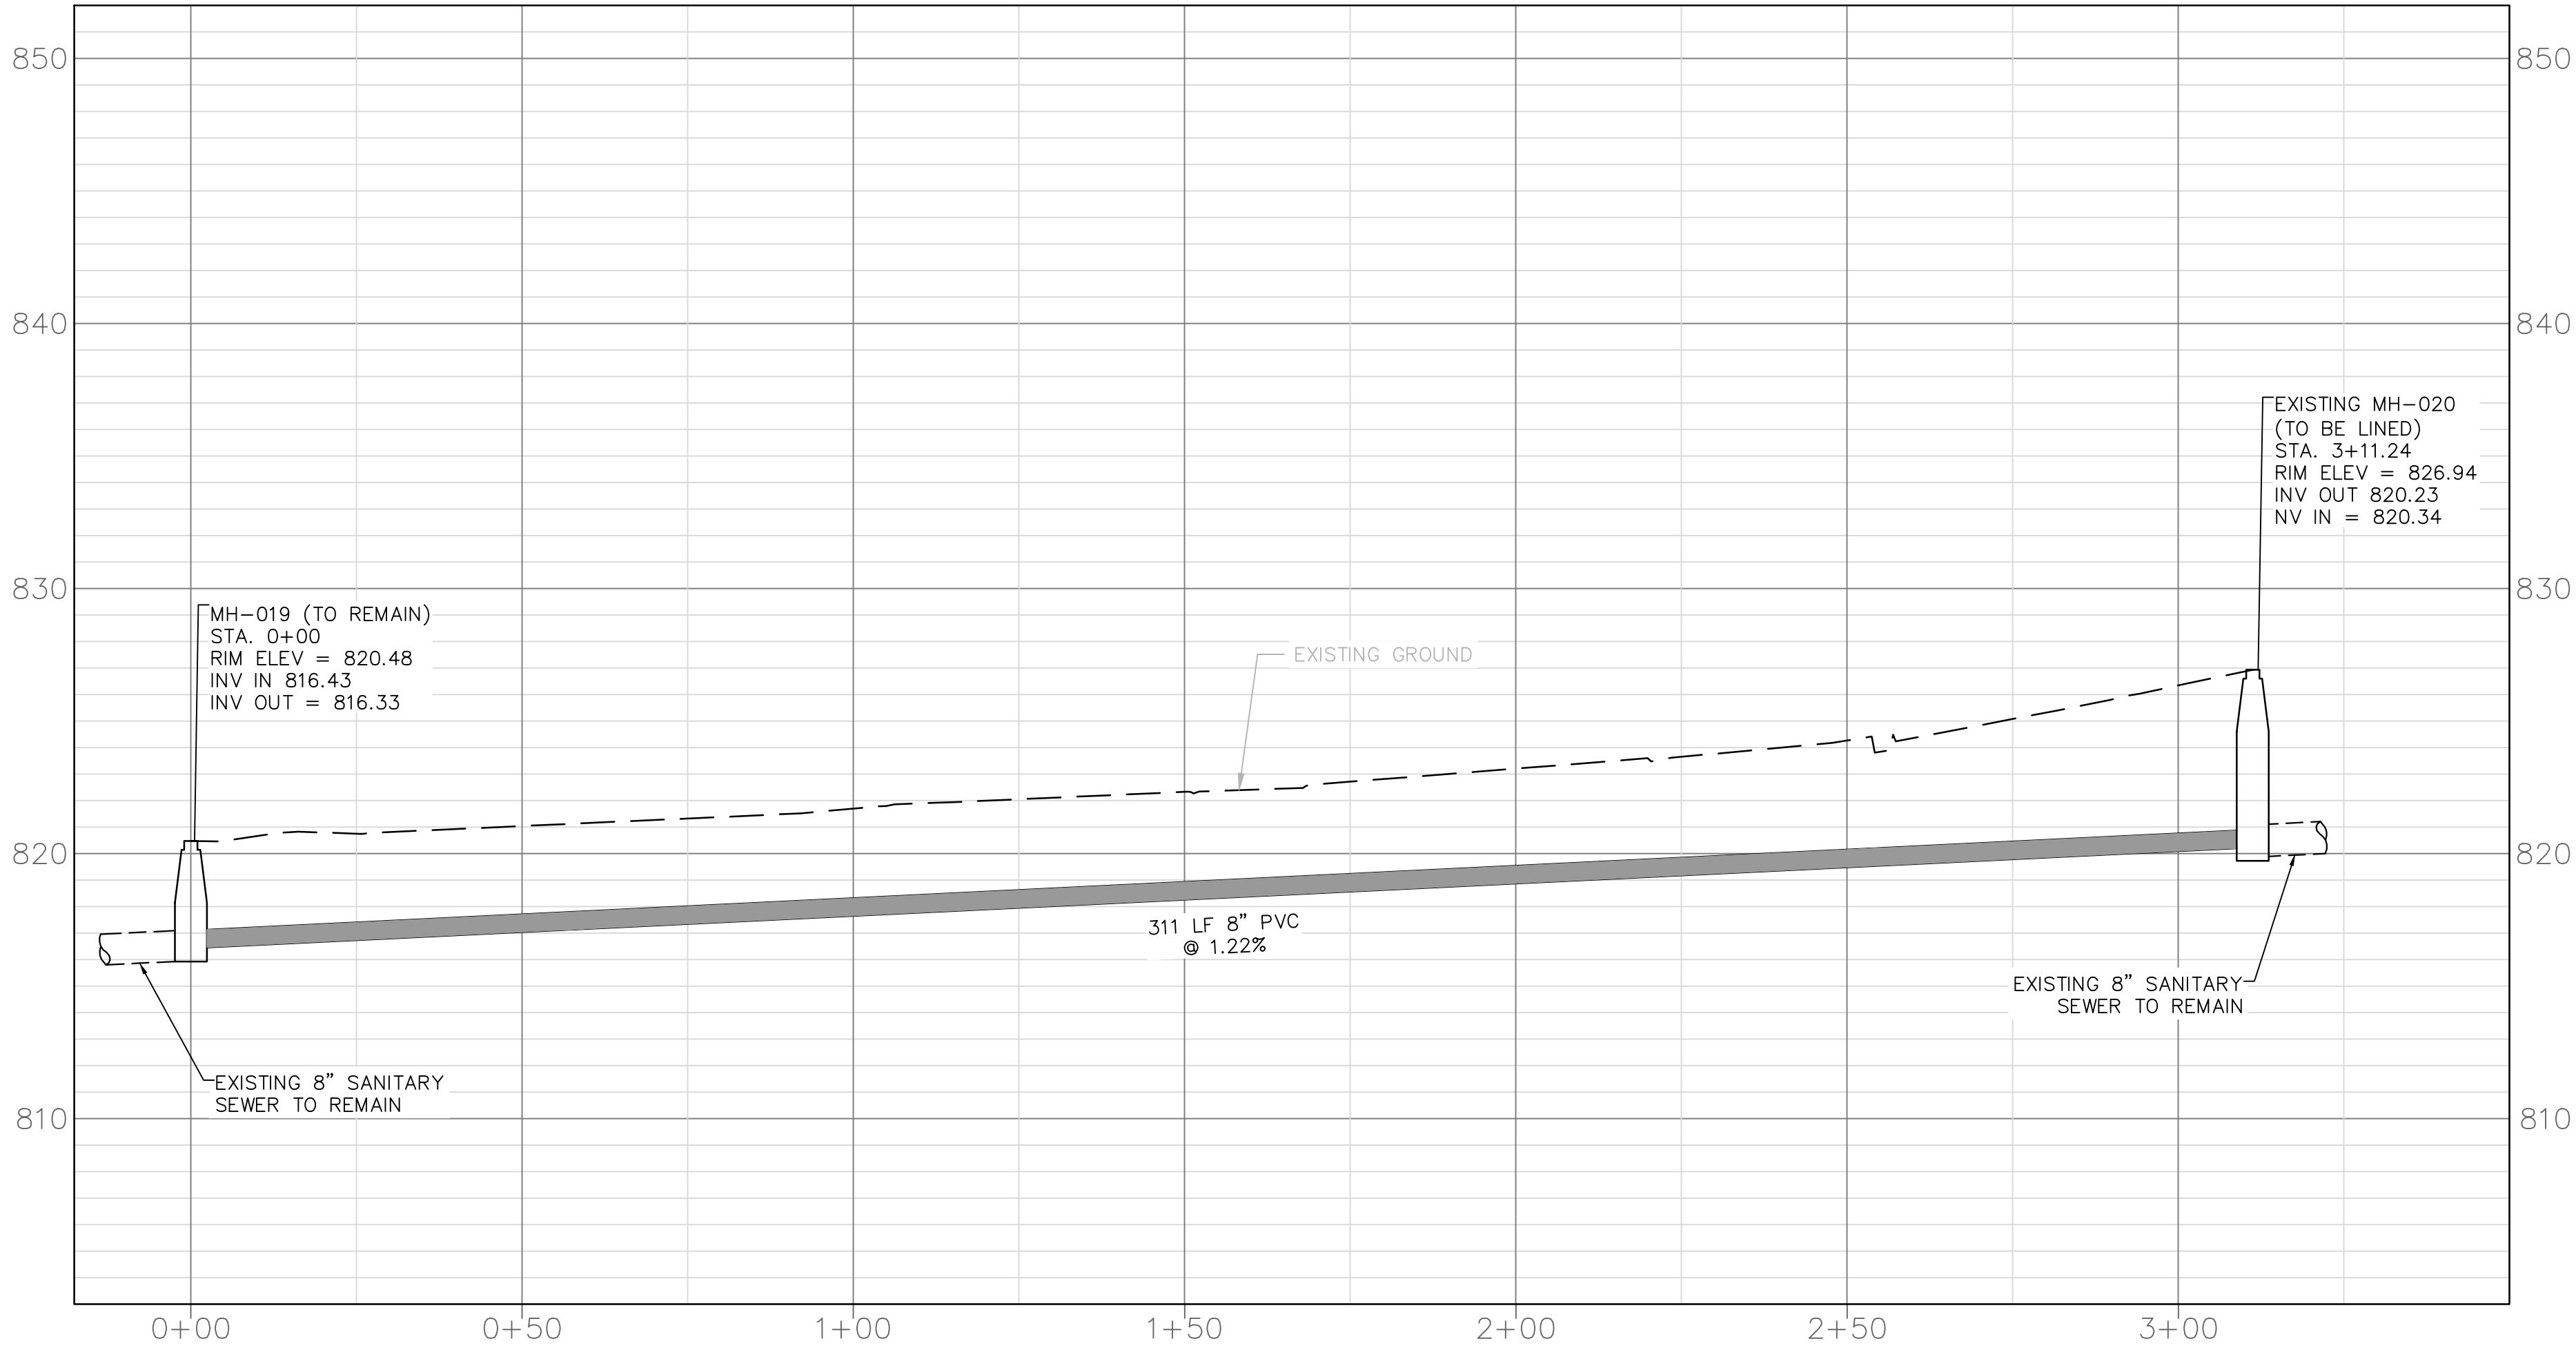

MUNICIPAL ENGINEERING, INC.
68 SHIPWASH DRIVE, GARNER, NC 27529 • PHONE: 919-772-5393
P.O. BOX 349, BOONE, NC 28607 • PHONE: 828-262-1767
LICENSE NUMBERS: F-0812 & C-586





**TOWN OF LANDIS
SANITARY SEWER SYSTEM REHAB
ROWAN COUNTY, NORTH CAROLINA**

DATE	BY	REV.	DESCRIPTION
9-22-2022	R. MOSS		PLAN AND PROFILE
SCALE: AS SHOWN			
DATE: 9-22-2022			
DRWN. BY: R. MOSS			
CHKD. BY: G. FLOWERS			
PROJECT NUMBER			
G20053.0			
DRAWING NO.		SHEET NO.	
S-4		8	

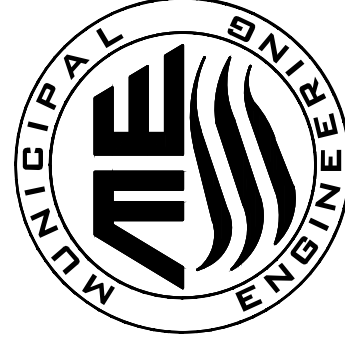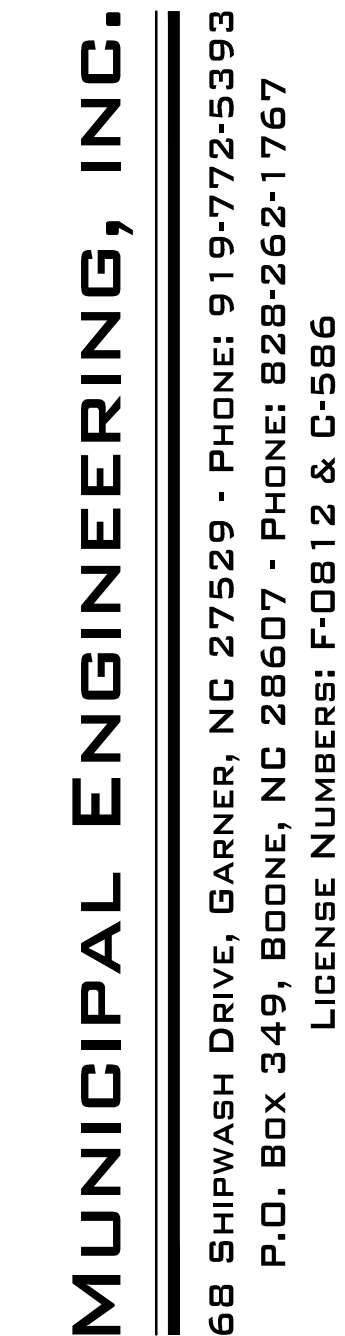
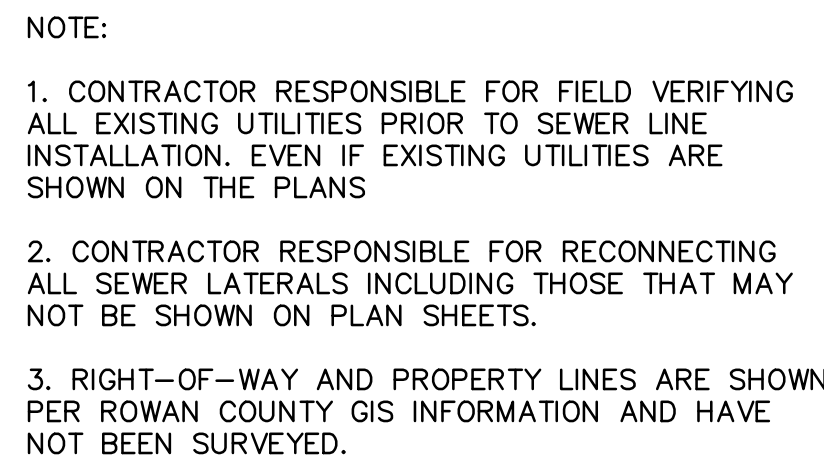


**TOWN OF LANDIS
SANITARY SEWER SYSTEM REHAB
ROWAN COUNTY, NORTH CAROLINA**

[illegible]

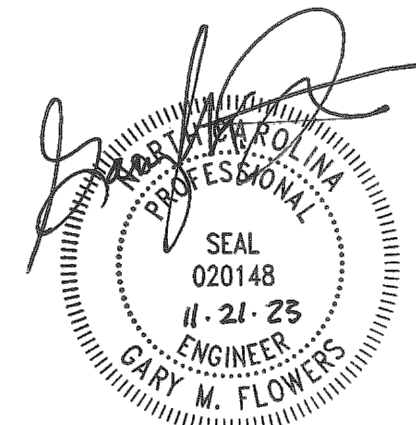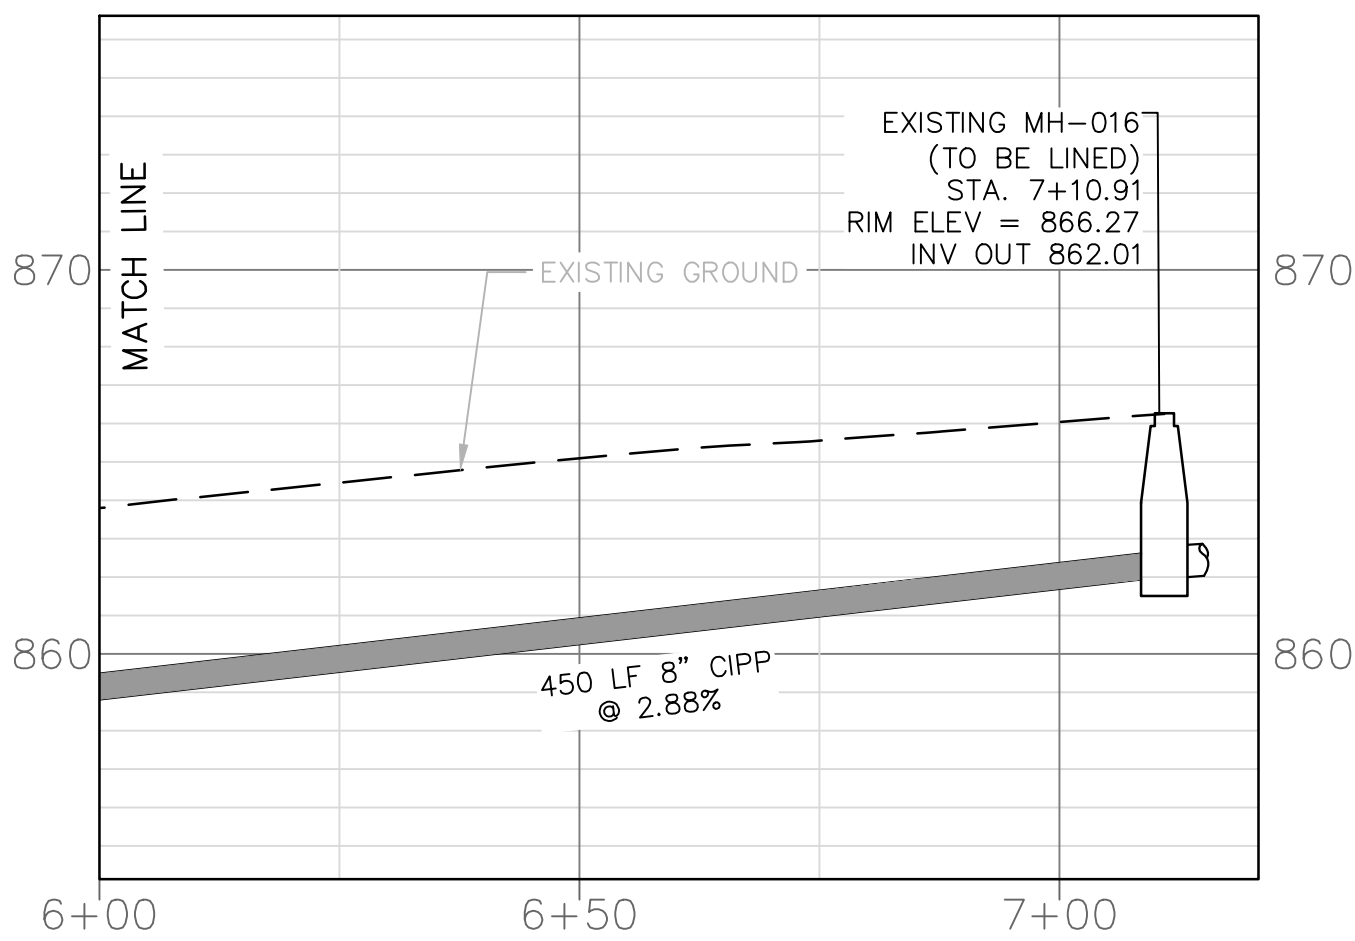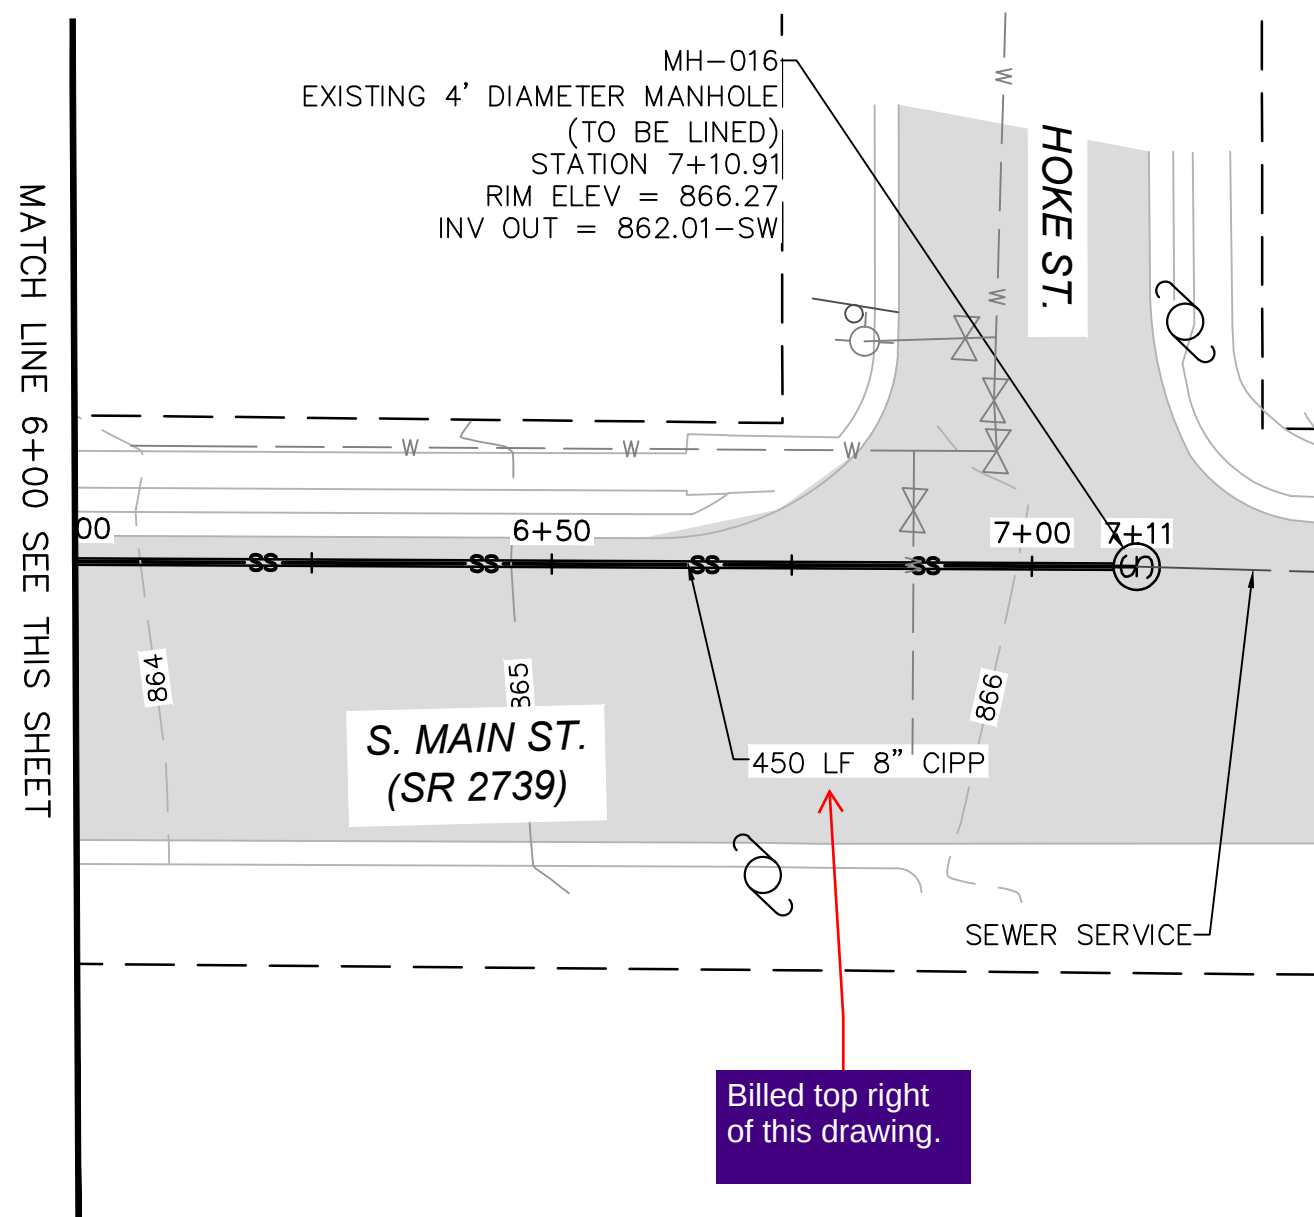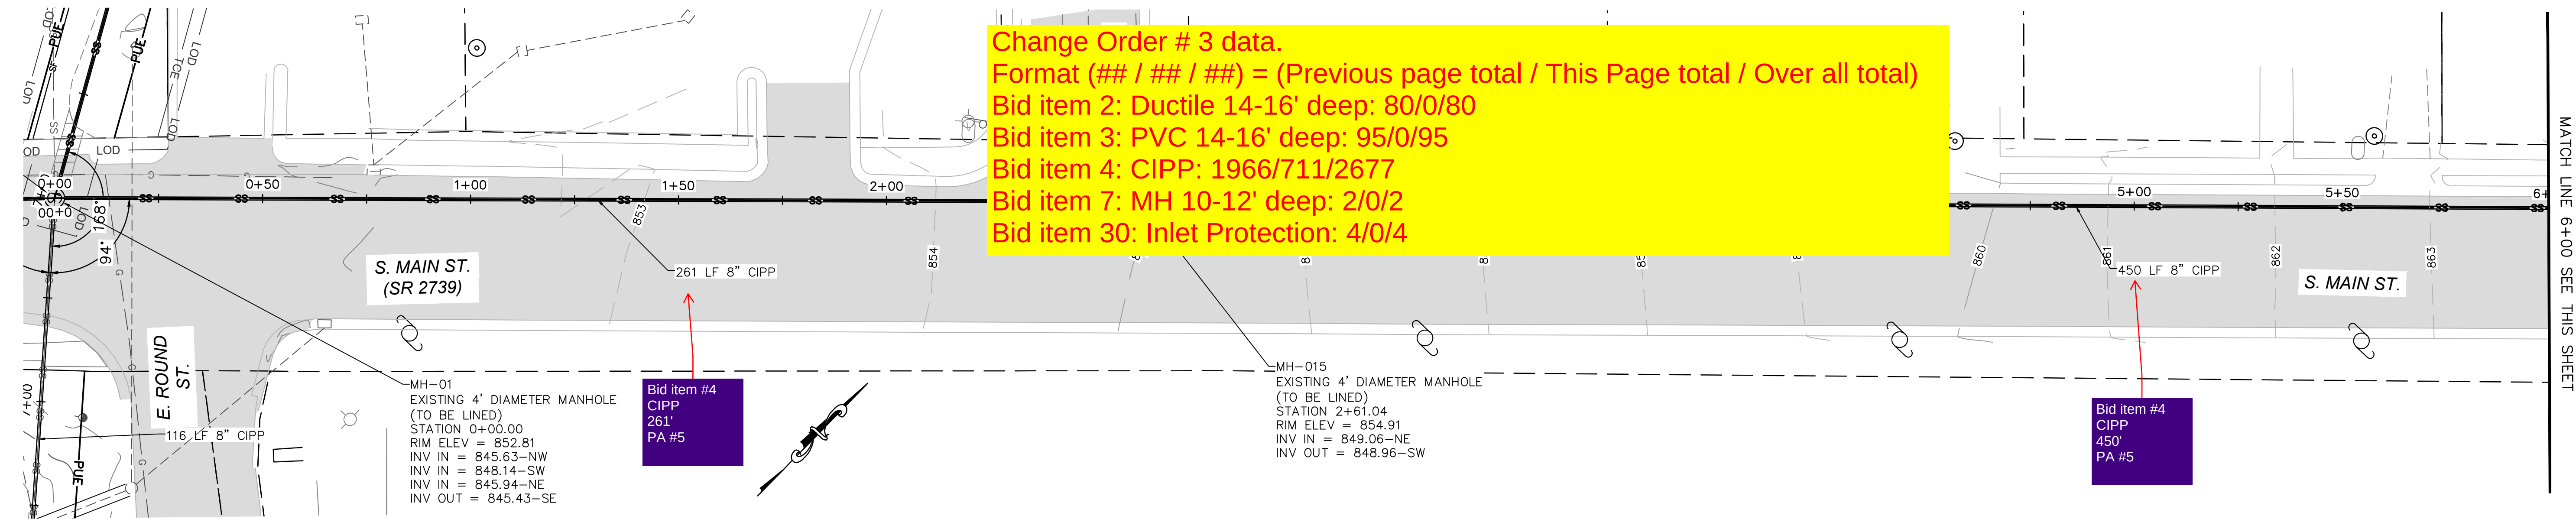


- NOTE:
1. CONTRACTOR RESPONSIBLE FOR FIELD VERIFYING ALL EXISTING UTILITIES PRIOR TO SEWER LINE INSTALLATION. EVEN IF EXISTING UTILITIES ARE SHOWN ON THE PLANS
 2. CONTRACTOR RESPONSIBLE FOR RECONNECTING ALL SEWER LATERALS INCLUDING THOSE THAT MAY NOT BE SHOWN ON PLAN SHEETS.
 3. RIGHT-OF-WAY AND PROPERTY LINES ARE SHOWN PER ROWAN COUNTY GIS INFORMATION AND HAVE NOT BEEN SURVEYED.

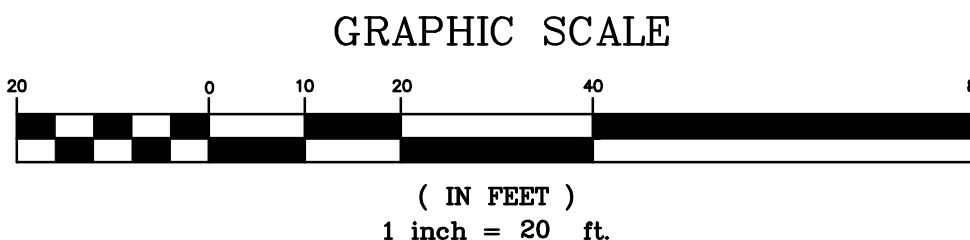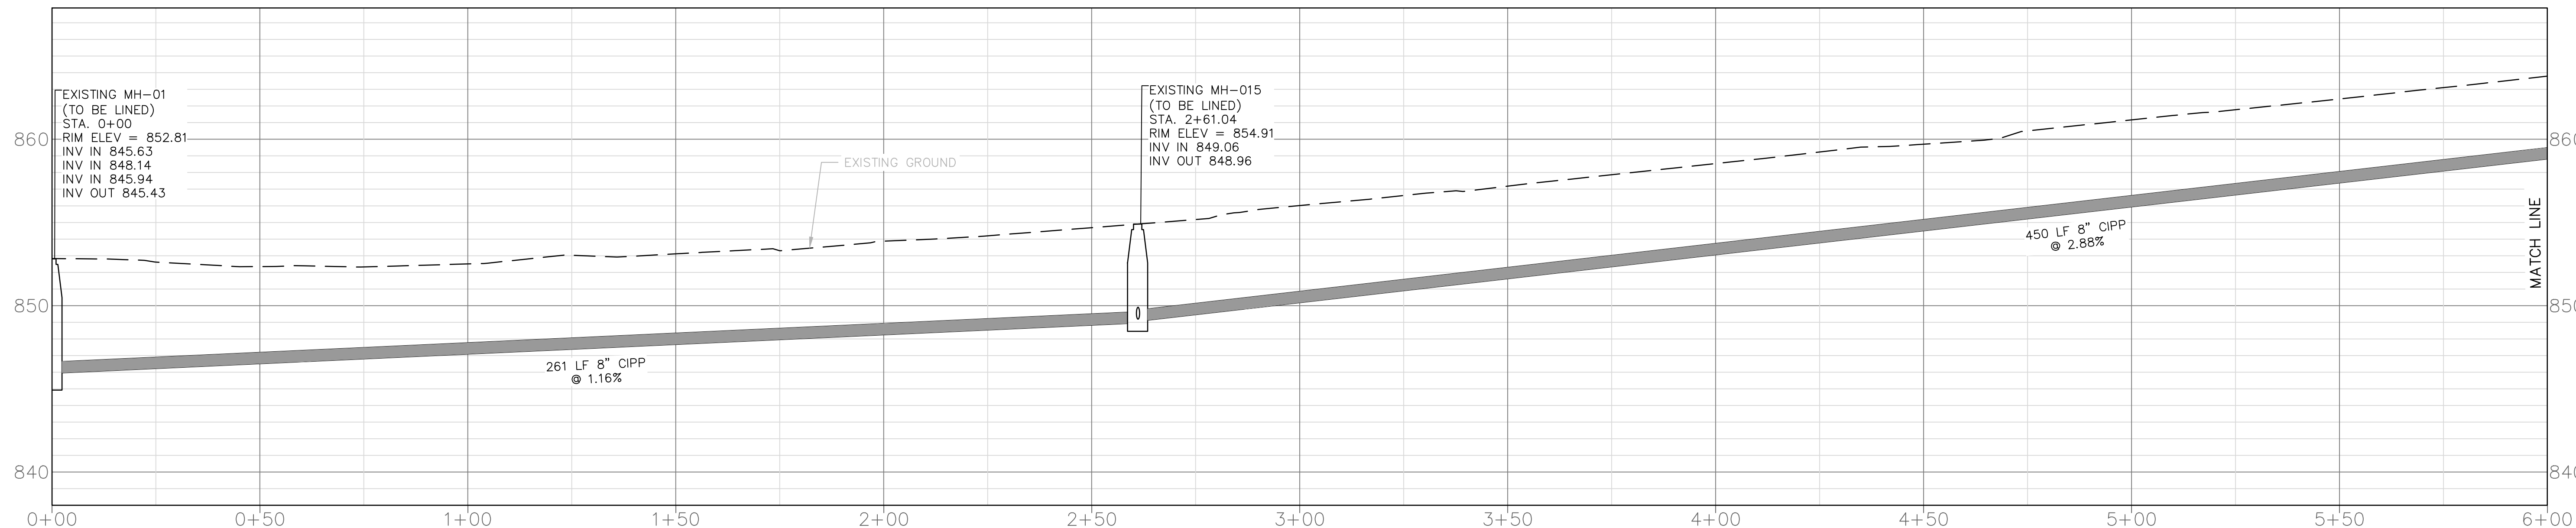



MUNICIPAL ENGINEERING, INC.
68 SHIPWASH DRIVE, GARNER, NC 27529 · PHONE: 919-772-5393
P.O. BOX 349, BOONE, NC 28607 · PHONE: 828-262-1767
LICENSE NUMBERS: F-0812 & C-586

**TOWN OF LANDIS
SANITARY SEWER SYSTEM REHAB
ROWAN COUNTY, NORTH CAROLINA**

DATE		BY	REV.	DESCRIPTION
9-22-2022		R. MOSS		PLAN AND PROFILE
G. FLOWERS				
PROJECT NUMBER		G20053.0		
DRAWING NO.		S-9		
SHEET NO.		13		

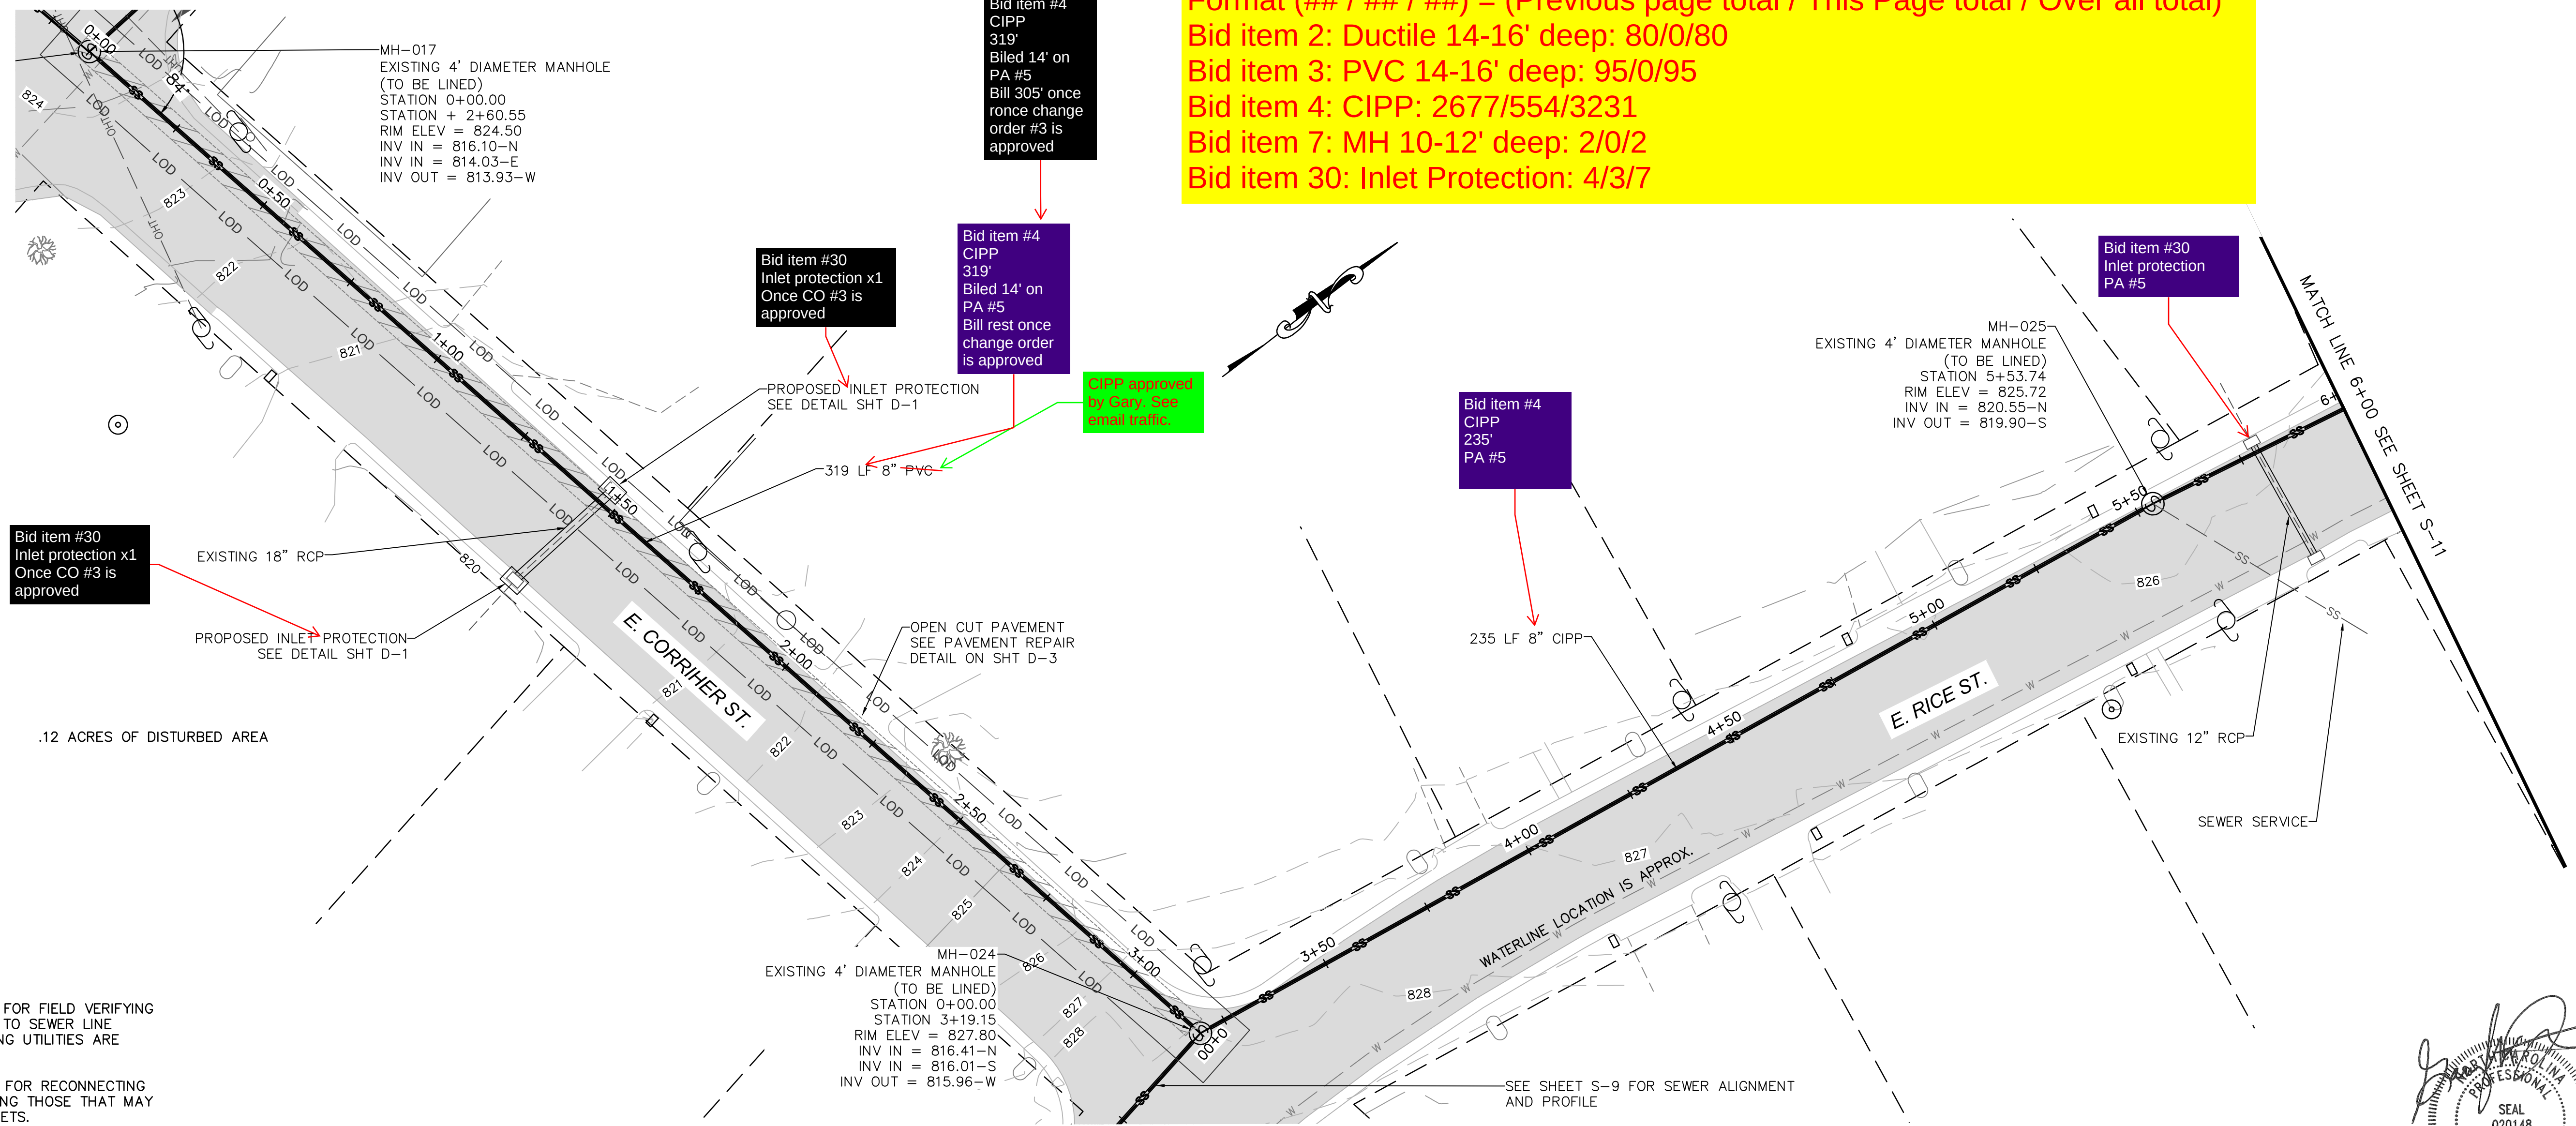

- NOTE:
1. CONTRACTOR RESPONSIBLE FOR FIELD VERIFYING ALL EXISTING UTILITIES PRIOR TO SEWER LINE INSTALLATION, EVEN IF EXISTING UTILITIES ARE SHOWN ON THE PLANS
 2. CONTRACTOR RESPONSIBLE FOR RECONNECTING ALL SEWER LATERALS INCLUDING THOSE THAT MAY NOT BE SHOWN ON PLAN SHEETS.
 3. RIGHT-OF-WAY AND PROPERTY LINES ARE SHOWN PER ROWAN COUNTY GIS INFORMATION AND HAVE NOT BEEN SURVEYED.

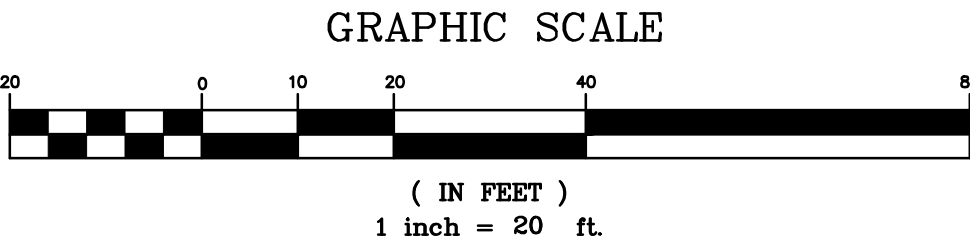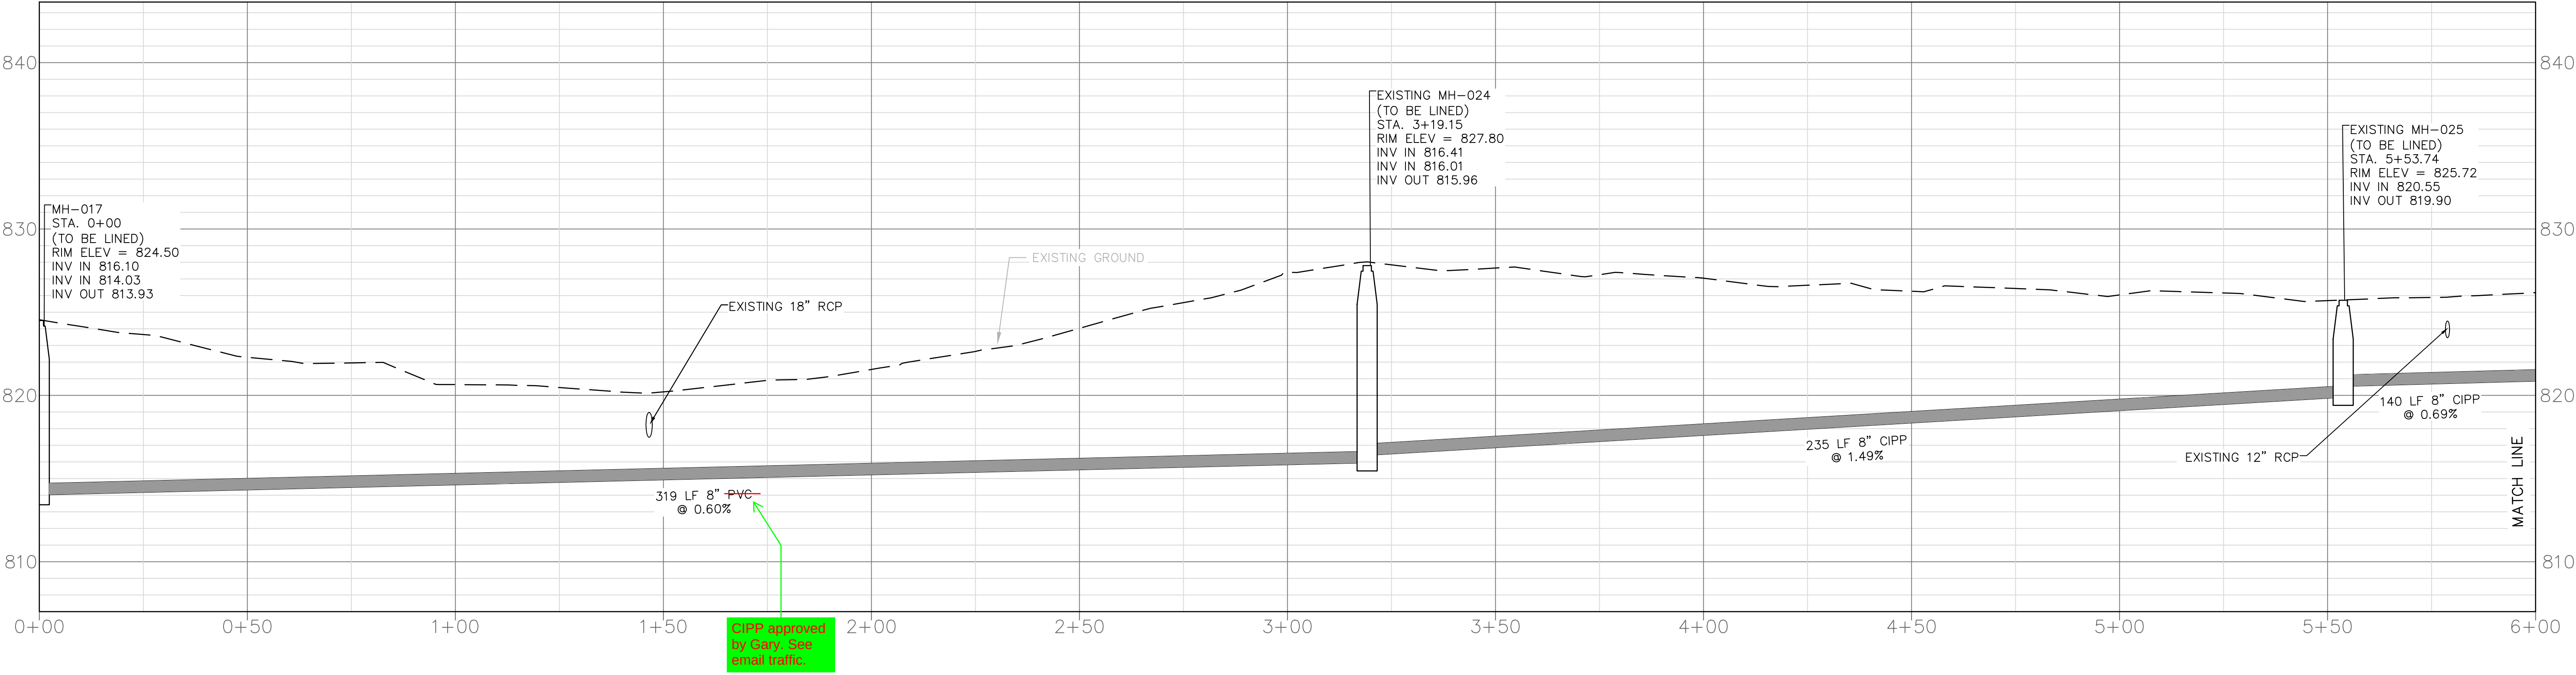

Change Order # 3 data.
Format (## / ## / ##) = (Previous page total / This Page total / Over all total)
Bid item 2: Ductile 14-16' deep: 80/0/80
Bid item 3: PVC 14-16' deep: 95/0/95
Bid item 4: CIPP: 2677/554/3231
Bid item 7: MH 10-12' deep: 2/0/2
Bid item 30: Inlet Protection: 4/3/7

MUNICIPAL ENGINEERING, INC.

68 SHIPWASH DRIVE, GARNER, NC 27529 • PHONE: 919-772-5393
P.O. BOX 349, BOONE, NC 28607 • PHONE: 828-262-1767
LICENSE NUMBERS: F-0812 & C-586

TOWN OF LANDIS
SANITARY SEWER SYSTEM REHAB
ROWAN COUNTY, NORTH CAROLINA





DATE	BY	REV.	DESCRIPTION

PLAN AND PROFILE



SCALE: AS SHOWN
DATE: 9-22-2022
DRWN. BY: R. MOSS
CHKD. BY: G. FLOWERS
PROJECT NUMBER
G20053.0
DRAWING NO. S-10
SHEET NO. 14

Change Order # 3 data.
Format (## / ## / ##) = (Previous page total / This Page total / Over all total)
Bid item 2: Ductile 14-16' deep: 80/0/80
Bid item 3: PVC 14-16' deep: 95/0/95
Bid item 4: CIPP: 3231/431/3662
Bid item 7: MH 10-12' deep: 2/0/2
Bid item 30: Inlet Protection: 7/0/7

Original Bid QTY:14. Requesting 66 additional feet via CO #3. New total QTY: 80
Original Bid QTY:12. Requesting 83 additional feet via CO #3. New total QTY: 95
Original Bid QTY:3357. Requesting 305 additional feet via CO #3. New total QTY: 3662
Original Bid QTY:1. Requesting 1 additional via CO #3. New total QTY: 2
Original Bid QTY:4. Requesting 5 additional via CO #3. New total QTY: 9
(I expect to have at least 2 more locations during continued construction)

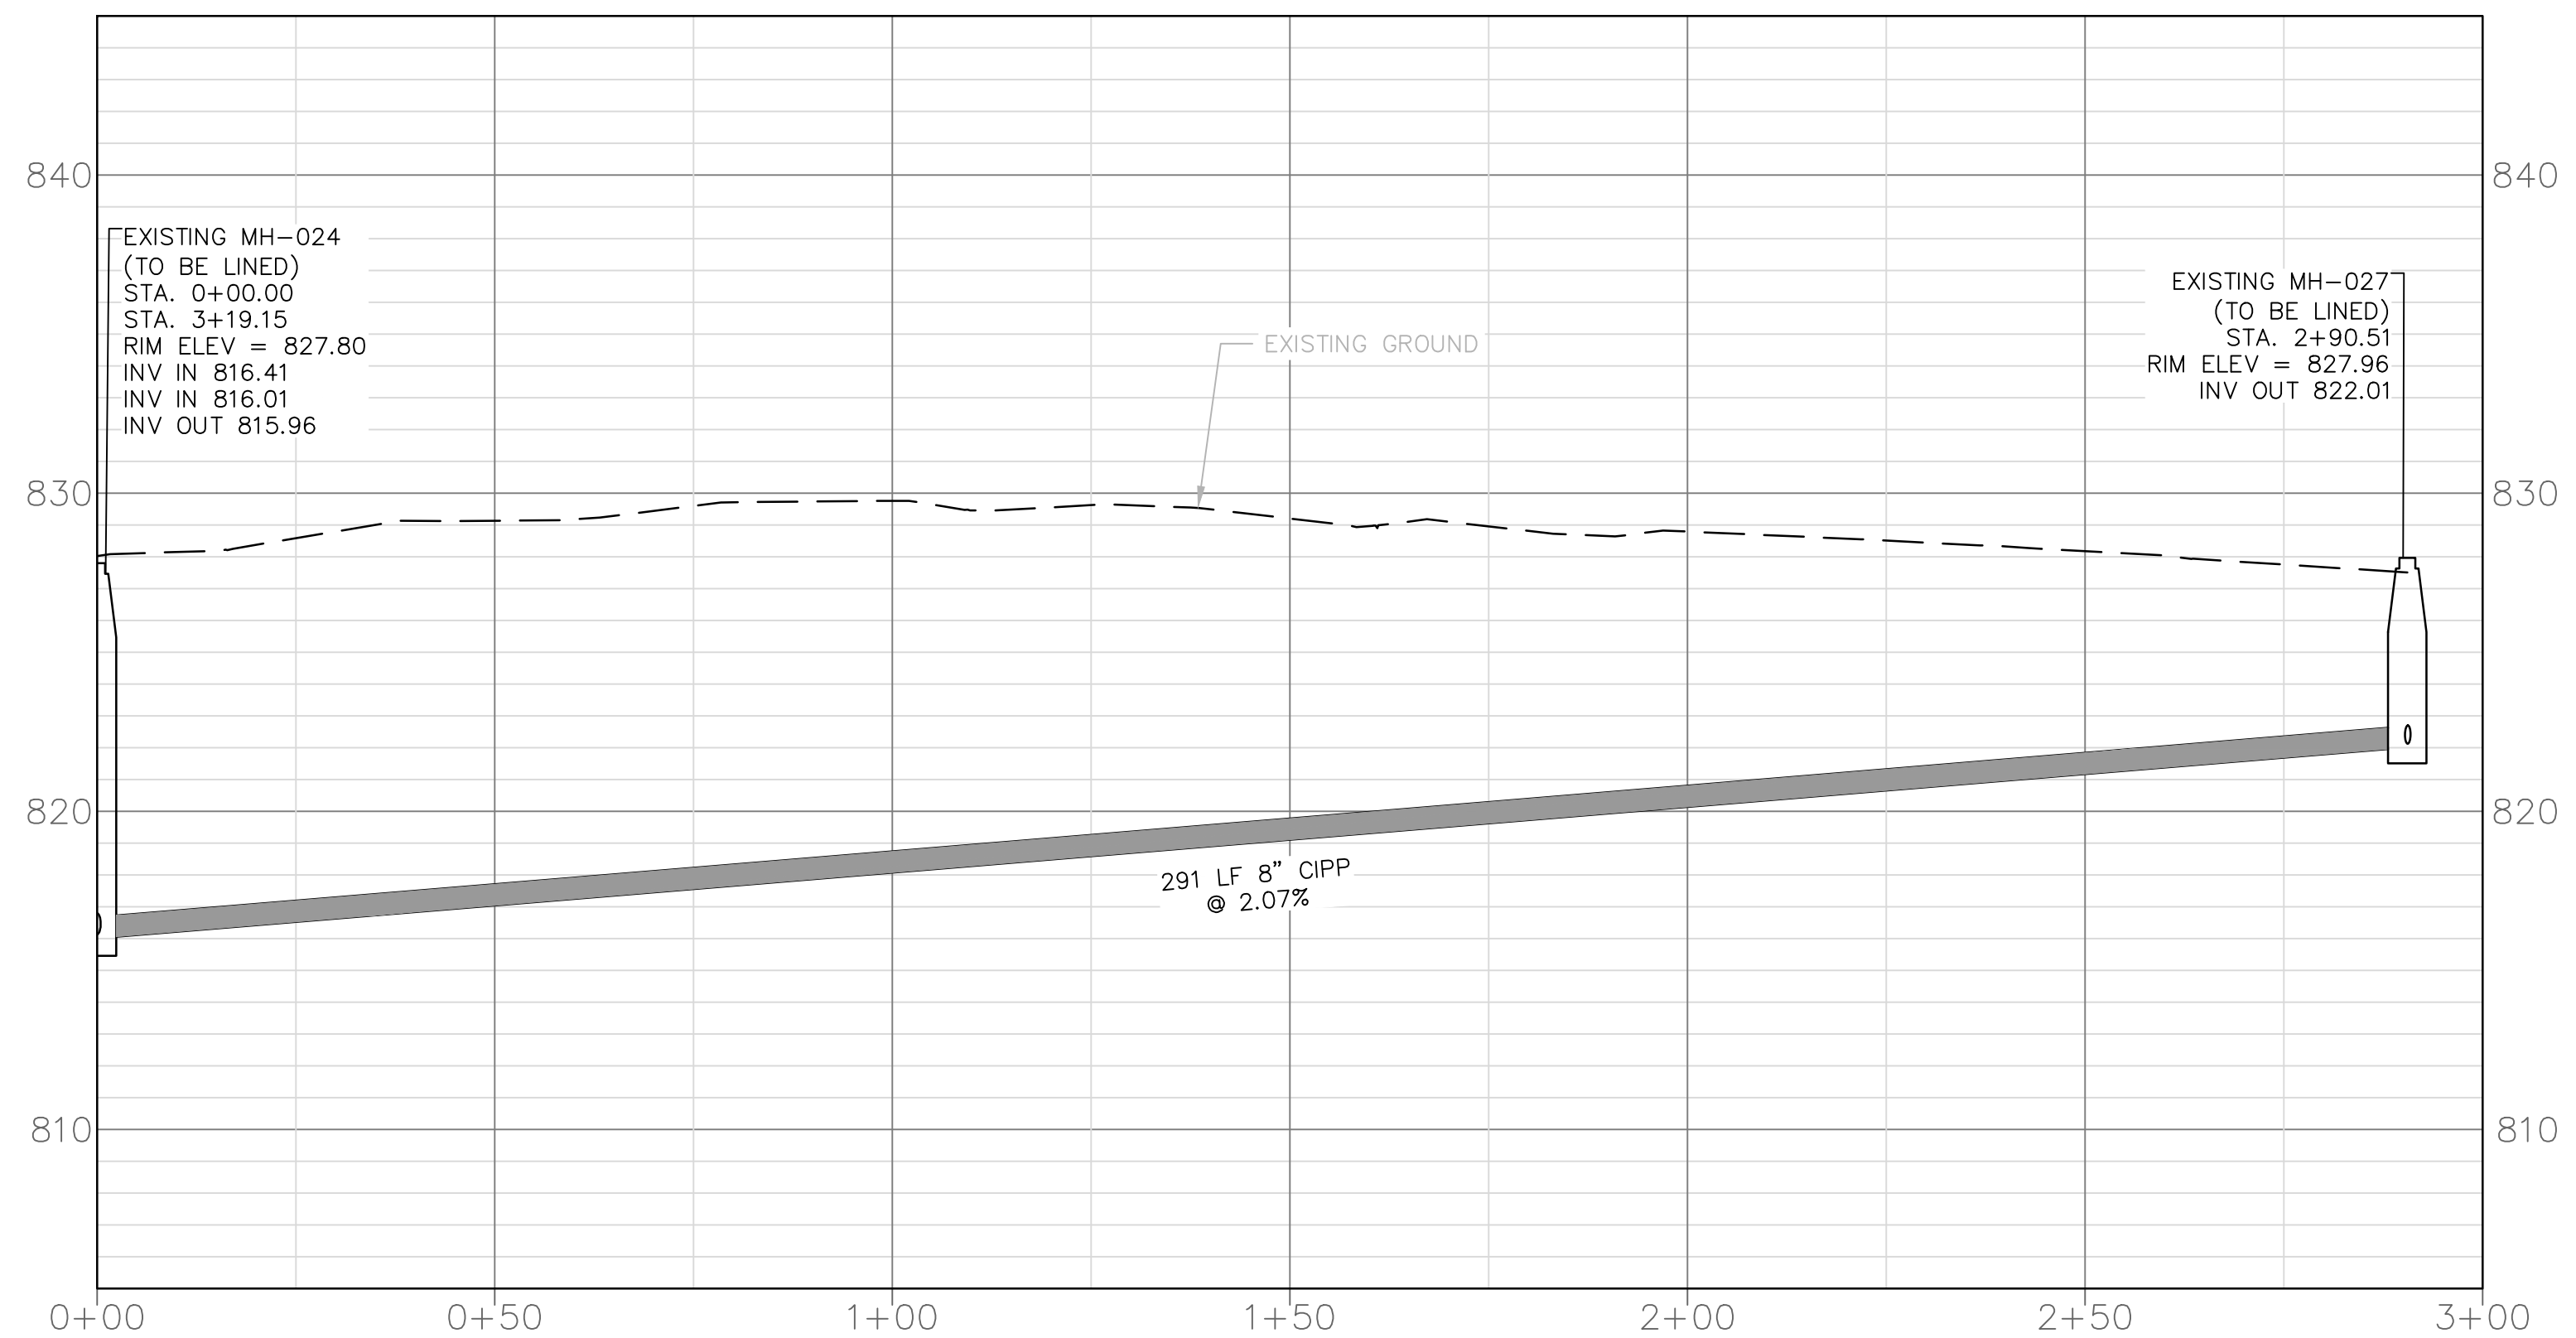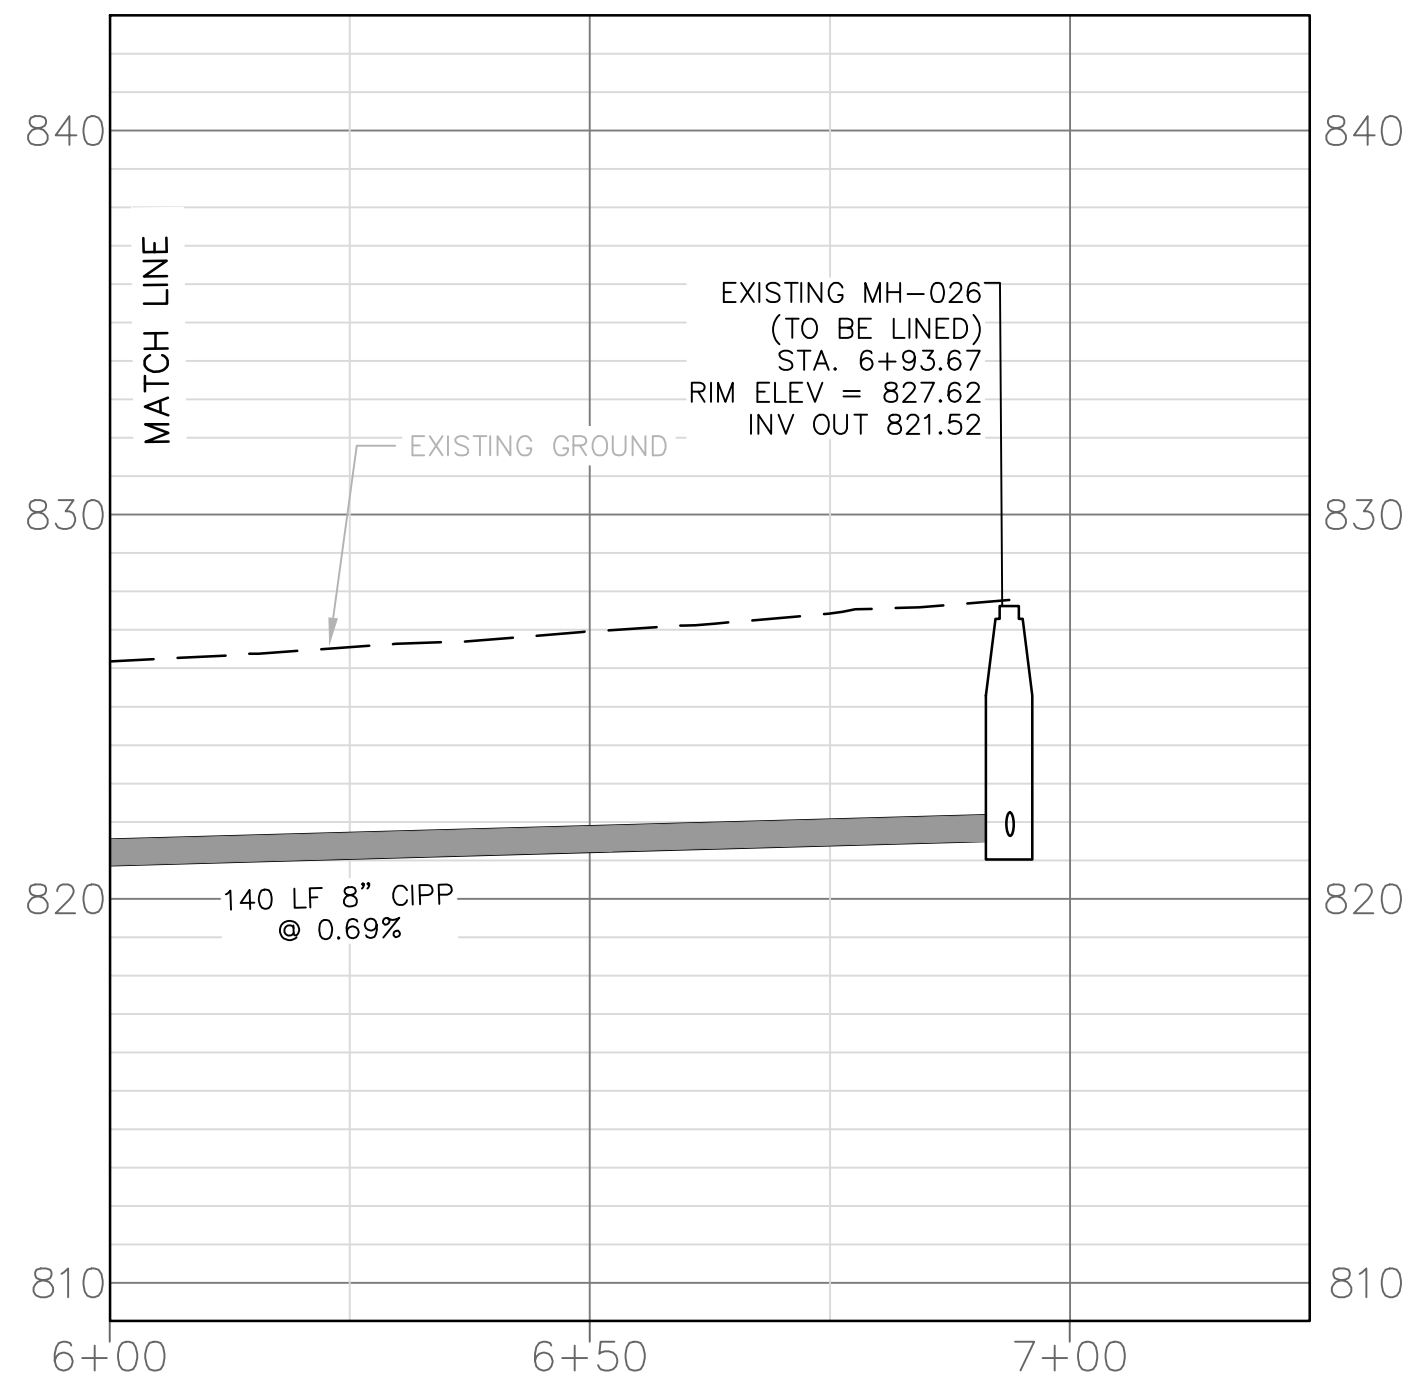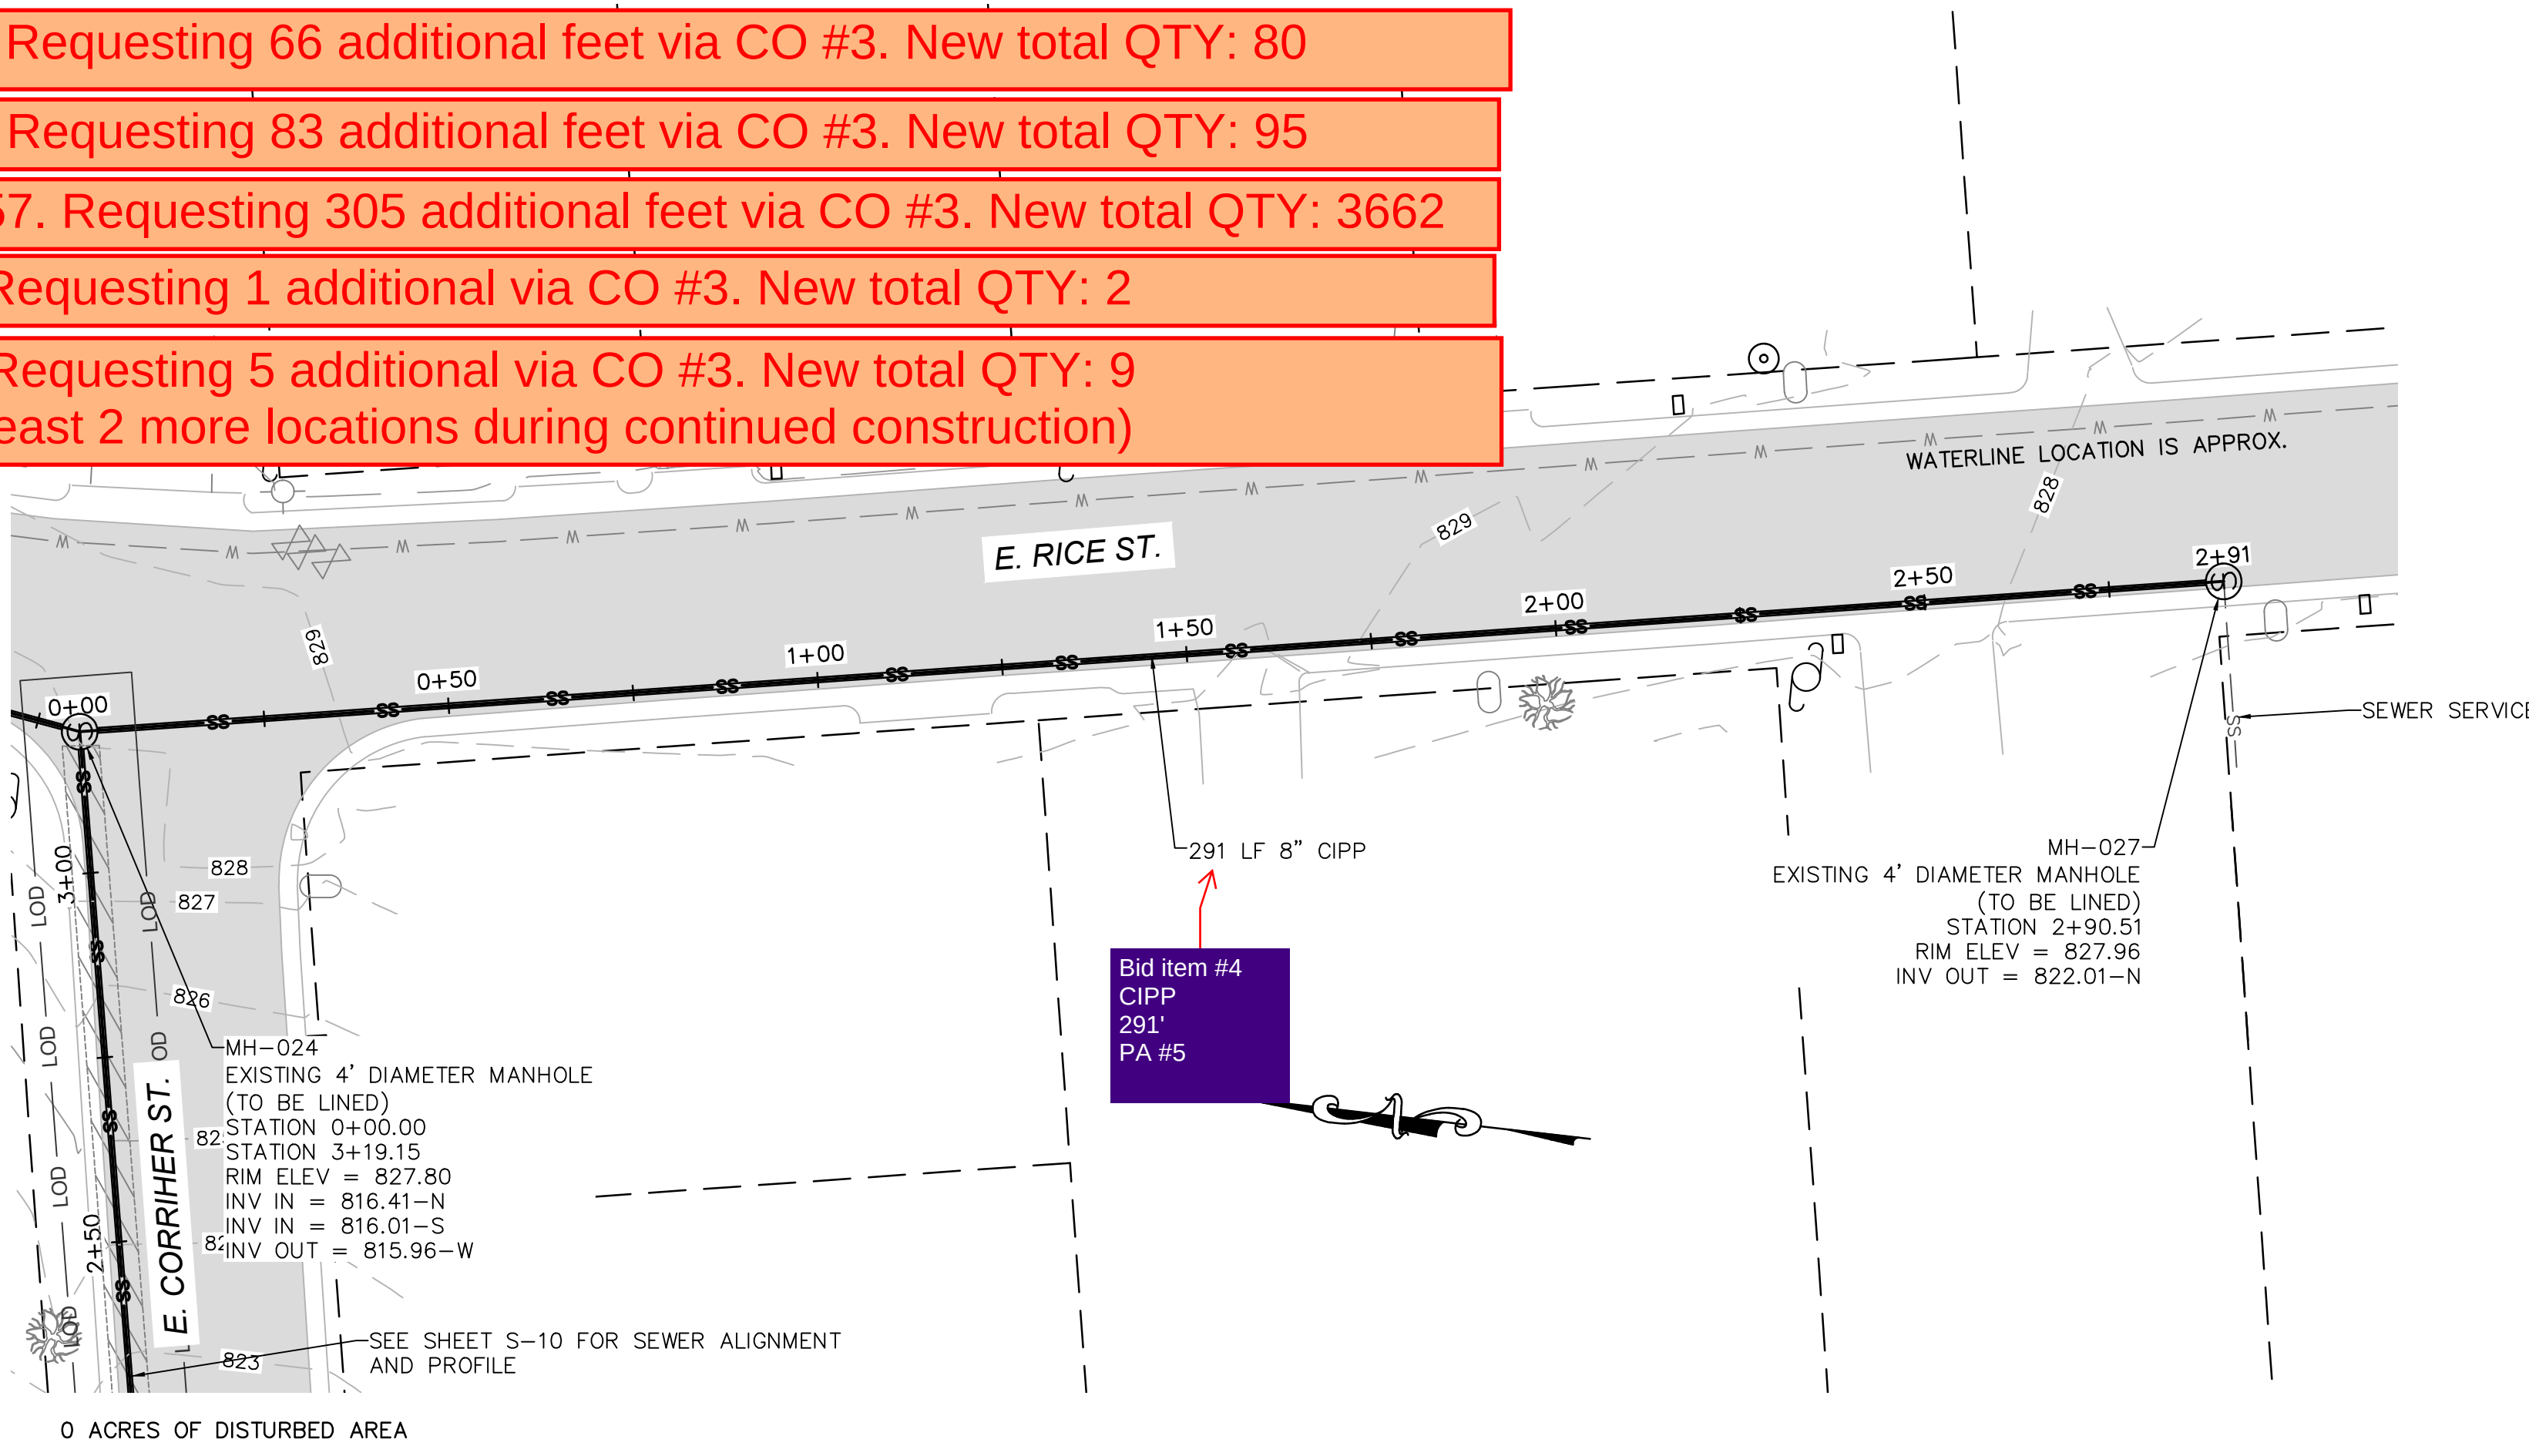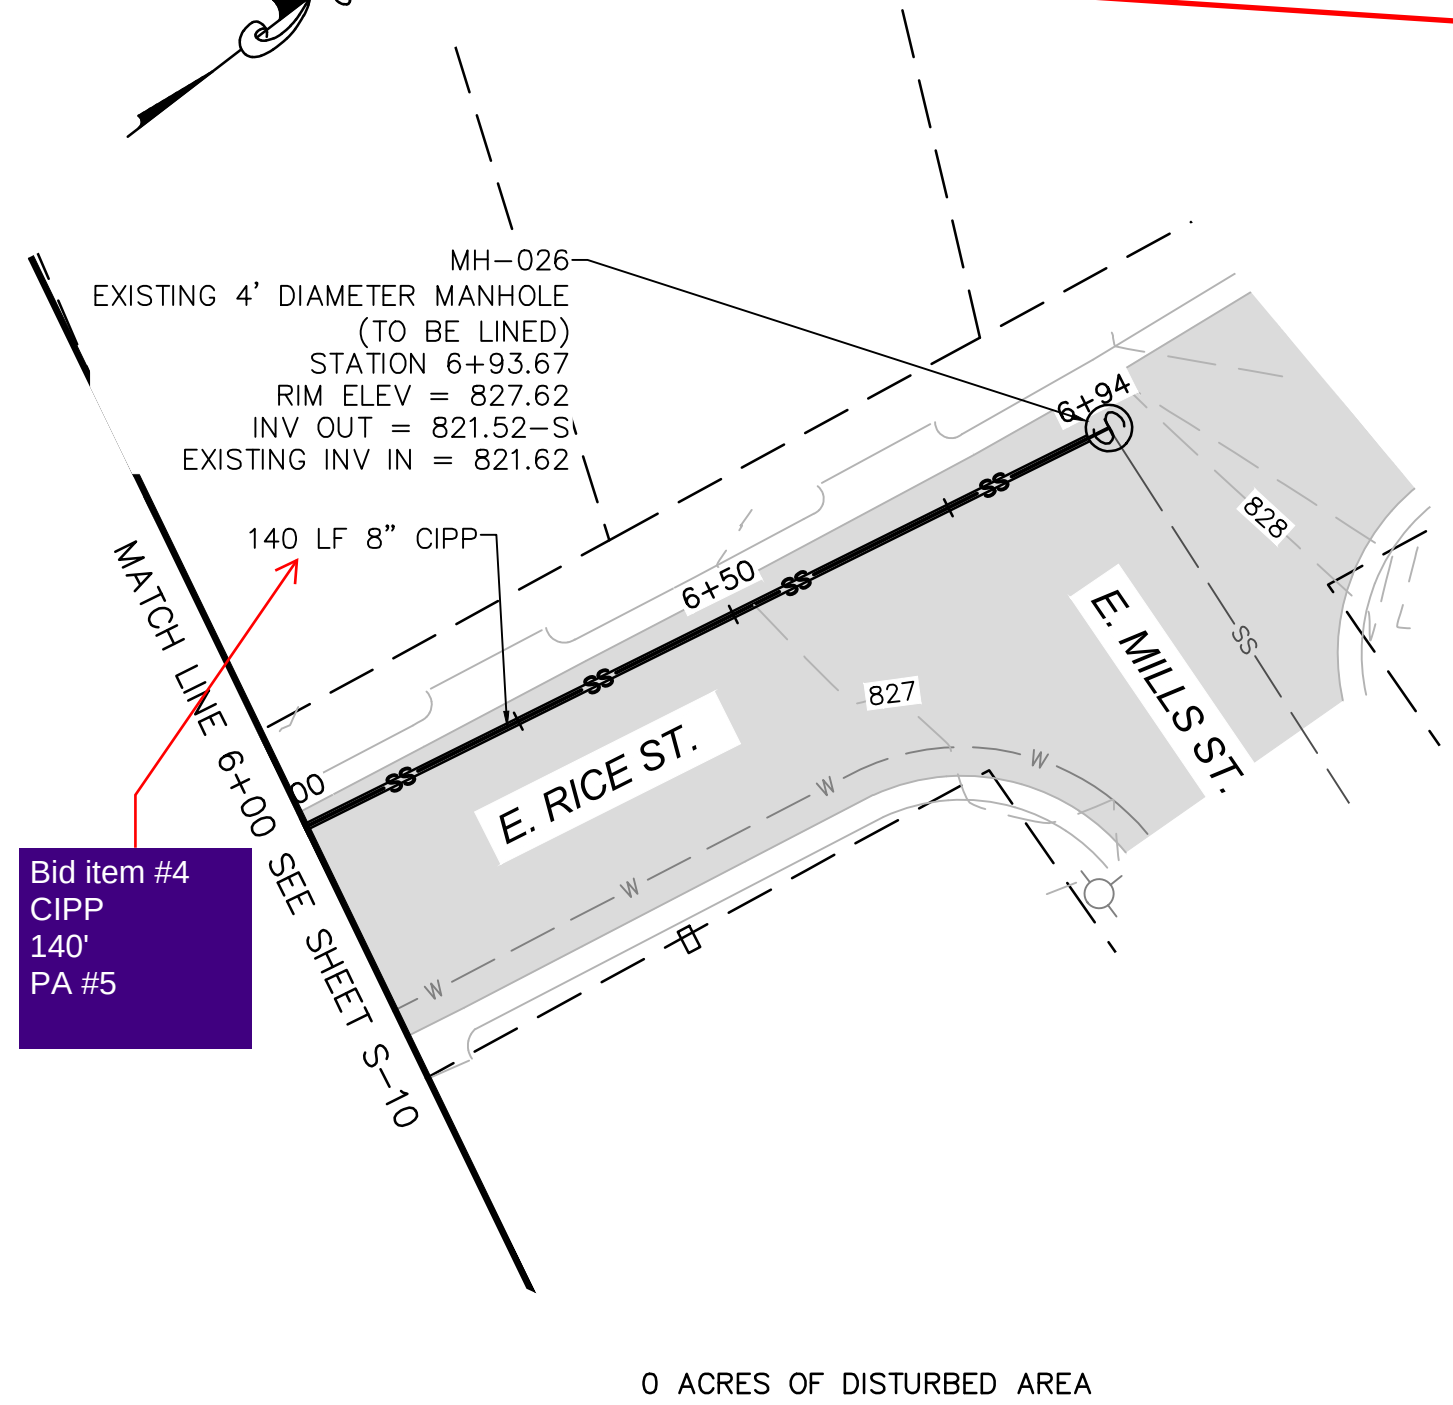

NOTE:
1. CONTRACTOR RESPONSIBLE FOR FIELD VERIFYING ALL EXISTING UTILITIES PRIOR TO SEWER LINE INSTALLATION. EVEN IF EXISTING UTILITIES ARE SHOWN ON THE PLANS
2. CONTRACTOR RESPONSIBLE FOR RECONNECTING ALL SEWER LATERALS INCLUDING THOSE THAT MAY NOT BE SHOWN ON PLAN SHEETS.
3. RIGHT-OF-WAY AND PROPERTY LINES ARE SHOWN PER ROWAN COUNTY GIS INFORMATION AND HAVE NOT BEEN SURVEYED.

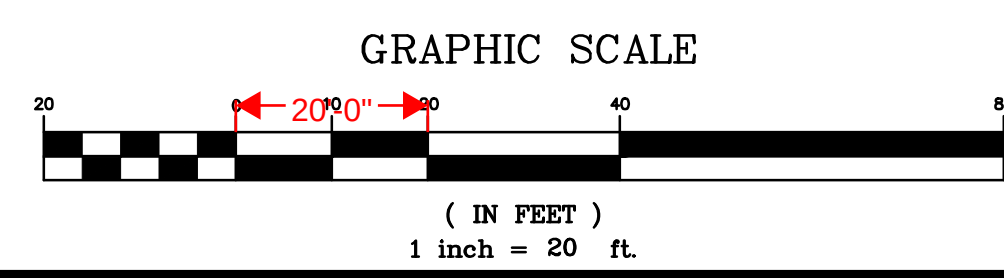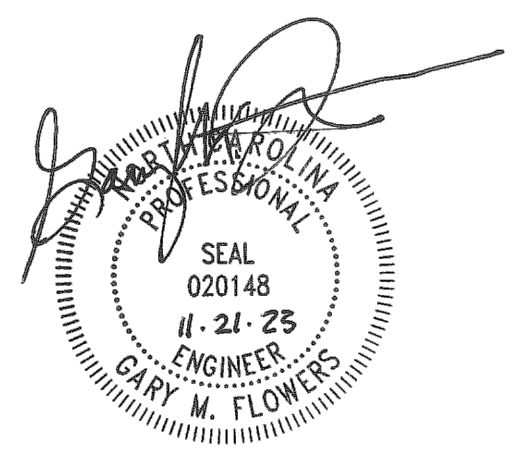

MUNICIPAL ENGINEERING, INC.

68 SHIPWASH DRIVE, GARNER, NC 27529 • PHONE: 919-772-5393
P.O. BOX 349, BOONE, NC 28607 • PHONE: 828-262-1767
LICENSE NUMBERS: F-0812 & C-586

TOWN OF LANDIS
SANTARY SEWER SYSTEM REHAB
ROWAN COUNTY, NORTH CAROLINA

DATE	BY	REV.	DESCRIPTION

SCALE: AS SHOWN
DATE: 9-22-2022
DRWN. BY: R. MOSS
CHKD. BY: G. FLOWERS

PROJECT NUMBER
G20053.0

DRAWING NO. S-11
SHEET NO. 15