


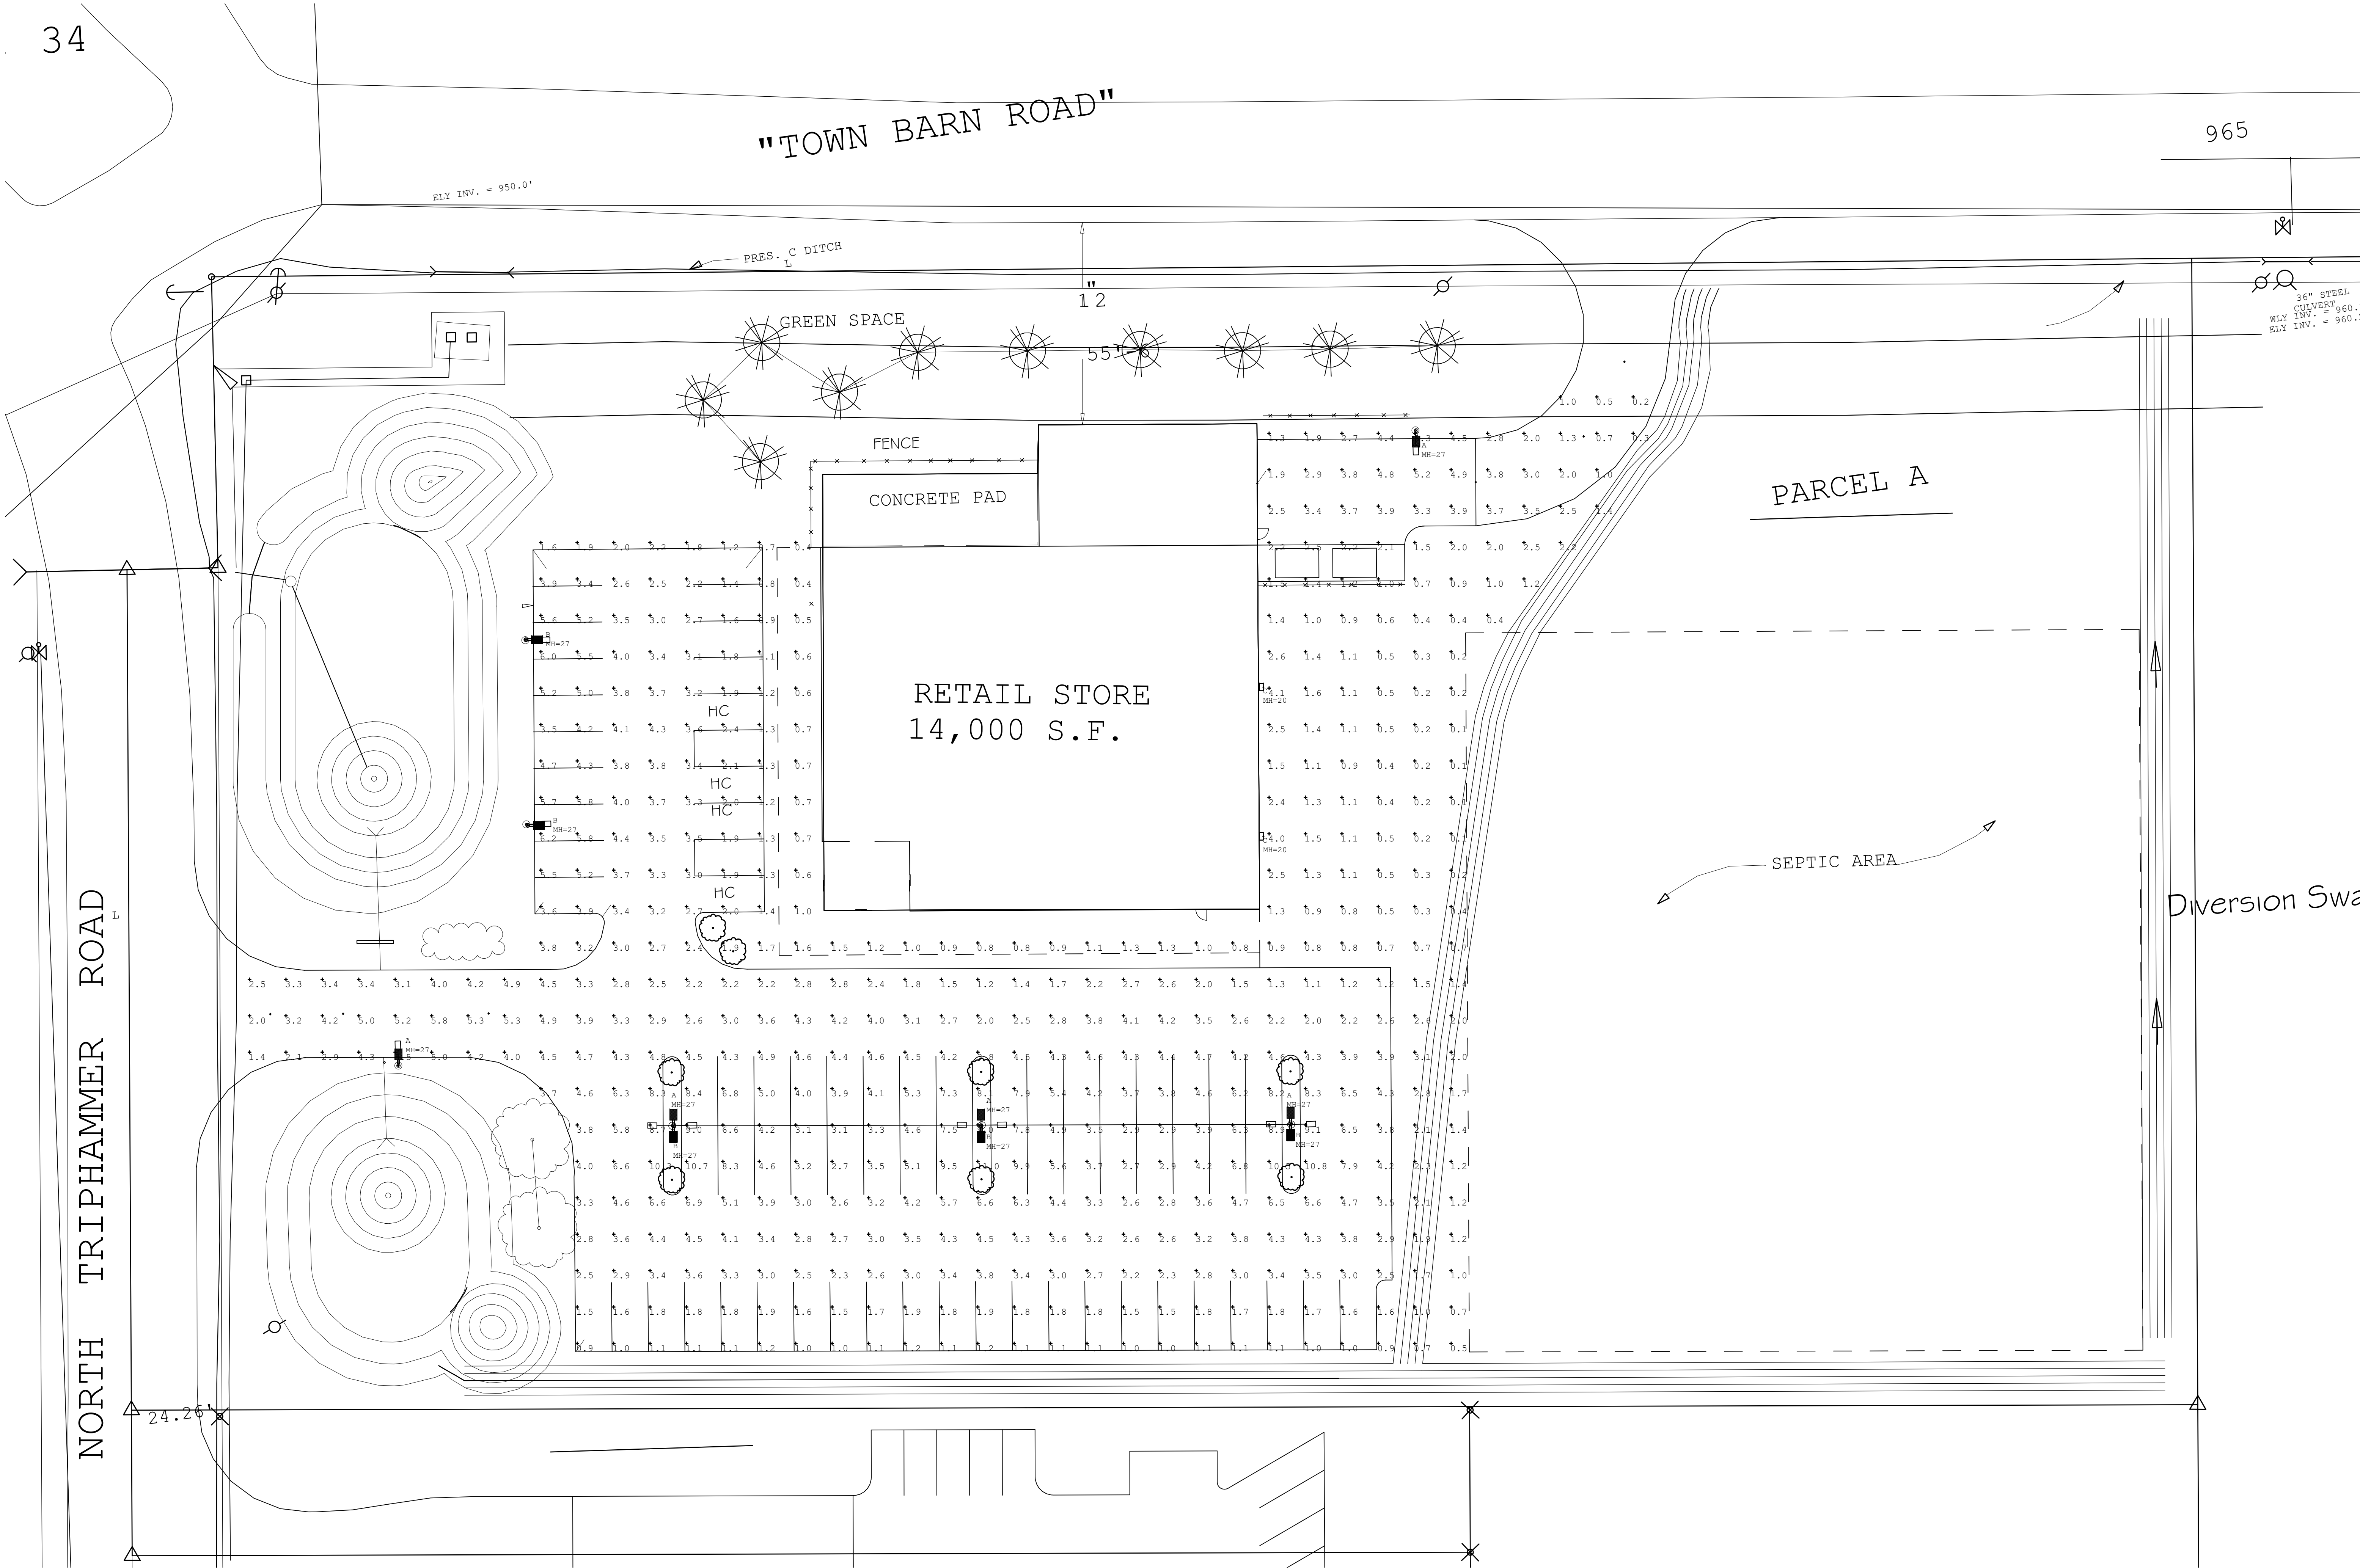

LIGHTING PLAN
1"=20'-0"

PROPOSED ABC SUPPLY STORE (formerly LANSING MARKET)

NORTH TRIPHAMMER ROAD, LANSING, NY 14882

GEORGE W. BREUHAUS, ARCHITECT

950 DANBY ROAD, SUITE 220

ITHACA, NEW YORK 14850

TEL: 807-257-8348

PROJ. NO: 25 - 13

SCALE: AS NOTED

DRAWN: BREUHAUS

DATE: 27 MAY 25

LIGHTING PLAN

SITE-3