




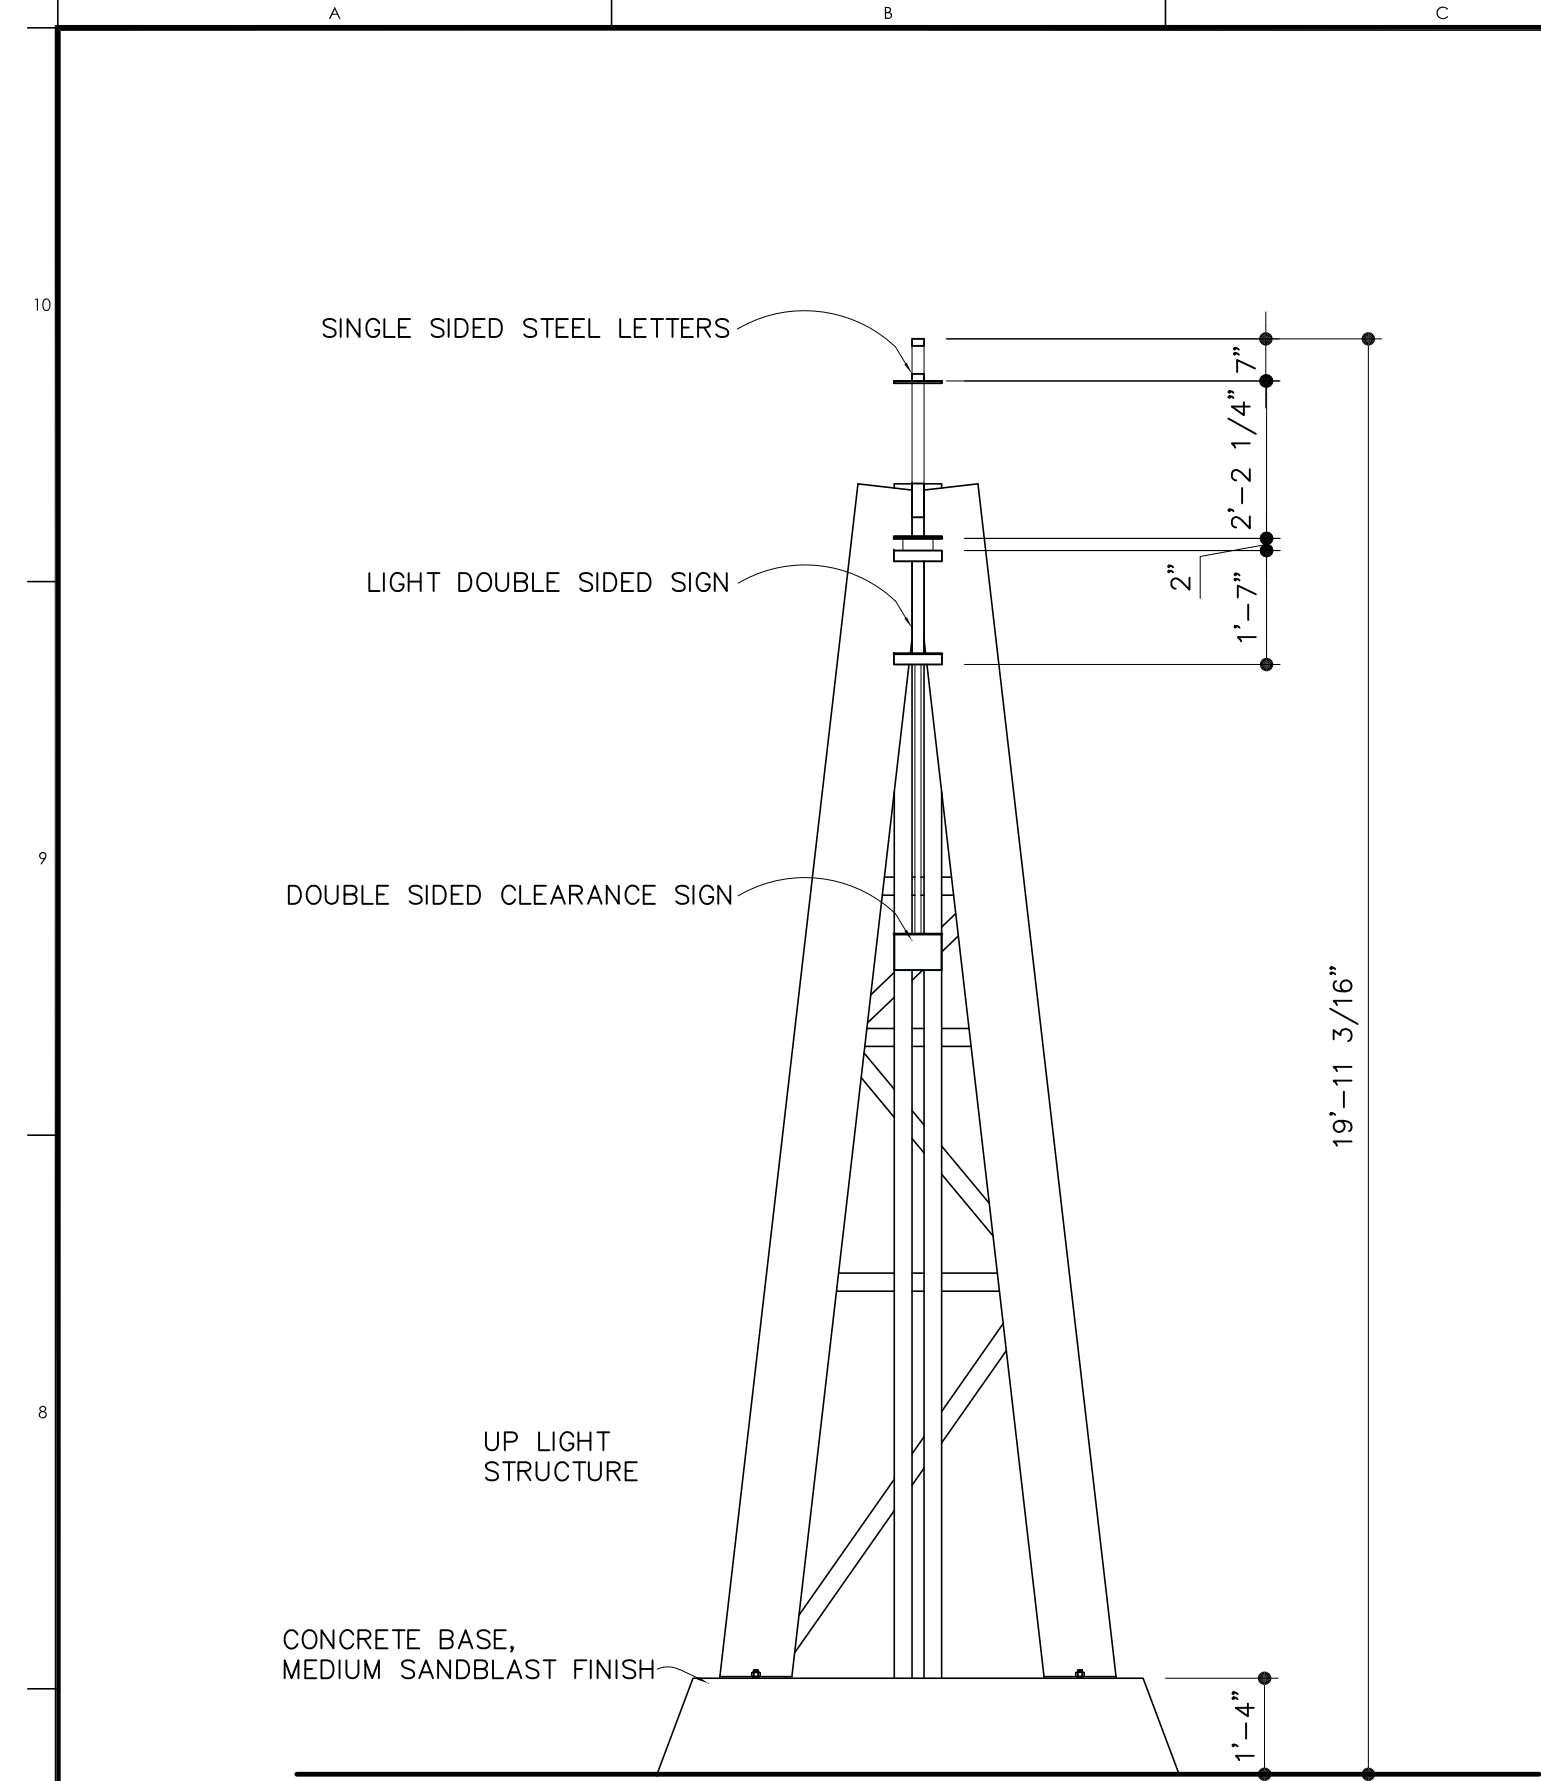


4 NEW DEPOT SIGN SIDE ELEVATION
A201 SCALE: 3/8" = 1'-0" AT 30" X 42"

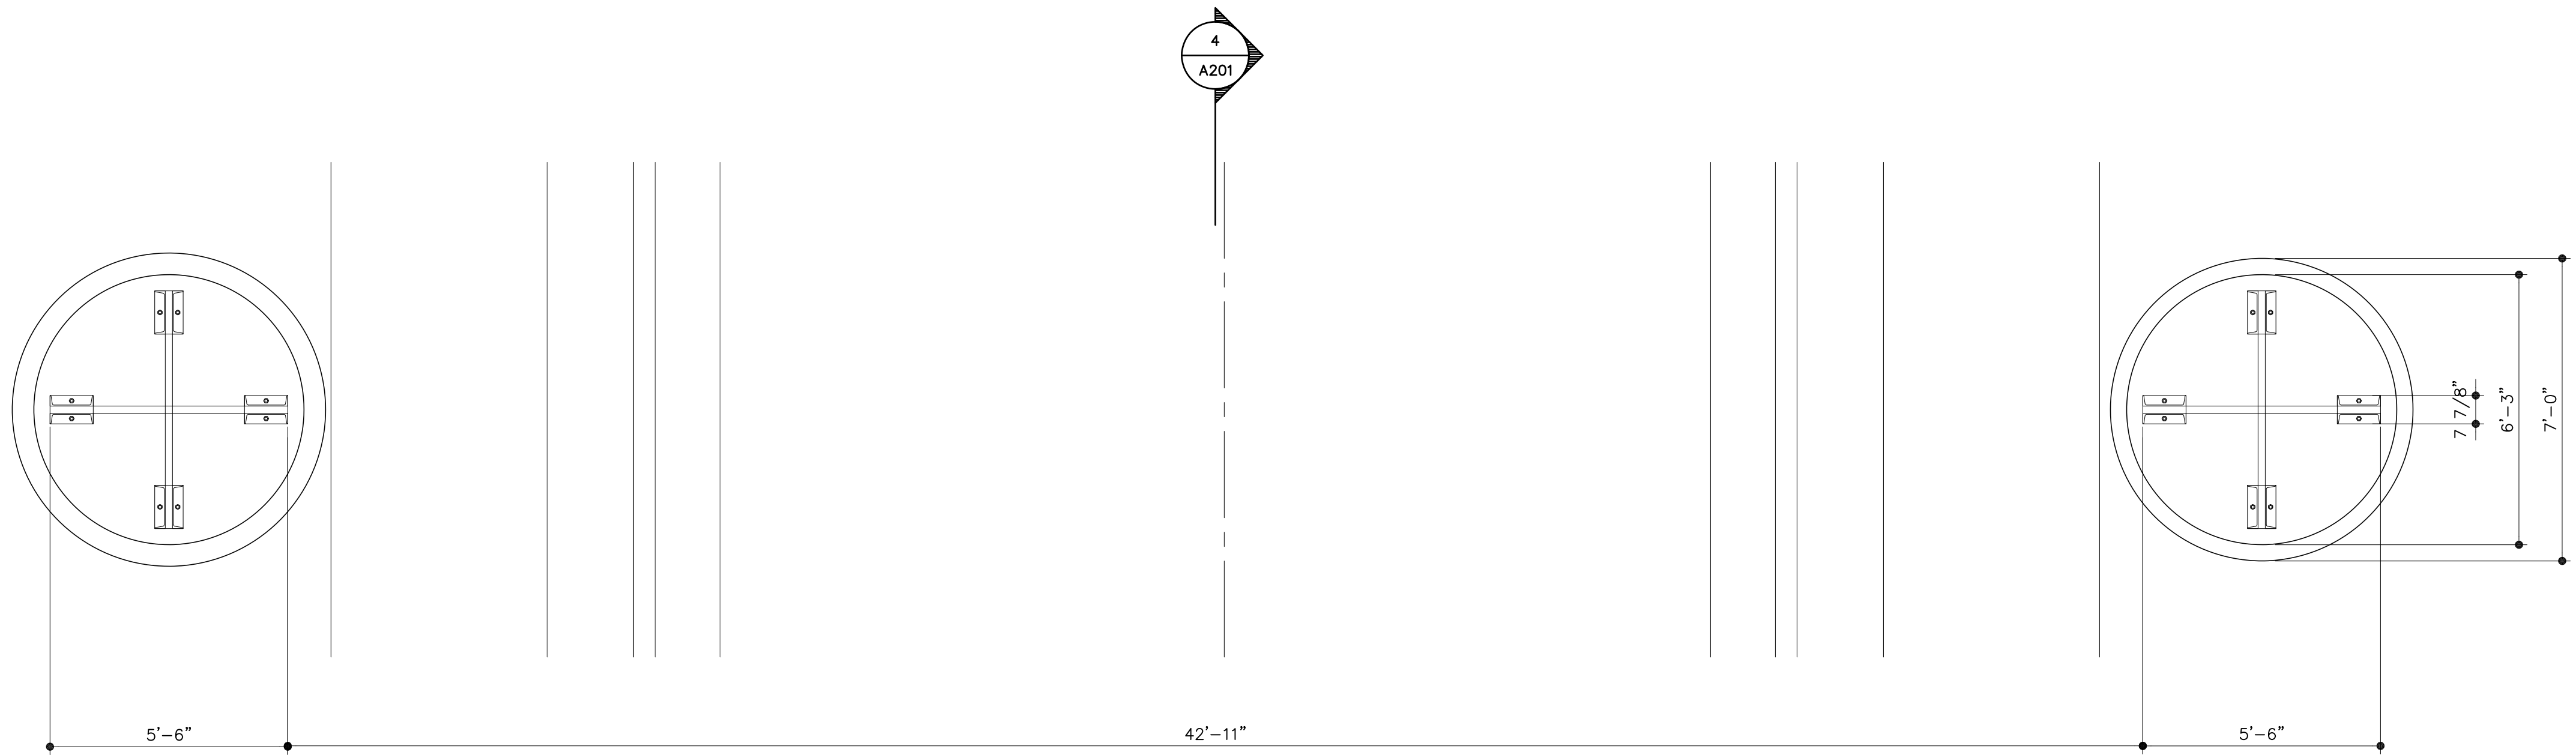


1 NEW DEPOT SIGN STREET LEVEL PLAN
A201 SCALE: 3/8" = 1'-0" AT 30" X 42"

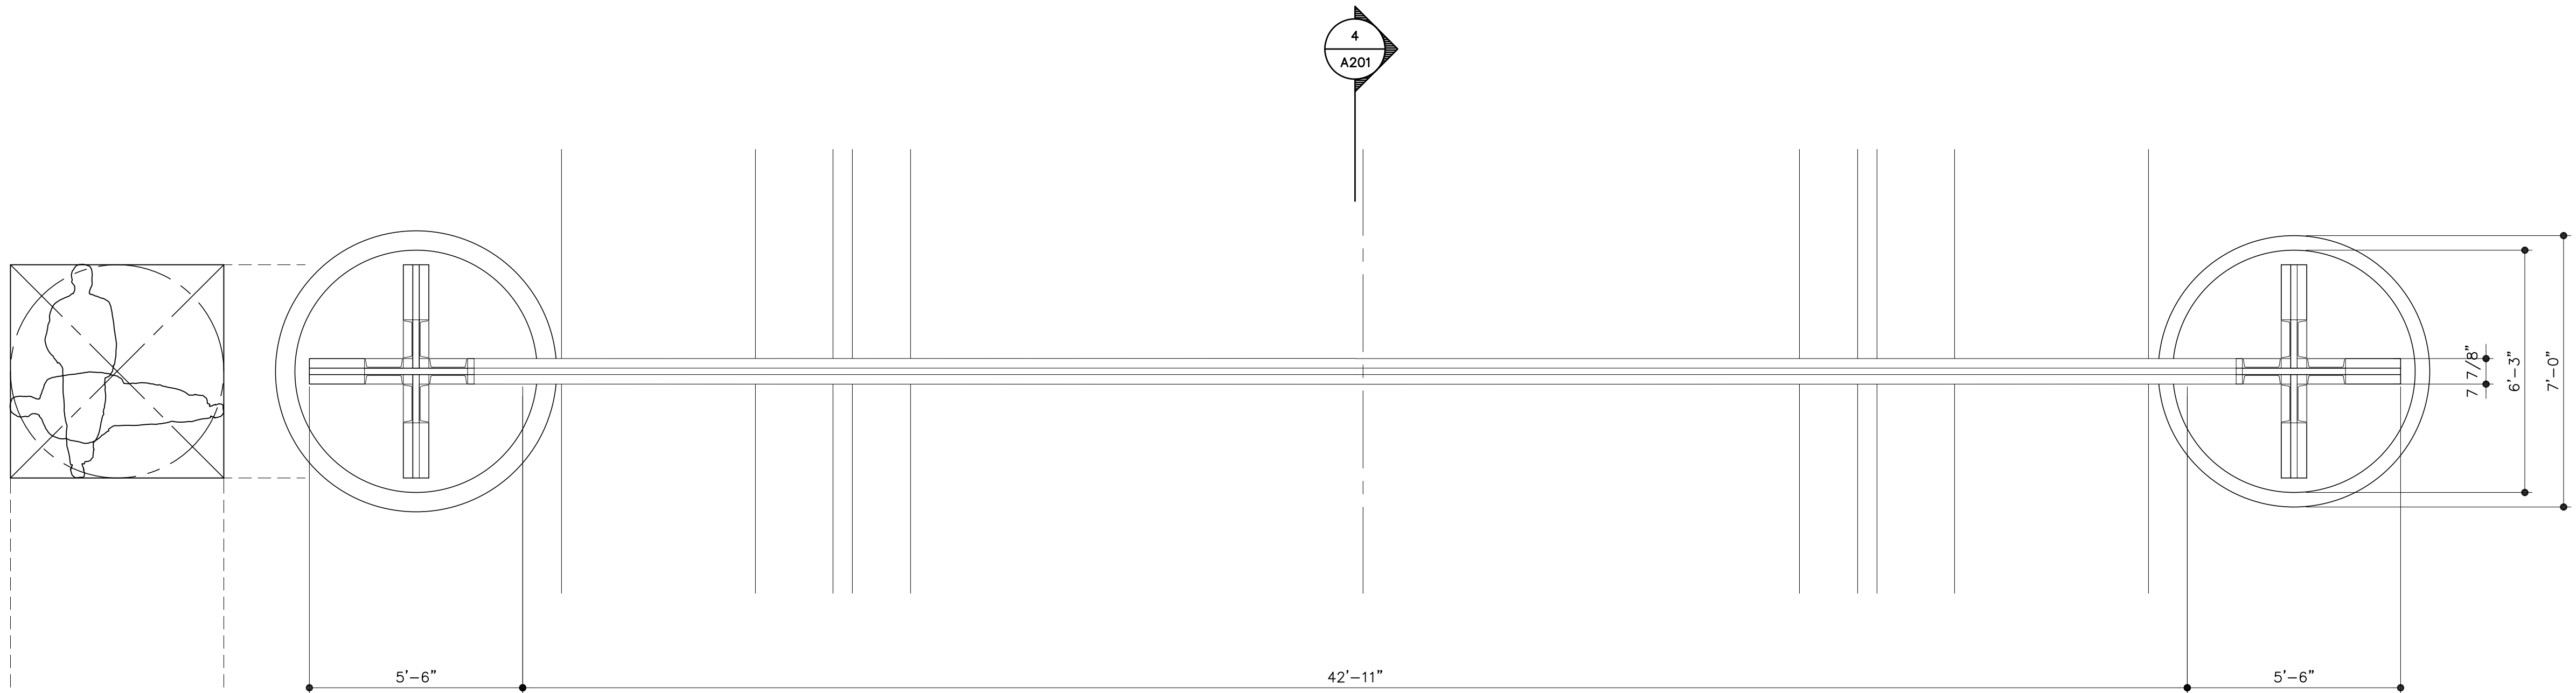

2 NEW DEPOT SIGN TOP VIEW PLAN
A201 SCALE: 3/8" = 1'-0" AT 30" X 42"

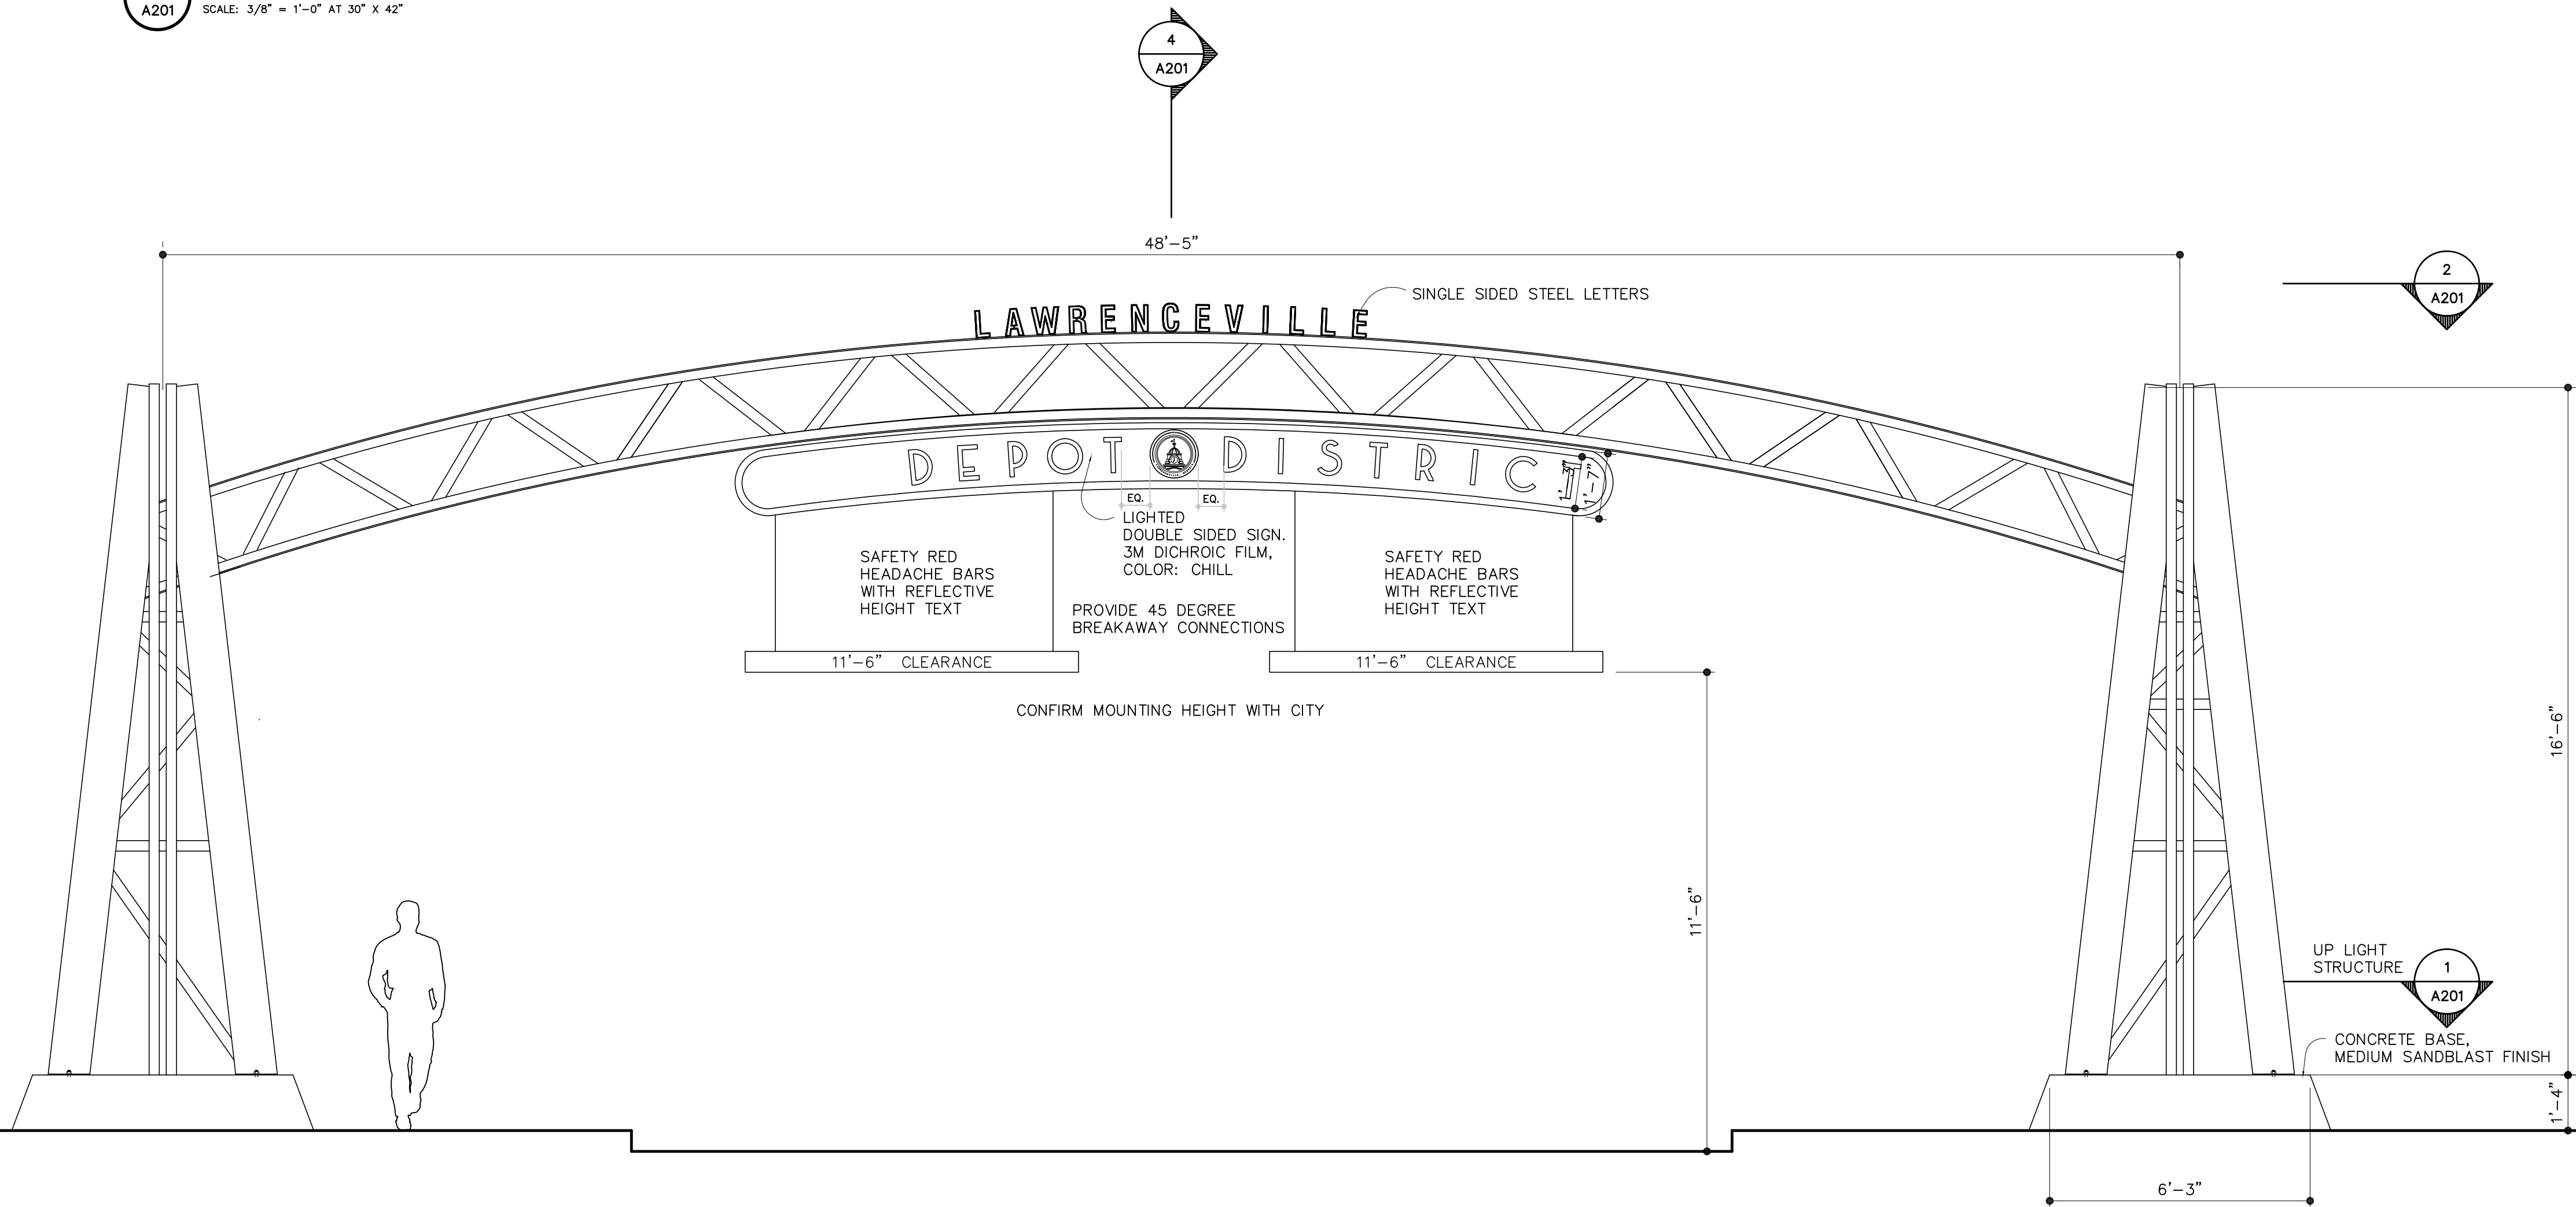

3 NEW DEPOT SIGN FRONT ELEVATION
A201 SCALE: 3/8" = 1'-0" AT 30" X 42"

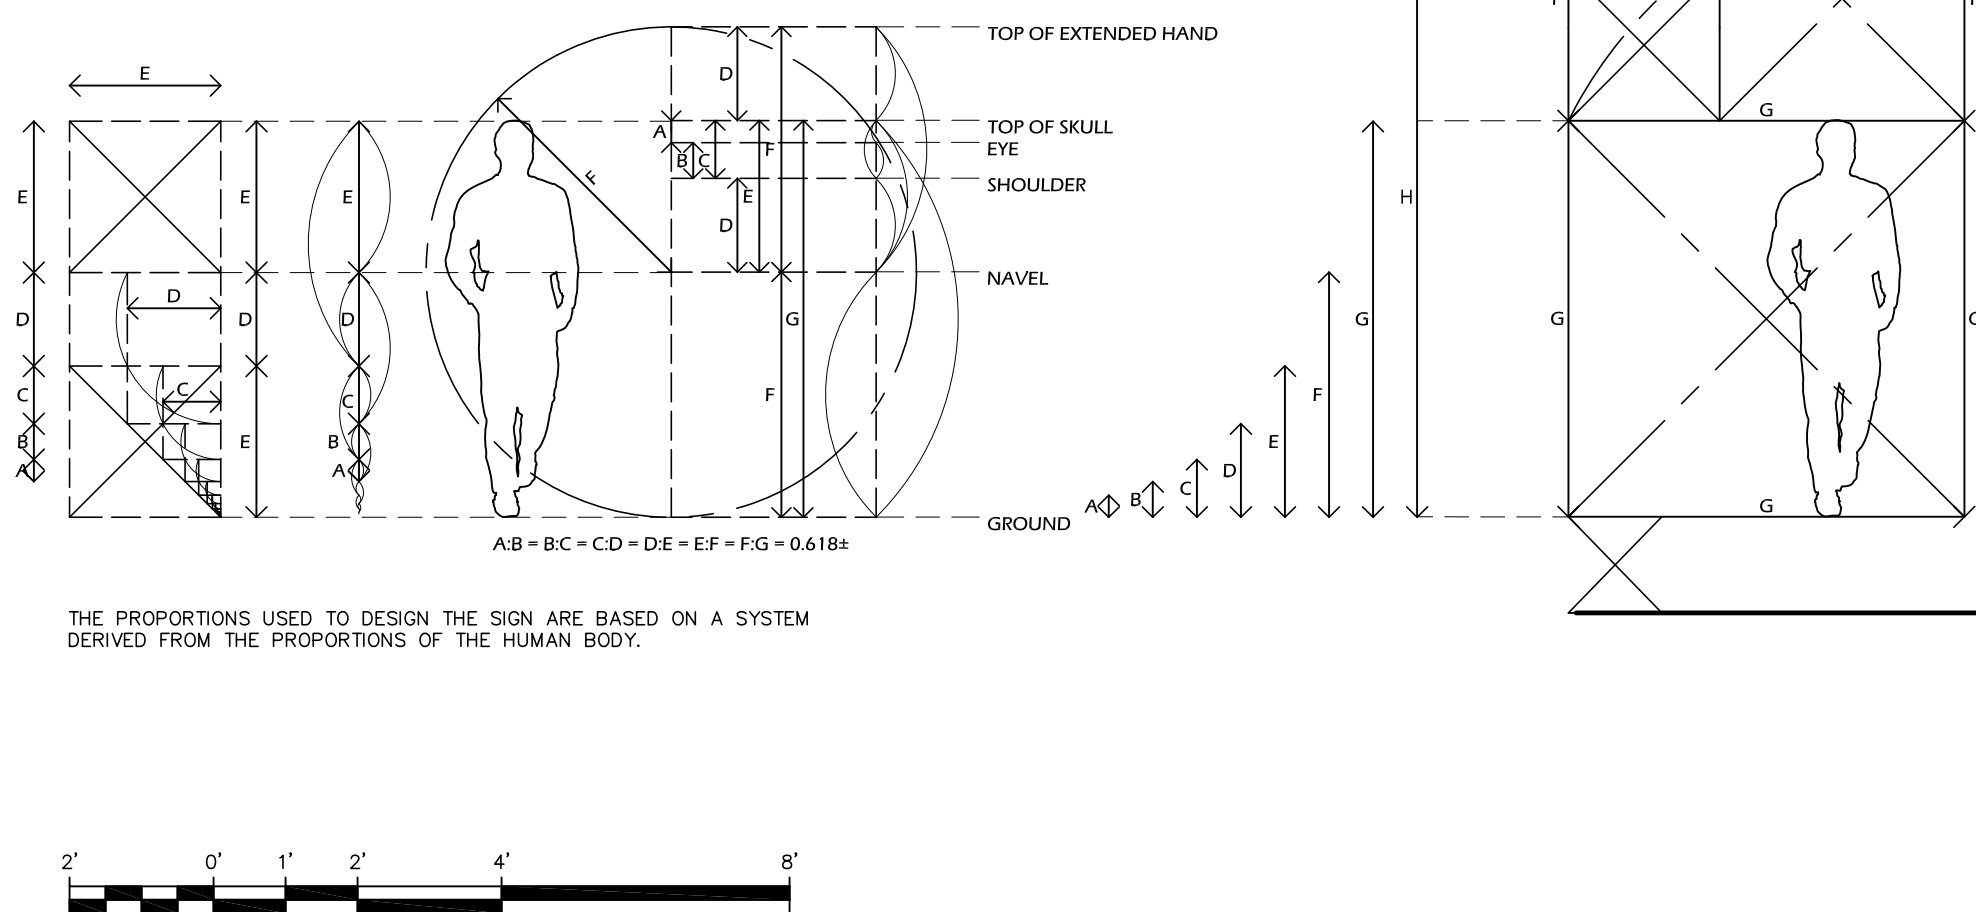

GENERAL NOTES

1. THE CONTRACTOR IS SOLELY RESPONSIBLE FOR PROVIDING ALL SAFETY MEASURES REQUIRED TO PROTECT THE GENERAL PUBLIC FROM DEMOLITION AND CONSTRUCTION WORK FOR THE DURATION OF THE PROJECT.
2. CONTRACTOR SHALL VERIFY DIMENSIONS OF ALL EXISTING CONDITIONS PRIOR TO CONSTRUCTION.

SHEET SPECIFIC NOTES

1. USE OF KAWAURA FONT BY DAVID KERNHOFF FOR "CITY OF LAWRENCEVILLE" AND "DEPOT DISTRICT" LETTERS.

STEEL FINISH

- | | |
|-----|--|
| F-1 | MILL FINISHED CARBON STEEL AND SEALED. REMOVE ORANGE RUST STAINS BEFORE APPLICATION. |
| F-2 | BLACKENED 316 STAINLESS STEEL. USE: INSTA-BLACK SS-370. PHONE: 252-786-1330. www.gsl.com/black-oxide/stainless-steel/room/inter-look-ss-370. or: |

ARCHITECT

Cos Architecture
183 N Perry St
Lawrenceville, GA
30046
404 806 0556

www.cosarc.com

CONSULTANT

SEAL

IF SEALED, DO NOT COPY

PROJECT

CITY OF LAWRENCEVILLE

Depot District
Signs

LAWRENCEVILLE, GA 30046

COPYRIGHT © 2020 CAS ARCHITECTURE, P.C. ALL RIGHTS RESERVED. THIS DOCUMENT AND ANY REPRODUCTIONS IN WHOLE OR IN PART ARE THE PROPERTY OF CAS ARCHITECTURE, P.C. AND MAY NOT BE REPRODUCED, PUBLISHED, USED OR COPIED IN ANY MANNER WITHOUT WRITTEN PERMISSION FROM CAS ARCHITECTURE, P.C. THESE DOCUMENTS HAVE BEEN PREPARED SPECIFICALLY FOR THE PROJECT. THEY ARE NOT SUITABLE FOR USE ON OTHER PROJECTS OR IN OTHER LOCATIONS. THIS DOCUMENT HAS BEEN CREATED ELECTRONICALLY. THIS MEDIA SHOULD NOT BE CONSIDERED A CERTIFIED DOCUMENT UNLESS IT HAS BEEN PROPERLY SEALED AND ORIGINALLY SIGNED BY A REGISTERED ARCHITECT OF CAS ARCHITECTURE, P.C. THESE PLANS ARE COMPLEMENTARY. THEREFORE THE CONTRACTOR SHALL USE THE ARCHITECTURAL, STRUCTURAL, MECHANICAL, PLUMBING AND ELECTRICAL PLANS AND SPECIFICATIONS, WHEN REQUIRED BY ANY ONE, SHALL BE BINDING AS REQUIRED BY ALL. THE CONTRACTOR SHALL BE RESPONSIBLE FOR THE COORDINATION OF THE WORK OF ALL TRADES.

NO. DATE ISSUANCE / REVISIONS


SHEET TITLE
NORTH PERRY STREET
DEPOT SIGN

SHEET NUMBER


A201

PROJECT DATE DRAWN BY
21119 6.21.21 CAS


FILE
21119_03_A201.dwg

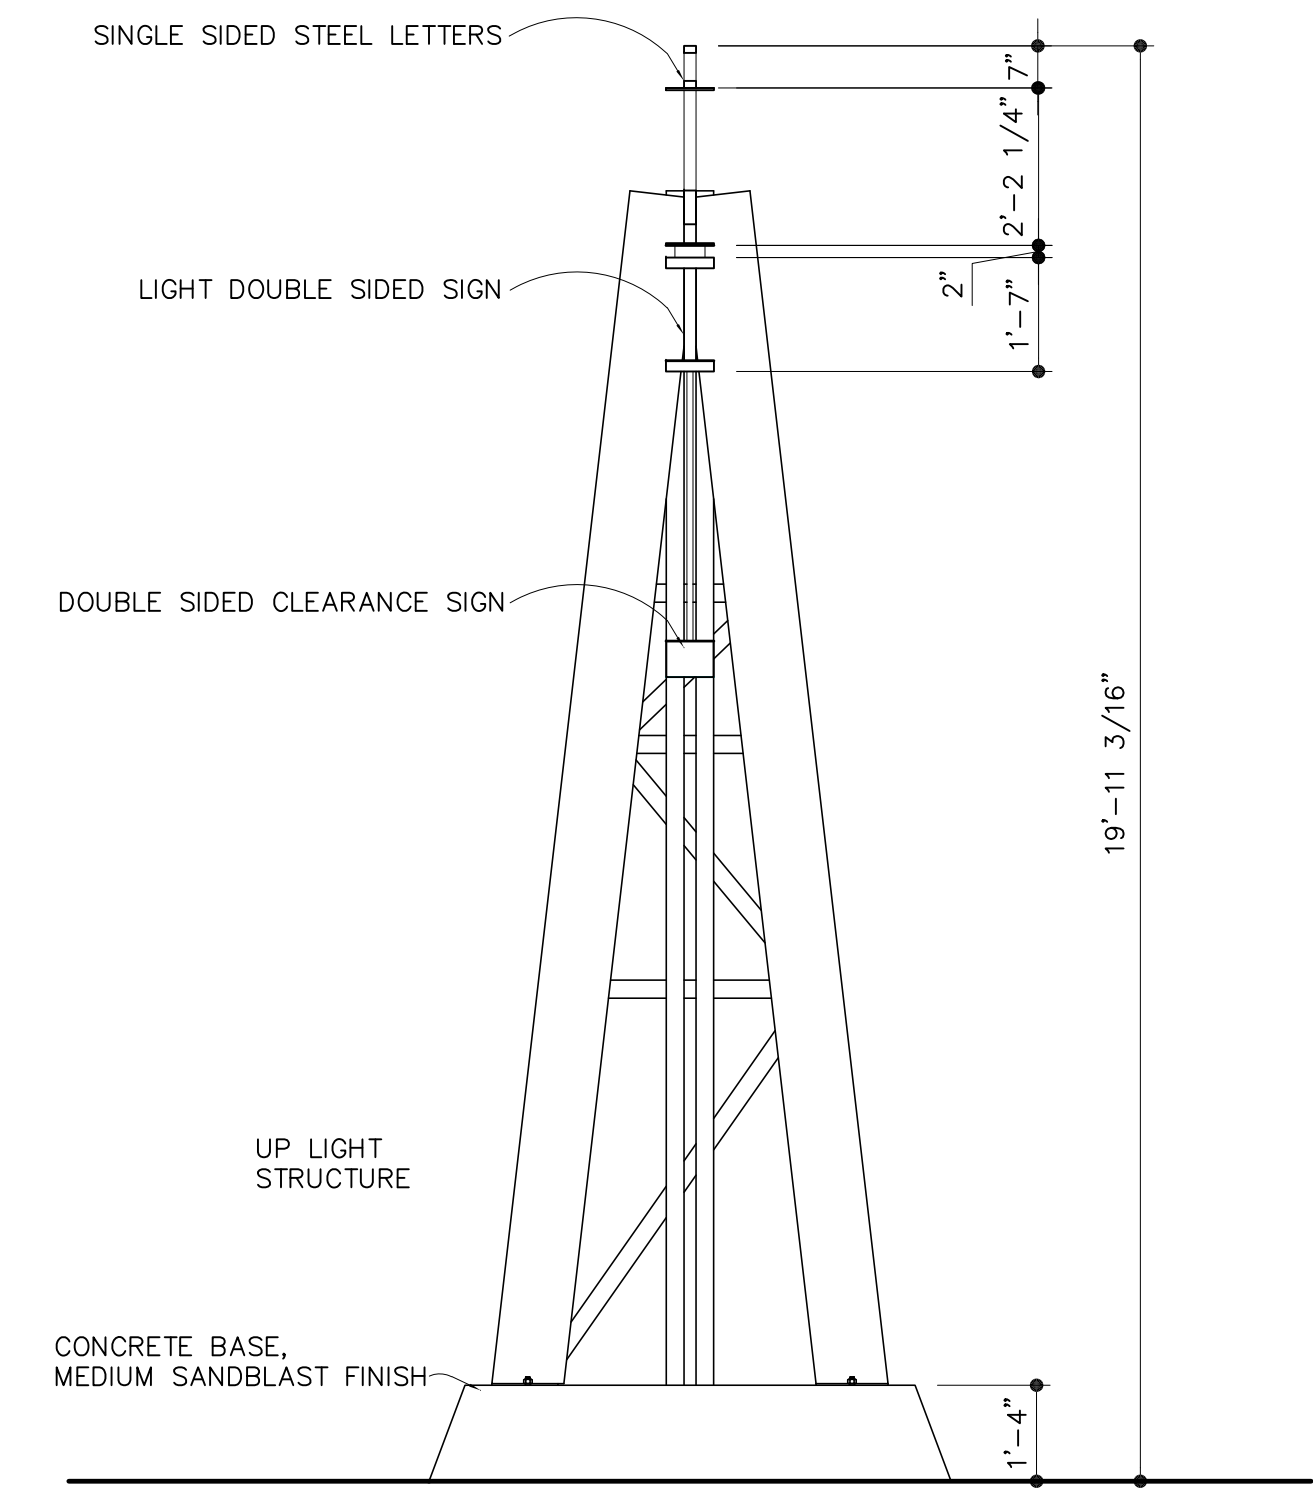


4 NEW DEPOT SIGN SIDE ELEVATION
SCALE: 3/8" = 1'-0" AT 30" X 42"

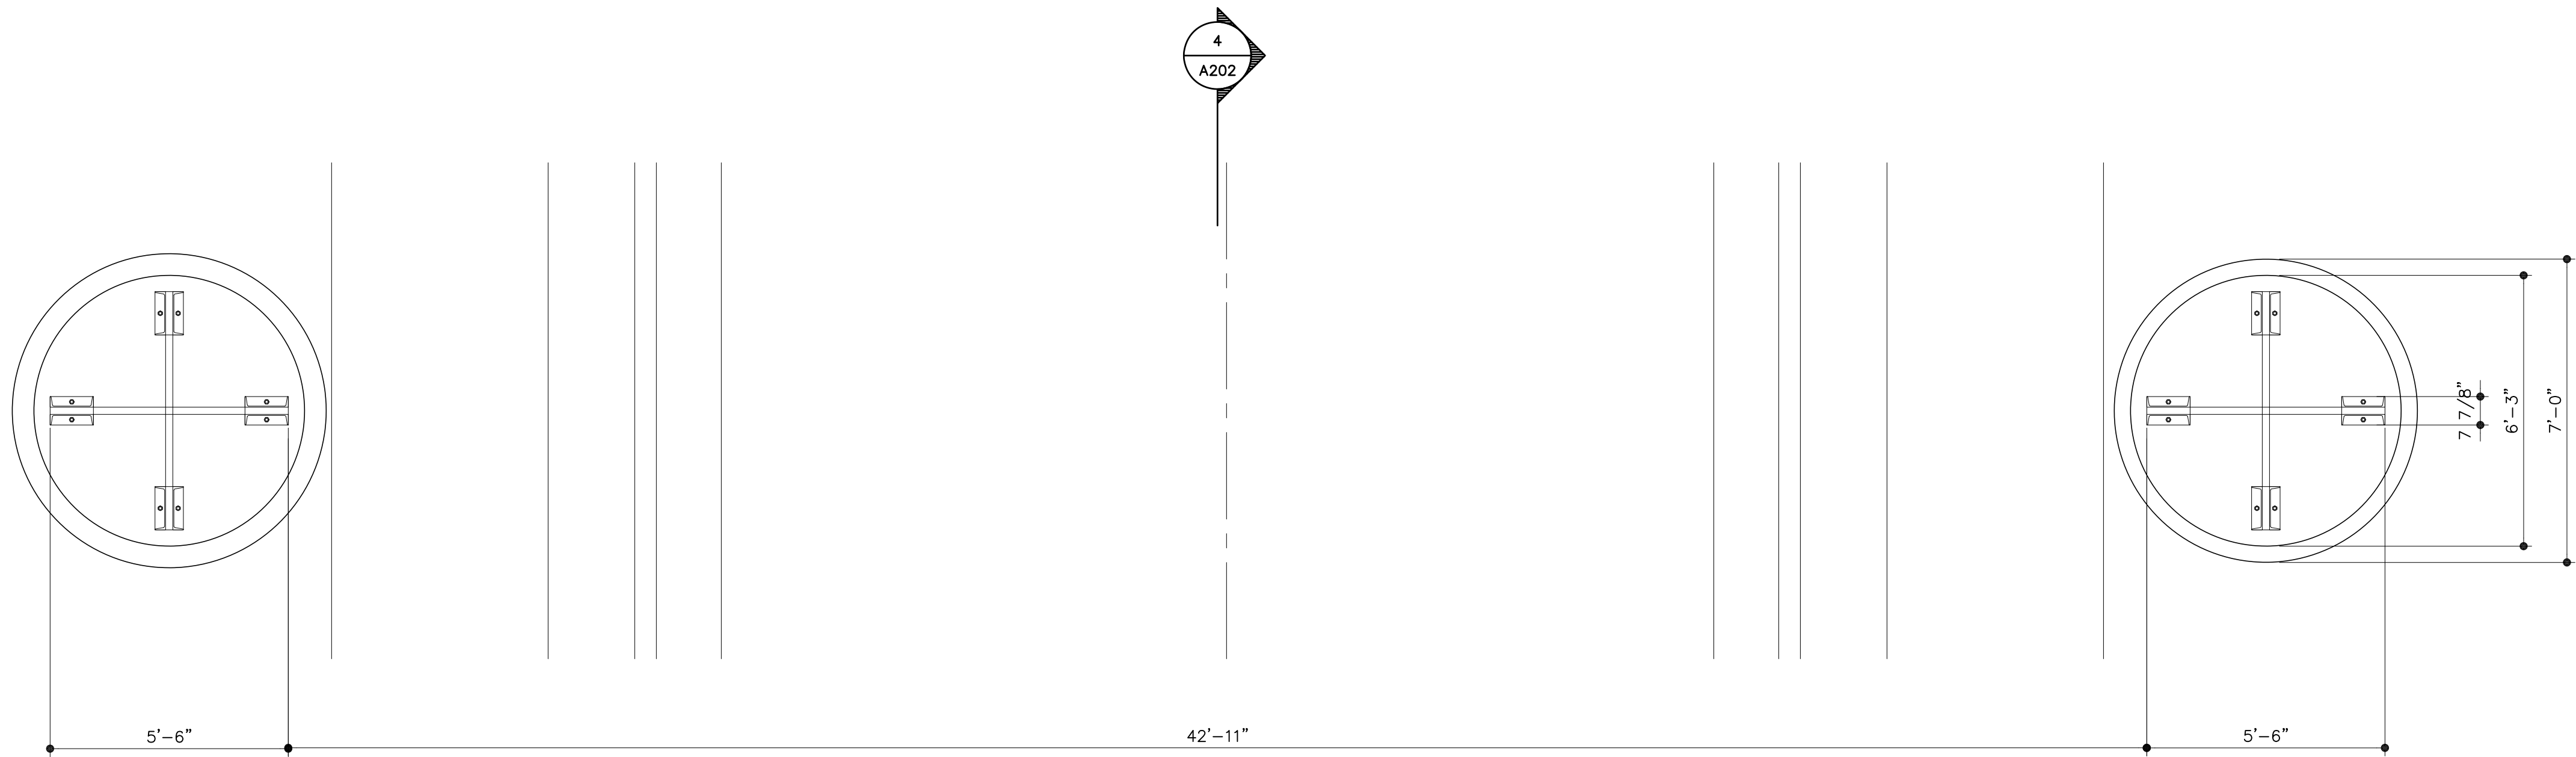

1 NEW DEPOT SIGN STREET LEVEL PLAN
SCALE: 3/8" = 1'-0" AT 30" X 42"

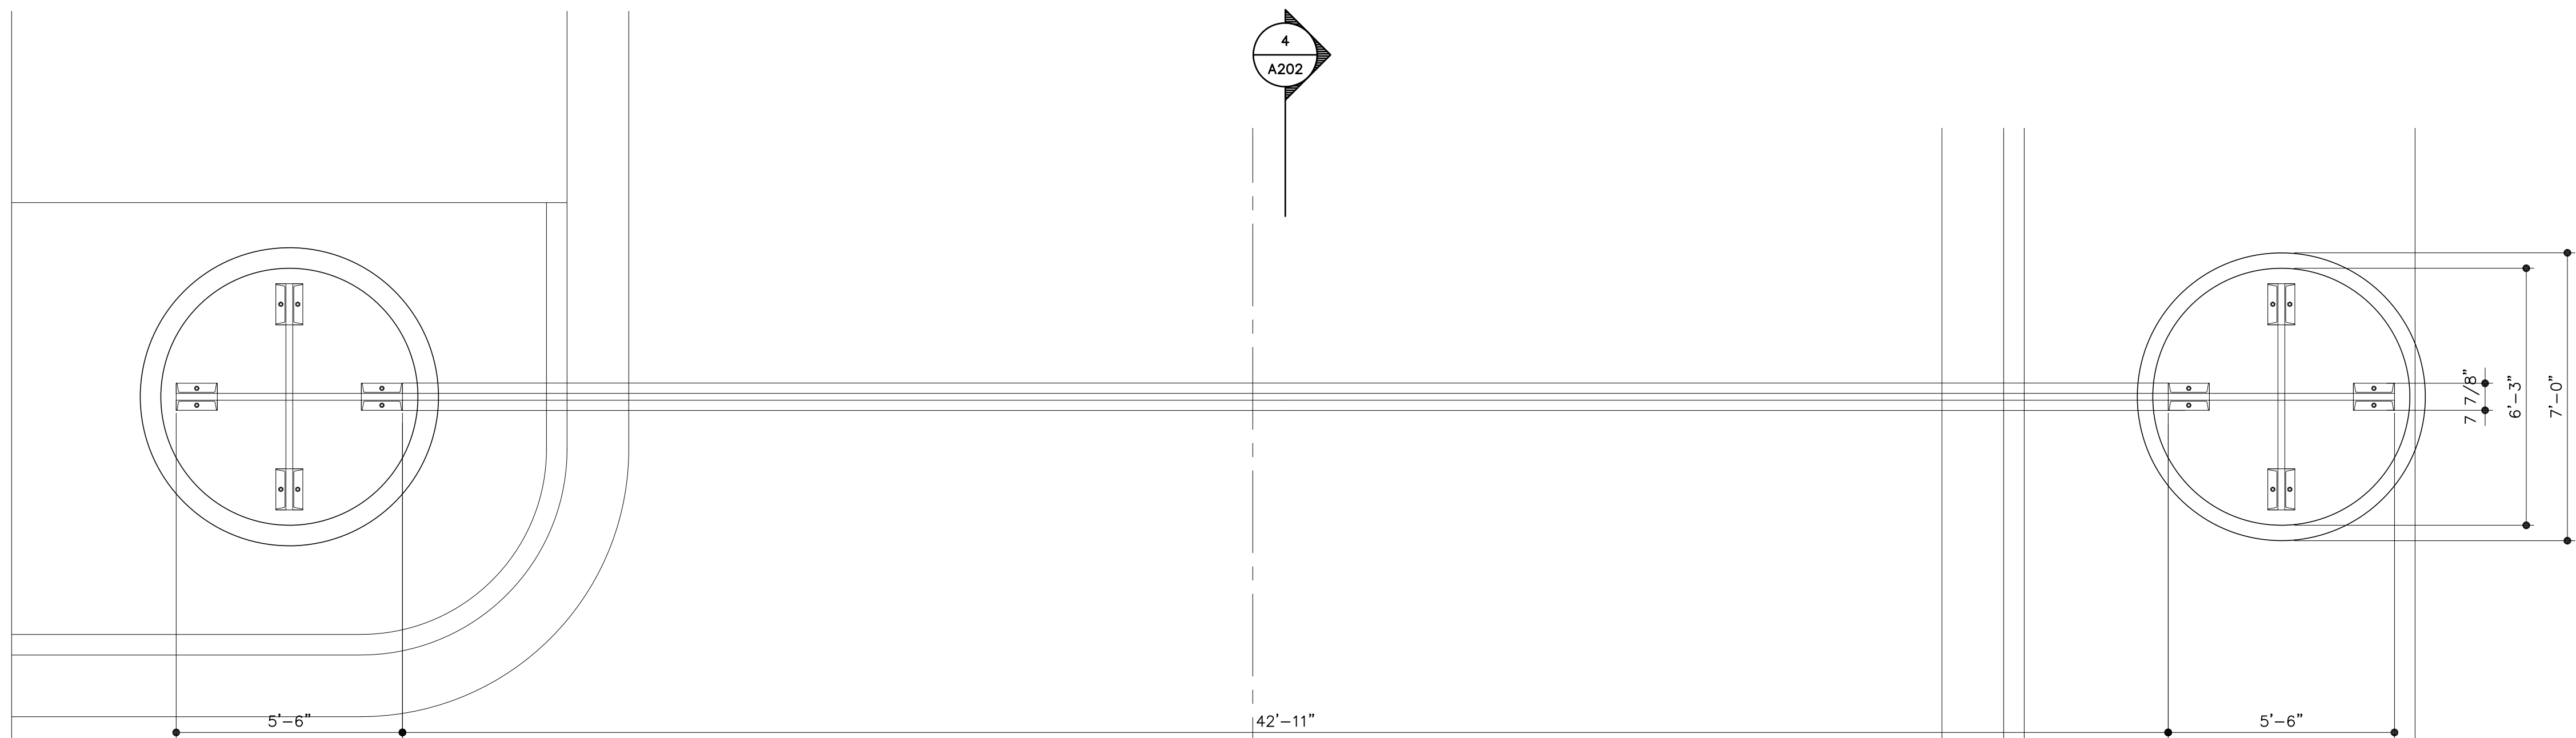

2 NEW DEPOT SIGN TOP VIEW PLAN
SCALE: 3/8" = 1'-0" AT 30" X 42"

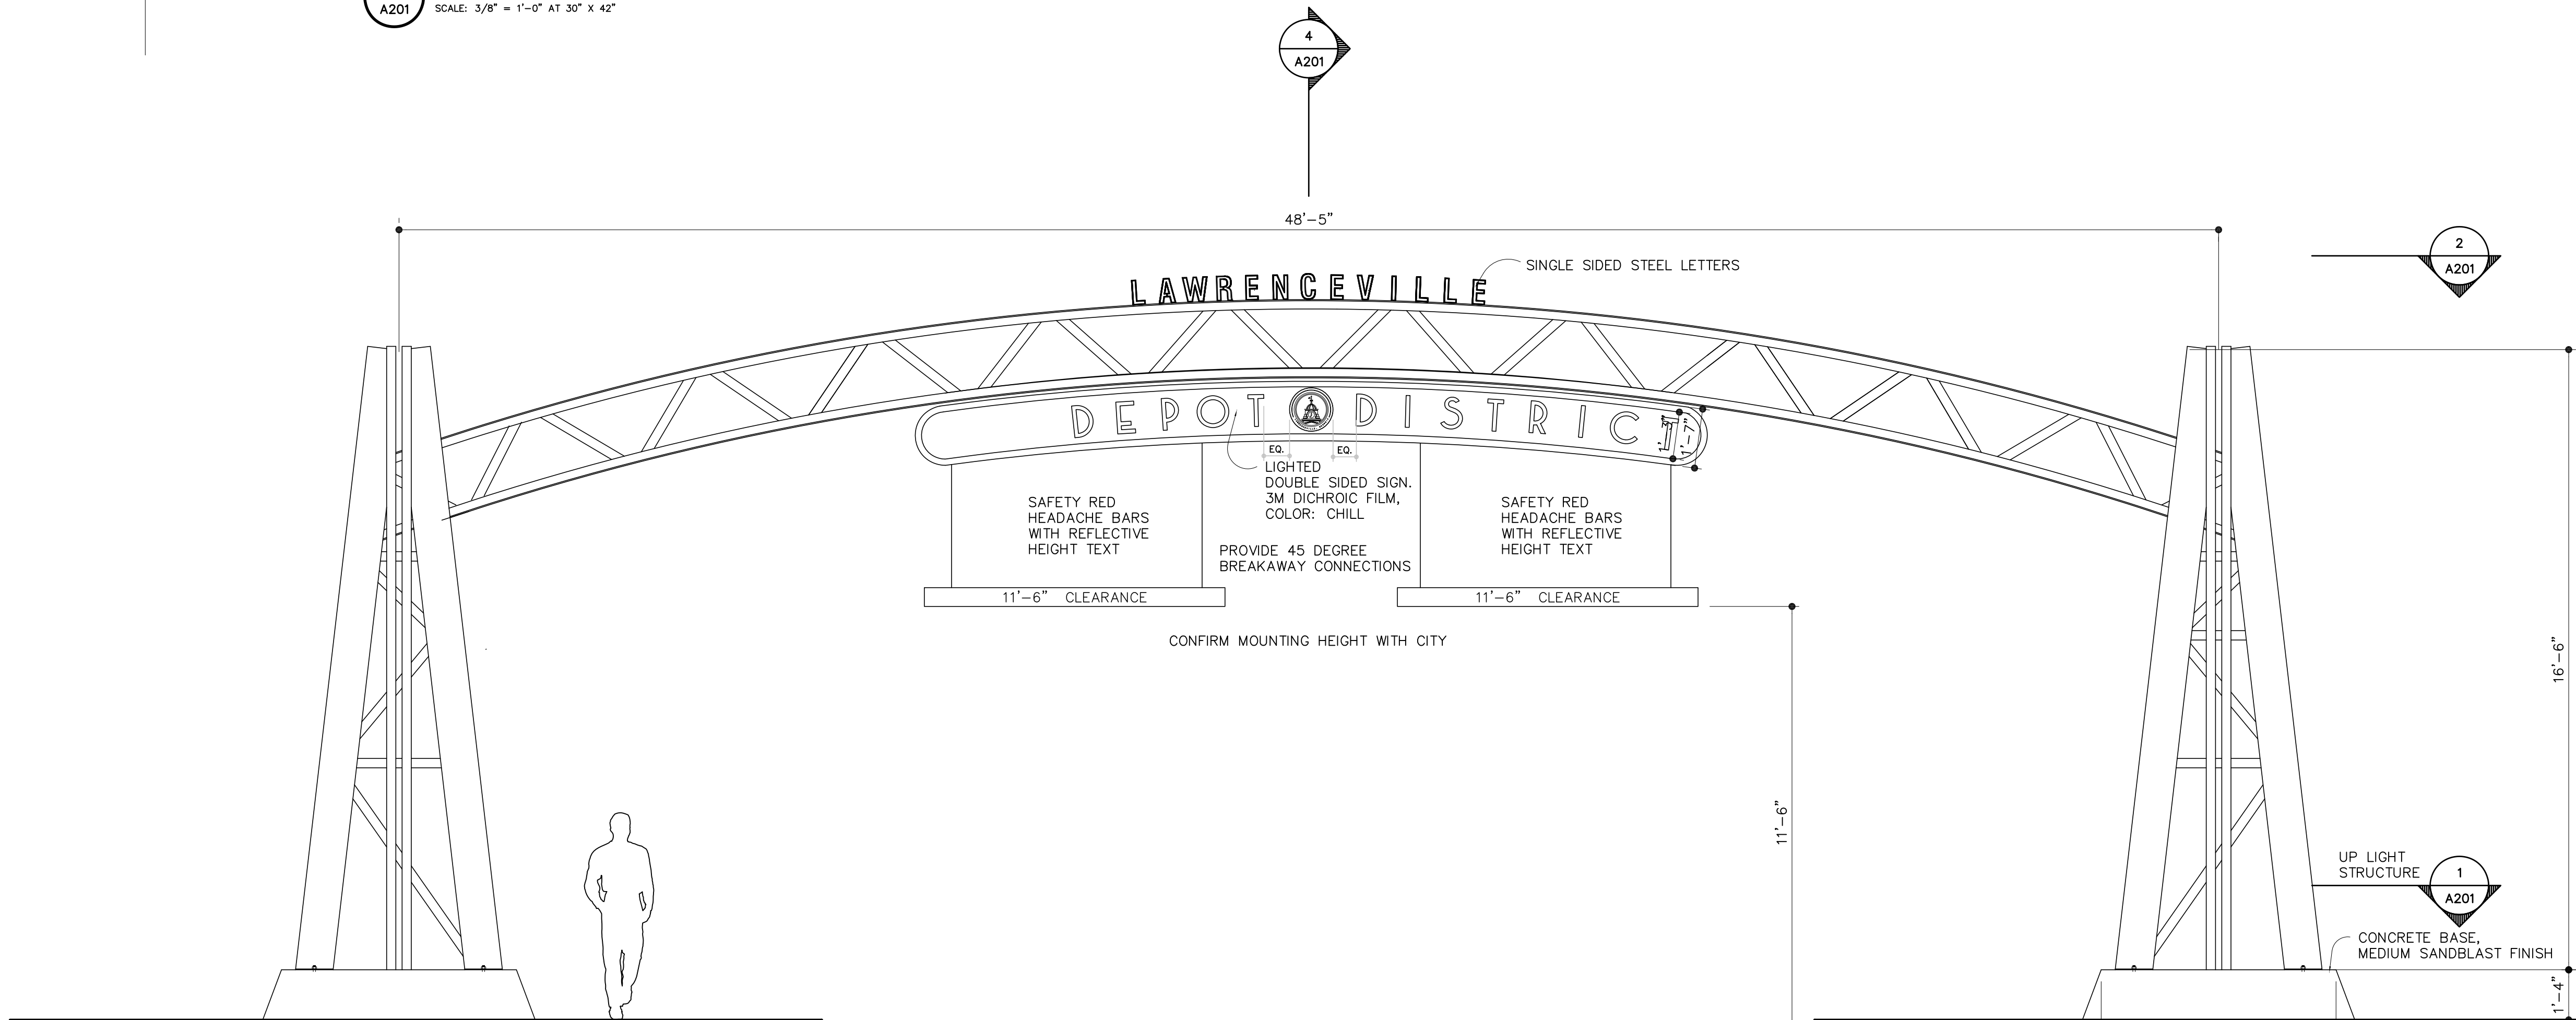

3 NEW DEPOT SIGN FRONT ELEVATION
SCALE: 3/8" = 1'-0" AT 30" X 42"

GENERAL NOTES

- THE CONTRACTOR IS SOLELY RESPONSIBLE FOR PROVIDING ALL SAFETY MEASURES REQUIRED TO PROTECT THE GENERAL PUBLIC FROM DEMOLITION AND CONSTRUCTION WORK FOR THE DURATION OF THE PROJECT.
- CONTRACTOR SHALL VERIFY DIMENSIONS OF ALL EXISTING CONDITIONS PRIOR TO CONSTRUCTION.

SHEET SPECIFIC NOTES

- USE OF KAWOOWA FONT BY DAVID KERNHOFF FOR "CITY OF LAWRENCEVILLE" AND "DEPOT DISTRICT" LETTERS.

STEEL FINISH

- F-1 MILL FINISHED CARBON STEEL AND SEALED. REMOVE ORANGE RUST STAINS BEFORE APPLICATION.
- F-2 BLACKENED 316 STAINLESS STEEL. USE EPA INSTA-BLAK SS-370 PHONE: 252-786-1330 www.epi.com/black-oxide/stainless-steel/room/ INTER-SIDE-SS-370

ARCHITECT

Cos Architecture
183 N Perry St
Lawrenceville, GA
30046
404 806 0556

www.cosarc.com

CONSULTANT

SEAL

IF SEALED, DO NOT COPY

PROJECT

CITY OF LAWRENCEVILLE

Depot District
Signs

LAWRENCEVILLE, GA 30046

COPYRIGHT © 2020 CAS ARCHITECTURE, P.C. ALL RIGHTS RESERVED. THIS DOCUMENT AND ANY REPRODUCTIONS IN WHOLE OR IN PART ARE THE PROPERTY OF CAS ARCHITECTURE, P.C. AND MAY NOT BE REPRODUCED, PUBLISHED, USED OR COPIED IN ANY MANNER WITHOUT WRITTEN PERMISSION FROM CAS ARCHITECTURE, P.C. THESE DOCUMENTS HAVE BEEN PREPARED SPECIFICALLY FOR THIS PROJECT. THEY ARE NOT SUITABLE FOR USE ON OTHER PROJECTS OR IN OTHER LOCATIONS.

THIS DOCUMENT HAS BEEN CREATED ELECTRONICALLY. THIS MEDIA SHOULD NOT BE CONSIDERED A CERTIFIED DOCUMENT UNLESS IT HAS BEEN PROPERLY SEALED AND ORIGINALLY SIGNED BY A REGISTERED ARCHITECT OF CAS ARCHITECTURE, P.C.

THESE PLANS ARE COMPLEMENTARY. THEREFORE THE CONTRACTOR SHALL SEE THE ARCHITECTURAL, STRUCTURAL, MECHANICAL, PLUMBING AND ELECTRICAL PLANS AND SPECIFICATIONS. WHAT IS REQUIRED BY ANY ONE SHALL BE BINDING AS REQUIRED BY ALL. THE CONTRACTOR SHALL BE RESPONSIBLE FOR THE COORDINATION OF THE WORK OF ALL TRADES.

NO. DATE ISSUANCE / REVISIONS

SHEET TITLE
SOUTH CLAYTON STREET
DEPOT SIGN

SHEET NUMBER

A202

PROJECT DATE DRAWN BY

21119 6.21.21 CAS

FILE
21119_03_A202.dwg



NO.	DATE	ISSUANCE / REVISIONS

SHEET TITLE
RENDERINGS

SHEET NUMBER

A203

PROJECT	DATE	DRAWN
21119	6.21.21	CAS
FILE	20104_02_A101.dwg	