

TOWN OF LOS GATOS

110 E. MAIN ST., LOS GATOS, CA. 95030

BUILDING INSPECTION DEPARTMENT - PHONE 354-6876

APPLICATION FOR BUILDING PERMIT

B 9441

3

FOR APPLICANT TO FILL IN

HERNANDEZ Que.	
TRACT	SIZE OF LOT
S.F.R.	NO. OF BUILDINGS NOW ON LOT
ST PALMER	PH 395-0315
IME	WK 371 8531
	PH
	PH
	TOWN LICENSE
DESCRIPTION OF WORK	
DD	ALTER REPAIR DEMOLISH
nd FL	GAR BSMT OTHER
	NO. OF STORIES NO. OF LIVING UNITS
F STRUCTURE	DESCRIPTION OF WORK
	room & bath
	ESTIMATE VALUATION 60,000.00
CONSTRUCTION LENDING AGENCY	

BUILDING PERMIT APPROVAL		DATE
PLAN DEPT.		7/11/81
PUBLIC WORKS		7/11/81
FIRE DEPT.		1/1
BUILDING DEPT.		10/15/81
SEWER CONNECT		
FR. SB	TYPE CONST.	
REAR SB	OCC. GROUP	
LEFT SB	USE ZONE	
RIGHT SB	FIRE SPR.	
VALUATION	\$ 60,000	
FEES & TAXES		
BUILDING PERMIT	\$	313.00
SIESMIC TAX		4.20
CONSTRUCTION TAX		45.50
UTILITY TAX		136.50
PLAN CHECK FEE		156.50
TOTAL	\$	655.70

READ CAREFULLY

THIS APPLICATION IS A BUILDING PERMIT WHEN PROPERLY FILLED OUT, SIGNED, AND VALIDATED FOR THE CORRECT PERMIT FEE, IN THE VALIDATION SPACE.

PERMISSION IS THEREFORE GRANTED TO DO SUCH WORK AS INDICATED, IN THIS APPLICATION, IN ACCORDANCE WITH, AND SUBJECT TO, ALL OF THE PROVISIONS OF THE BUILDING CODE OF THE TOWN OF LOS GATOS AND RELATED LAWS.

THIS PERMIT BECOMES NULL AND VOID IF WORK IS NOT COMMENCED WITHIN 120 DAYS FROM THE DATE OF ISSUANCE, OR IF WORK IS SUSPENDED AT ANY TIME DURING CONSTRUCTION FOR MORE THAN 120 DAYS, OR IF ANY WORK IS DONE ON THE SAID BUILDING OR STRUCTURE IN VIOLATION OF ANY TOWN ORDINANCE OR STATE LAW RELATING THERETO.

CONTRACTORS DECLARATION

I AM PROPERLY LICENSED BY THE STATE OF CALIFORNIA LICENSE LAW.

COMPLETE A OR B

WORKER'S COMPENSATION DECLARATION

BY AFFIRM THAT I HAVE A POLICY OF WORKER'S COM-
ION INSURANCE. A CERTIFIED COPY OF A CERTIFICATE OF
INSURANCE IS HEREWITH FURNISHED, AND ON FILE WITH
VN. I FURTHER AFFIRM THAT I SHALL KEEP THE INSURANCE
CT THROUGHOUT THE JOB.

EXEMPTION FROM WORKER'S COMPENSATION INSURANCE

RTIFY THAT IN THE PERFORMANCE OF THE WORK FOR
THIS PERMIT IS ISSUED, I SHALL NOT EMPLOY ANY PER-
ANY MANNER SO AS TO BECOME SUBJECT TO THE
R'S COMPENSATION LAWS OF CALIFORNIA.

AT I HAVE READ THIS APPLICATION AND STATE THAT THE
ATION IS CORRECT. I AGREE TO COMPLY WITH ALL
ANCES AND STATE LAWS RELATING TO BUILDING CON-
ND HEREBY AUTHORIZE REPRESENTATIVES OF THIS CITY
N THE ABOVE MENTIONED PROPERTY FOR INSPECTION

VALIDATION

10/6/81 9350 655.70

NOTICE

WORK AUTHORIZED BY THIS PERMIT RE-
QUIRES INSPECTION AND APPROVAL.
WHEN WORK IS READY FOR INSPECTION.
CALL BUILDING DEPARTMENT, 354-6876.

ATTACHMENT 6

110 EAST MAIN STREET

Job Address

Date _____

Owner

Building Permit No.

TYPE OF INSPECTION	COMPLETION	
		INSPECTOR
A. Location Excavation, Forms		
B. Foundation, Steel, Material		

C. Plumbing, Rough (Partial)		
D. Mechanical Underfloor		
E. Girder and Joist		

F. Frame		
G. Masonry		
H. Flues, Vents		
I. Plumbing, Rough (Complete)		
J. Electric, Conduit		
K. Electric, Wiring		
L. Roof Sheathing		
M. Mechanical Rough		
N. Water Service Pressure Regul'tr		
O. Insulation		

P. Interior Lath		
Q. Exterior Lath		
R. Final Gas Test		
S. Furnace		
T. Electrical Fixtures		
U. Plumbing Fixtures		
V. Sewer (Backwater Valve)		
W. Insulation Certificate		
X. Smoke Detector		
Y. House Number Posted		
Z. Final, Job Completed		

[illegible]

INSPECTOR MUST BE GIVEN 24-HOUR NOTICE
BEFORE EACH INSPECTION. PHONE 354-6876

THIS CARD MUST BE KEPT POSTED ON THE
JOB AT ALL TIMES UNTIL FINAL APPROVAL

SEE REVERSE SIDE FOR INFORMATION AND
REQUIREMENTS FOR FINAL INSPECTION
AND OCCUPANCY

NOTICE

Final inspection and occupancy of all new buildings requires clearance from the following agencies:

BUILDING DEPARTMENT (354-6876)

- a) Building construction complete and approved.
- b) Final grading and drainage completed.
- c) Energy compliance certification.

PLANNING DEPARTMENT (354-6872)

- a) Driveway and parking improvement complete.
- b) Required landscape and irrigation complete.

PUBLIC WORKS (354-6864)

- a) Subdivision and offsite improvements complete.
- b) Off site utilities installed and completed.

CENTRAL FIRE (378-4015)


- a) Fire hydrants completed and operational.
- b) Fire extinguishers as required installed.
- c) Fire sprinkler system (if applicable) tested and operational.
- d) Emergency or fire access (if required) completed.

HEALTH DEPARTMENT (279-6060)

- a) Private sewage disposal system (if applicable) to be complete and approved.
- b) Certificate of compliance and approval for food handling facilities.

On request for final inspection, **Building Department** will process occupancy clearance request for approval of required occupancy certificate.

Occupancy or utility approval cannot be granted until required agency clearance is approved.

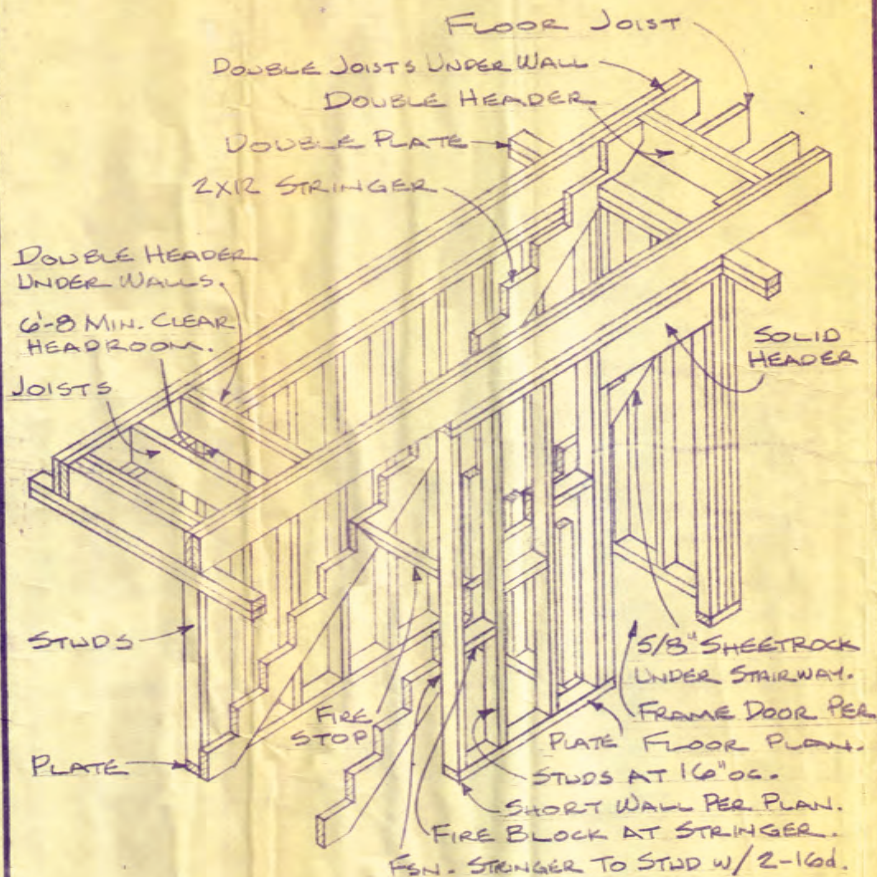


APPROX.
B-3

STAIR FRAME DETAIL

SIGNED

SCALE
1"=1'-0"

JOB
APPROX.
B-3

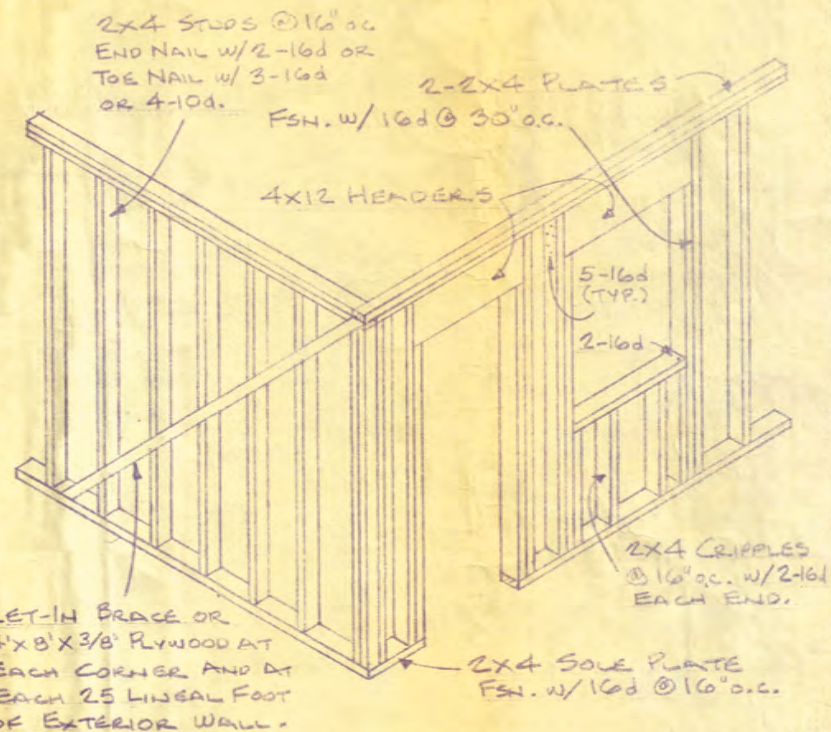

LET-IN BRACE OR
4'X8'X3/8\"/>

SUBFLOOR PER FOUNDATION PLAN.

APPROX.
B-1



WALL FRAMING

SIGNED

SCALE
1"=1'-0"


JOB
APPROX.
B-1



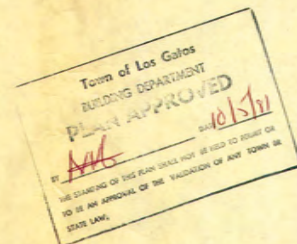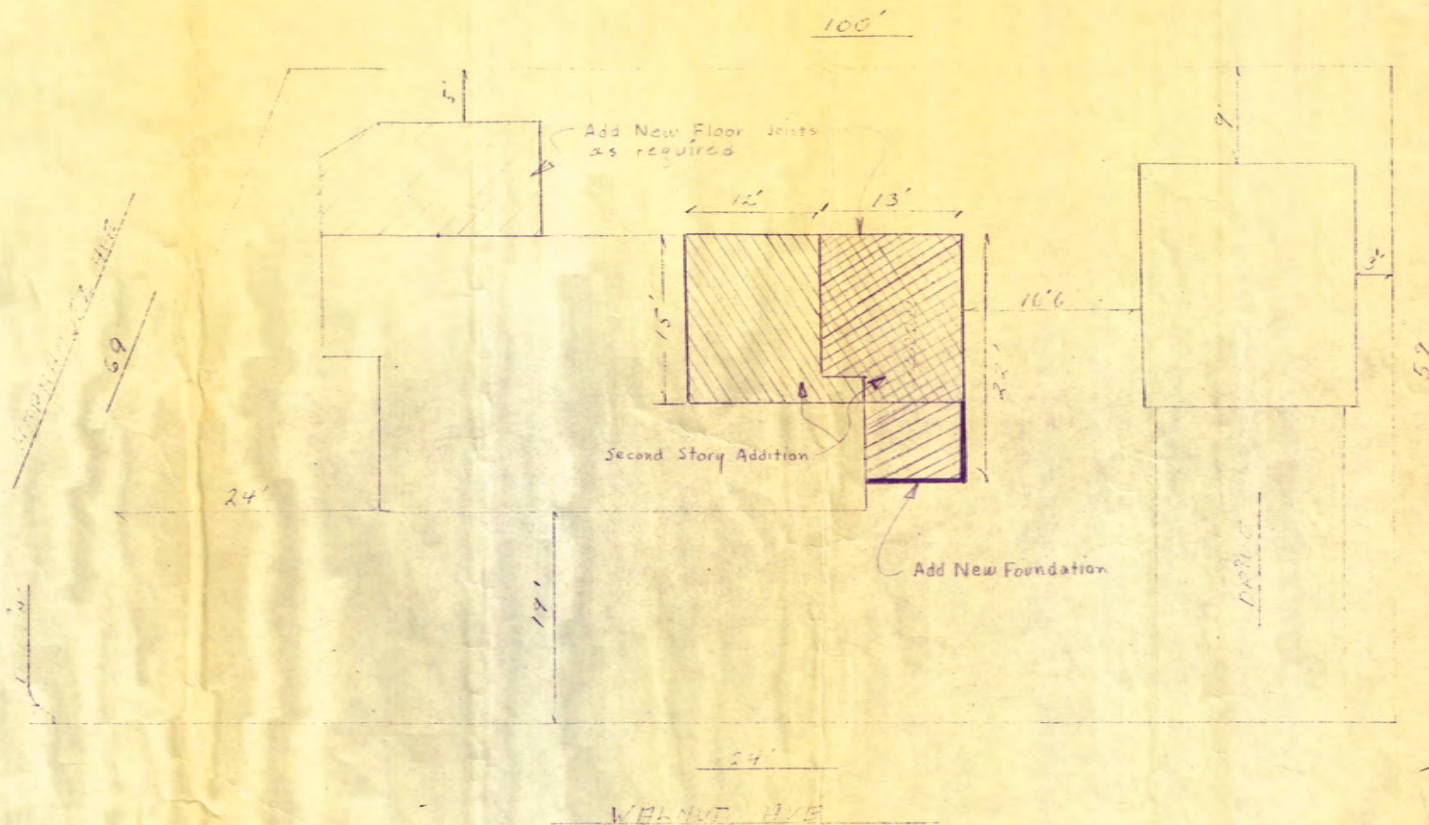


MR. & MRS. PALMER		
SCALE: 1/2" = 1'	APPROVED BY: <u>Melvin R. Hill</u>	DRAWN BY:
DATE:		REVISED: <u>MH</u>
67 HENNHOFFZ		
Melvin R. Hill RCE 19704 410 W. Sunnyoaks Ave, Campbell		DRAWING NUMBER 5-1

866-1546

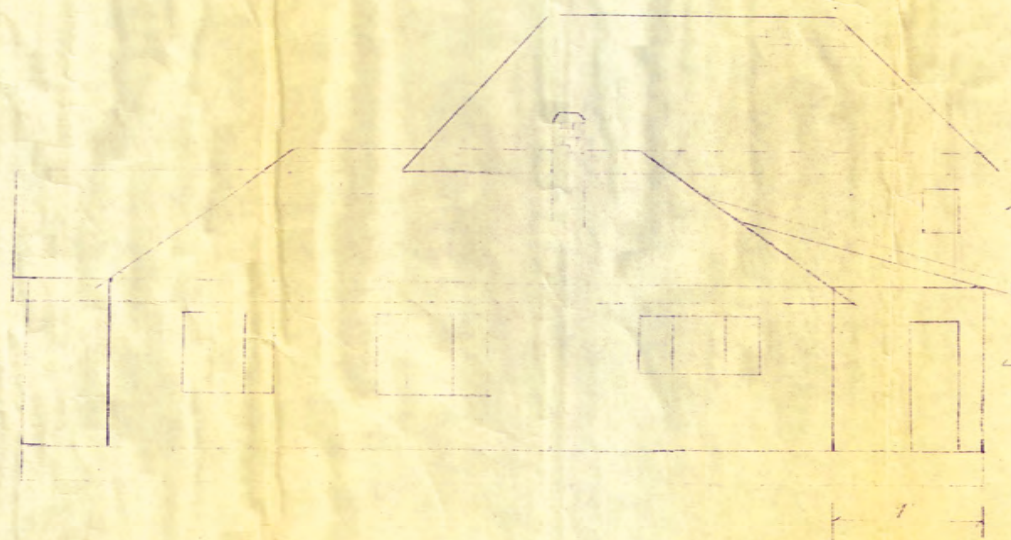


NEW ADDITION

EXISTING PORCH

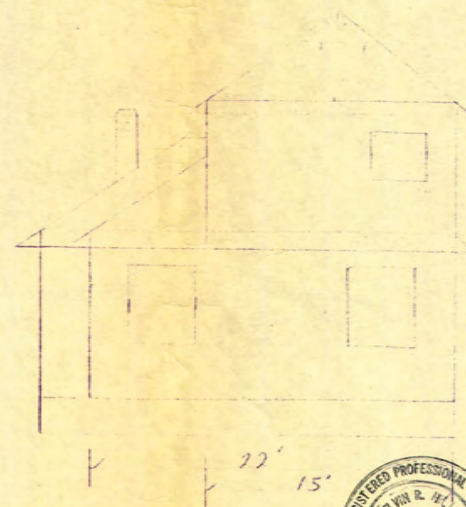


MRS & MRS. PALMER

SCALE: 1/8" = 1'	APPROVED BY: <i>Melvin R. Hill</i>	DRAWN BY:
DATE:	REVISED: MH	
69 HERNANDEZ, LOS GATOS		
Melvin R. Hill 410 W. Sunnyoaks Ave., Campbell	RCE 19704	DRAWING NUMBER: S-2

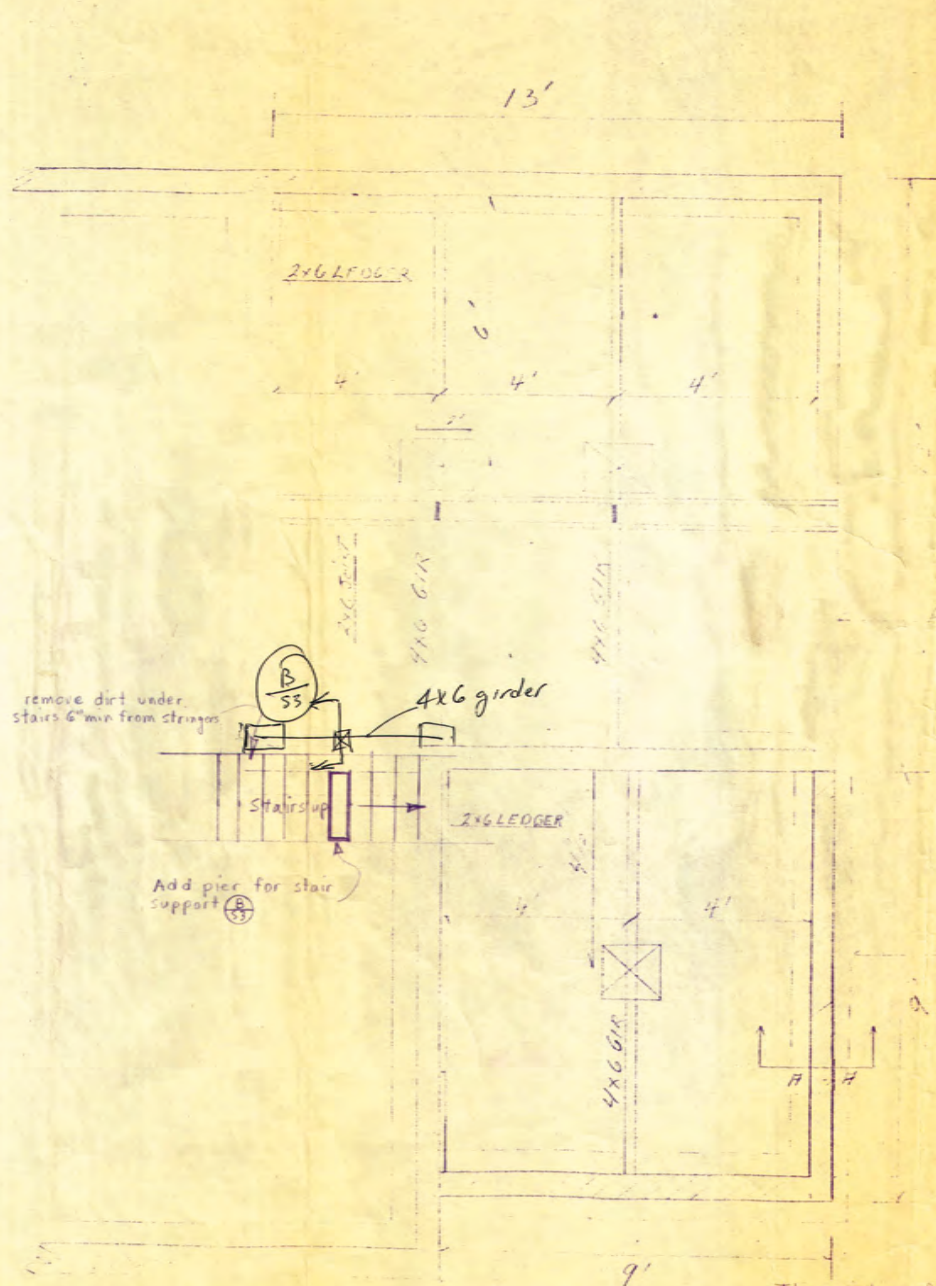

EXISTING FDN

NEW FDN

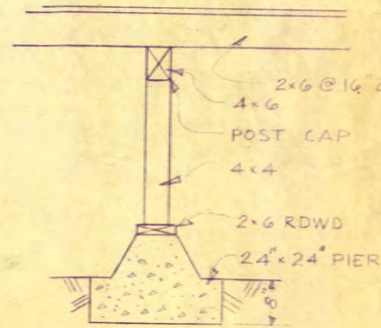

B
S-3


A
S-3

3/4" SCALE

2x4 STUDS 16" OC
1/2" PLYWOOD SHEAR
ALL OUTSIDE WALLS
4x12 NAILS
3/8" T&B FLOOR JOIST
2x6 FLOOR JOIST
16" OC

2x4 @ 16" OC
underpinning to be
2x6 or 3x4 studs @ 2 story
bearing walls




1/2" BOLTS 6' OC
1/2" BARS T&B

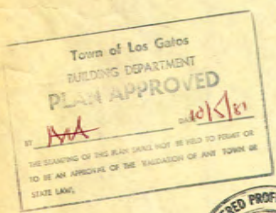

The existing fdn. is adequate to carry the proposed second story provided the piers are added as shown

Melvin R. Hill
RCE 19704

MR & MRS. PALMER			
SCALE: 1/2" = 1'	APPROVED BY:		DRAWN BY
DATE: 10-1-81	Melvin R. Hill		REVISED: MH
GR HERNANDEZ, LOS GATOS			
Melvin R. Hill RCE 19704 410 W Sunnyside Ave, Campbell			DRAWING NUMBER S-3

 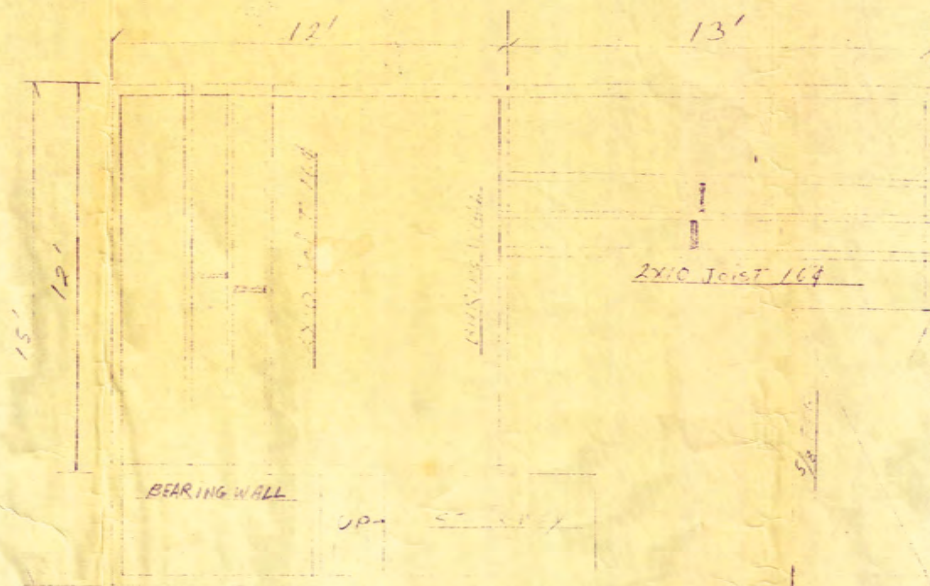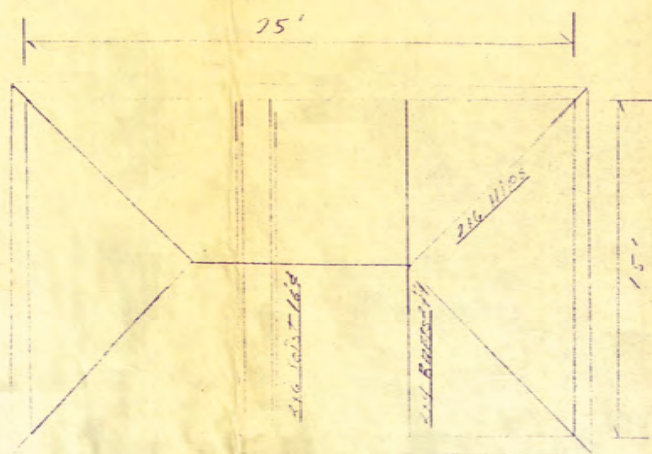

SECOND STORY

PER INSULATION CEILING


DOUBLE INSULATED WINDOWS

PER INSULATION WALL

2x10 JOIST

4x12 HOSE HILL OUTLINE

2x10 JOIST

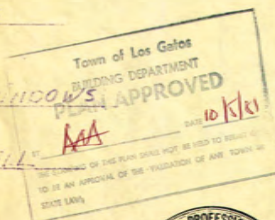

MR. & MRS. PALMER

SCALE	APPROVED BY	DRAWN BY
DATE	Melvin R. Hill	REVISED MH
69 HERNANDEZ, LOS GATOS		
Melvin R. Hill RCE 19704		DRAWING NUMBER
410 W. Sunnyside Ave. Campbell		5-4



SHEETROCK ATTIC SPACE for storage, etc.

SECOND STORY
N.T.S.

OAKLAND WALL LINES
NEW BUILDING

SECOND FLOOR

Town of Los Angeles
 BUILDING DEPARTMENT
 PLAN APPROVED
 [Signature]
 10/5/81



MR & MRS PALMER

SCALE: 1/4" = 1'-0"
 APPROVED BY: [Signature]
 DRAWN BY: [Signature]

This Page Intentionally Left Blank