

TOPO LEGEND

- WM WATER METER
- WV WATER VALVE
- ICV INTERVAL CONTROL VALVE
- FH FIRE HYDRANT
- SIGN
- SM SANITARY SEWER MANHOLE
- 95 MAJOR CONTOUR
- 94 MINOR CONTOUR
- OP OVERHEAD POWER LINE
- OT OVERHEAD TELEPHONE LINE
- SS SANITARY SEWER LINE
- G NATURAL GAS LINE
- W WATER LINE
- VEGETATION/TREE LINE

LEGEND

- PROPERTY LINE
- EXISTING SUBSTATION CHAIN LINK FENCE
- PROPOSED SUBSTATION CHAIN LINK FENCE
- EXISTING CONCRETE PANEL FENCE
- PROPOSED CONCRETE PANEL FENCE
- PROPOSED NON-CONDUCTIVE FENCE
- 95 EXISTING MAJOR CONTOUR
- 94 EXISTING MINOR CONTOUR
- 94 PROPOSED CONTOUR
- PROPOSED ASPHALT DRIVEWAY
- PROPOSED ENTRANCE DRIVEWAY
- EXISTING CATCH BASIN, TYPE 1
- PROPOSED CATCH BASIN, TYPE 1
- GRATE INLET
- GATE VALVE
- EXISTING DRAINAGE PIPE
- PROPOSED DRAINAGE PIPE
- EXISTING FOUNDATION
- PROPOSED FOUNDATION
- EXISTING VAULT



CATCH BASIN SCHEDULE

CB-1 TYPE 1 RIM EL 96.40 S- IE 6" 93.62 E- IE 6" 93.72	CB-2 TYPE 1 RIM EL 97.00 W- IE 6" 94.00 E- IE 6" 93.90	GI-1 RIM EL 96.72 N- IE 6" 94.69 E- IE 6" 95.12 S- IE 6" 95.05 W- IE 6" 94.83
CB-3 TYPE 1 RIM EL 96.72 S- IE 6" 94.64 W- IE 6" 94.54	CB-4 TYPE 1 RIM EL 96.72 S- IE 6" 95.14 E- IE 6" 95.04	

REFERENCE DRAWINGS

- D-21030 SITE PLAN AND GENERAL NOTES
- D-21032 TEMPORARY EROSION/SEDIMENT CONTROL PLAN
- D-21033 GRADING AND FENCING PLAN
- D-3306 FOUNDATION PLAN
- D-3326 STRUCTURAL PLAN

60% DESIGN
NOT FOR CONSTRUCTION

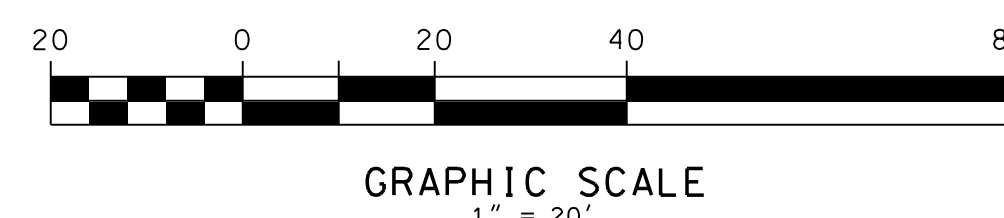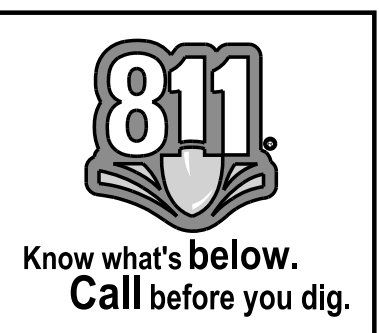

WD NUMBER: 111023608		CITY PROJECT NO:	
REVISION DESCRIPTION: REVISED PER LYNDEN TRC COMMENTS		DRAINAGE PLAN LYNDEN SUBSTATION	
DATE: 2022.08.18 15:03:47-0700			
CADD: J. Nelson	ENGINEER: J. Nelson	PSE PUGET SOUND ENERGY	SUBSTATION ENGINEERING DEPARTMENT
REVIEWED:	APPROVED: J. HENRY		
SCALE: 1"=20'-0"		CLASS: SITE	DRAWING NO: D-21034
FILE NO:		CODE: LYN	REV NO: 1
CADD NO: D-21034_01.dgn		INTERNAL USE	

USER: j.nelson 2:56:49 PM 8/17/2022