


- LEGEND**
- PROPERTY LINE
 - EXISTING SUBSTATION CHAIN LINK FENCE
 - PROPOSED SUBSTATION CHAIN LINK FENCE
 - EXISTING CONCRETE PANEL FENCE
 - PROPOSED CONCRETE PANEL FENCE
 - PROPOSED NON-CONDUCTIVE FENCE
 - - -94 - - - EXISTING MINOR CONTOUR
 - - -95 - - - EXISTING MAJOR CONTOUR
 - - -94 - - - PROPOSED CONTOUR
 - POWER POLE AND GUY WIRE
 - EXISTING FOUNDATION (REF ONLY)
 - PROPOSED FOUNDATION (REF ONLY)
 - CATCH BASIN, TYPE 1 (SEE DRAINAGE PLAN)
 - GRATE INLET (SEE DRAINAGE PLAN)
 - DRAINAGE PIPE (SEE DRAINAGE PLAN)
 - EXISTING VAULT
 - ▨ PROPOSED CONCRETE CURB CUT AND SIDEWALK
 - PROPOSED ASPHALT DRIVEWAY

- TOPO LEGEND**
- ⊗ WM WATER METER
 - ⊗ WV WATER VALVE
 - ⊗ CV IRRIGATION CONTROL VALVE
 - ⊗ FH FIRE HYDRANT
 - ⊗ S SIGN
 - ⊗ SSM SANITARY SEWER MANHOLE
 - 95--- MAJOR CONTOUR
 - 96--- MINOR CONTOUR
 - OP--- OVERHEAD POWER LINE
 - OT--- OVERHEAD TELEPHONE LINE
 - SS--- SANITARY SEWER LINE
 - G--- NATURAL GAS LINE
 - W--- WATER LINE
 - VEGETATION/TREE LINE

- REFERENCE DRAWINGS**
- D-21030 SITE PLAN AND GENERAL NOTES
 - D-21032 TEMPORARY EROSION/SEDIMENT CONTROL PLAN
 - D-21034 DRAINAGE PLAN
 - D-3306 FOUNDATION PLAN
 - D-3326 STRUCTURAL PLAN

60% DESIGN
NOT FOR CONSTRUCTION

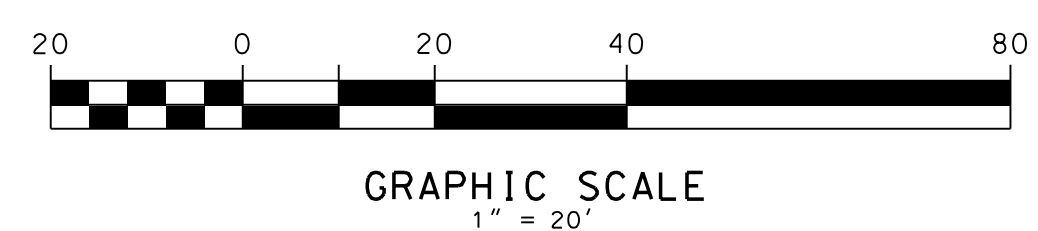

THIS DRAWING PARTIALLY SUPERSEDES D-3307		CITY PROJECT NO:	
WD NUMBER: 111023608		GRADING AND FENCING PLAN LYNDEN SUBSTATION	
REVISION DESCRIPTION: REVISED PER LYNDEN TRC COMMENTS			
CADD	J. Nelson	PUGET SOUND ENERGY	ENGINEERING DEPARTMENT
ENGINEER			DRAWING NO D-21033
REVIEWED			REV NO 2
APPROVED	J. HENRY	SCALE: 1"=20'-0"	CLASS: SITE
		CADD NO: D-21033_01.dgn	FILE NO: CODE: LYN

INTERNAL USE

USER: j.r.nel 2:52:49 PM 8/17/2022