


8/17/2022 2:56:49 PM USER: jlnels

E
D
C
B
A

TOPO LEGEND

- WM WATER METER
WV WATER VALVE
ICV INTERVAL CONTROL VALVE
FH FIRE HYDRANT
S SIGN
SMM SANITARY SEWER MANHOLE
-95- MAJOR CONTOUR
-94- MINOR CONTOUR
OP OVERHEAD POWER LINE
OT OVERHEAD TELEPHONE LINE
SS SANITARY SEWER LINE
G NATURAL GAS LINE
W WATER LINE
VEGETATION/TREE LINE

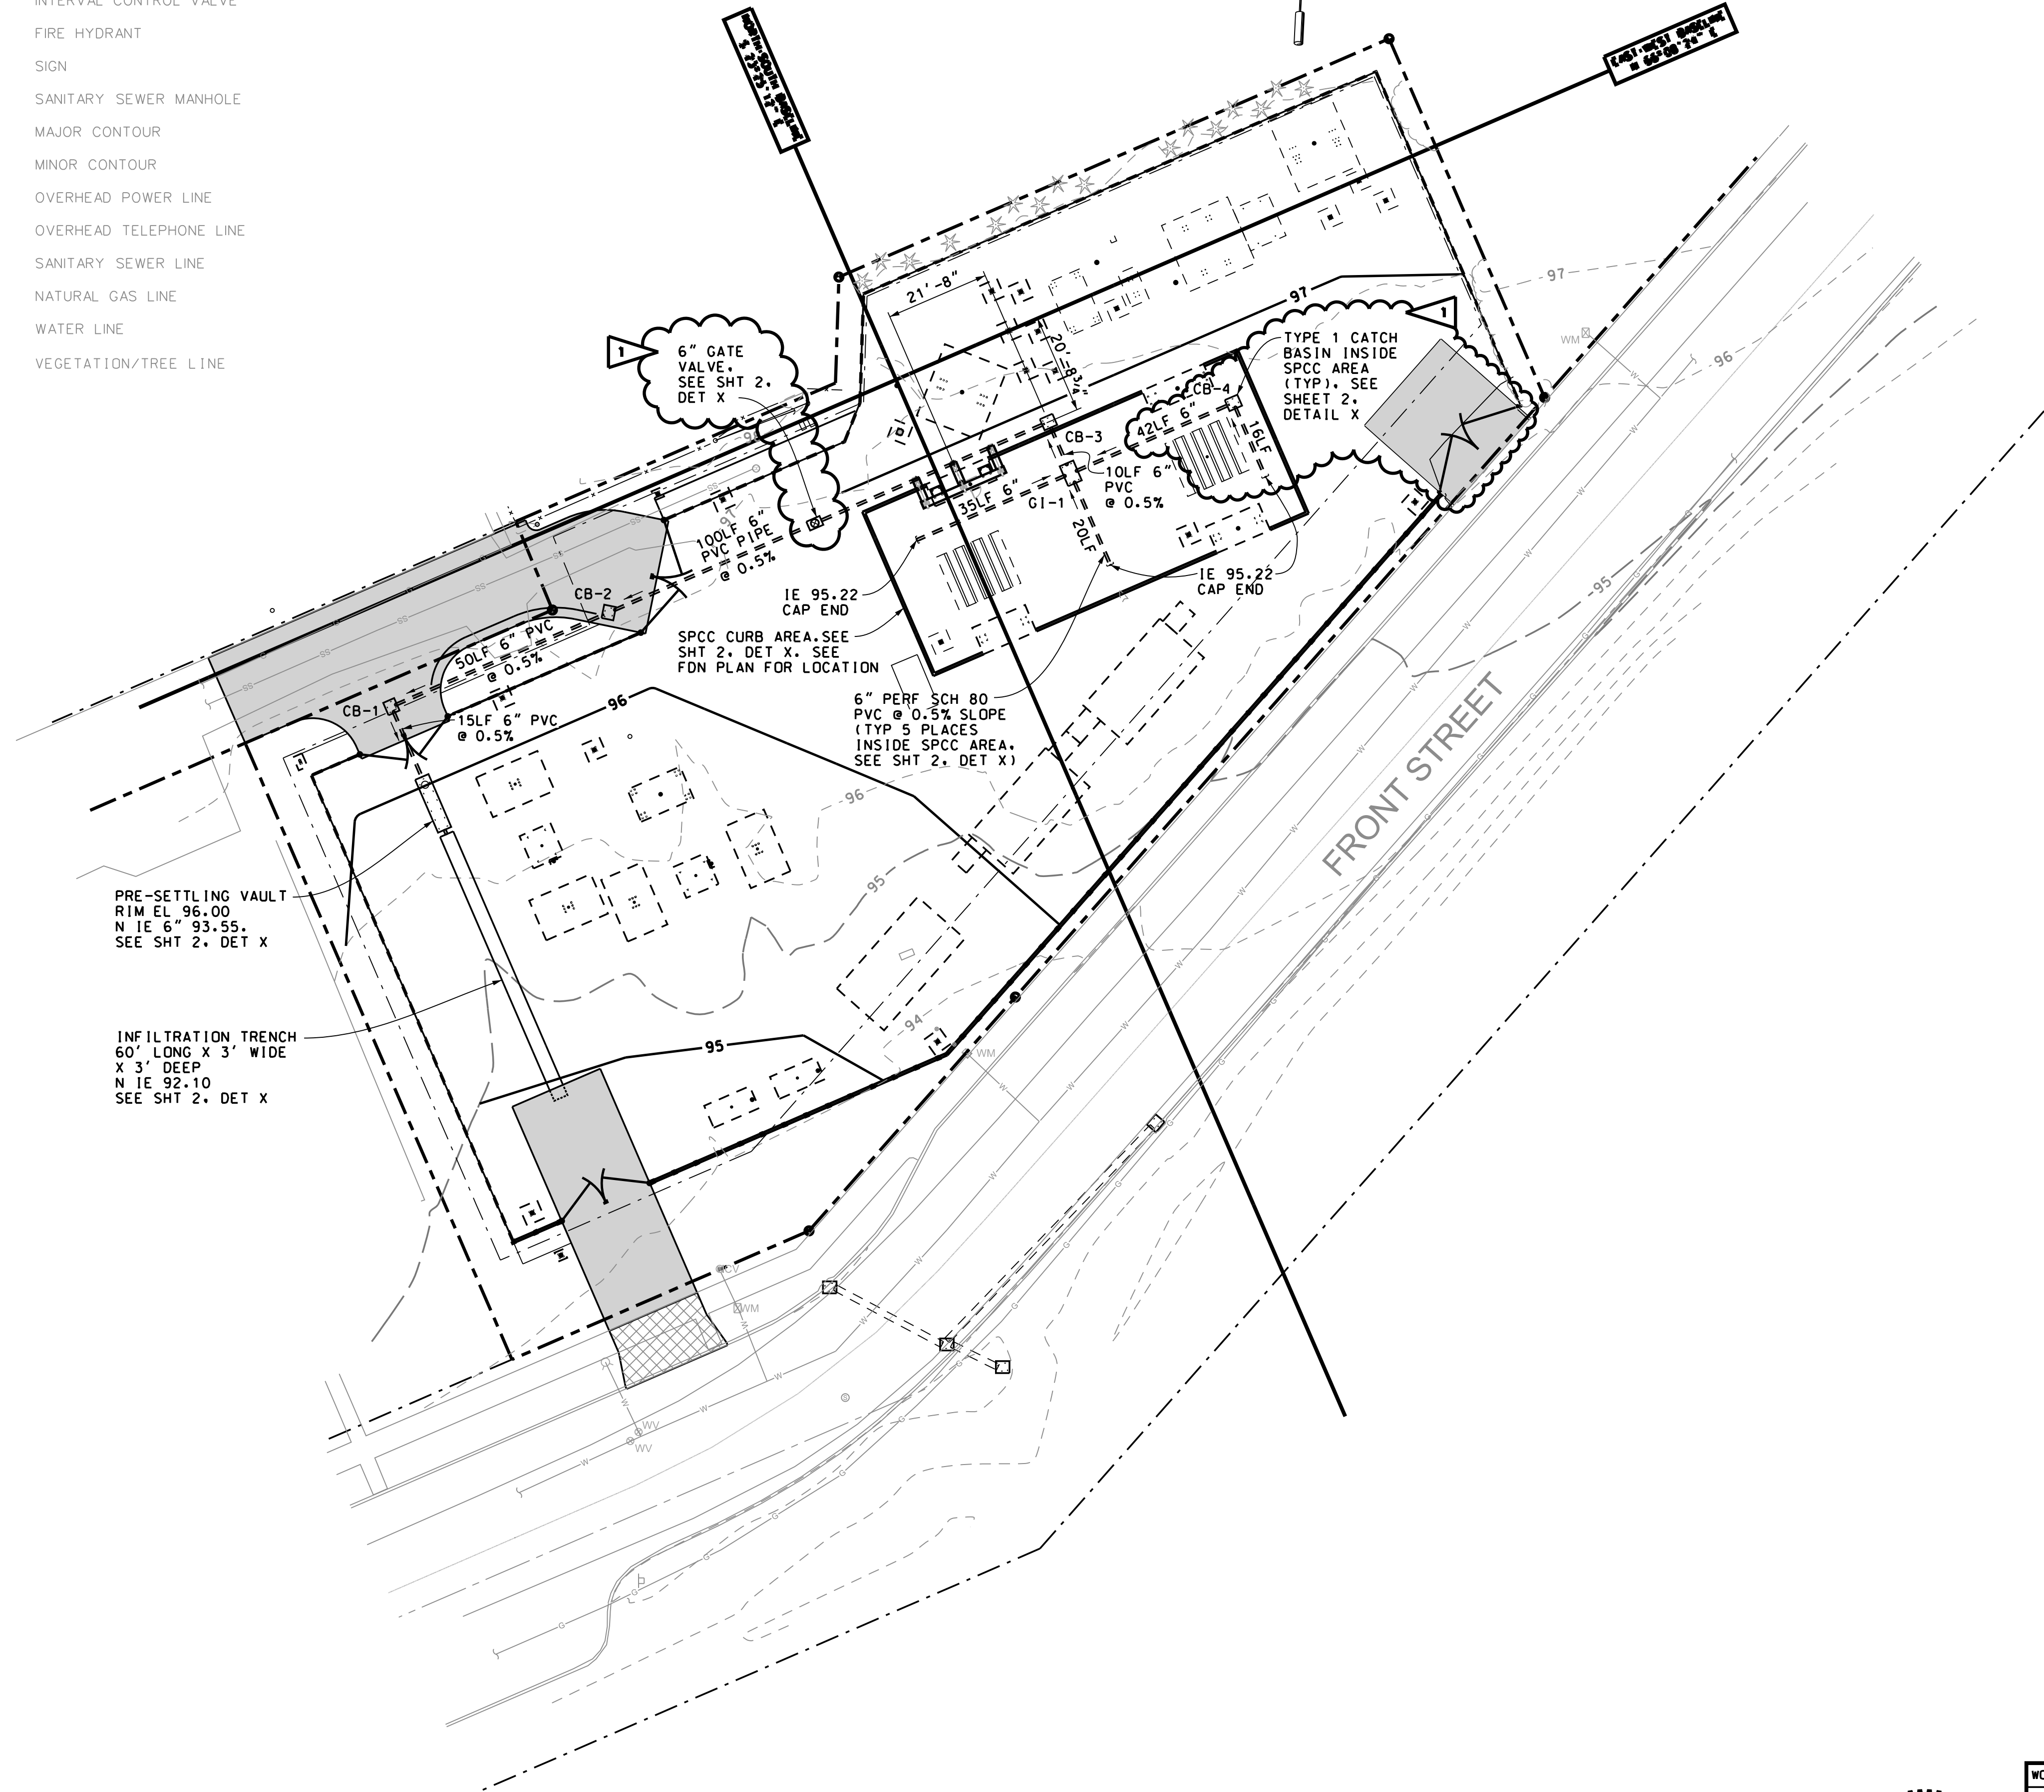

LEGEND

- PROPERTY LINE
--- EXISTING SUBSTATION CHAIN LINK FENCE
--- PROPOSED SUBSTATION CHAIN LINK FENCE
--- EXISTING CONCRETE PANEL FENCE
--- PROPOSED CONCRETE PANEL FENCE
--- PROPOSED NON-CONDUCTIVE FENCE
-95- EXISTING MAJOR CONTOUR
-94- EXISTING MINOR CONTOUR
-94- PROPOSED CONTOUR
[Hatched Box] PROPOSED ASPHALT DRIVEWAY
[Solid Grey Box] PROPOSED ENTRANCE DRIVEWAY
[Square with X] EXISTING CATCH BASIN, TYPE 1
[Square with Grid] PROPOSED CATCH BASIN, TYPE 1
[Square with Circle] GRATE INLET
[Square with X] GATE VALVE
===== EXISTING DRAINAGE PIPE
===== PROPOSED DRAINAGE PIPE
[Dashed Box] EXISTING FOUNDATION
[Dashed Box] PROPOSED FOUNDATION
[Solid Box] EXISTING VAULT


CATCH BASIN SCHEDULE

1	CB-1 TYPE 1 RIM EL 96.40 S- IE 6" 93.62 E- IE 6" 93.72	CB-2 TYPE 1 RIM EL 97.00 W- IE 6" 94.00 E- IE 6" 93.90	GI-1 RIM EL 96.72 N- IE 6" 94.69 E- IE 6" 95.12 S- IE 6" 95.05 W- IE 6" 94.83
	CB-3 TYPE 1 RIM EL 96.72 S- IE 6" 94.64 W- IE 6" 94.54	CB-4 TYPE 1 RIM EL 96.72 S- IE 6" 95.14 E- IE 6" 95.04	

REFERENCE DRAWINGS

- D-21030 SITE PLAN AND GENERAL NOTES
D-21032 TEMPORARY EROSION/SEDIMENT CONTROL PLAN
D-21033 GRADING AND FENCING PLAN
D-3306 FOUNDATION PLAN
D-3326 STRUCTURAL PLAN

60% DESIGN
NOT FOR CONSTRUCTION

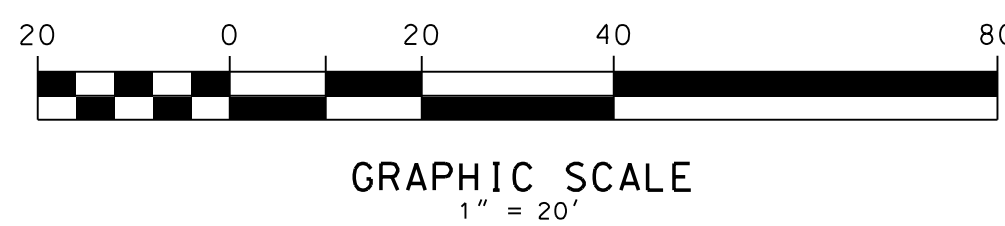

WD NUMBER: 111023608		CITY PROJECT NO:	
REVISION DESCRIPTION: REVISED PER LYNDEN TRC COMMENTS		DRAINAGE PLAN LYNDEN SUBSTATION	
CADD	J. Nelson	DATE	2022.08.18 15:03:47-0700
ENGINEER			
REVIEWED			
APPROVED	J. HENRY	DATE	2022.08.18 14:53:51-0700
PSE PUGET SOUND ENERGY		SUBSTATION ENGINEERING DEPARTMENT	DRAWING NO D-21034 SHEET: 01 OF 03
SCALE: 1"=20'-0"		CLASS: SITE	FILE NO: CODE: LYN
CADD NO: D-21034_01.dgn		REV NO 1	



INTERNAL USE