

FOOD SERVICE PLAN REVIEW APPROVED

Reviewer Ogden Date 9/29/2015

Plans are in compliance subject to:


- 1) Connection to approved water and wastewater systems.
- 2) Compliance with applicable state and local codes.
- 3) Compliance with all provisos on specification worksheet.

See Comments on Specification Sheet

File# 287318

- 1) HAND SINK
- 2) THREE COMP SINK
- 3) REFRIGERATED SANDWICH UNIT
- 4) TRASH
- 5) REACH IN FREEZER
- 6) POS
- 8) ICE MACHINE
- 9) HAND SINK
- 11) PANINI GRILL
- 12) SMOOTHIE BLENDER
- 13) ICE CREAM FREEZER
- 14) SNEEZE GUARD GLASS DISPLAY
- 16) ESPRESSO MACHINE
- 17) MOP SINK
- 18) UNDER COUNTER FREEZER
- 19) WAFFLE MAKER
- 20) CONVECTION OVEN
- 22) ESPRESSO GRINDER
- 23) COFFEE GRINDER
- 24) COFFEE BREWER
- 25) ICE BIN
- 27) VENTLESS HOOD

EQUIPMENT SCHEDULE										PLUMBING SCHEDULE										ELECTRICAL SCHEDULE									
Item #	Qty	Equipment Category	Equipment Remarks	Size	Vol	Vol	Vol	Vol	Vol	Vol	Vol	Vol	Vol	Vol	Vol	Vol	Vol	Vol	Vol	Vol	Vol	Vol	Vol	Vol	Vol	Vol	Vol	Vol	Vol
1	1	HAND SINK	SHALL BE A 10" x 10" x 10"	10"	10"	10"	10"	10"	10"	10"	10"	10"	10"	10"	10"	10"	10"	10"	10"	10"	10"	10"	10"	10"	10"	10"	10"	10"	10"
2	1	THREE COMPARTMENT SINK		10"	10"	10"	10"	10"	10"	10"	10"	10"	10"	10"	10"	10"	10"	10"	10"	10"	10"	10"	10"	10"	10"	10"	10"	10"	10"
3	1	REFRIGERATED SANDWICH UNIT		10"	10"	10"	10"	10"	10"	10"	10"	10"	10"	10"	10"	10"	10"	10"	10"	10"	10"	10"	10"	10"	10"	10"	10"	10"	10"
4	1	TRASH		10"	10"	10"	10"	10"	10"	10"	10"	10"	10"	10"	10"	10"	10"	10"	10"	10"	10"	10"	10"	10"	10"	10"	10"	10"	10"
5	1	REACH IN FREEZER		10"	10"	10"	10"	10"	10"	10"	10"	10"	10"	10"	10"	10"	10"	10"	10"	10"	10"	10"	10"	10"	10"	10"	10"	10"	10"
6	1	POS		10"	10"	10"	10"	10"	10"	10"	10"	10"	10"	10"	10"	10"	10"	10"	10"	10"	10"	10"	10"	10"	10"	10"	10"	10"	10"
7	1	ICE MACHINE		10"	10"	10"	10"	10"	10"	10"	10"	10"	10"	10"	10"	10"	10"	10"	10"	10"	10"	10"	10"	10"	10"	10"	10"	10"	10"
8	1	HAND SINK		10"	10"	10"	10"	10"	10"	10"	10"	10"	10"	10"	10"	10"	10"	10"	10"	10"	10"	10"	10"	10"	10"	10"	10"	10"	10"
9	1	ICE MACHINE		10"	10"	10"	10"	10"	10"	10"	10"	10"	10"	10"	10"	10"	10"	10"	10"	10"	10"	10"	10"	10"	10"	10"	10"	10"	10"
10	1	ICE MACHINE		10"	10"	10"	10"	10"	10"	10"	10"	10"	10"	10"	10"	10"	10"	10"	10"	10"	10"	10"	10"	10"	10"	10"	10"	10"	10"
11	1	PANINI GRILL		10"	10"	10"	10"	10"	10"	10"	10"	10"	10"	10"	10"	10"	10"	10"	10"	10"	10"	10"	10"	10"	10"	10"	10"	10"	10"
12	1	SMOOTHIE BLENDER		10"	10"	10"	10"	10"	10"	10"	10"	10"	10"	10"	10"	10"	10"	10"	10"	10"	10"	10"	10"	10"	10"	10"	10"	10"	10"
13	1	ICE CREAM FREEZER		10"	10"	10"	10"	10"	10"	10"	10"	10"	10"	10"	10"	10"	10"	10"	10"	10"	10"	10"	10"	10"	10"	10"	10"	10"	10"
14	1	SNEEZE GUARD GLASS DISPLAY CASE		10"	10"	10"	10"	10"	10"	10"	10"	10"	10"	10"	10"	10"	10"	10"	10"	10"	10"	10"	10"	10"	10"	10"	10"	10"	10"
15	1	ESPRESSO MACHINE		10"	10"	10"	10"	10"	10"	10"	10"	10"	10"	10"	10"	10"	10"	10"	10"	10"	10"	10"	10"	10"	10"	10"	10"	10"	10"
16	1	MOP SINK		10"	10"	10"	10"	10"	10"	10"	10"	10"	10"	10"	10"	10"	10"	10"	10"	10"	10"	10"	10"	10"	10"	10"	10"	10"	10"
17	1	CONVECTION OVEN		10"	10"	10"	10"	10"	10"	10"	10"	10"	10"	10"	10"	10"	10"	10"	10"	10"	10"	10"	10"	10"	10"	10"	10"	10"	10"
18	1	ESPRESSO GRINDER		10"	10"	10"	10"	10"	10"	10"	10"	10"	10"	10"	10"	10"	10"	10"	10"	10"	10"	10"	10"	10"	10"	10"	10"	10"	10"
19	1	COFFEE GRINDER		10"	10"	10"	10"	10"	10"	10"	10"	10"	10"	10"	10"	10"	10"	10"	10"	10"	10"	10"	10"	10"	10"	10"	10"	10"	10"
20	1	COFFEE BREWER		10"	10"	10"	10"	10"	10"	10"	10"	10"	10"	10"	10"	10"	10"	10"	10"	10"	10"	10"	10"	10"	10"	10"	10"	10"	10"
21	1	ICE BIN		10"	10"	10"	10"	10"	10"	10"	10"	10"	10"	10"	10"	10"	10"	10"	10"	10"	10"	10"	10"	10"	10"	10"	10"	10"	10"
22	1	VENTLESS HOOD		10"	10"	10"	10"	10"	10"	10"	10"	10"	10"	10"	10"	10"	10"	10"	10"	10"	10"	10"	10"	10"	10"	10"	10"	10"	10"

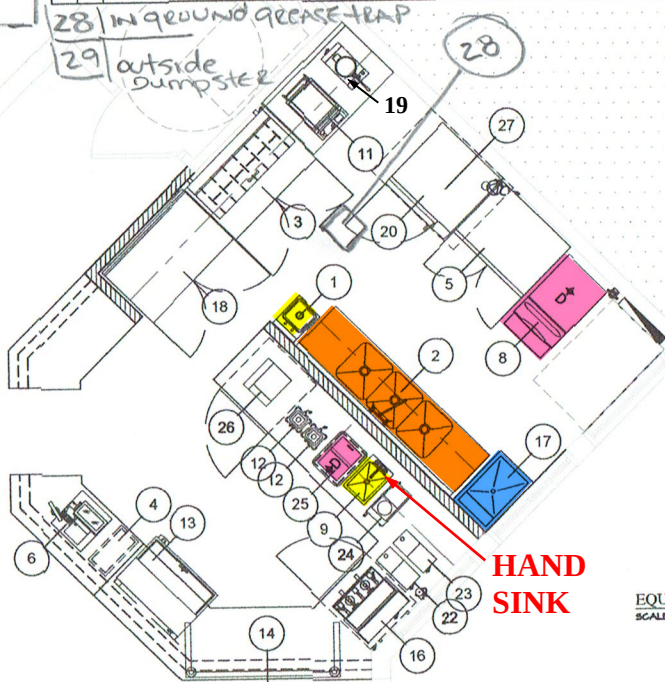

EQUIPMENT PLAN
SCALE: 1/2" = 1'-0"

4 TO THE BEST OF THE ARCHITECT'S OR ENGINEER'S KNOWLEDGE AND BELIEF, THESE PLANS AND SPECIFICATIONS COMPLY WITH THE 2010 FLORIDA BUILDING CODE.

4 THE DRAWINGS & DESIGN ARE VALID FOR 6 MONTHS FROM DATE OF BEING SEALED.

4 TO THE BEST OF THE ARCHITECT'S OR ENGINEER'S KNOWLEDGE AND BELIEF, THESE PLANS AND SPECIFICATIONS COMPLY WITH THE APPLICABLE MINIMUM BUILDING CODES AND THE APPLICABLE 1994/2011 FIRE SAFETY STANDARDS.

ALL DIMENSIONS AND JOBS CONDITIONS SHALL BE VERIFIED BY THE CONTRACTOR AND ALL DISCREPANCIES SHALL BE REPORTED TO THE ARCHITECT PRIOR TO COMMENCEMENT OF CONSTRUCTION.

DATE	BY
09/29/15	OG
09/29/15	OG
09/29/15	OG
09/29/15	OG
09/29/15	OG

ALL DIMENSIONS AND JOBS CONDITIONS SHALL BE VERIFIED BY THE CONTRACTOR AND ALL DISCREPANCIES SHALL BE REPORTED TO THE ARCHITECT PRIOR TO COMMENCEMENT OF CONSTRUCTION.

1538.00
An Interior Renovation for:
SWEET BREWNETTE
13999 GULF BLVD., SUITE C-2
MADEIRA BEACH, FL



FRAZE
design
1750 CENTRAL AVENUE
ST. PETERSBURG, FL 33705
PHONE: 727.728-5608
FAX: 727.728-5609

SUBMIT TITLE
EQUIPMENT PLAN
SUBMIT NUMBER
A-5

SQUARE FOOTAGE CALCULATIONS:
 SQUARE FOOTAGE UNDER IMPROVEMENT 1236.58 SF
 EXIST. REQUIREMENTS:
 MAXIMUM TRAVEL DISTANCE TO EXIT (SERVICABLE) - 200'-0" FROM ANY POINT


TOTAL SQUARE FOOTAGE OF SEATING AREA 645.51' DIVIDED BY NET/SQ. FT PER OCCUPANCY 15 = 43 TOTAL NUMBER OF PEOPLE IN DINING AREA
 TOTAL SQUARE FOOTAGE EMPLOYEE AREA 525.51' DIVIDED BY NET/SQ. FT PER OCCUPANCY 100 = 6 TOTAL NUMBER OF EMPLOYEES

TOTAL OCCUPANCY LOAD 49
 HALF OF OCCUPANCY LOAD = 25 THESE EXPRESS WIDTH PER OCCUPANT SERVED (2) = 9"
 EXPRESS WIDTH PROVIDED = 64"

FIRE CODES
 TOTAL SQUARE FOOTAGE MENA/ANTILE AREA 1236.51' DIVIDED BY NET/SQ. FT PER OCCUPANCY 30 = 42 TOTAL NUMBER OF PEOPLE
 TOTAL OCCUPANCY LOAD 42

SEATING CHART	
NUMBER OF SEATS AT TABLES SHOWN (RINGS)	50 SEATS
NUMBER OF ACCESSIBLE SEATS REQUIRED	1 SEAT
NUMBER OF ACCESSIBLE SEATS SHOWN	2 SEATS

FIXTURE COUNT SUMMARY	
TOTAL NUMBER OF OCCUPANCY	49
NUMBER OF FIXTURES REQUIRED	1
NUMBER OF FIXTURES PROVIDED	1 (8 USED)

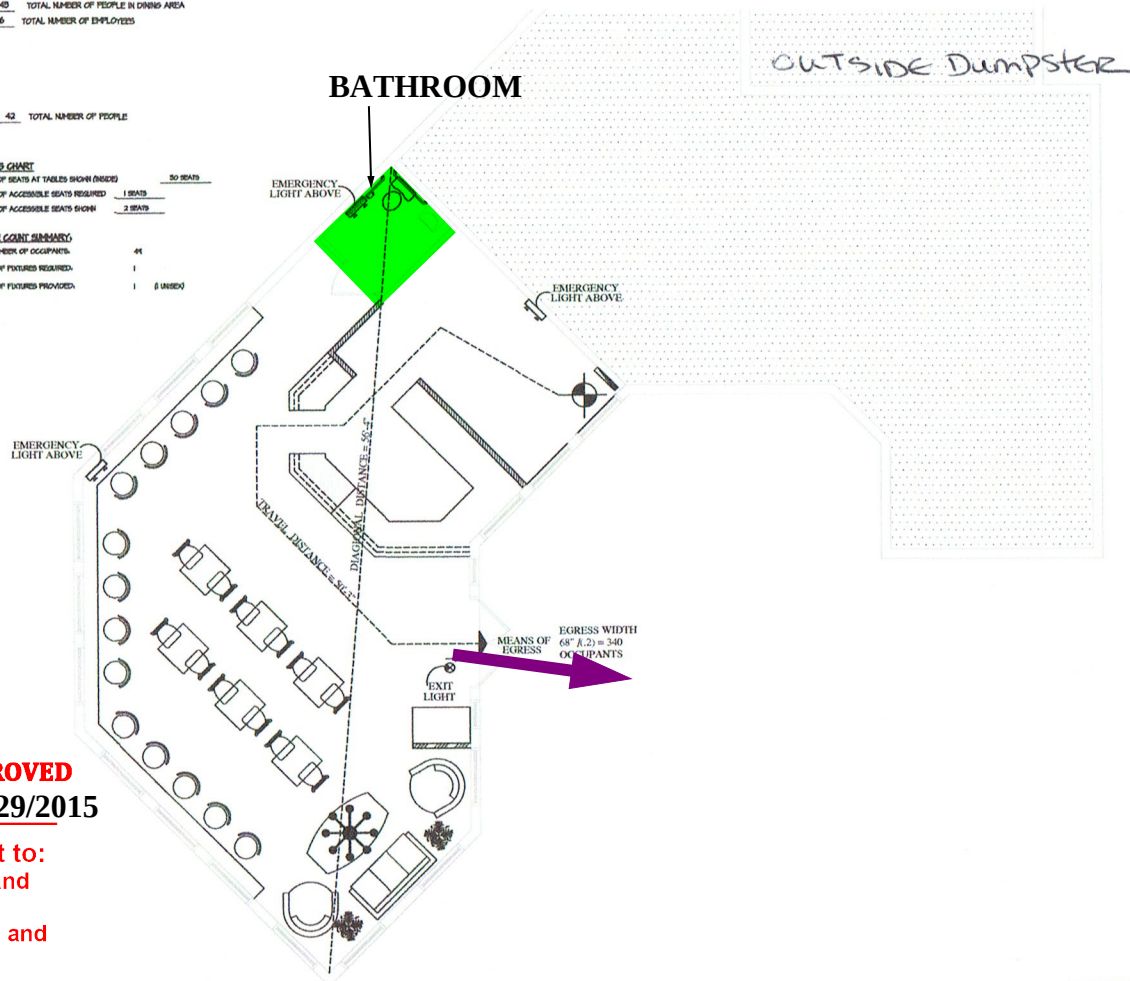

FOOD SERVICE PLAN REVIEW APPROVED

Reviewer g.m.f. Date 9/29/2015

Plans are in compliance subject to:

- 1) Connection to approved water and wastewater systems.
- 2) Compliance with applicable state and local codes.
- 3) Compliance with all provisos on specification worksheet.

See Comments on Specification Sheet

File# 287318


LIFE SAFETY PLAN
 SCALE: 1/4" = 1'-0"



DATE	BY:
REVISED 09/24/15	
PERMIT 09/24/15	
REV.	
REV.	
REV.	

THIS CONTRACT, DRAWING, SPECIFICATIONS AND PERMITS ARE SUBJECT TO THE CITY OF PETERSBURG'S POLICY ON THE USE OF PERMITS. THE CITY OF PETERSBURG SHALL NOT BE RESPONSIBLE FOR THE DESIGN OR CONSTRUCTION OF THE PROJECT. THE CITY OF PETERSBURG SHALL NOT BE RESPONSIBLE FOR THE DESIGN OR CONSTRUCTION OF THE PROJECT.

FOR: 1556.00
 An Interior Renovation for:
SWEET BREWNETTE
 13999 GULF BLVD., SUITE C-2
 MADEIRA BEACH, FL

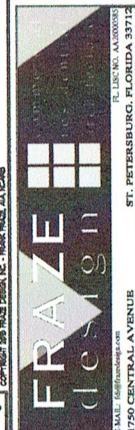

TO THE BEST OF THE ARCHITECT OR ENGINEER'S KNOWLEDGE AND BELIEF, THESE PLANS AND SPECIFICATIONS COMPLY WITH THE 2010 FLORIDA BUILDING CODE.

THE DRAWINGS & DESIGN ARE VALID FOR 12 MONTHS FROM DATE OF BEING SEALED.

TO THE BEST OF THE ARCHITECT OR ENGINEER'S KNOWLEDGE AND BELIEF, THESE PLANS AND SPECIFICATIONS COMPLY WITH THE APPLICABLE FLORIDA BUILDING CODES AND THE APPLICABLE FLORIDA FIRE SAFETY STANDARDS.

ALL DIMENSIONS AND JOBS CONDITIONS SHALL BE VERIFIED BY THE CONTRACTOR. ANY AND ALL DISCREPANCIES SHALL BE REPORTED TO THE ARCHITECT PRIOR TO COMMENCEMENT OF CONSTRUCTION.

SHEET TITLE
 LIFE SAFETY PLAN

SHEET NUMBER

LS-1