
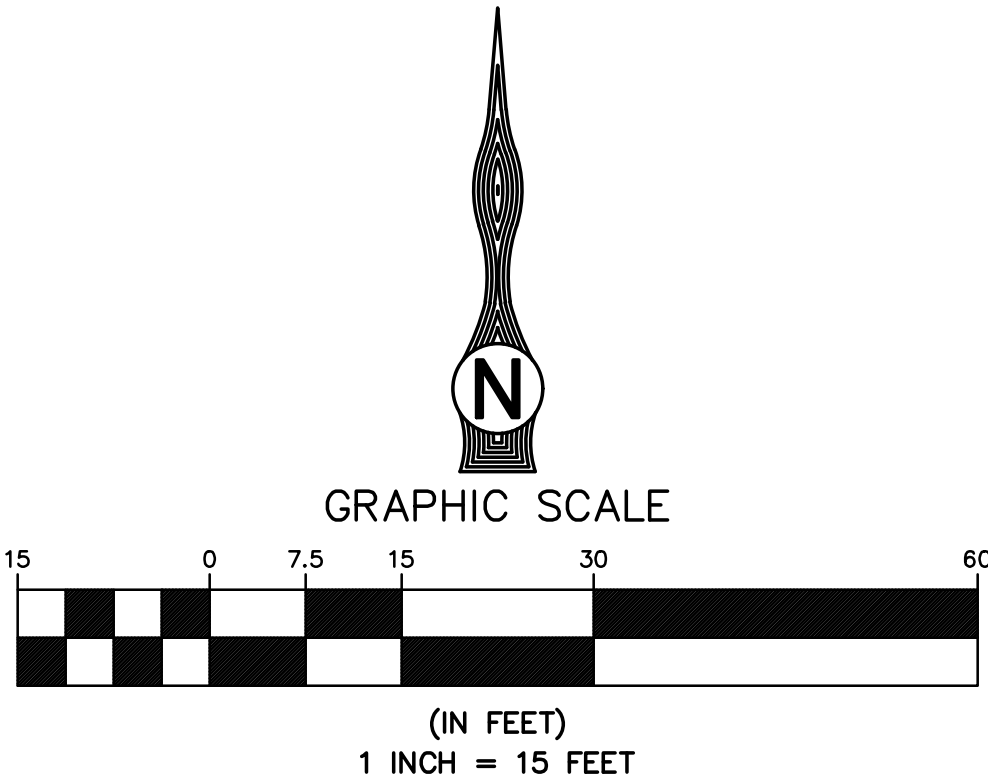


CALIFORNIA AVENUE

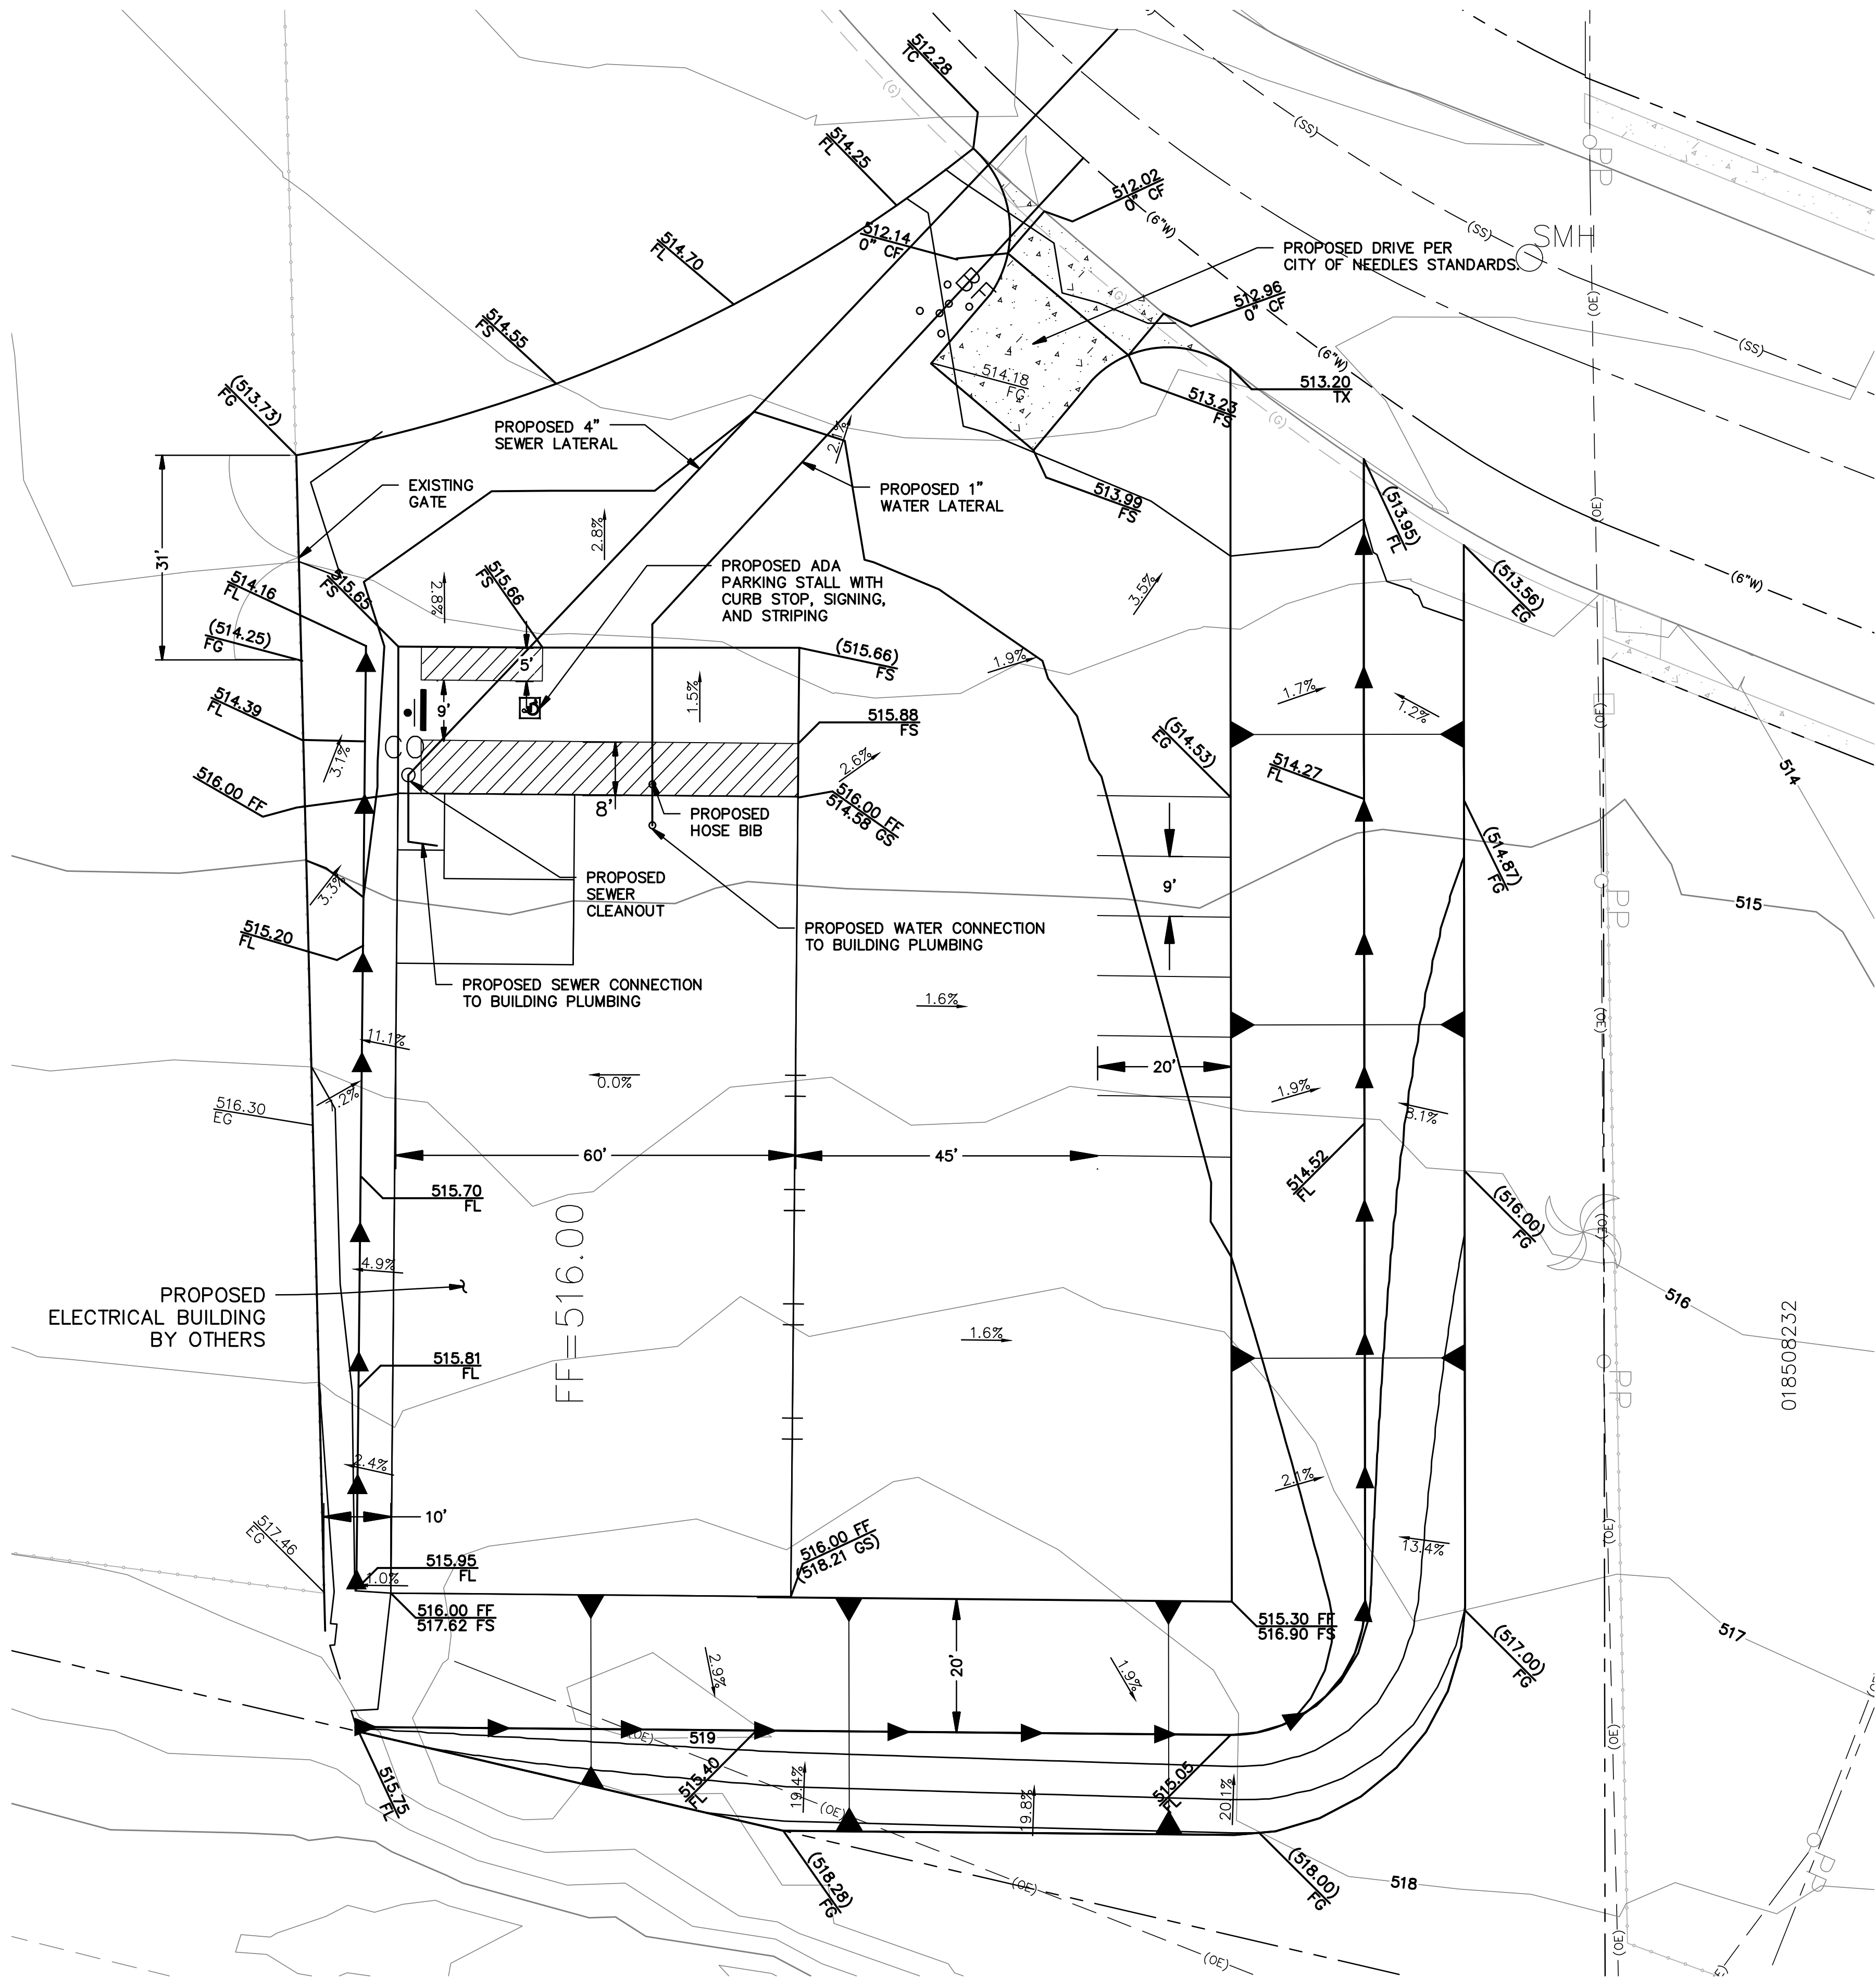

Underground Service Alert

Call: TOLL FREE 1-800 227-2600

TWO WORKING DAYS BEFORE YOU DIG

BASIS OF BEARINGS:
E OF BALBOA PLACE, FORMERLY HIGHWAY 66, BEARING
N28°27'40\"/>

REVISIONS					
MARK	DATE	INITIAL	DESCRIPTION	DATE	APP'D

CITY OF NEEDLES

APPROVED FOR CONSTRUCTION:

STEVEN W. LEDBETTER R.C.E. 84044 EXP. DATE 9-30-25



TKE ENGINEERING

TKE ENGINEERING, INC.
2305 CHICAGO AVENUE
RIVERSIDE, CA 92507
(951) 680-0440
(951) 680-0490 FAX

STEVEN W. LEDBETTER R.C.E. No. 84044
EXPIRES: 9-30-25

DRAWN BY:	AM
DESIGNED BY:	SL
CHECKED BY:	SL
RECOMMENDED BY:	

CITY OF NEEDLES

PROPOSED ELECTRICAL YARD
GRADING AND SITE PLAN
JANUARY 16, 2025

SHEET OF 1