


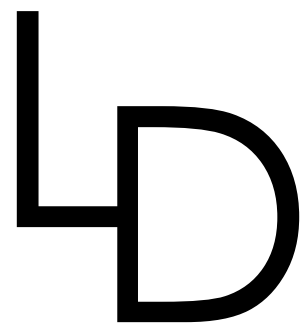

lofties
design

467 COLLEGE AVE
NORMAN, OK
PROPOSED ADU

SQUARE FOOTAGE


650 SQ FT
TOTAL UNDER ROOF

642 SQ FT
8 SQ FT

LIVING FRAME:
MECH CLOSET


FOUNDATION/
FLOOR PLAN/
ELECTRICAL

A101

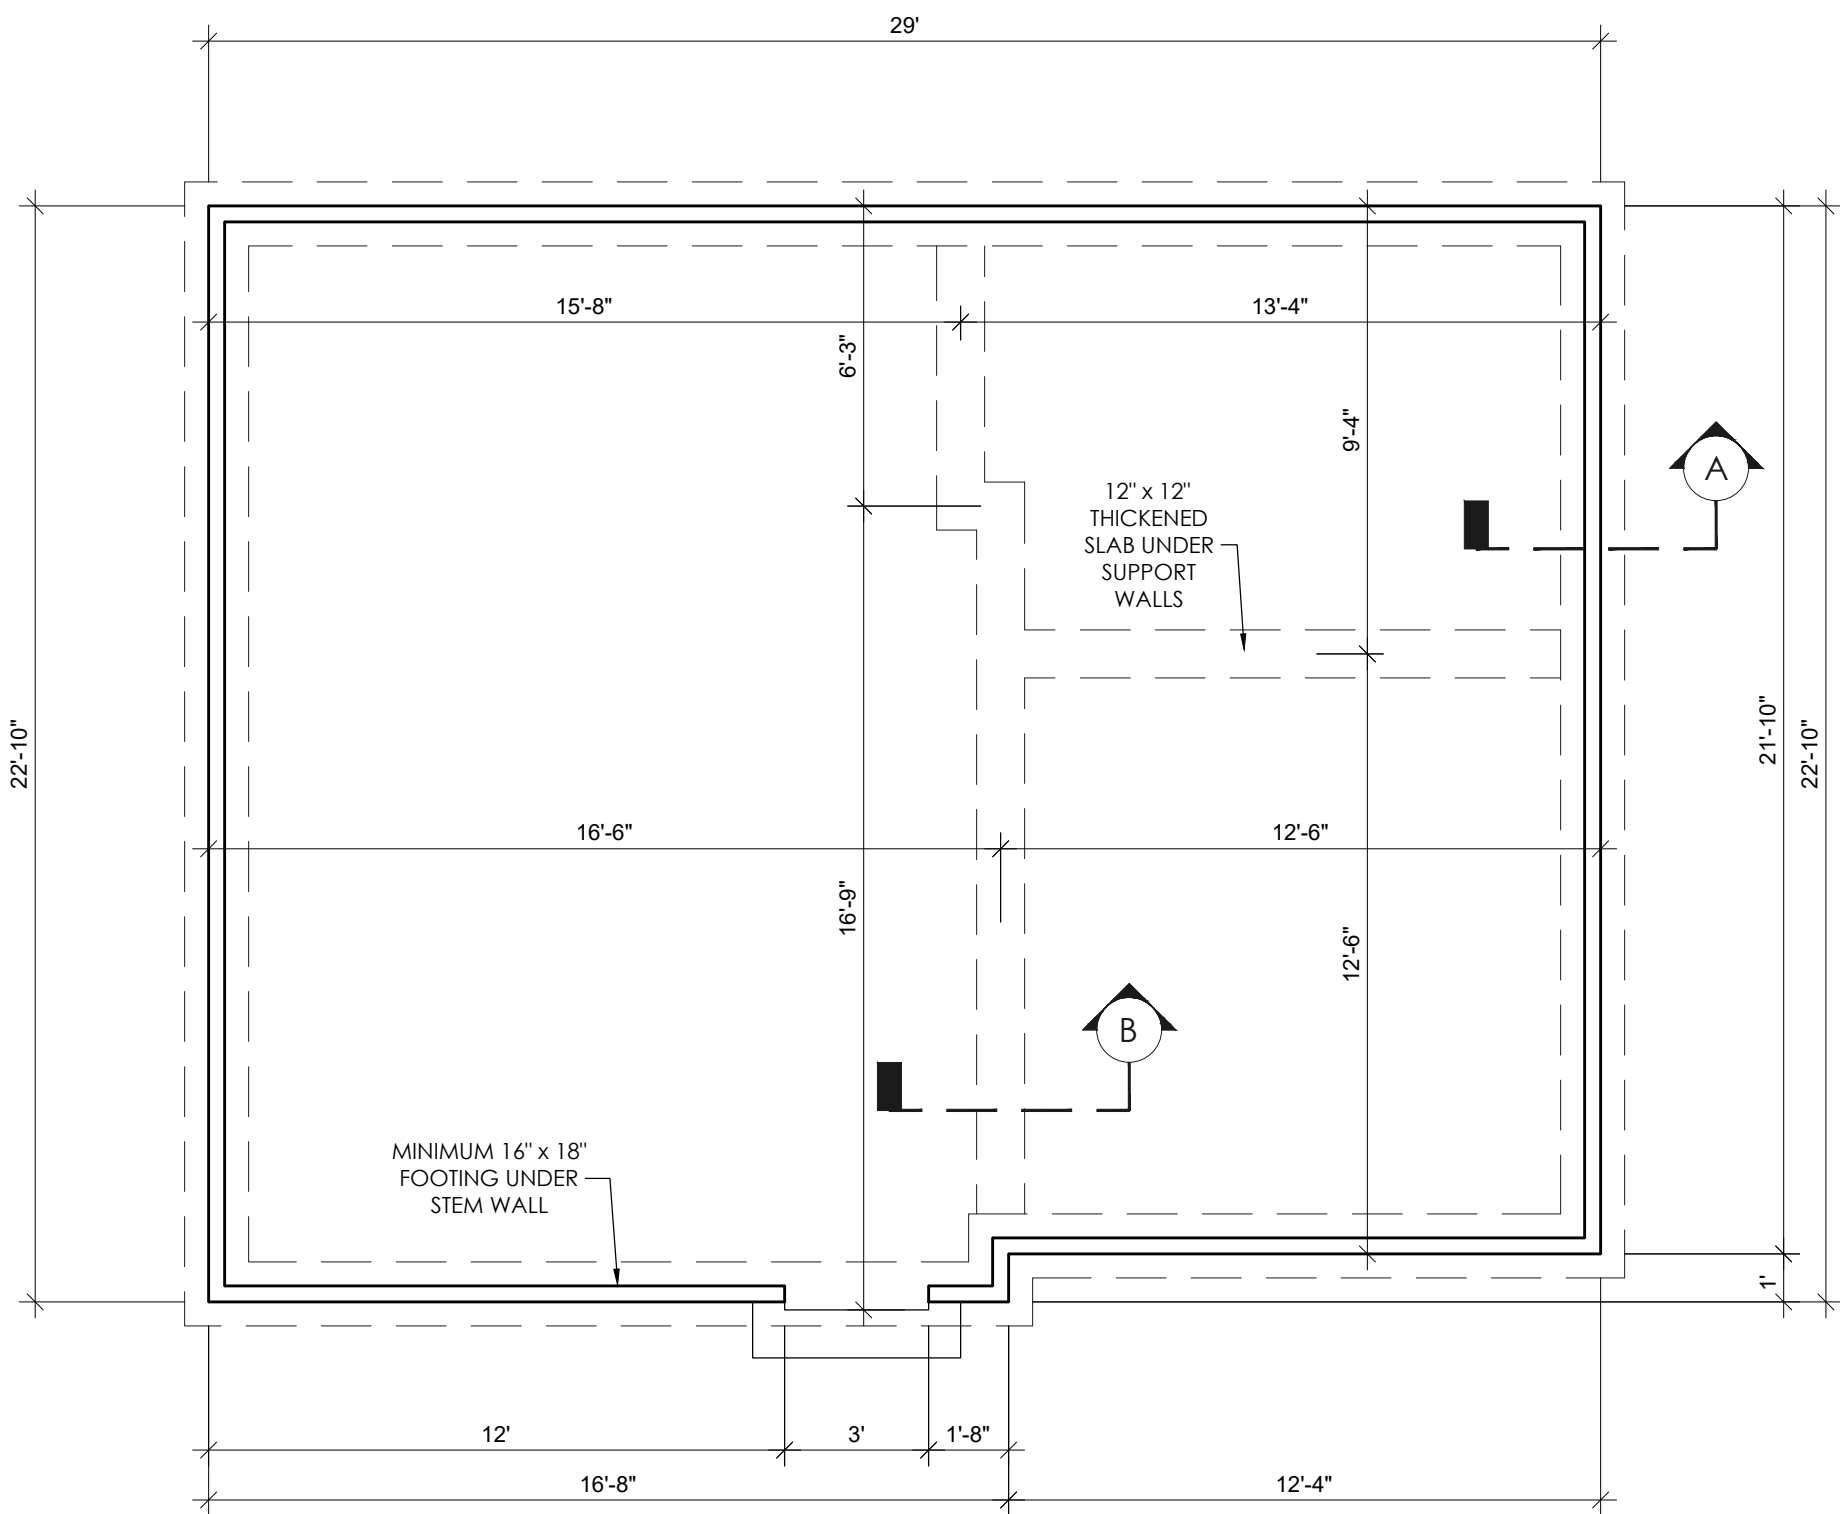


1

FOUNDATION
SCALE: 1/4" = 1'-0"

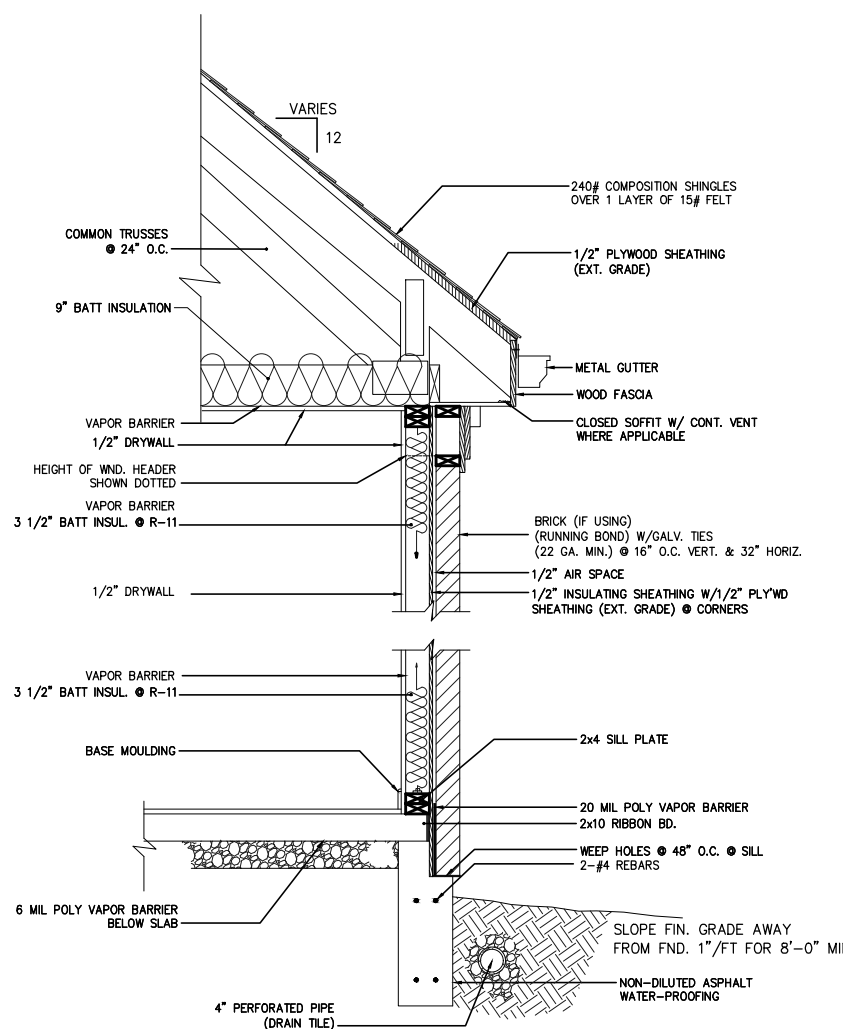

D


TYPICAL WALL SECTION
NTS

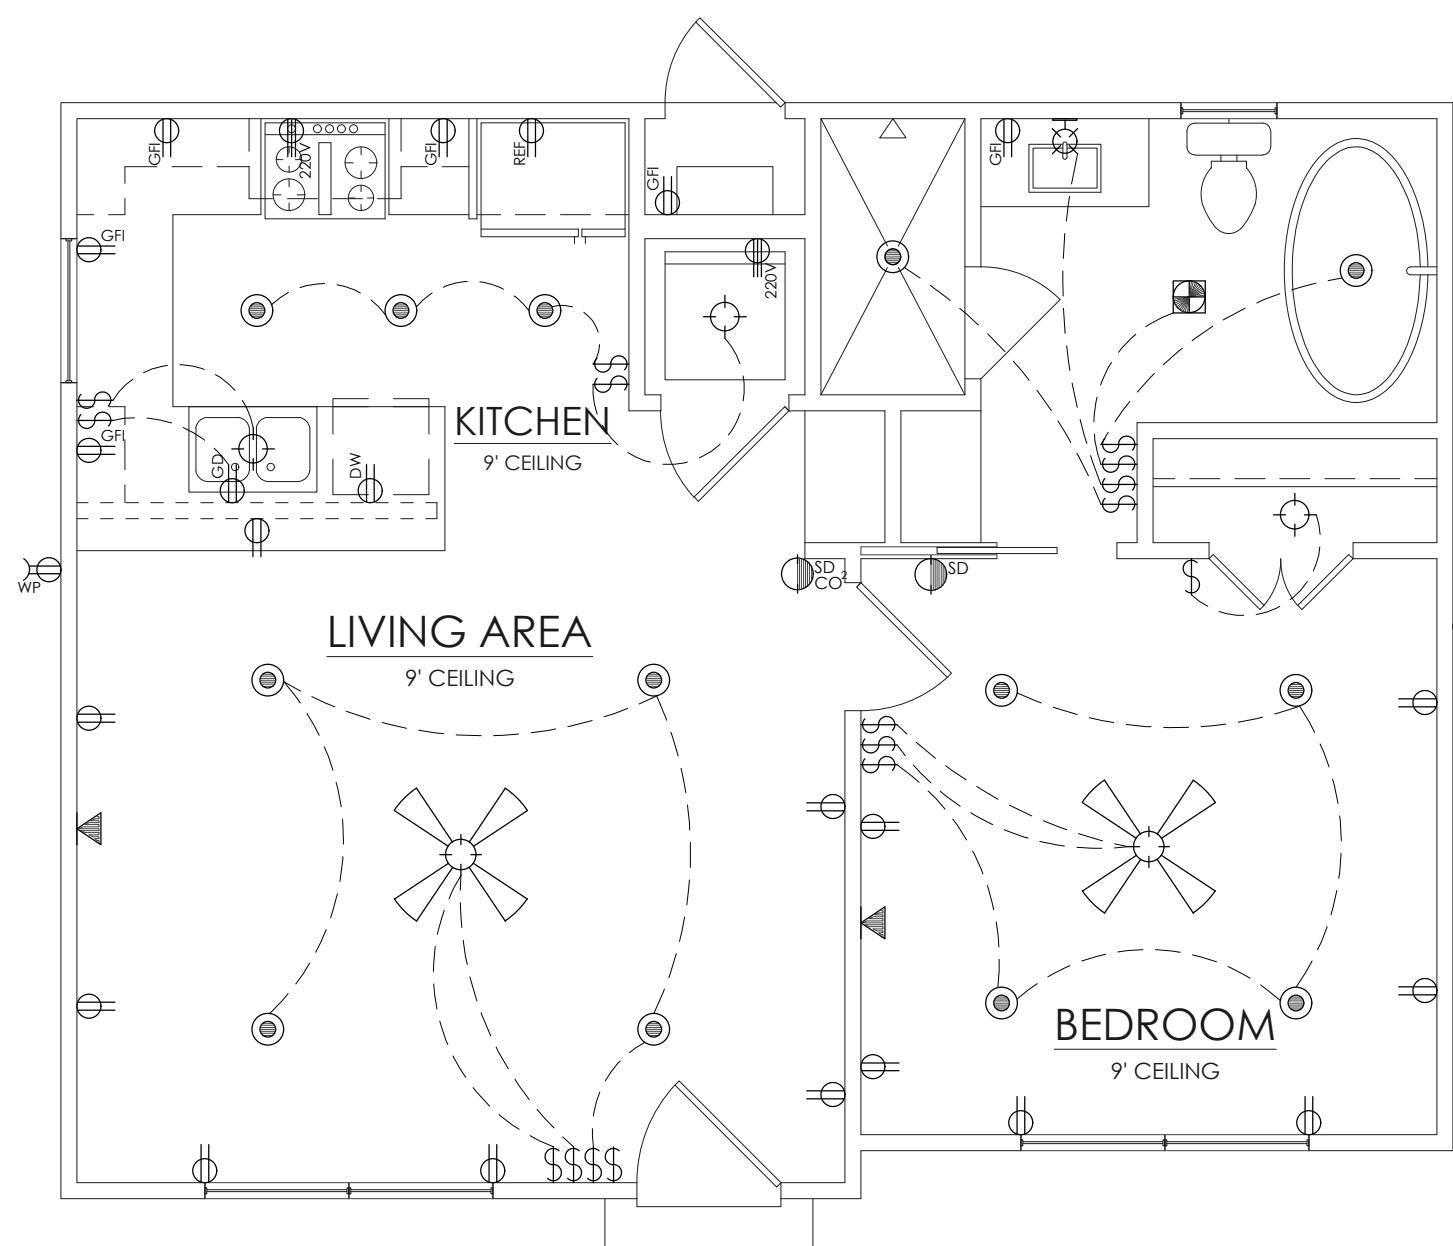

3


ELECTRICAL
SCALE: 1/4" = 1'-0"

ELECTRICAL/LIGHTING SYMBOLS	
	110V DUPLEX OUTLET
	110V GROUND FAULT INTERCEPTOR
	110V WEATHER PROOF-NO FAULT
	220V DUPLEX OUTLET
	CEILING MOUNTED OUTLET
	PHONE/CABLE
	BATHROOM EXHAUST VENT, HEATER, & LIGHT
	RECESSED CAN LIGHT
	BRACKET LIGHT
	CEILING FAN W/ LIGHT KIT
	WALL MOUNTED LIGHT
	SINGLE PHASE SWITCH
	SMOKE DETECTOR
	SMOKE AND CARBON MONOXIDE DETECTOR

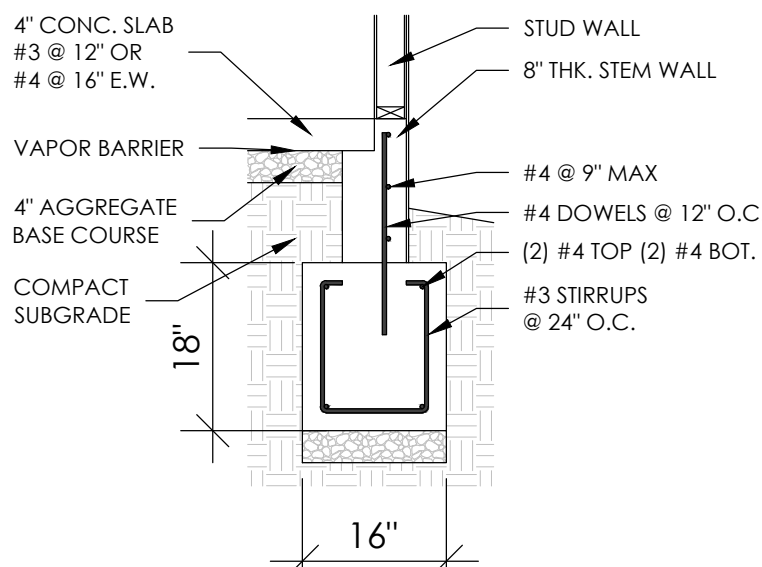


A

RESIDENTIAL EXTERNAL FOOTING
NTS

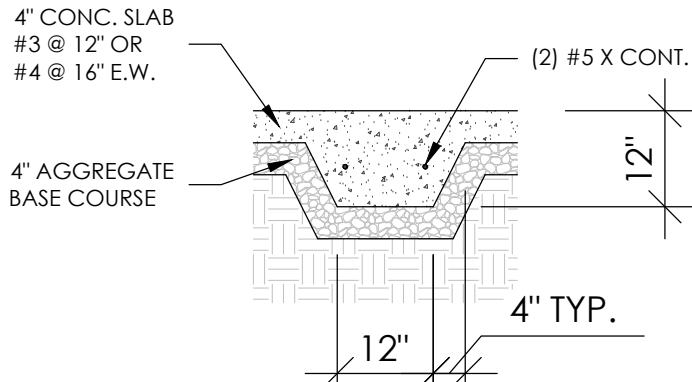


B

THICKENED SLAB, TYP.
NTS

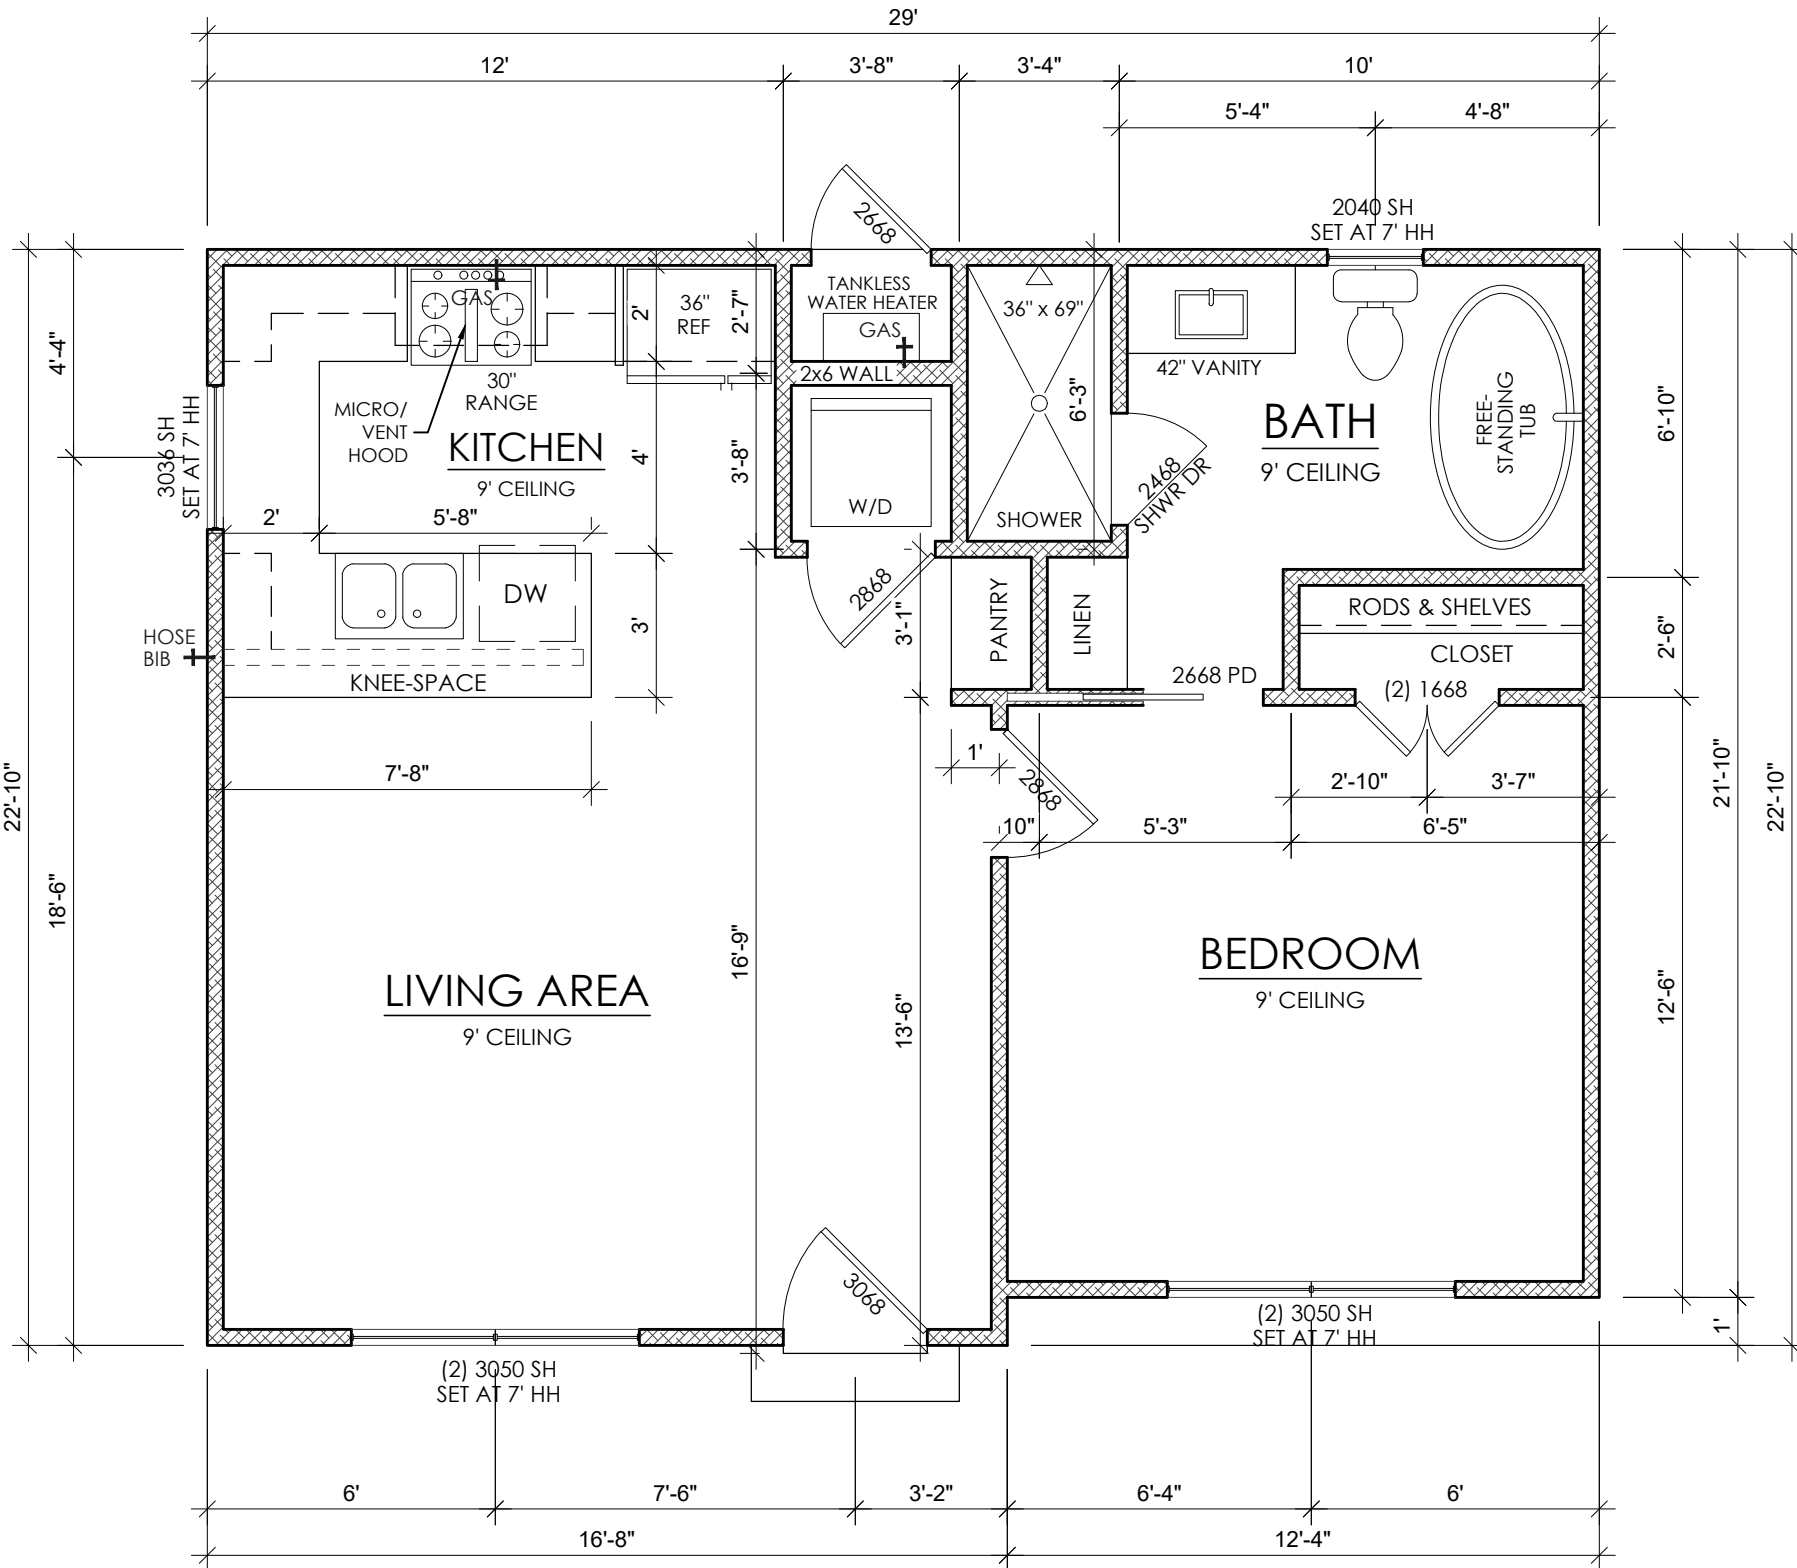

2

FLOOR PLAN
SCALE: 1/4" = 1'-0"

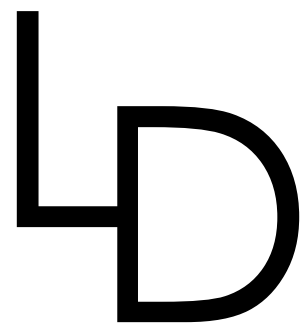

lofties
design

467 COLLEGE AVE
NORMAN, OK
PROPOSED ADU

SQUARE FOOTAGE


650 SQ FT
TOTAL UNDER ROOF

642 SQ FT
8 SQ FT


LIVING FRAME:
MECH CLOSET

ELEVATIONS/
ROOF PLAN

A102

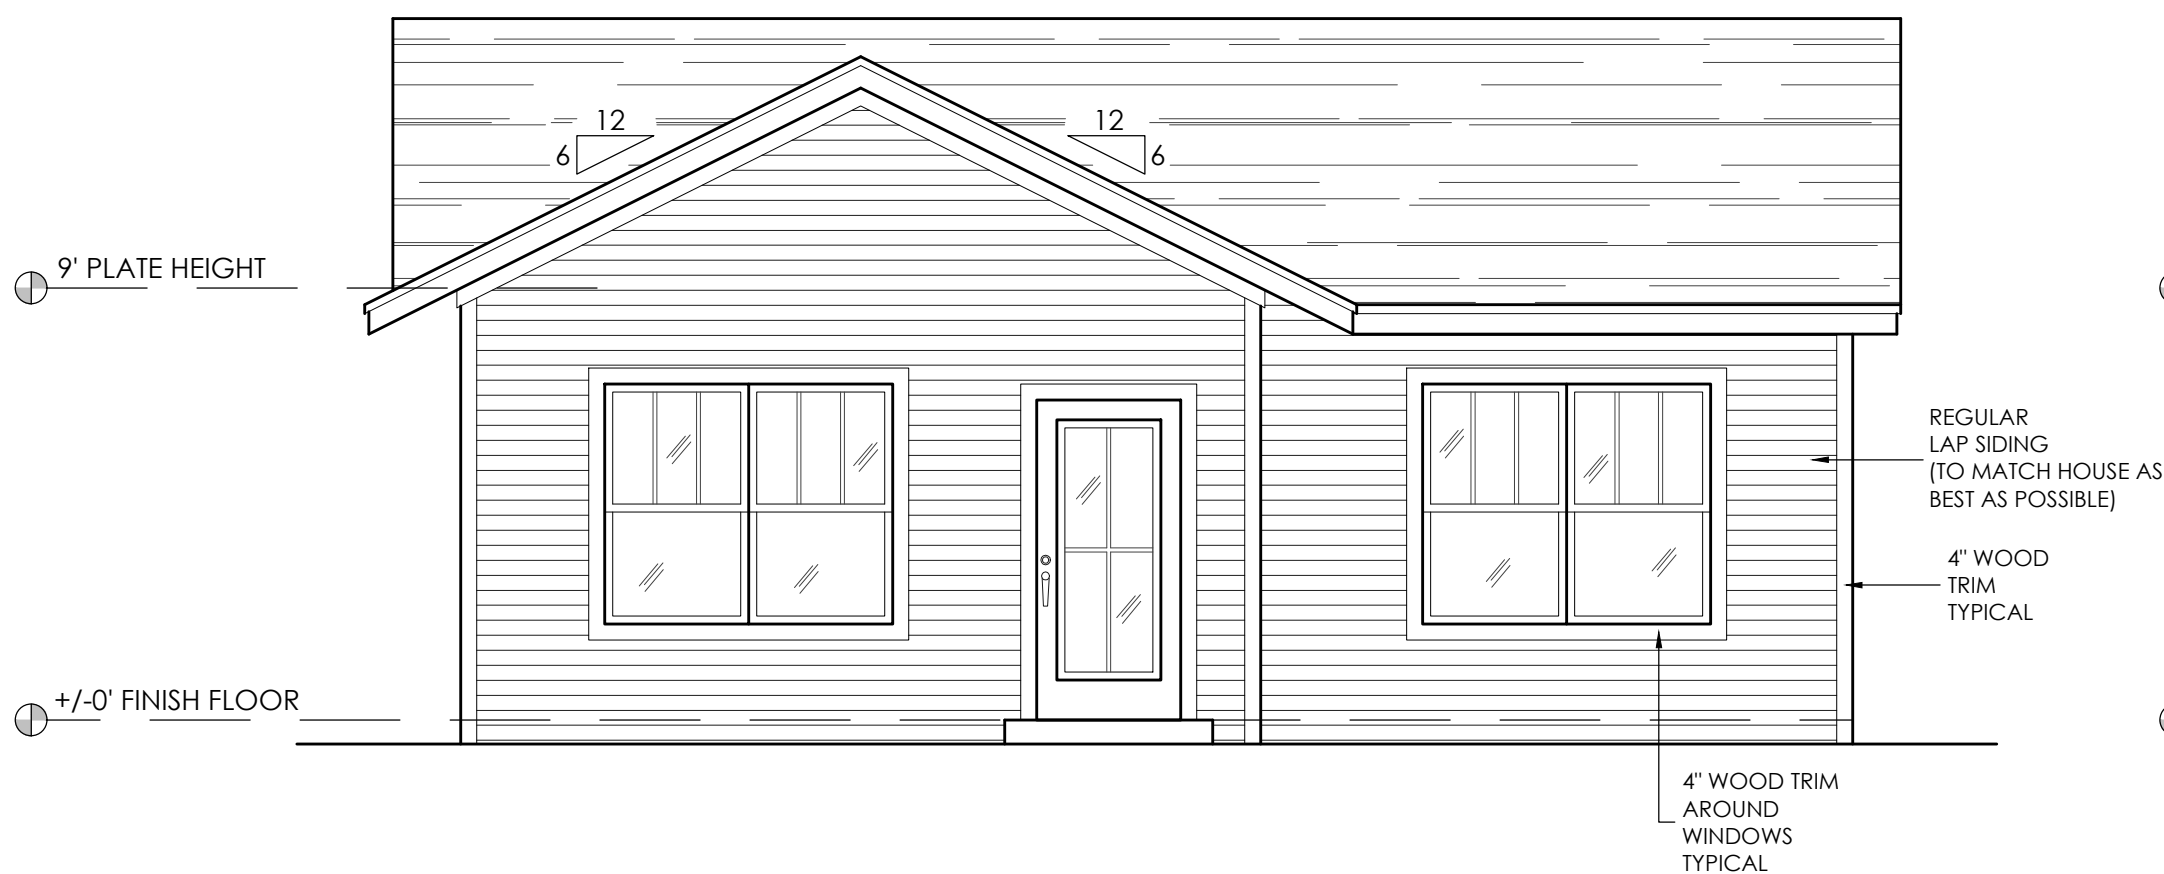


1 FRONT ELEVATION
SCALE: 1/4" = 1'-0"

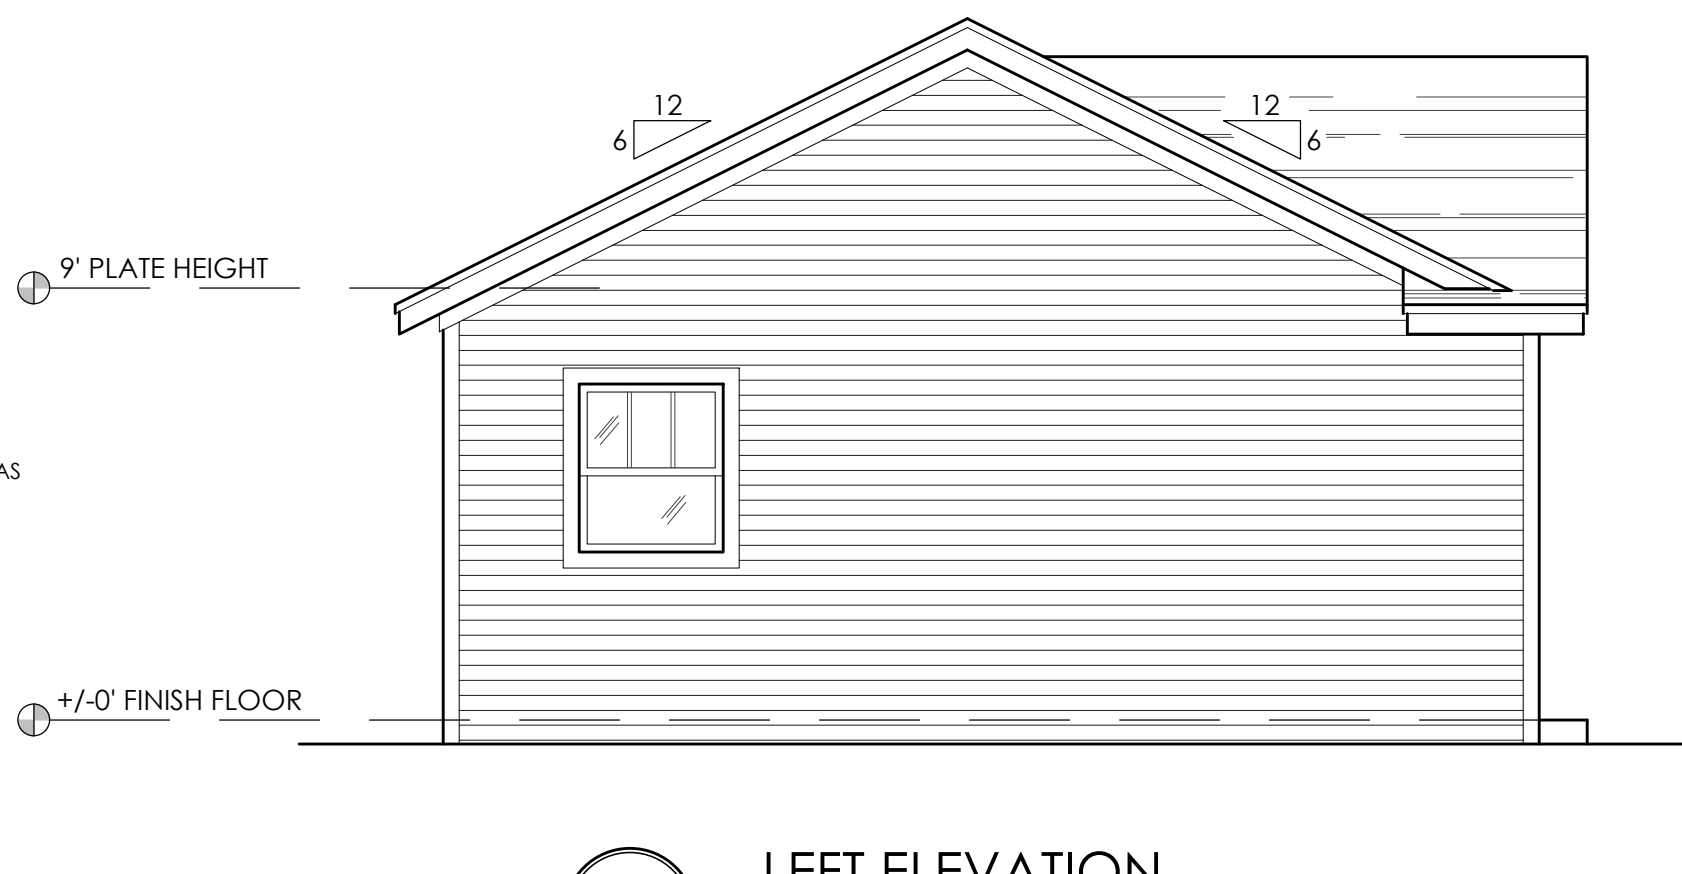


2 LEFT ELEVATION
SCALE: 1/4" = 1'-0"




3 REAR ELEVATION
SCALE: 1/4" = 1'-0"

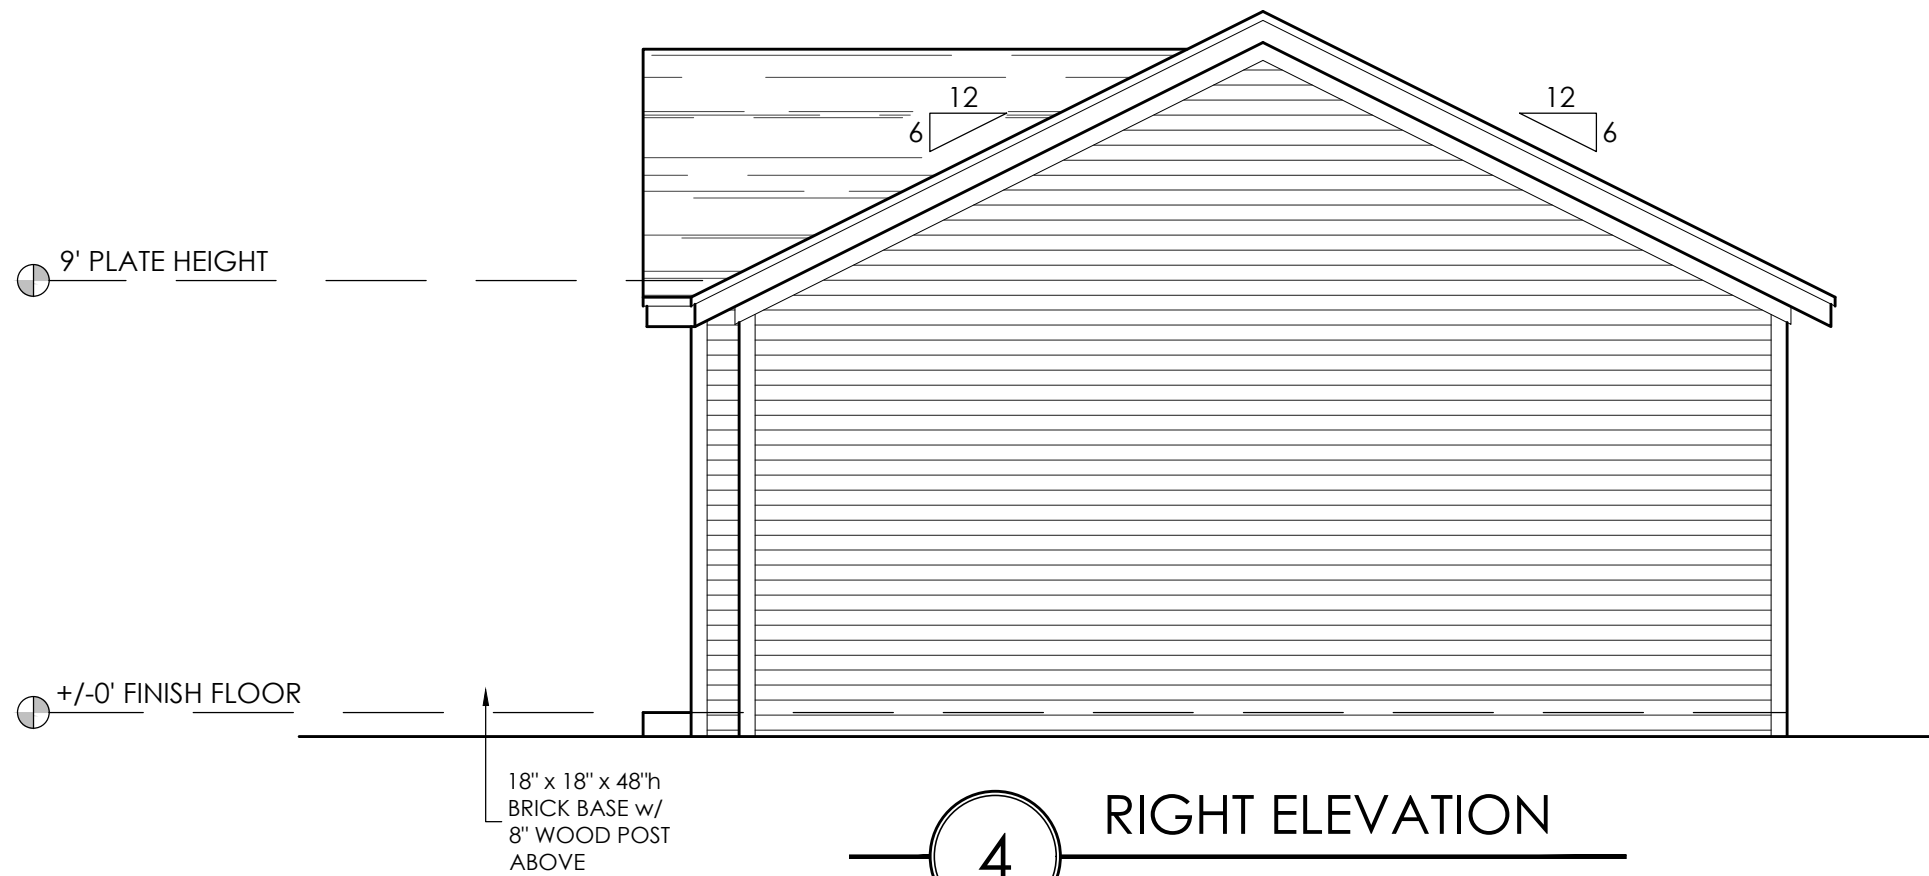


4 RIGHT ELEVATION
SCALE: 1/4" = 1'-0"

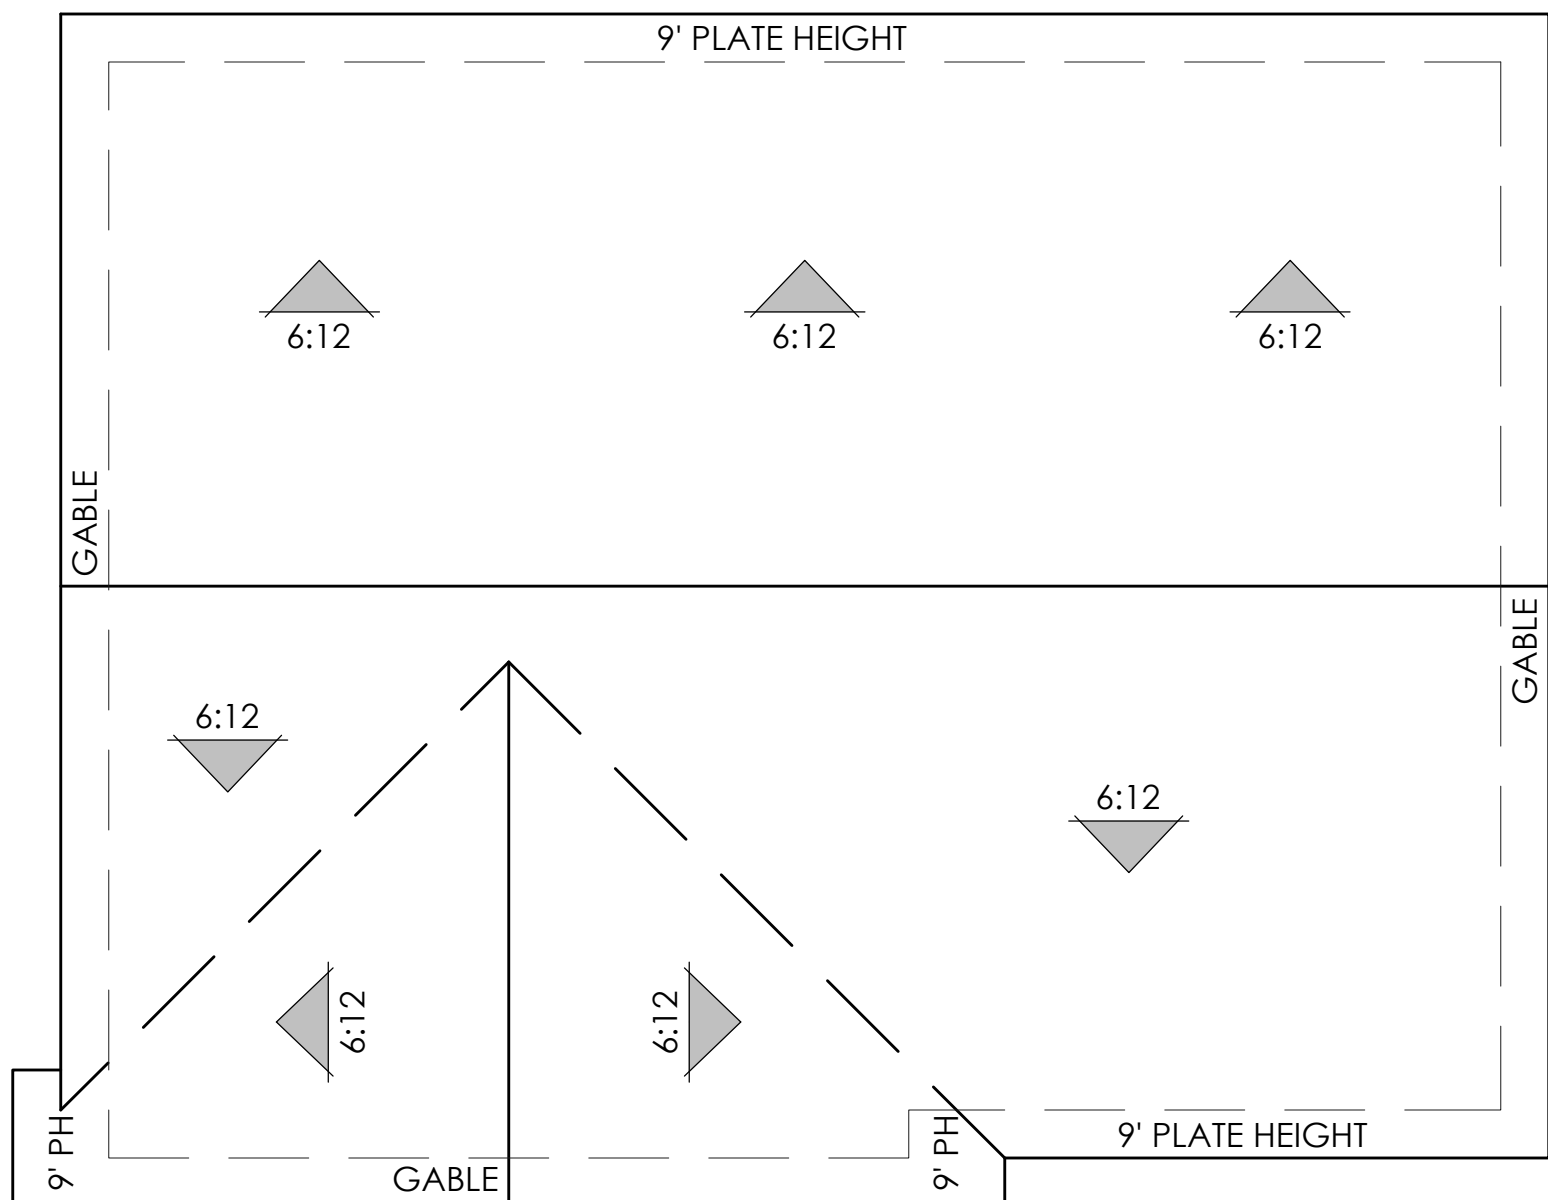


5 ROOF PLAN
SCALE: 1/4" = 1'-0"

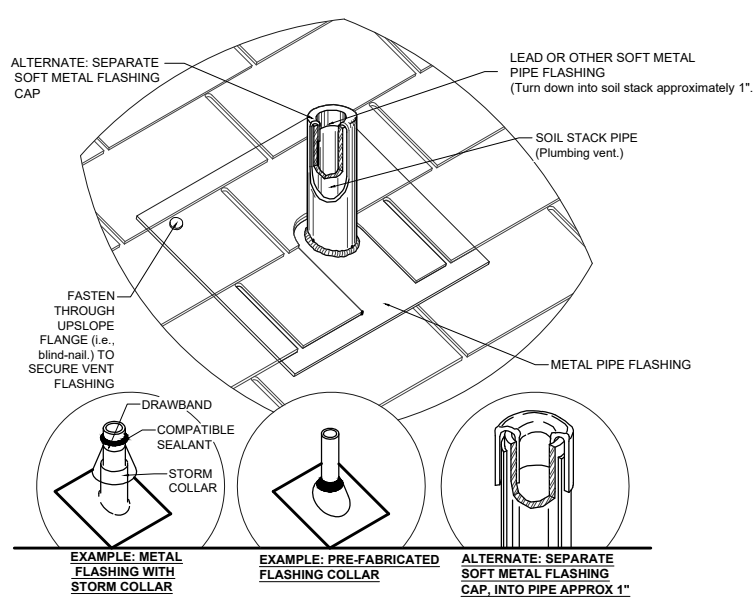

A SOIL PIPE STACK DETAIL
NTS

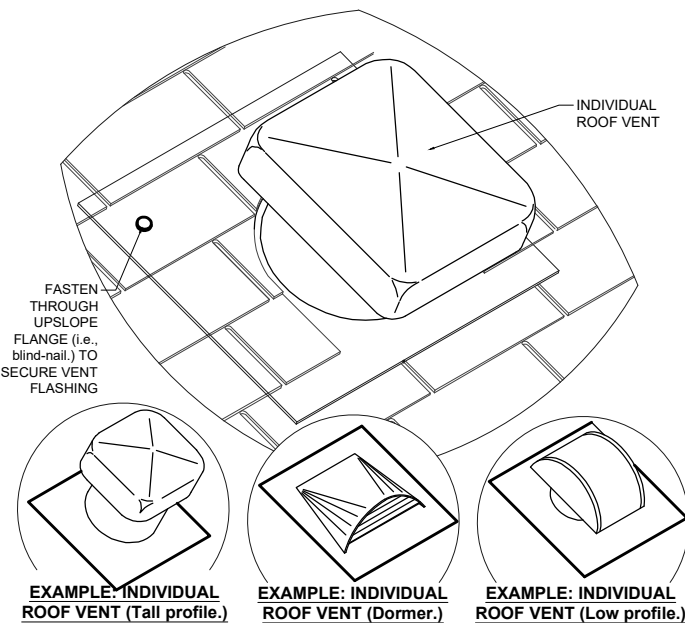

B ROOF VENT DETAIL
NTS

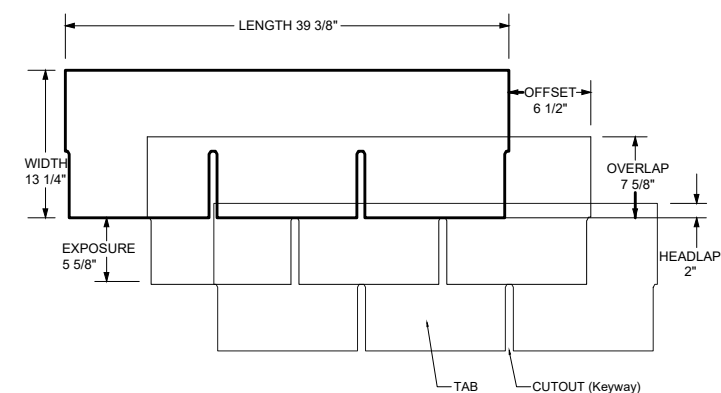

C BASIC SHINGLE COURSE - LAMINATED
NTS