


NO.	DESCRIPTION	DATE

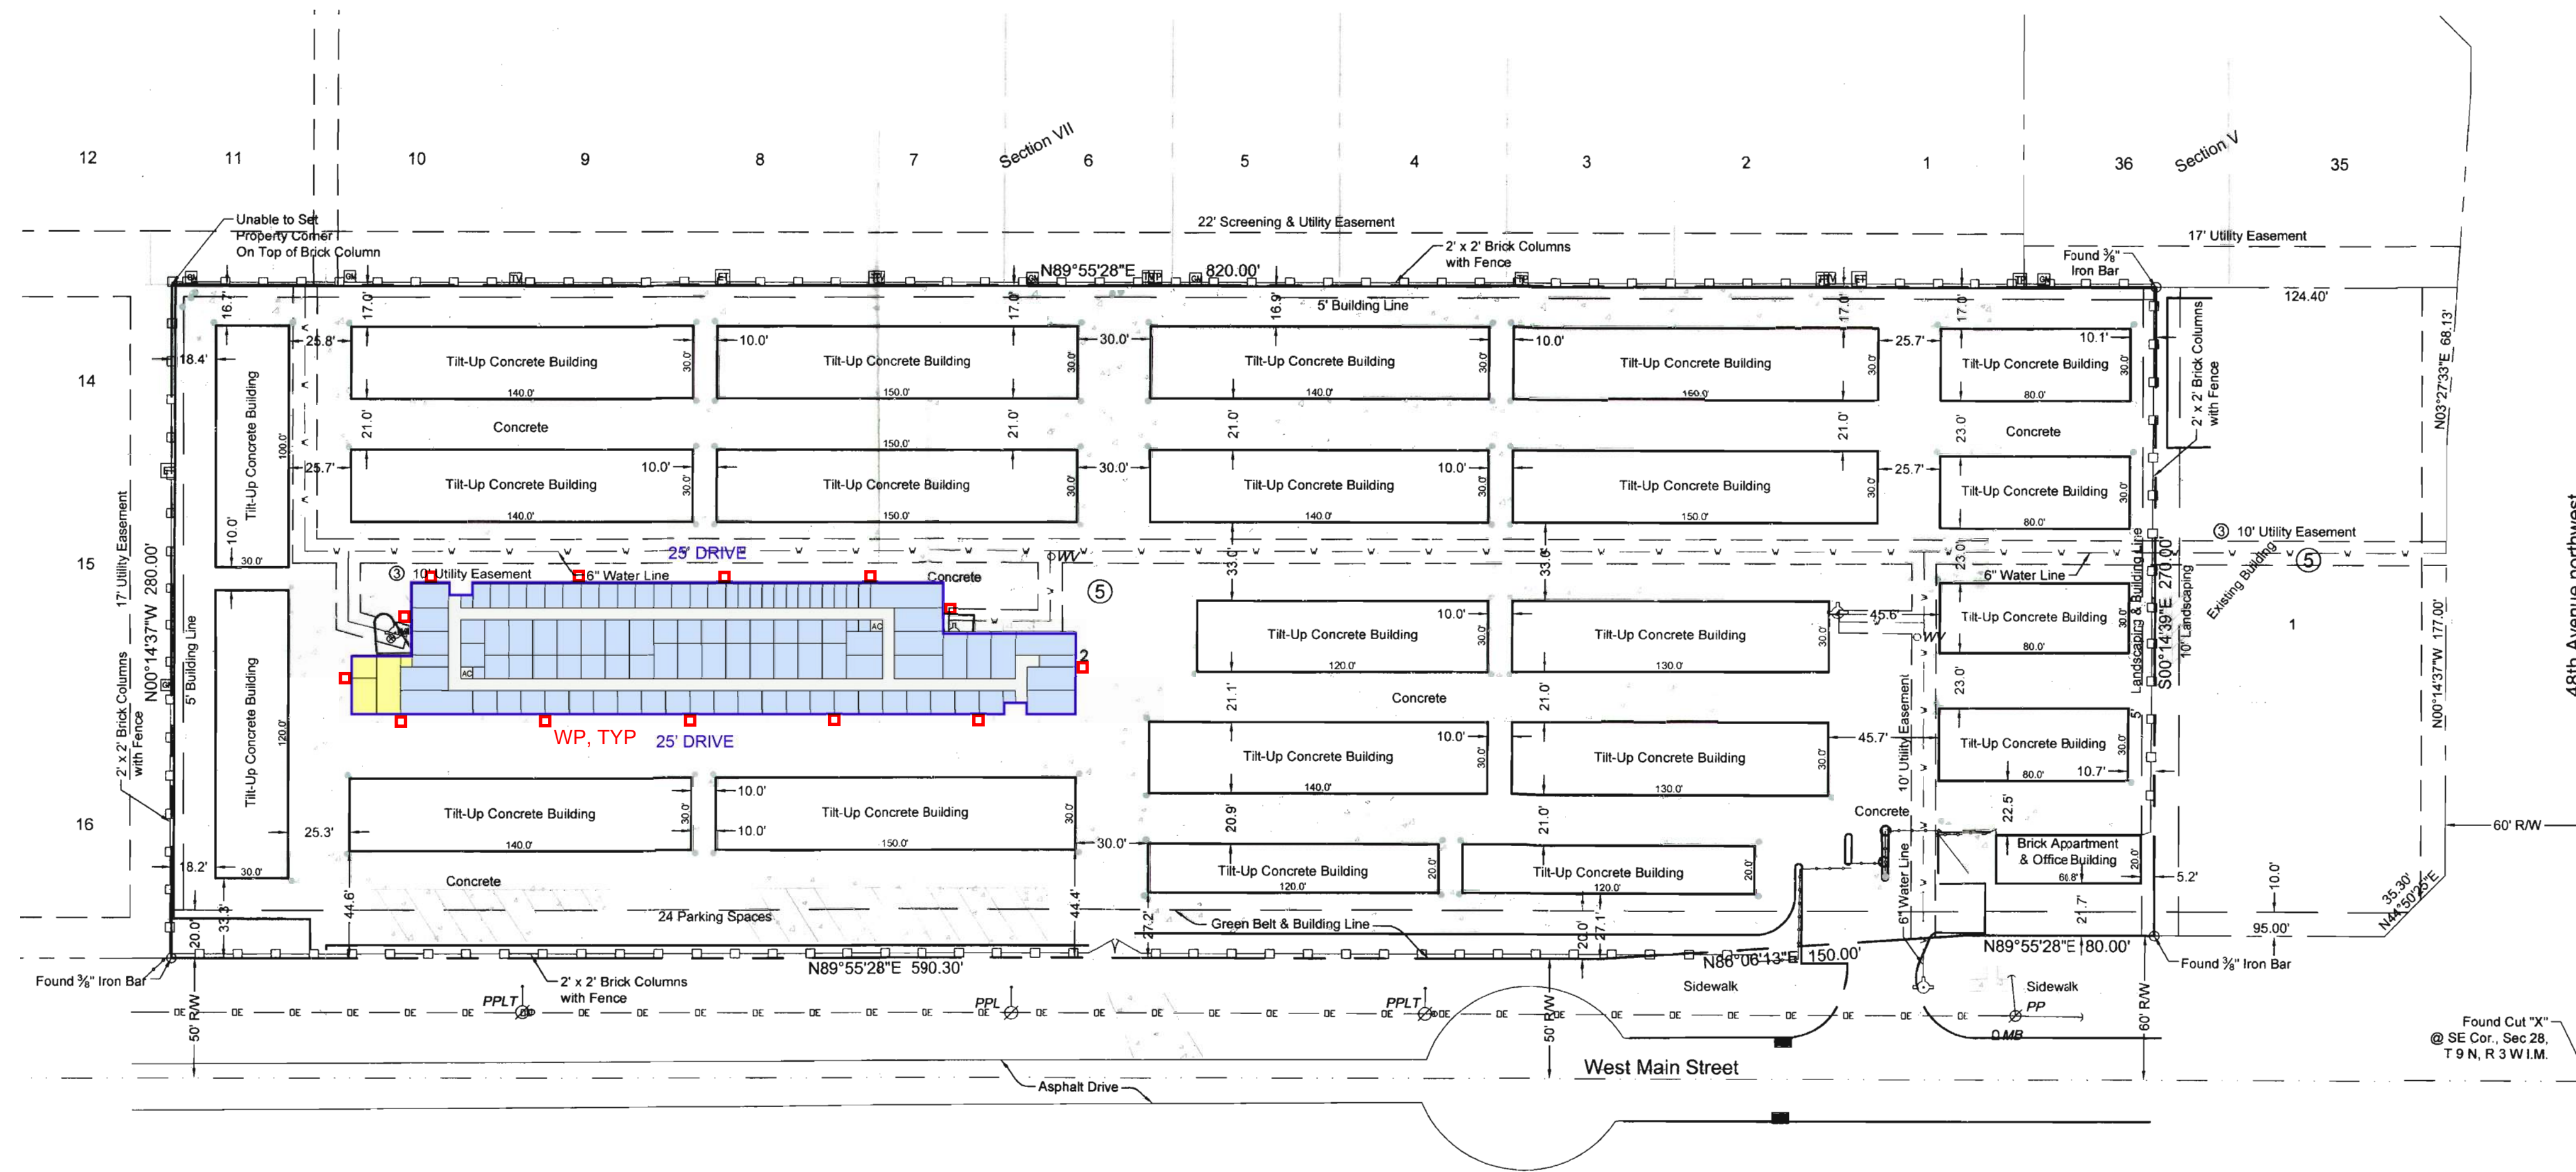


**1 SITE PLAN**  
SCALE: 1" = 50'

**(WP) WALL PACK LIGHTING SPECIFICATION**

Wallpack	120 or 277	19W LED	Lithonia WDGE2 Wall Pack. Fixture to have 2000 nominal lumens, 4000K color temperature, full cutoff.	Lithonia	WDGE2 LED P2 40K 70CRI T3M MVOLT SRM -
----------	------------	---------	--	----------	--

**Cambridge Addition Section VI Block 5, Lot 2**

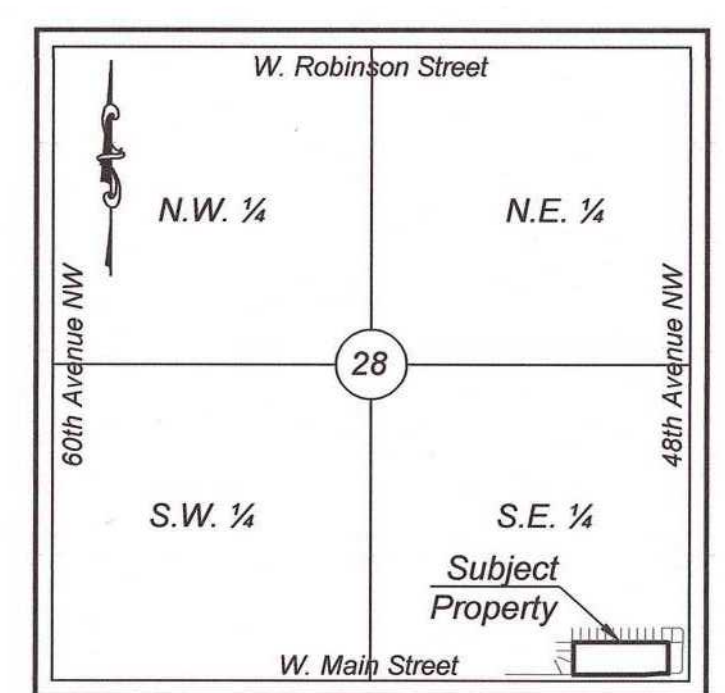

**Vicinity Map**  
Section 28, Township 9N, Range 3W  
Not To Scale

site plan

**Cambridge Storage Expansion**

4801 West Main Street  
Norman, Oklahoma

PROJECT NUMBER  
**NORMAN**  
DATE  
**06.03.24**  
SHEET NUMBER  
**SUP1.0**